


GENERAL NOTES

1. REFER TO ARCHITECTURAL DRAWINGS FOR OVERFLOW SCUPPER SIZES.

SHEET NOTES

- ① 3"Ø ROOF DRAIN LEADER DOWN. REFER TO SHEET F3 FOR CONTINUATION.
- ② 4"Ø ROOF DRAIN LEADER DOWN. REFER TO SHEET F3 FOR CONTINUATION.
- ③ 4"Ø ROOF DRAIN PIPING BELOW ROOF. SLOPE AT 1/8" INCH PER FOOT.
- ④ 3"Ø ROOF DRAIN PIPING BELOW ROOF. SLOPE AT 1/4" INCH PER FOOT.
- ⑤ 3"Ø ROOF DRAIN LEADER DOWN. REFER TO SHEET F3 FOR CONTINUATION.
- ⑥ OVERFLOW SCUPPER. REFER TO ARCHITECTURAL PLANS.

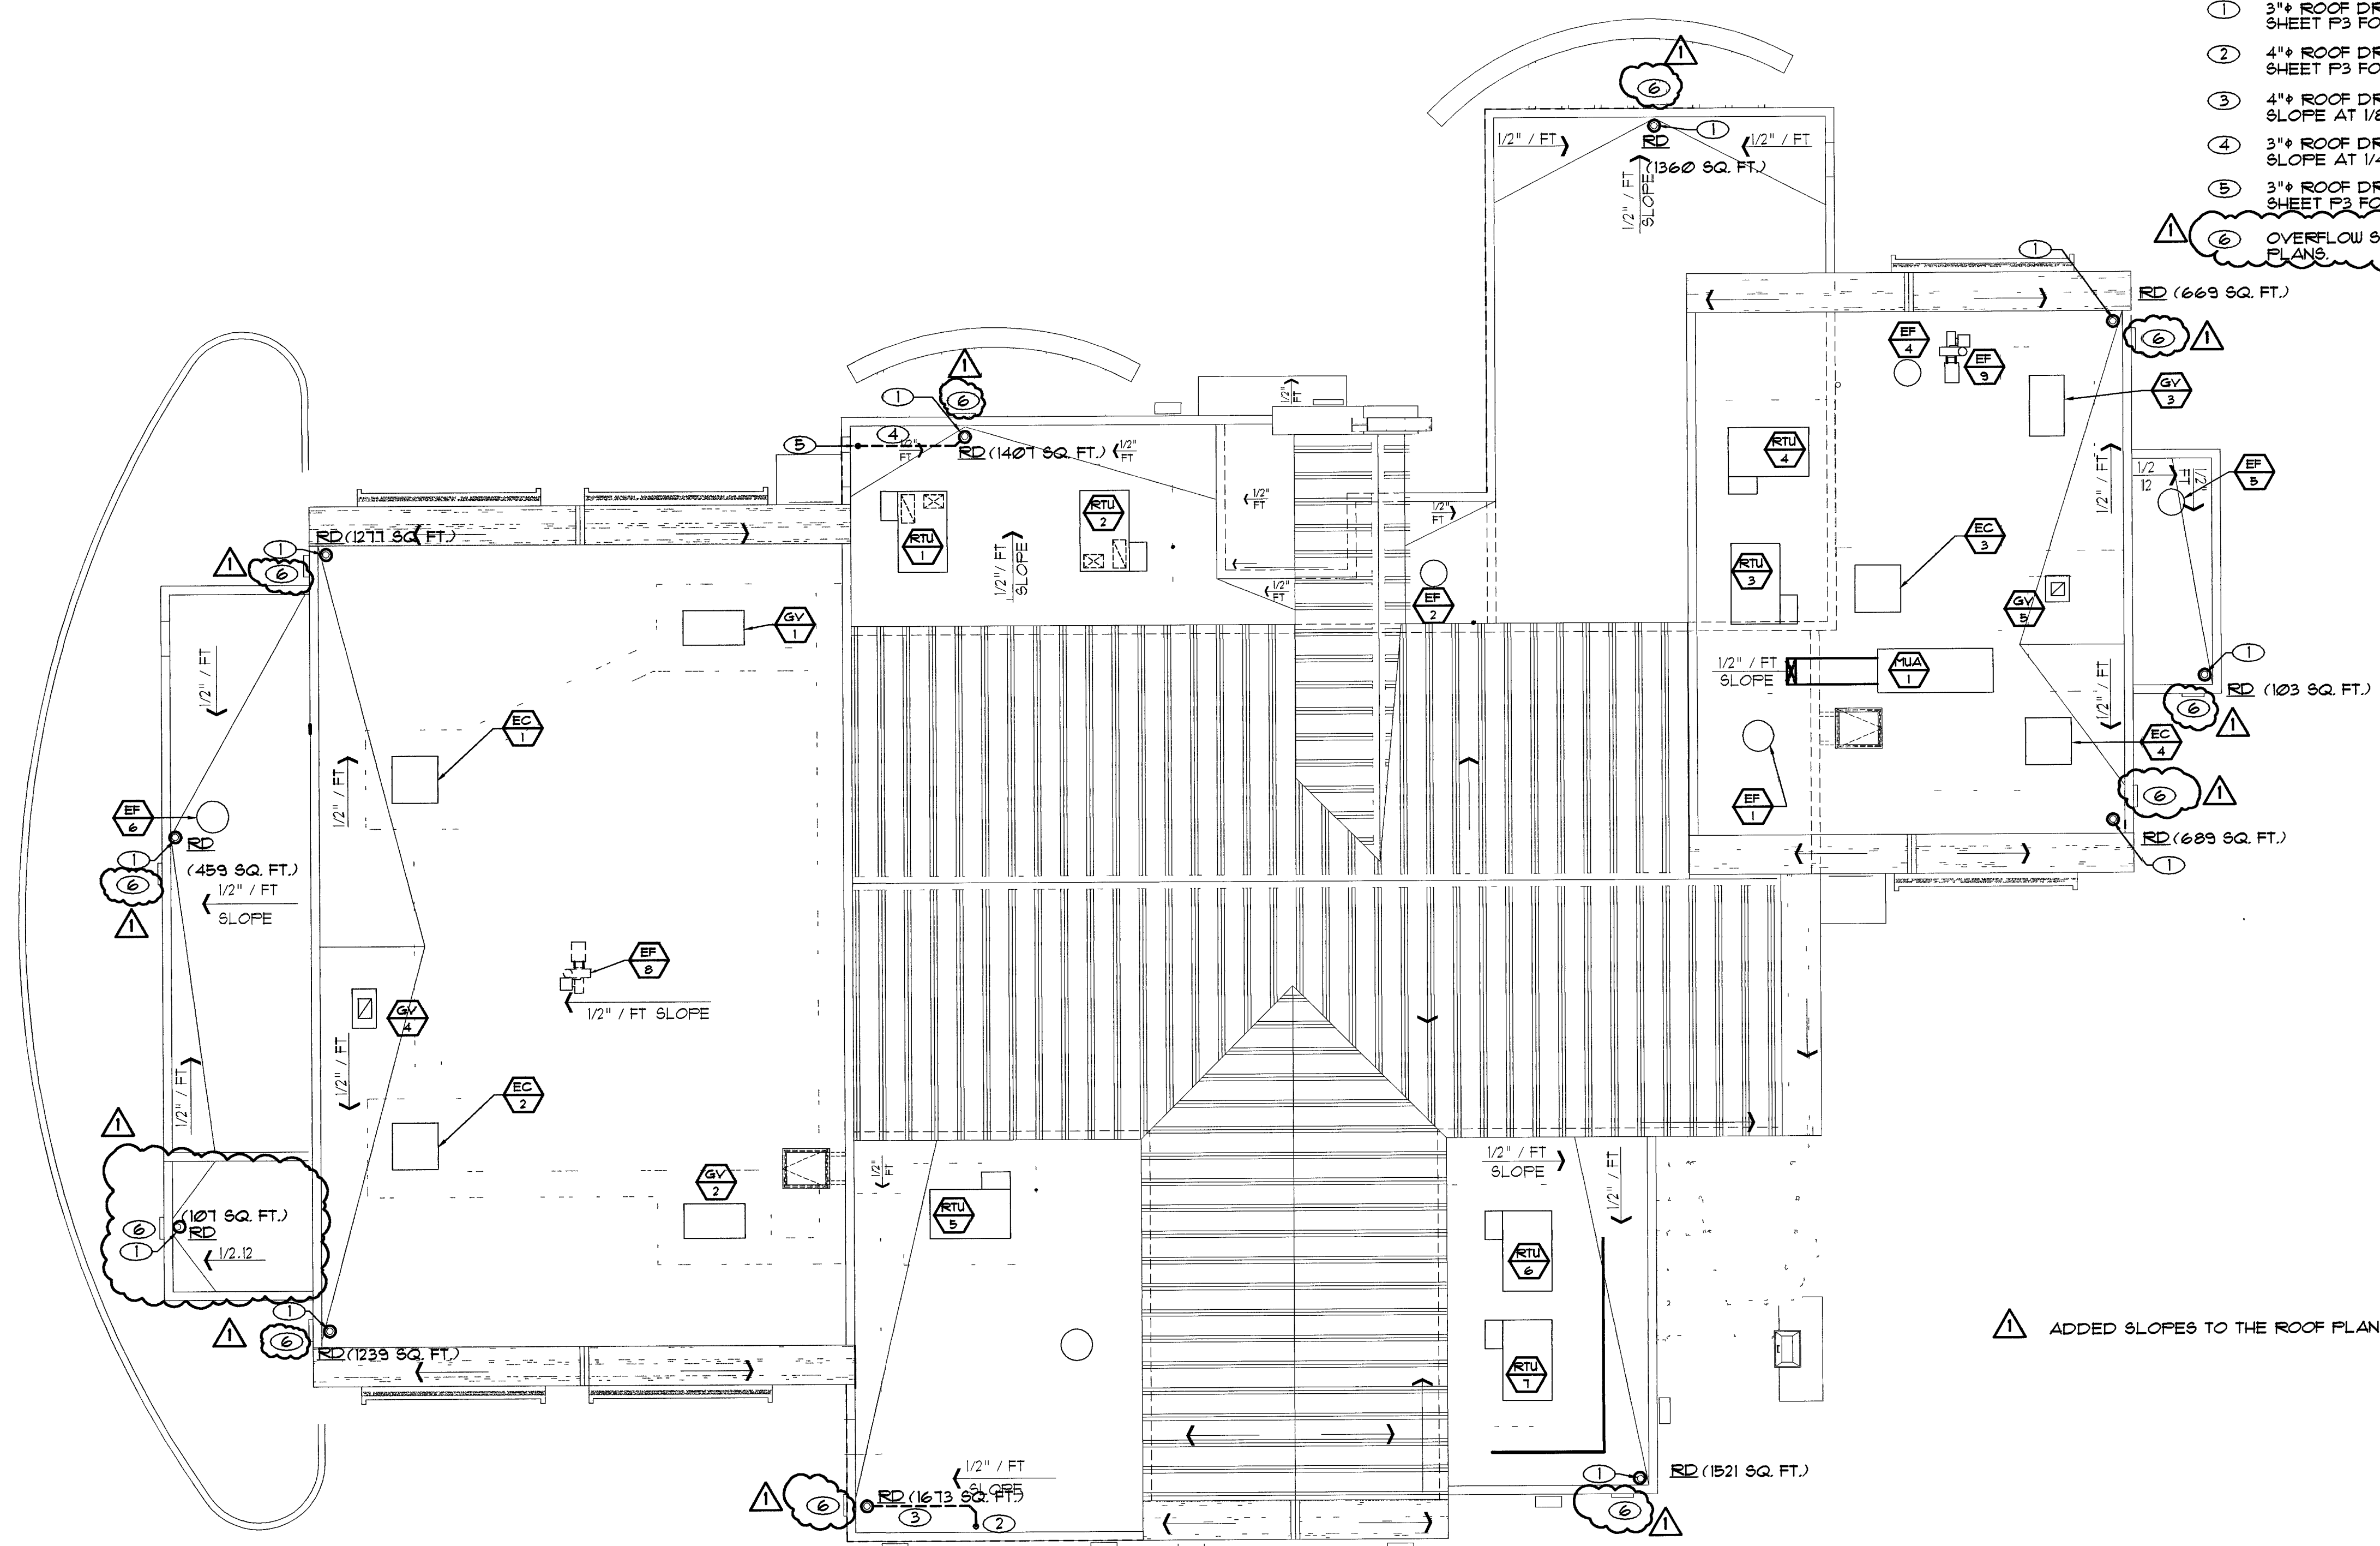

 ADDED SLOPES TO THE ROOF PLAN

◀ Project North

PLUMBING ROOF PLAN

Scale: 1/8"=1'-0"

DEPARTMENT OF PUBLIC WORKS

CITY OF LAS VEGAS, NEVADA
FIRE STATION #8
PLUMBING ROOF PLAN

PLUMBING ROOF PLAN

OWNER: CITY OF LAS VEGAS
DEPARTMENT OF PUBLIC WORKS
ARCHITECTURAL SERVICES

400 EAST STEWART AVENUE
LAS VEGAS, NEVADA 89101
PHONE: (702) 229-6535
FAX: (702) 382-3232
TDD: (702) 386-9108

DRAWN **DEB**
FILE
DATE **4/3/04**
SCALE **1/8" = 1'-0"**
BID NO **041534104**
CLV DWG NO **630-101**

602
SHT NO

P4

RECORD DRAWING