




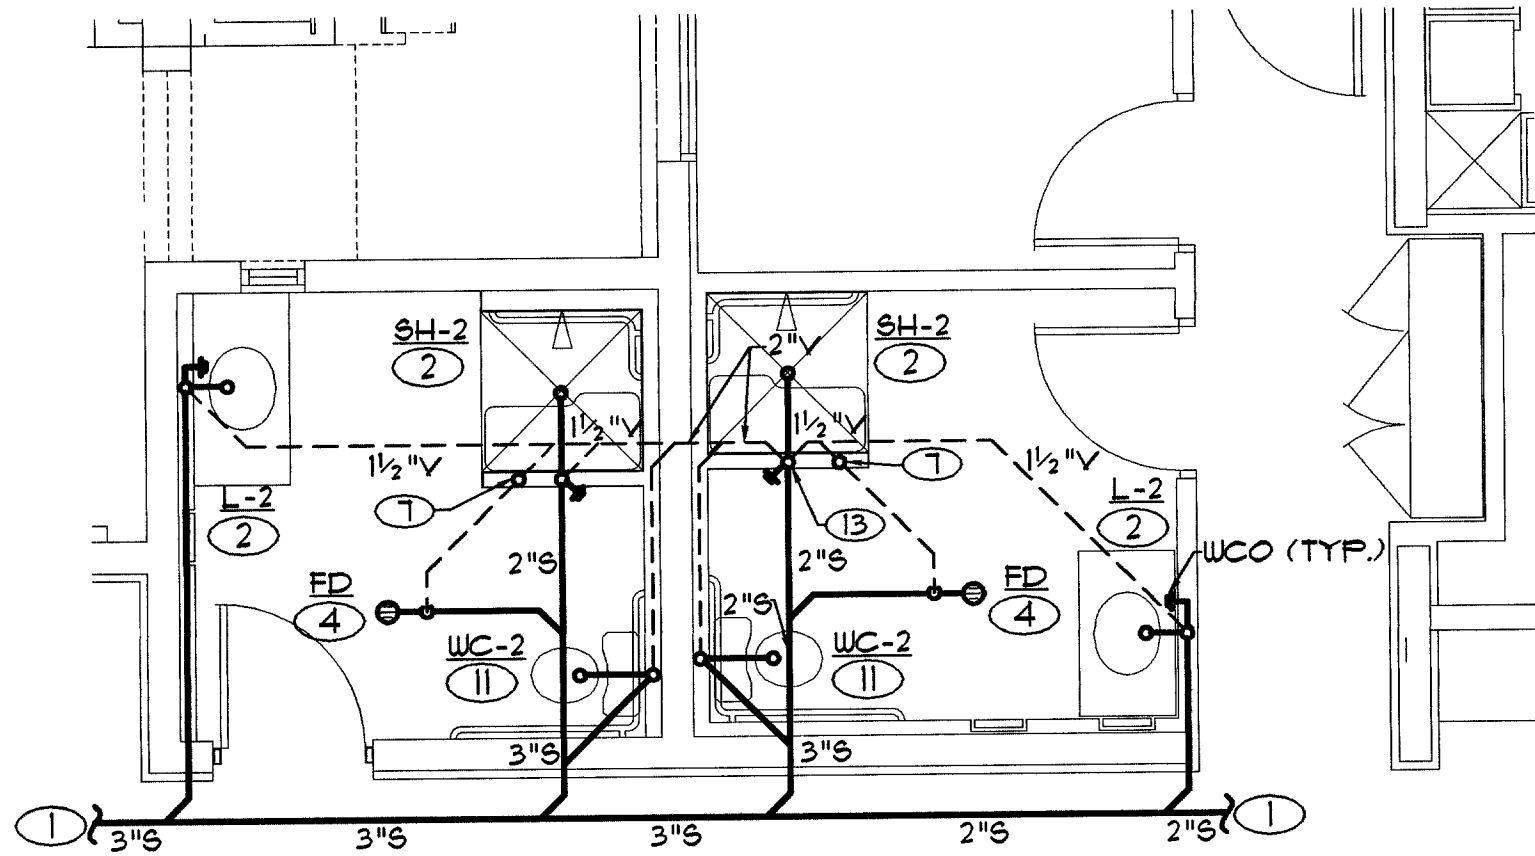


1 RESTROOM – SANITARY WASTE & VENT
SCALE: 1/4" = 1'-0"

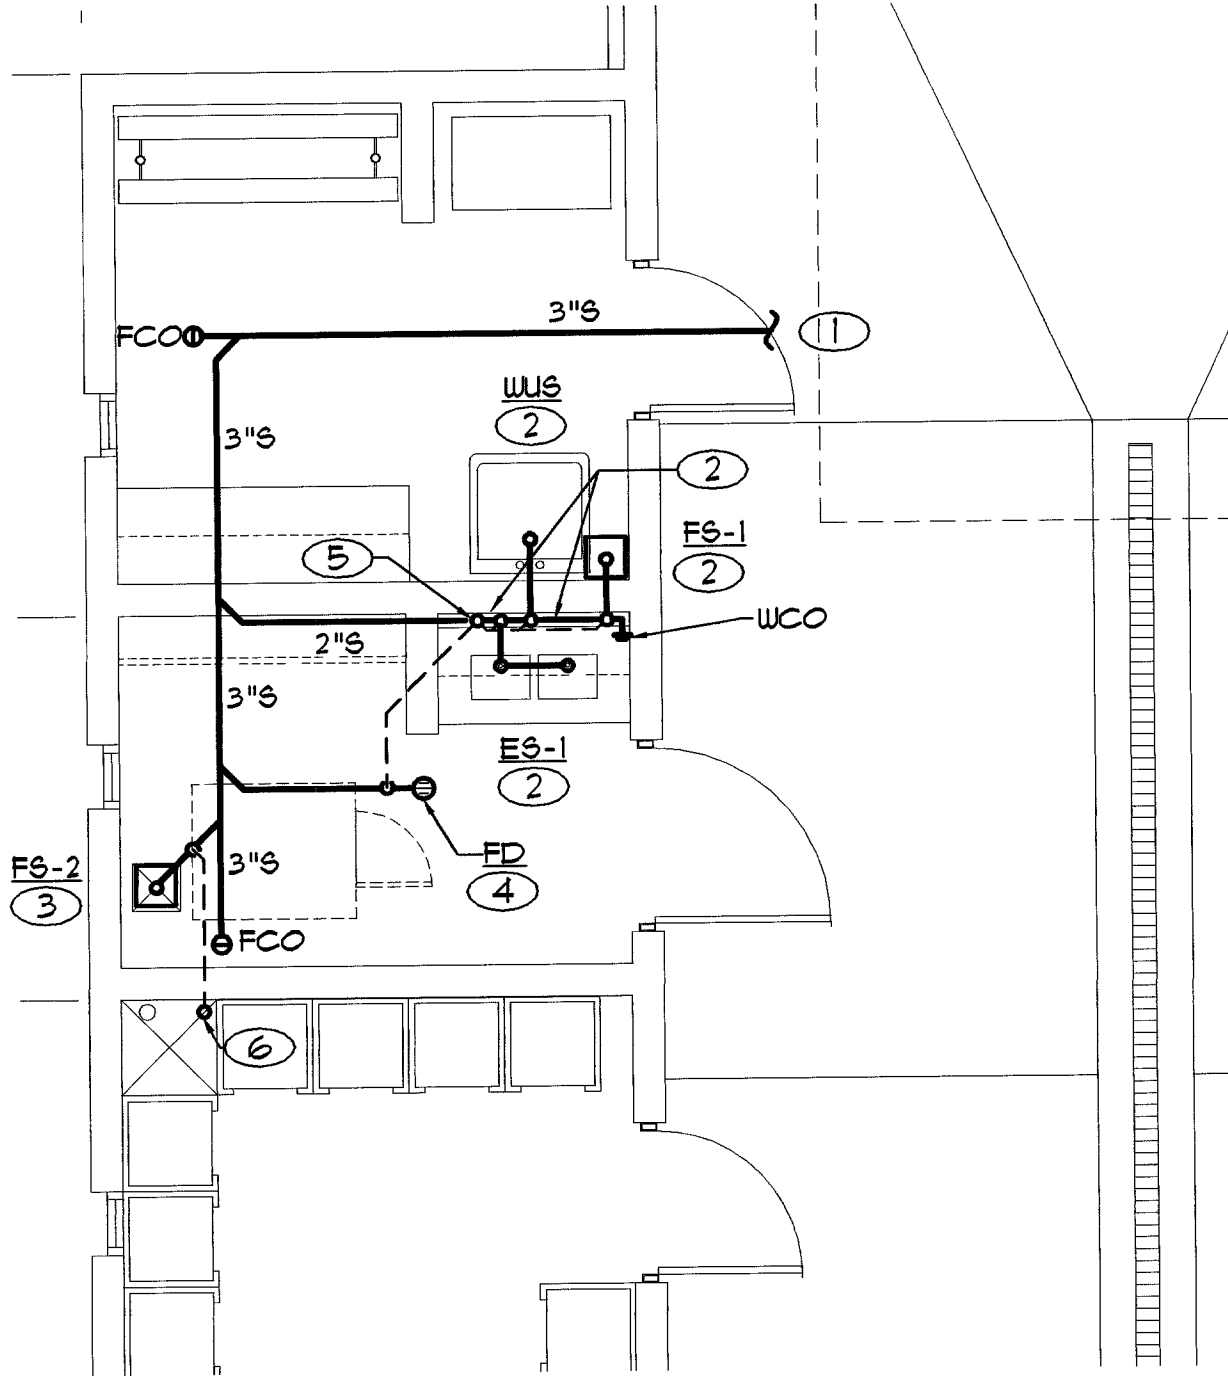


2 CLEAN ROOM – SANITARY WASTE & VENT
SCALE: 1/4" = 1'-0"

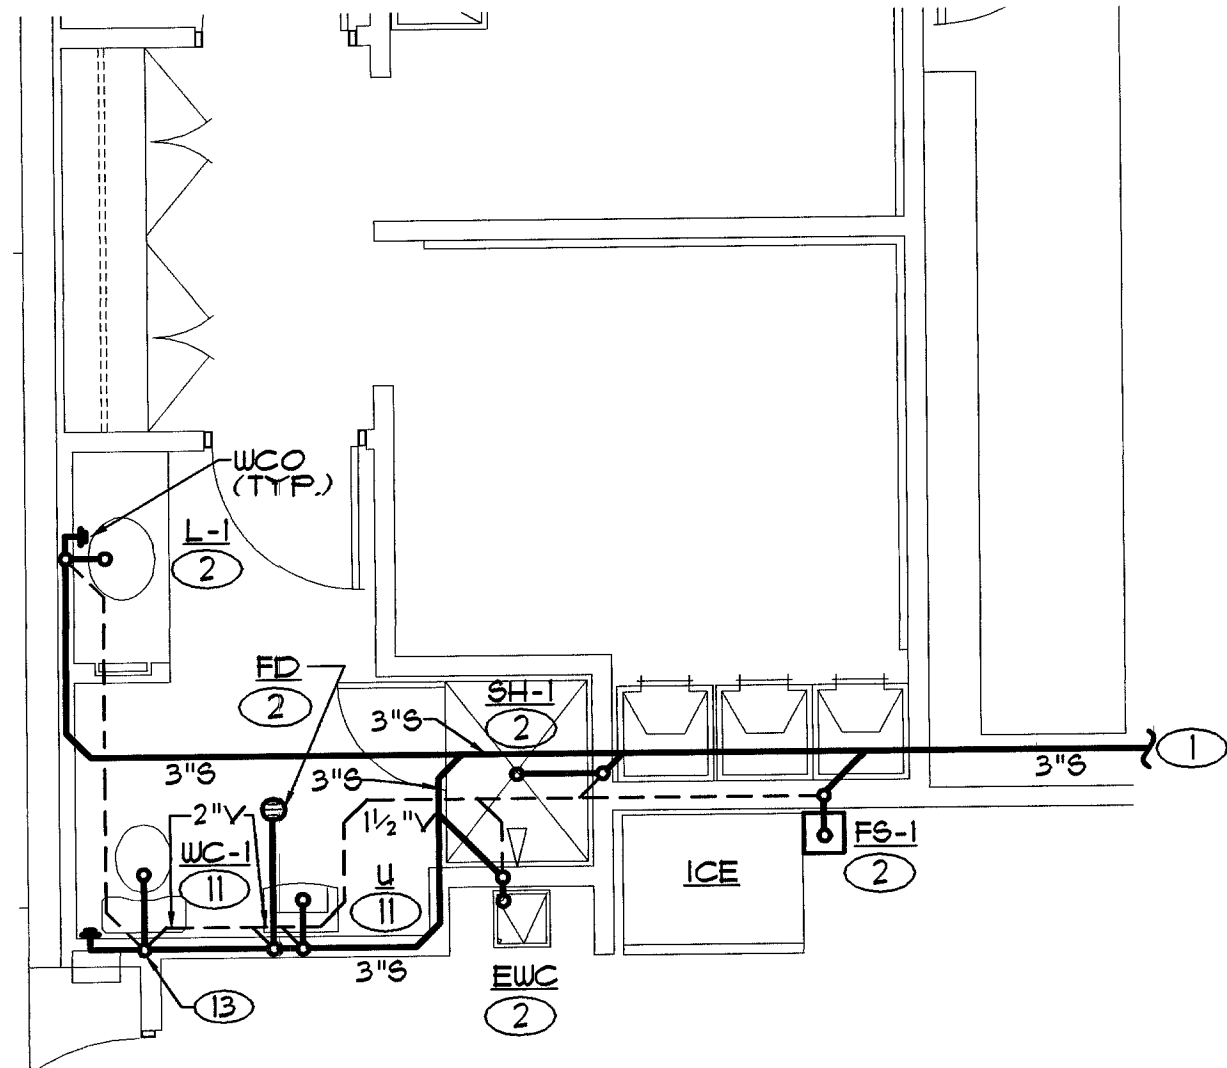


3 CAPTAIN'S BATHROOM – SANITARY WASTE & VENT
SCALE: 1/4" = 1'-0"

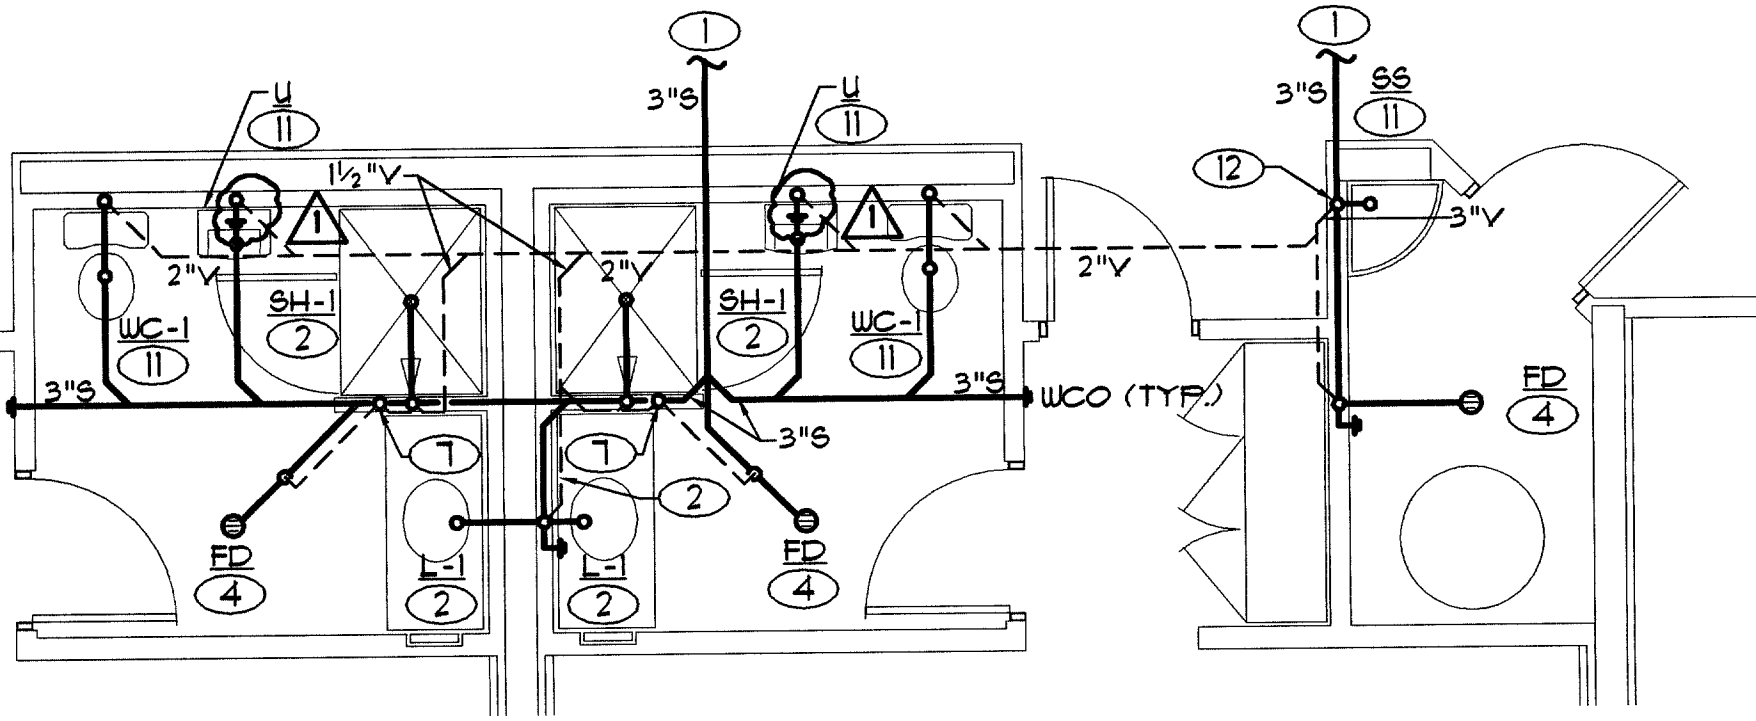

4 RESTROOM – SANITARY WASTE & VENT
SCALE: 1/4" = 1'-0"

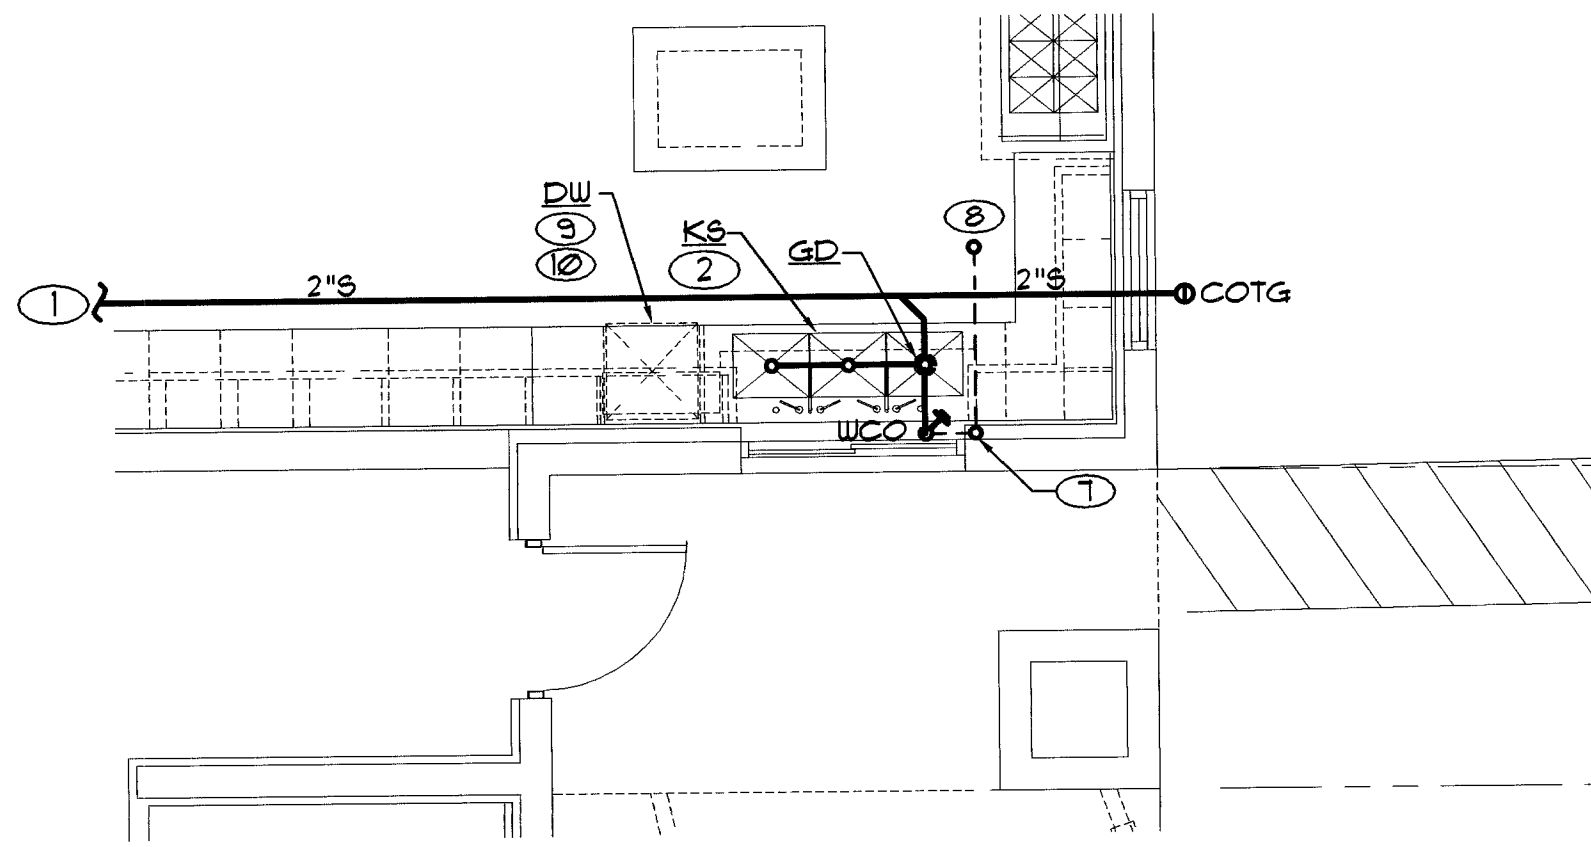

5 KITCHEN – SANITARY WASTE & VENT
SCALE: 1/4" = 1'-0"

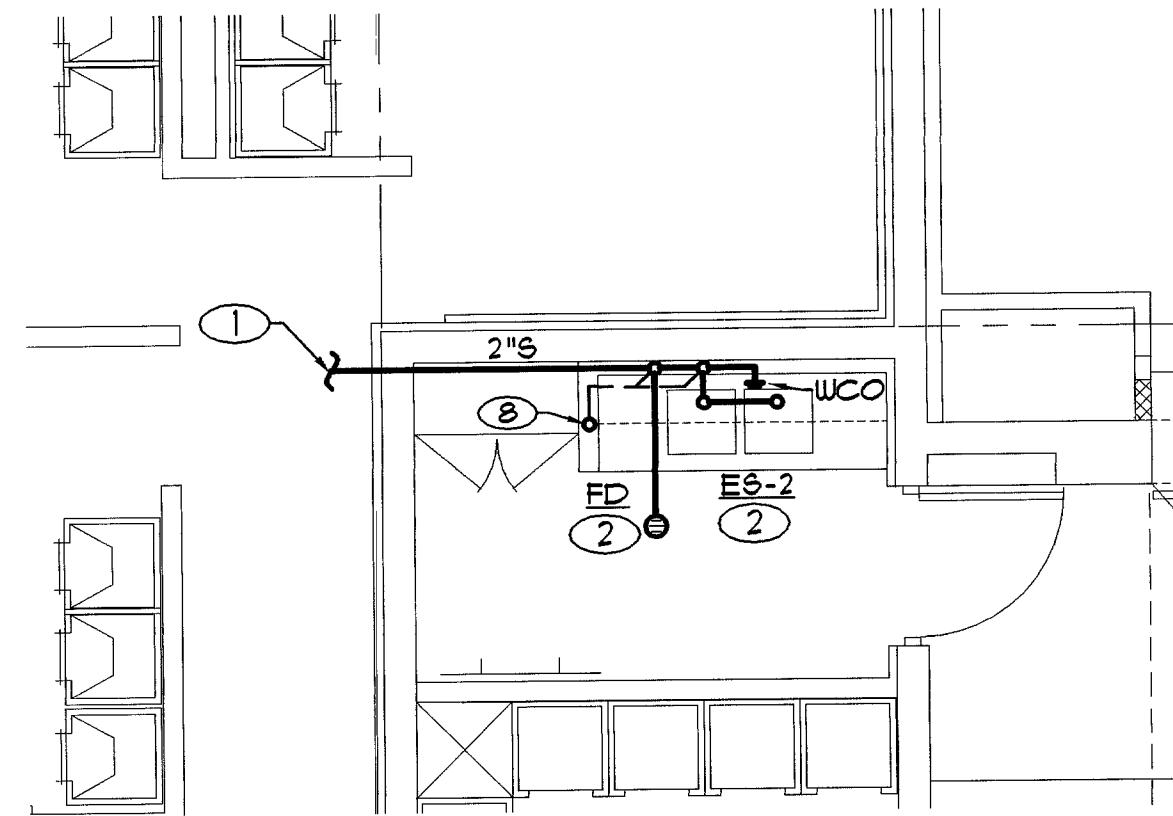

6 RESCUE CLEAN ROOM – SANITARY WASTE & VENT
SCALE: 1/4" = 1'-0"

SHEET NOTES

- 1 REFER TO SHEET P3 FOR CONTINUATION.
- 2 2" S, 1 1/2" V.
- 3 3" S, 2" V BELOW SLAB.
- 4 2" S, 1 1/2" V BELOW SLAB.
- 5 1 1/2" V UP, 2" VTR.
- 6 2" V UP, 2" VTR.
- 7 1 1/2" V UP.
- 8 1 1/2" VTR.
- 9 FURNISHED BY OWNER AND INSTALLED BY CONTRACTOR.
- 10 PROVIDE AIR GAP FITTINGS AS REQUIRED BY CODE.
- 11 3" S, 2" V.
- 12 3" VTR.
- 13 2" VTR.
- 14 PROVIDE CLEANOUTS ON ALL SINKS AND URINALS.

GENERAL NOTES

1. NO PLASTIC PIPE IS PERMITTED ABOVE GRADE SINCE THERE IS A RETURN AIR PLENUM.

RECORD DRAWING



REVISIONS
DATE: 5/13/04
BY: BLDG. DEPT. COMMENTS

CONSULTANT

COMFORT ENGINEERING
MECHANICAL • ELECTRICAL • PLUMBING
2350 LAS VEGAS, NEVADA 89146
TEL: (702) 382-3882 FAX: 387-076

CITY OF LAS VEGAS, NEVADA
FIRE STATION #8
ENLARGED PLUMBING PLANS -
SANITARY WASTE & VENT

OWNER: CITY OF LAS VEGAS
DEPARTMENT OF PUBLIC WORKS
ARCHITECTURAL SERVICES

400 EAST STEWART AVENUE
LAS VEGAS, NEVADA 89101
PHONE: (702) 229-6535
FAX: (702) 382-3232
TDD: (702) 386-9108

DRAWN: DBB
FILE:
DATE: 4/9/04
SCALE: 1/4" = 1'-0"
BID NO: 041534104
CLV DWG NO: 630-101

SHT NO: 103

P5

10288P