


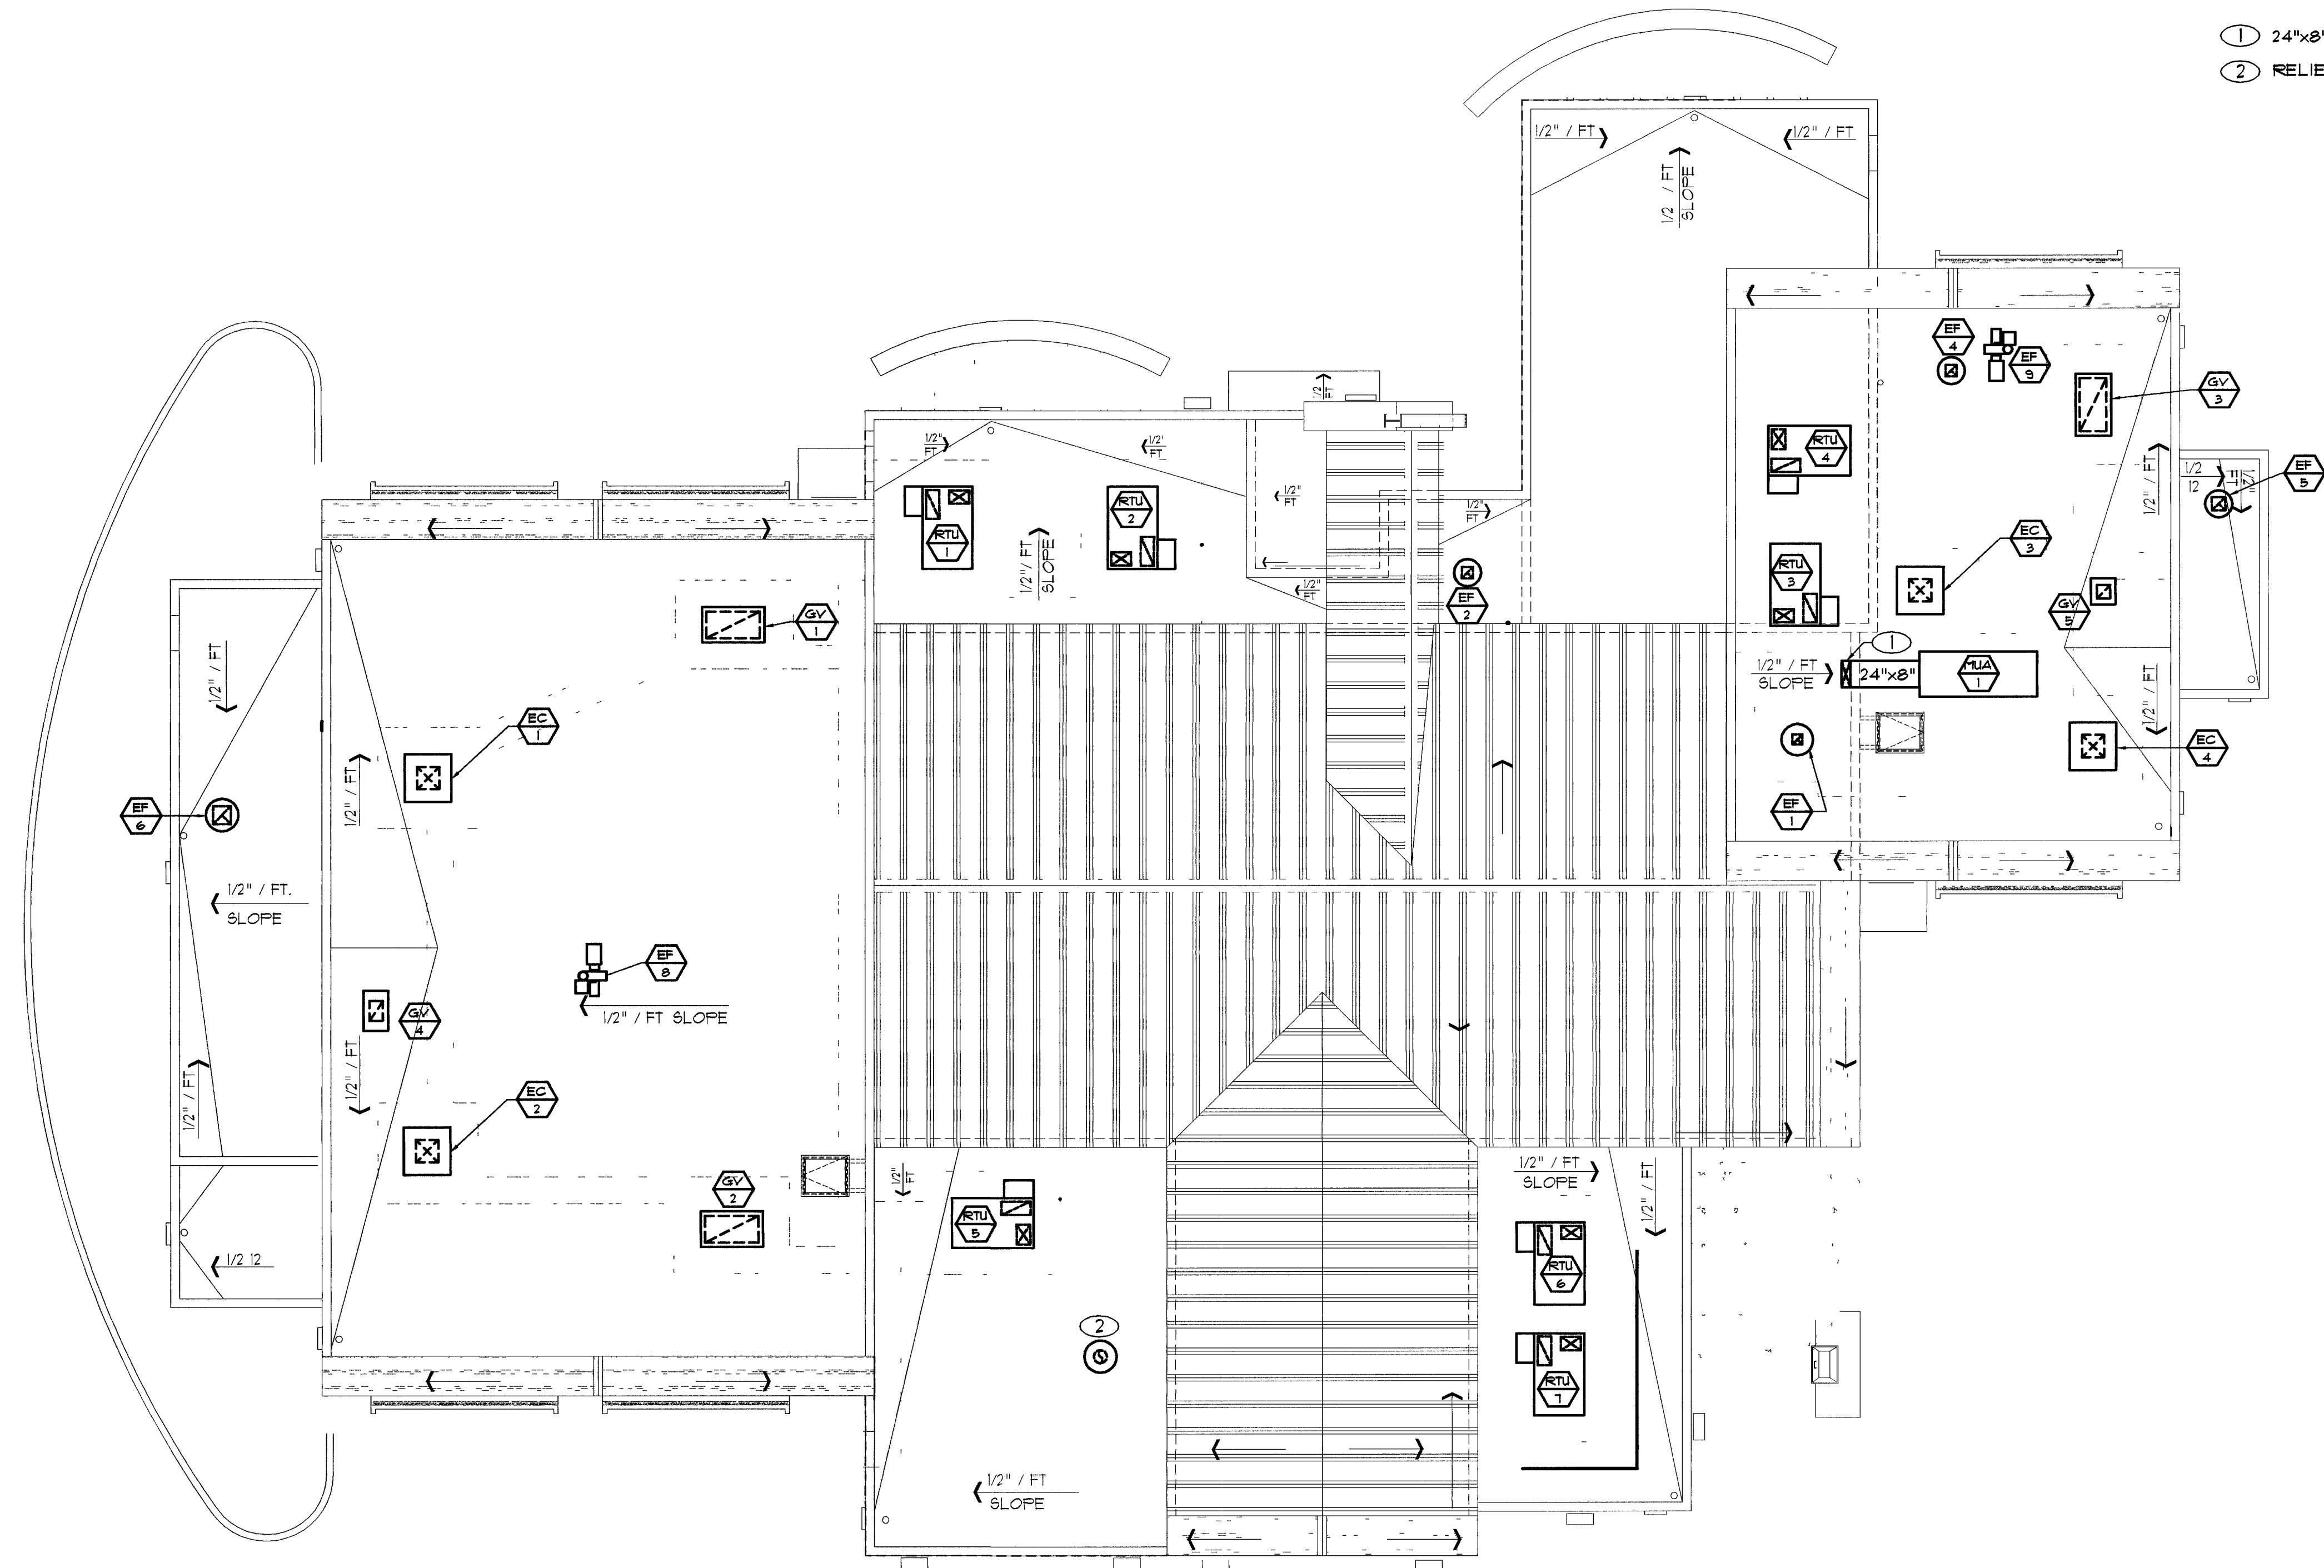

MECHANICAL ROOF PLAN

Scale: 1/8"=1'-0"

◀ Project North

GENERAL NOTES

1. THE MECHANICAL CONTRACTOR SHALL VERIFY LOCATION OF ROOF MOUNTED EQUIPMENT AND ROOF PENETRATIONS WITH ARCHITECT AND STRUCTURAL ENGINEER PRIOR TO BEGINNING WORK. REFER TO ARCHITECTURAL DETAILS FOR ROOF CURB AND AND ROOFING REQUIREMENTS.
2. MAINTAIN A 10 FT. CLEARANCE FROM ANY OUTSIDE AIR INTAKE AND ALL EXHAUST AND PLUMBING TERMINATIONS.

SHEET NOTES

- ① 24"x8" INSULATED AND JACKETED SUPPLY DUCT DOWN THRU ROOF.
- ② RELIEF HOOD.



REVISIONS

CONSULTANT

COMFORT ENGINEERING

MECHANICAL • ELECTRICAL • PLUMBING
2550 SOUTH RAINBOW, SUITE 5-28
LAS VEGAS, NV 89102
TEL: (702) 357-9892 FAX: 987-1076



CITY OF LAS VEGAS, NEVADA

FIRE STATION #8

MECHANICAL ROOF PLAN

STAMP

OWNER: CITY OF LAS VEGAS
DEPARTMENT OF PUBLIC WORKS
ARCHITECTURAL SERVICES

400 EAST STEWART AVENUE
LAS VEGAS, NEVADA 89101
PHONE: (702) 239-6535
FAX: (702) 382-3232
TDD: (702) 386-9108

DRAWN: DBB

DATE: 4/9/04

SCALE: 1/8" = 1'-0"

BID NO: 041534104

CLV DWG NO: 630-101

096

SHT NO

M4

RECORD DRAWING