


General Notes:

- SEE MECHANICAL DRAWINGS AND ARCHITECTURAL REFLECTED CEILING PLAN FOR LOCATIONS OF MAJOR SUPPLY, RETURN, AND EXHAUST GRILLES AS SHOWN ON THE REFLECTED CEILING PLAN. IT IS THE RESPONSIBILITY OF THE CONTRACTOR TO COORDINATE ALL LOCATIONS OF CEILING PENETRATIONS, & OPENINGS TO INCLUDE HVAC SERVICE GRILLES, LIGHT FIXTURES, SPEAKERS, FIRE SPRINKLER HEADS, ETC.
- WORK ON THIS SHEET SHALL BE DONE IN CONJUNCTION WITH MECHANICAL, ELECTRICAL & AUXILIARY PLANS AND FIRE PROTECTION PLANS.
- ROOF SCREWS SHALL NOT PENETRATE METAL ROOF DECK BY MORE THAN 1" INTO CEILING SPACE.
- PROVIDE ACOUSTIC BATT. INSULATION DIRECTLY OVER ALL DORMITORY CEILINGS.
- GENERAL CONTRACTOR TO WELD MTL. TABS TO BOTTOM OF METAL ROOF DECK FOR ACOUSTICAL CEILING GRID SUPPORT CONNECTION.

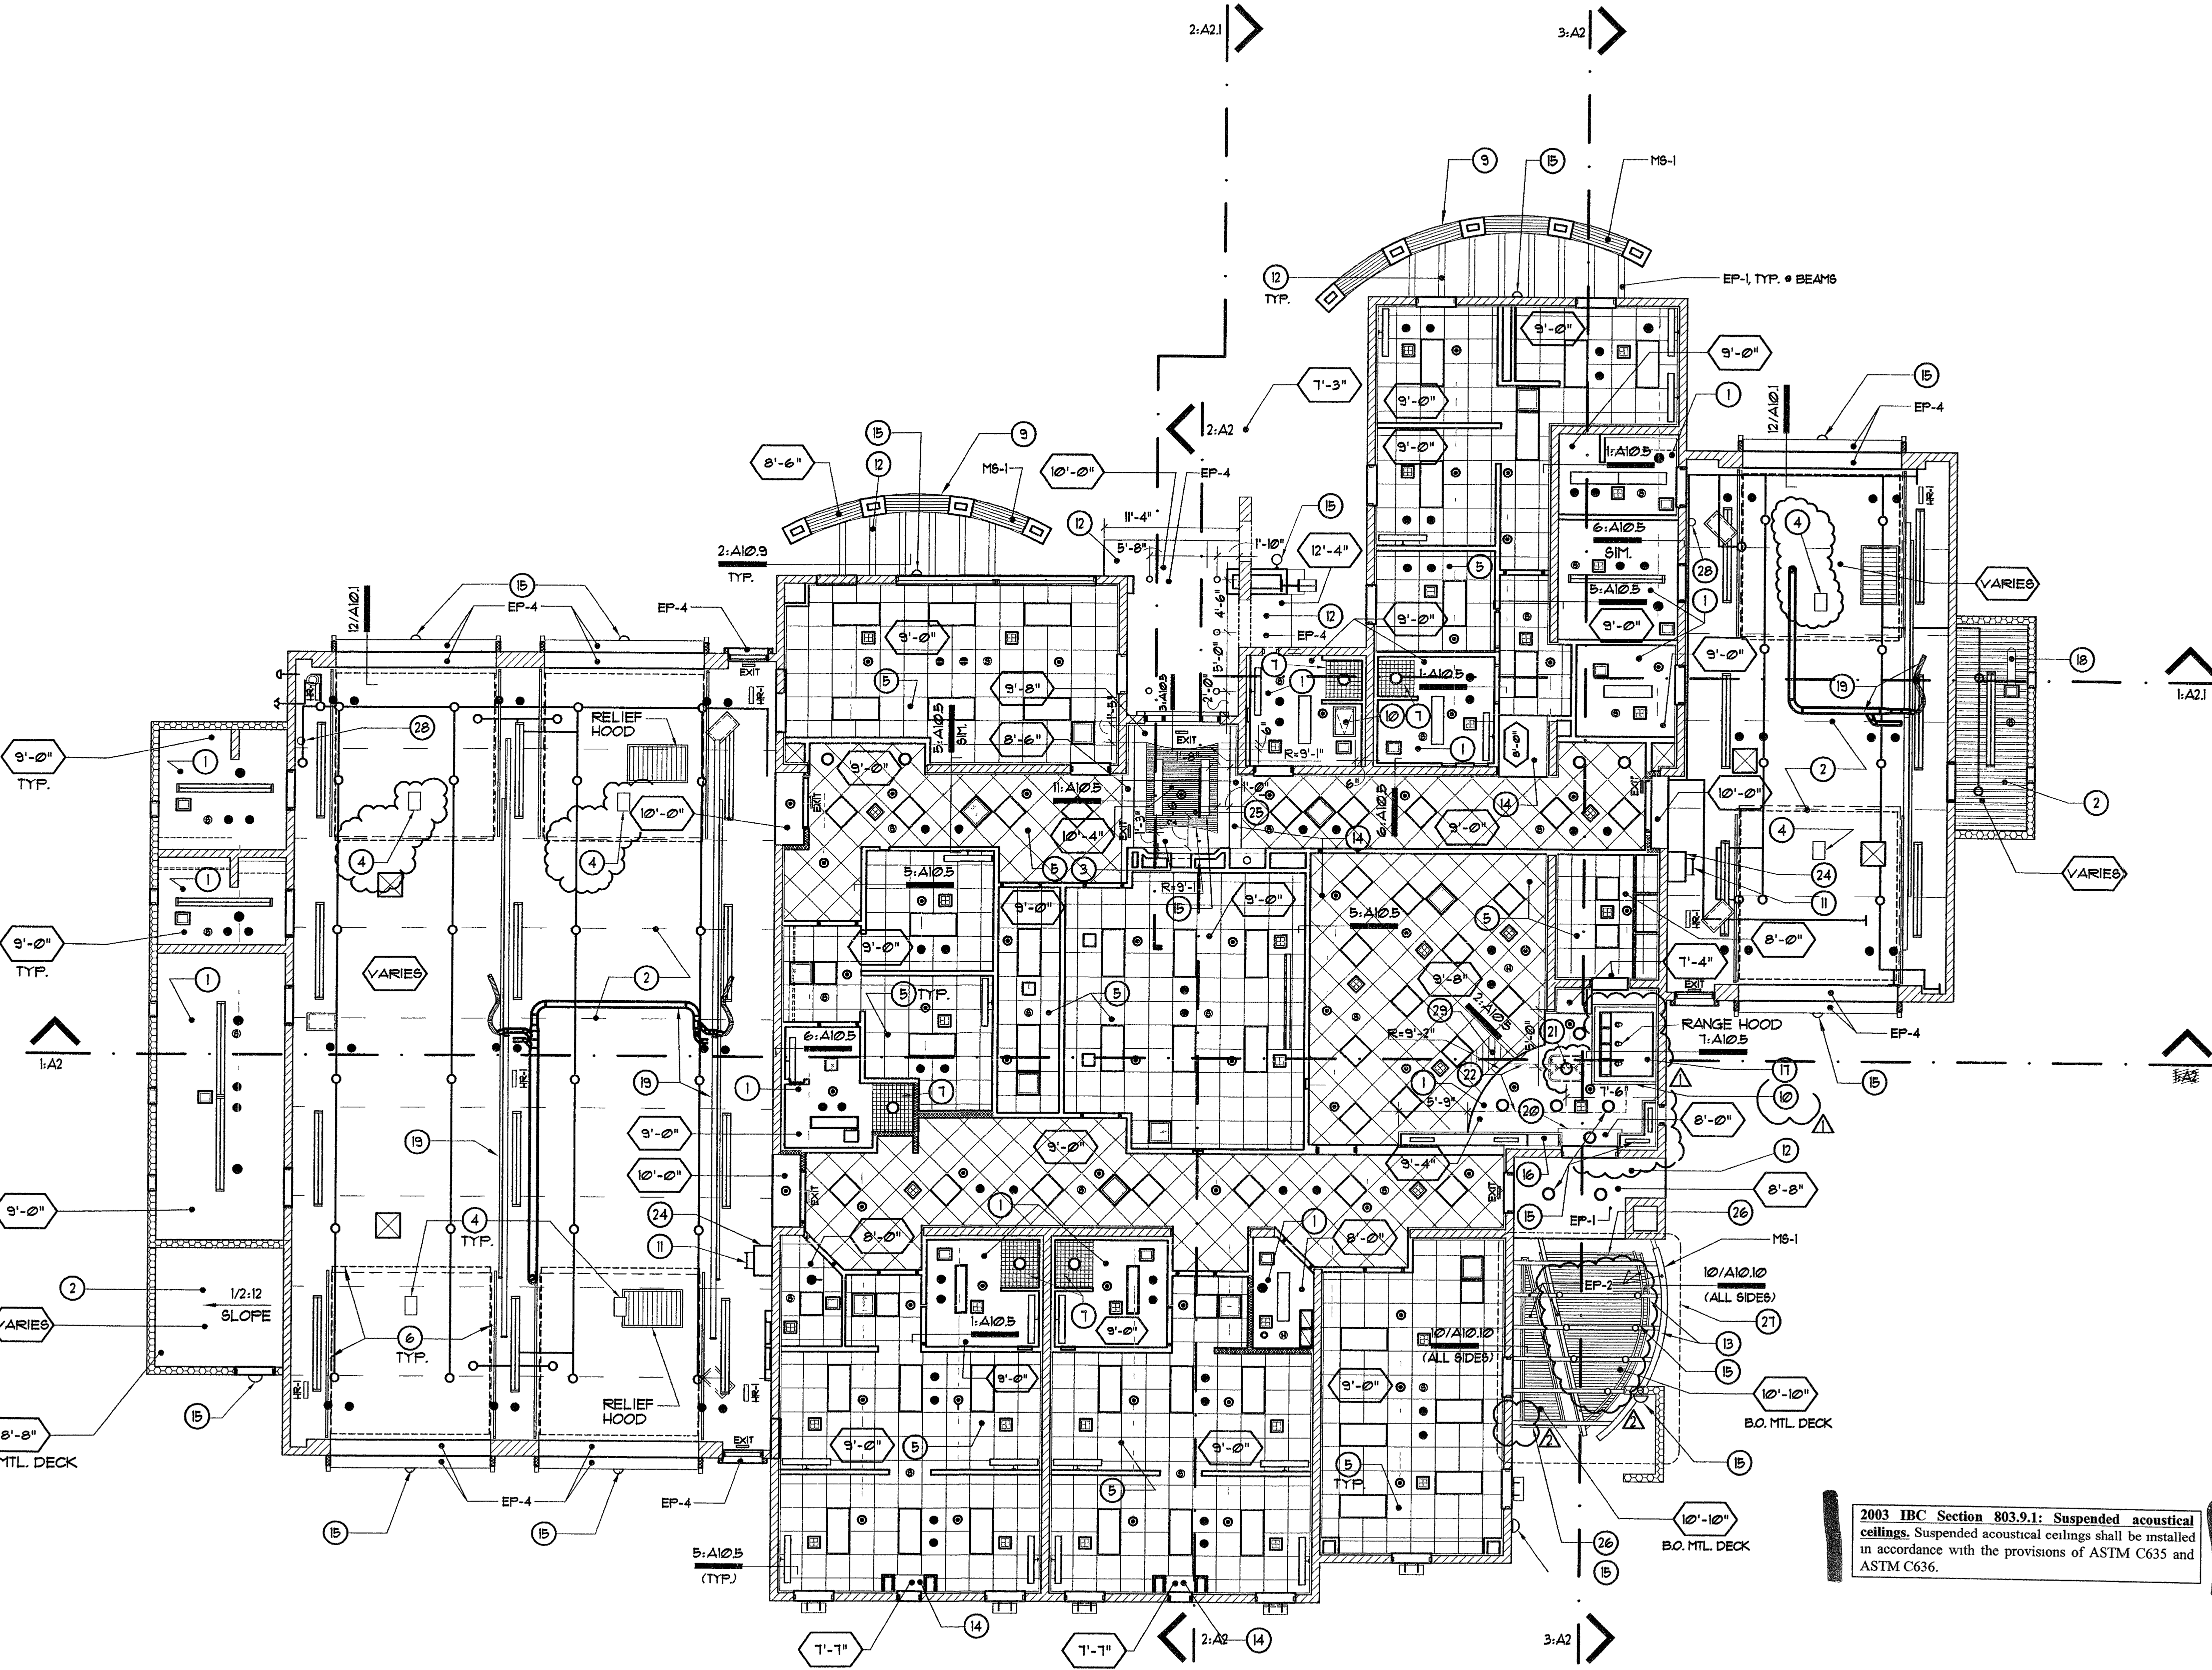

Reflected Ceiling Plan

Scale: 1/8" = 1'-0"

Project North

Keynotes

- 5/8" TYPE "X" GYP. BD. CEILING, PAINT PER FINISH LEGEND.
- EXPOSED CEILING TRUSSES AND/OR METAL ROOF DECK, PAINT TO MATCH WALLS.
- 5/8" TYPE "X" GYP. BD. FINISHED CEILING COVE, PAINT PER FINISH LEGEND, SEE DETAIL 8.
- OVERHEAD DOOR OPENER AND TRACK (CENTERED ON DOOR OPENINGS, TYP.).
- 2' x 2' SUSPENDED ACOUSTICAL TILE CEILING, SEE SPECIFICATIONS.
- LINE OF OVERHEAD DOOR AND OVERHEAD DOOR TRACKS.
- CERAMIC TILE TO MATCH RESTROOM WALL (USE FIELD COLOR).
- WINDOW CANOPY, SEE DETAILS KEYED IN ON SHEETS A41, A42 & A102.
- TRELLIS COLUMN HEADER, SEE DET. 12/A102, MTL. SIDING FINISH, SEE SHT A-42.
- UL LISTED 1-HOUR ENCLOSURE AROUND TYPE I HOOD, SEE DETAIL 1/A103.
- ROOF LADDER UP TO ROOF HATCH, SEE DETAIL 1/A93. CENTER LADDER UNDER ROOF HATCH.
- LIGHT SAND STUCCO FINISH TO MATCH BUILDING, SEE SPECIFICATIONS.
- TUBE STEEL PATIO CANOPY, SEE DETAIL 2/A102 AND STRUCT'L DIAGS. PAINT W/ COLOR: (EP-2).
- 5/8" TYPE "X" GYP. BD. CEILING SOFFIT, PAINT.
- LIGHT FIXTURE, SEE LIGHT FIXTURE LEGEND - THIS PAGE & ELECTRICAL DRAWINGS.
- MICROWAVE, SEE INTERIOR ELEVATION DETAIL 26/A82.
- RANGE HOOD, SEE MECHANICAL DRAWINGS.
- EXPOSED DUCTWORK AND DIFFUSER, SEE MECHANICAL DIAGS.
- DIESEL EXHAUST HOSE AND TRACK SYSTEM, SEE VEHICLE EXHAUST PLAN DIAG.
- 5/8" TYPE "X" GYP. BD. CEILING SOFFIT, SEE INT. ELEVATIONS.
- HANGING POT RACK @ 1'-0" FROM FINISHED FLOOR TO BOTTOM EDGE OF RACK.
- 4" WIDE 3/4" PLYWOOD "CATWALK" ABOVE KITCHEN FRAMING FOR ACCESS TO GREASE SHAFT DUCTWORK.
- STUCCO FINISHED BEAMS, W/ MTL. COPING, SEE DETAIL.
- ROOF LADDER SUPPORT CHASE, BOTTOM OF CHASE TO BE AT 8'-4" AFF, SEE DETAIL 1/A93. CHASE TO BE METAL FRAMED W/ PAINTED GYP. BD. FINISH (CENTER THE SUPPORT CHASE DIRECTLY UNDER ROOF HATCH).
- LAMINATE (LAM-3) O/ 1/2" PLYWOOD O/ MTL. STUD FRAMING. COORD. W/ CABINET MFR.
- METAL TRIM, SEE DETAIL 10/A1010. MITER CUT & BEAM TRIM TOGETHER AT ALL CORNERS.
- STUB OUT CONDUITS AND LOCATE ELECTRICAL CONDUITS ABOVE PATIO CANOPY ROOF DECK. ONLY LOCATE J-BOXES FOR CANOPY LIGHTS BELOW ROOF DECK. PROVIDE A WATERTIGHT SEAL AT ALL CONDUIT PENETRATIONS THRU ROOF DECK.
- CONTRACTOR TO PROVIDE 3/4" EMT CONDUIT THROUGH ROOF FOR "GPS SYSTEM" FROM BATTERY CHARGER LOCATION.
- PROVIDE 2X4 OPENING IN CEILING GRID & 2X4 CEILING TILE FOR ATTIC ACCESS.

Light Fixture Legend

- (PROVIDE PROPER BLOCKING IN WALLS FOR WALL MOUNTED FIXTURES.)
- WALL MOUNTED INCANDESCENT FIXTURE
 - WALL MOUNTED UP & DOWN FLUORESCENT FIXTURE
 - 2' x 2' FLUORESCENT "PARAMAX" FIXTURE
 - 2' x 4' FLUORESCENT "PARAMAX" FIXTURE
 - SURFACE MOUNTED FLUORESCENT FIXTURE
 - RECESSED INCANDESCENT DOWN-LIGHT
 - SURFACE MOUNTED STRIP FLUORESCENT FIXTURE
 - EXTERIOR LIGHT FIXTURE, SEE ELECTRICAL DRAWINGS. & SHT. A41, A42 FOR MOUNTING HT. OF FIXTURES.
 - CEILING HUNG PENDANT FIXTURE, SEE ELECTRICAL DRAWINGS.

Mech. / Plumb. Fixture Legend

- MECHANICAL DUCTWORK THRU CEILING, SEE MECH. DIAGS.
- MECHANICAL GRILL, SEE MECHANICAL DRAWINGS.
- MECHANICAL GRILL, SEE MECHANICAL DRAWINGS.
- MECHANICAL GRILL, SEE MECHANICAL DRAWINGS.
- MECHANICAL EQUIPMENT, SEE MECHANICAL DRAWINGS.
- SPRINKLER HEAD & SPRINKLER LINES, SEE FIRE PROTECTION PLAN.
- SPRINKLER HEAD & SPRINKLER LINES, SEE FIRE PROTECTION PLAN.
- RADIO & LANDLINE SYSTEM SPEAKER, SEE SHEET E-41.
- SMOKE DETECTOR, SEE ELECTRICAL DRAWINGS, SHEET E-51.
- HEAT DETECTOR, SEE ELECTRICAL DRAWINGS, SHEET E-51.
- HEAT DETECTOR, SEE ELECTRICAL DRAWINGS, SHEET E-51.



REVISIONS
BLDG DEPT - 5/21/04
OWNER - 6/21/04

CONSULTANT

CITY OF LAS VEGAS, NEVADA
FIRE STATION 19
Reflected Ceiling Plan

RECEIVED
JUN 25 2004
CITY OF LAS VEGAS
PERMITS

OWNER: CITY OF LAS VEGAS
DEPARTMENT OF PUBLIC WORKS
ARCHITECTURAL SERVICES

ARCHITECT OF RECORD:
SAMUEL D. TOLMAN, AIA, NCARB
400 EAST STEWART AVENUE
LAS VEGAS, NEVADA 89101
PHONE: (702) 229-6535
FAX: (702) 382-3332
TDD: (702) 386-9108

DRAWN: EP8
FILE: 198-AS
DATE: 6/18/04
SCALE: 1/8" = 1'-0"
SHEET NO: 041534104
CLV DWN NO: 630-101

A5