

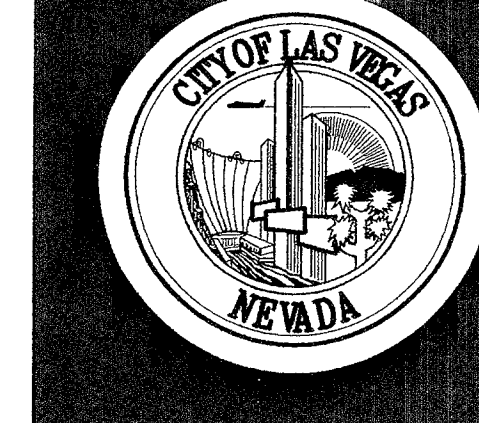
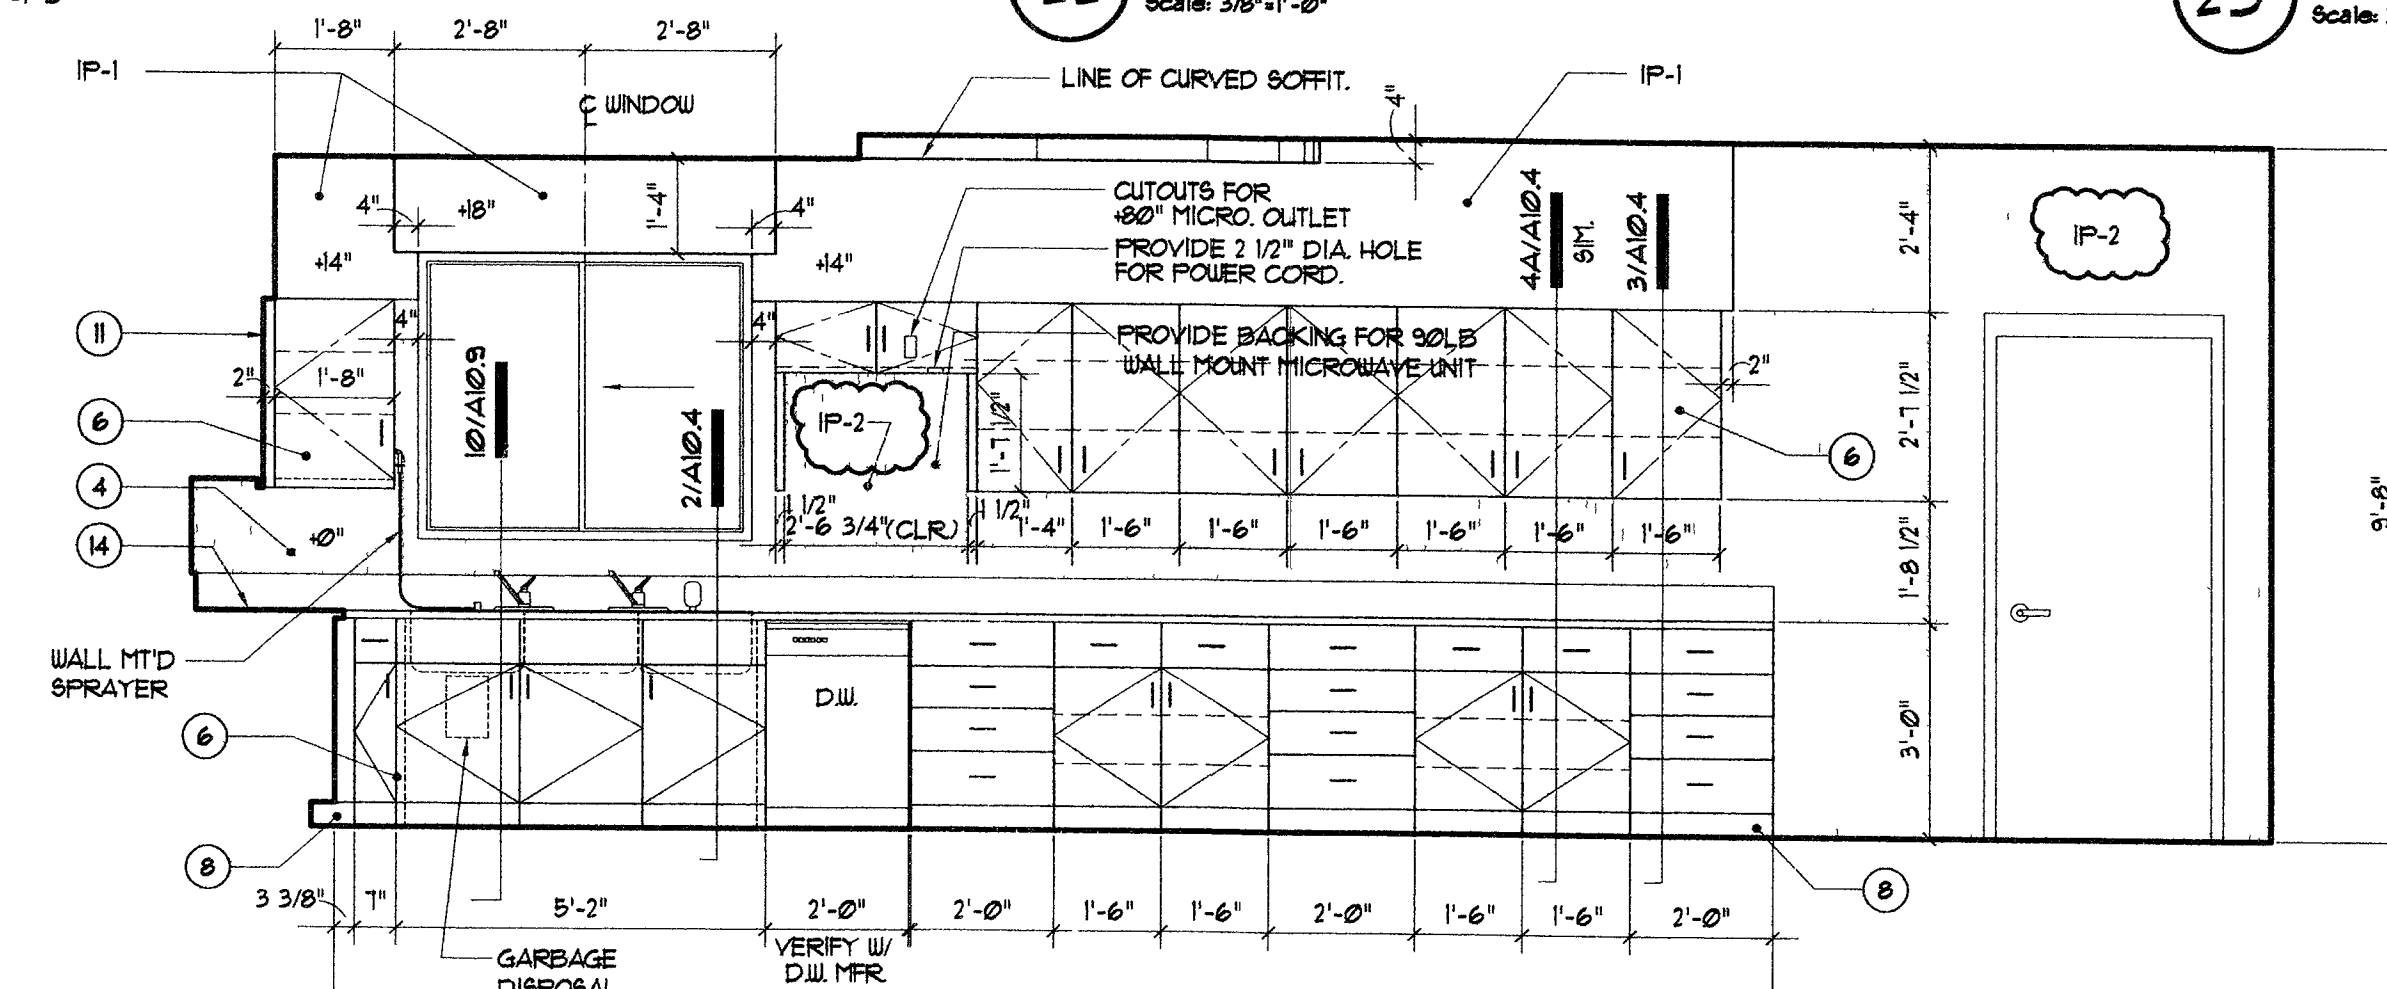
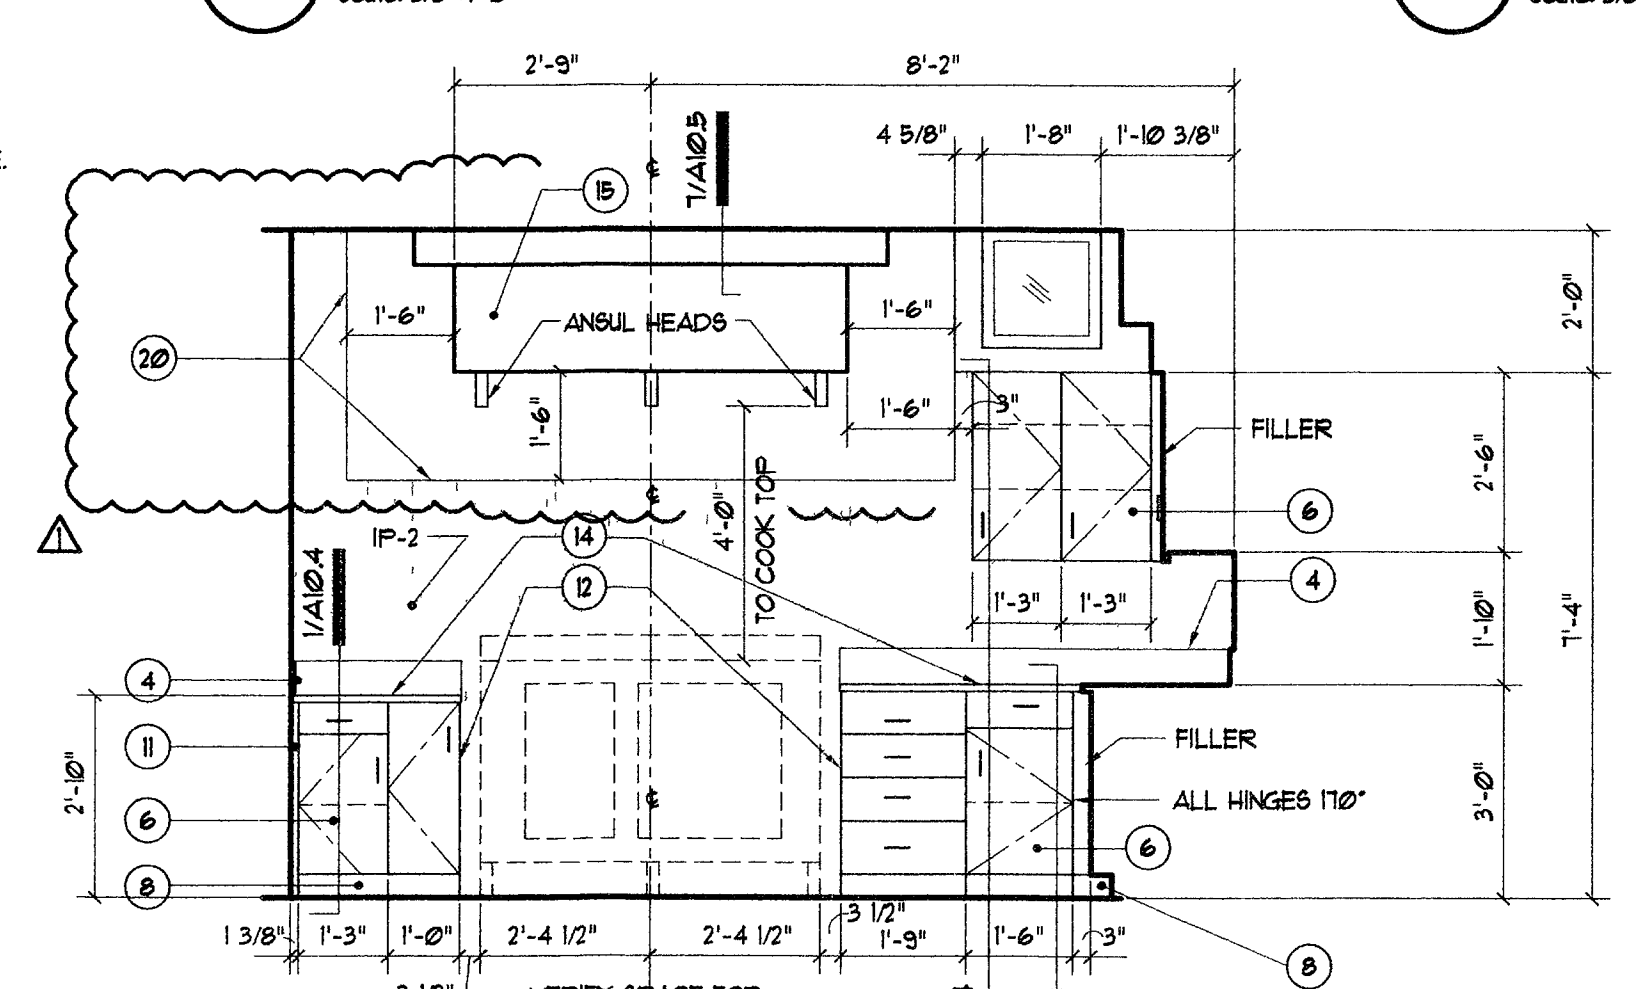
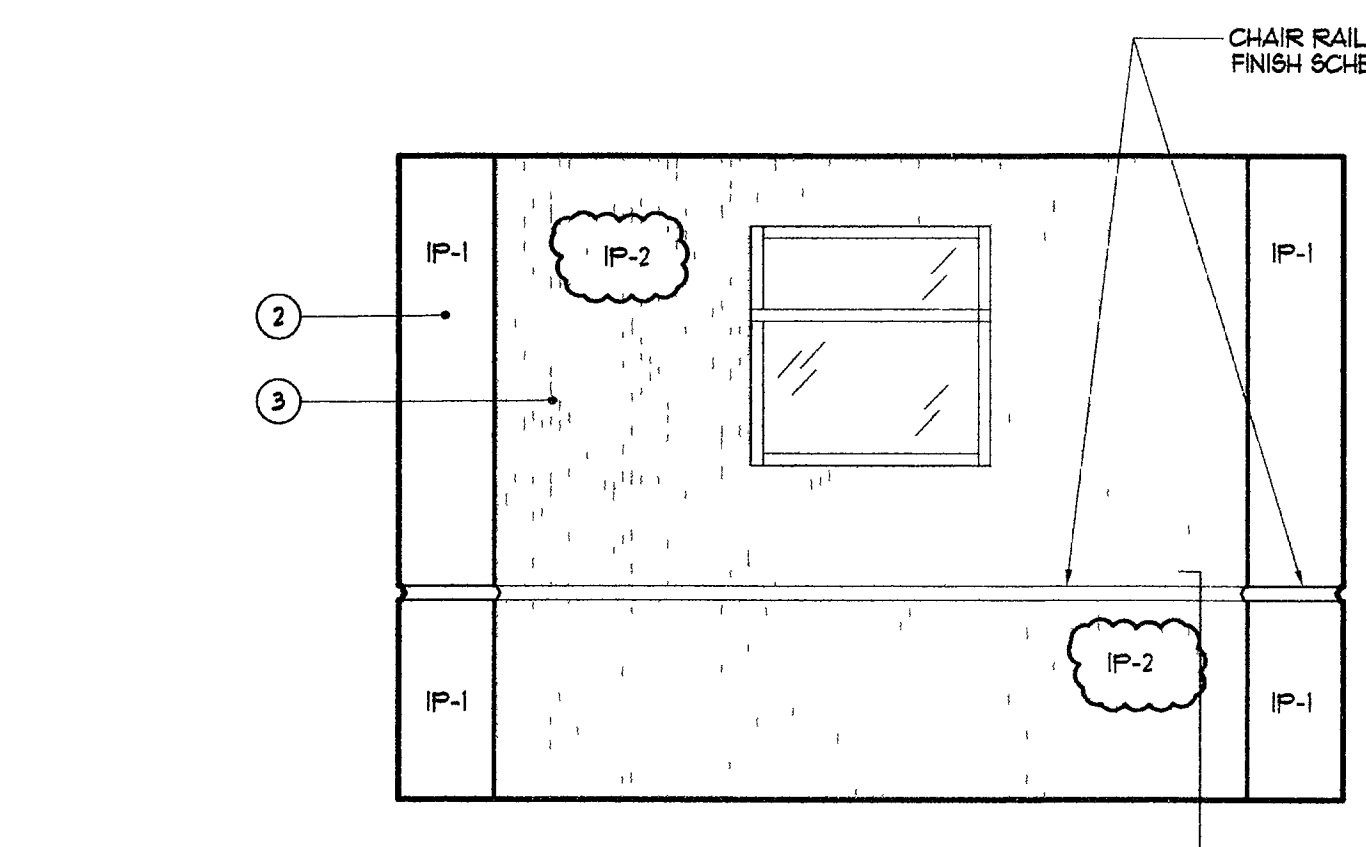
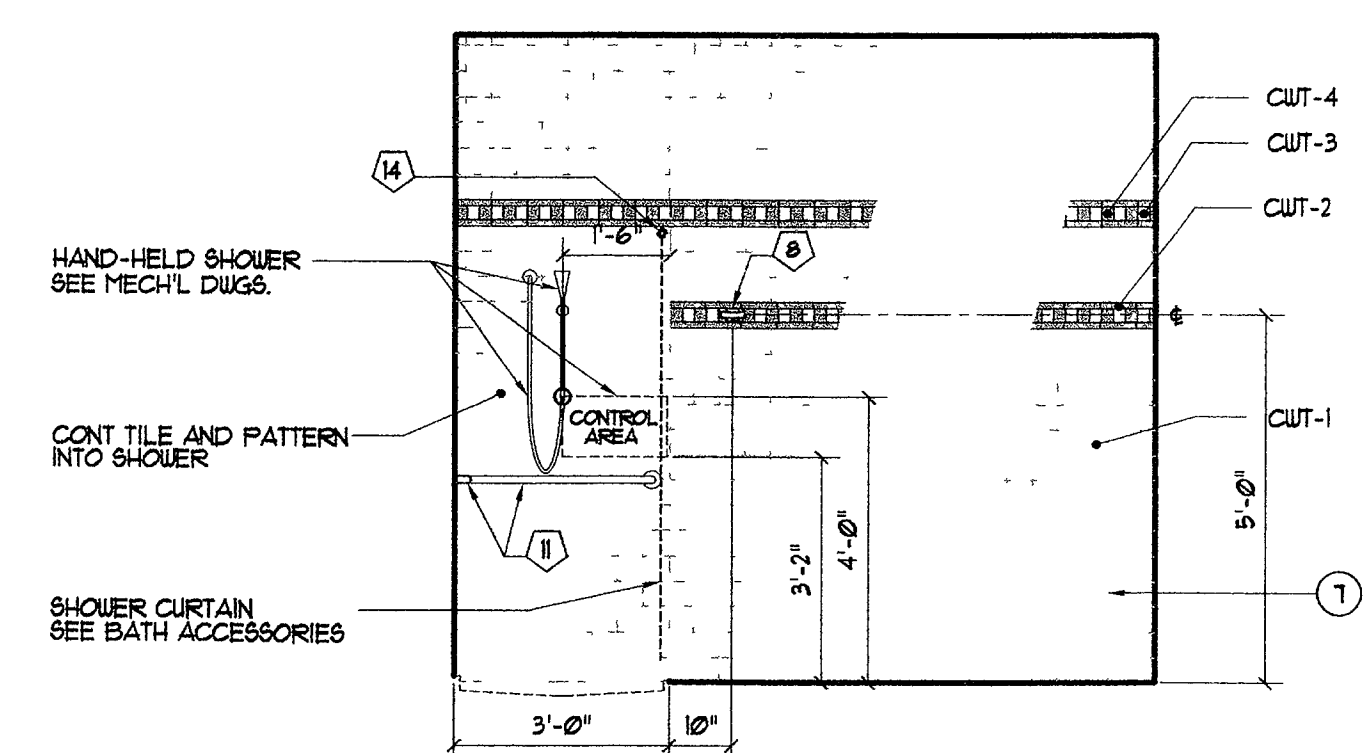
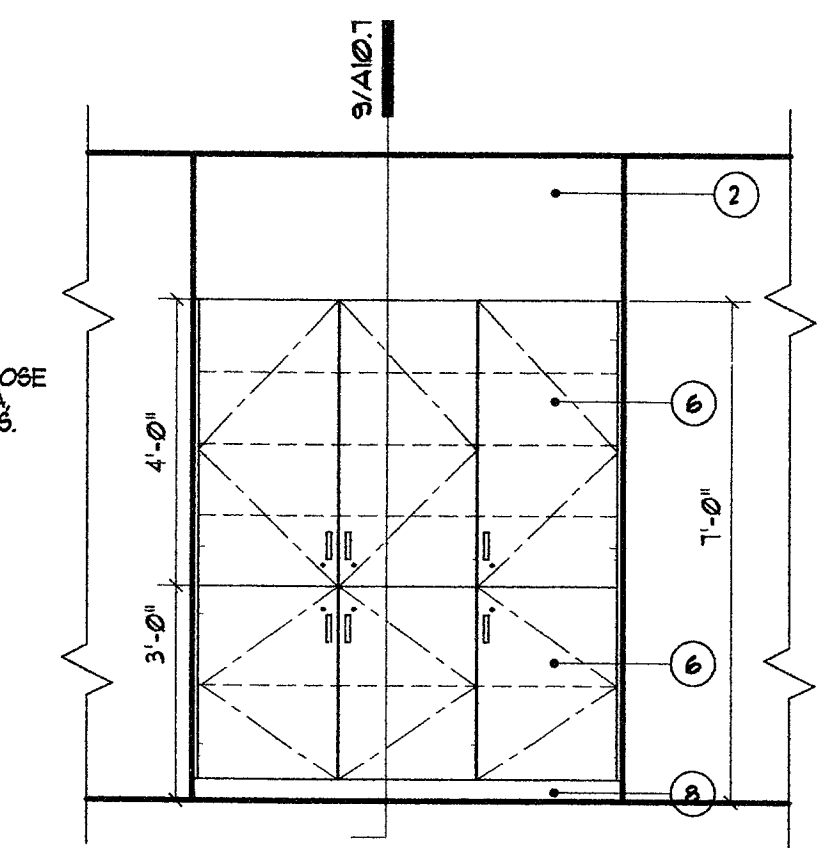
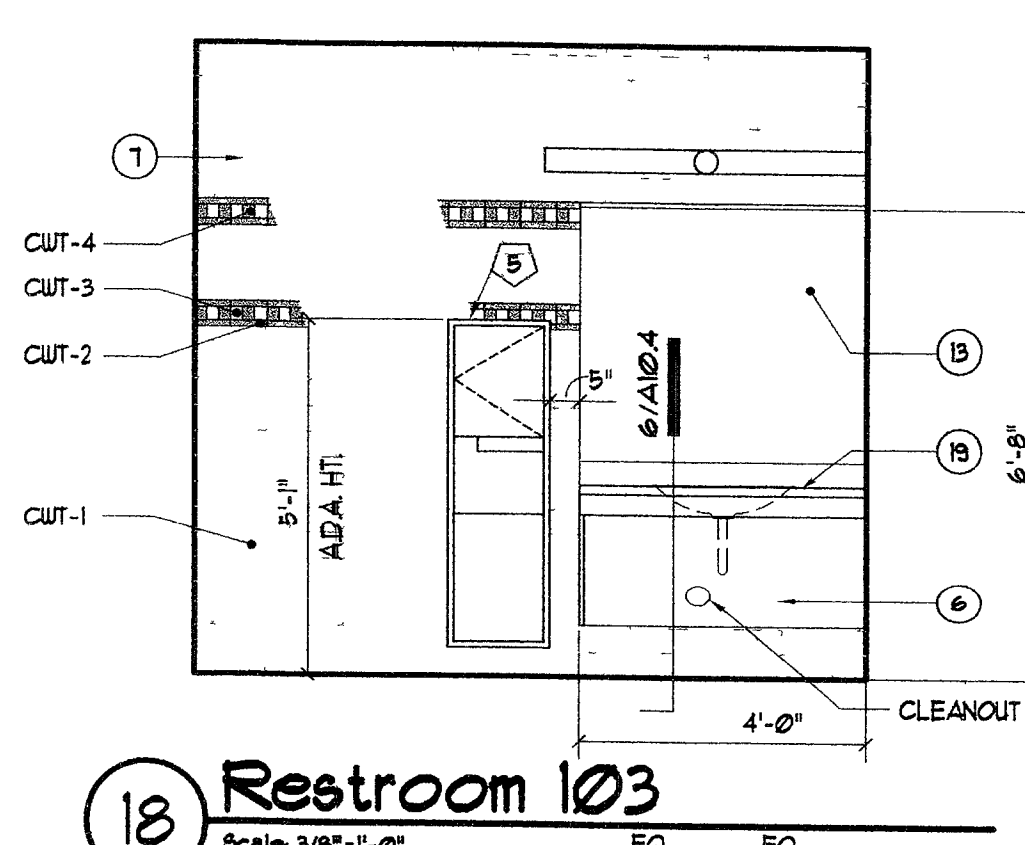
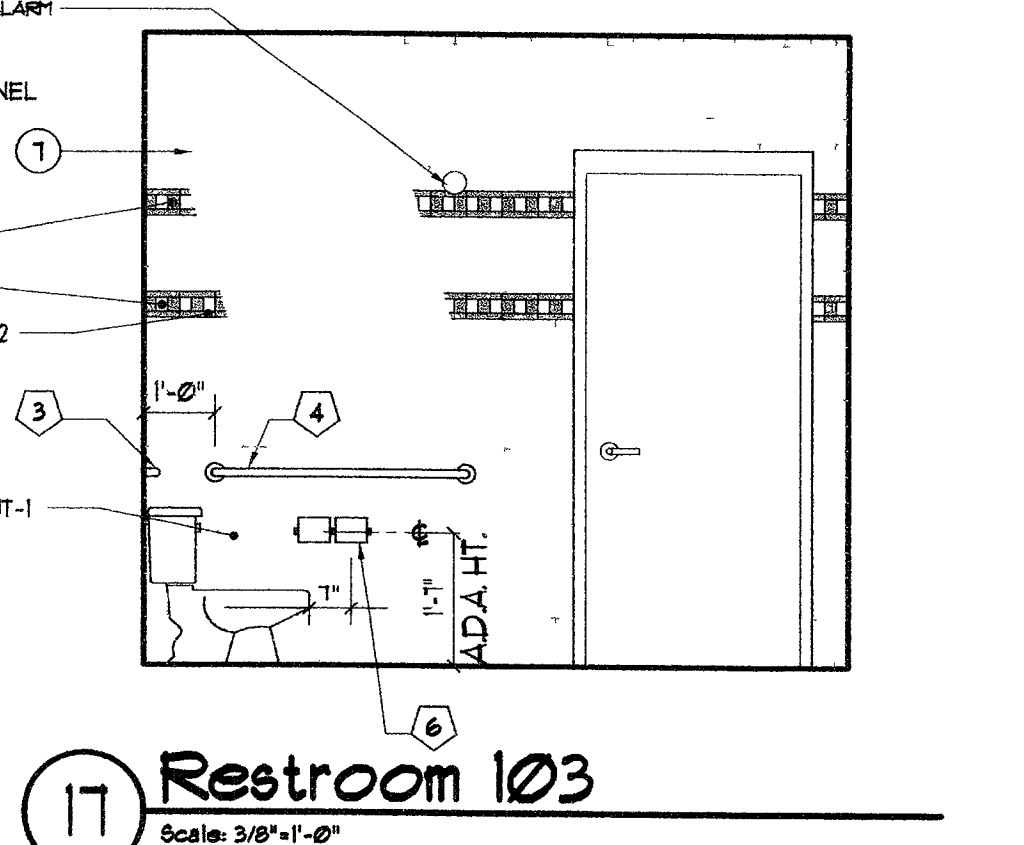


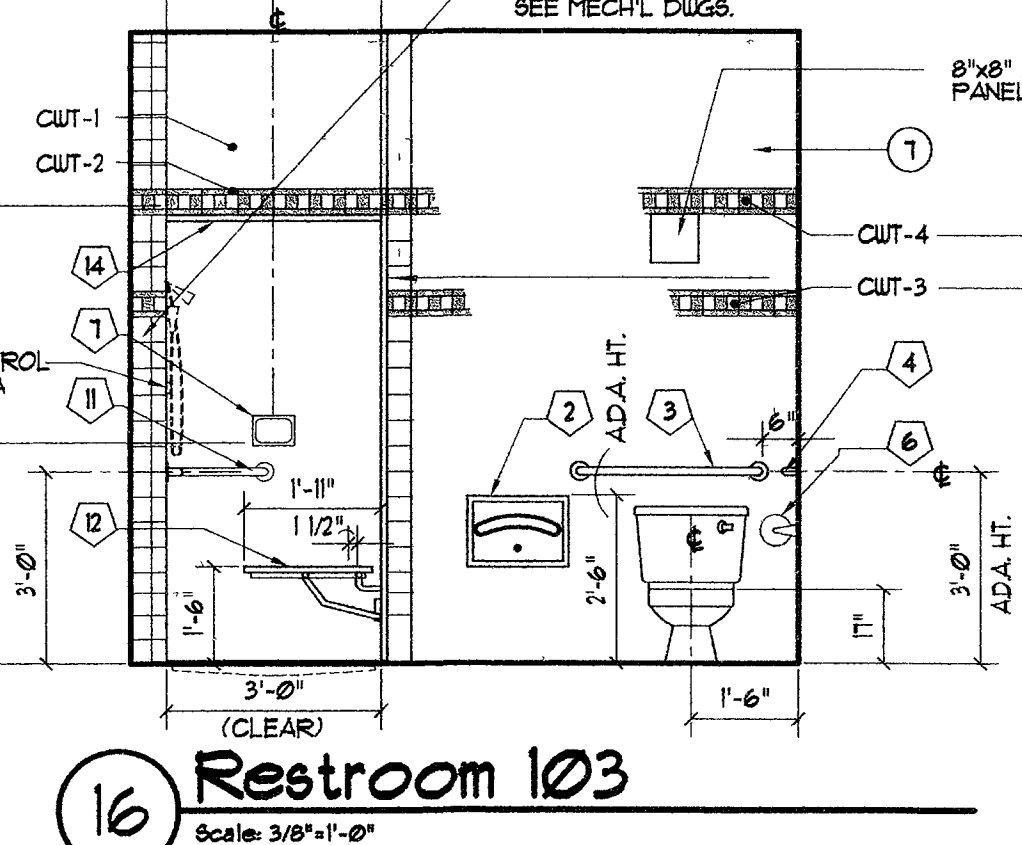

REVISIONS
BLDG DEPT - 5/21/04
CONSULTANT

GENERAL NOTE: SEE SHEET A81 FOR TOILET ACCESSORY SCHEDULE.

SHOWER DOOR SPECIFICATION:
ALL SHOWER ENCLOSURES (w/ SIDELIGHTS WHERE SHOWN) SHALL BE ALUMINUM FRAMED SHOWER ENCLOSURE, BY "CENTURY SHOWER DOORS" - (LUCETTE SERIES, MODEL NO. L-1675) OR "AMERICAN SHOWER DOOR" (MODEL # 50400) OR AFFID EQUAL SILVER ANODIZED FINISH & GLASS. VERIFY SIZE PRIOR TO FABRICATION.



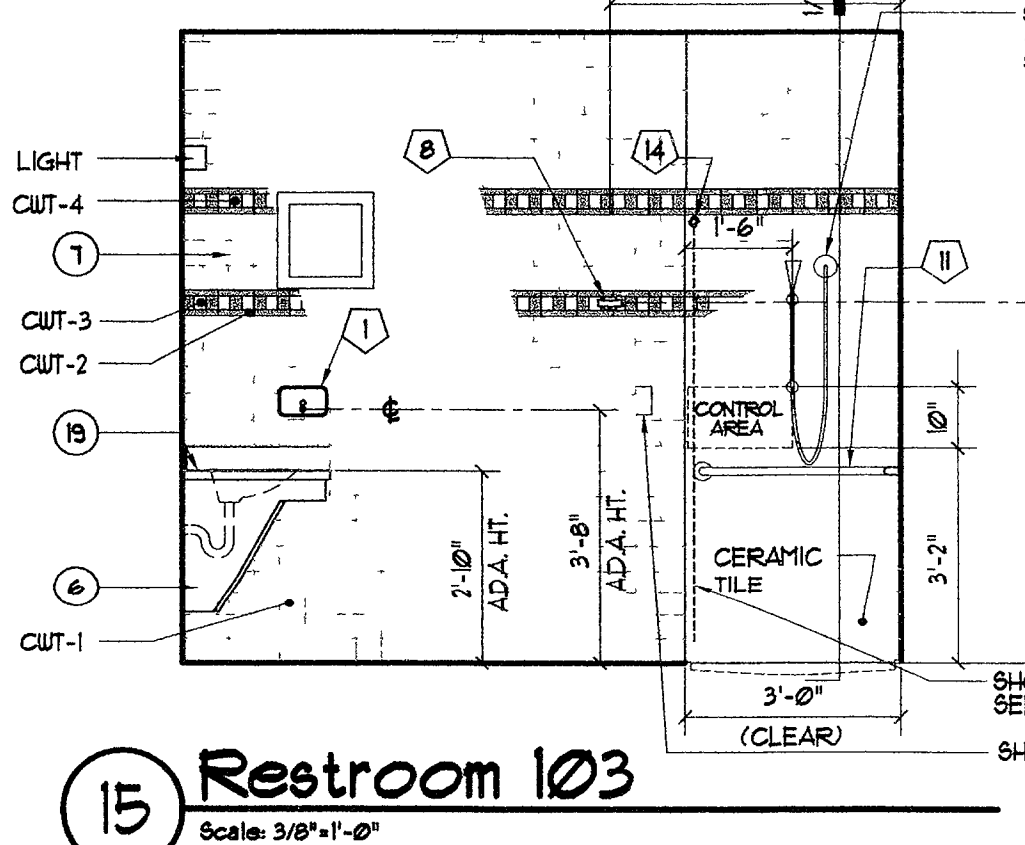


PLANS APPROVED
ARCHITECTURAL
Building & Safety Dept.
City of Las Vegas, Nevada





MJH JUN 17 2004

Does Not Include Structural, Electrical, Plumbing/Mechanical or Civil Site Improvements Make No Change Without Approval Plan Is Not a Permit to Violate Any Ordinance

RECEIVED
JUN 11 2004
CITY OF LAS VEGAS
BUILDING DEPT.

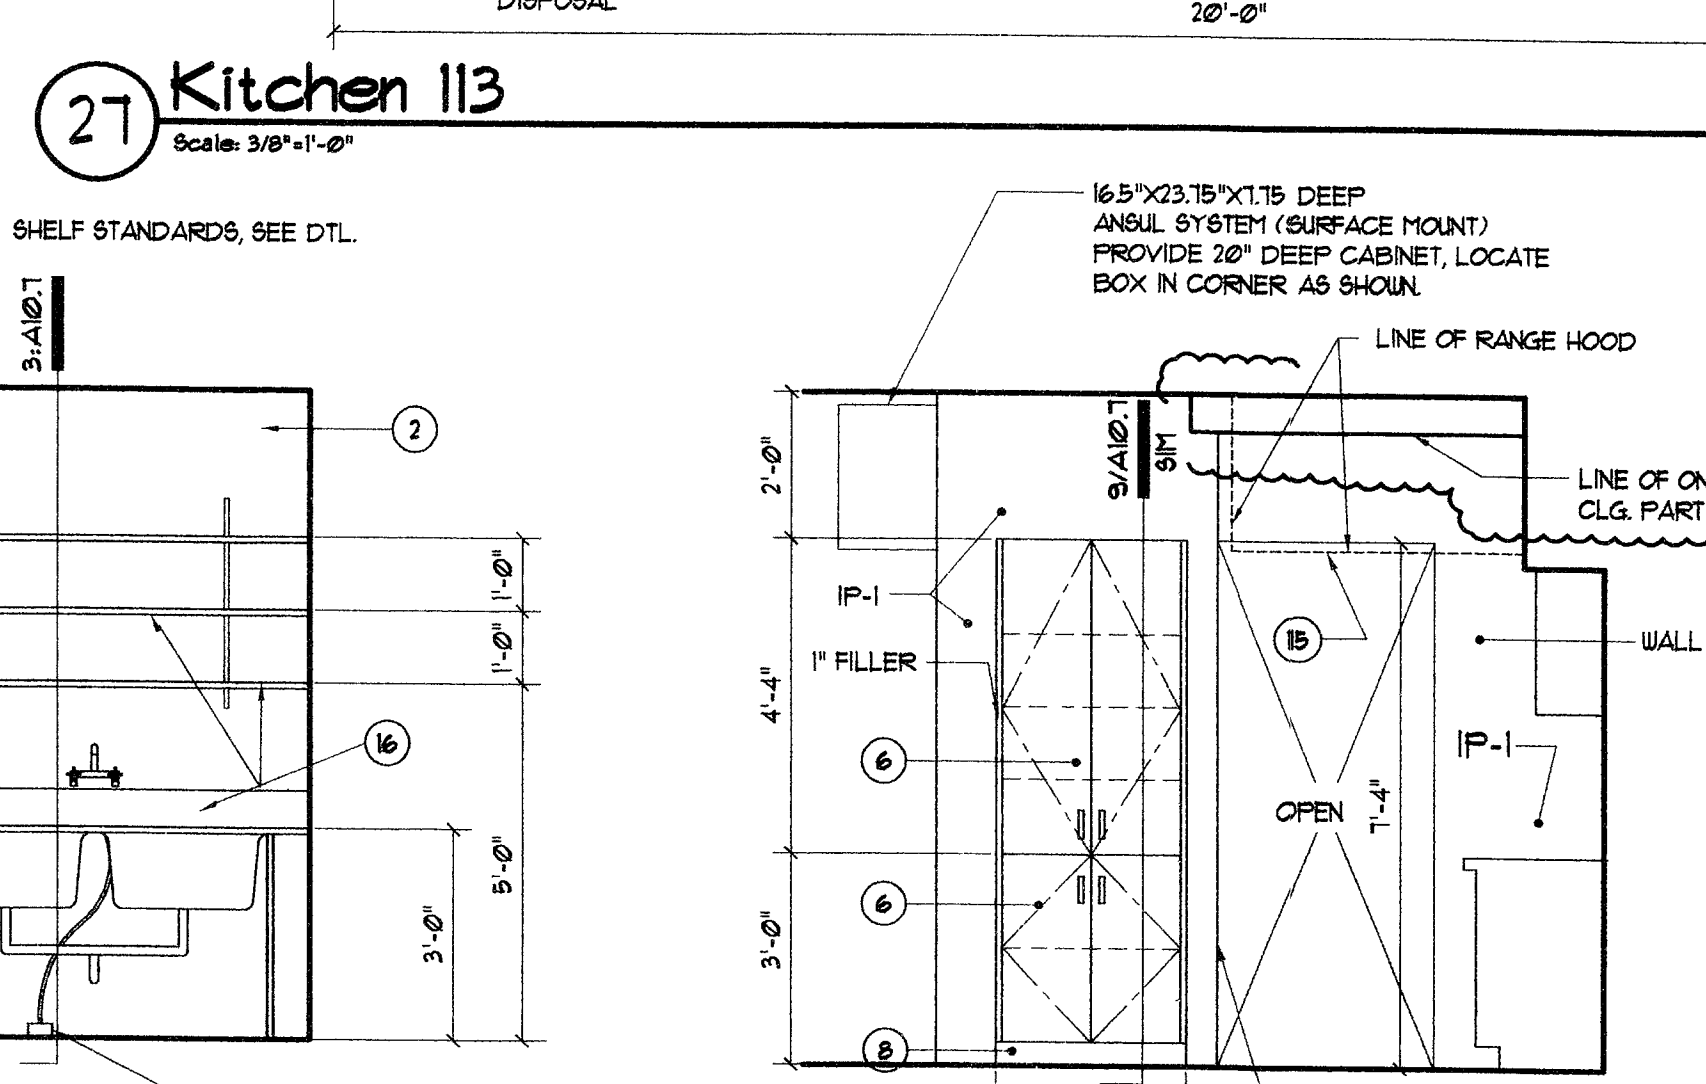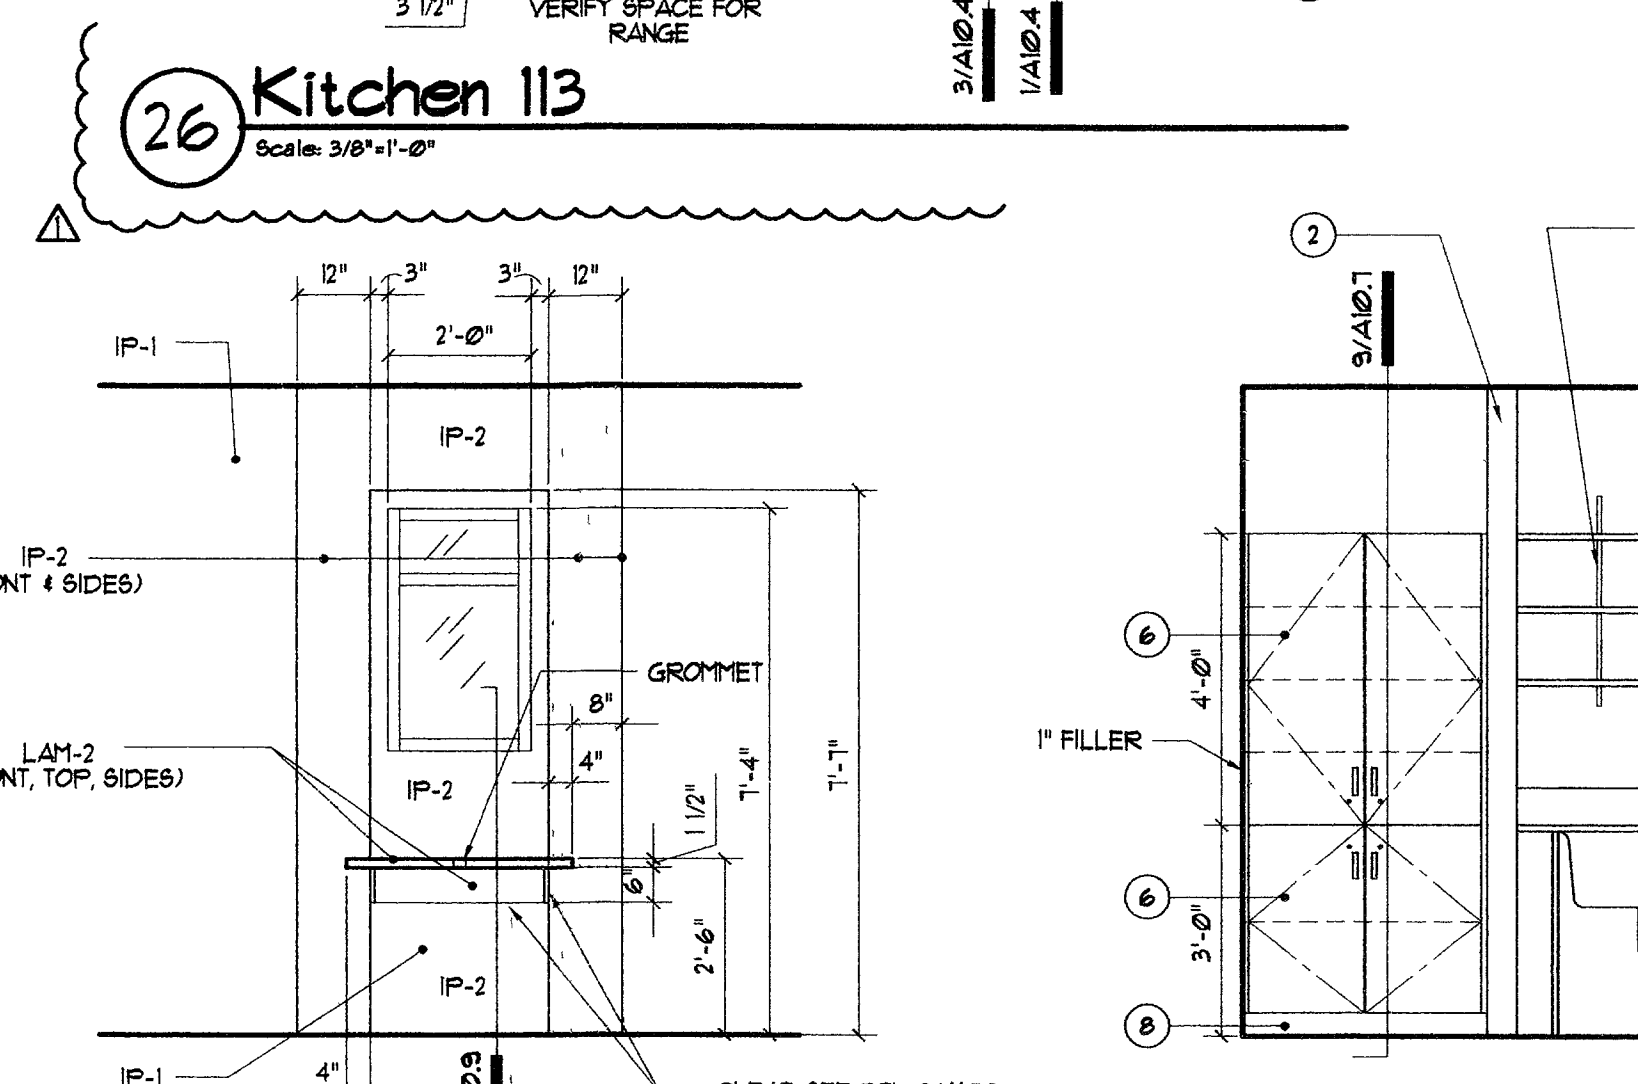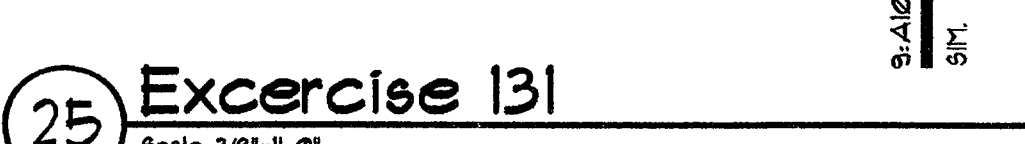

- ### Keynotes
- 1 CHU WALL, SEE WALL LEGEND ON SHEET G2.
 - 2 GYPSUM BOARD OVER METAL STUD FRAMING
 - 3 GYPSUM BOARD O/ FURRING CHANNELS
 - 4 STAINLESS STEEL BACKSPASH TO MATCH COUNTERTOP.
 - 5 ENGINEERED STONE COUNTERTOP, SEE ROOM FINISH SCHEDULE.
 - 6 PLASTIC LAMINATE (LAM-1) FINISH UPPER / BASE CABINETS & SIDES.
 - 7 CERAMIC WALL TILE AND COVE BASE
 - 8 RUBBER COVE BASE (RB-1), SEE SHT. A6.
 - 9 TACK BOARD, SEE SPECIFICATIONS
 - 10 MARKER BOARD, SEE SPECIFICATIONS
 - 11 EXTEND CAB. FACE TO ADJACENT SURFACE, SCRIBE TO FIT.
 - 12 FINISH END OF CABINETS W/ STAINLESS STEEL TO MATCH COUNTER, HEM EXPOSED EDGES.
 - 13 MIRROR, POLISH EDGES, ANCHOR W/ ADHESIVE, SEE SPEC'S.
 - 14 SWIRLED STAINLESS STL. FINISH COUNTERTOP.
 - 15 DASHED LINE INDICATES LINE OF S. STL. RANGE HOOD, SEE MECH. DUGS.
 - 16 S.S.TL. DISINFECTING SINK AND SHELVES, SEE PLUMBING SCHEDULE.
 - 17 PRE-FABRICATED ALUM./GLASS SHOWER DOOR W/ SIDELIGHT, (SEE SHOWER DOOR SPEC THIS SHEET.)
 - 18 LINEN CABINET, SEE DETAIL 9/A107.
 - 19 ENGINEERED STONE COUNTERTOP AND BACKSPASH - SEE FINISH SCHEDULE.
 - 20 S. STL. BACKING O/ INTERIOR SIDE OF WALL TYPE "A". S. STL. TO MATCH TYPE I HOOD (GAGE, FINISH, ETC.). FASTEN S. STL. BACKING PER FABRICATOR'S RECOMMENDATIONS. (SUBMIT SHOP DRAWINGS FOR ATTACHMENT/FABRICATION). EXTEND BACKING 18" BEYOND BACK OF HOOD (3 SIDES) AS SHOWN.

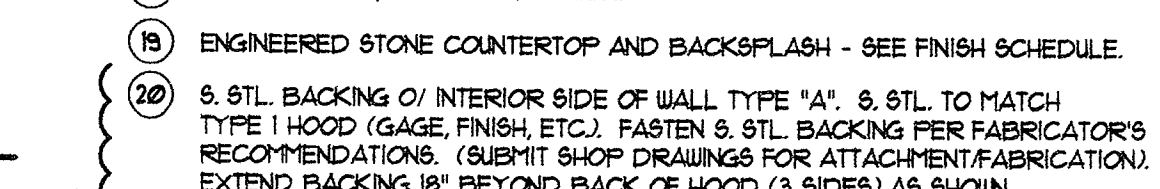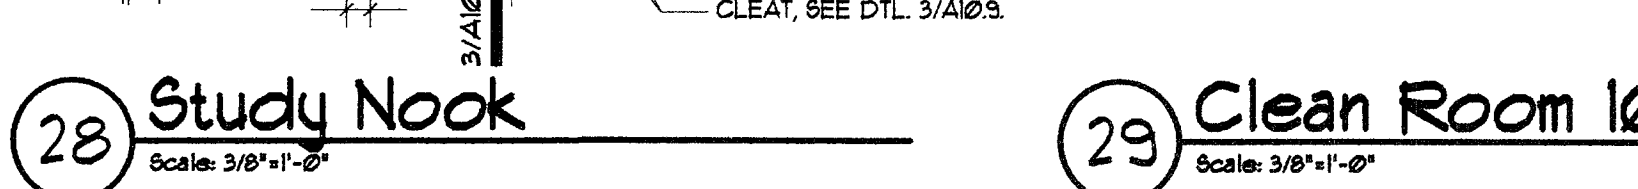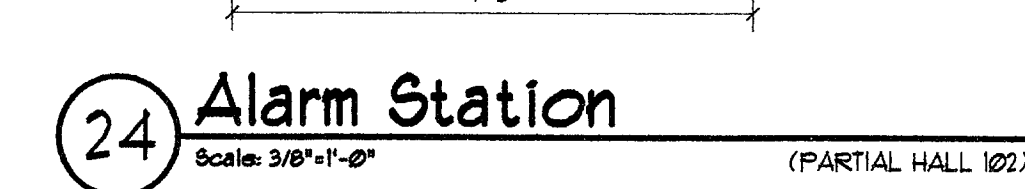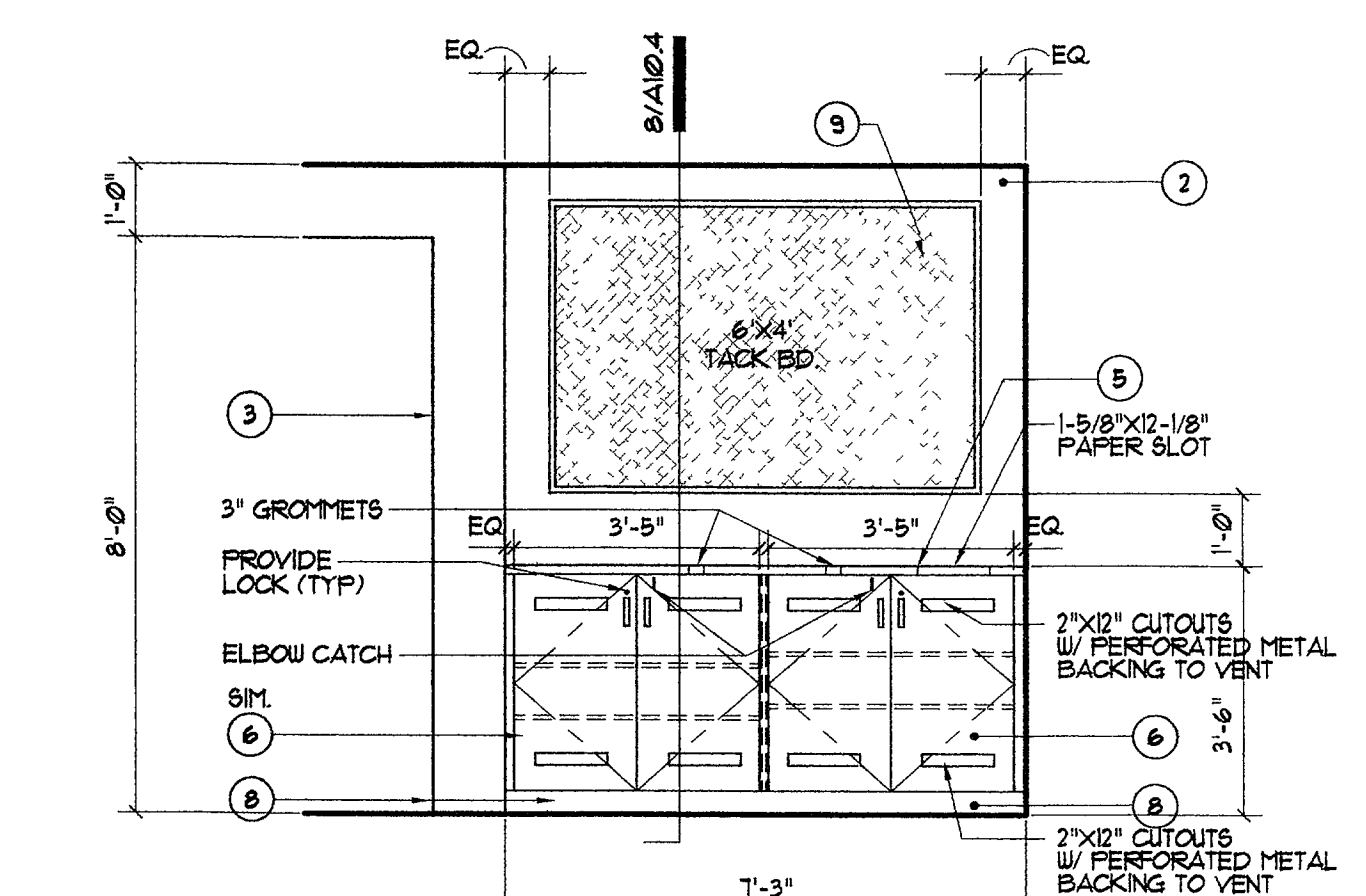

CITY OF LAS VEGAS, NEVADA
FIRE STATION #8
Interior Elevations

OWNER: CITY OF LAS VEGAS
DEPARTMENT OF PUBLIC WORKS
ARCHITECTURAL SERVICES

400 EAST STEWART AVENUE
LAS VEGAS, NEVADA 89101
PHONE: (702) 229-6535
FAX: (702) 382-5232
TDD: (702) 386-9108

DRAWN: EP6
FILE: f88-A82
DATE: 6/8/04
SCALE: 3/8"=1'-0"
SHEET NO: 04.15341.04
CLV DWG NO: 630-101

A8.2