


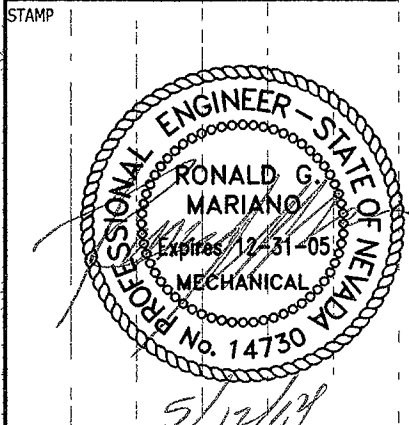

REVISIONS
5/12/04
BLDG DEPT. COMMENTS

CONSULTANT
COMFORT ENGINEERING
MECHANICAL - ELECTRICAL - PLUMBING
2550 LAS VEGAS AVENUE, SUITE 208
LAS VEGAS, NEVADA 89168
TEL: (702) 367-3892 • FAX: 367-1076
COURT REPORT DESIGN

CITY OF LAS VEGAS, NEVADA
FIRE STATION #8
ENLARGED PLUMBING PLANS -
DOMESTIC WATER



OWNER: CITY OF LAS VEGAS
DEPARTMENT OF PUBLIC WORKS
ARCHITECTURAL SERVICES

400 EAST STEWART AVENUE
LAS VEGAS, NEVADA 89101
PHONE: (702) 229-6535
FAX: (702) 382-3232
TDD: (702) 386-9108


DRAWN: DBB
FILE:
DATE: 4/2/04
SCALE: 1/4" = 1'-0"
BID NO: 041534104
CLV DWG NO: 630-101

SHEET NO: P6


RECEIVED
MAY 14 2004
CITY OF LAS VEGAS

DEPARTMENT OF PUBLIC WORKS


DRAWINGS AS INSTRUMENTS OF SERVICE ARE THE PROPERTY OF THE DESIGN PROFESSIONAL WHOSE STAMP OF CERTIFICATION APPEARS ON THE DRAWINGS AND SPECIFICATIONS. ANY USE OR REPRODUCTION IN WHOLE OR IN PART WITHOUT WRITTEN CONSENT IS STRICTLY PROHIBITED. COPIES OF THE DRAWINGS AND SPECIFICATIONS REMAINED BY THE CLIENT MAY BE UTILIZED ONLY FOR OCCUPANCY OF THE PROJECT FOR WHICH THEY WERE PREPARED AND NOT FOR THE CONSTRUCTION OF ANY OTHER PROJECT IN A C 633 790

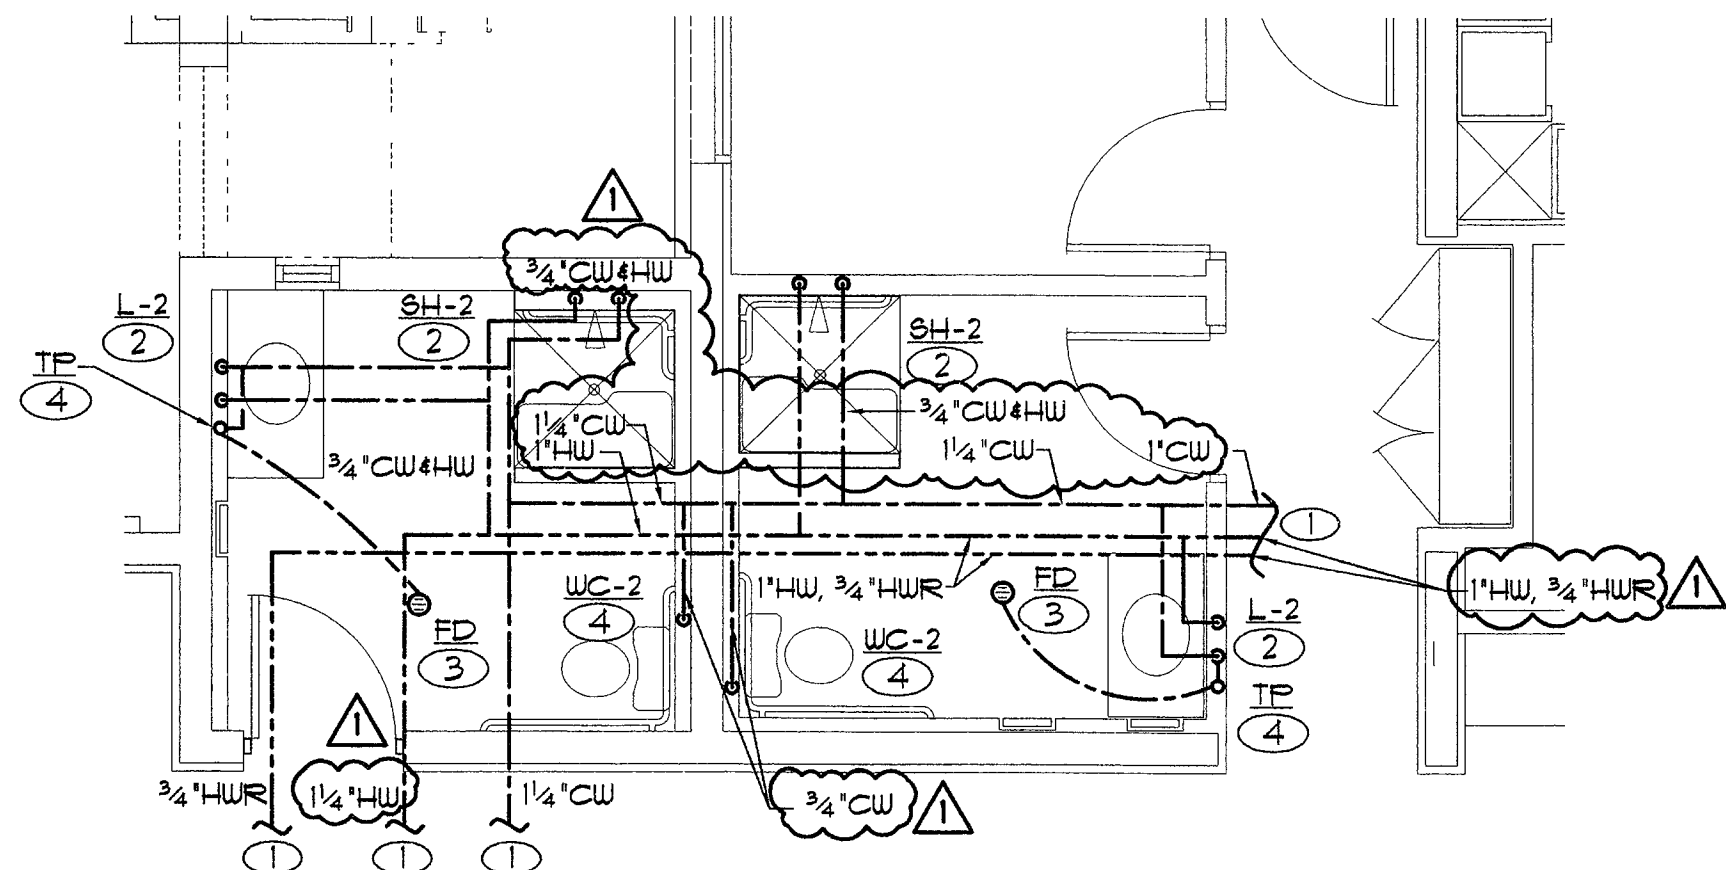


1 RESTROOM - DOMESTIC WATER
SCALE: 1/4" = 1'-0"

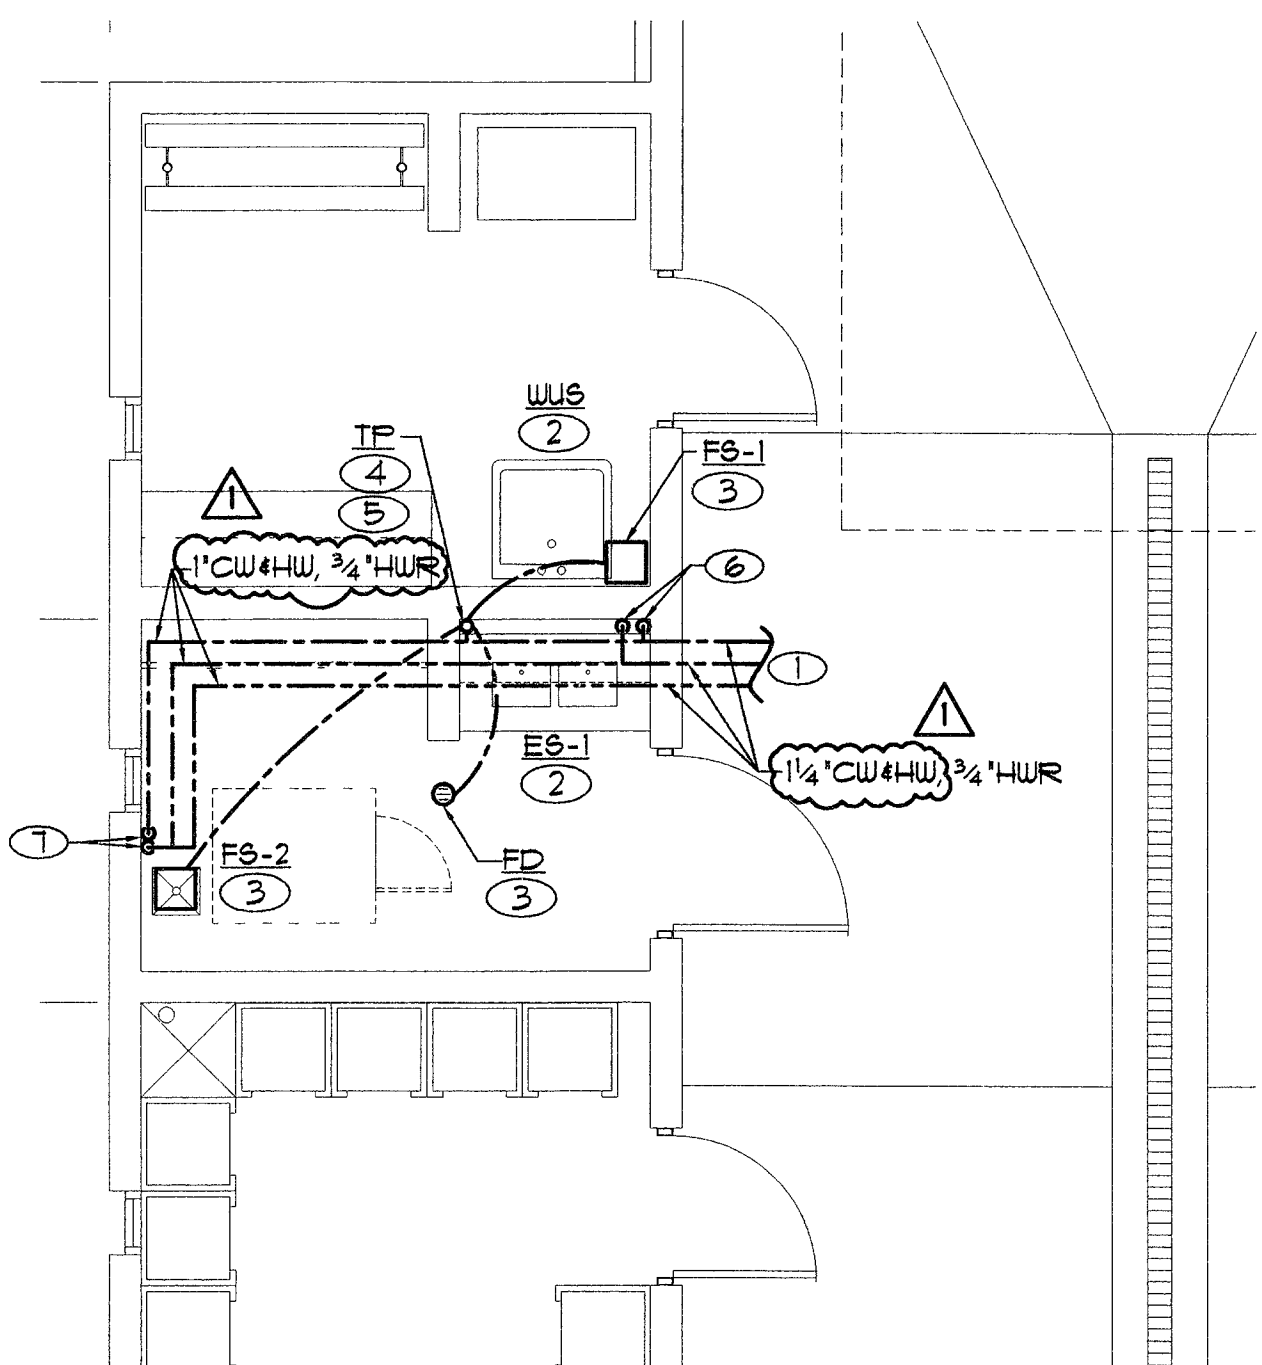


2 CLEAN ROOM - DOMESTIC WATER
SCALE: 1/4" = 1'-0"

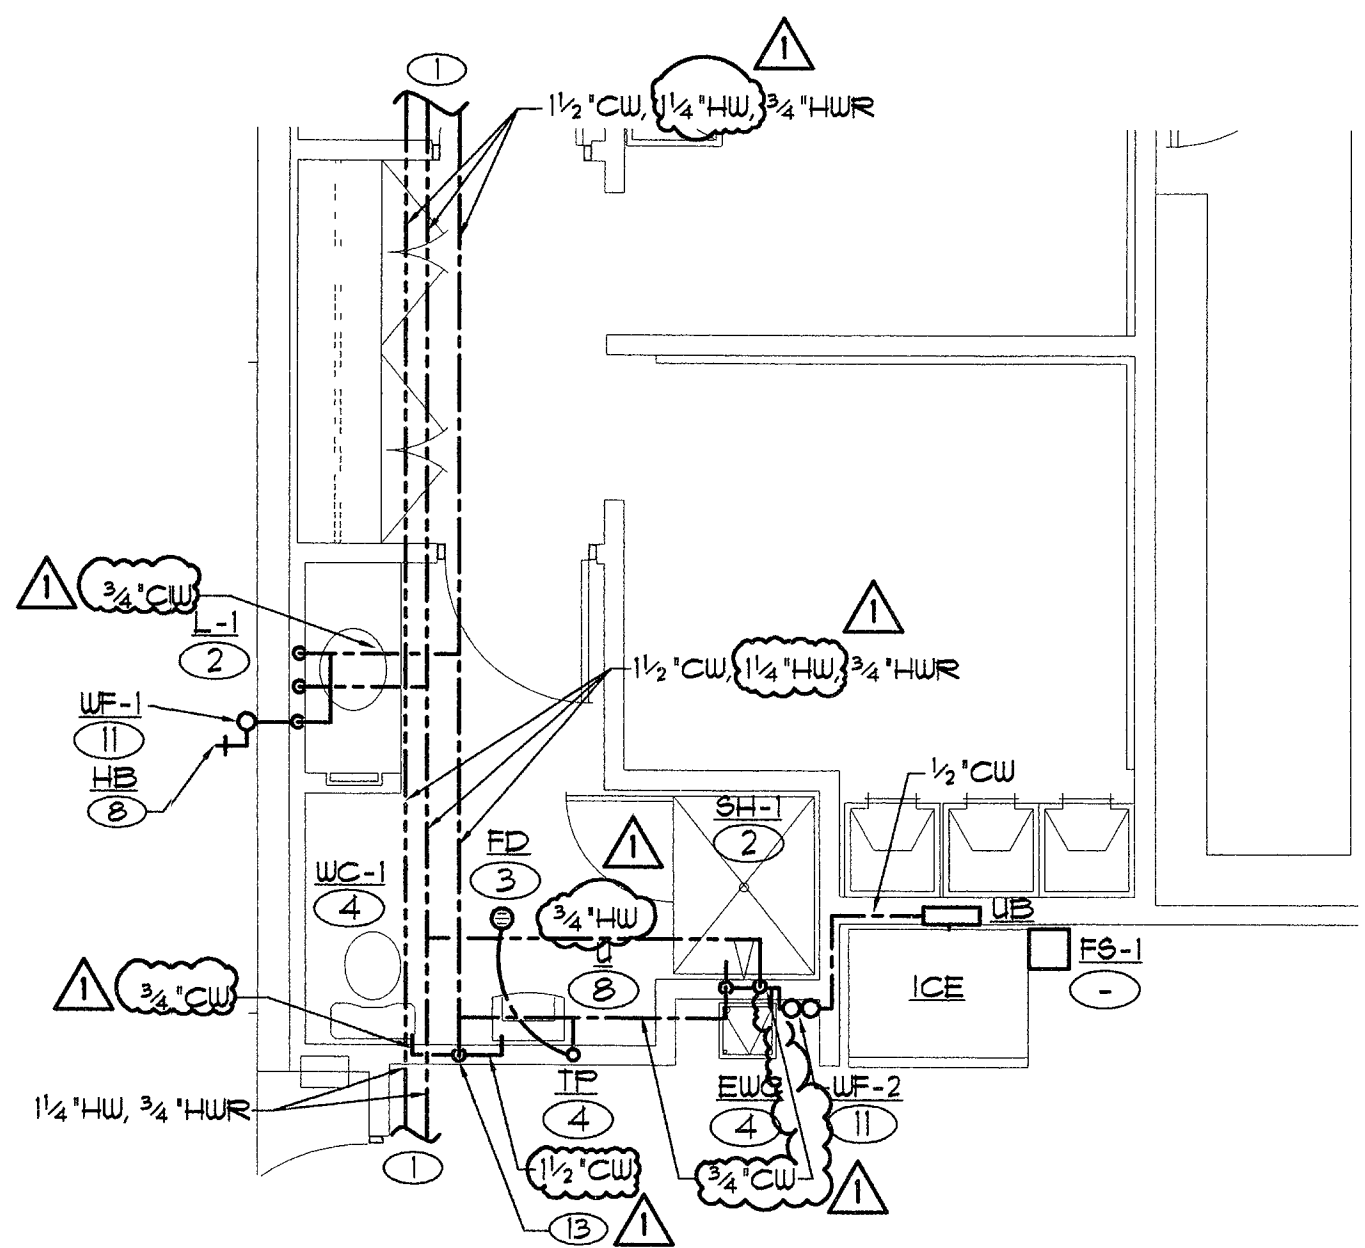


3 CAPTAIN'S BATHROOM - DOMESTIC WATER
SCALE: 1/4" = 1'-0"

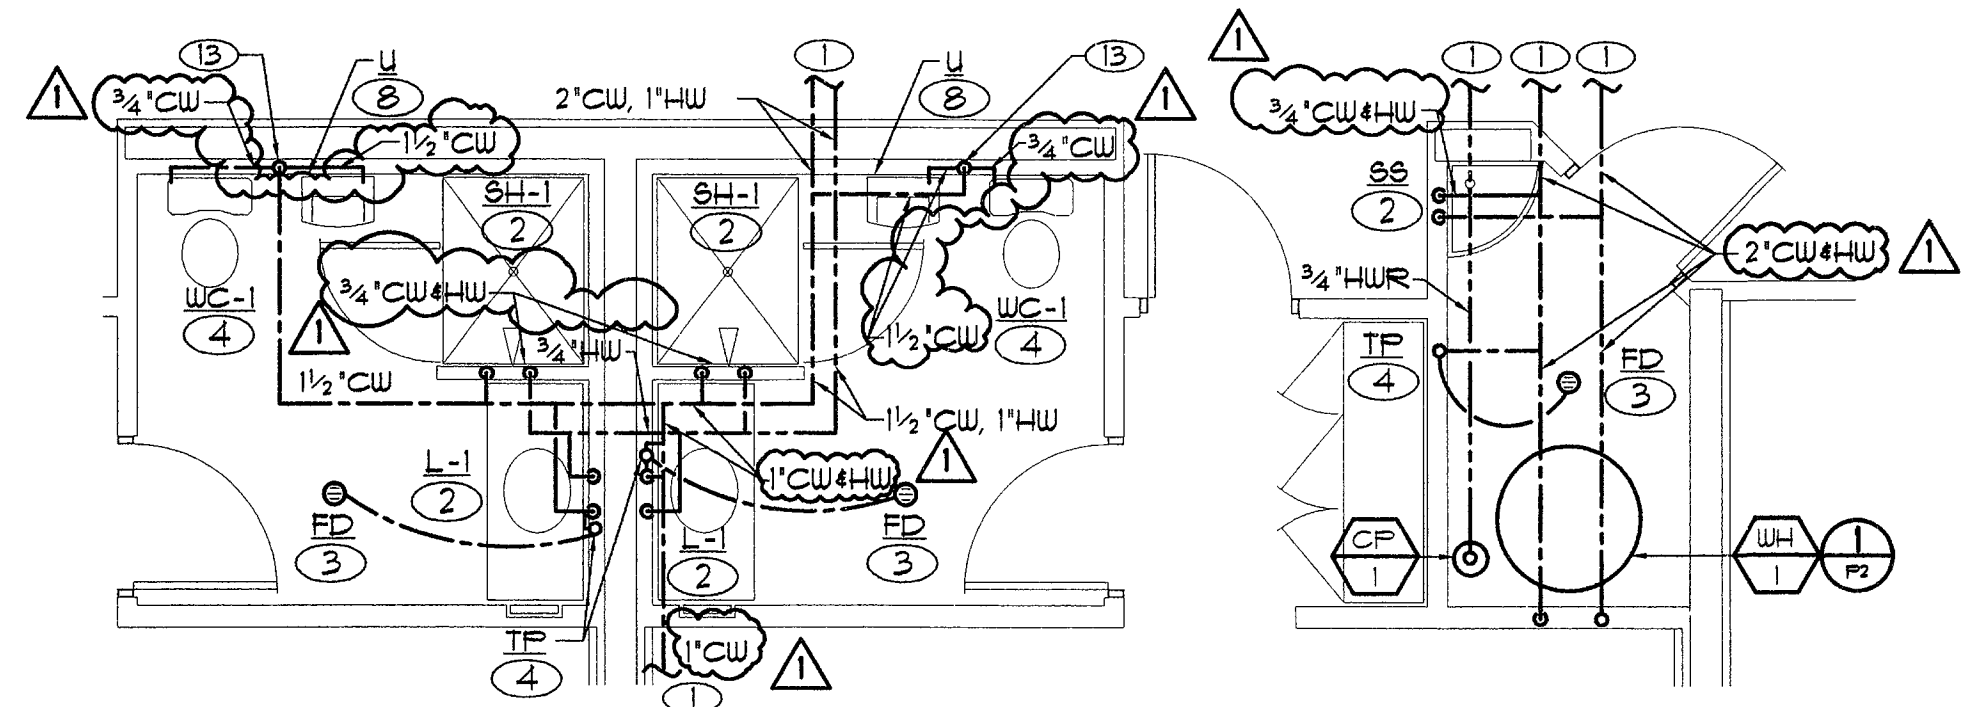

4 RESTROOM - DOMESTIC WATER
SCALE: 1/4" = 1'-0"

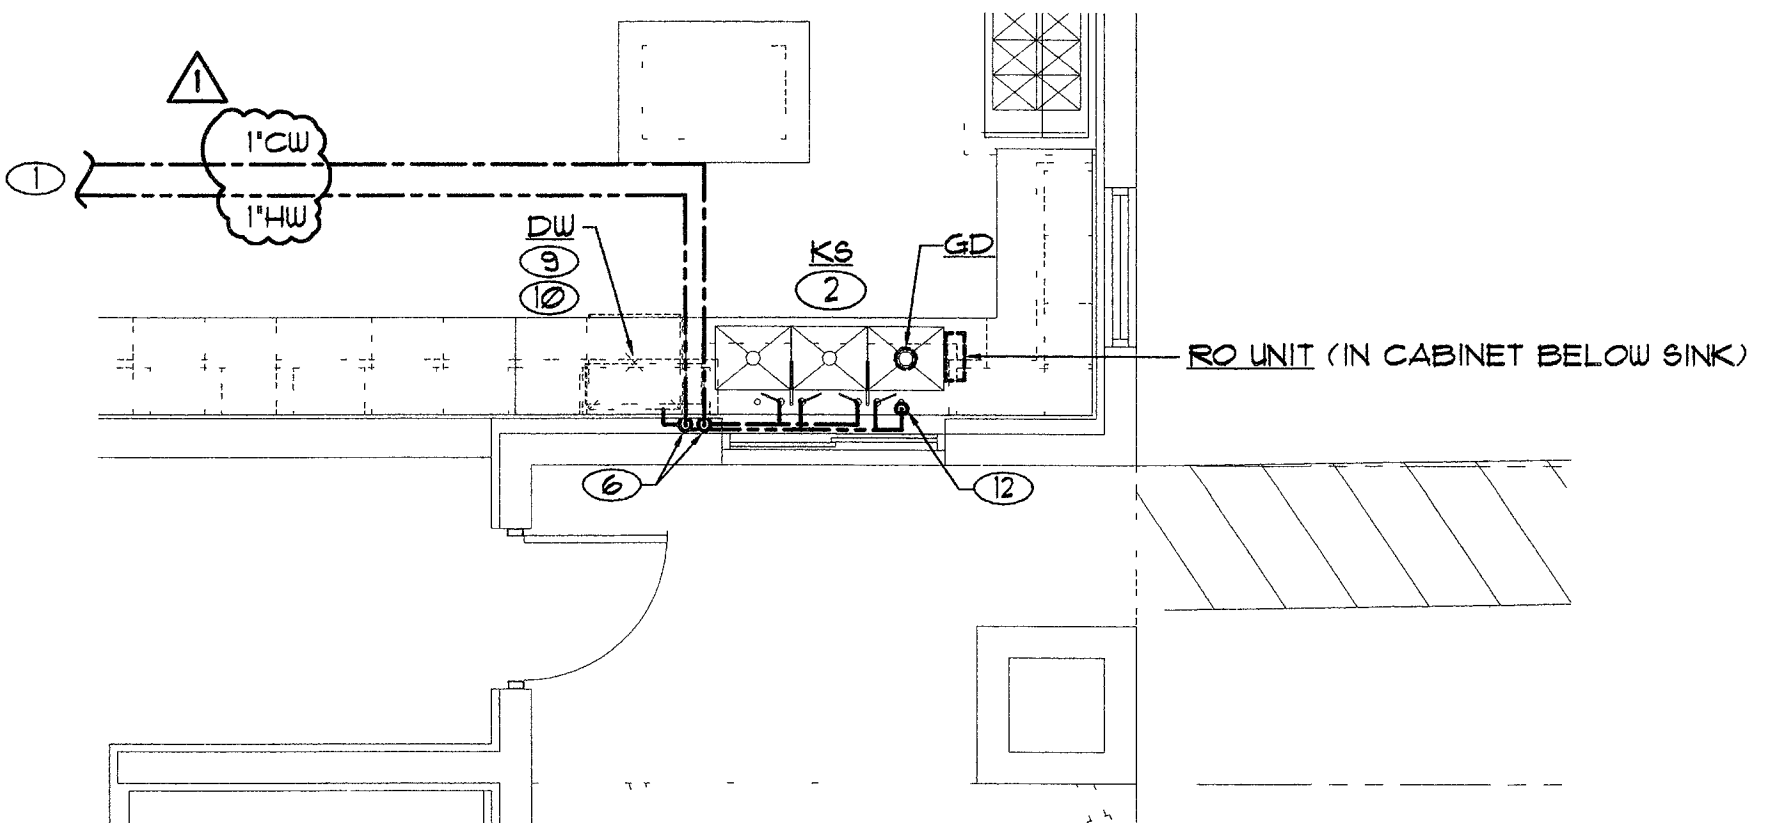

5 KITCHEN - DOMESTIC WATER
SCALE: 1/4" = 1'-0"

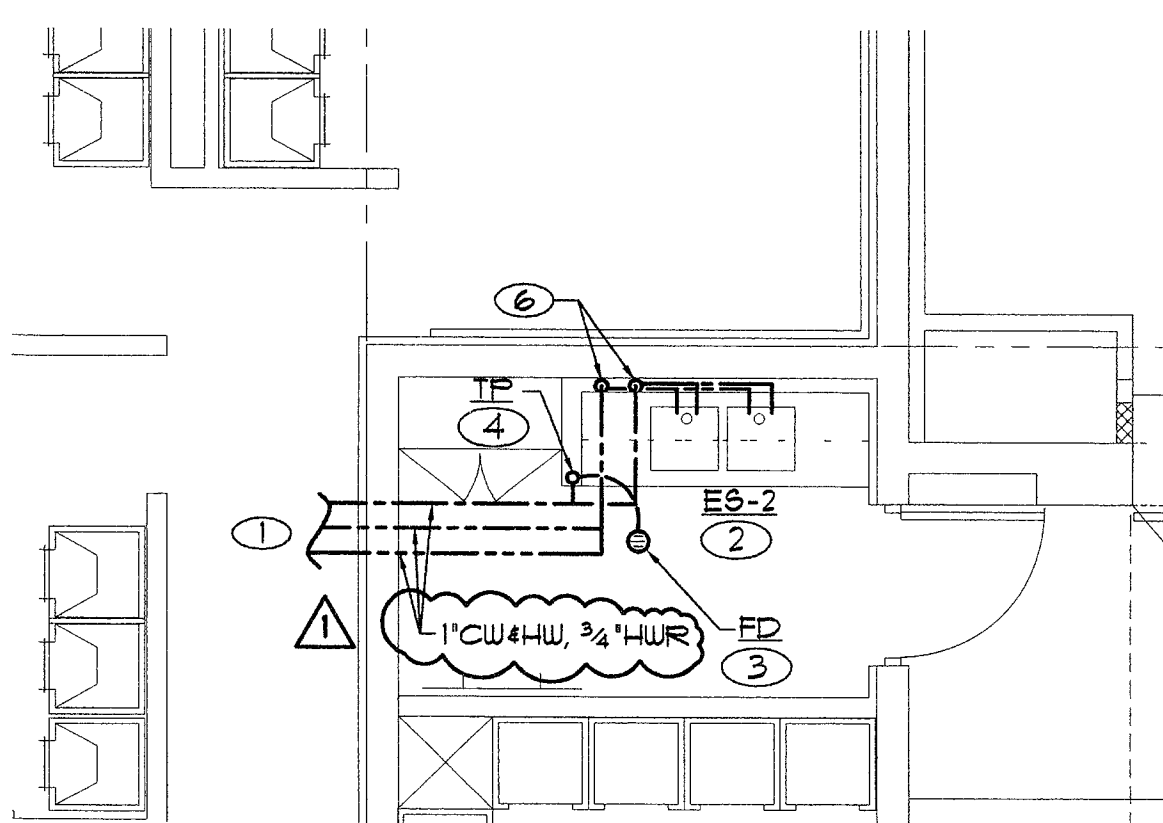

6 RESCUE CLEAN ROOM - DOMESTIC WATER
SCALE: 1/4" = 1'-0"

SHEET NOTES

- 1 REFER TO SHEET P3 FOR CONTINUATION.
- 2 1/2" CW AND HW.
- 3 1/2" CW BELOW SLAB FROM TRAP PRIMER.
- 4 1/2" CW.
- 5 PROVIDE PRECISION PLUMBING PRODUCTS MODEL NO. DU-3 TRAP PRIMER DISTRIBUTION UNIT.
- 6 1" CW AND HW DOWN IN WALL. DISTRIBUTE TO FIXTURES.
- 7 3/4" CW AND HW DOWN TO HOSE BIBBS FOR WASHER/EXTRACTOR.
- 8 3/4" CW.
- 9 FURNISHED BY OWNER AND INSTALLED BY CONTRACTOR.
- 10 1/2" HW.
- 11 MOUNT FILTER ASSEMBLY ON WALL.
- 12 DECK MOUNTED SPRAYER WITH WALL HOOK.
- 13 1/2" CW DOWN IN WALL. DISTRIBUTE TO FIXTURES.