



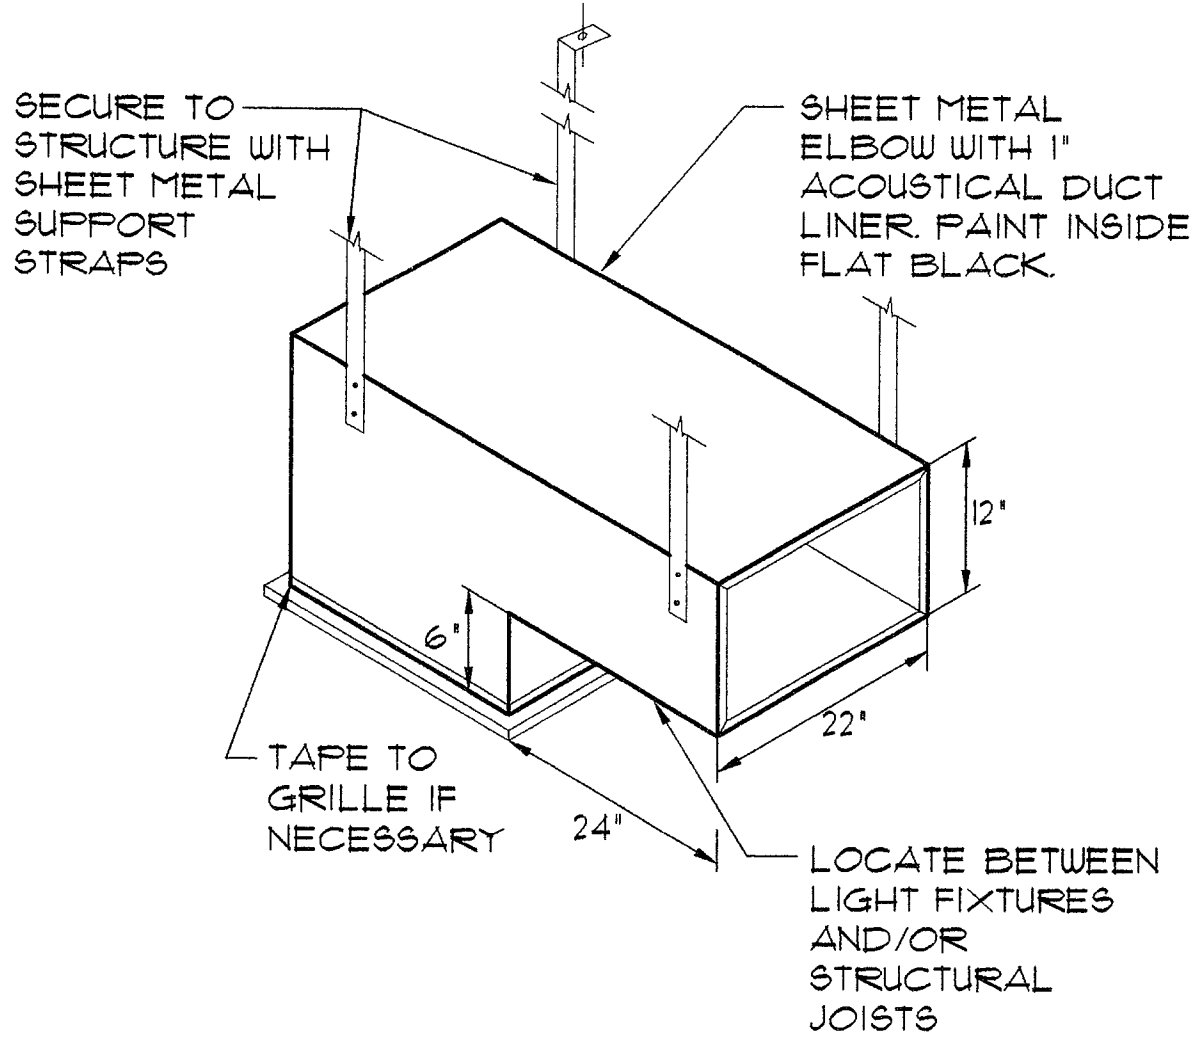

RETURN AIR GRILLE DETAIL  
NO SCALE


1  
M2.1

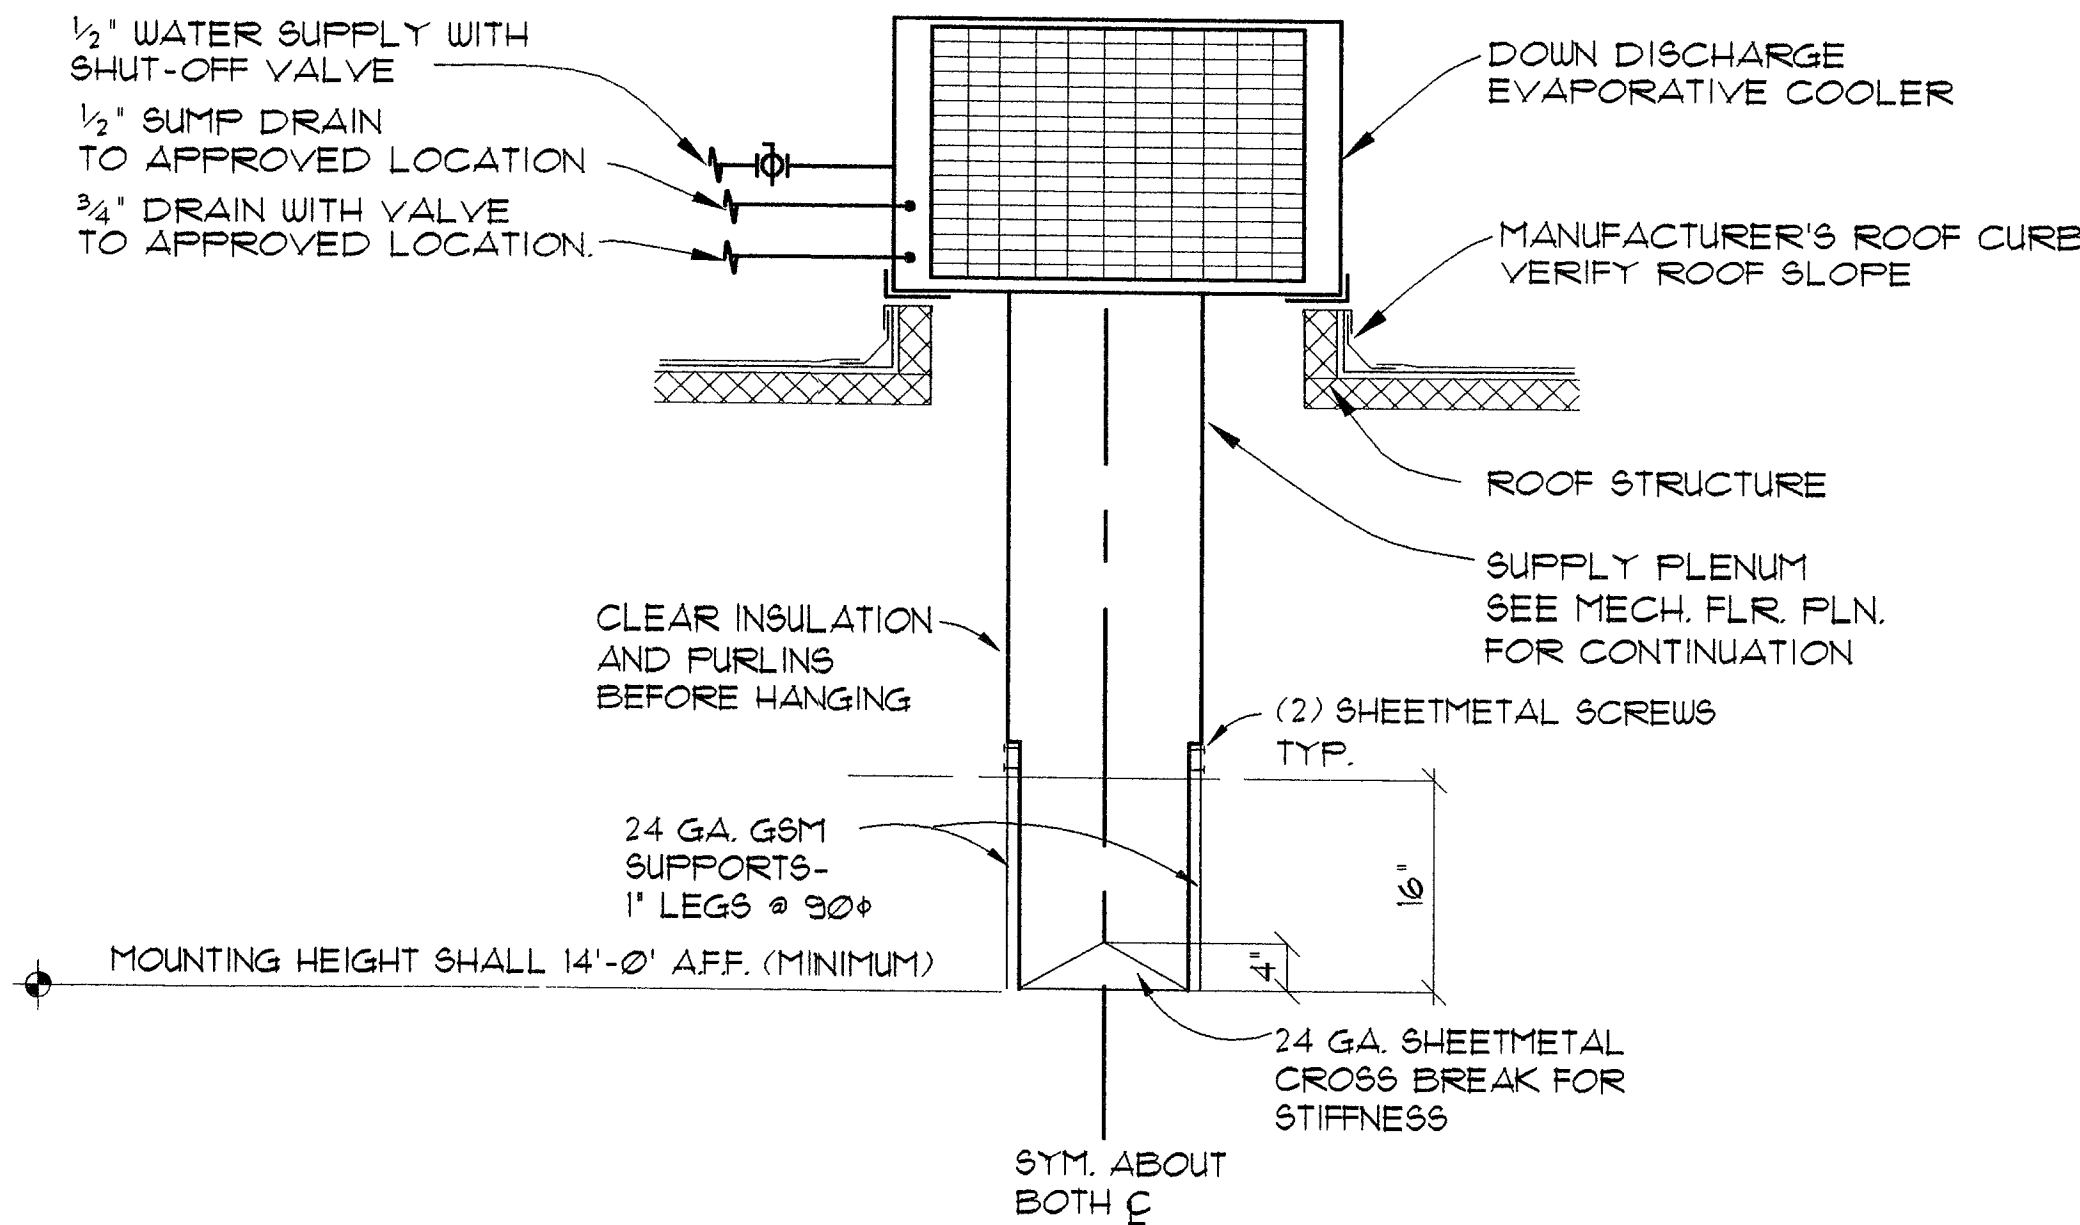

NOTE:  
REFER TO ARCHITECTURAL DRAWINGS FOR ROOF CURB MOUNTING DETAILS  
ROOF CURBS SHALL BE 8" HIGH AND FACTORY SLOPED AT 1/2" PER FT.

EVAPORATIVE COOLER UNIT DETAIL  
NO SCALE


2  
M2.1

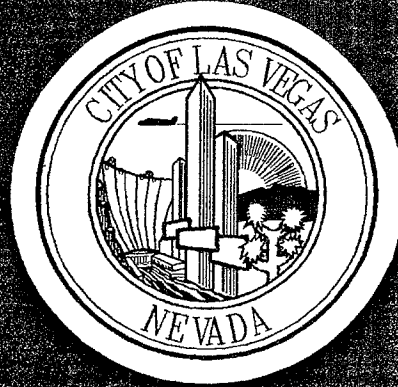

REVISIONS

CONSULTANT

 
COMFORT ENGINEERING  
MECHANICAL - ELECTRICAL - PLUMBING  
2550 LAS VEGAS BLVD., SUITE 208  
LAS VEGAS, NEVADA 89168  
TEL. (702) 367-0892 • FAX 367-1076



CITY OF LAS VEGAS, NEVADA  
FIRE STATION #8

MECHANICAL DETAILS

STAMP

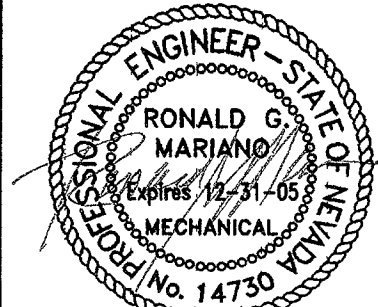

OWNER: CITY OF LAS VEGAS  
DEPARTMENT OF PUBLIC WORKS  
ARCHITECTURAL SERVICES

400 EAST STEWART AVENUE  
LAS VEGAS, NEVADA 89101  
PHONE: (702) 229-6535  
FAX: (702) 382-5232  
TDD: (702) 386-9108

DRAWN

DBB

FILE

DATE

4/3/04

SCALE

AS NOTED

REV NO

04.15341.04

CLV DWG NO

630-101

SIT NO

M2.1

DRAWING AS INSTRUMENTS OF SERVICE ARE THE PROPERTY OF THE DESIGN PROFESSIONAL. THESE STAMPS OF CERTIFICATION APPEAR ON THE DRAWINGS AND SPECIFICATIONS ANY USE OF REPRODUCTION IN WHOLE OR IN PART WITHOUT WRITTEN CONSENT IS STRICTLY PROHIBITED. COPIES OF THE DRAWINGS AND SPECIFICATIONS ISSUED BY THE CLIENT MAY BE USED ONLY FOR THE PROJECT FOR WHICH THEY WERE PREPARED AND NOT FOR THE CONSTRUCTION OF ANY OTHER PROJECT. N.E.C. 623.760