


GENERAL NOTES

1. THE MECHANICAL CONTRACTOR SHALL VERIFY LOCATION OF ROOF MOUNTED EQUIPMENT AND ROOF PENETRATIONS WITH ARCHITECT AND STRUCTURAL ENGINEER PRIOR TO BEGINNING WORK. REFER TO ARCHITECTURAL DETAILS FOR ROOF CURB AND ROOFING REQUIREMENTS.
2. MAINTAIN A 10 FT. CLEARANCE FROM ANY OUTSIDE AIR INTAKE AND ALL EXHAUST AND PLUMBING TERMINATIONS.

SHEET NOTES

- ① 24"x8" INSULATED AND JACKETED SUPPLY DUCT DOWN THRU ROOF.
- ② RELIEF HOOD.

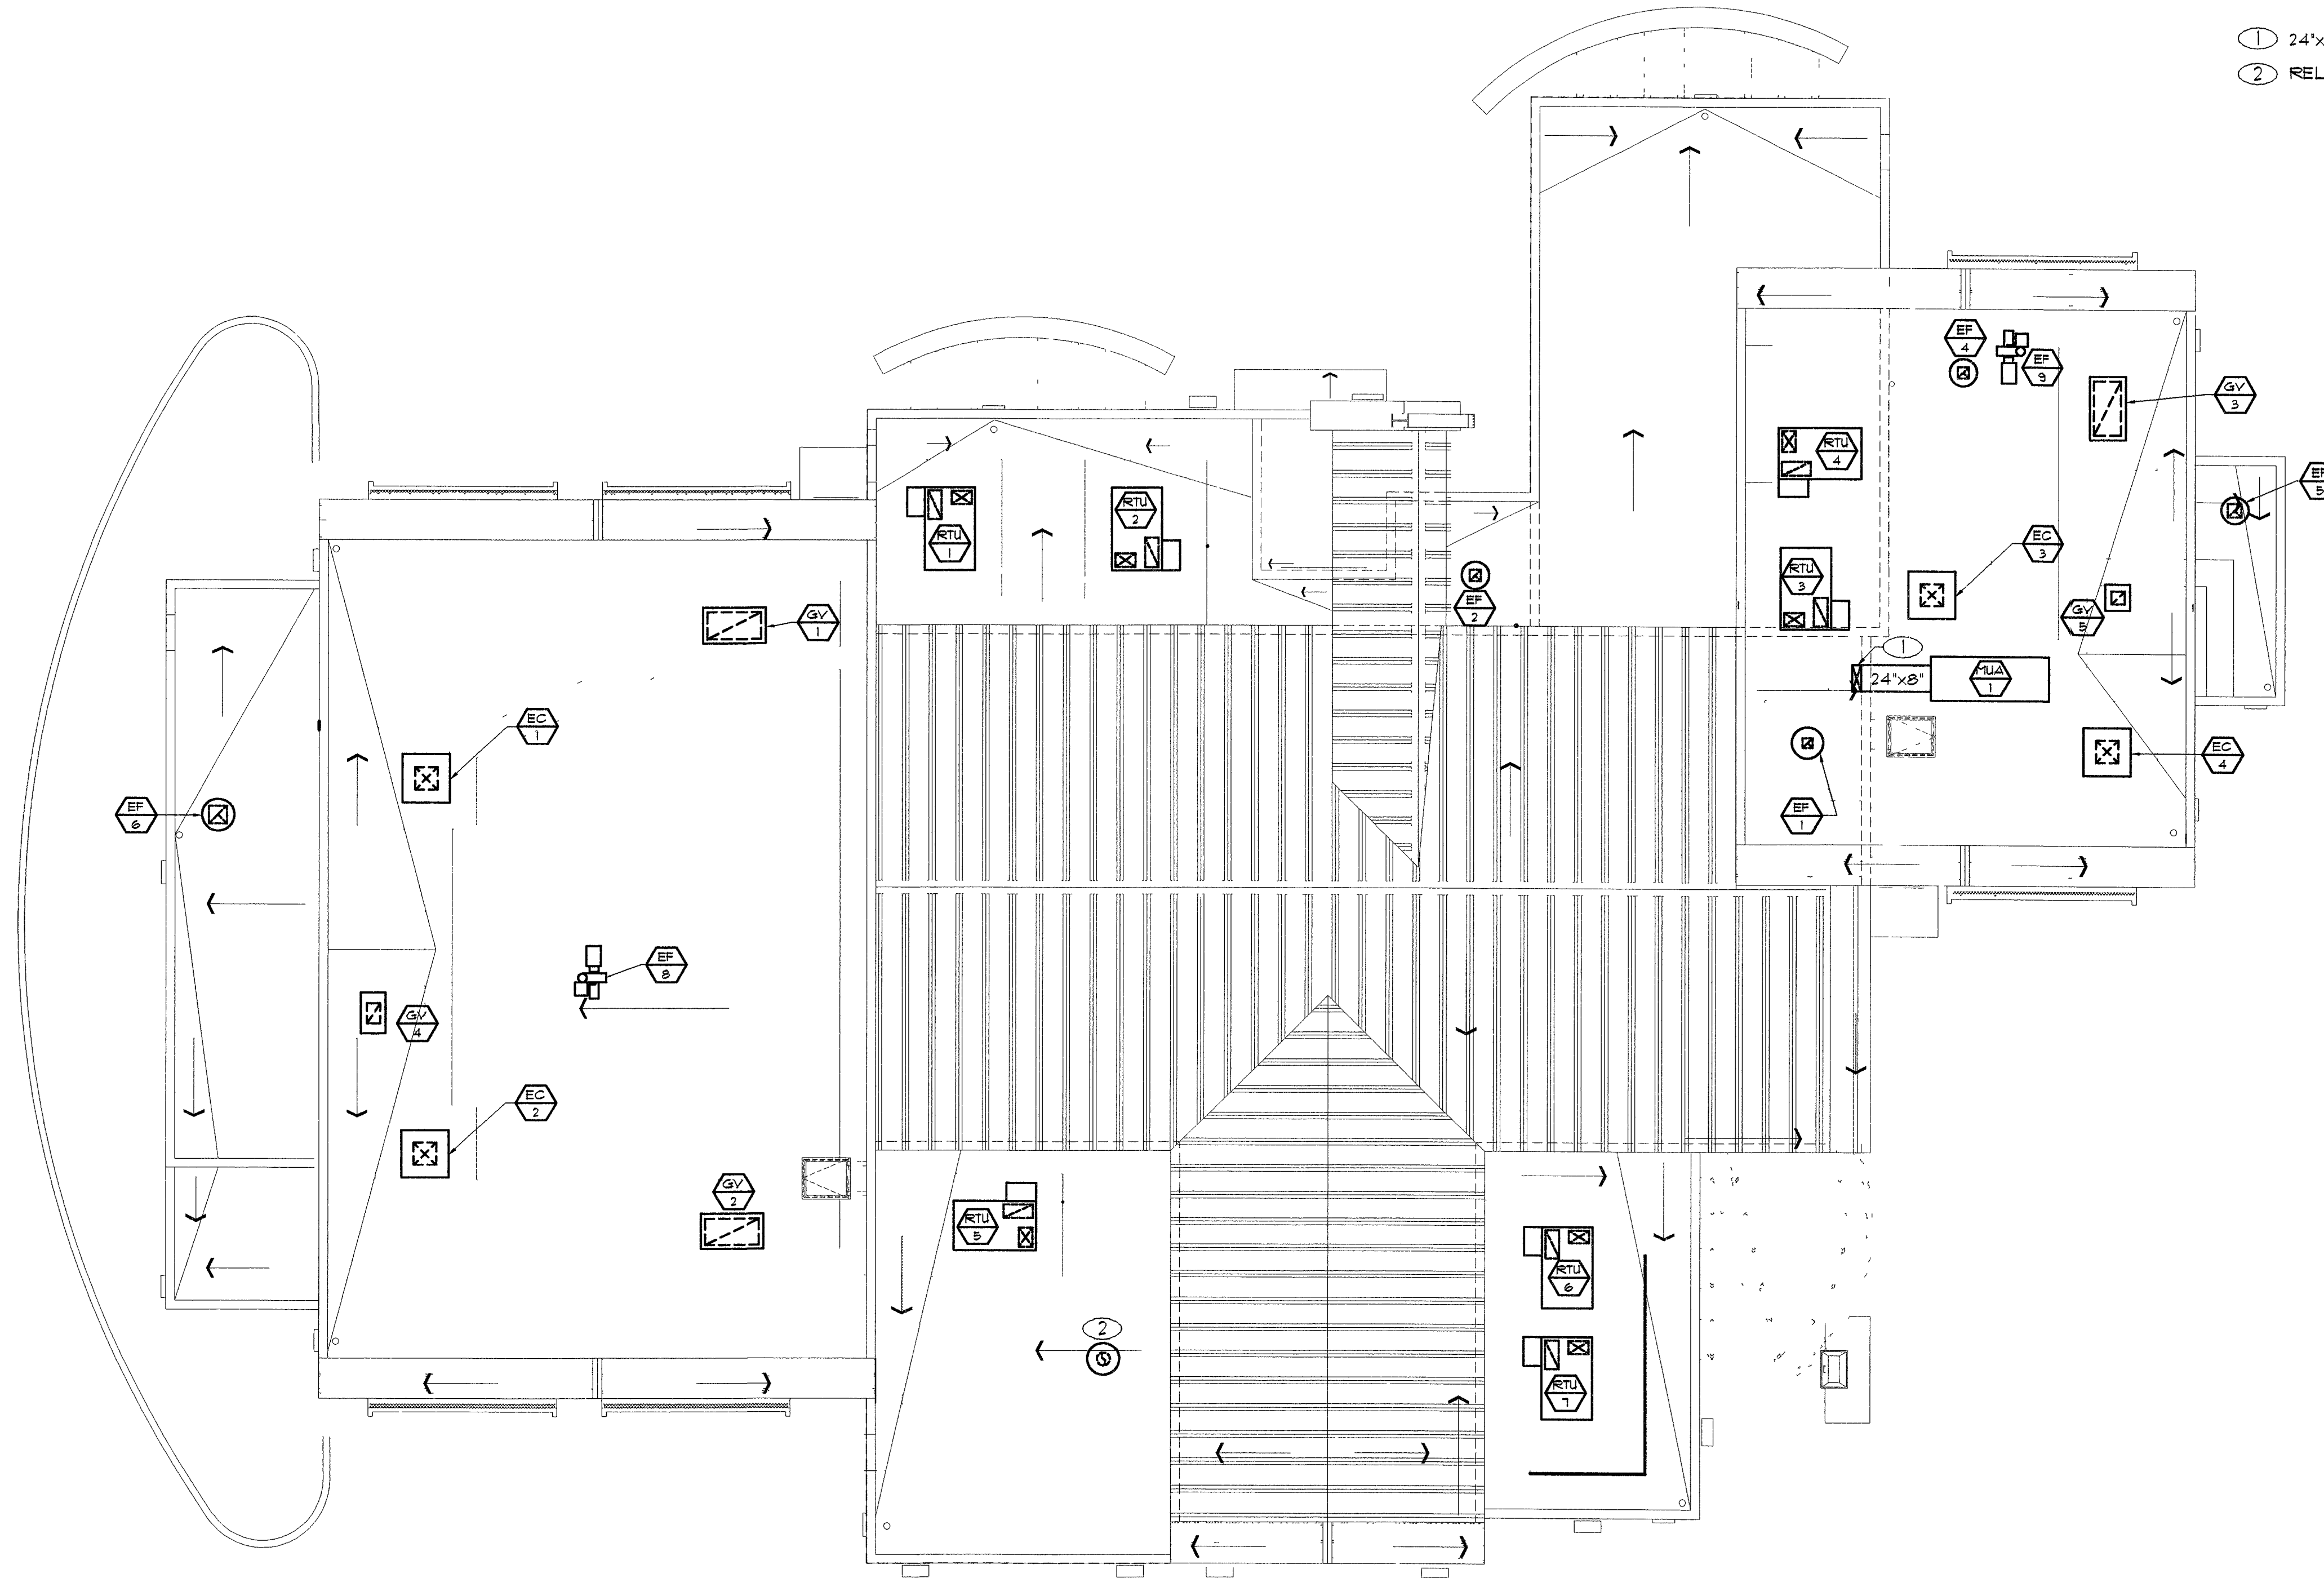

MECHANICAL ROOF PLAN

Scale: 1/8" = 1'-0"

◀ Project North




REVISIONS

CONSULTANT

COMFORT ENGINEERING
MECHANICAL • ELECTRICAL • PLUMBING
2550 SOUTH RAINBOW, SUITE E-23
LAS VEGAS, NEVADA 89146
TEL. (702) 367-0892 • FAX 367-1076

CITY OF LAS VEGAS, NEVADA
FIRE STATION #8
MECHANICAL ROOF PLAN

TAMP

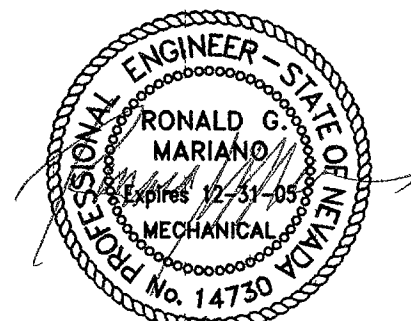

OWNER: CITY OF LAS VEGAS
DEPARTMENT OF PUBLIC WORKS
ARCHITECTURAL SERVICES

100 EAST STEWART AVENUE
LAS VEGAS, NEVADA 89101
PHONE: (702) 229-6535
FAX: (702) 382-3232
TDD: (702) 386-9108

RAWN DBB

LE

DATE 4/19/84

SCALE 142 = 1'-0"

041524104

LV DWG NO 620101

630-101

M4