

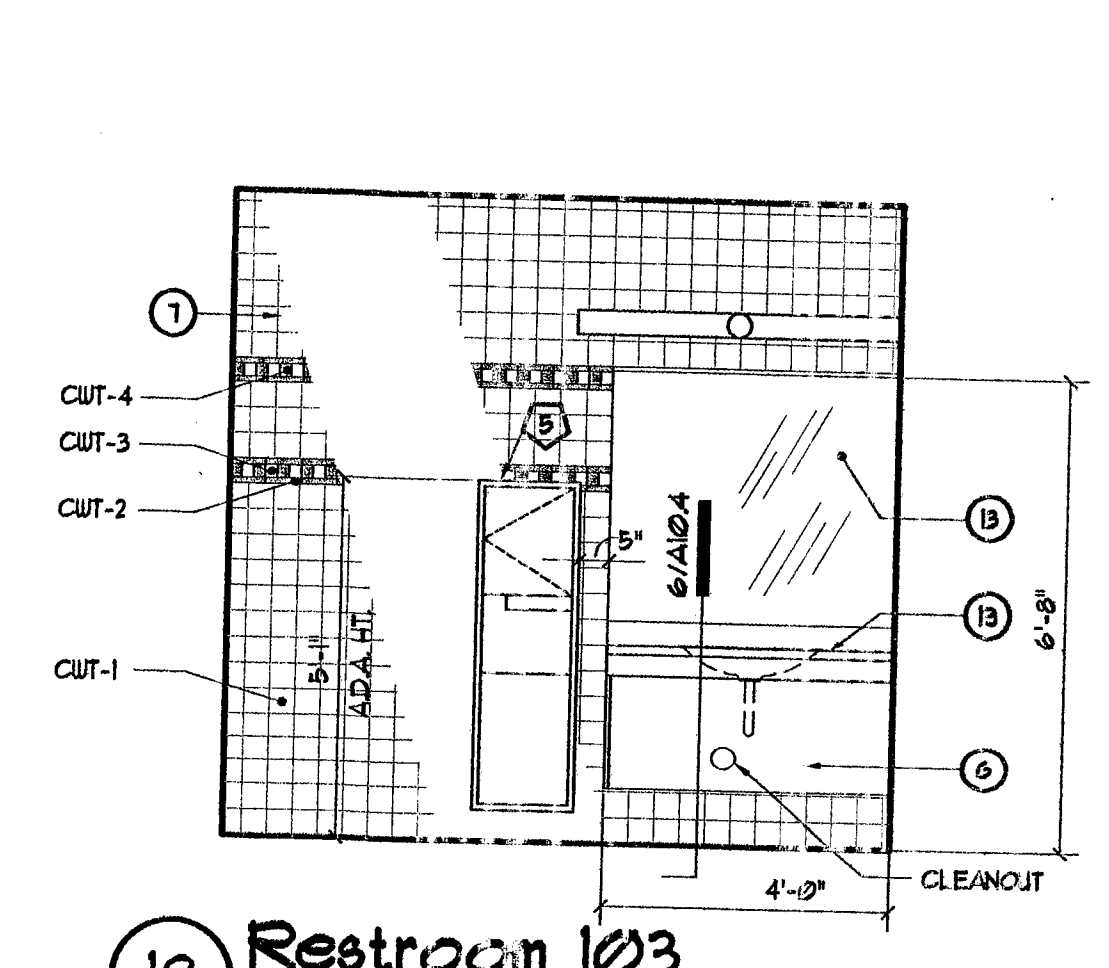
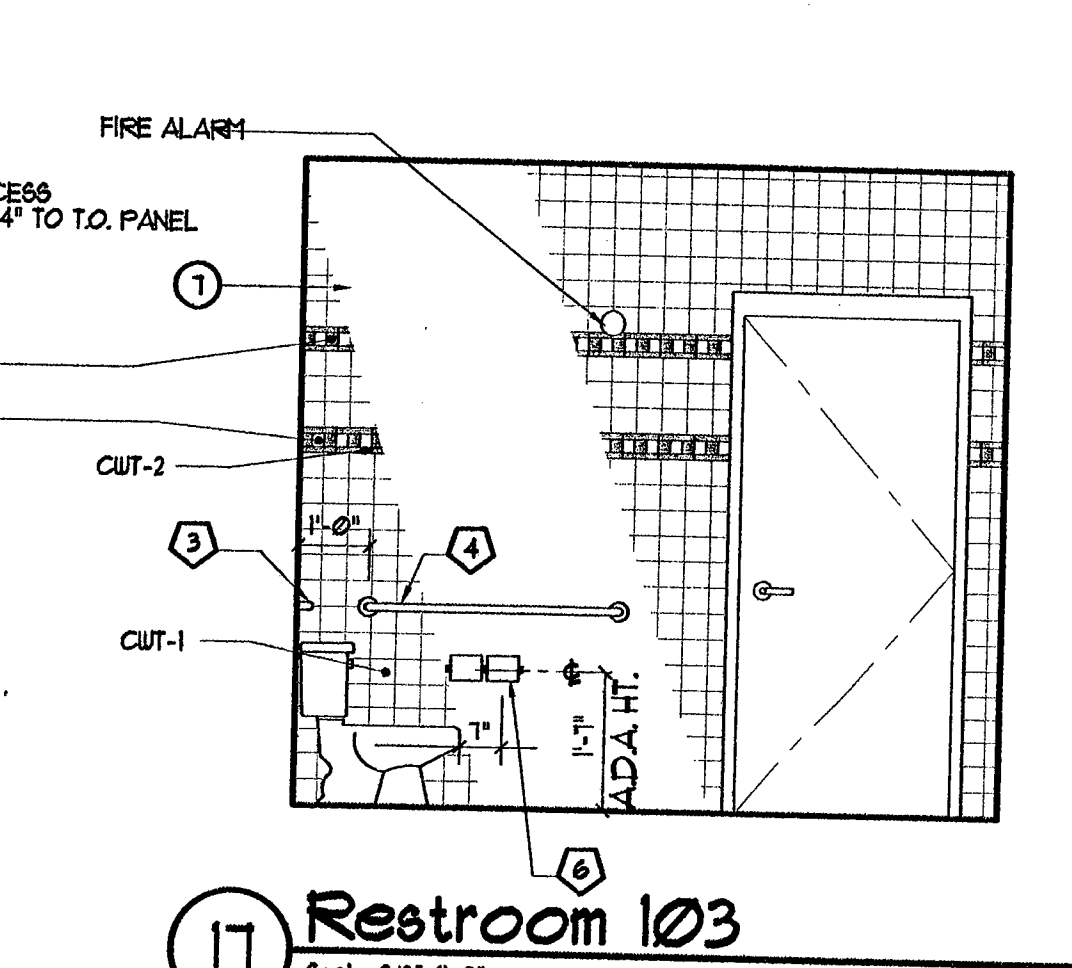
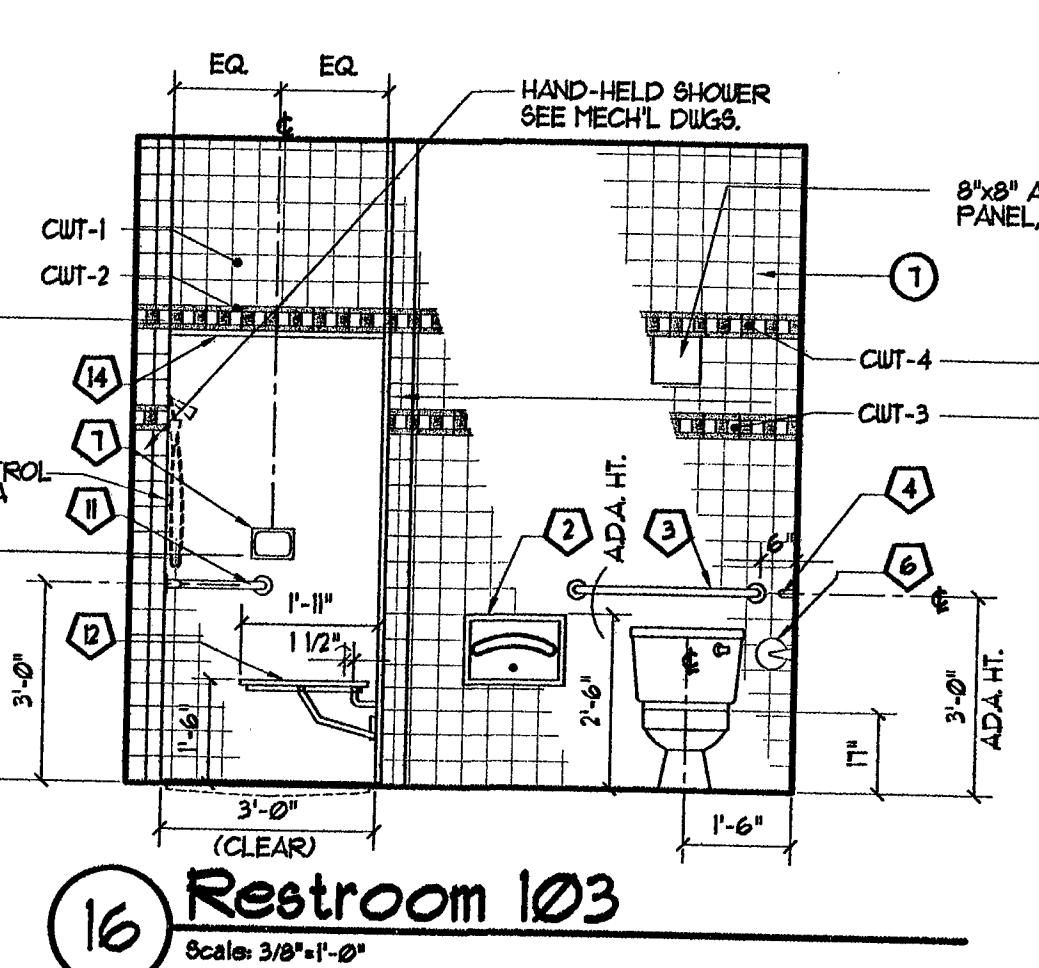
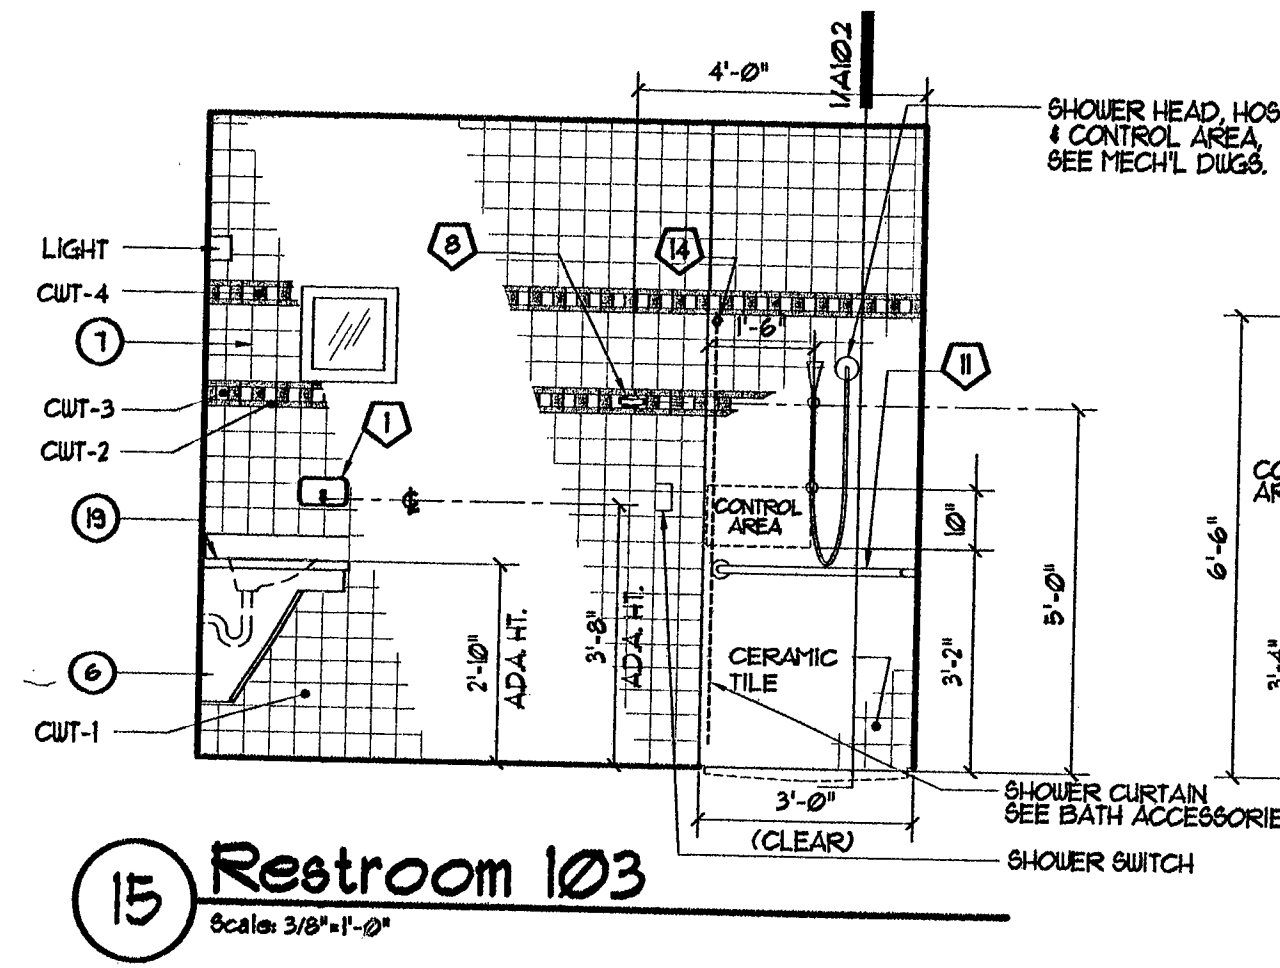
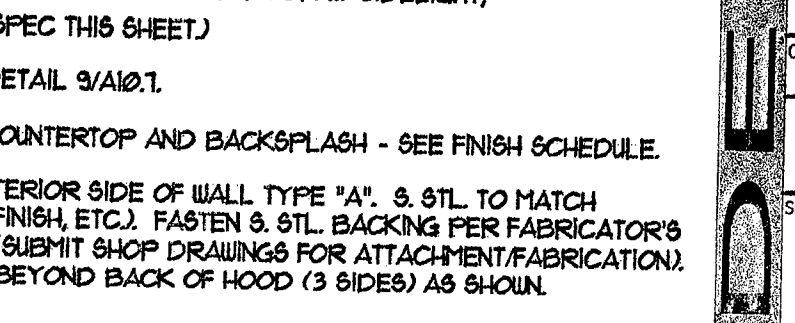
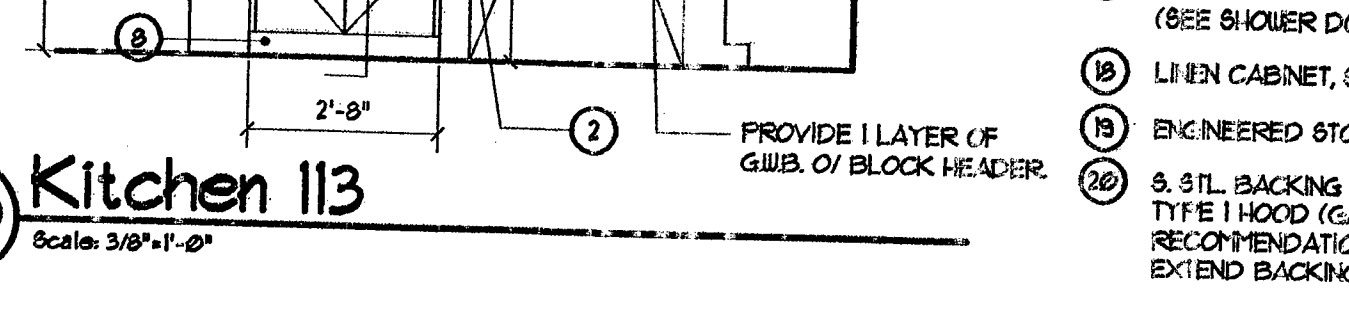
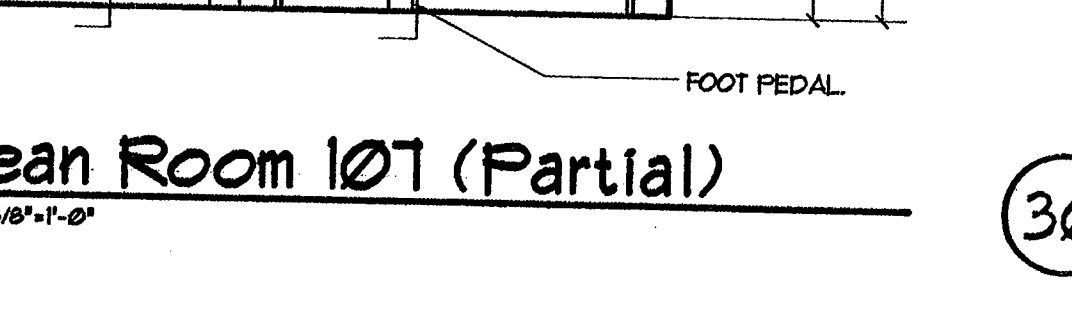
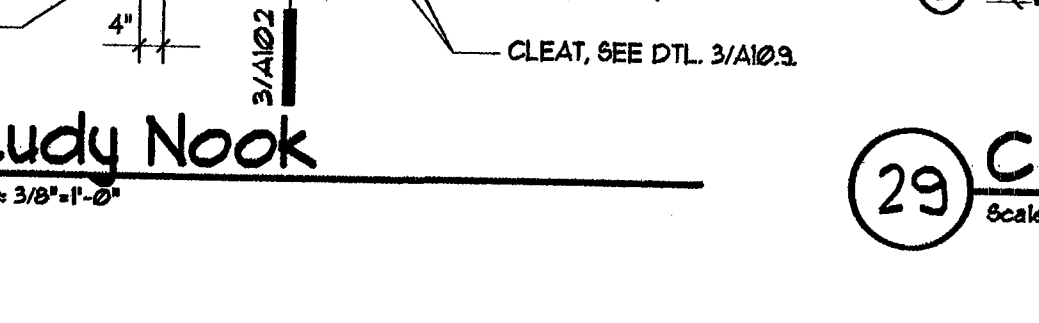
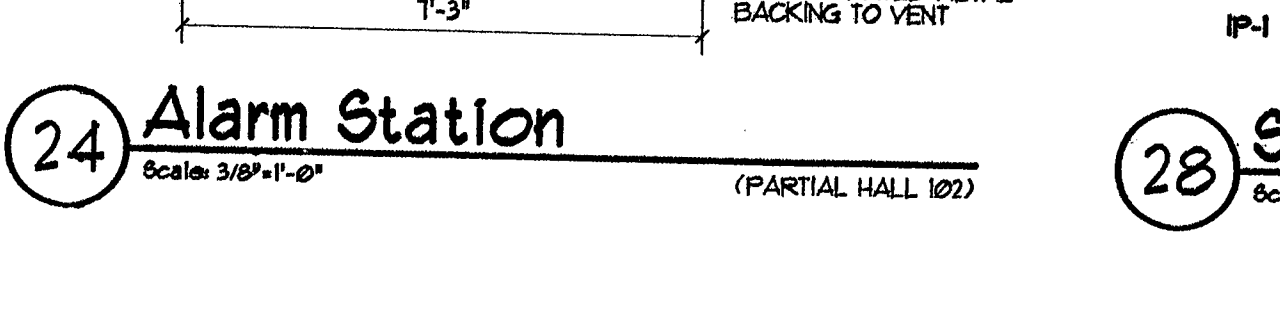
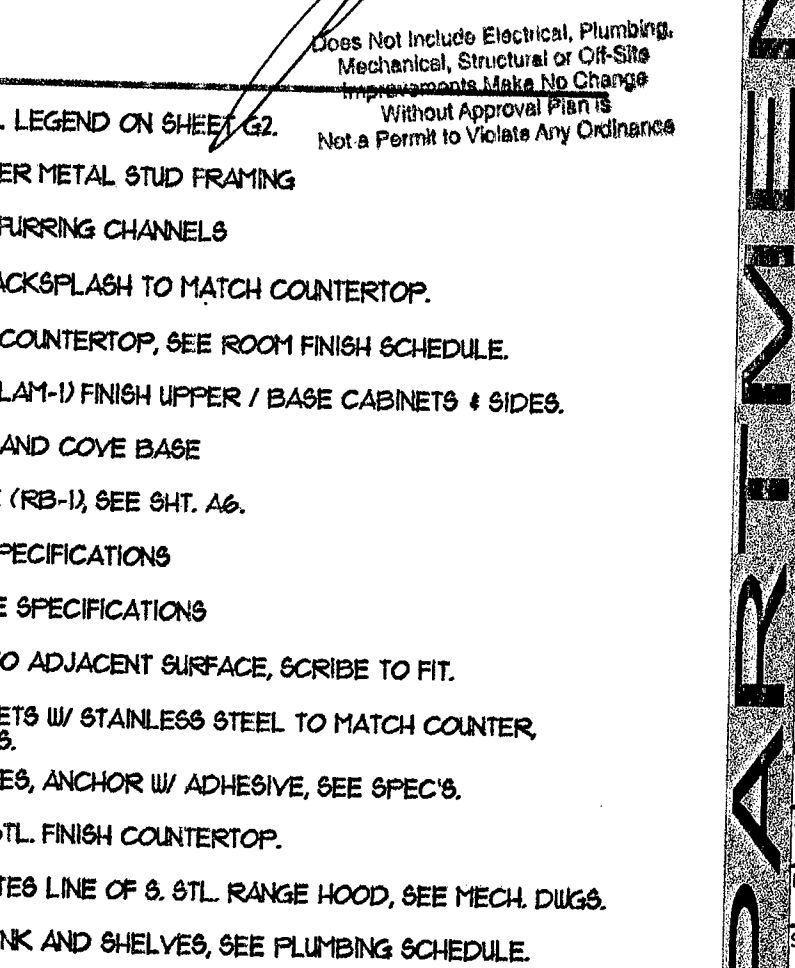
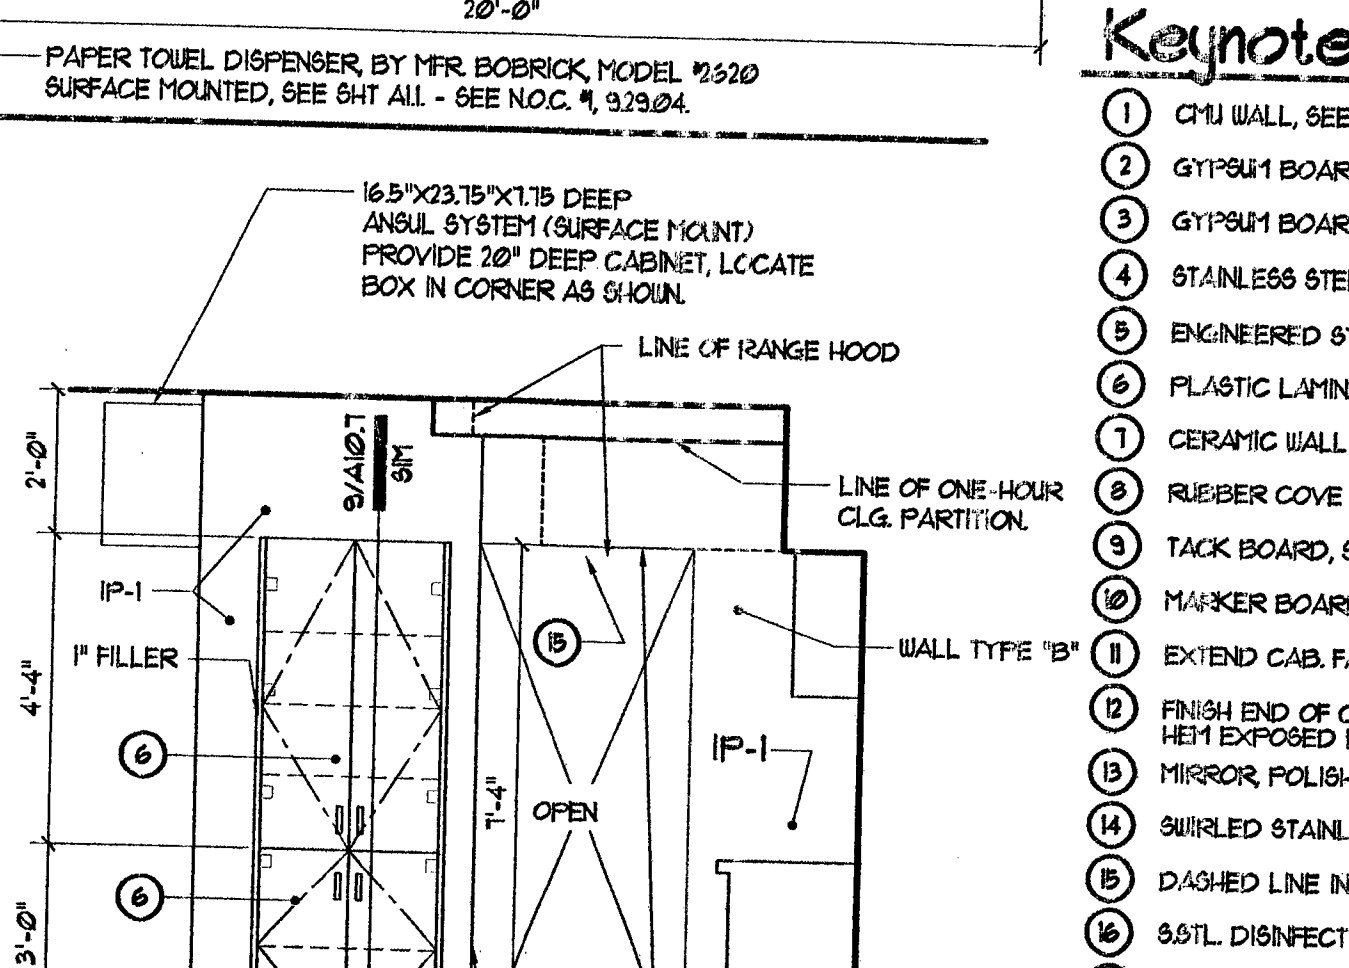
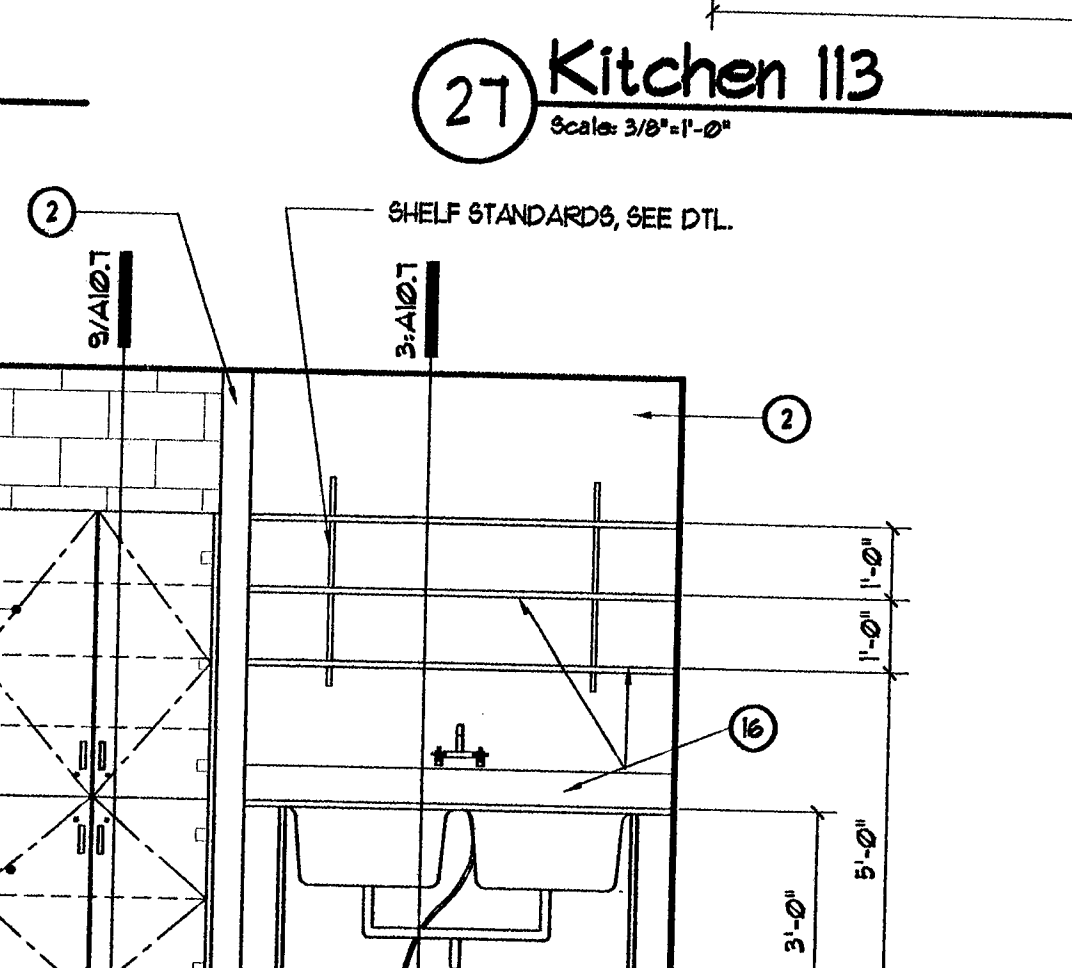
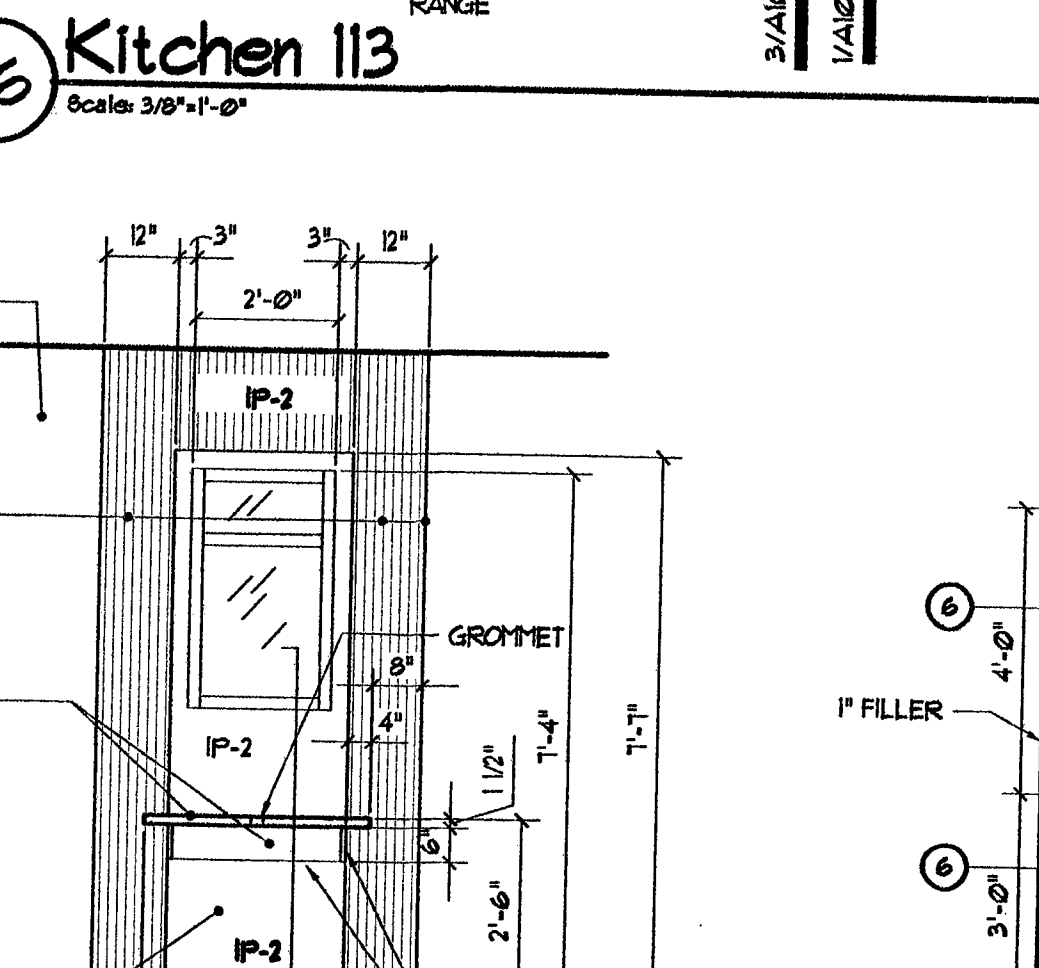
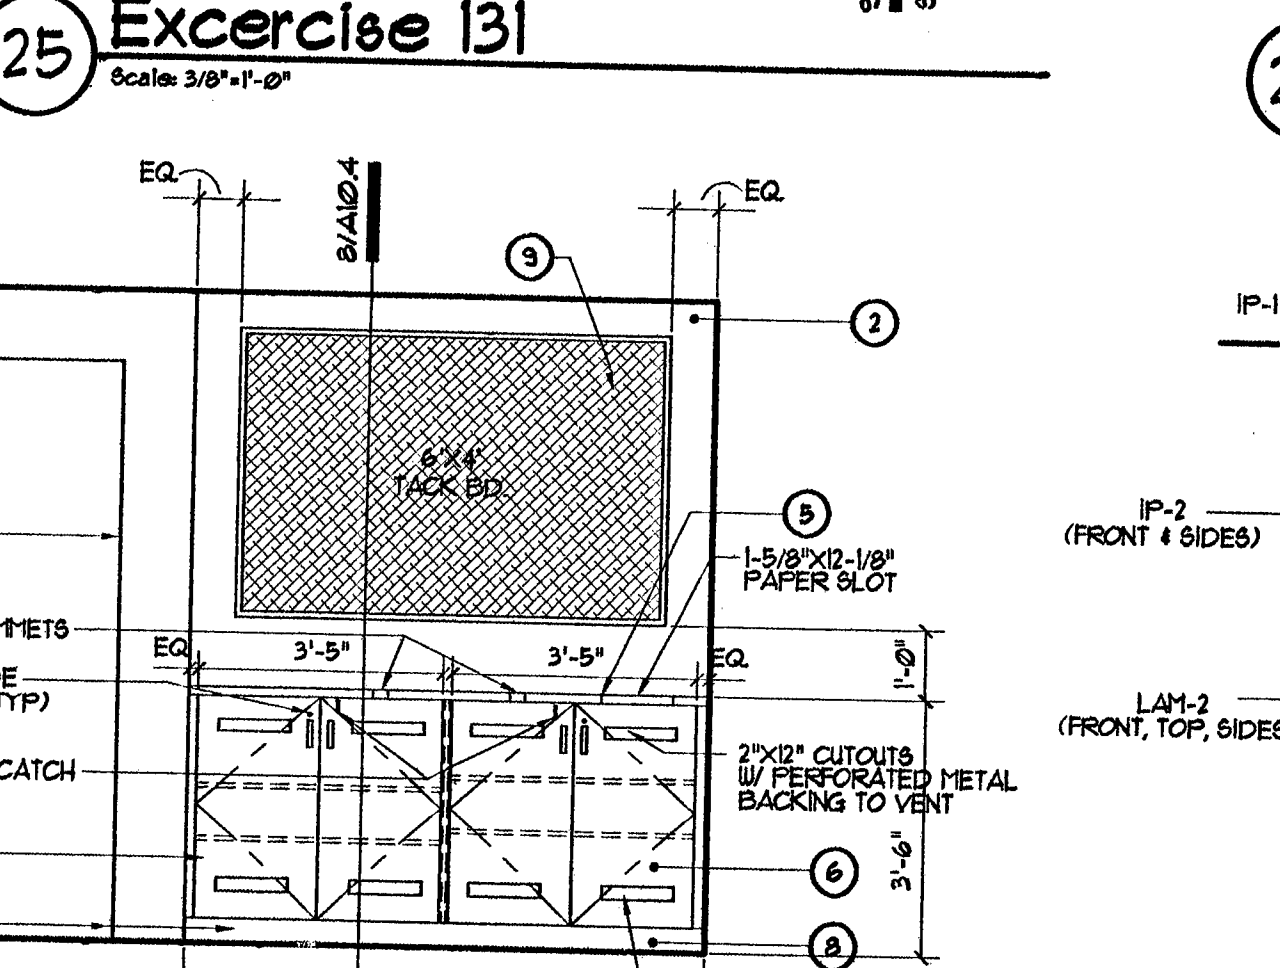
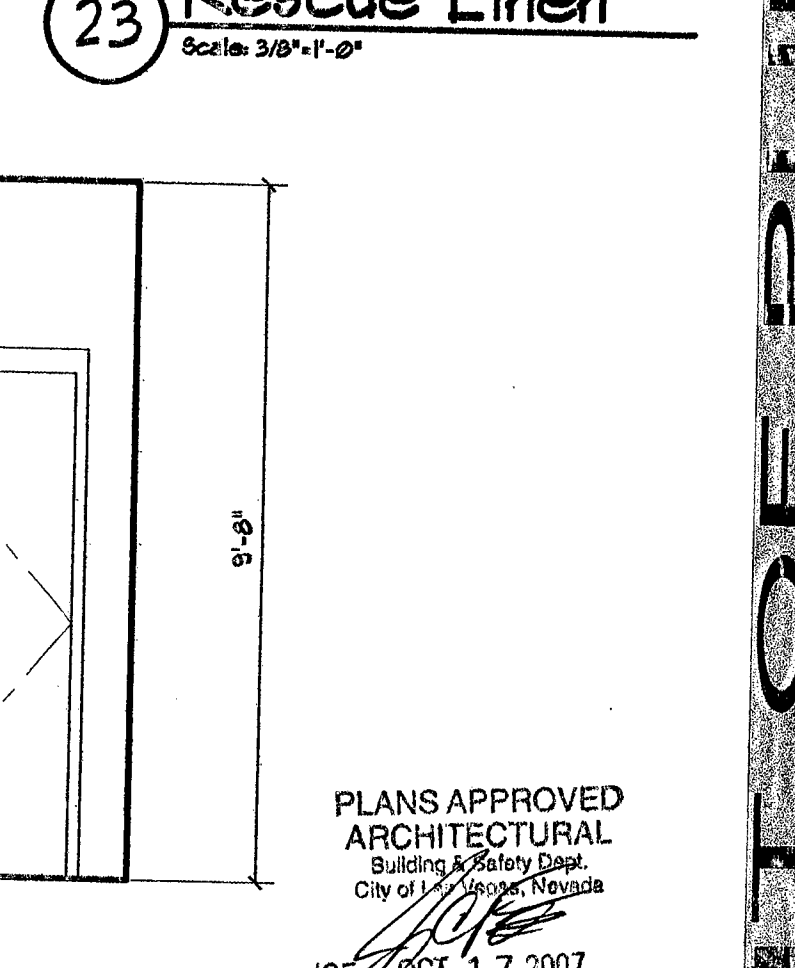
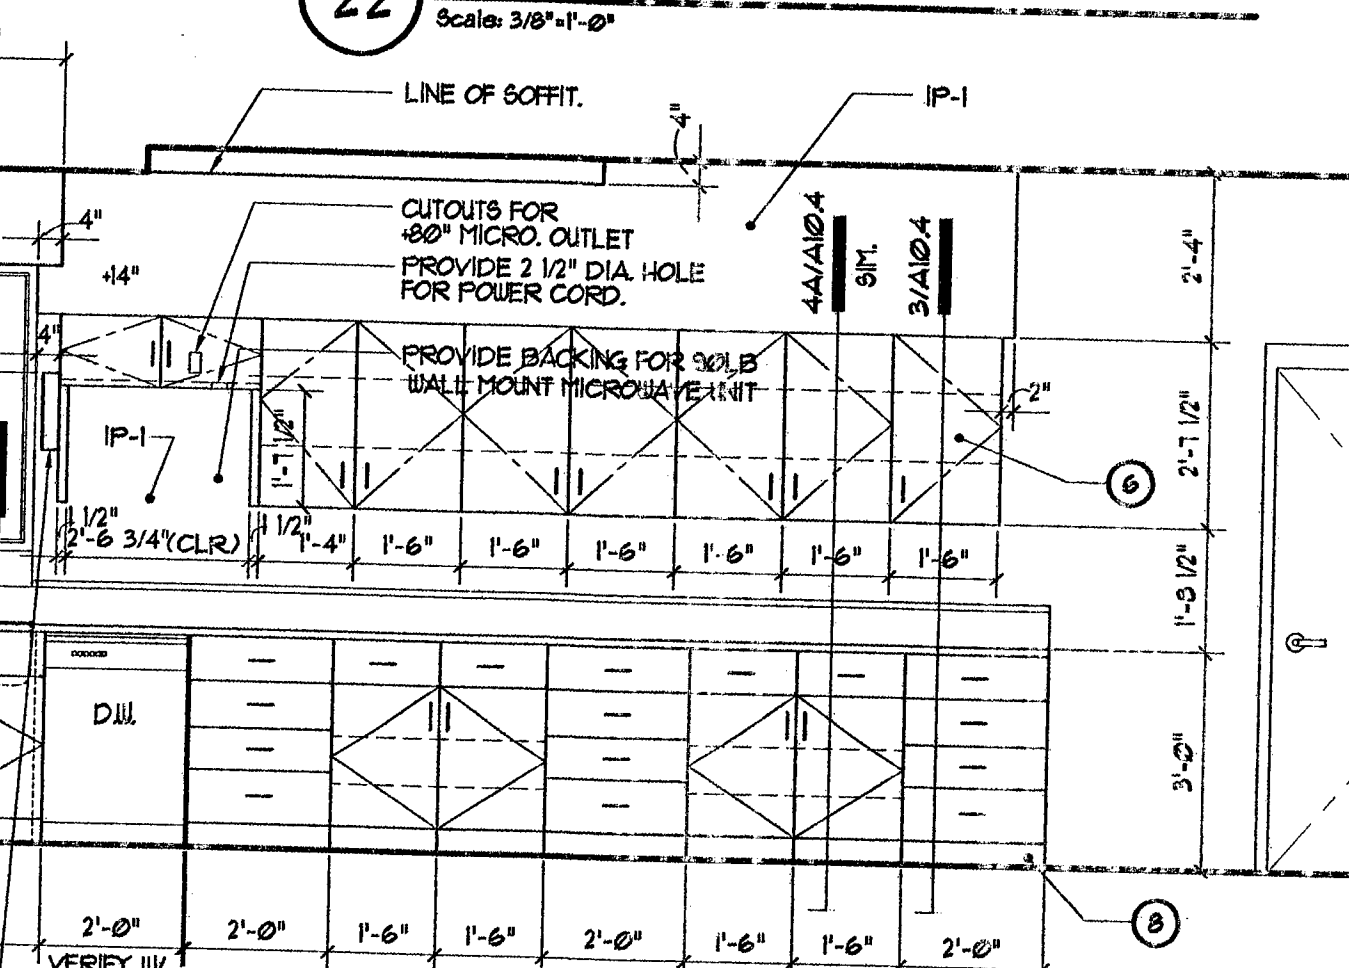
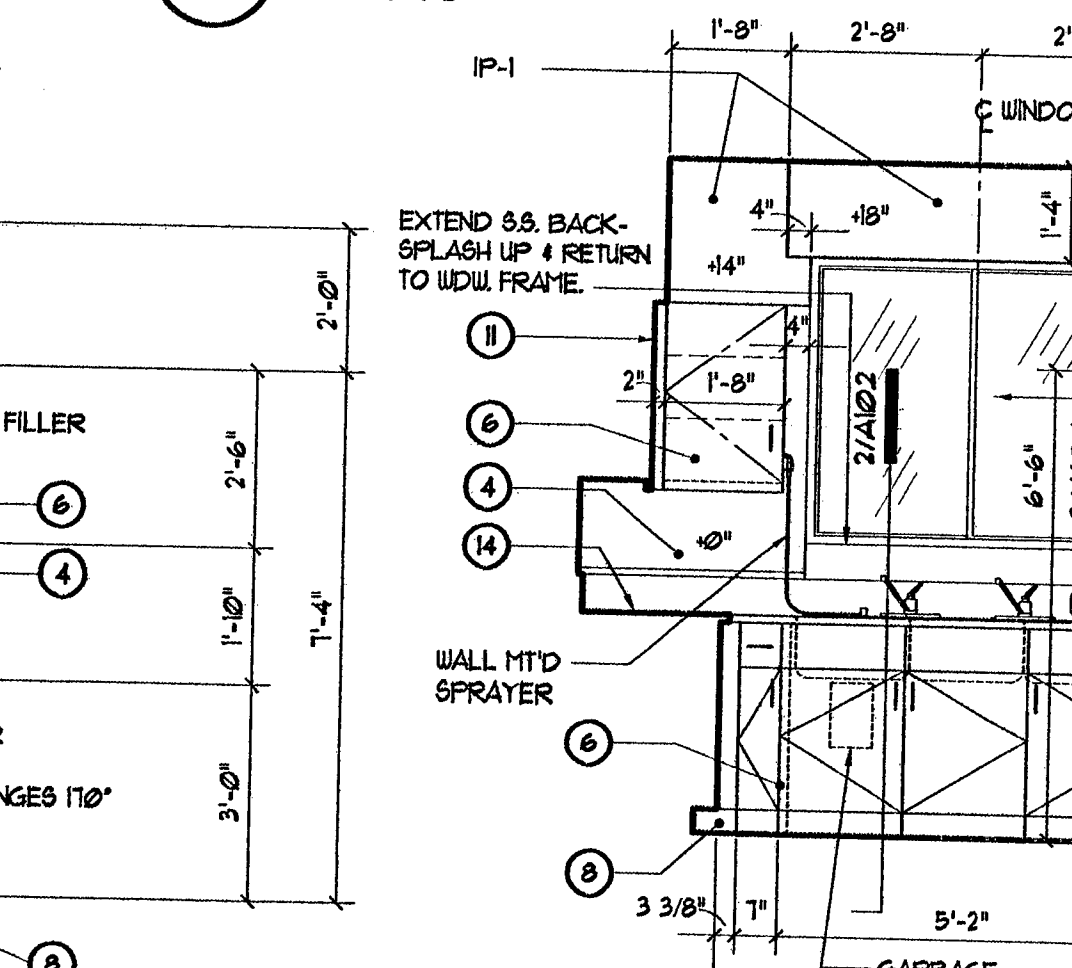
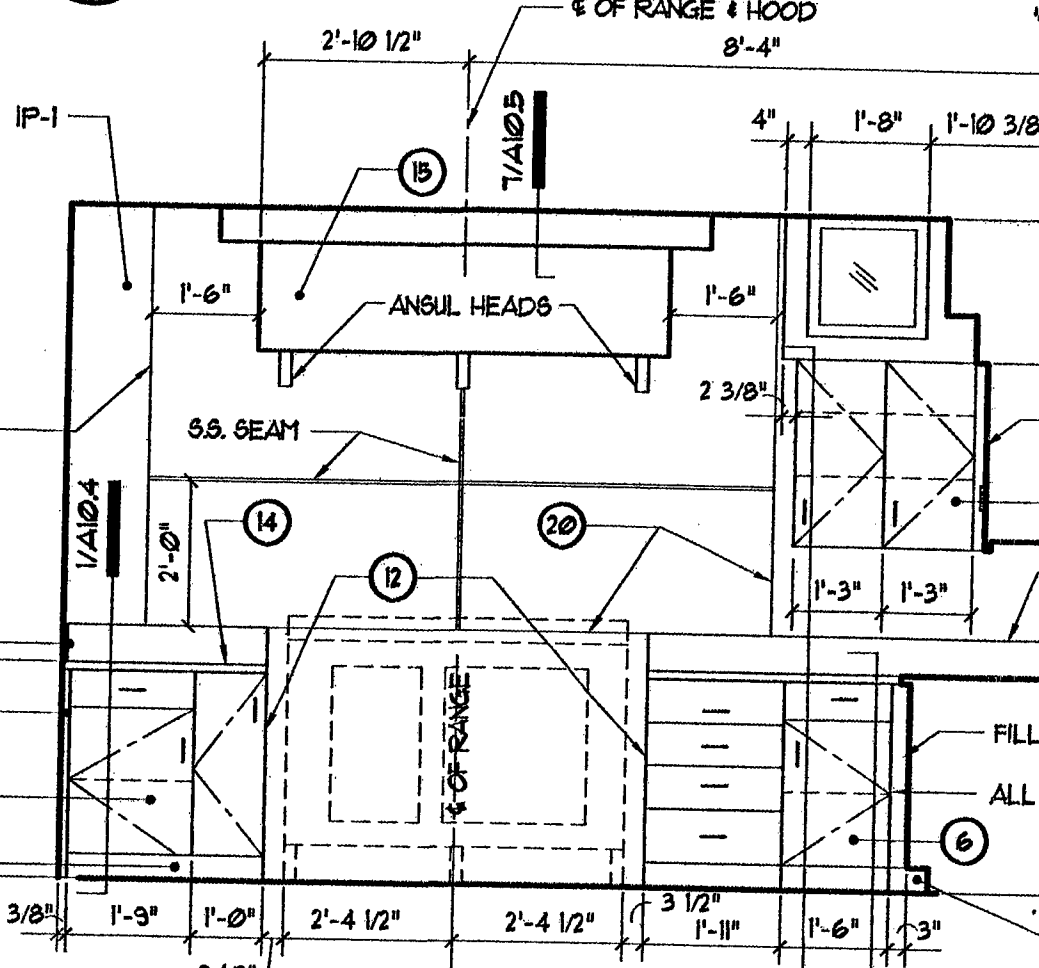
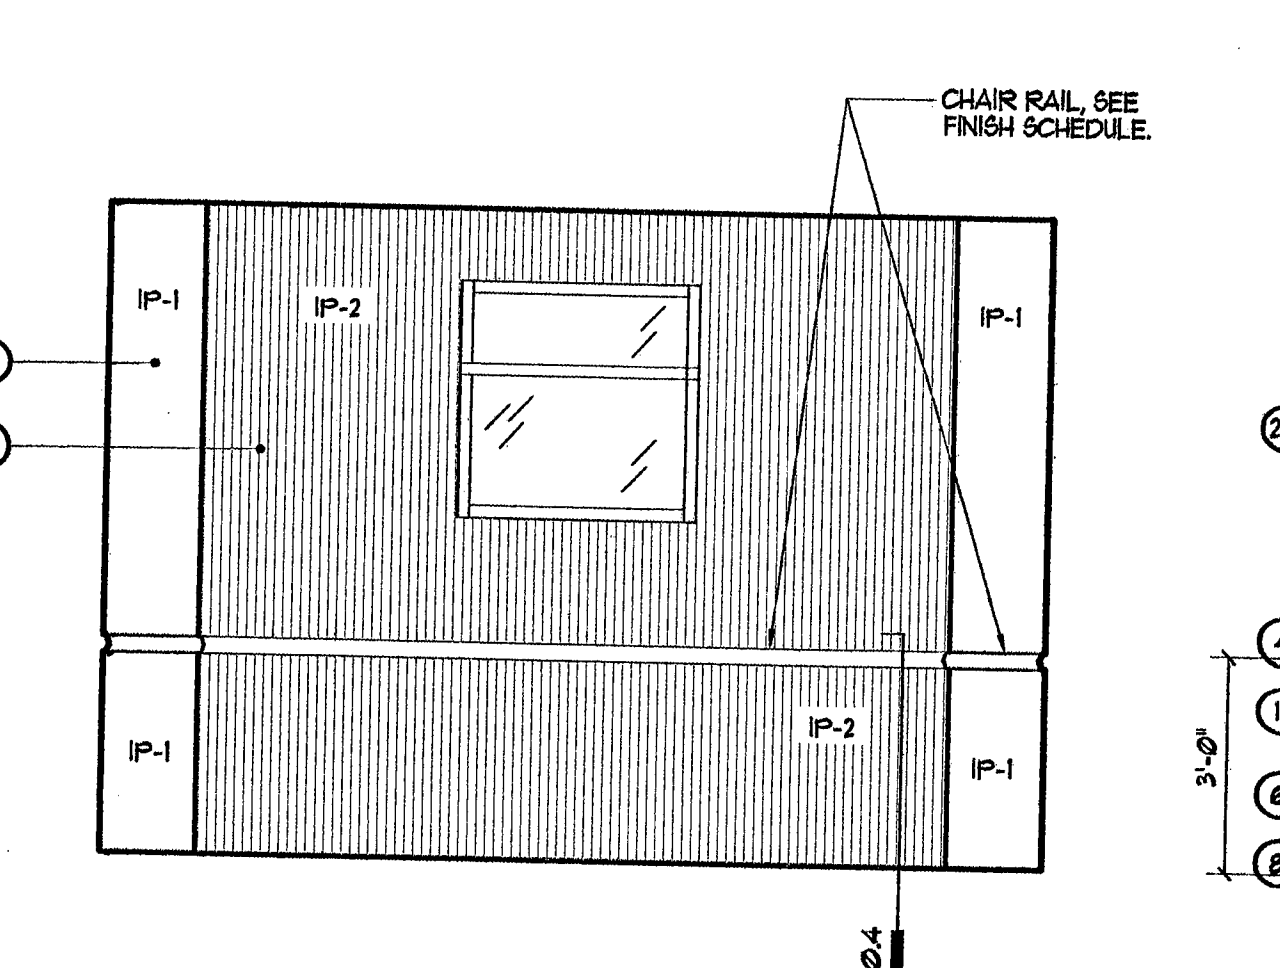
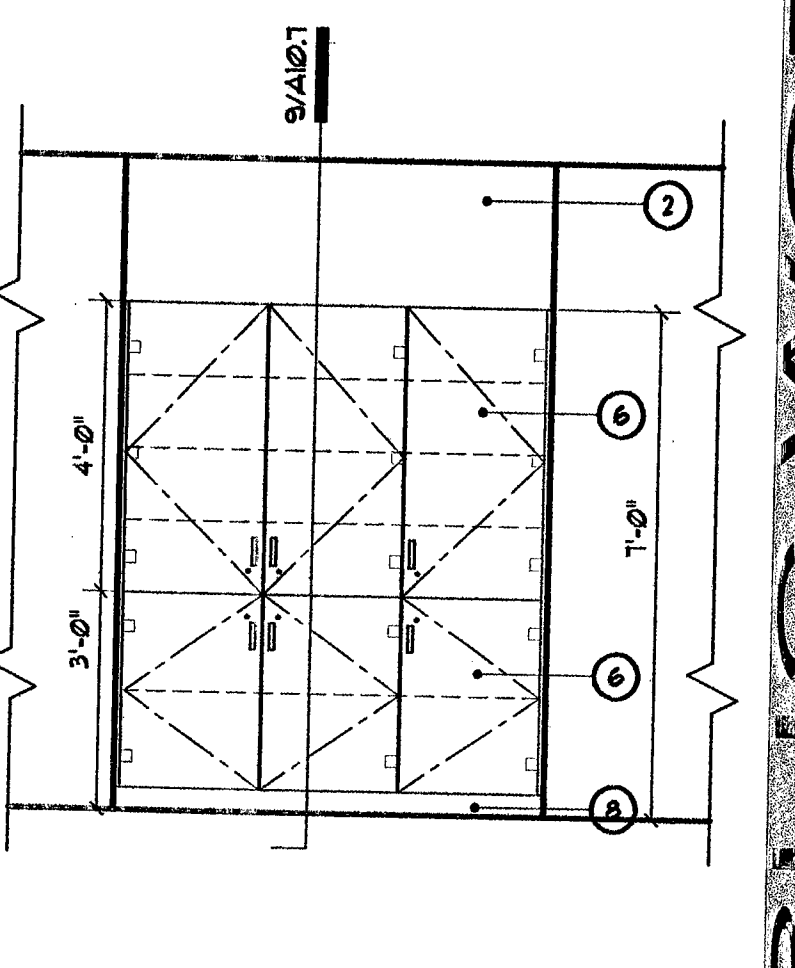
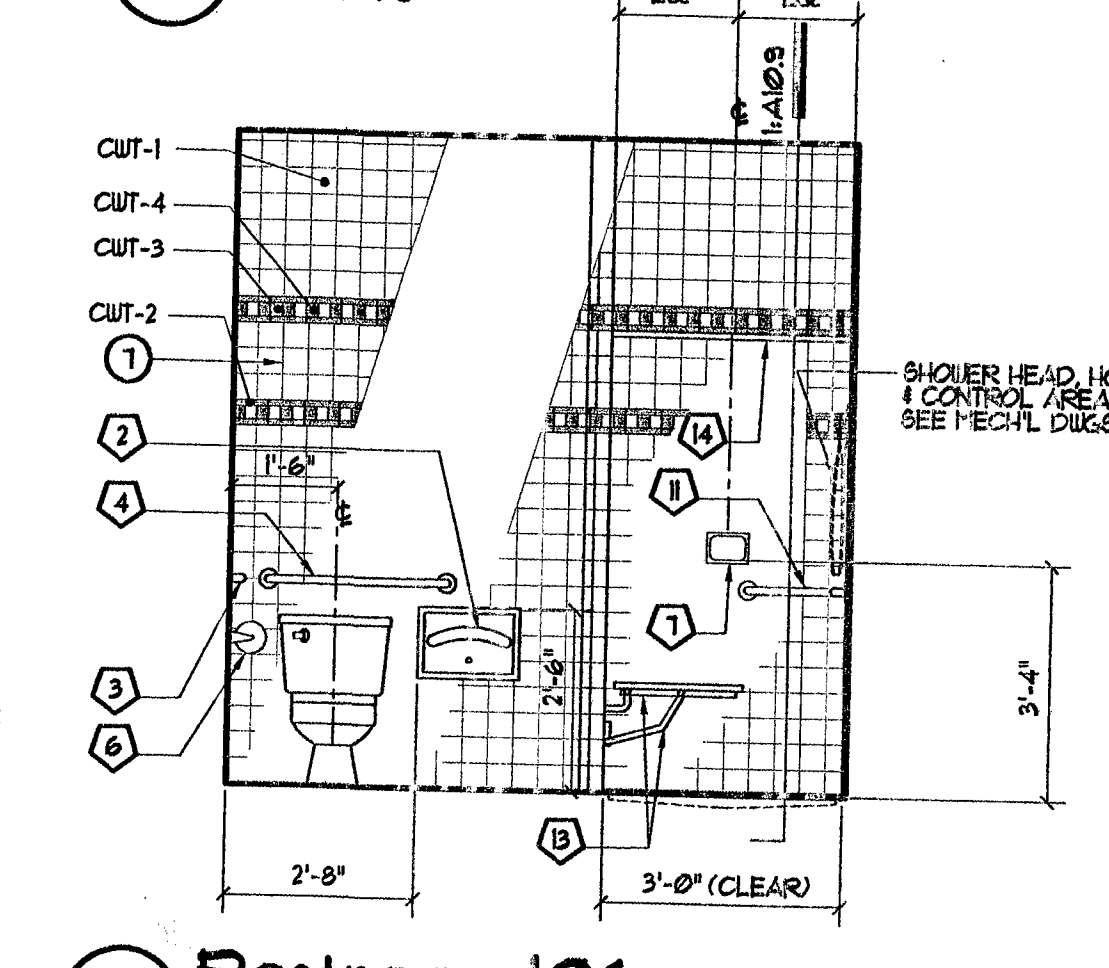
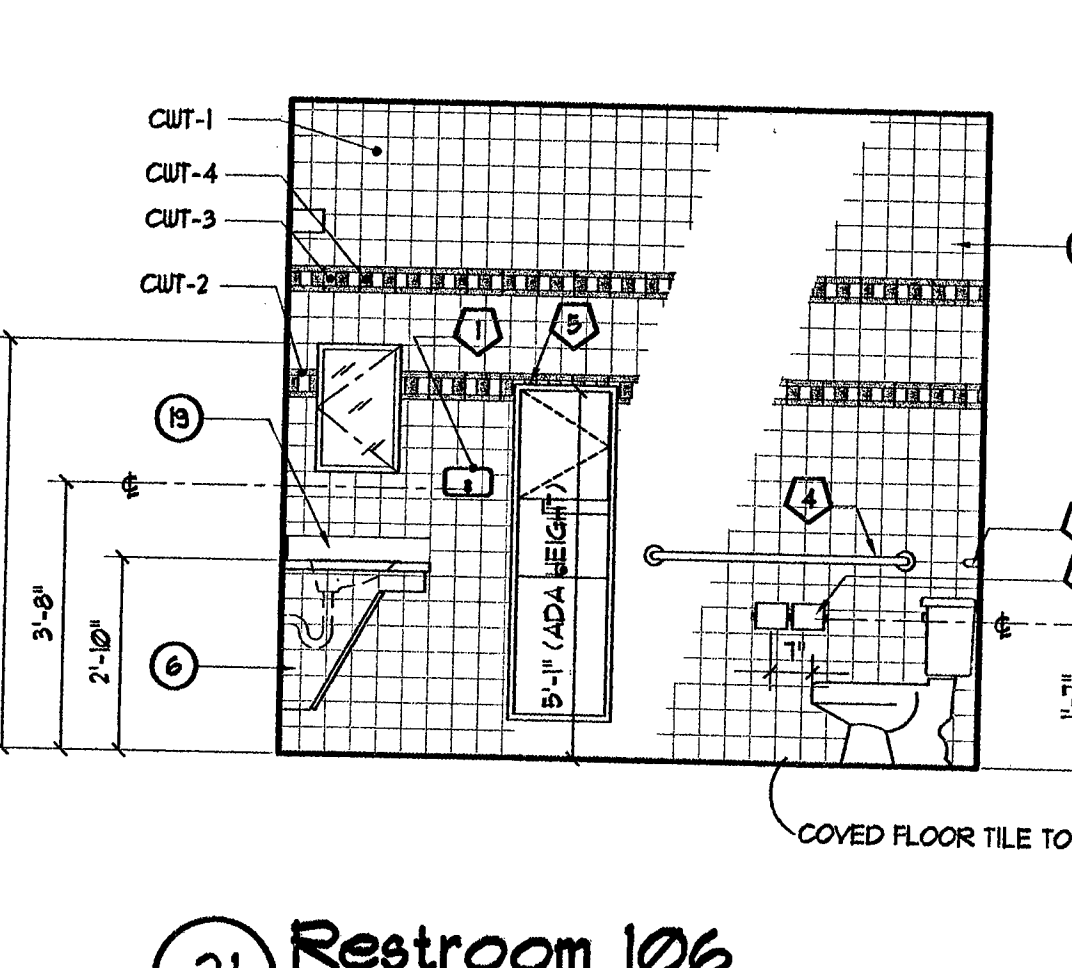


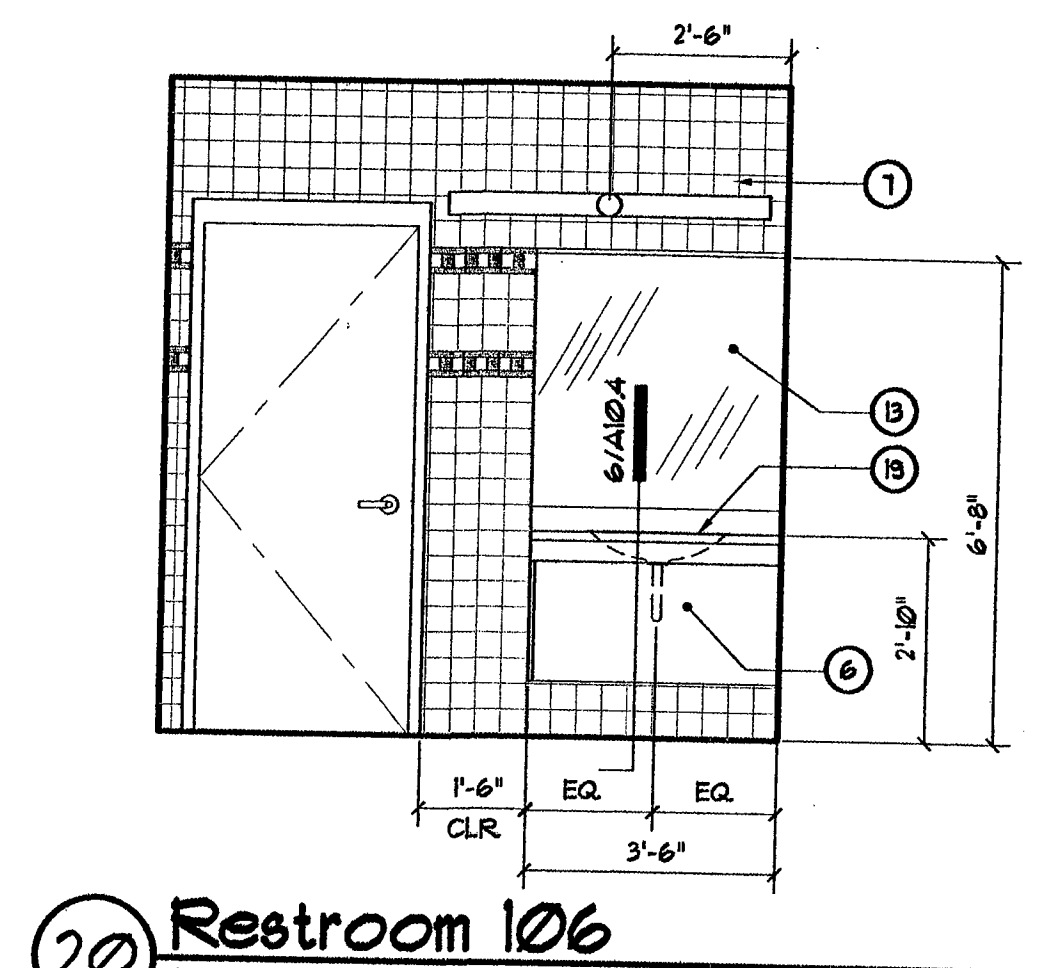

GENERAL NOTE: SEE SHEET A8J FOR TOILET ACCESSORY SCHEDULE.

SHOWER DOOR SPECIFICATION:
ALL SHOWER ENCLOSURES (W/ SIDELIGHTS WHERE SHOWN), SHALL BE:
ALUMINUM FRAMED SHOWER ENCLOSURE, BY CENTURY SHOWER DOORS® - (LUCETTE SERIES, MODEL NO. L-1623) OR AMERICAN SHOWER DOOR® (MODEL # 5104190) OR APPROX. SILVER ANODIZED FINISH & OBSCURE GLASS. VERIFY SIZE PRIOR TO FABRICATION.

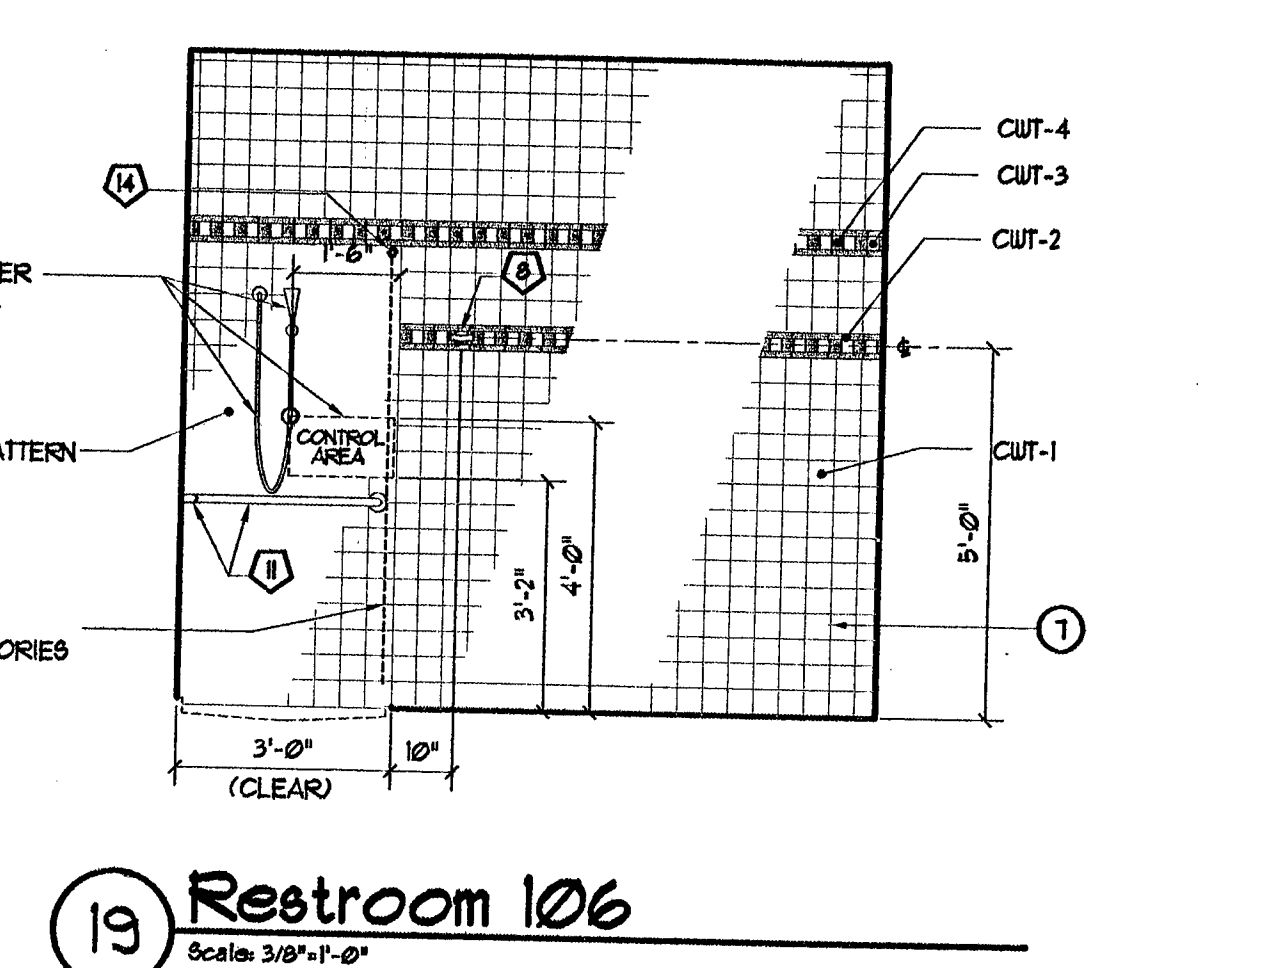

- Keynotes**
1. GYPSUM BOARD OVER METAL STUD FRAMING
 2. GYPSUM BOARD OVER FURRING CHANNELS
 3. STAINLESS STEEL BACKSPLASH TO MATCH COUNTERTOP
 4. ENGINEERED STONE COUNTERTOP, SEE ROOM FINISH SCHEDULE
 5. PLASTIC LAMINATE (LAM-1) FINISH UPPER / BASE CABINETS & SIDES
 6. CERAMIC WALL TILE AND COVE BASE
 7. RUBBER COVE BASE (RB-1), SEE SHT. A6
 8. TACK BOARD, SEE SPECIFICATIONS
 9. MARKER BOARD, SEE SPECIFICATIONS
 10. EXTEND CAB. FACE TO ADJACENT SURFACE, SCRIBE TO FIT
 11. FINISH END OF CABINETS W/ STAINLESS STEEL TO MATCH COUNTER, HEAT EXPOSED EDGES
 12. MIRROR, POLISH EDGES, ANCHOR W/ ADHESIVE, SEE SPEC'S
 13. SWIRLED STAINLESS STL. FINISH COUNTERTOP
 14. DASHED LINE INDICATES LINE OF S. STL. RANGE HOOD, SEE MECH. DUGS.
 15. S. STL. DISINFECTING SINK AND SHELVES, SEE PLUMBING SCHEDULE
 16. PREFABRICATED ALUMINUM SHOWER DOOR W/ SIDELIGHT, (SEE SHOWER DOOR SPEC THIS SHEET)
 17. LINEN CABINET, SEE DETAIL 3/A102.1
 18. ENGINEERED STONE COUNTERTOP AND BACKSPLASH - SEE FINISH SCHEDULE
 19. S. STL. BACKING OF INTERIOR SIDE OF WALL TYPE "A". S. STL. TO MATCH TYPE I HOOD (GAGE, FINISH, ETC.). FASTEN S. STL. BACKING PER FABRICATOR'S RECOMMENDATIONS. (SUBMIT SHOP DRAWINGS FOR ATTACHMENT FABRICATION, EXTEND BACKING 16" BEYOND BACK OF HOOD (3 SIDES) AS SHOWN.

CITY OF LAS VEGAS, NEVADA
FIRE STATION #48
Interior Elevations

PLANS APPROVED
ARCHITECTURAL
Building & Safety Dept.
City of Las Vegas, Nevada

JCE OCT 17 2007

Does Not Include Electrical, Plumbing, Mechanical, Structural or Civil-Size. Measurements Made in the Field. Without Approval Plan is Not a Permit to Violate Any Ordinance.

Keynotes

1. GYPSUM BOARD OVER METAL STUD FRAMING
2. GYPSUM BOARD OVER FURRING CHANNELS
3. STAINLESS STEEL BACKSPLASH TO MATCH COUNTERTOP
4. ENGINEERED STONE COUNTERTOP, SEE ROOM FINISH SCHEDULE
5. PLASTIC LAMINATE (LAM-1) FINISH UPPER / BASE CABINETS & SIDES
6. CERAMIC WALL TILE AND COVE BASE
7. RUBBER COVE BASE (RB-1), SEE SHT. A6
8. TACK BOARD, SEE SPECIFICATIONS
9. MARKER BOARD, SEE SPECIFICATIONS
10. EXTEND CAB. FACE TO ADJACENT SURFACE, SCRIBE TO FIT
11. FINISH END OF CABINETS W/ STAINLESS STEEL TO MATCH COUNTER, HEAT EXPOSED EDGES
12. MIRROR, POLISH EDGES, ANCHOR W/ ADHESIVE, SEE SPEC'S
13. SWIRLED STAINLESS STL. FINISH COUNTERTOP
14. DASHED LINE INDICATES LINE OF S. STL. RANGE HOOD, SEE MECH. DUGS.
15. S. STL. DISINFECTING SINK AND SHELVES, SEE PLUMBING SCHEDULE
16. PREFABRICATED ALUMINUM SHOWER DOOR W/ SIDELIGHT, (SEE SHOWER DOOR SPEC THIS SHEET)
17. LINEN CABINET, SEE DETAIL 3/A102.1
18. ENGINEERED STONE COUNTERTOP AND BACKSPLASH - SEE FINISH SCHEDULE
19. S. STL. BACKING OF INTERIOR SIDE OF WALL TYPE "A". S. STL. TO MATCH TYPE I HOOD (GAGE, FINISH, ETC.). FASTEN S. STL. BACKING PER FABRICATOR'S RECOMMENDATIONS. (SUBMIT SHOP DRAWINGS FOR ATTACHMENT FABRICATION, EXTEND BACKING 16" BEYOND BACK OF HOOD (3 SIDES) AS SHOWN.

AMUEL D. TOIMAN
REGISTERED ARCHITECT
No. 2272
STATE OF NEVADA

OWNER: CITY OF LAS VEGAS
DEPARTMENT OF PUBLIC WORKS
ARCHITECTURAL SERVICES

ARCHITECT OF RECORD
SAMUEL D. TOIMAN, AIA, NCARB
400 EAST STEWART AVENUE
LAS VEGAS, NEVADA 89101
PHONE: (702) 229-6535
FAX: (702) 382-3232
TDD: (702) 386-9108

DRAWN: EPB
FILE: 1948-A82
DATE: 1/31/01
SCALE: 3/8"=1'-0"
SHEET NO: 061534113
SHEET NO: 630-104

A8.2