




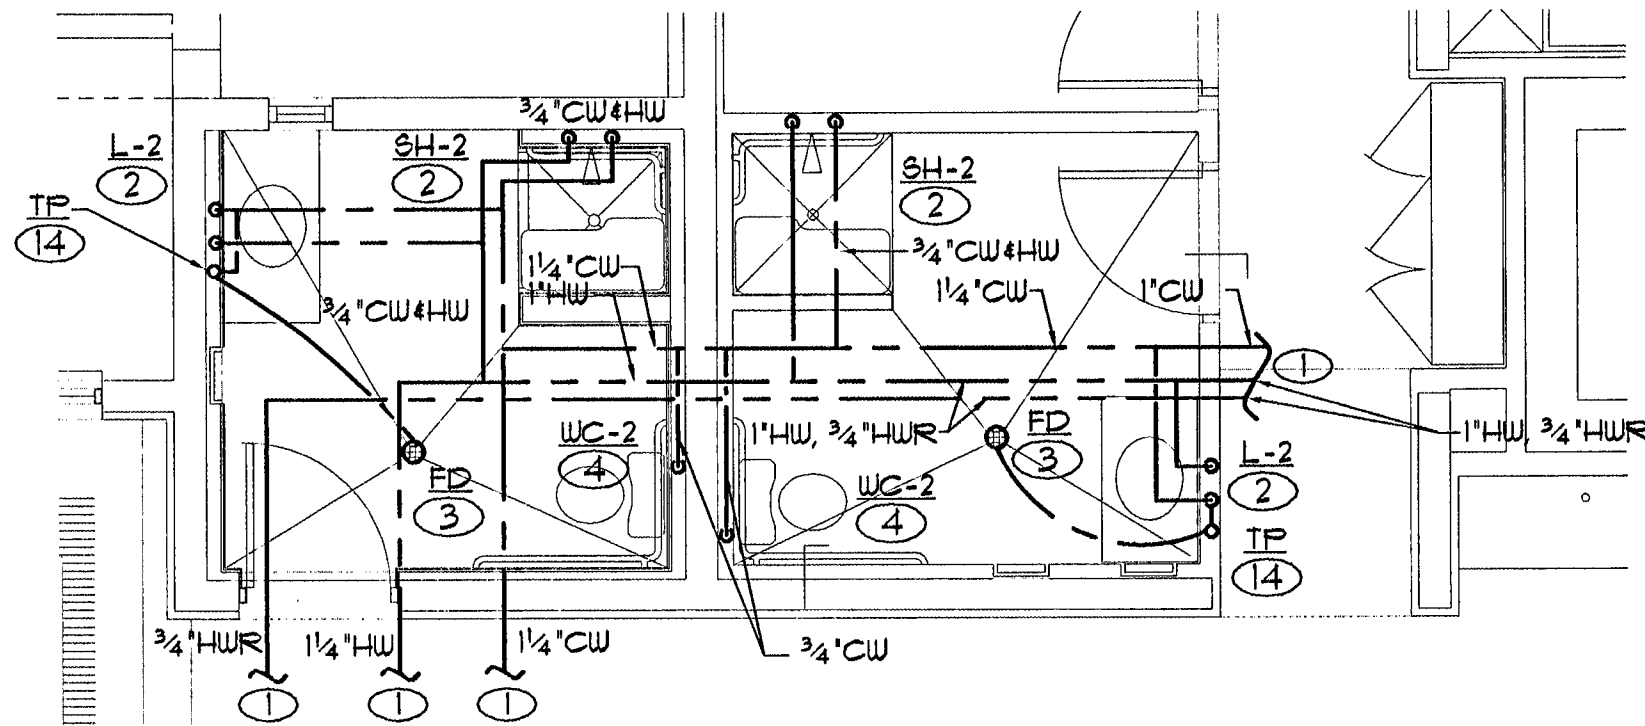


1 RESTROOM - DOMESTIC WATER
SCALE: 1/4" = 1'-0"

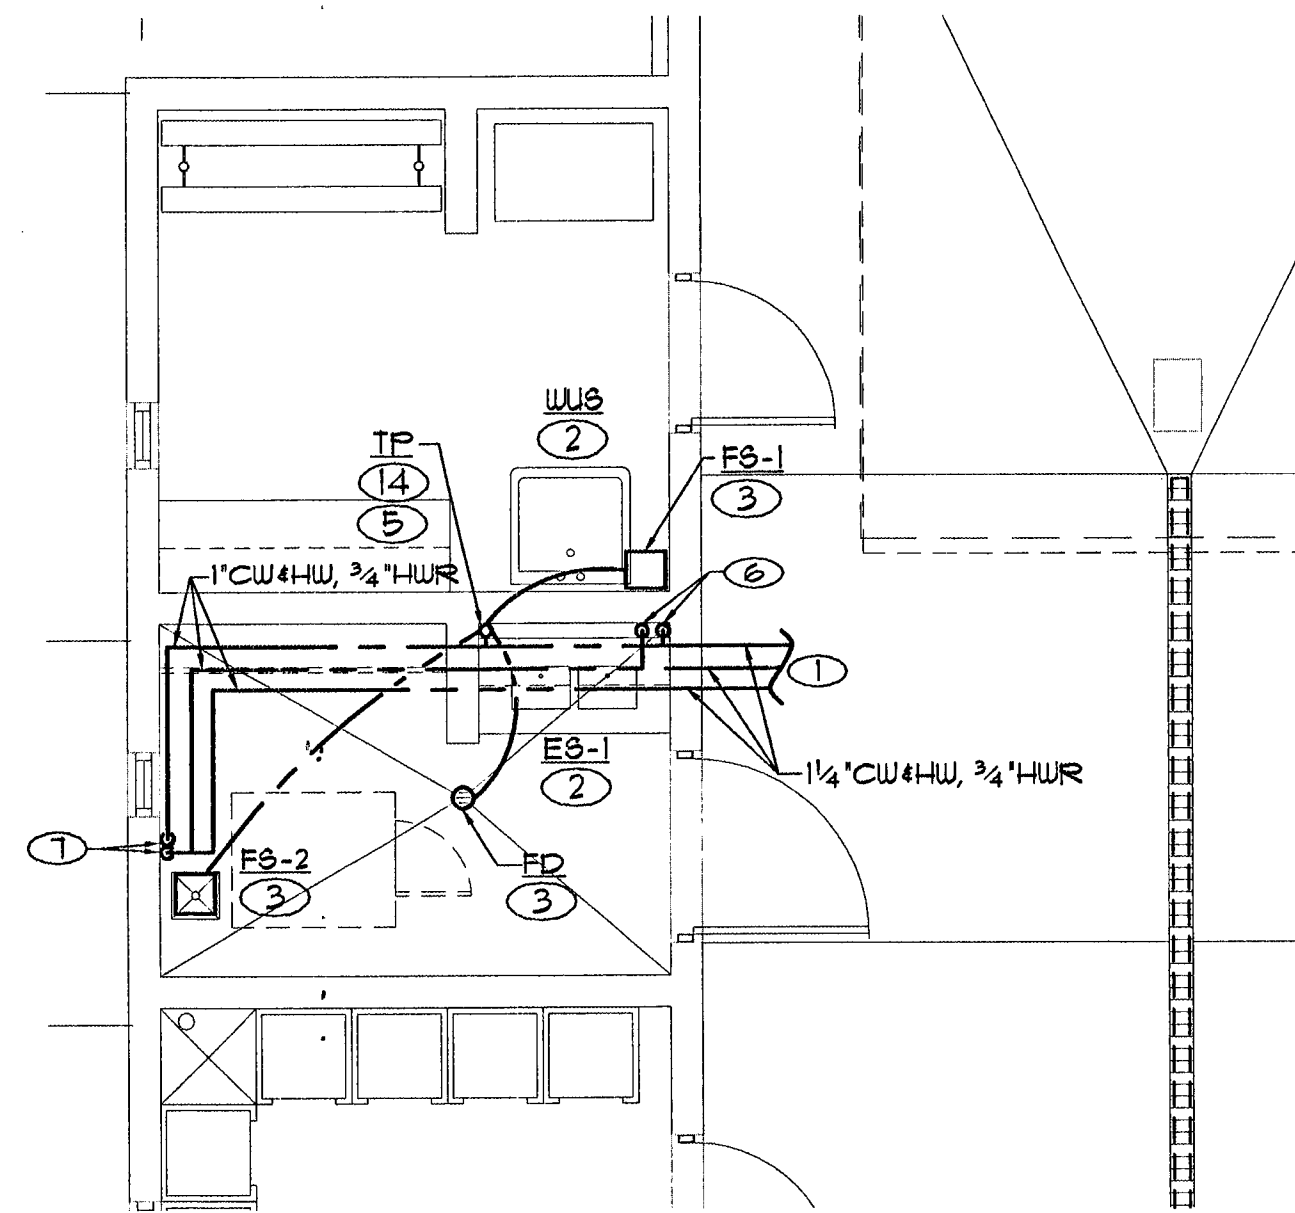


2 CLEAN ROOM - DOMESTIC WATER
SCALE: 1/4" = 1'-0"

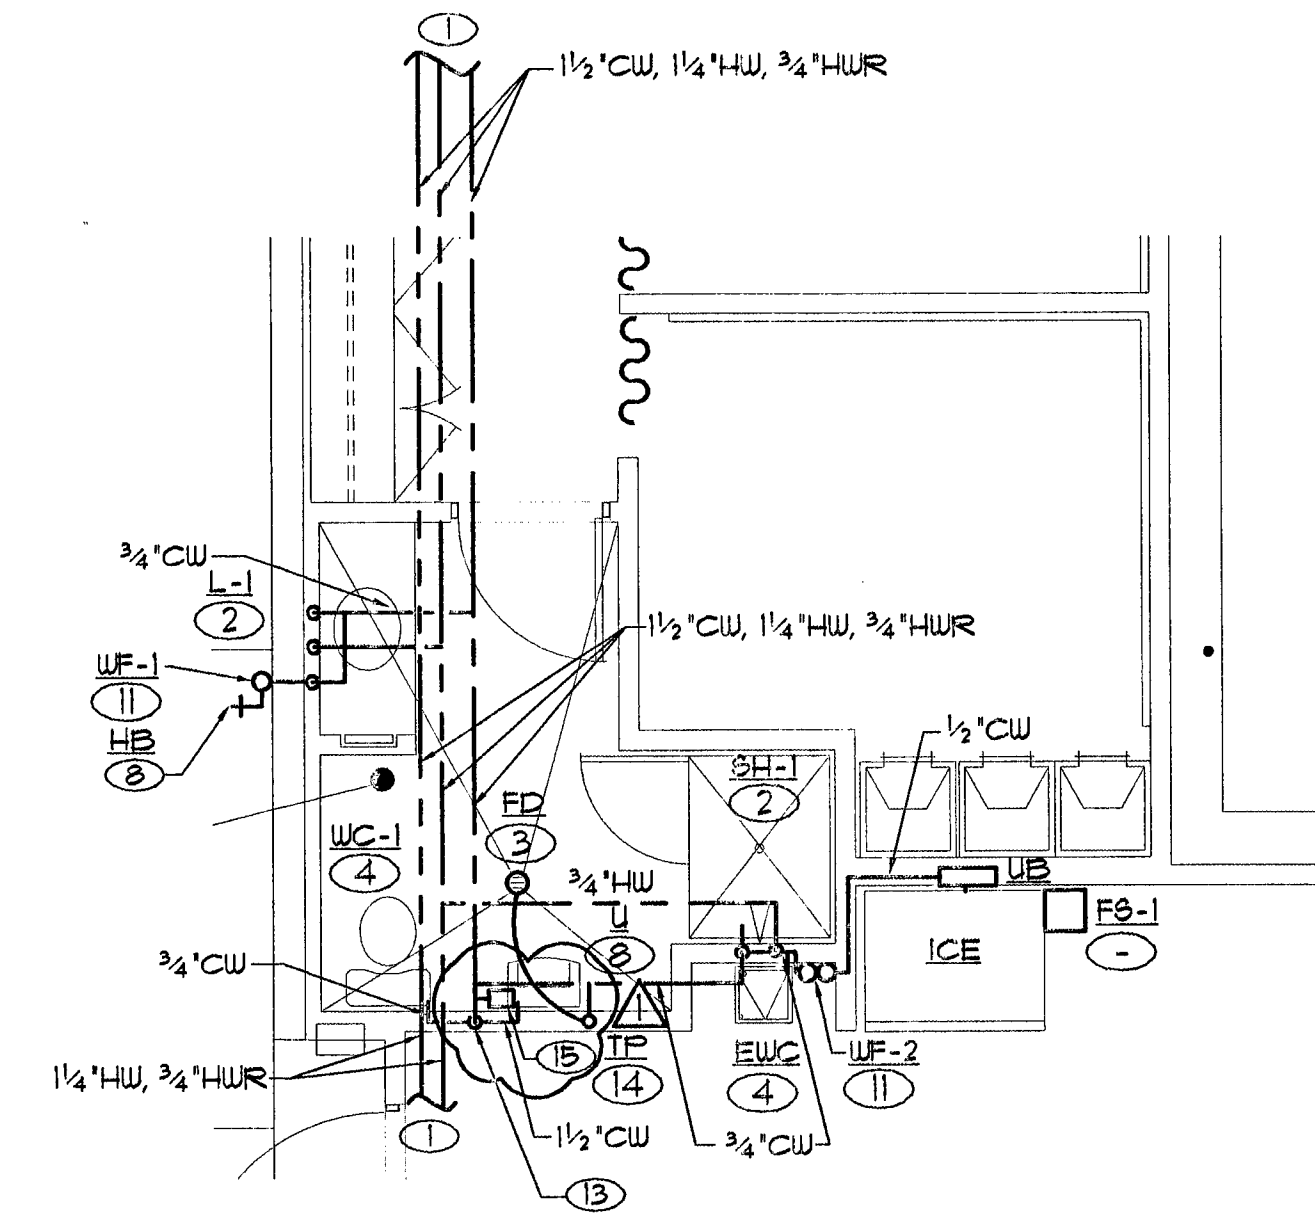


3 CAPTAIN'S BATHROOM - DOMESTIC WATER
SCALE: 1/4" = 1'-0"

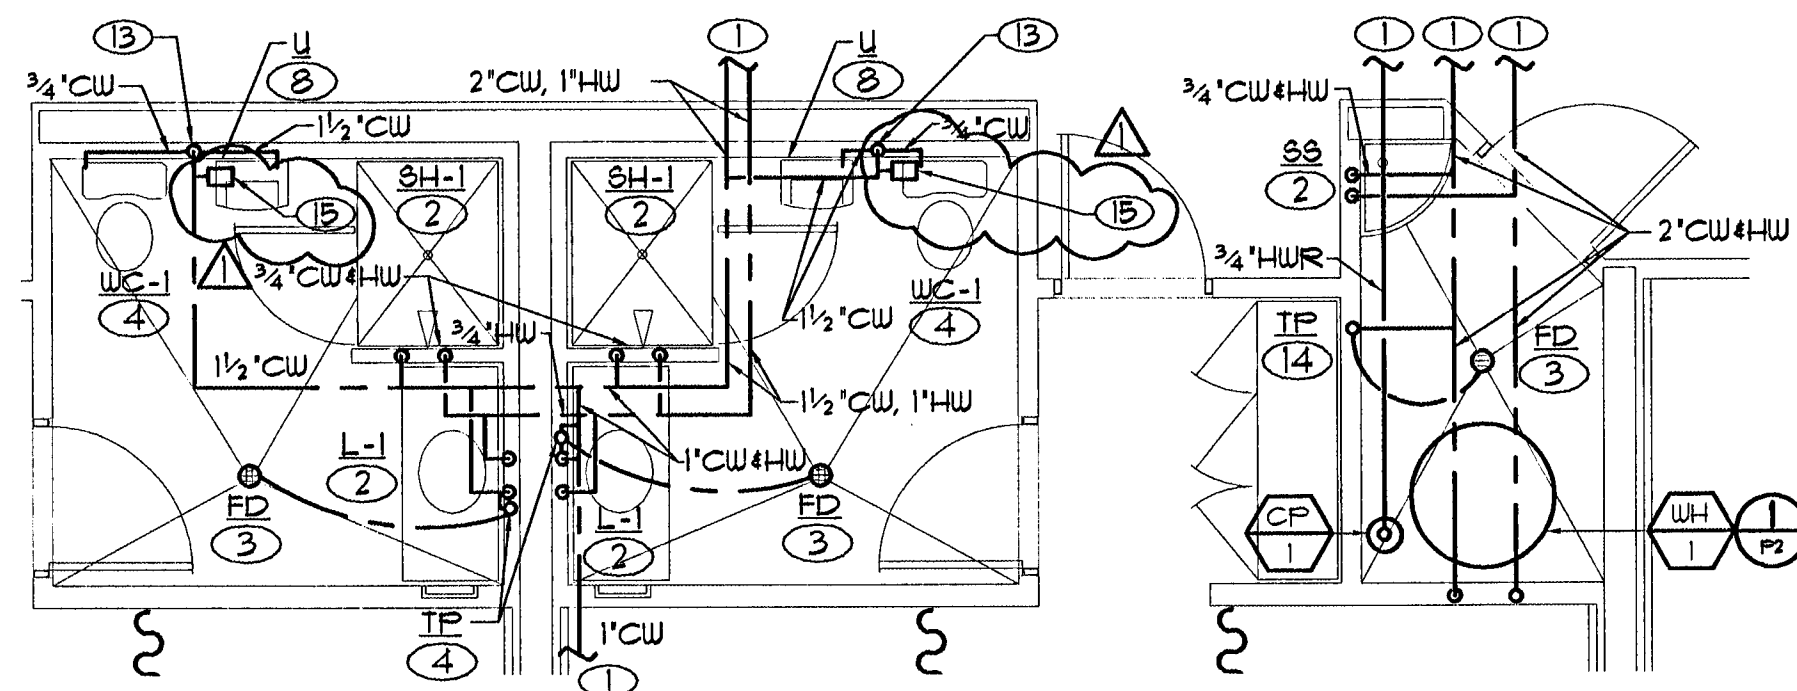

4 RESTROOM - DOMESTIC WATER
SCALE: 1/4" = 1'-0"

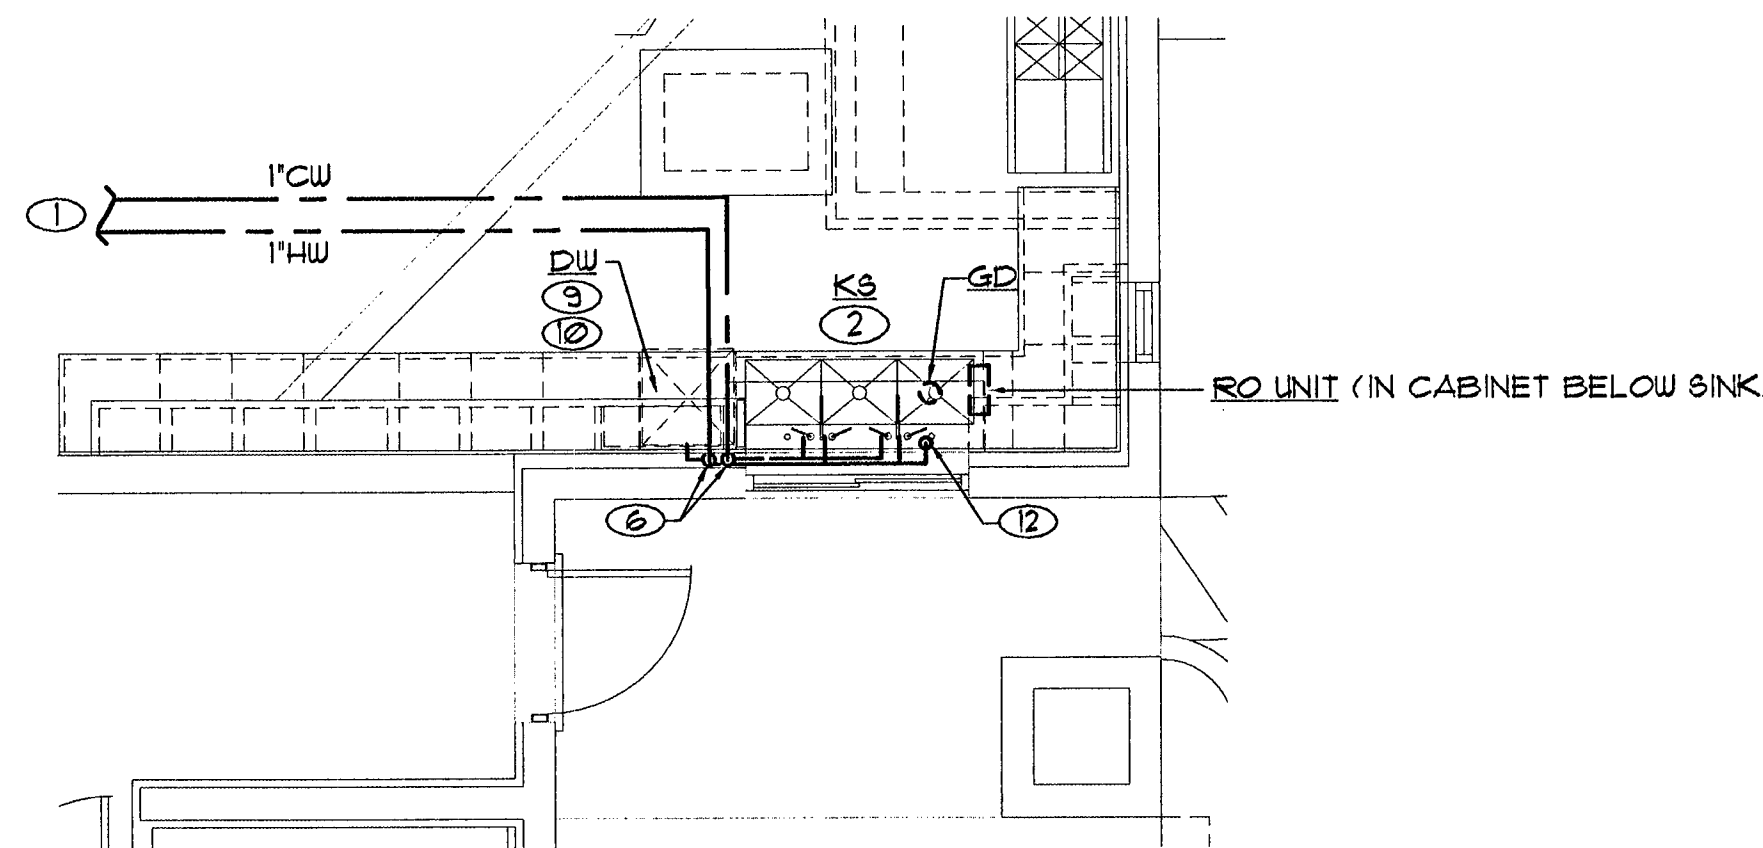

5 KITCHEN - DOMESTIC WATER
SCALE: 1/4" = 1'-0"

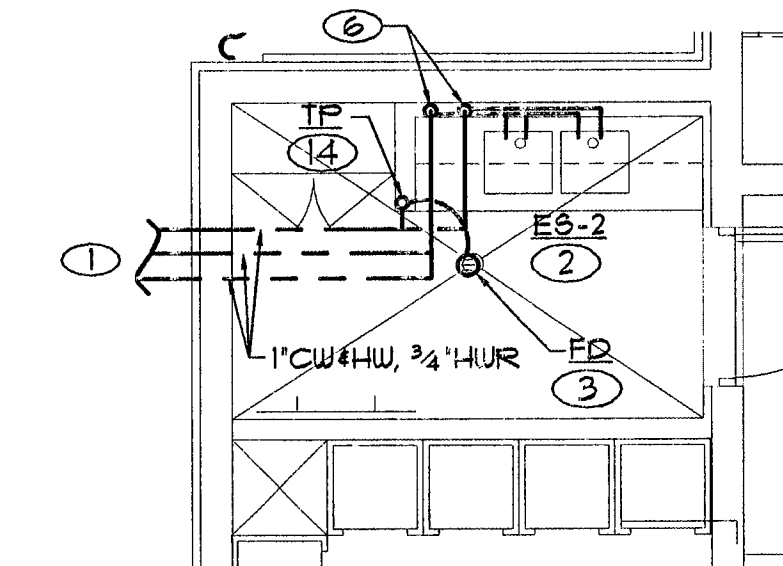

6 RESCUE CLEAN ROOM - DOMESTIC WATER
SCALE: 1/4" = 1'-0"

SHEET NOTES

- 1 REFER TO SHEET P3 FOR CONTINUATION.
- 2 3/4" CW AND HW.
- 3 1/2" CW BELOW SLAB FROM TRAP PRIMER.
- 4 3/4" CW.
- 5 PROVIDE PRECISION PLUMBING PRODUCTS MODEL NO. DU-3 TRAP PRIMER DISTRIBUTION UNIT.
- 6 1" CW AND HW DOWN IN WALL. DISTRIBUTE TO FIXTURES.
- 7 3/4" CW AND HW DOWN TO HOSE BIBBS FOR WASHER/EXTRACTOR.
- 8 3/4" CW.
- 9 FURNISHED BY OWNER AND INSTALLED BY CONTRACTOR.
- 10 1/2" HW.
- 11 MOUNT FILTER ASSEMBLY ON WALL.
- 12 DECK MOUNTED SPRAYER WITH WALL HOOK.
- 13 1/2" CW DOWN IN WALL. DISTRIBUTE TO FIXTURES.
- 14 1/2" CW.
- 15 WATER HAMMER ARRESTOR. PROVIDE ACCESS PANEL.

PLANS APPROVED
PLUMBING/MECHANICAL
Building & Safety Dept.
City of Las Vegas, Nevada


8/31/07

Does Not Include Architectural, Electrical
Structural or Civil Site
Improvements. Make No Change
Without Approval. Plan is
Not a Permit to Violate Any Ordinance.

RECEIVED

SEP - 6 2007

CITY OF LAS VEGAS
BUILDING DEPT.

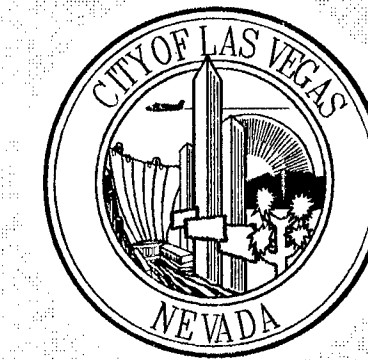


REVISIONS
CLV PLAN CHECK
CONTENTS 8-31-07

CONSULTANT
COMFORT ENGINEERING
COMFORT BY DESIGN
MECHANICAL-ELECTRICAL-PLUMBING
9175 WEST FLAMINGO ROAD, LAS VEGAS, NEVADA 89147
TEL: (702) 367-0892 FAX: 367-4076
06-0514

CITY OF LAS VEGAS, NEVADA

FIRE STATION #48

ENLARGED PLUMBING PLANS -
DOMESTIC WATER

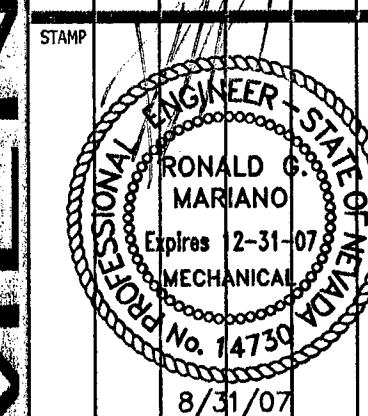

OWNER: CITY OF LAS VEGAS
DEPARTMENT OF PUBLIC WORKS
ARCHITECTURAL SERVICES

ARCHITECT OF RECORD
SAMUEL D. TOLMAN, AIA, NCARB
400 EAST STEWART AVENUE
LAS VEGAS, NEVADA 89101
PHONE: (702) 229-5531
FAX: (702) 382-3232
TDD: (702) 386-9108

DRAWN	DBB
TITLE	26-0514
DATE	07/17/07
SCALE	1/4" = 1'-0"
BID NO.	
C/DWG NO.	
SHT NO.	

P6