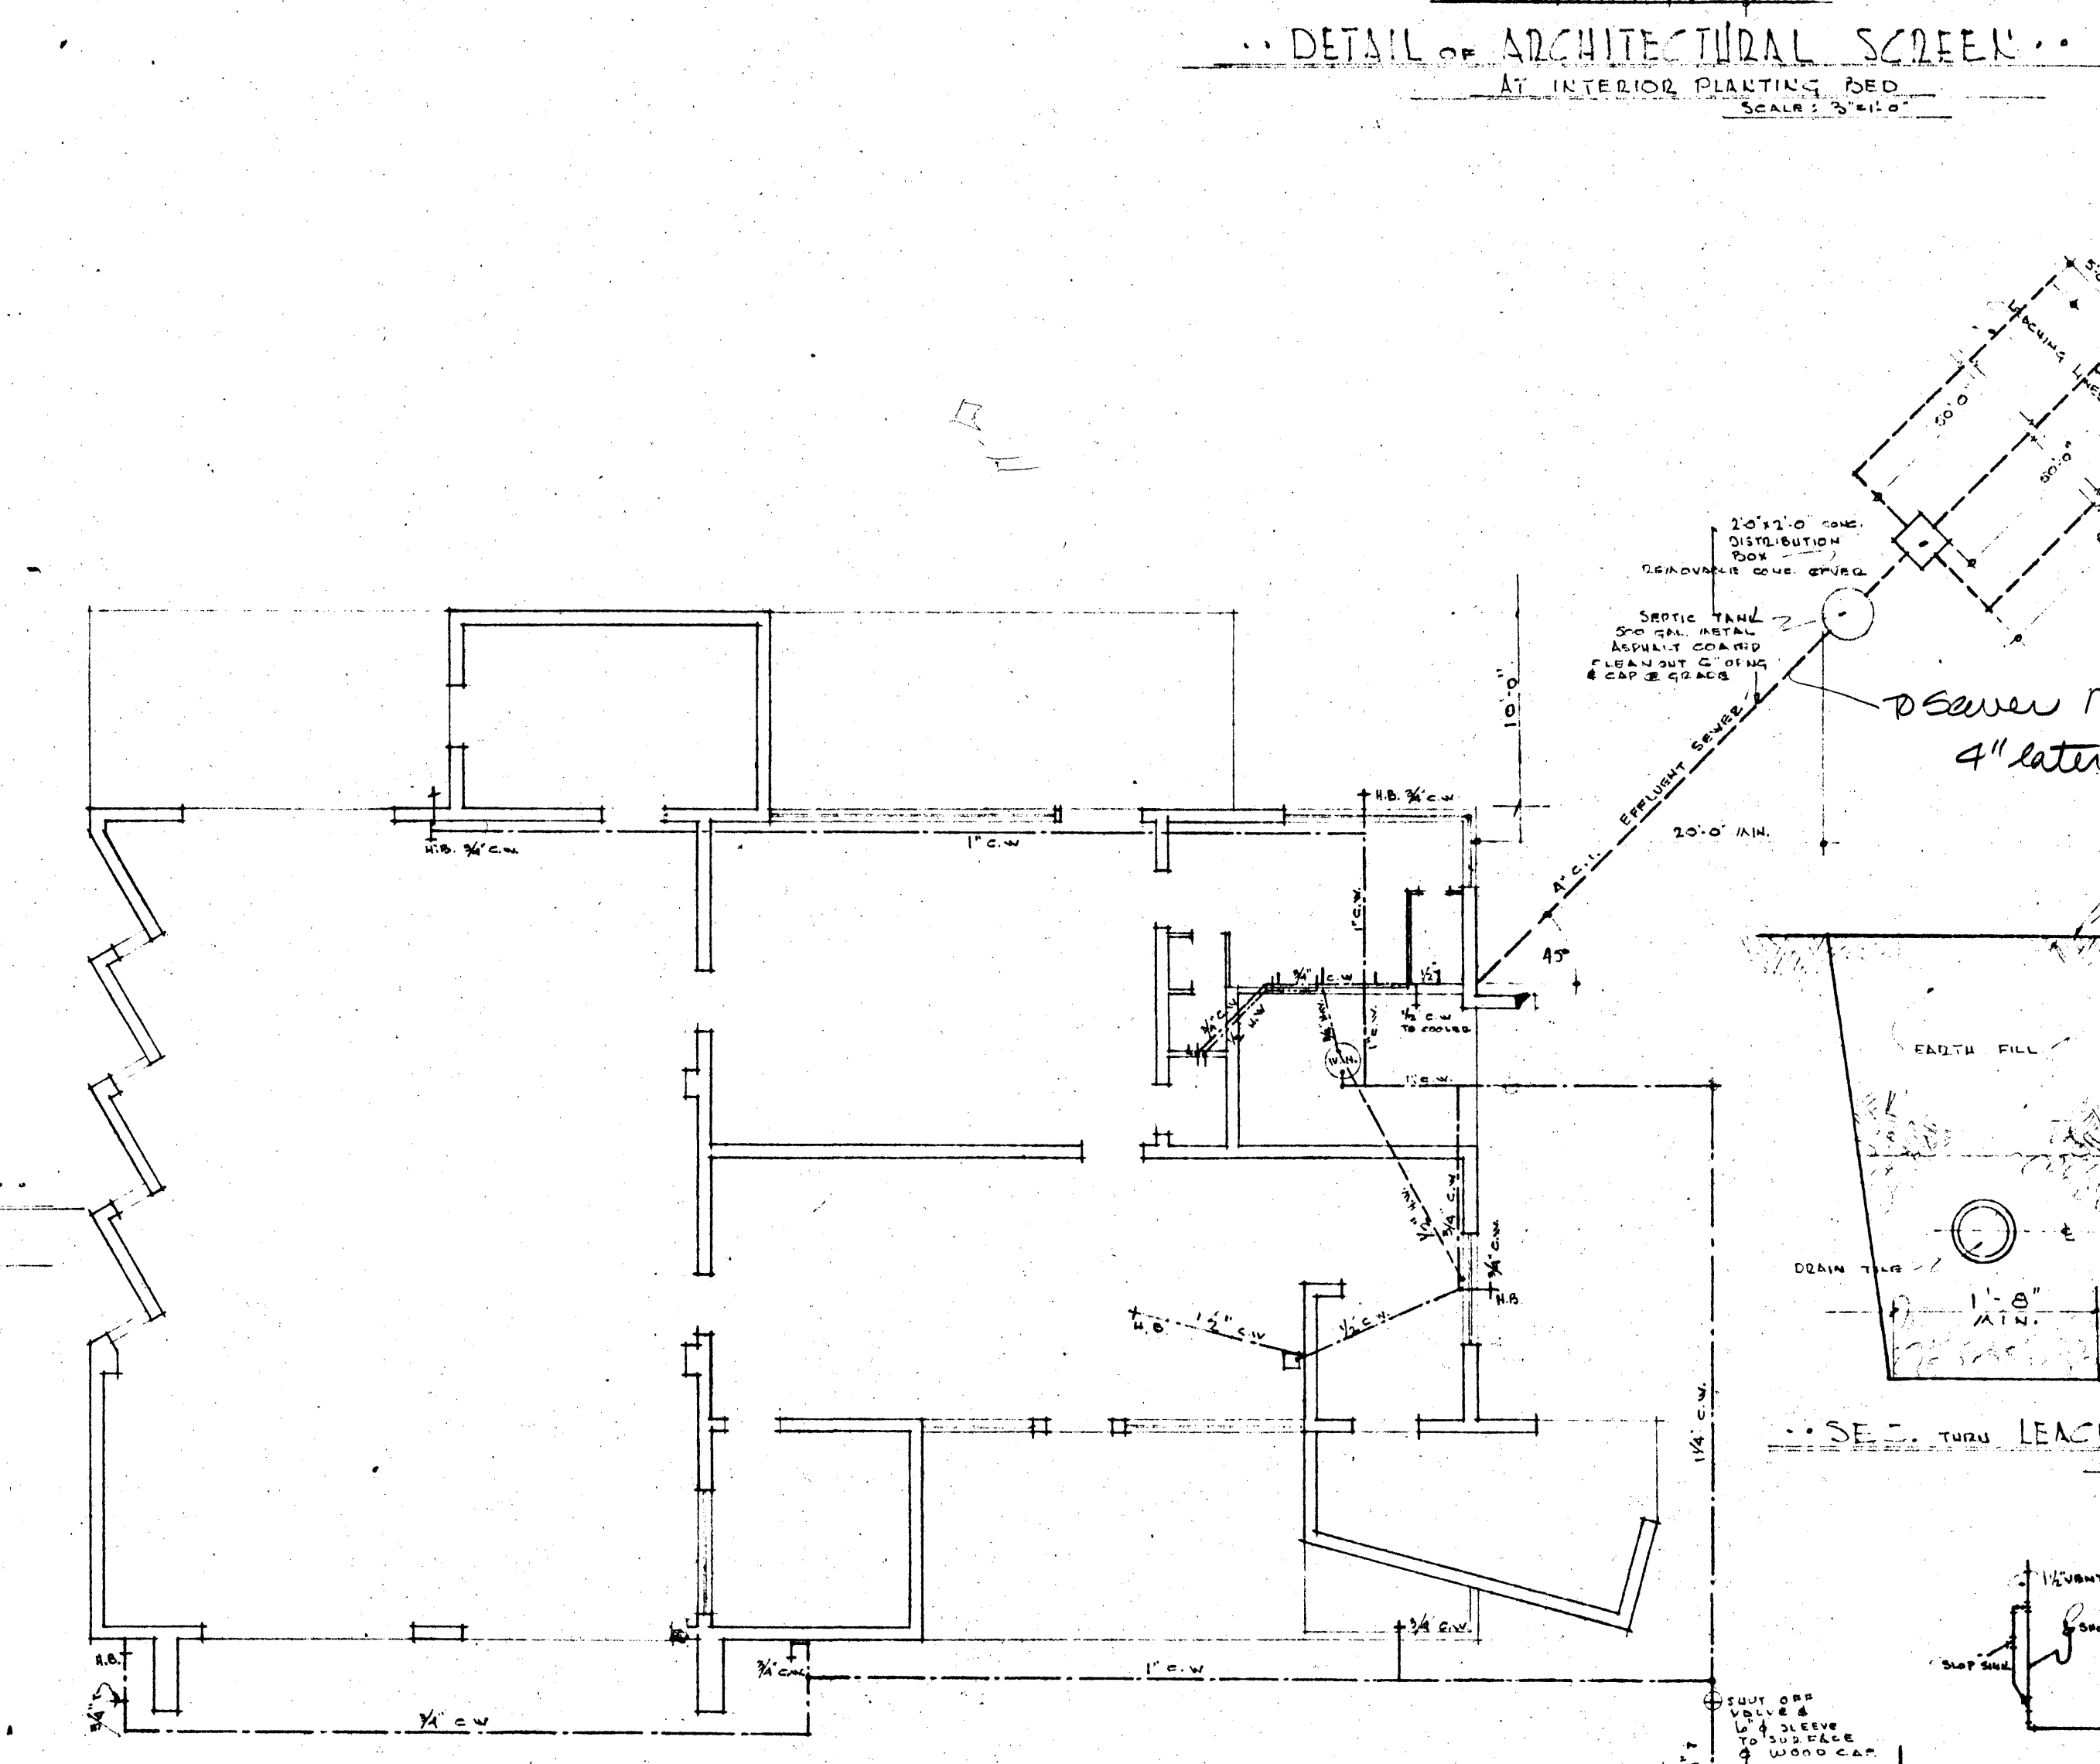
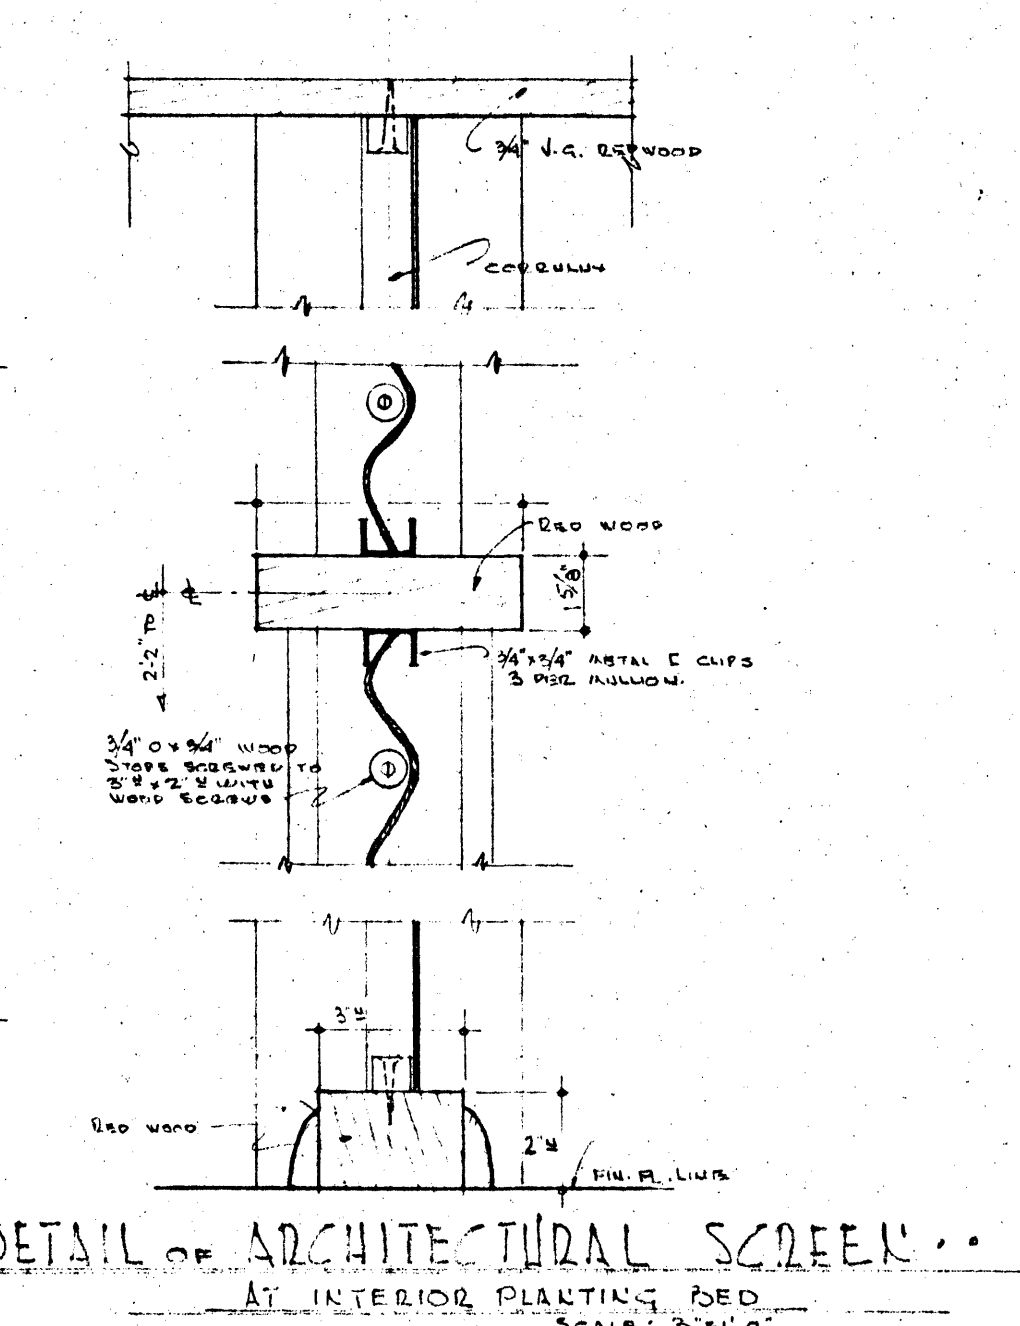
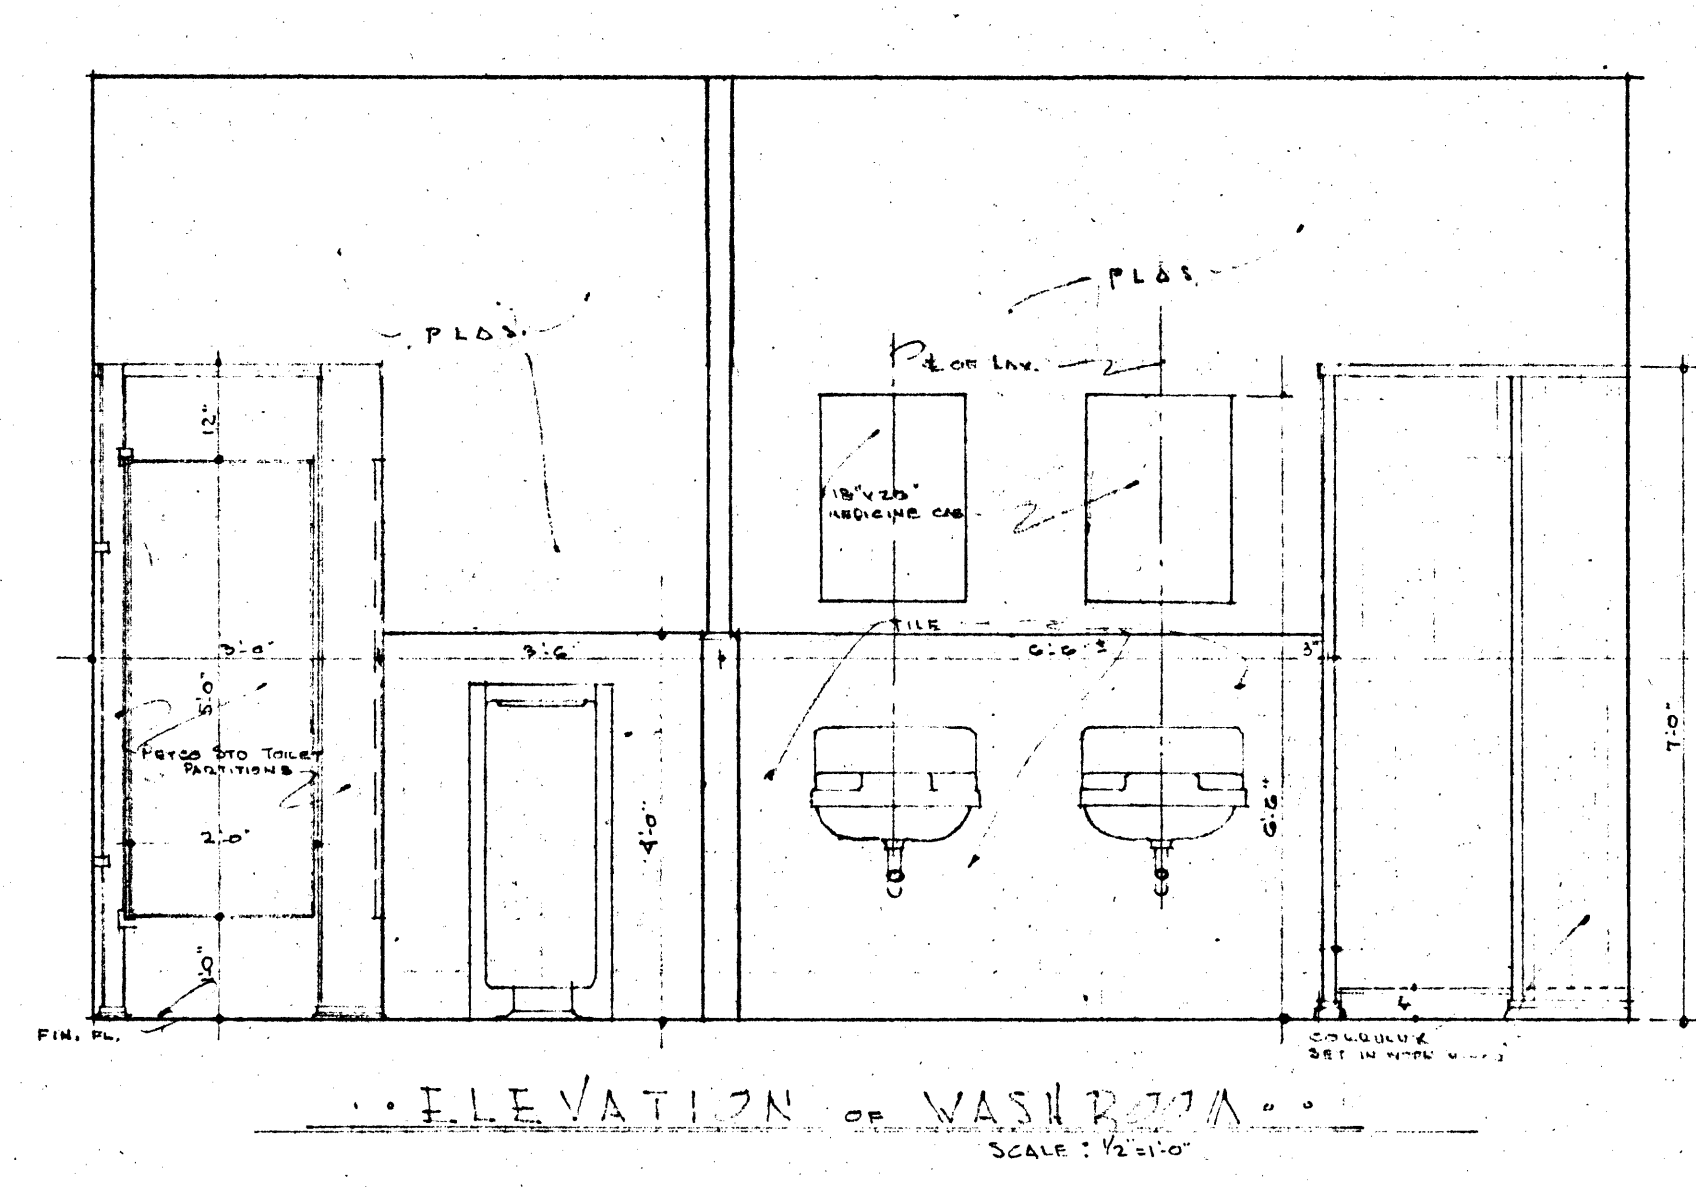
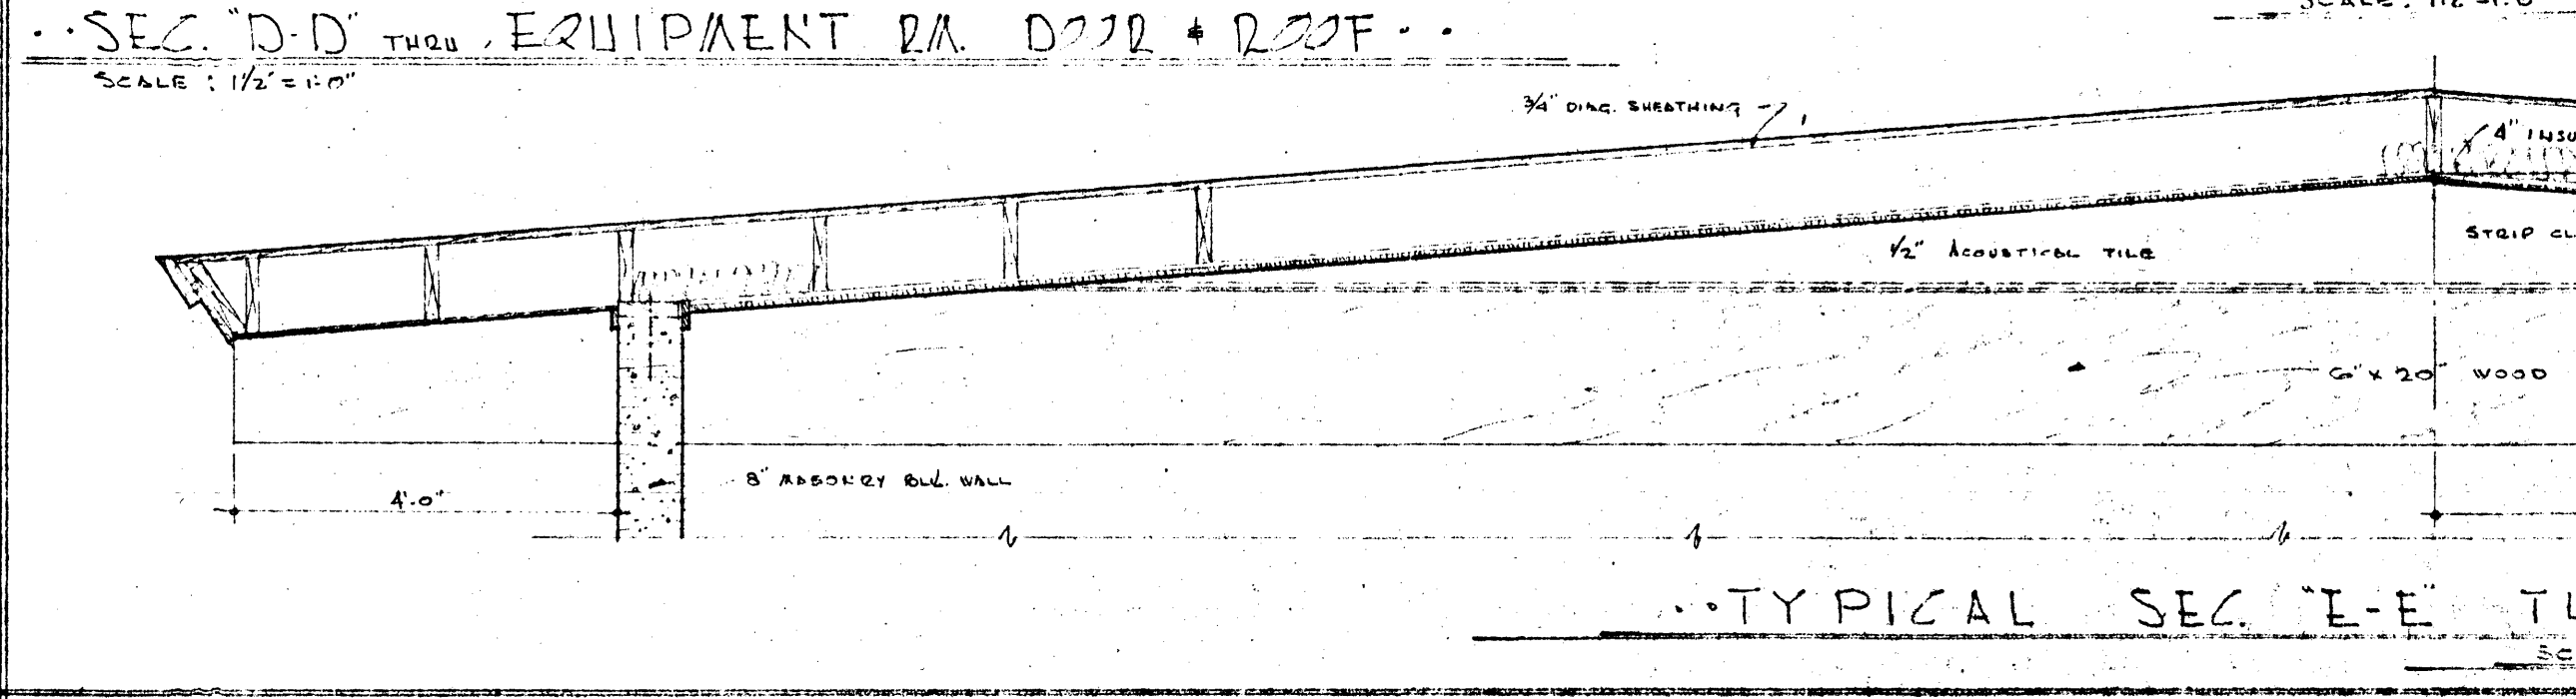
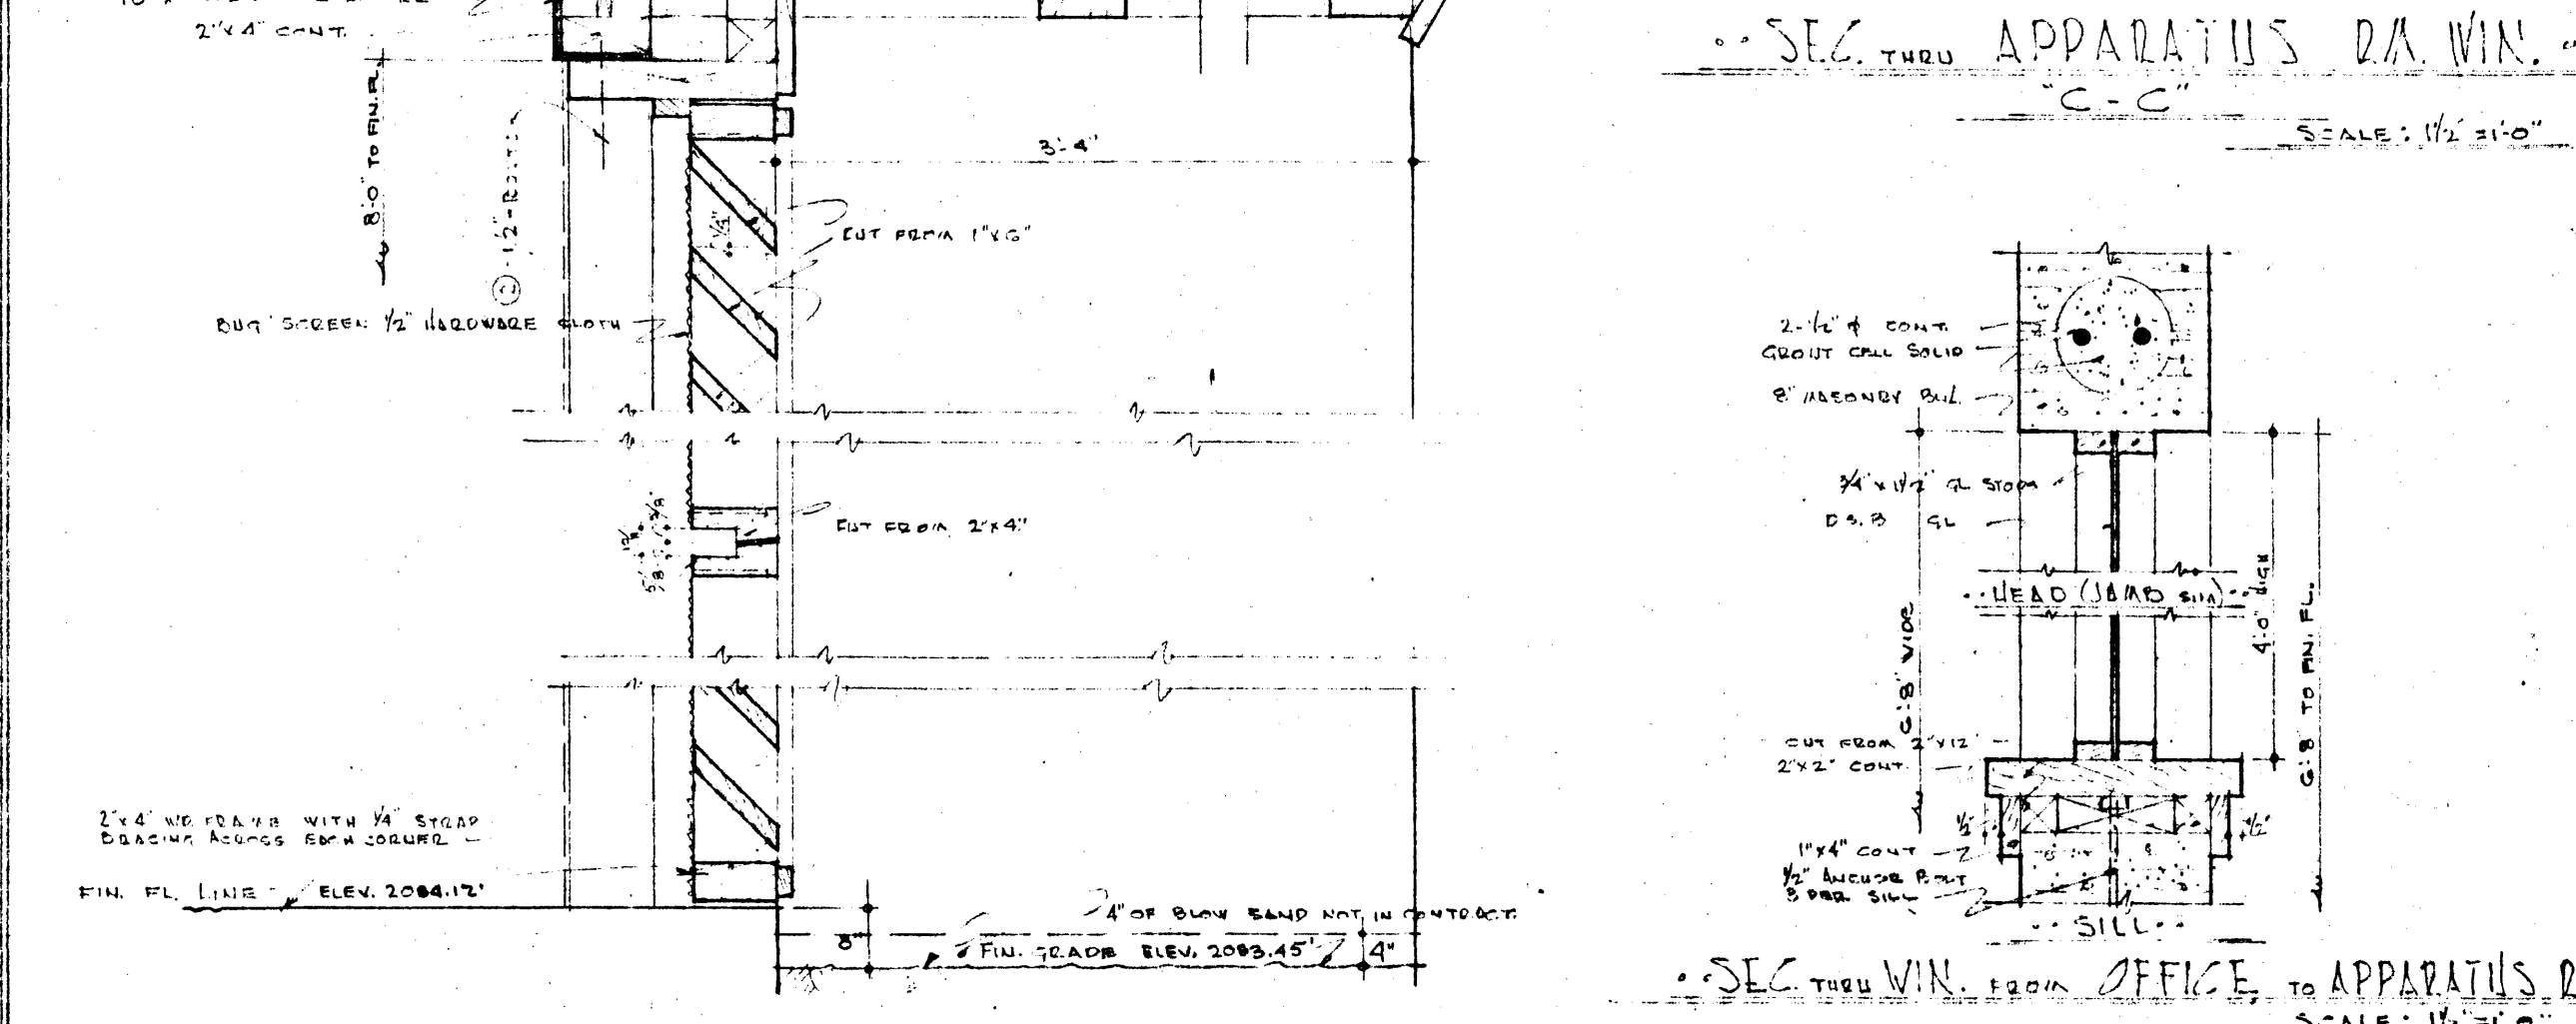
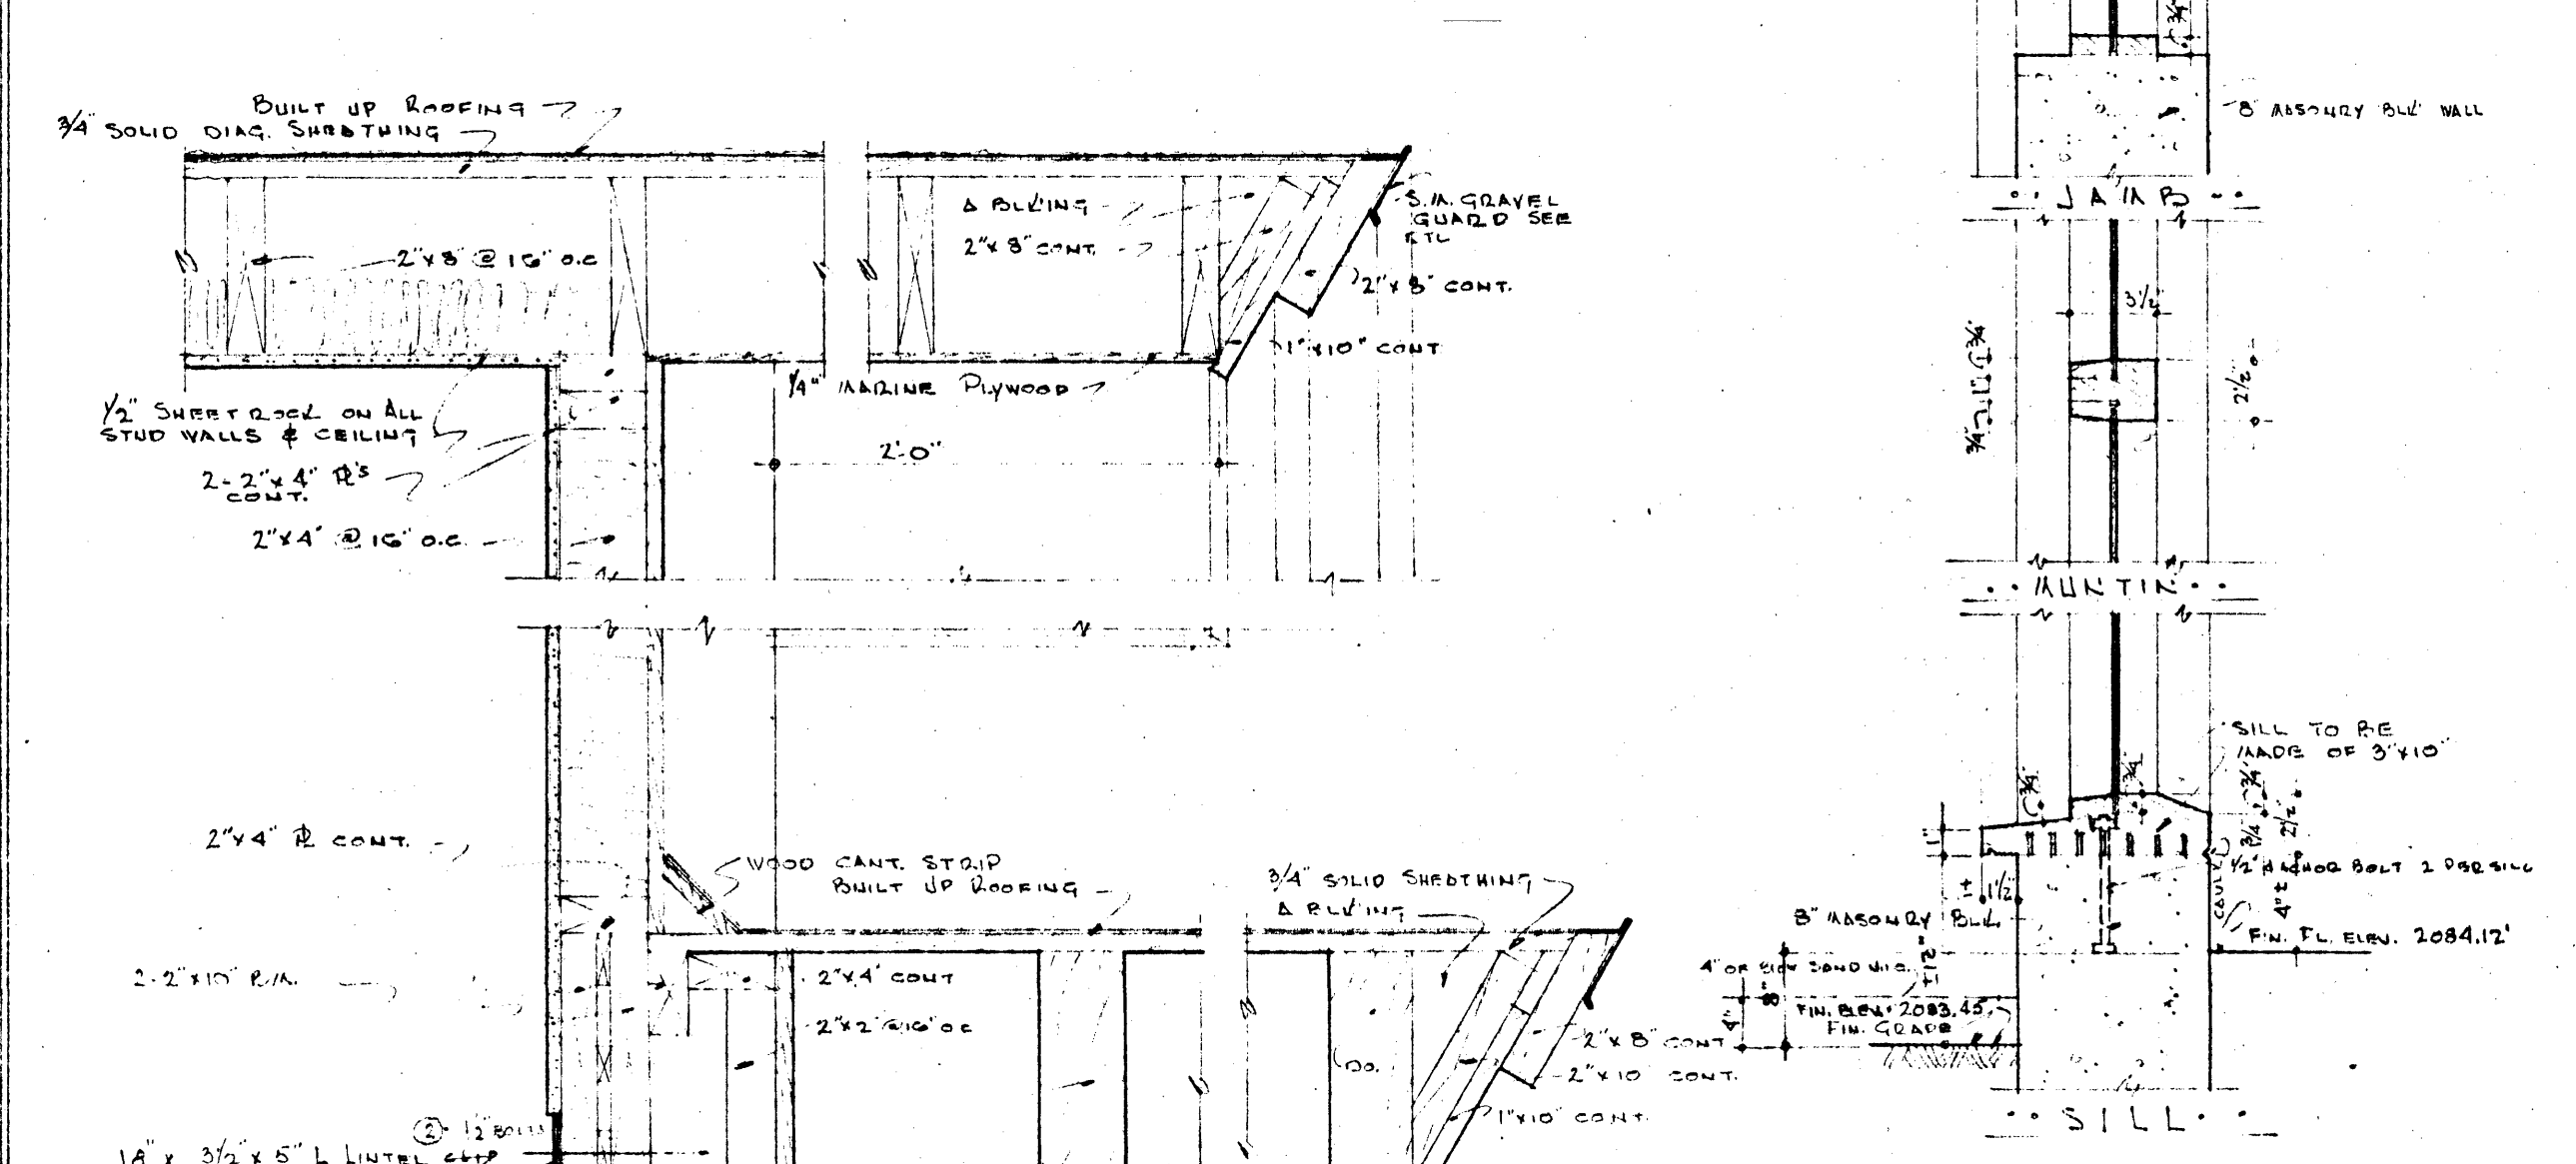
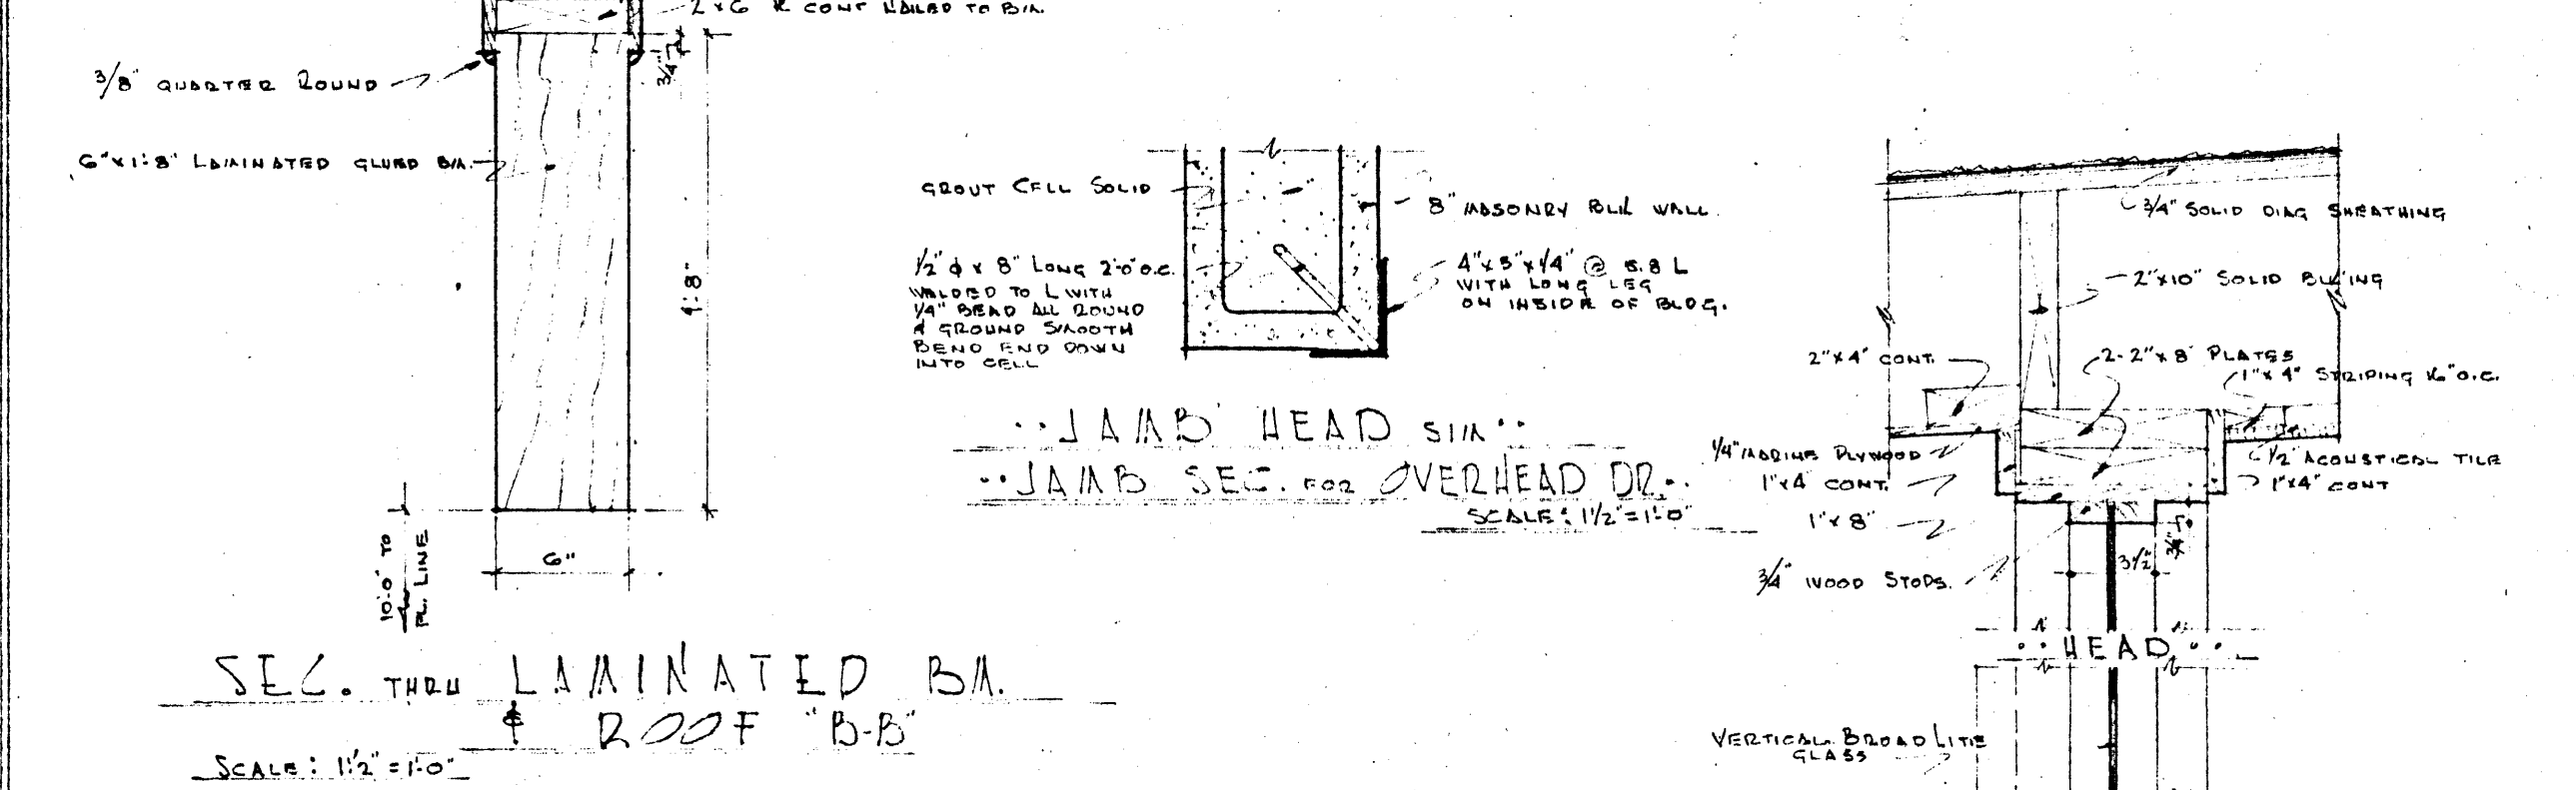
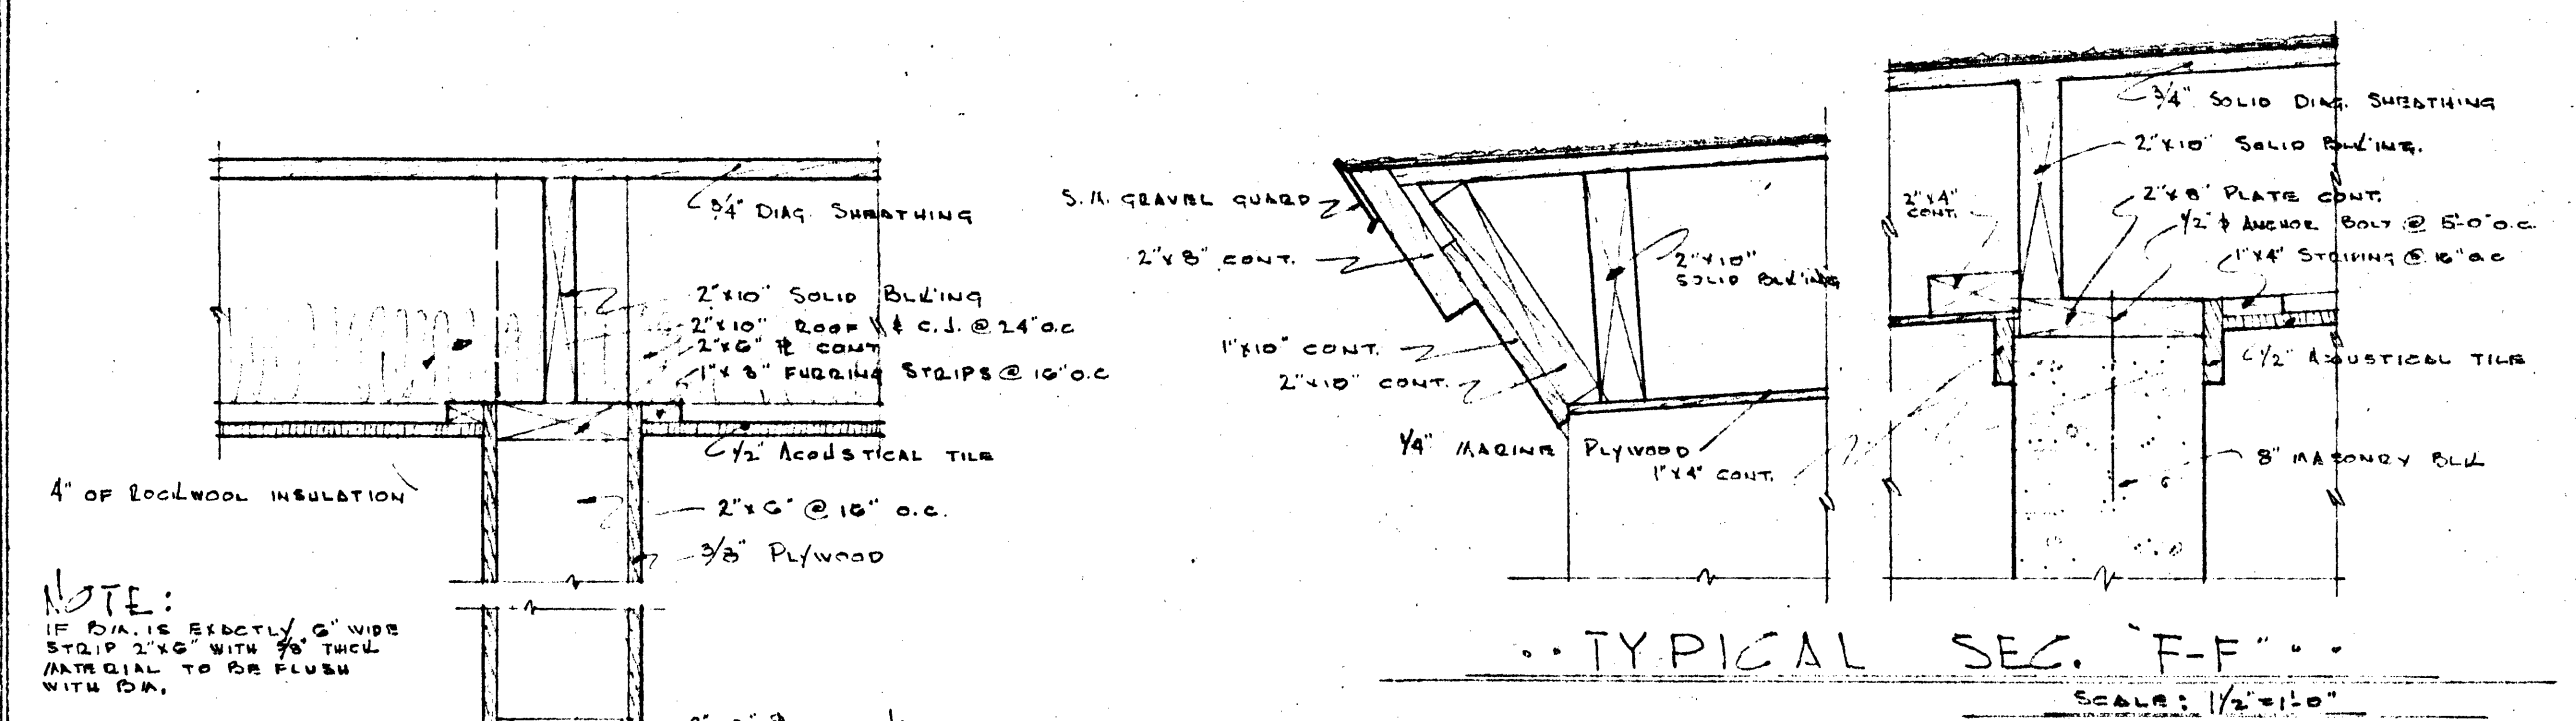


NOTES:
1. COLD WATER PIPING TO BE COPPER TUBING - THICK WALL.
2. NOT ALL PIPING TO BE SHOWN @ ALL CONC. WALL & BLDG WALLS.
3. 20" HIGH AIR CONDENSERS ON ROOF RIMMER.
4. COLD WATER, HOT WATER, GREY WATER.
5. FIRST FLOOR ABOVE TO BE CHILLED WATER.
6. 1" C.P.V.

ARCHITECTURAL DETAILS & PLUMBING PLAN
WALTER ZICK & HARRIS SHARP
ARCHITECTS
LAS VEGAS, NEVADA
FIRE STATION BLDG FOR
CITY OF LAS VEGAS
LAS VEGAS, NEVADA

JOB	DATE
1151	13 NOV. 51

DRAWN	CHECKED
P.J.L.	H.M.S.

SHEET	OF
7	9

REVISIONS: VERIFY ALL DIMENSIONS AT THE SITE