


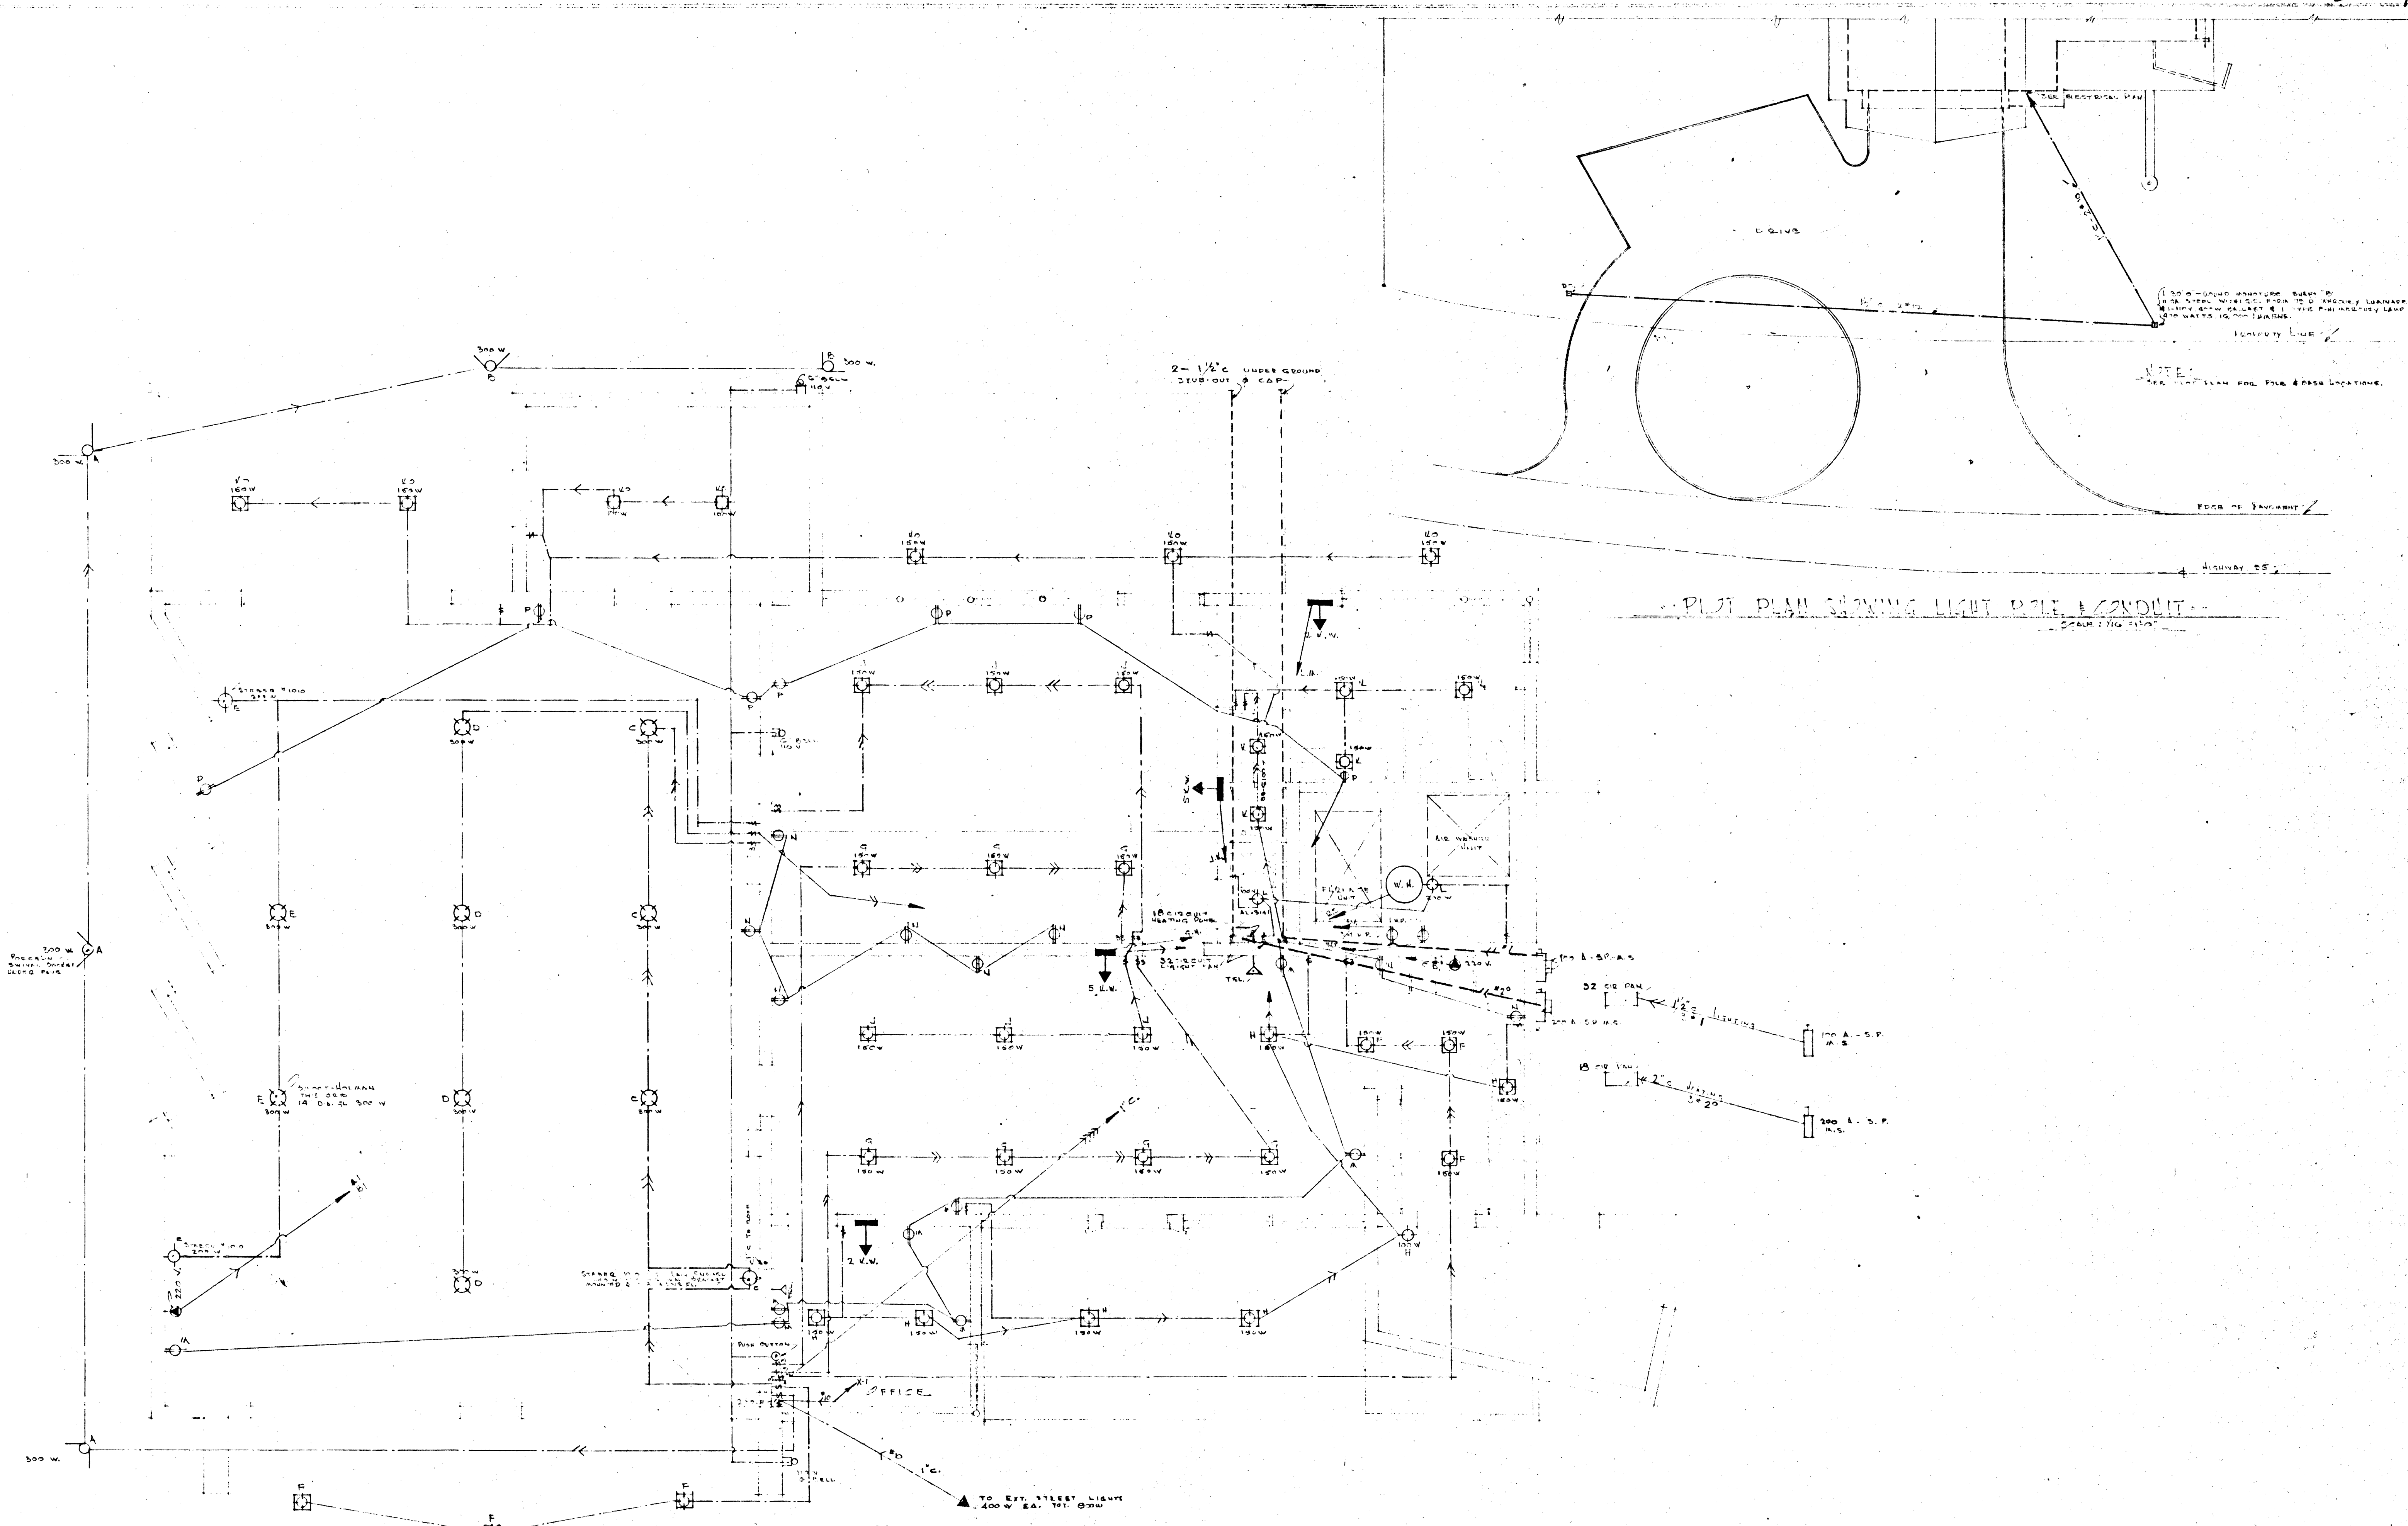

ELECTRICAL LAYOUT

SCALE: 1/4" = 1'-0"

NOTE: ALL LINES LIKE - [Symbol] ARE RESOLITE # 1010, G-10 150 W, UNLESS OTHER WIRE SHOWN. CONTRACTOR TO SUPPLY MAIN SWITCH, METER, SOCKET & WIRETAP HEAD.

ELECTRICAL LAYOUT		SUB	DATE
WALTER ZICK & HARRIS SHARP		1151	13 NOV 51
ARCHITECTS		DRAWN	J.L. & P.J.L.
LAS VEGAS, NEVADA		CHECKED	H.P.S.
FIRE STATION BLDG FOR		SHEET	9
CITY OF LAS VEGAS		OF	9
LAS VEGAS, NEVADA			