
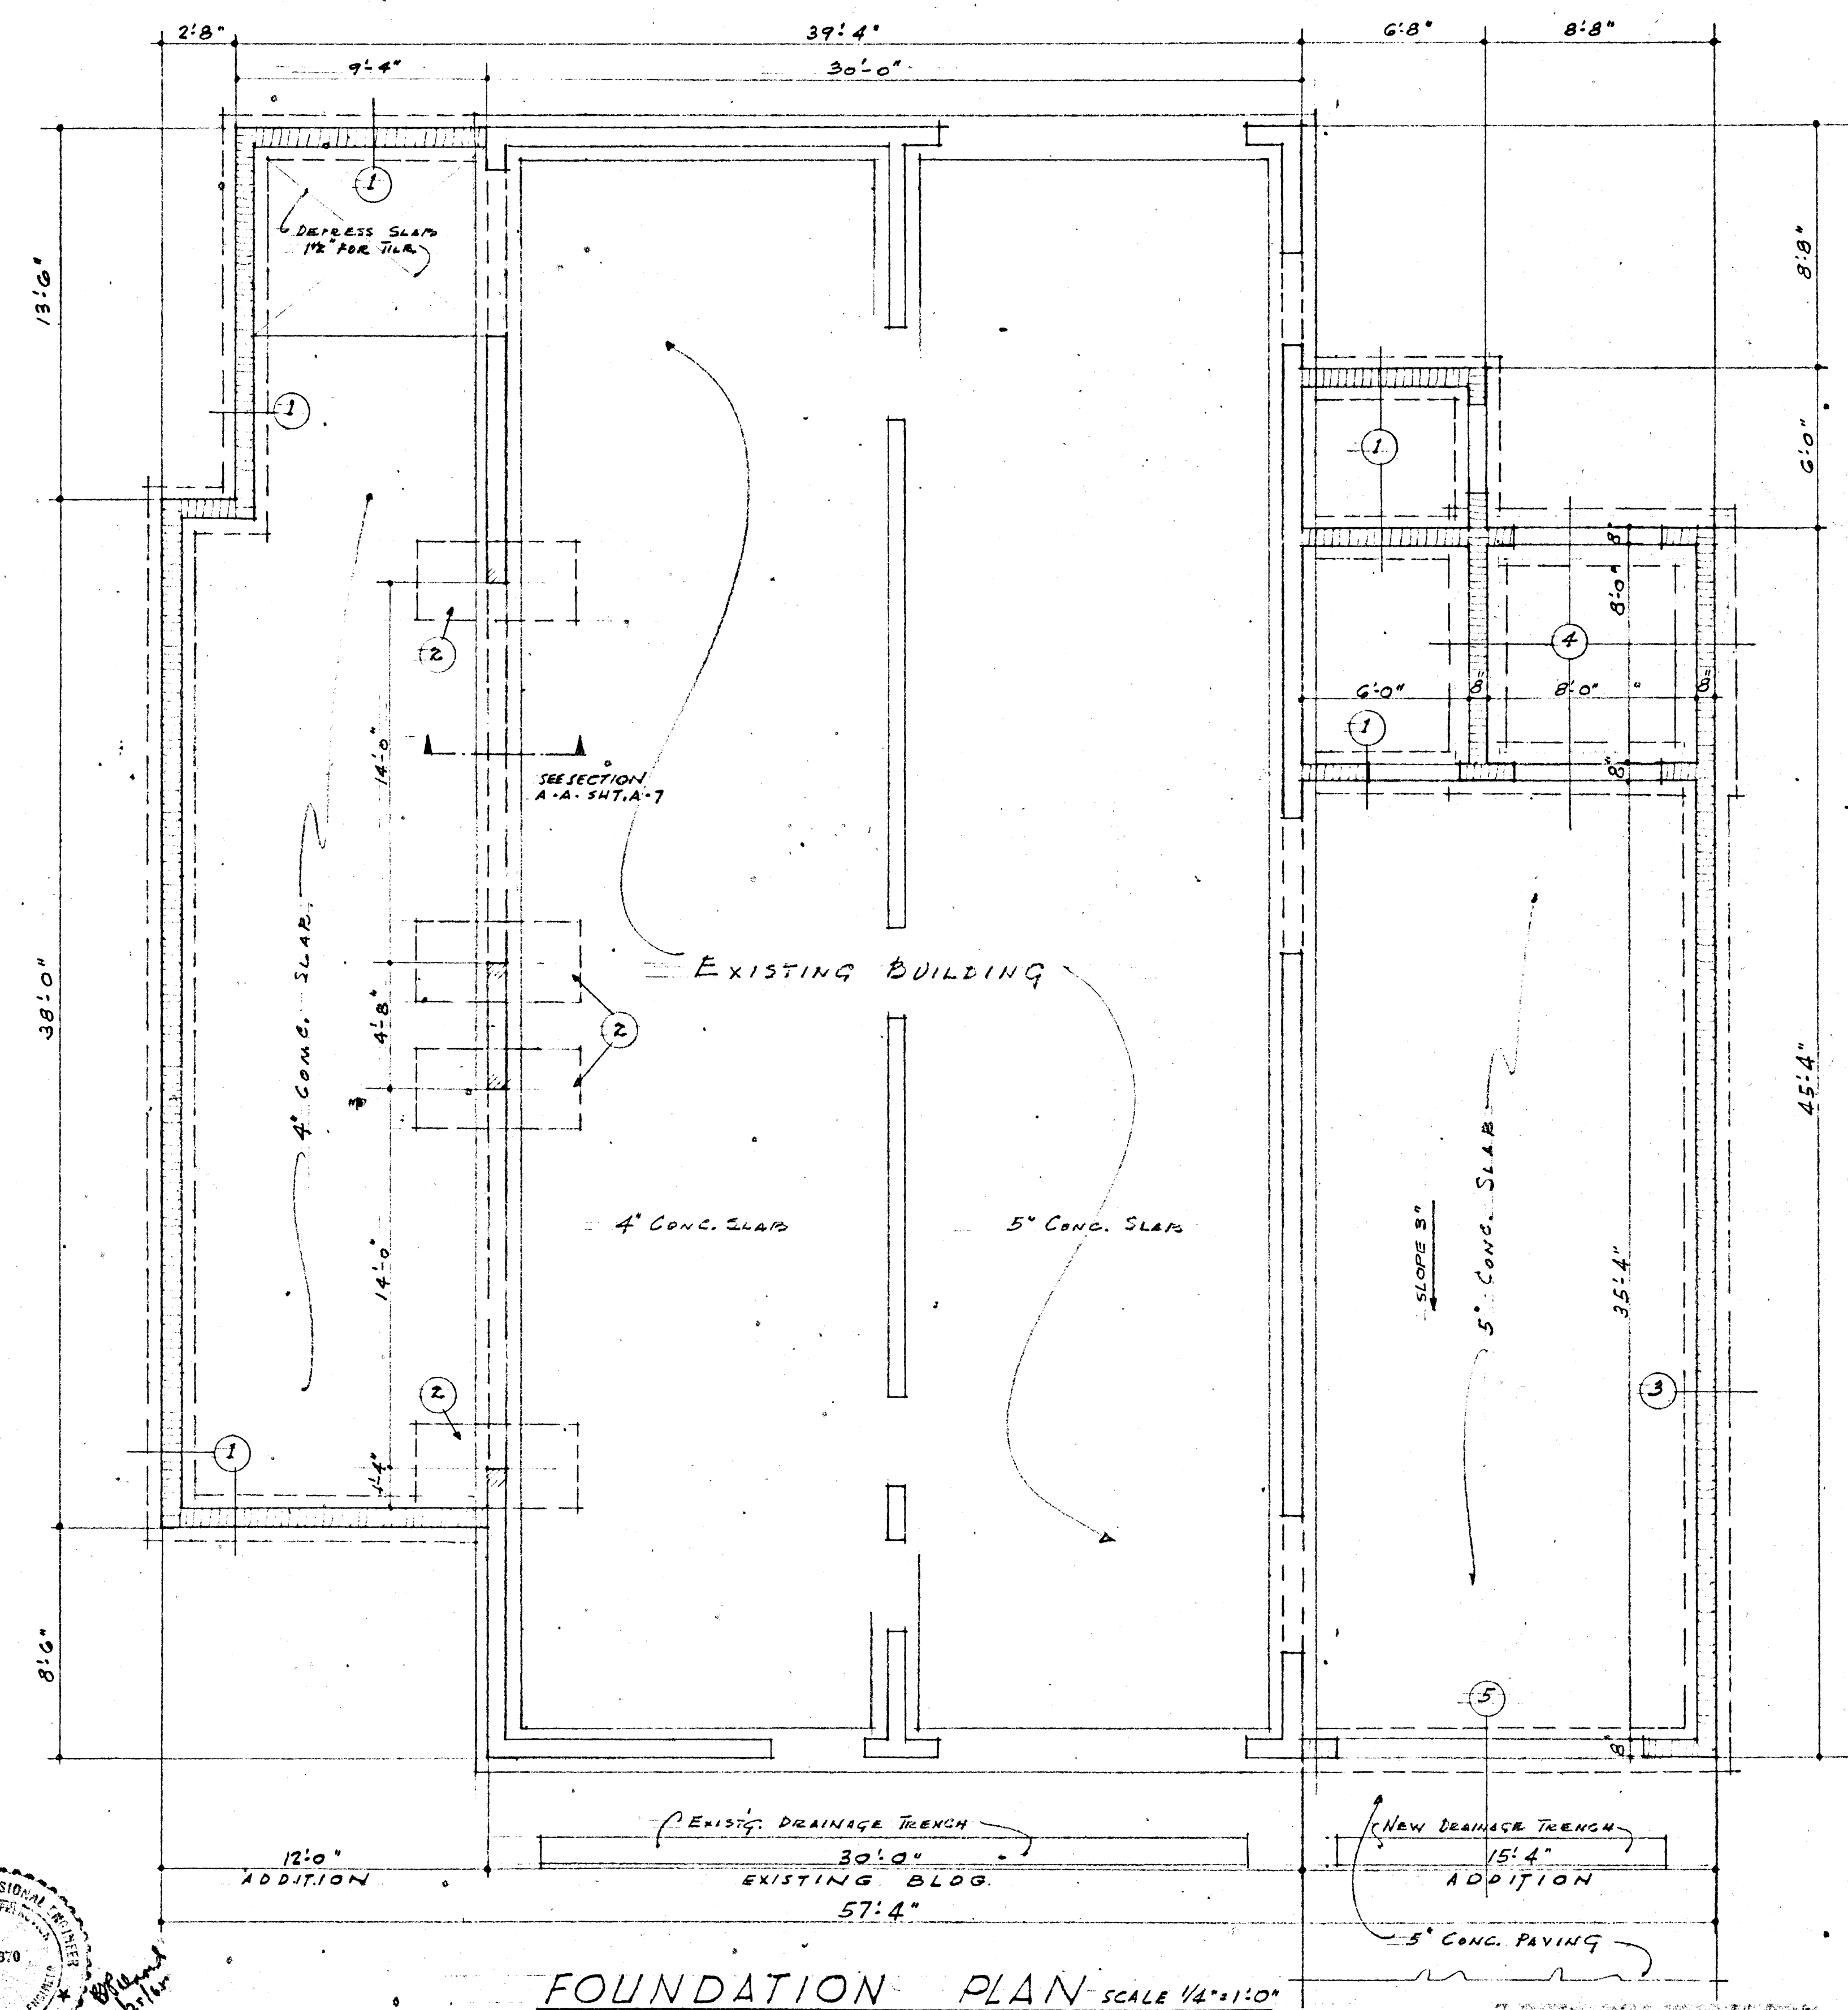


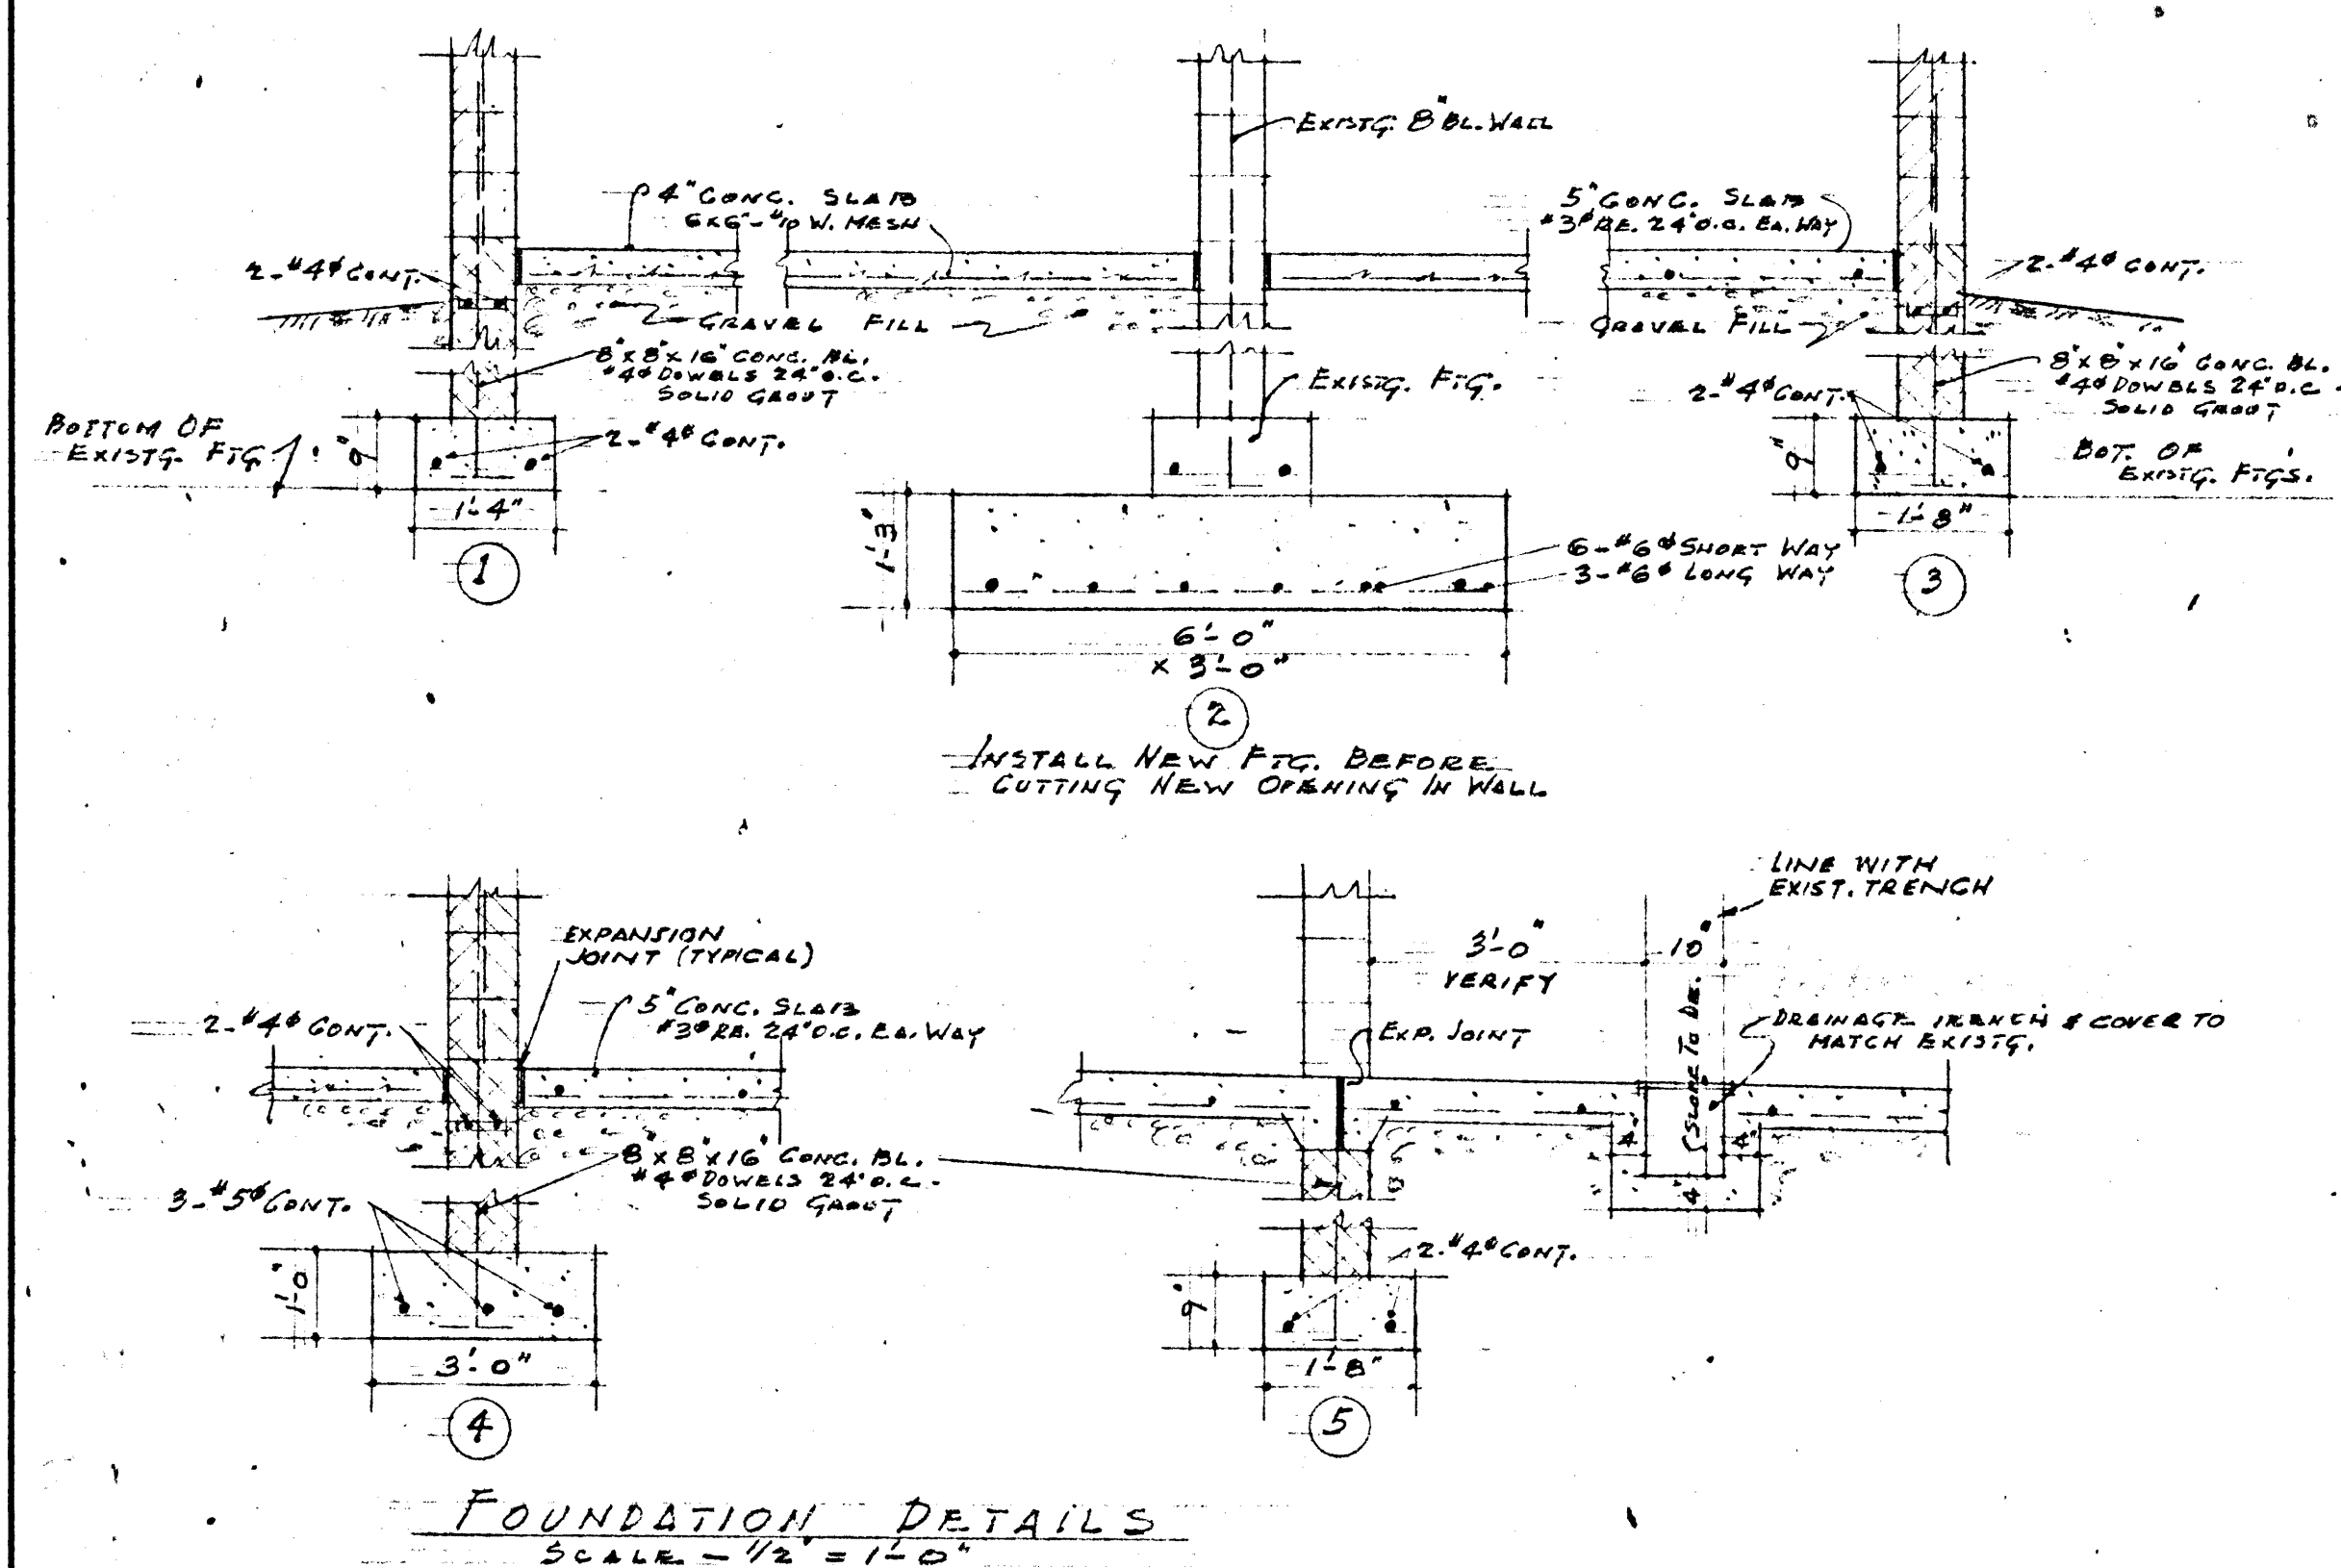

1/25/60

[Signature]
DIRECTOR OF PUBLIC WORKS
[Signature]
CHIEF OF FIRE DEPT

IRA C. MARSHAK EDWARD LEEDS
ARCHITECTS A.I.A.
820 S. SIXTH STREET LAS VEGAS, NEV.

EDWARD LEEDS

VEGAS HEIGHTS, FIRE STATION ADDITION
1201 WEST MILLER STREET
LAS VEGAS, NEVADA

	SHEET TITLE
	FOUNDATION PLAN & DETAILS

DRAWN BY	RBS.
DATE	1-28-65

4 ML-198	REVISIONS	SHEET NO
		A.2 2 OF 12

