


3-13-16

- L. INSULATE OLD & NEW DUCTWORK WITH JOHNS-MANVILLE MICROWITE NO. B-305 - 1" THICK SECURED WITH WIRE AT 12" O.C. WEATHER-PROOF ALL EXPOSED DUCT TO O.S.A.
- M. DUCTWORK SHALL BE PER LATEST STANDARDS OF THE A.S.H. & A.C.E.
- N. HEATER VENTS SHALL BE AMERIVENT PIPE & AMERIVENT CAPS & FLASHING ALL NBFU APPROVED.
- O. PROVIDE BALANCING DAMPERS IN ALL ACCESSIBLE BRANCH DUCTS.
- P. PROVIDE CANVAS CONNECTIONS OF 8 OZ. SIZE ON ALL EQUIPMENT INTAKES & DISCHARGES TO DUCTWORK.
- Q. REFRIGERANT PIPING SHALL BE COPPER REFRIG. SERVICE TYPE.
- R. INSTALL ALL EQUIPMENT AS PER MANUFACTURERS' INSTRUCTIONS.
- S. RANGE EXHAUST FAN - JENM - AIR, NO. 9/CIV, WALL TYPE 1/2 HPS VOLT 1 PH. 60 CYC. PROVIDE ROUND DUCT THRU WALL TO FAN. TO EXHAUST 400 CFM @ 1/2" S.P.
- T. REMOVE ALL EXISTING UNUSED AIR DUCTS. CAP ENDS OF USED PORTION OF EXIST DUCT.
- U. DUCTS & VENTS OR FLUES GOING THRU TILE ROOF SHALL BE FLASHED WITH 4LB. LEAD SHEETING AS MFGD. BY DOW CHEMICAL CO.
- V. LOCATE THERMOSTATS 52" ABOVE FLOOR.

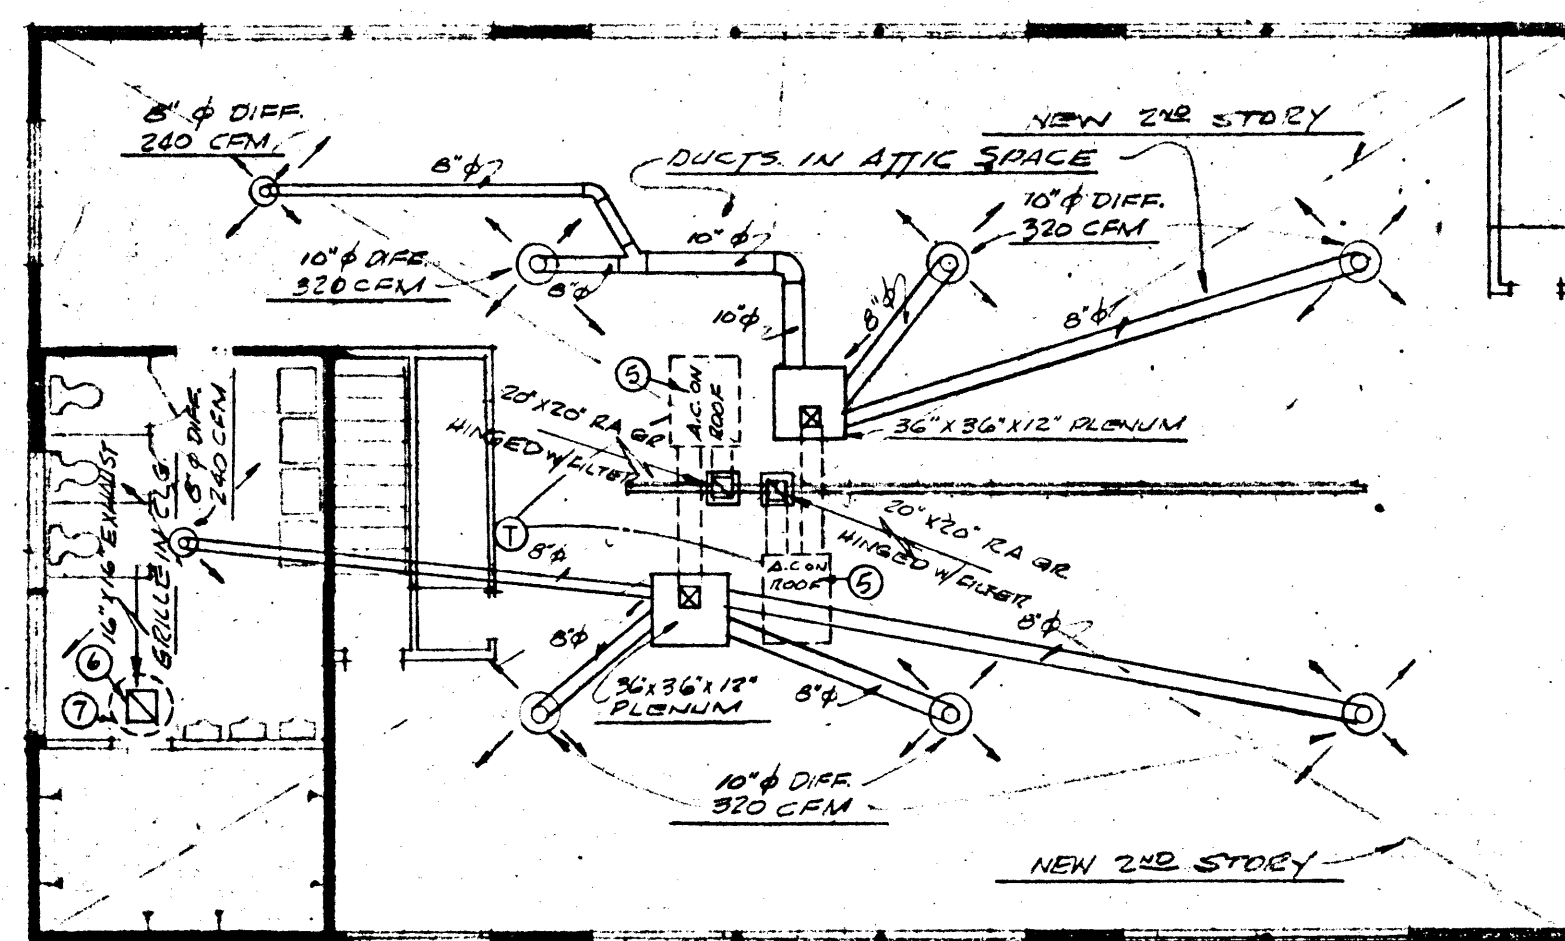

HEATING & AIR CONDITIONING
SECOND FLOOR PLAN 1/8" = 1'-0"



KNIGHTON & MC DANIEL ARCHITECTS 2032 EAST CHARLESTON BLVD. • LAS VEGAS, NEVADA DU 4-4725	
K	M
SHEET TITLE: HEATING & A.C. PLANS JOB TITLE: ALUMINATION & ADDITION TO CENTRAL FIRE STATION OWNER: CITY OF LAS VEGAS ADDRESS: LAS VEGAS, NEVADA	
JOB NUMBER: C 124	
REVISIONS 1 2 3 4 5 6 7 8	
DRAWN BY: PH CHECKED: 10 DATE: 7/27/60 SHEET: 1	
M 3 OF 23	