



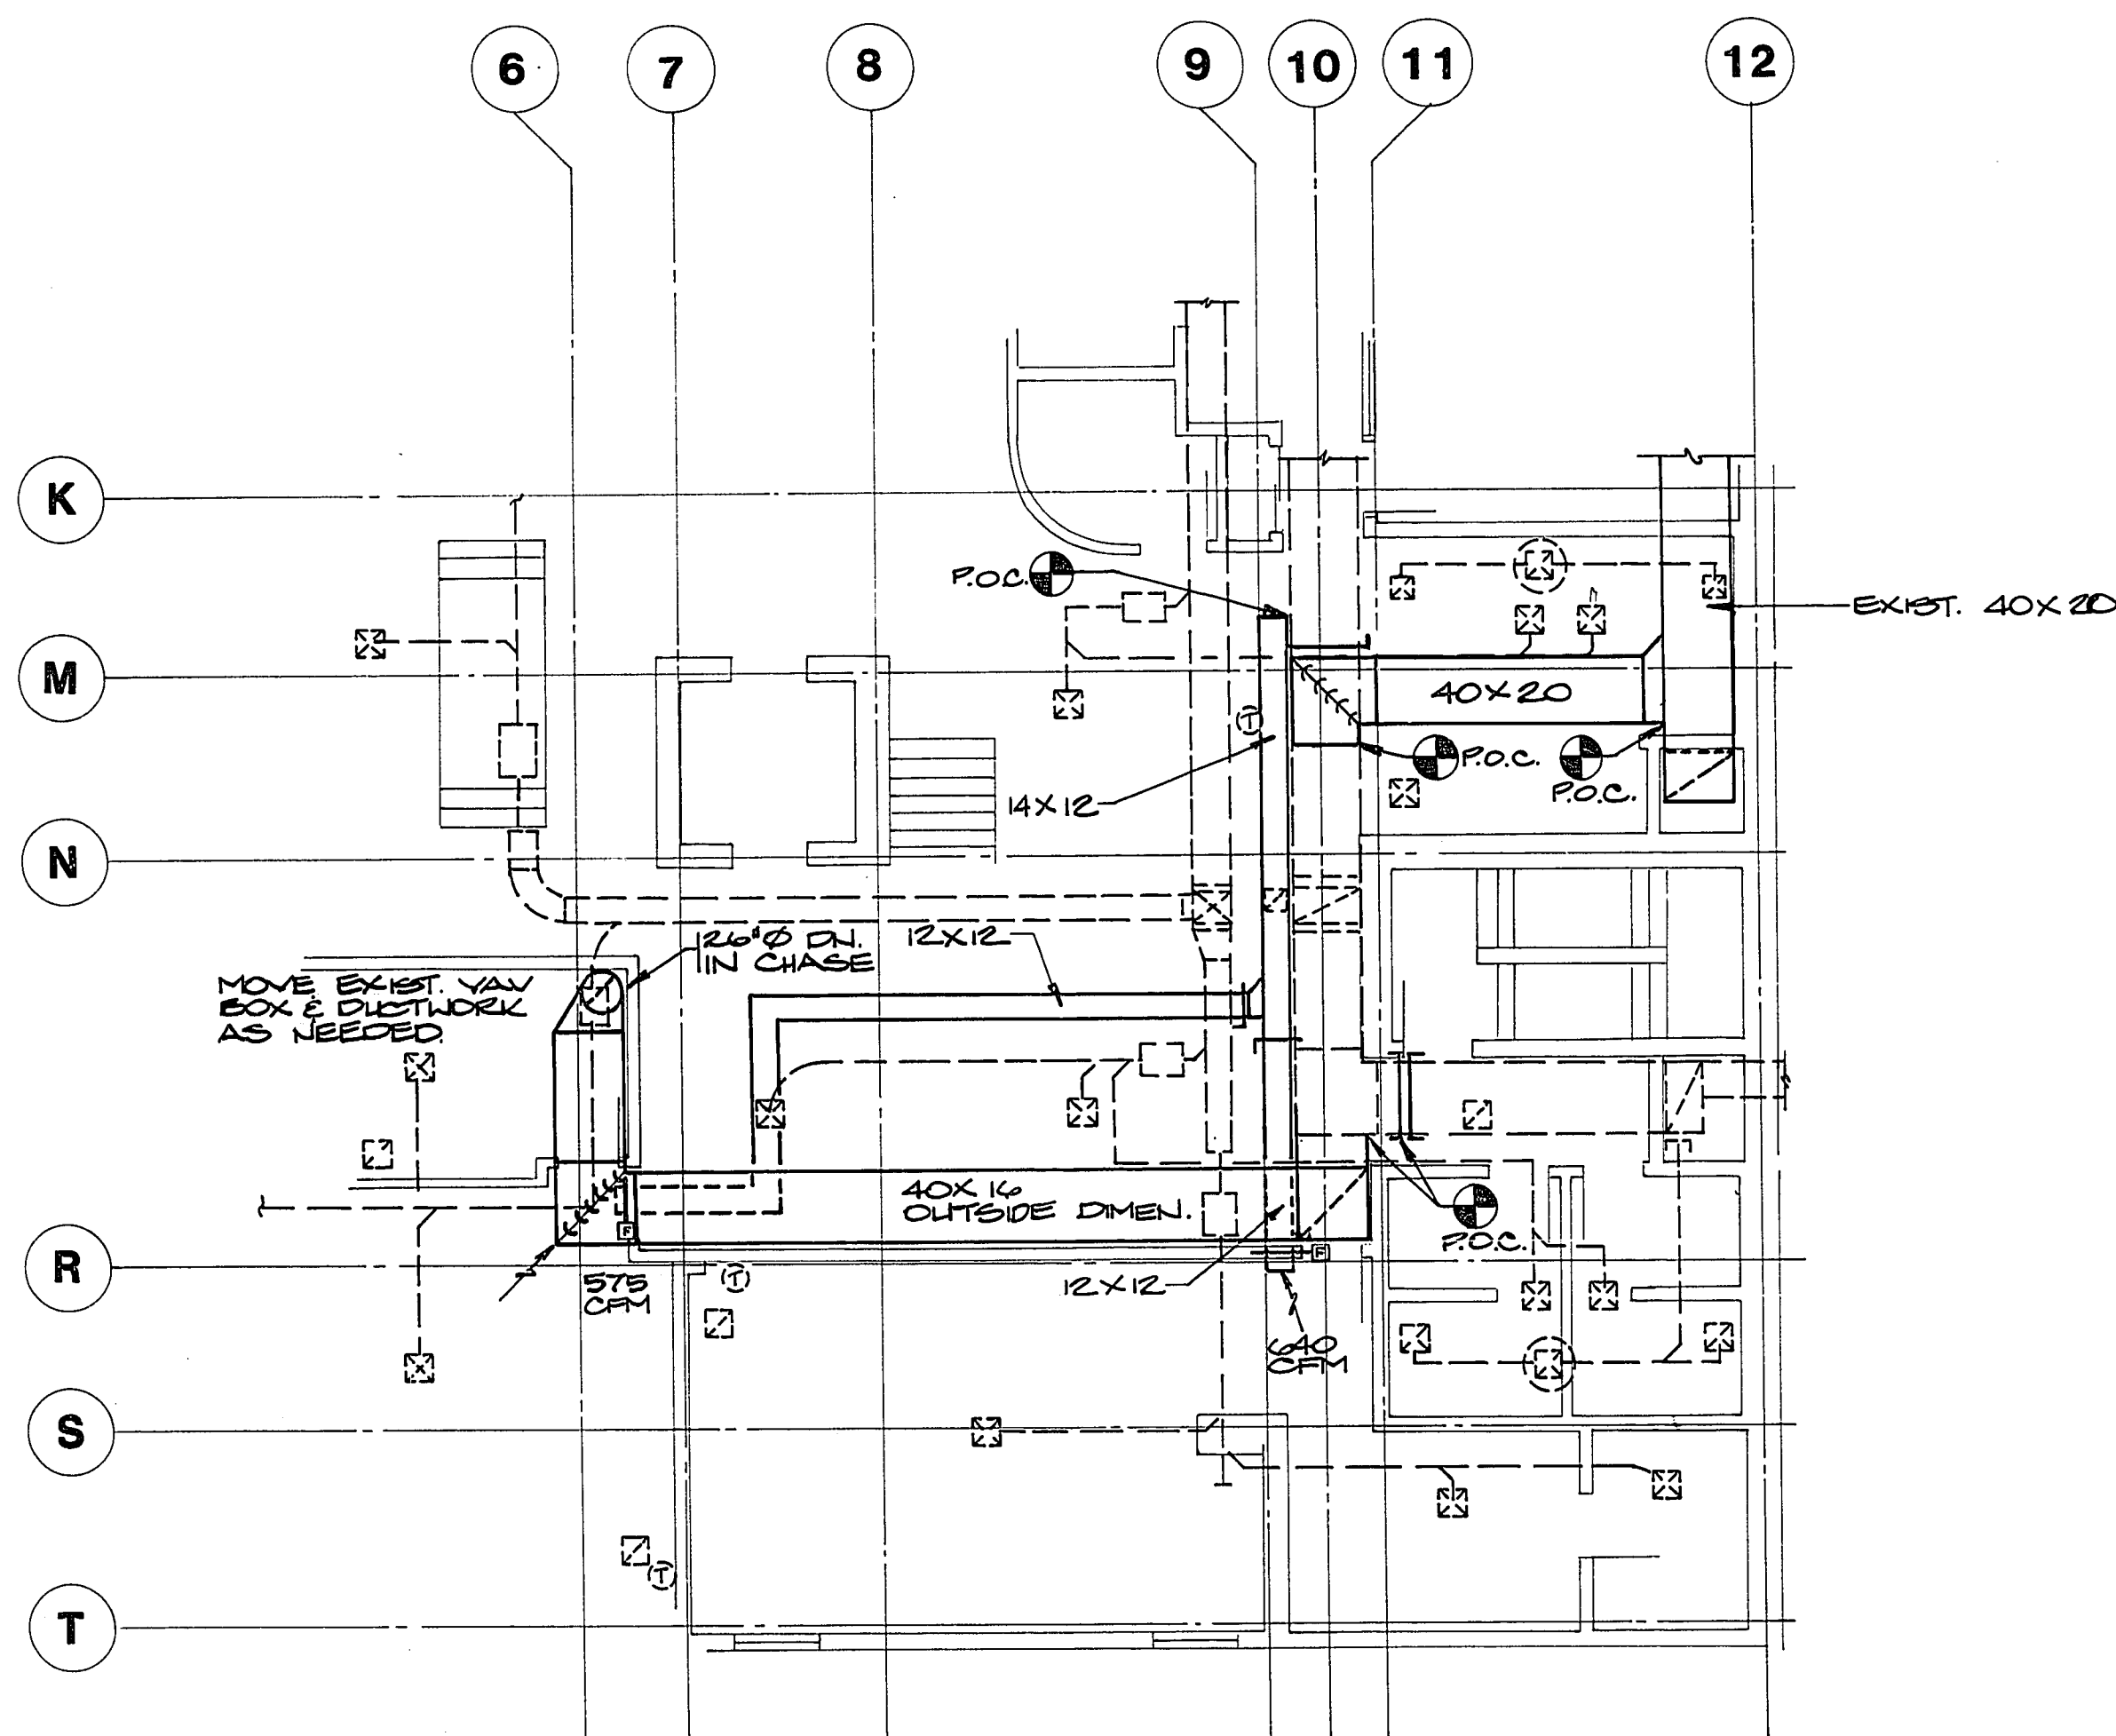

SECOND LEVEL

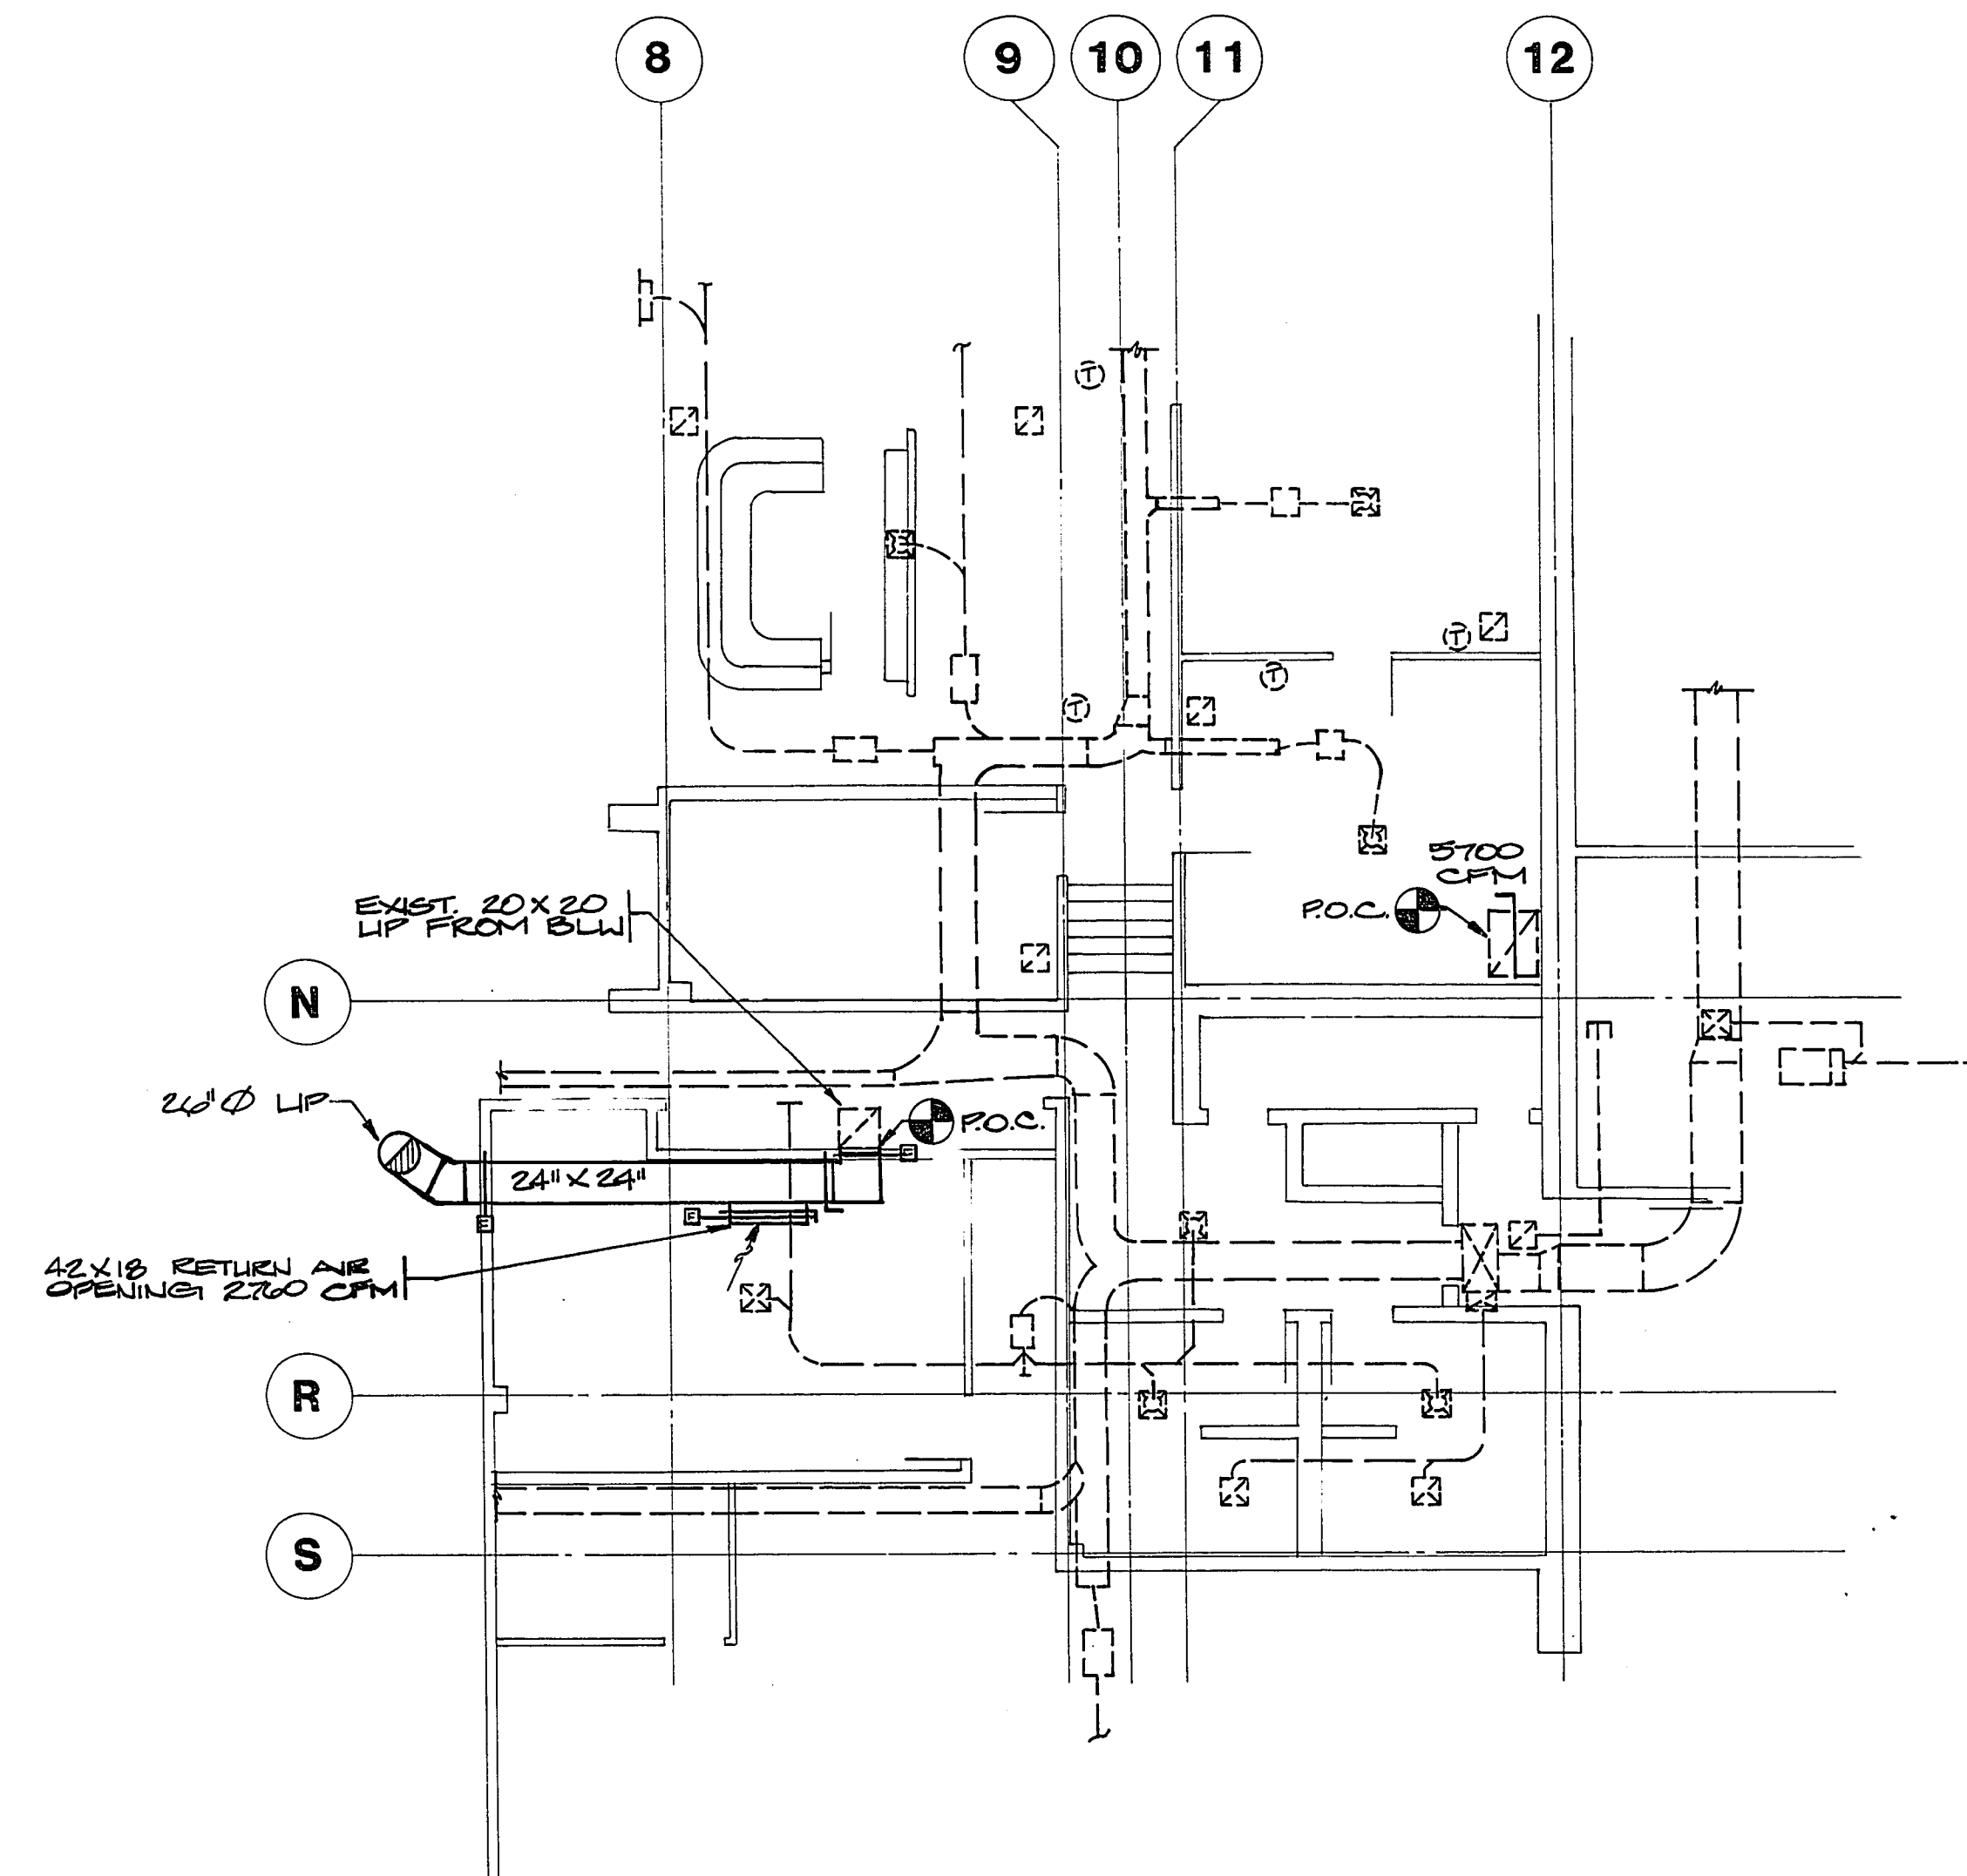

PLAZA LEVEL

revised Description Refer to Tracing for Latest Revision		Submit App'd Date	Reference Information and Notes: P.O.C. - POINT OF CONNECTION TO EXISTING NOTE: CONTRACTOR WILL FIELD VERIFY CLEARANCES AND DUCT ROUTING PRIOR TO SUBMITTING CHANGE ORDER.	Designed CRM Drawn AVM Checked CRM Date 3/28/91	REVISED MECHANICAL PLAN Kennedy/Jenks/Chilton Reno, Nevada	FIRE STATION #1 HVAC REMODEL LAS VEGAS, NEVADA	1/8" = 1'-0" Job No. 91026 Sheet R-1 of 6
--	--	-------------------------	---	--	---	---	--

4-215
630-740