
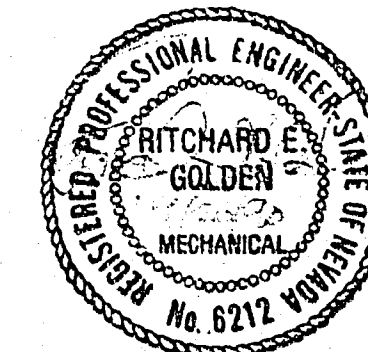
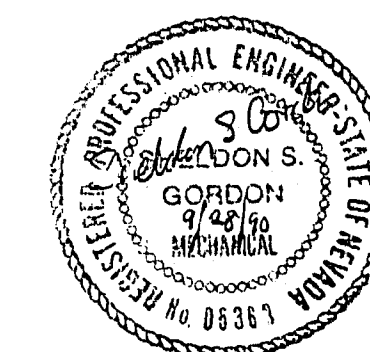


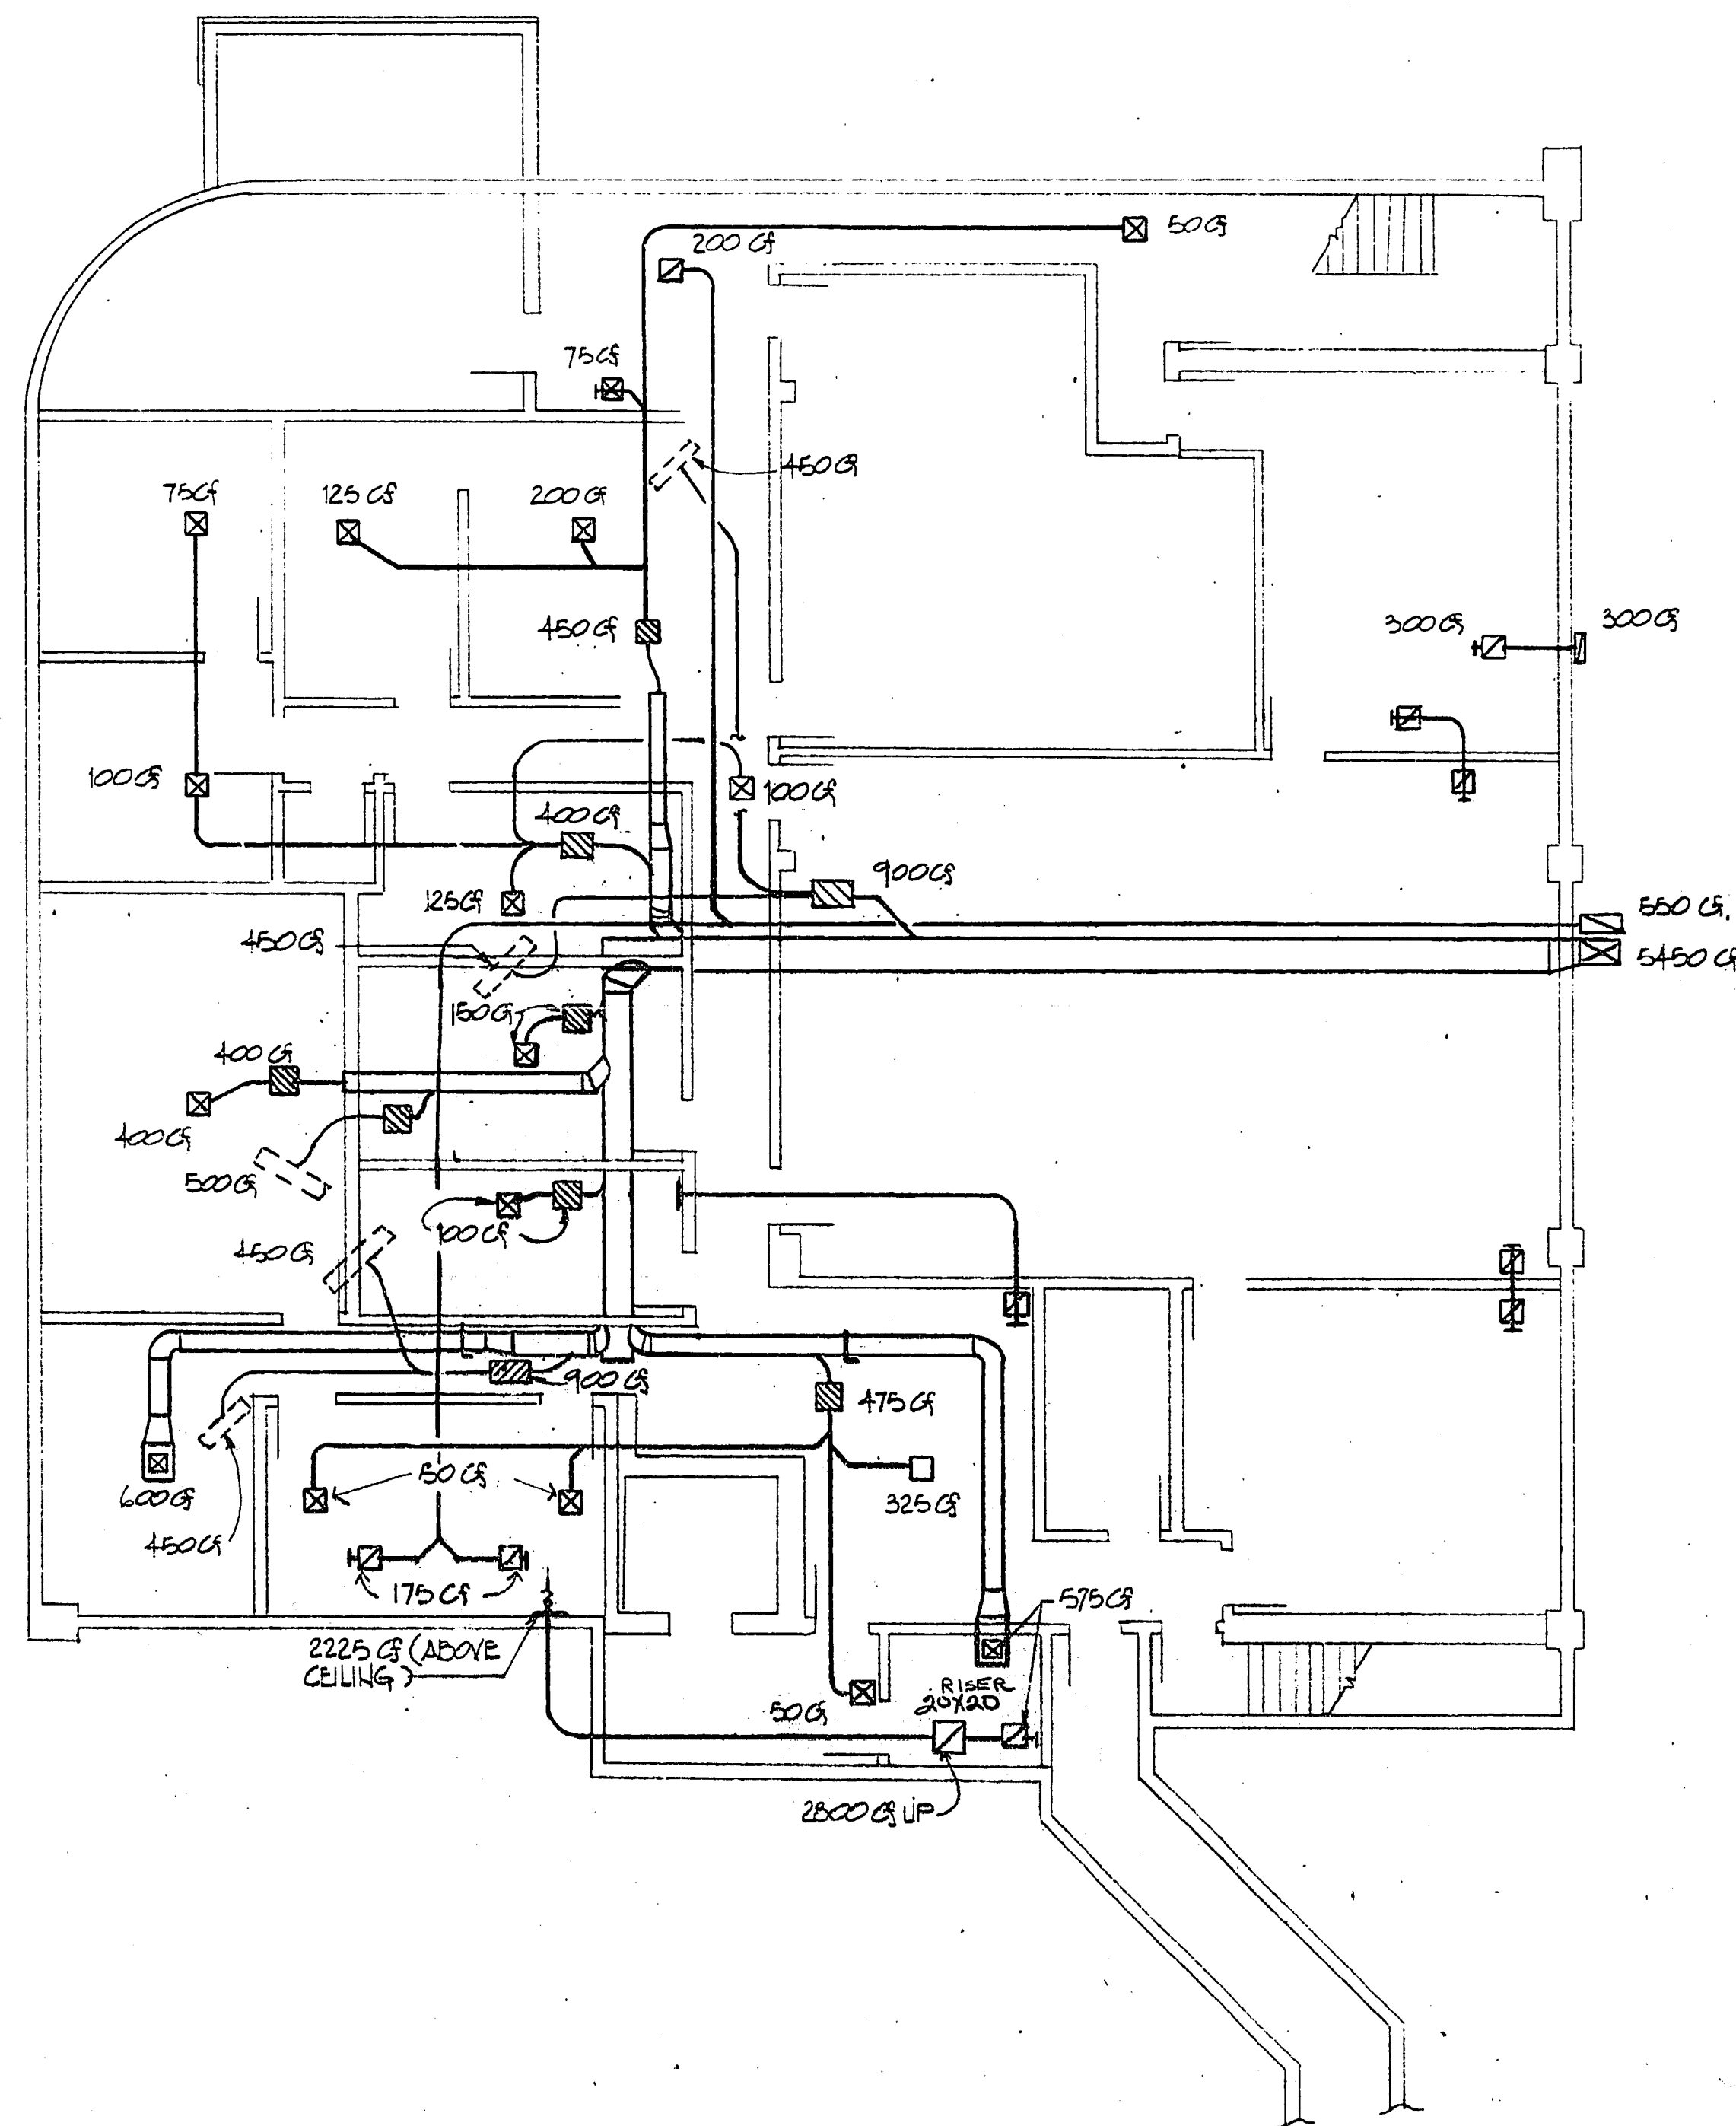

Revised	Description	Submit	App'd	Date
Refer to Tracing for Latest Revision				

Reference Information and Notes:

Designed
REG
Drawn
RS
Checked
REG
Date
9/25/90

COMMUNICATION LEVEL FLOOR PLAN

Kennedy/Jenks/Chilton

Reno, Nevada

Submitted:

Approved:

**FIRE STATION #1
HVAC REMODEL
LAS VEGAS, NEV.**

Scale
1/8"=1'-0"
Job No.
Sheet 5
M-5
of 6

630-74C

4-214