
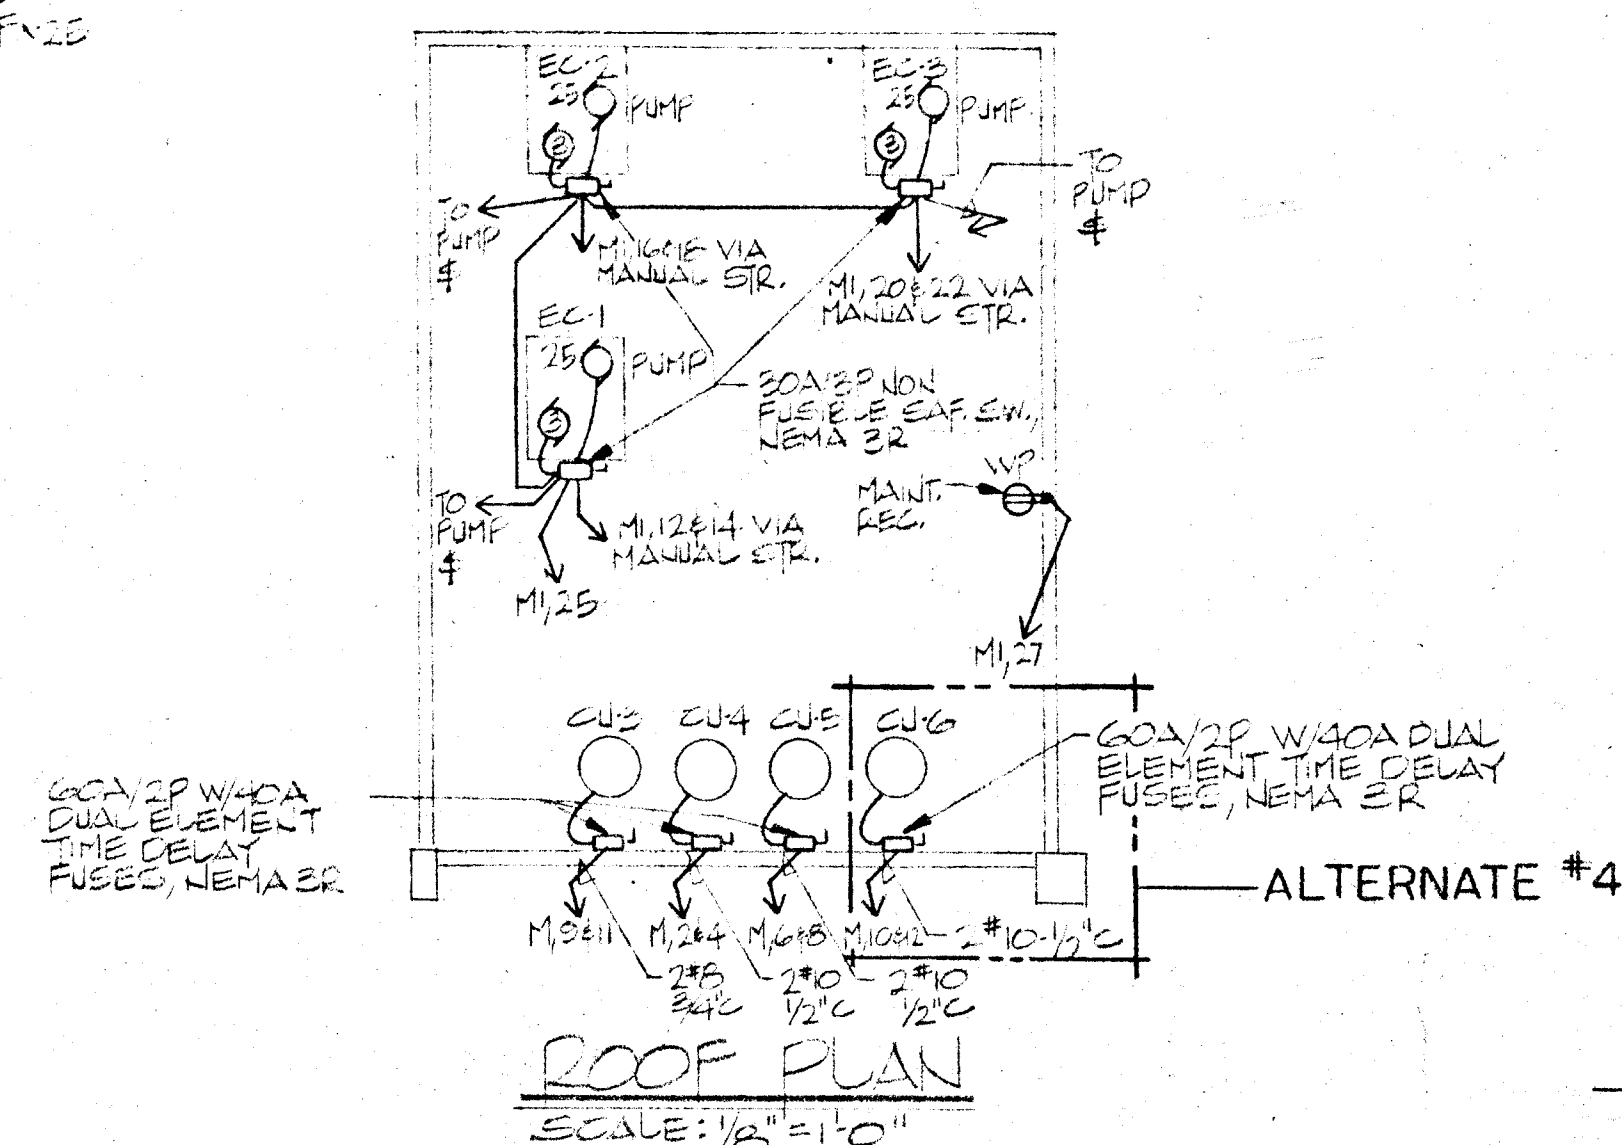
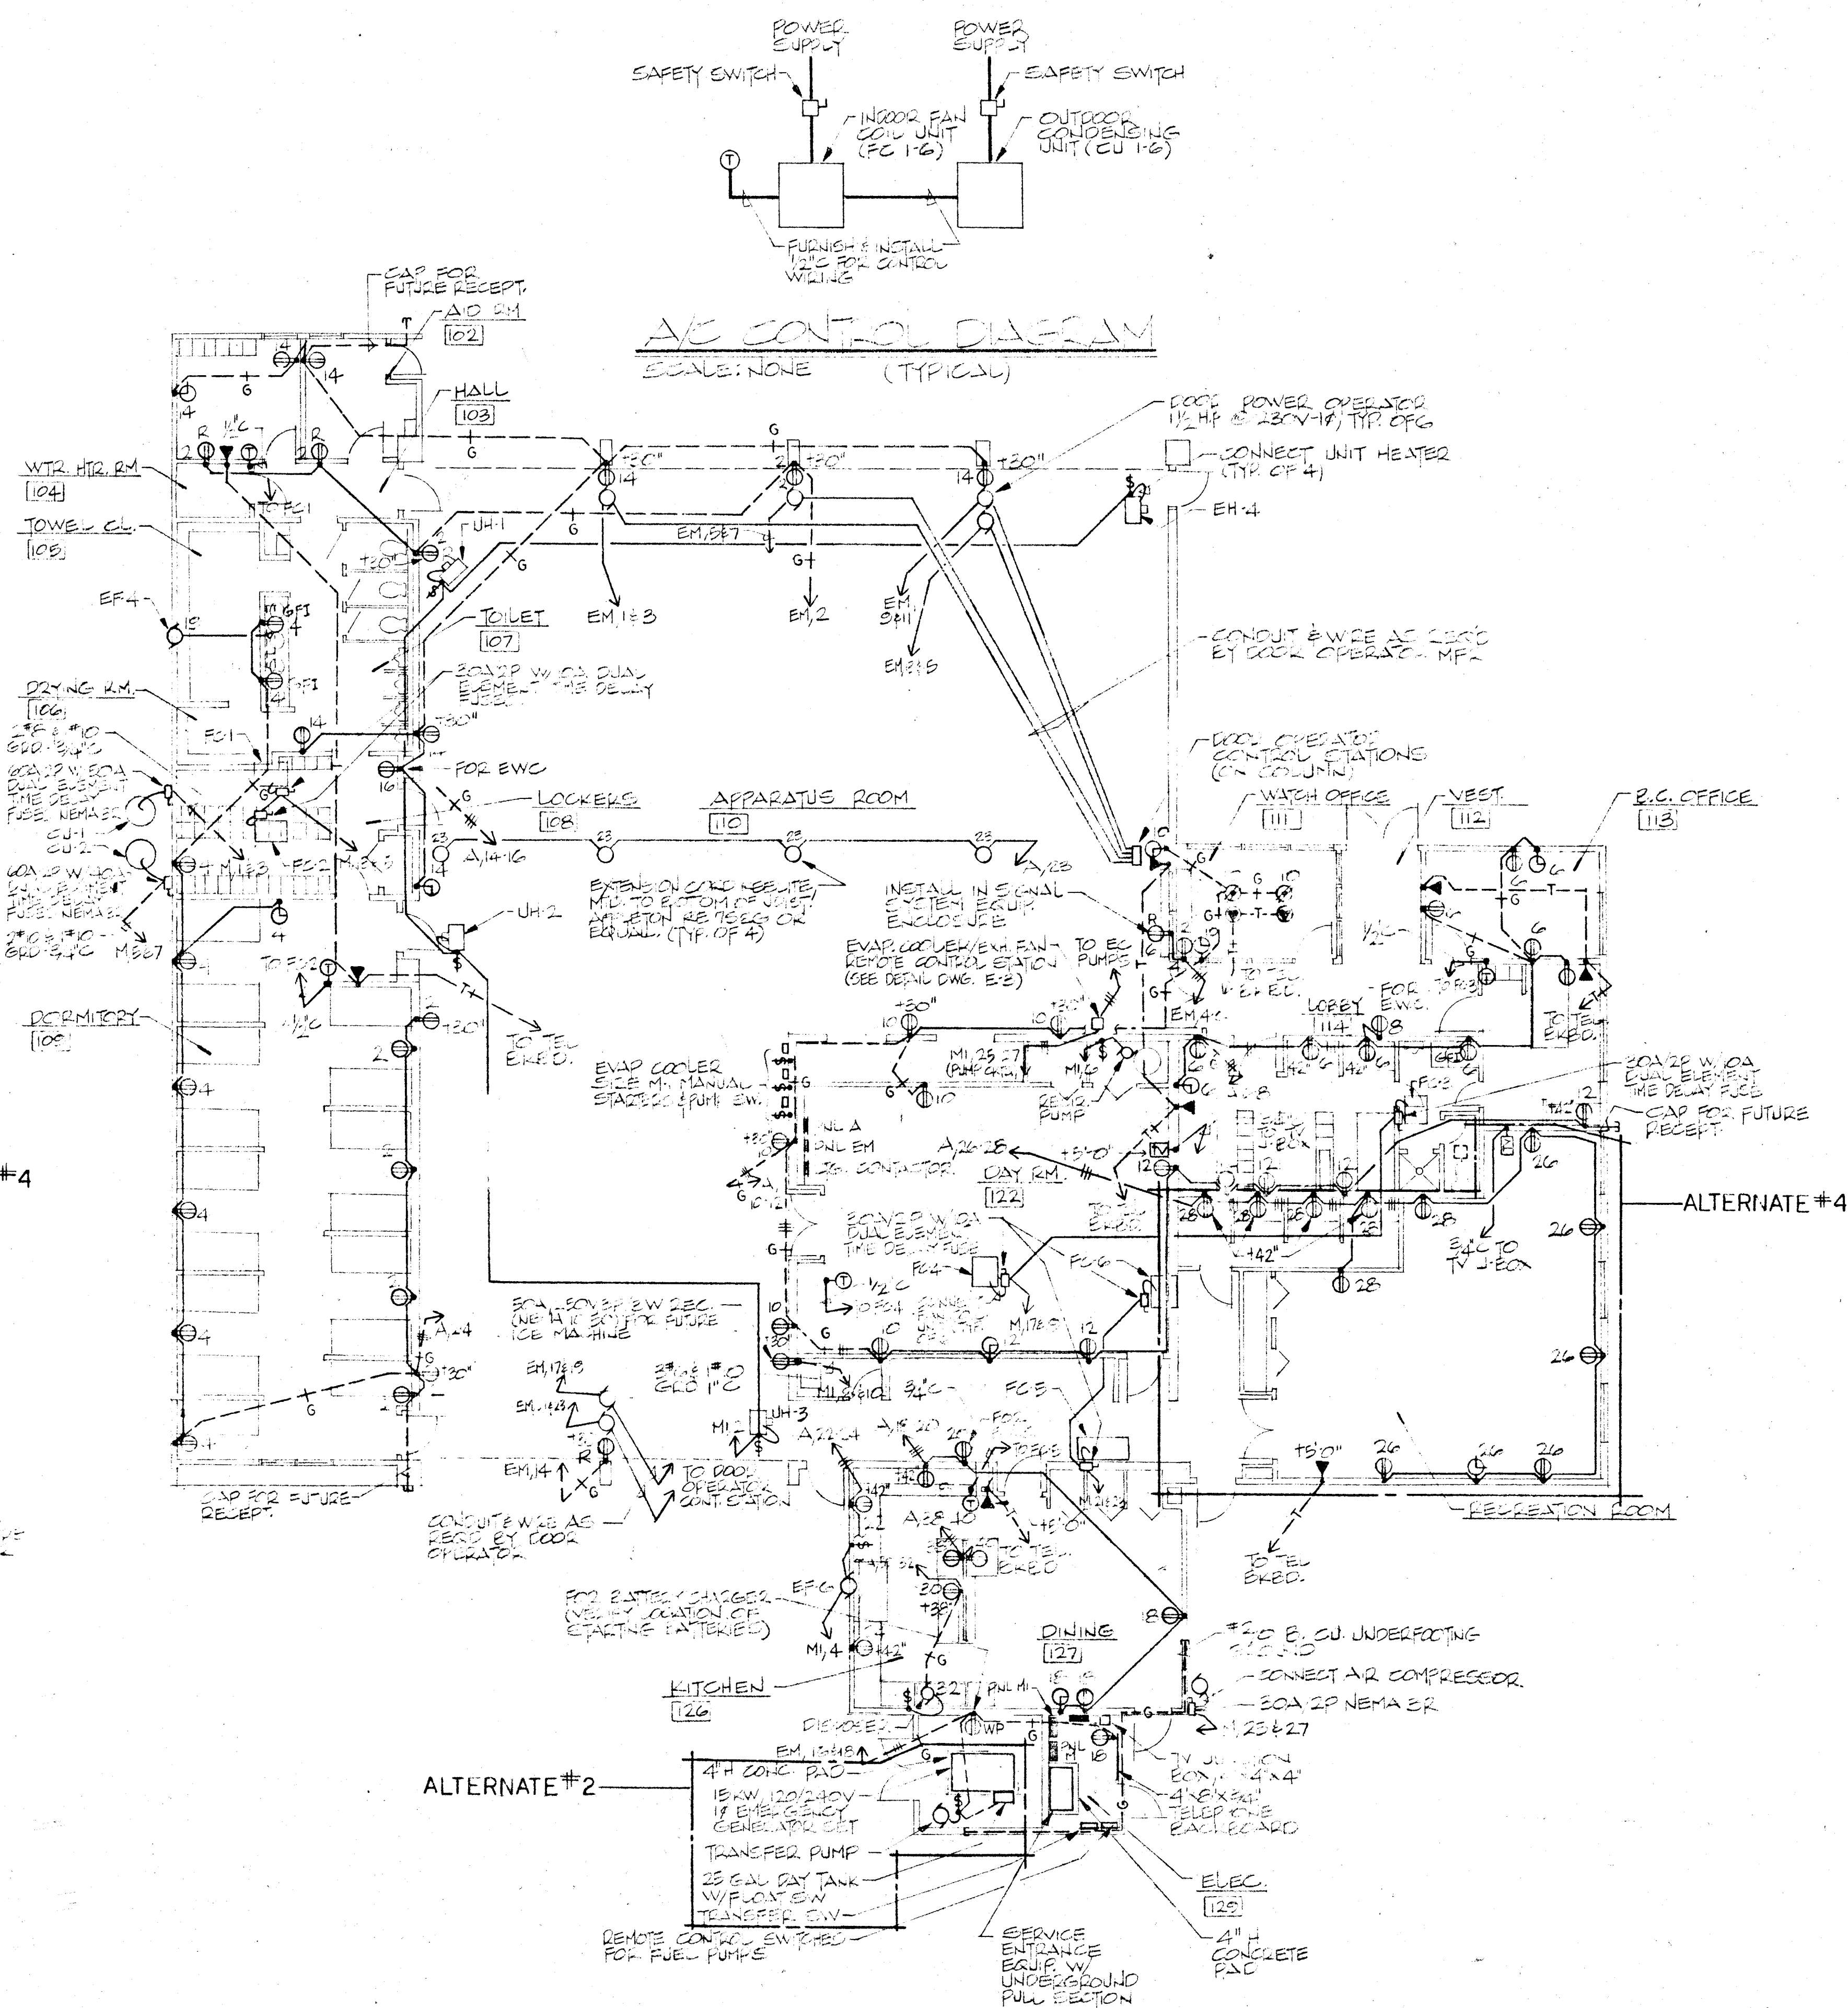


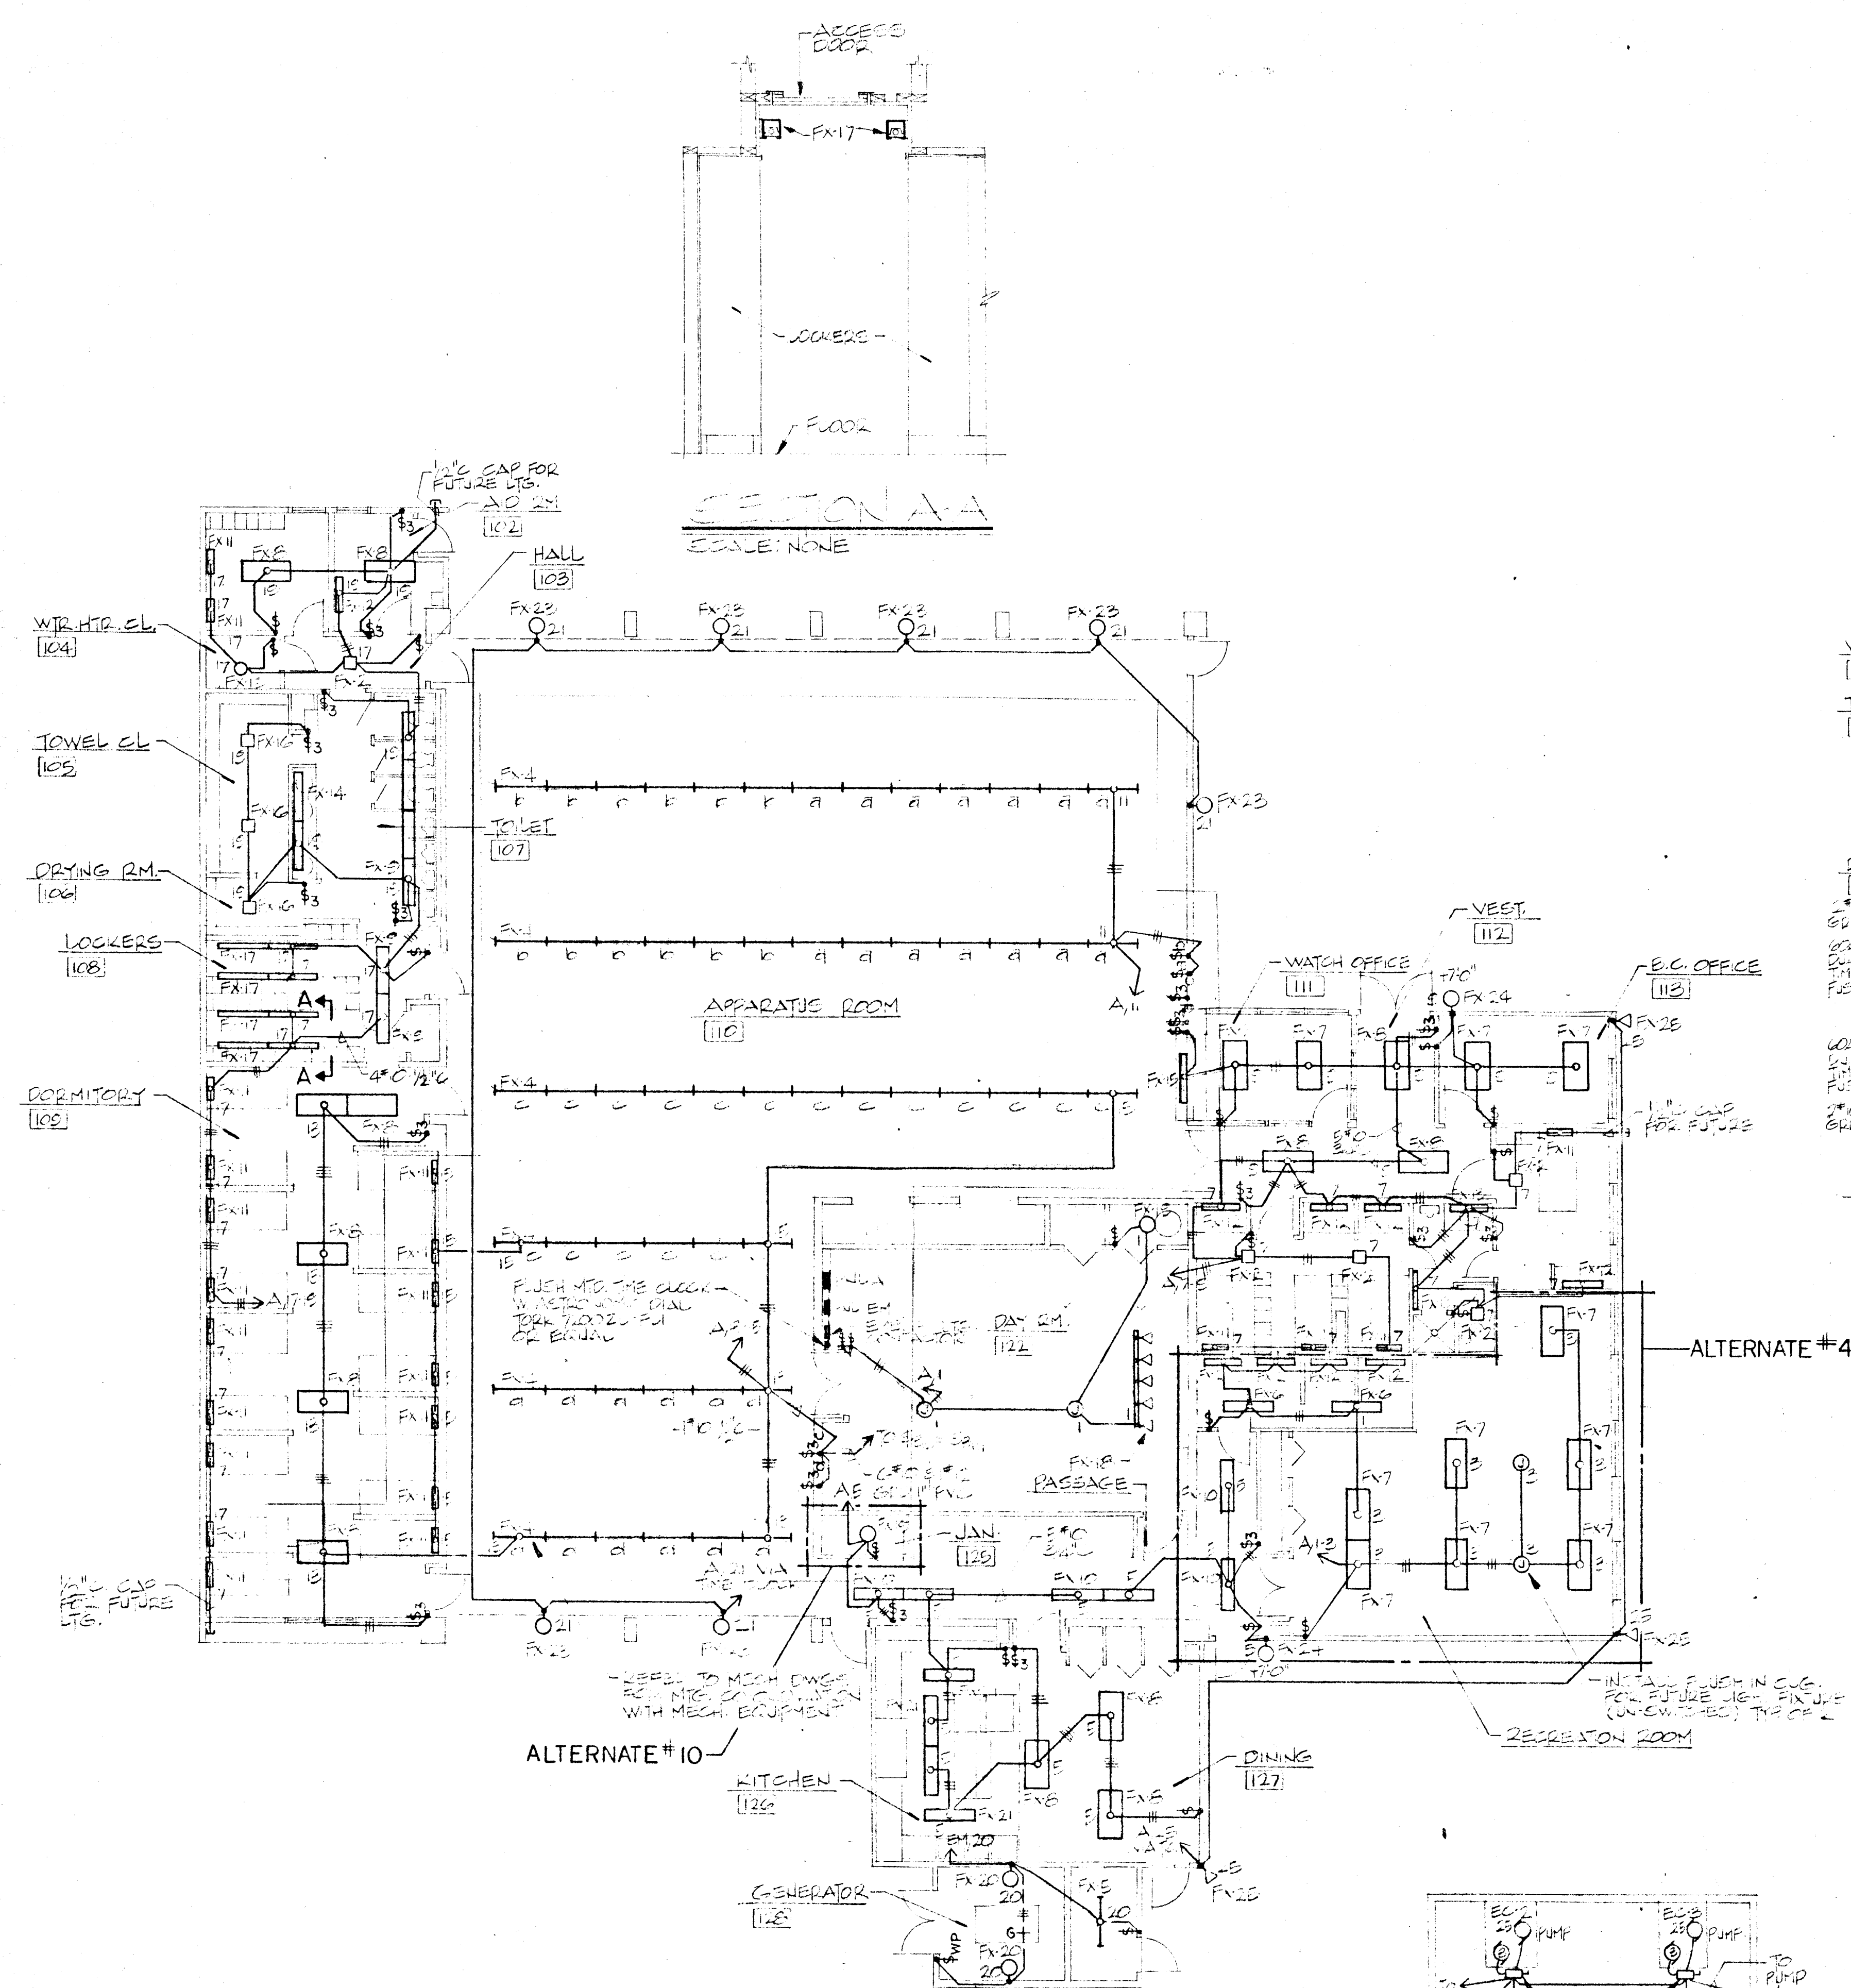

GROUND FLOOR PLAN - LIGHTING
SCALE: 1/8" = 1'-0"

GROUND FLOOR PLAN-POWER
SCALE: 1/8"=1'-0"

7LA 064

[illegible]

data: 198507 no. 0015
drawn by: F. G.
approved:
checked by: P. H. / H. W.

nevada architrionics
 david f. wellen · john c. mavers · gerald m. moffitt
 a e r o h i t e c t s
 800 s. rancho drive · (702) 870-6448 · las vegas, nevada 89106



Sheet title: ELECTRICAL - FLOOR PLANS
LIGHTING & POWER

BASE BID

Project: CITY OF LAS VEGAS
FIRE STATION NO. 7

sheet no.

E-2A

of :