
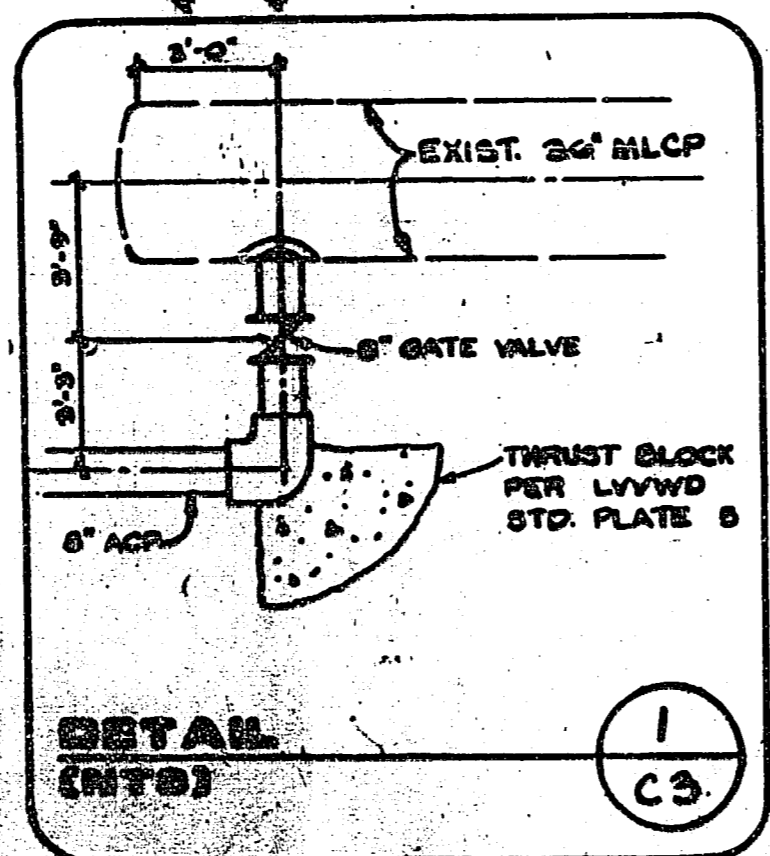


STA. 7+07.84 MATCHLINE SEE SHEET C4

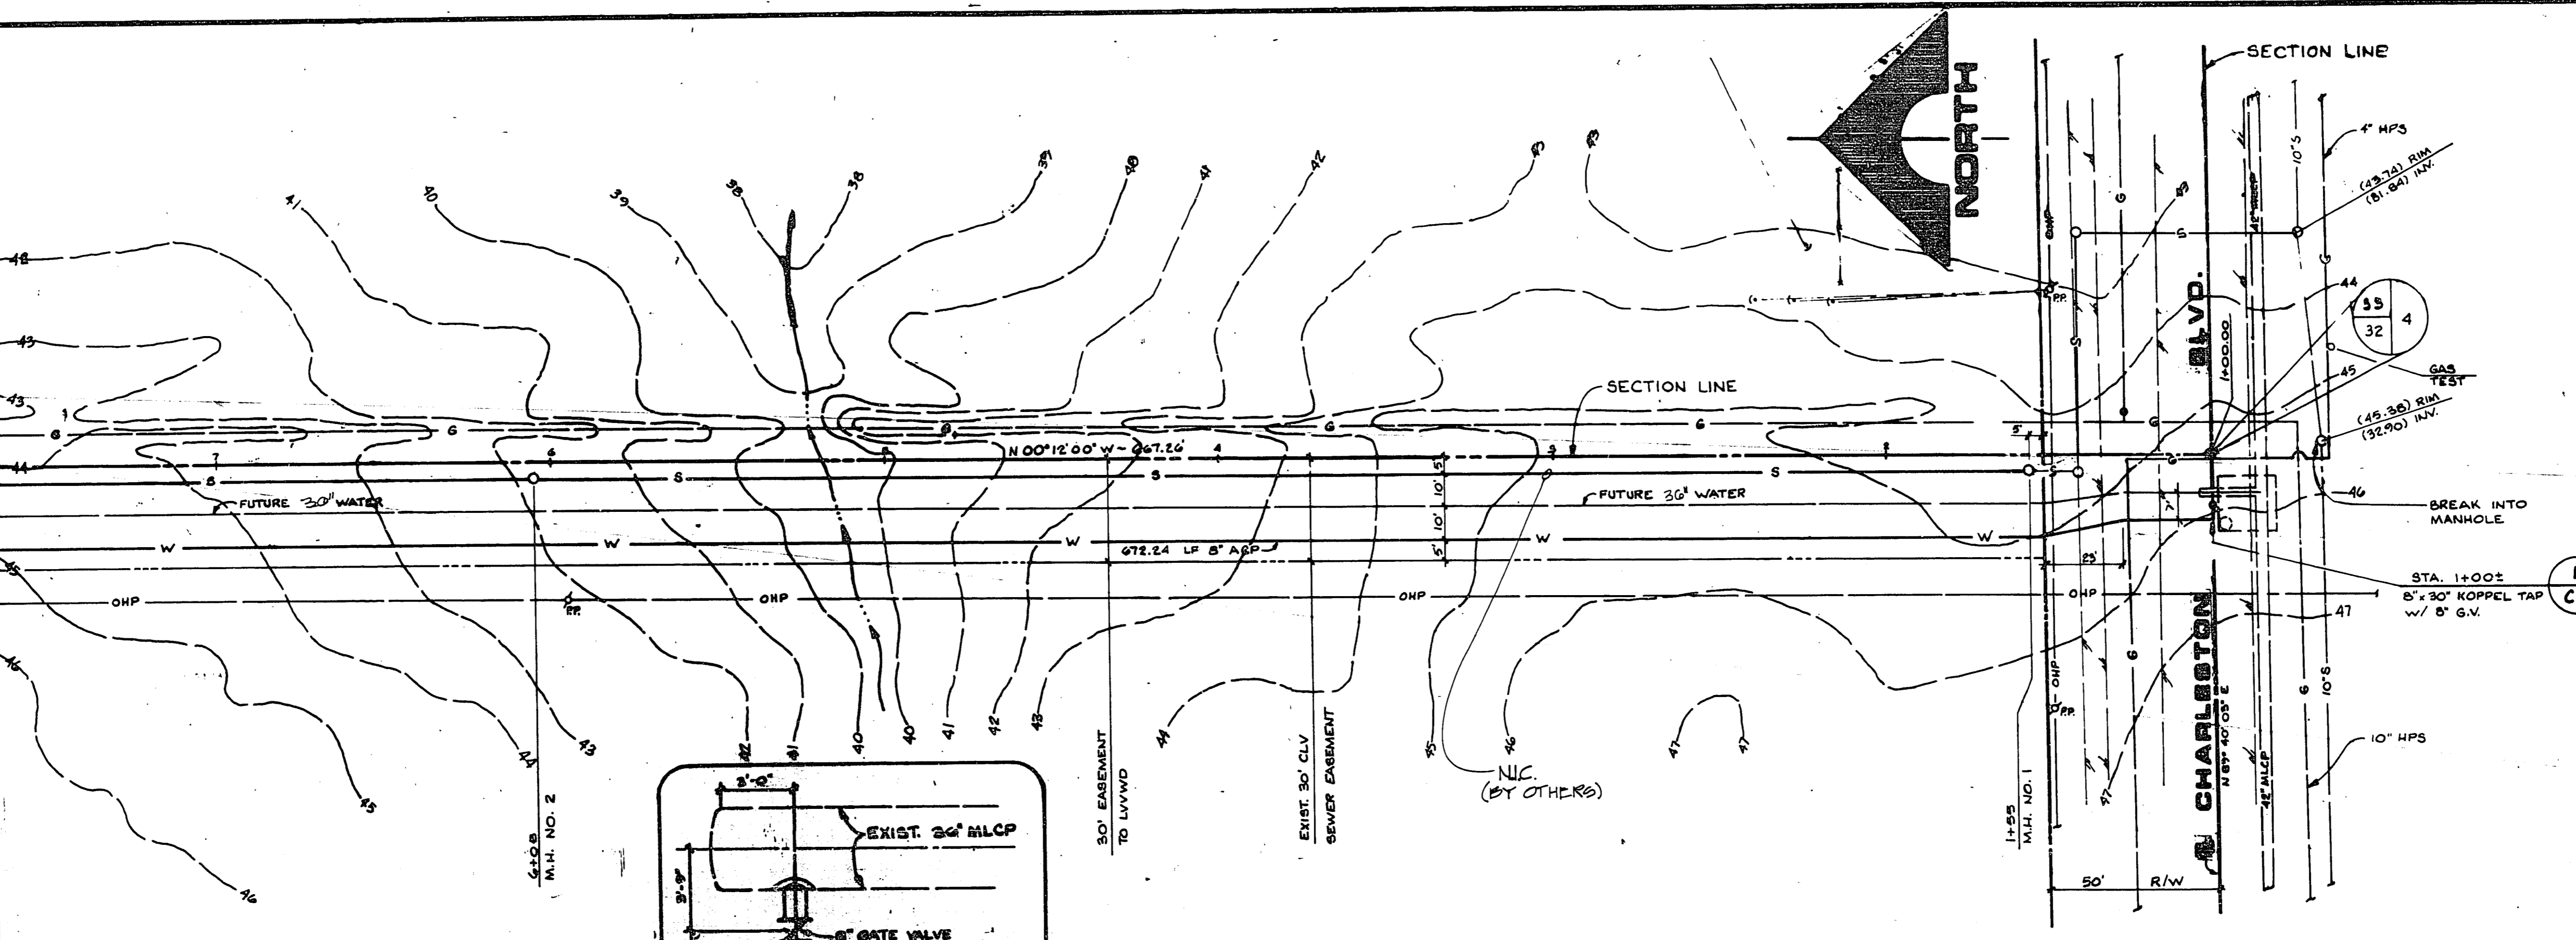


PLAN
 SCALE: 1" = 30'

NOTE: ALL STATIONING SECTION LINE STATIONS


NOTE: SEE SHEET C4 FOR WATER DISTRICT NOTES, UTILITY COMPANY SIGNATURE BLOCK & PUBLIC UTILITY QUANTITIES

NOTE:
 VERTICAL ANGLE POINTS ARE SCHEMATIC ONLY. JOINTS MAY BE PULLED TO MAKE GRADE CHANGES.

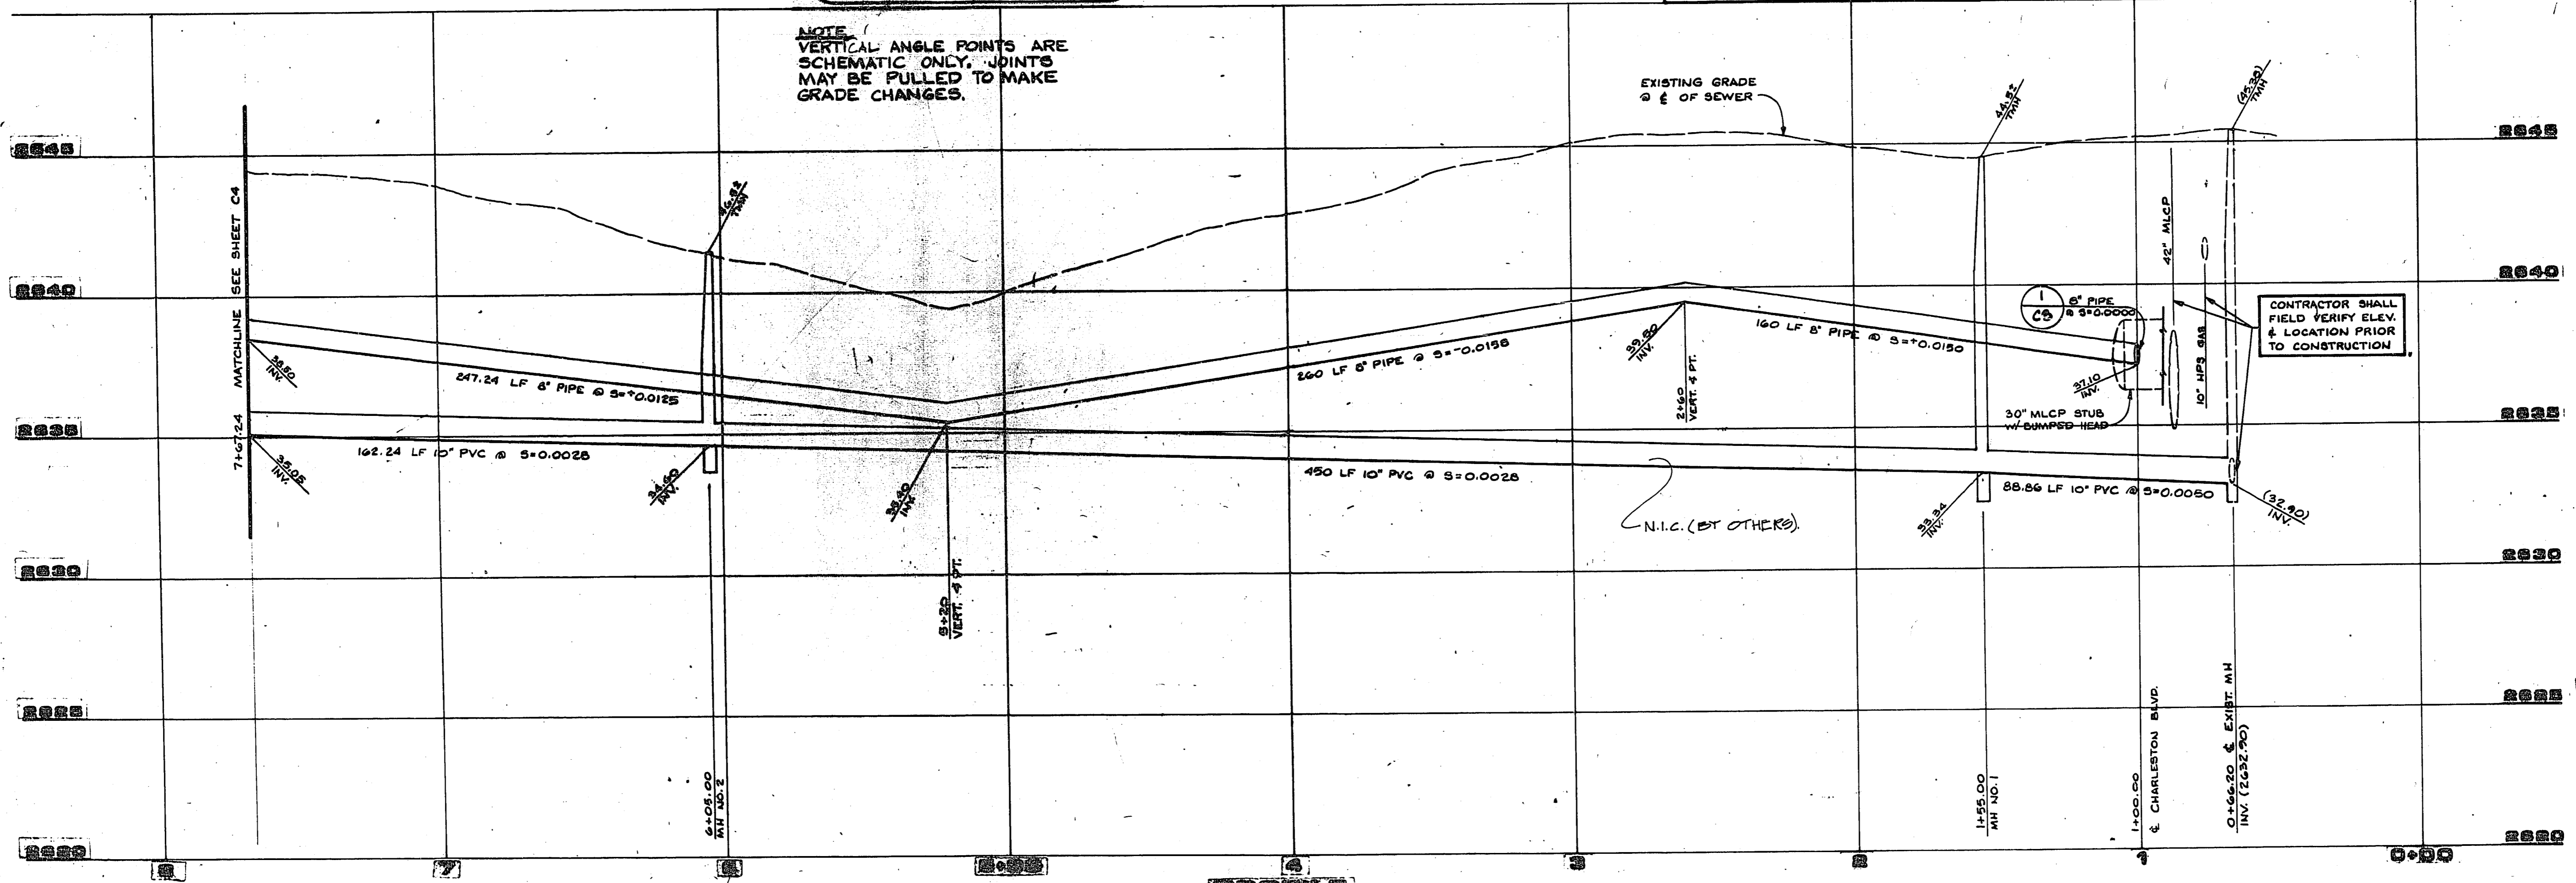

PROFILE
 SCALE: 1" = 10'

REV	DATE	DESCRIPTION
1	3/15/09	3343 P.E. NO. 10476

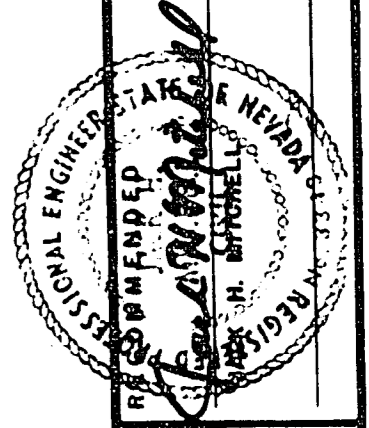

G.C. WALLACE, INC.
 Engineering/Architecture
 1555 SOUTH RAINBOW BLVD./LAS VEGAS, NEVADA 89102

CITY OF LAS VEGAS
 PIPE STATION NO. 8
 UTILITY PLAN & PROFILE

SHEET

4-177
 630-78