


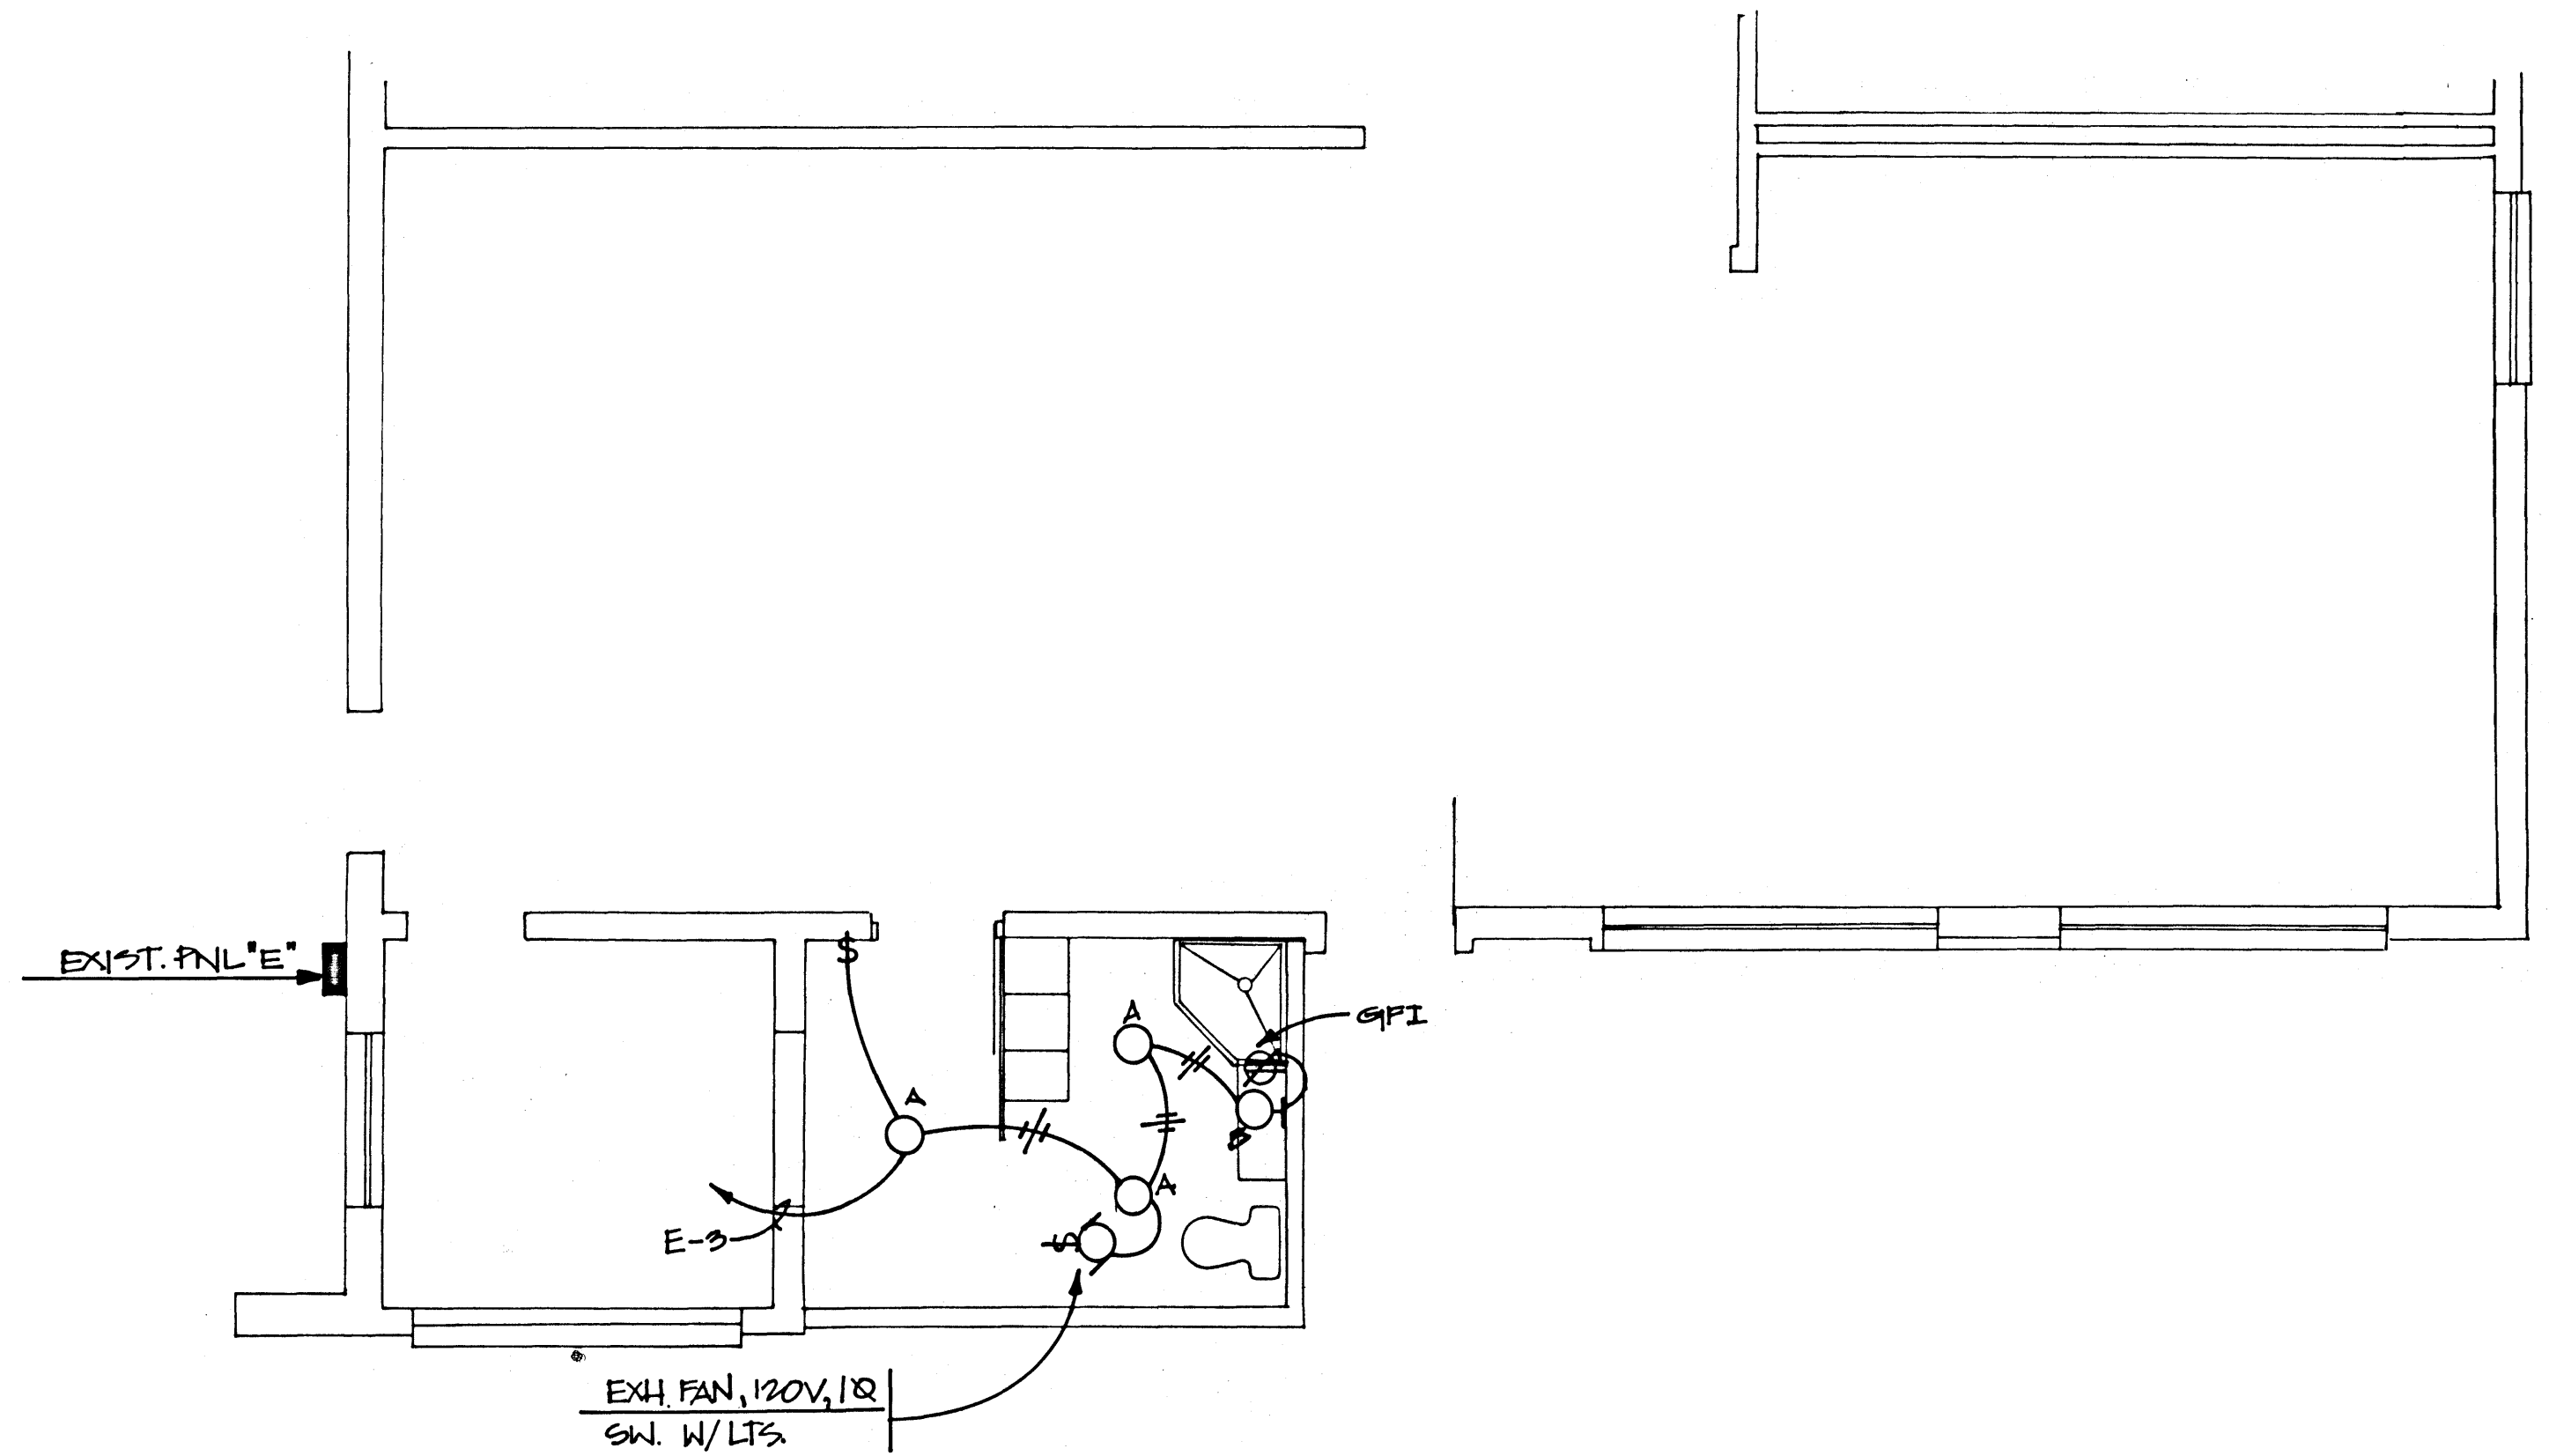


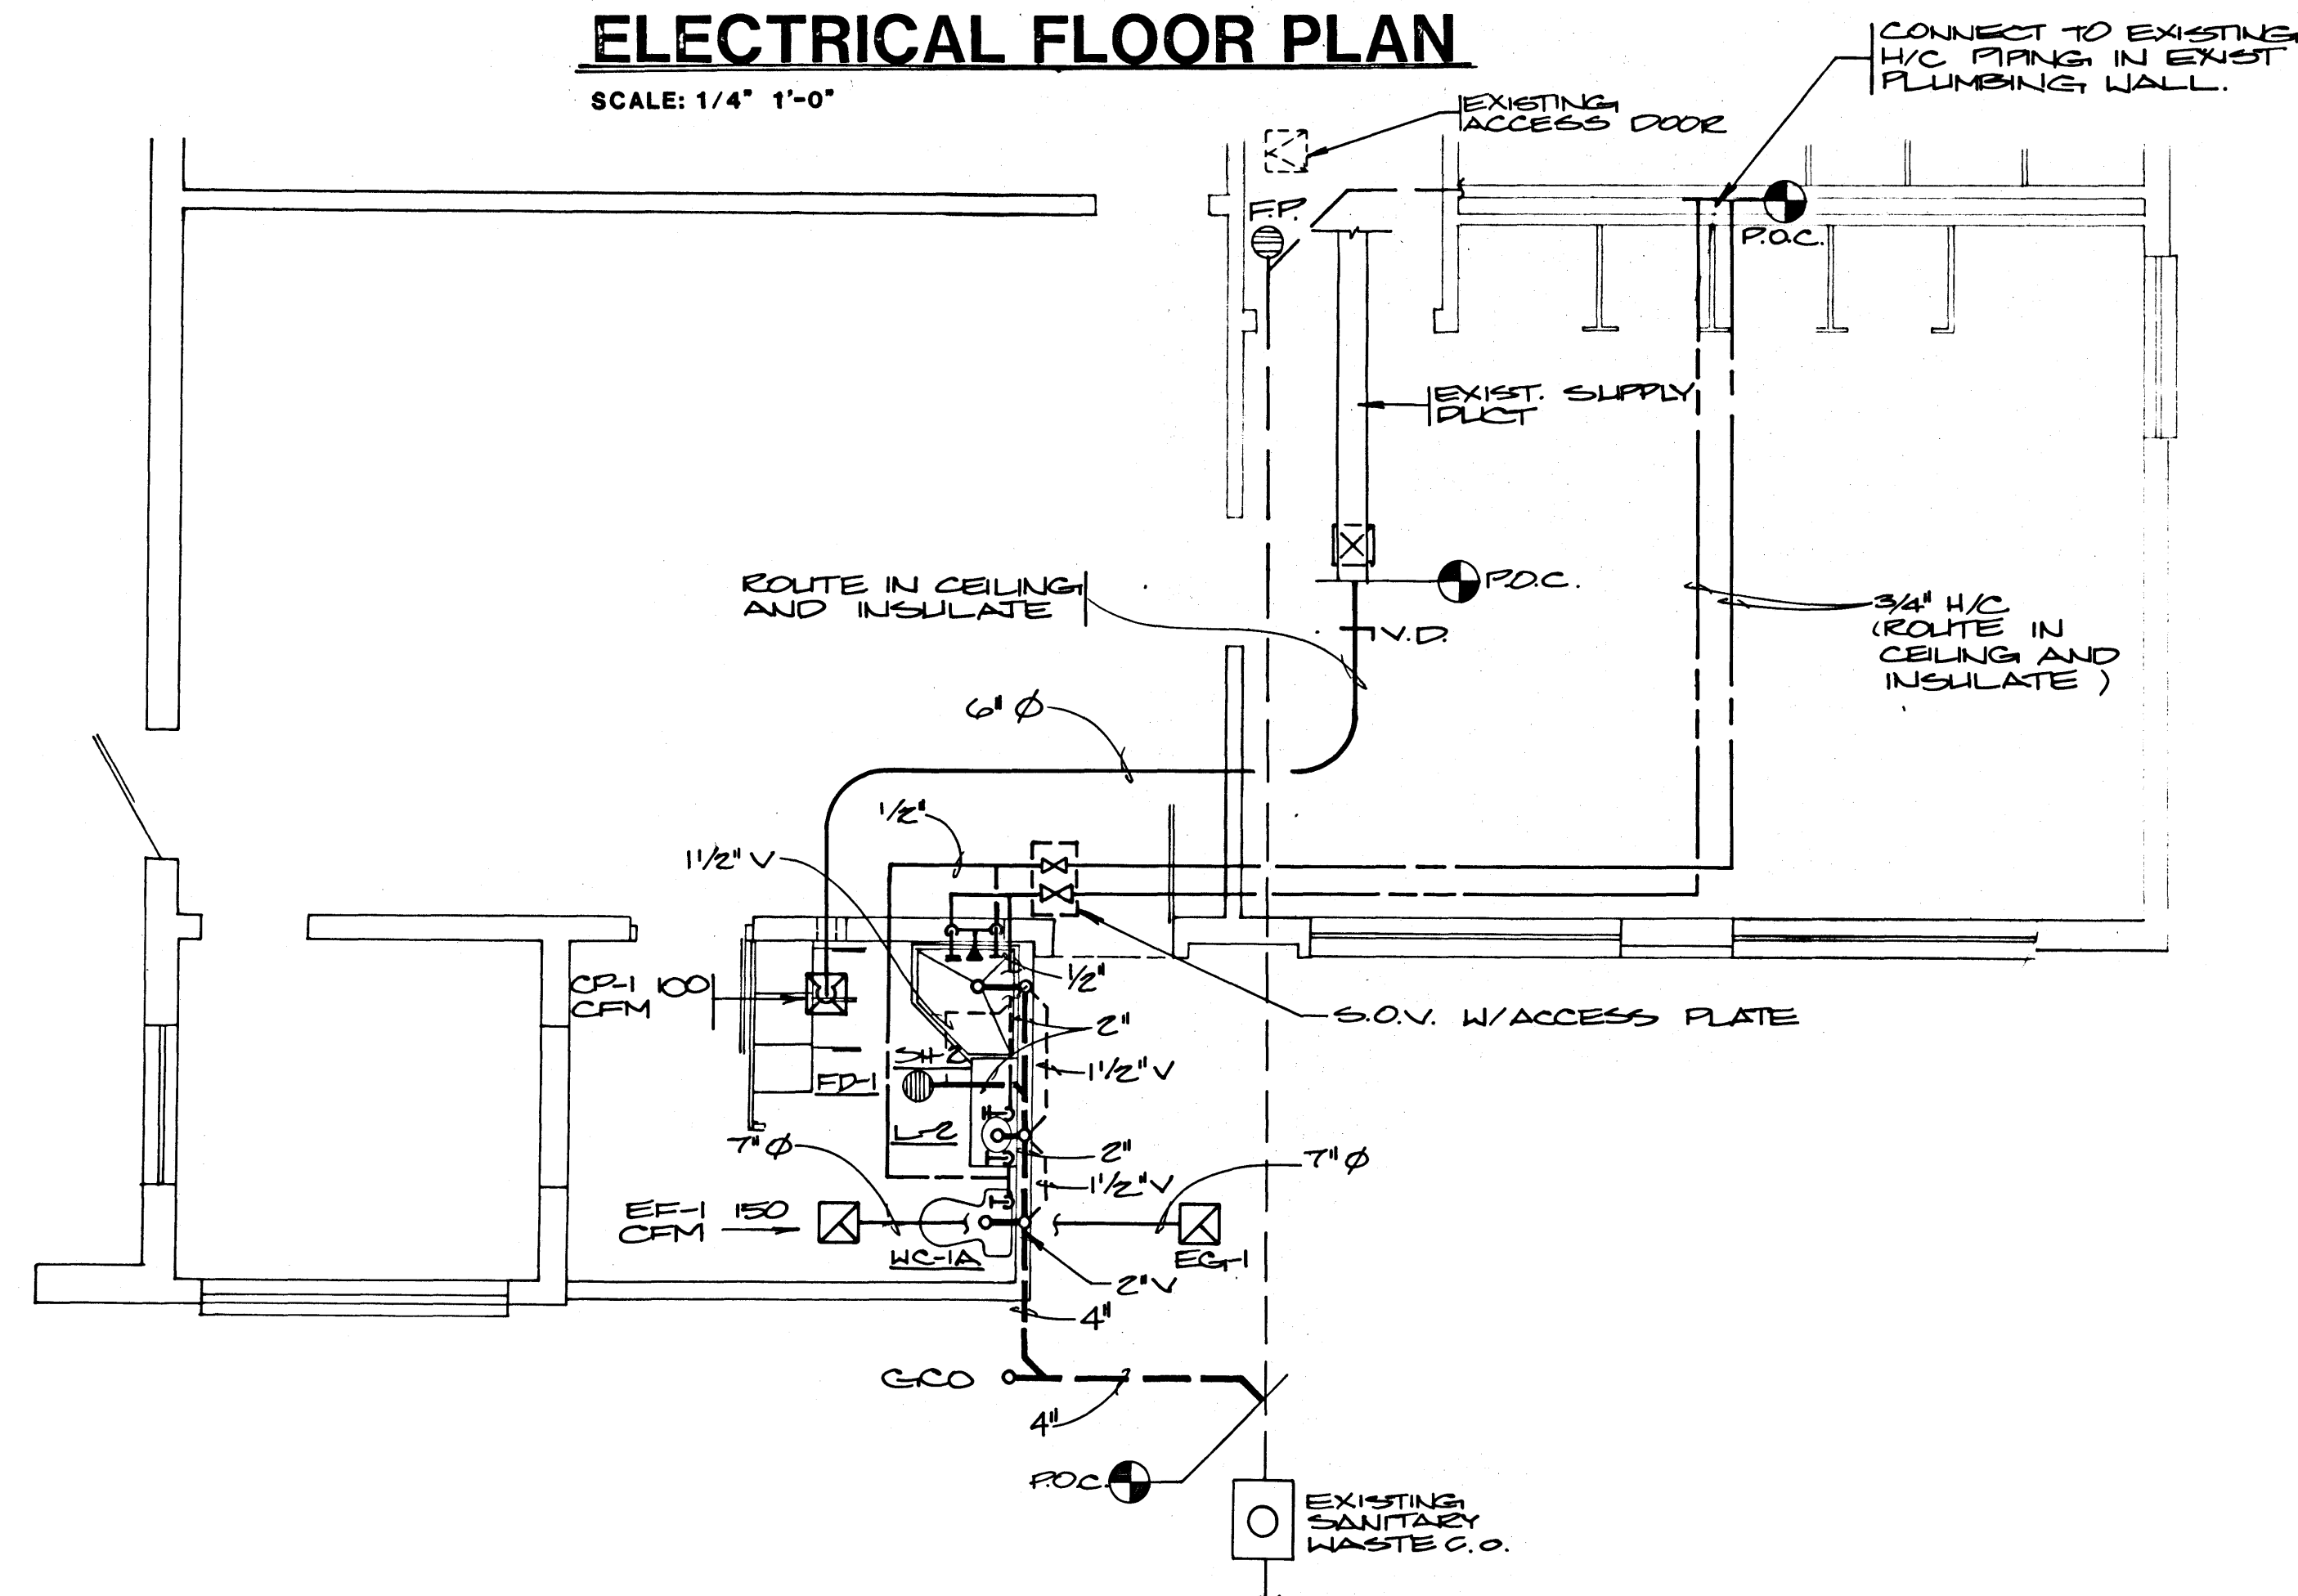

ELECTRICAL FLOOR PLAN
SCALE: 1/4" 1'-0"

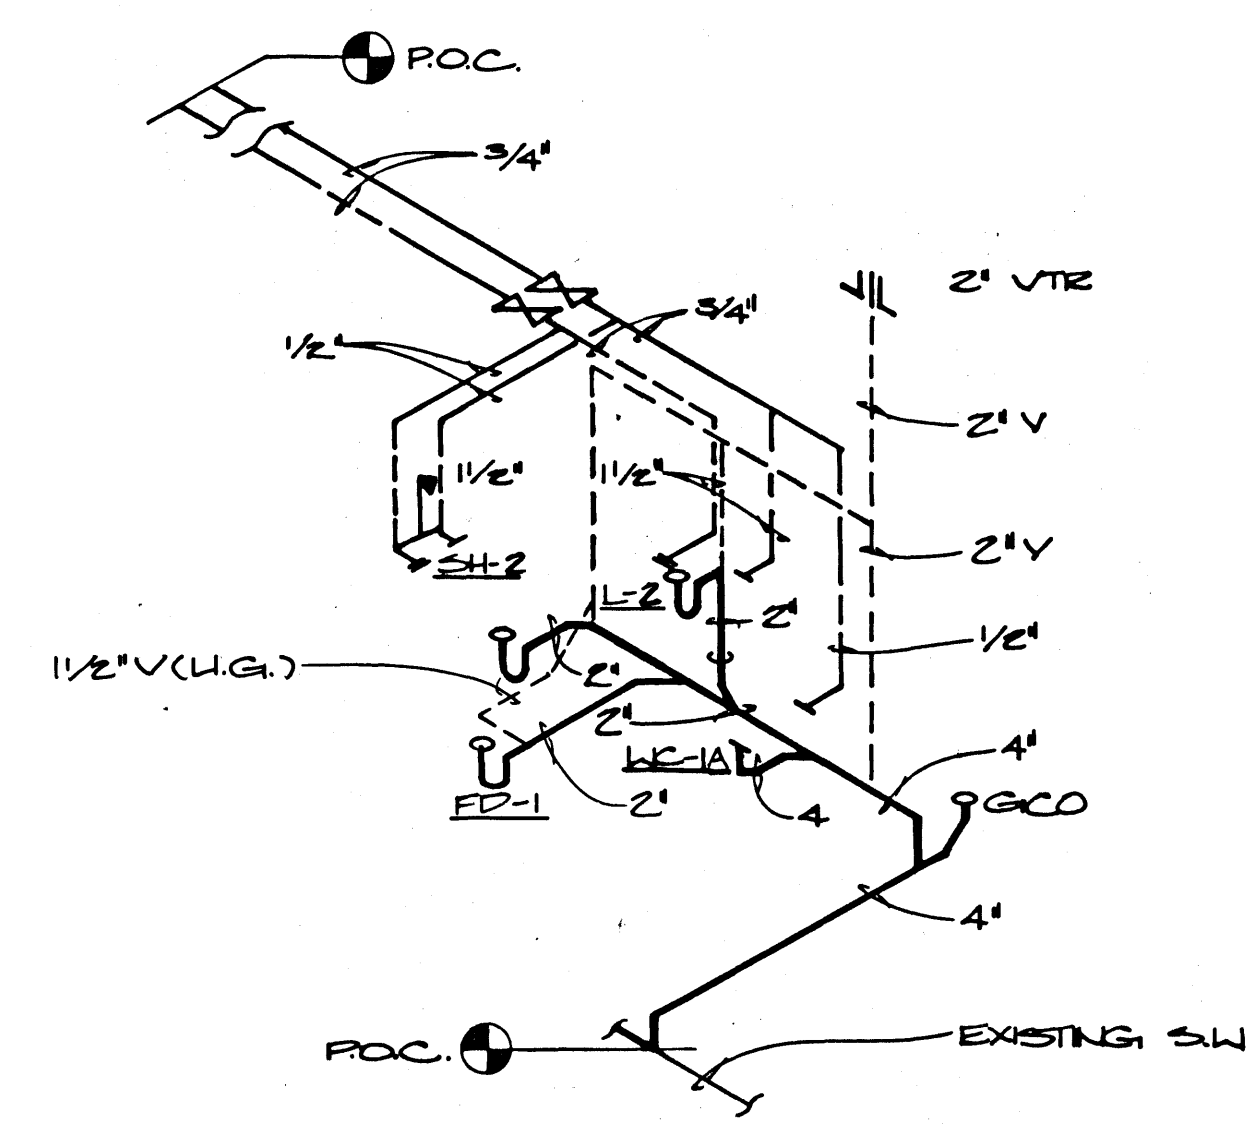

MECHANICAL FLOOR PLAN
SCALE: 1/4" 1'-0"

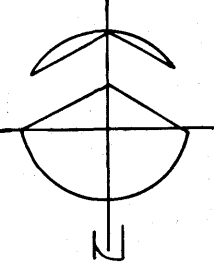

PIPING DIAGRAM
N.T.S.

Patrick J. Klink AIA
Wayne P. Schreiner AIA
Thomas M. Silva AIA

HSA Architects, Inc.
ARCHITECTURE PLANNING INTERIORS
1531 West Oakley Boulevard, Las Vegas, Nevada 89102
(702) 383-0077 FAX (702) 383-0057

FIRE STATION # 5 MECH PLAN/ELECTRICAL
JOB TITLE
FEMALE FIRE FIGHTERS BATHROOM FACILITY ADDITIONS
Verify all Dimensions and Conditions at the Site

Sheet Title
901002.0
Date
JAN. 29, 91
Drawn By
LDG
Check
MOB

Sheet
ME-2
Of
5