



EXISTING FLOOR PLAN
SCALE 1/8" = 1'-0"

A
A1.0

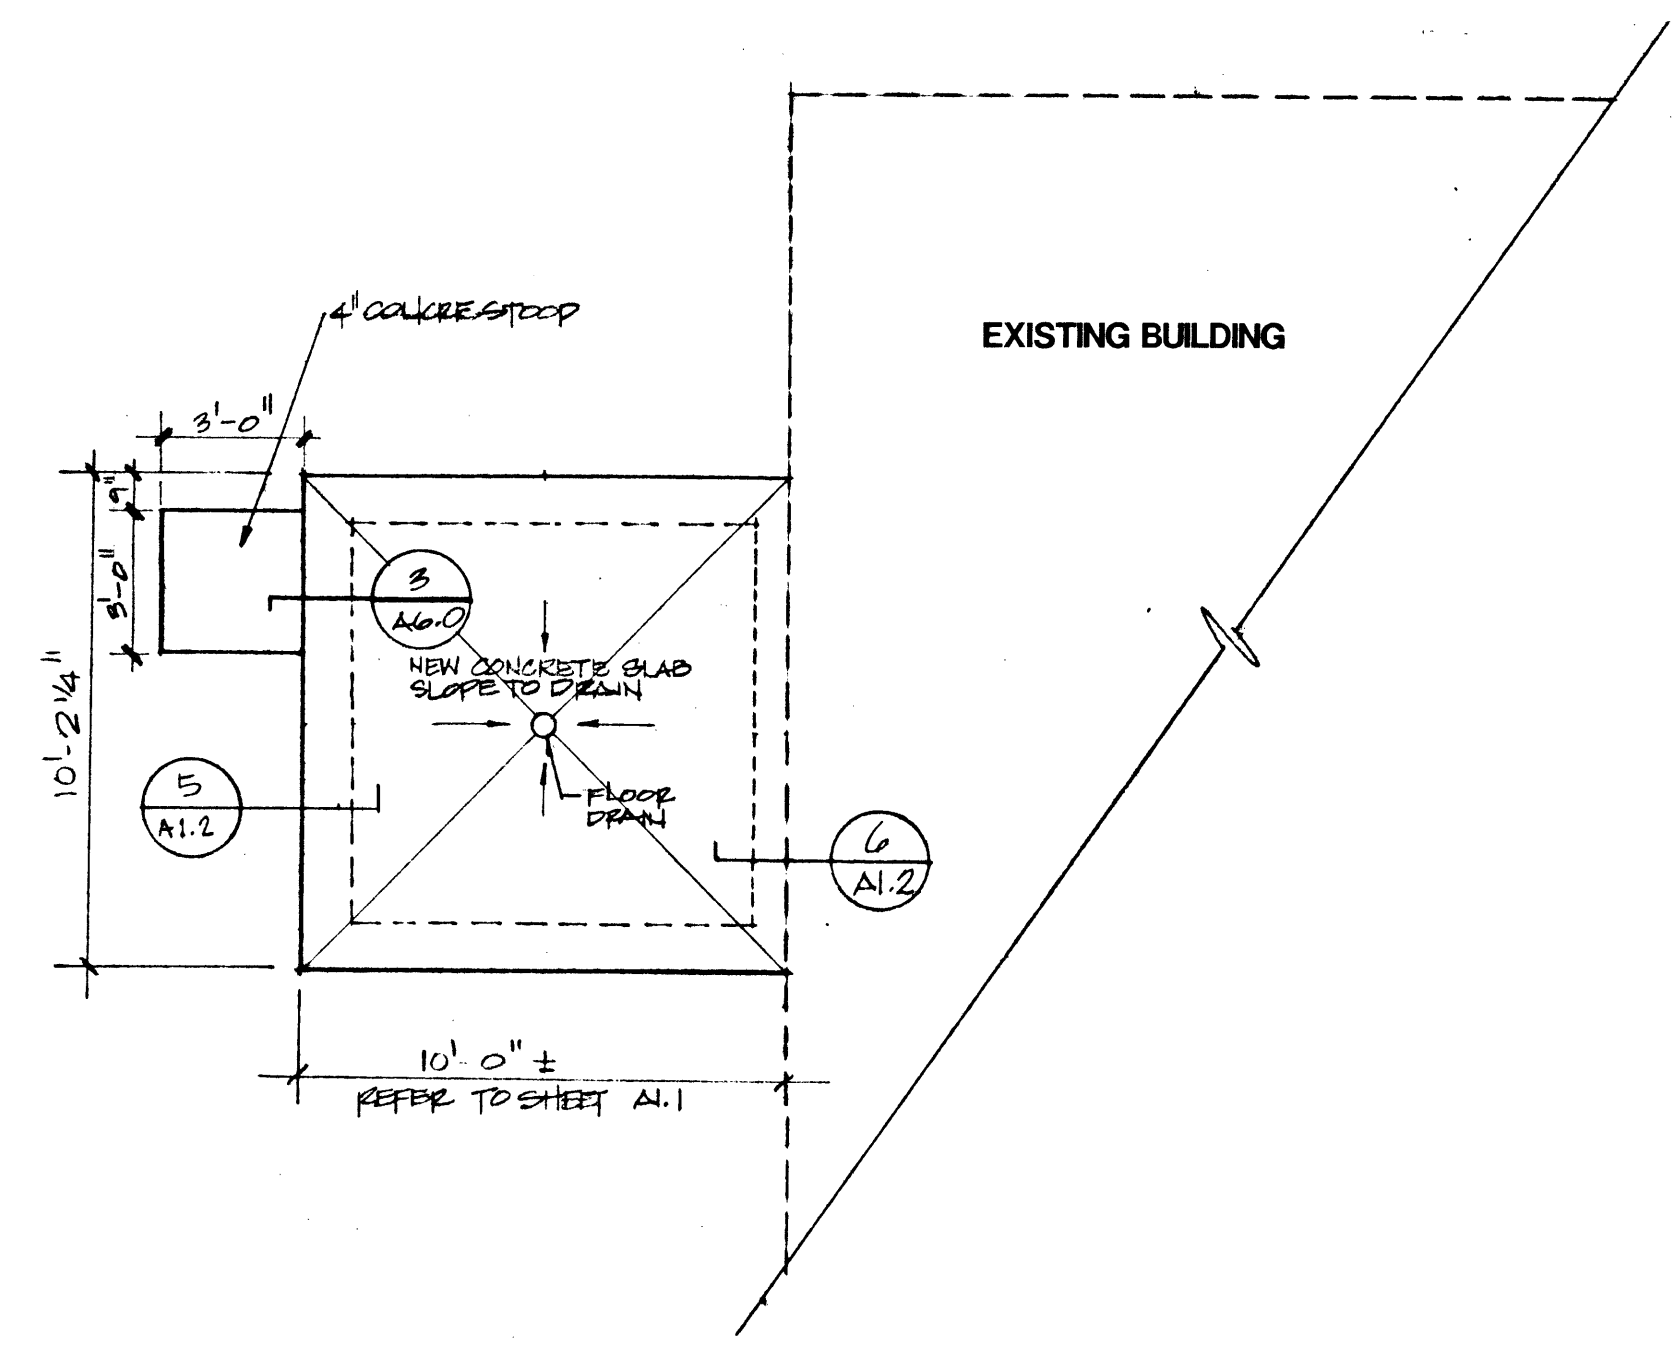




FOUNDATION PLAN
1/4" = 1'-0"

B
A1.0

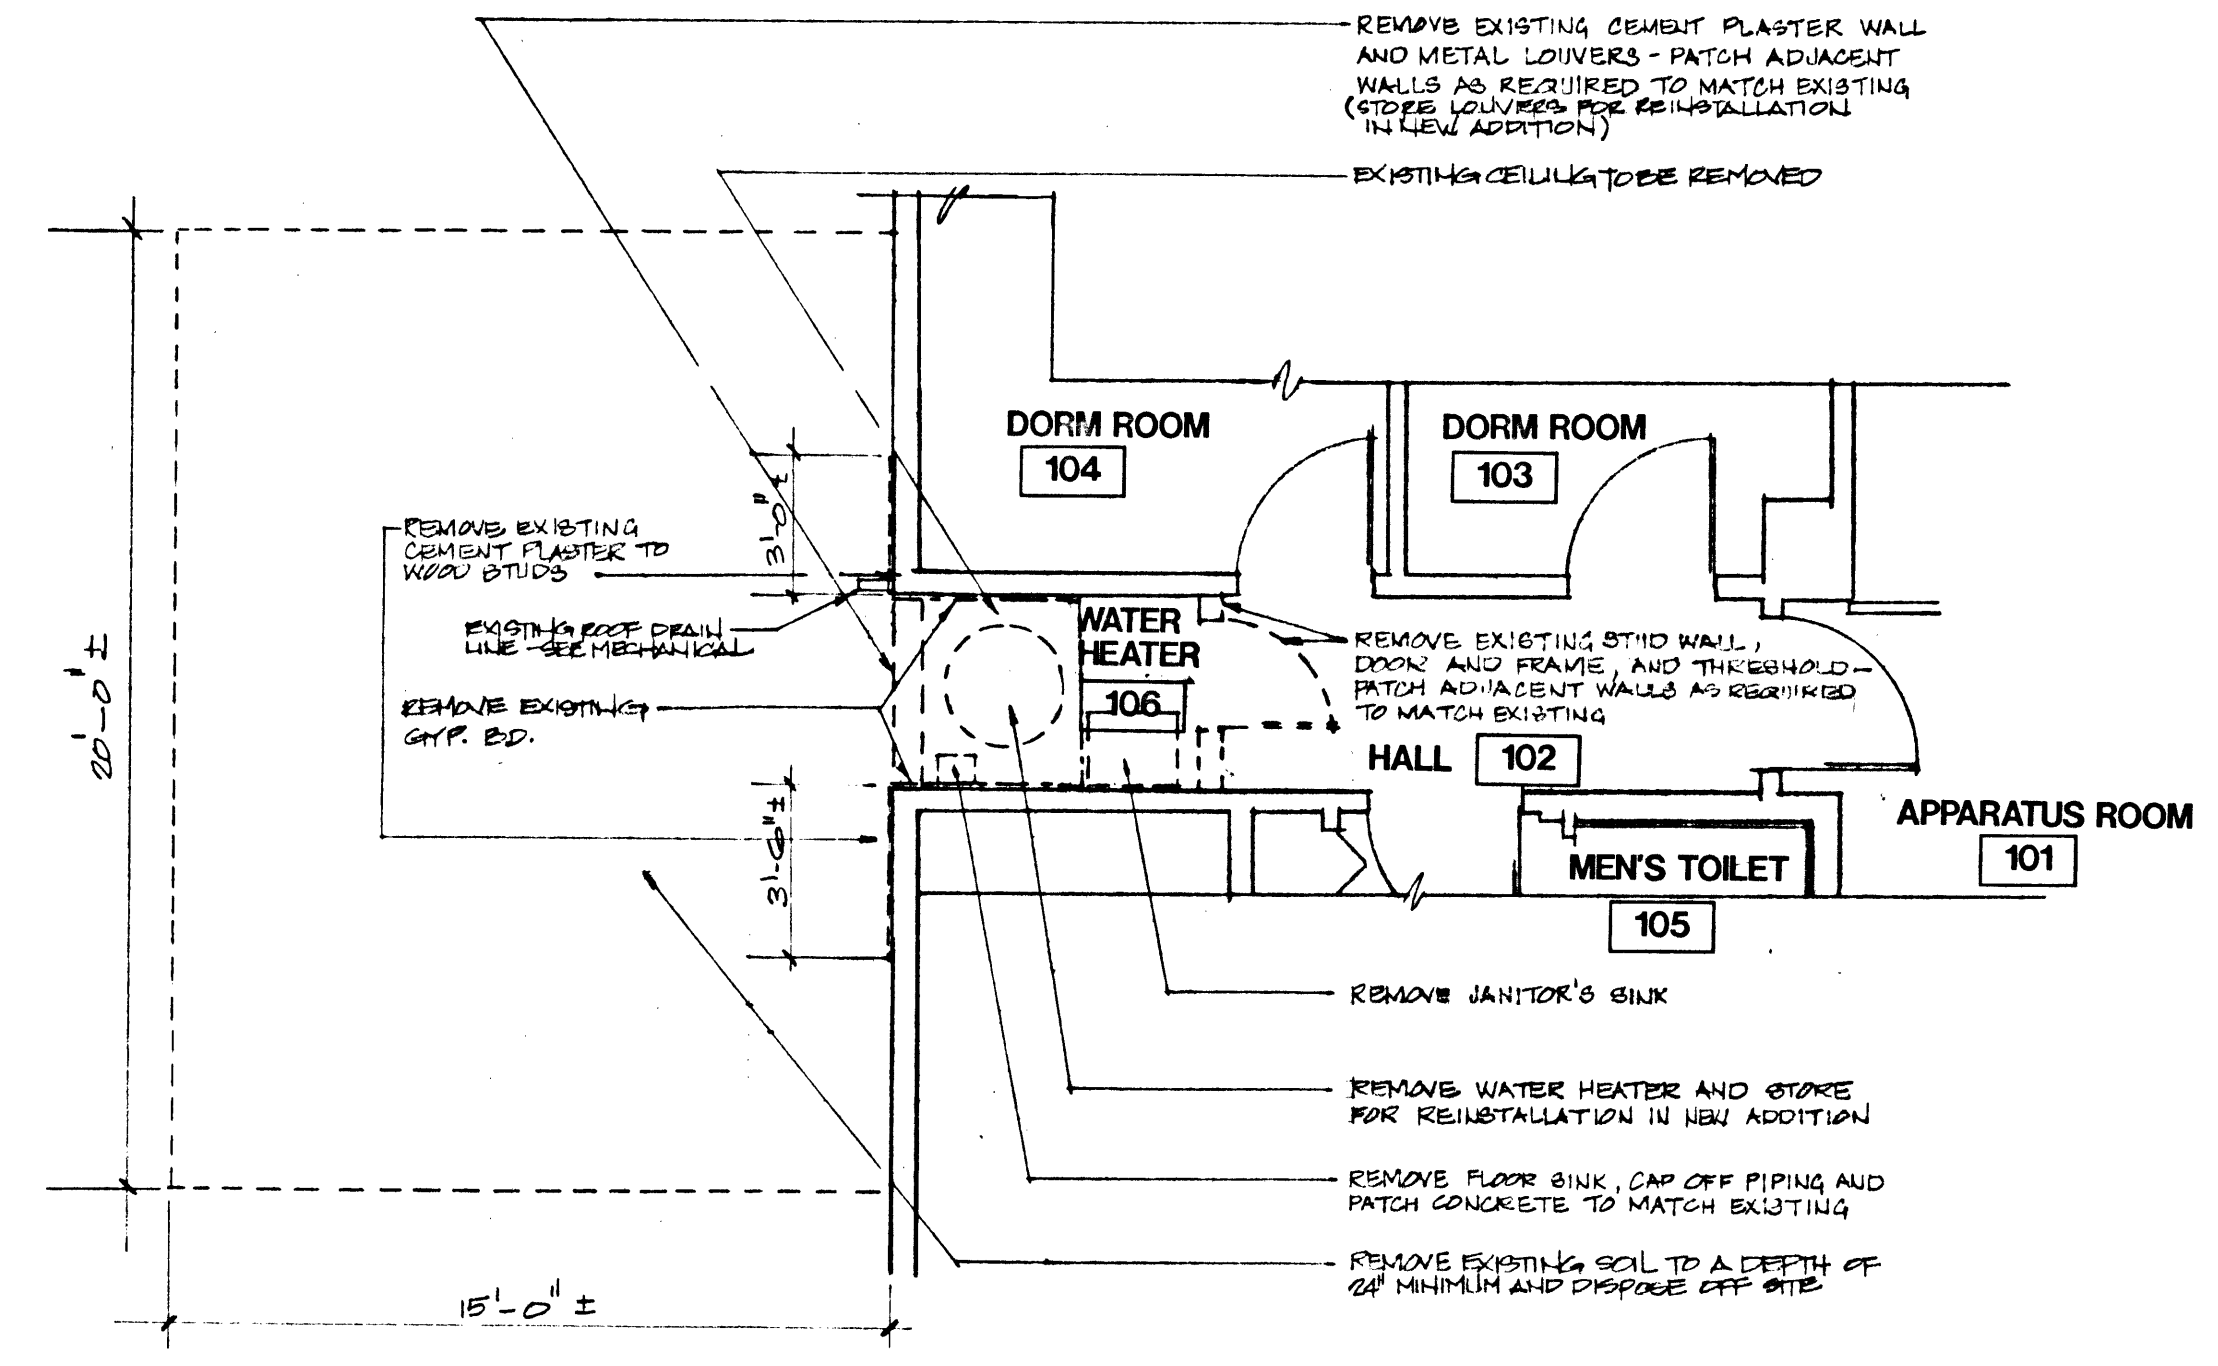

ENLARGED TOILET ROOM - DEMOLITION PLAN
1/4" = 1'-0"

C
A1.0

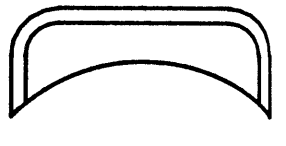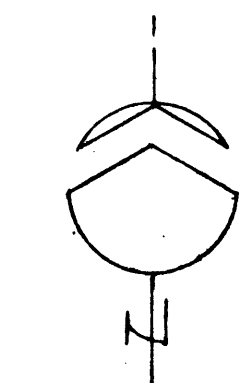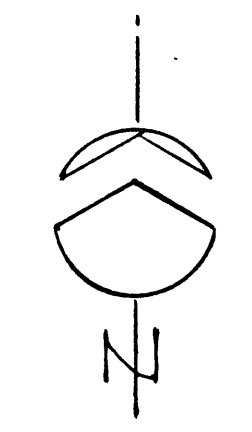

Patrick J. Darrick AIA
Wayne P. Schreyer AIA
Thomas M. Shee AIA

HSA ARCHITECTS, INC.
Architecture Planning Interiors
1531 West Oakley Boulevard, Las Vegas, Nevada 89102
(702) 383-0077 FAX (702) 383-0057

Sheet Title: **FIRE STATION #3: FLOOR PLAN**
JOB Title: **FEMALE FIRE FIGHTERS BATHROOM FACILITY ADDITIONS**

Job No: 901002.0
Date: 29 JAN 1991
Drawn By: SSK
Check: TMS

Sheet: **A1.0**

12

AS-BUILT DRAWINGS

4-140

630-83