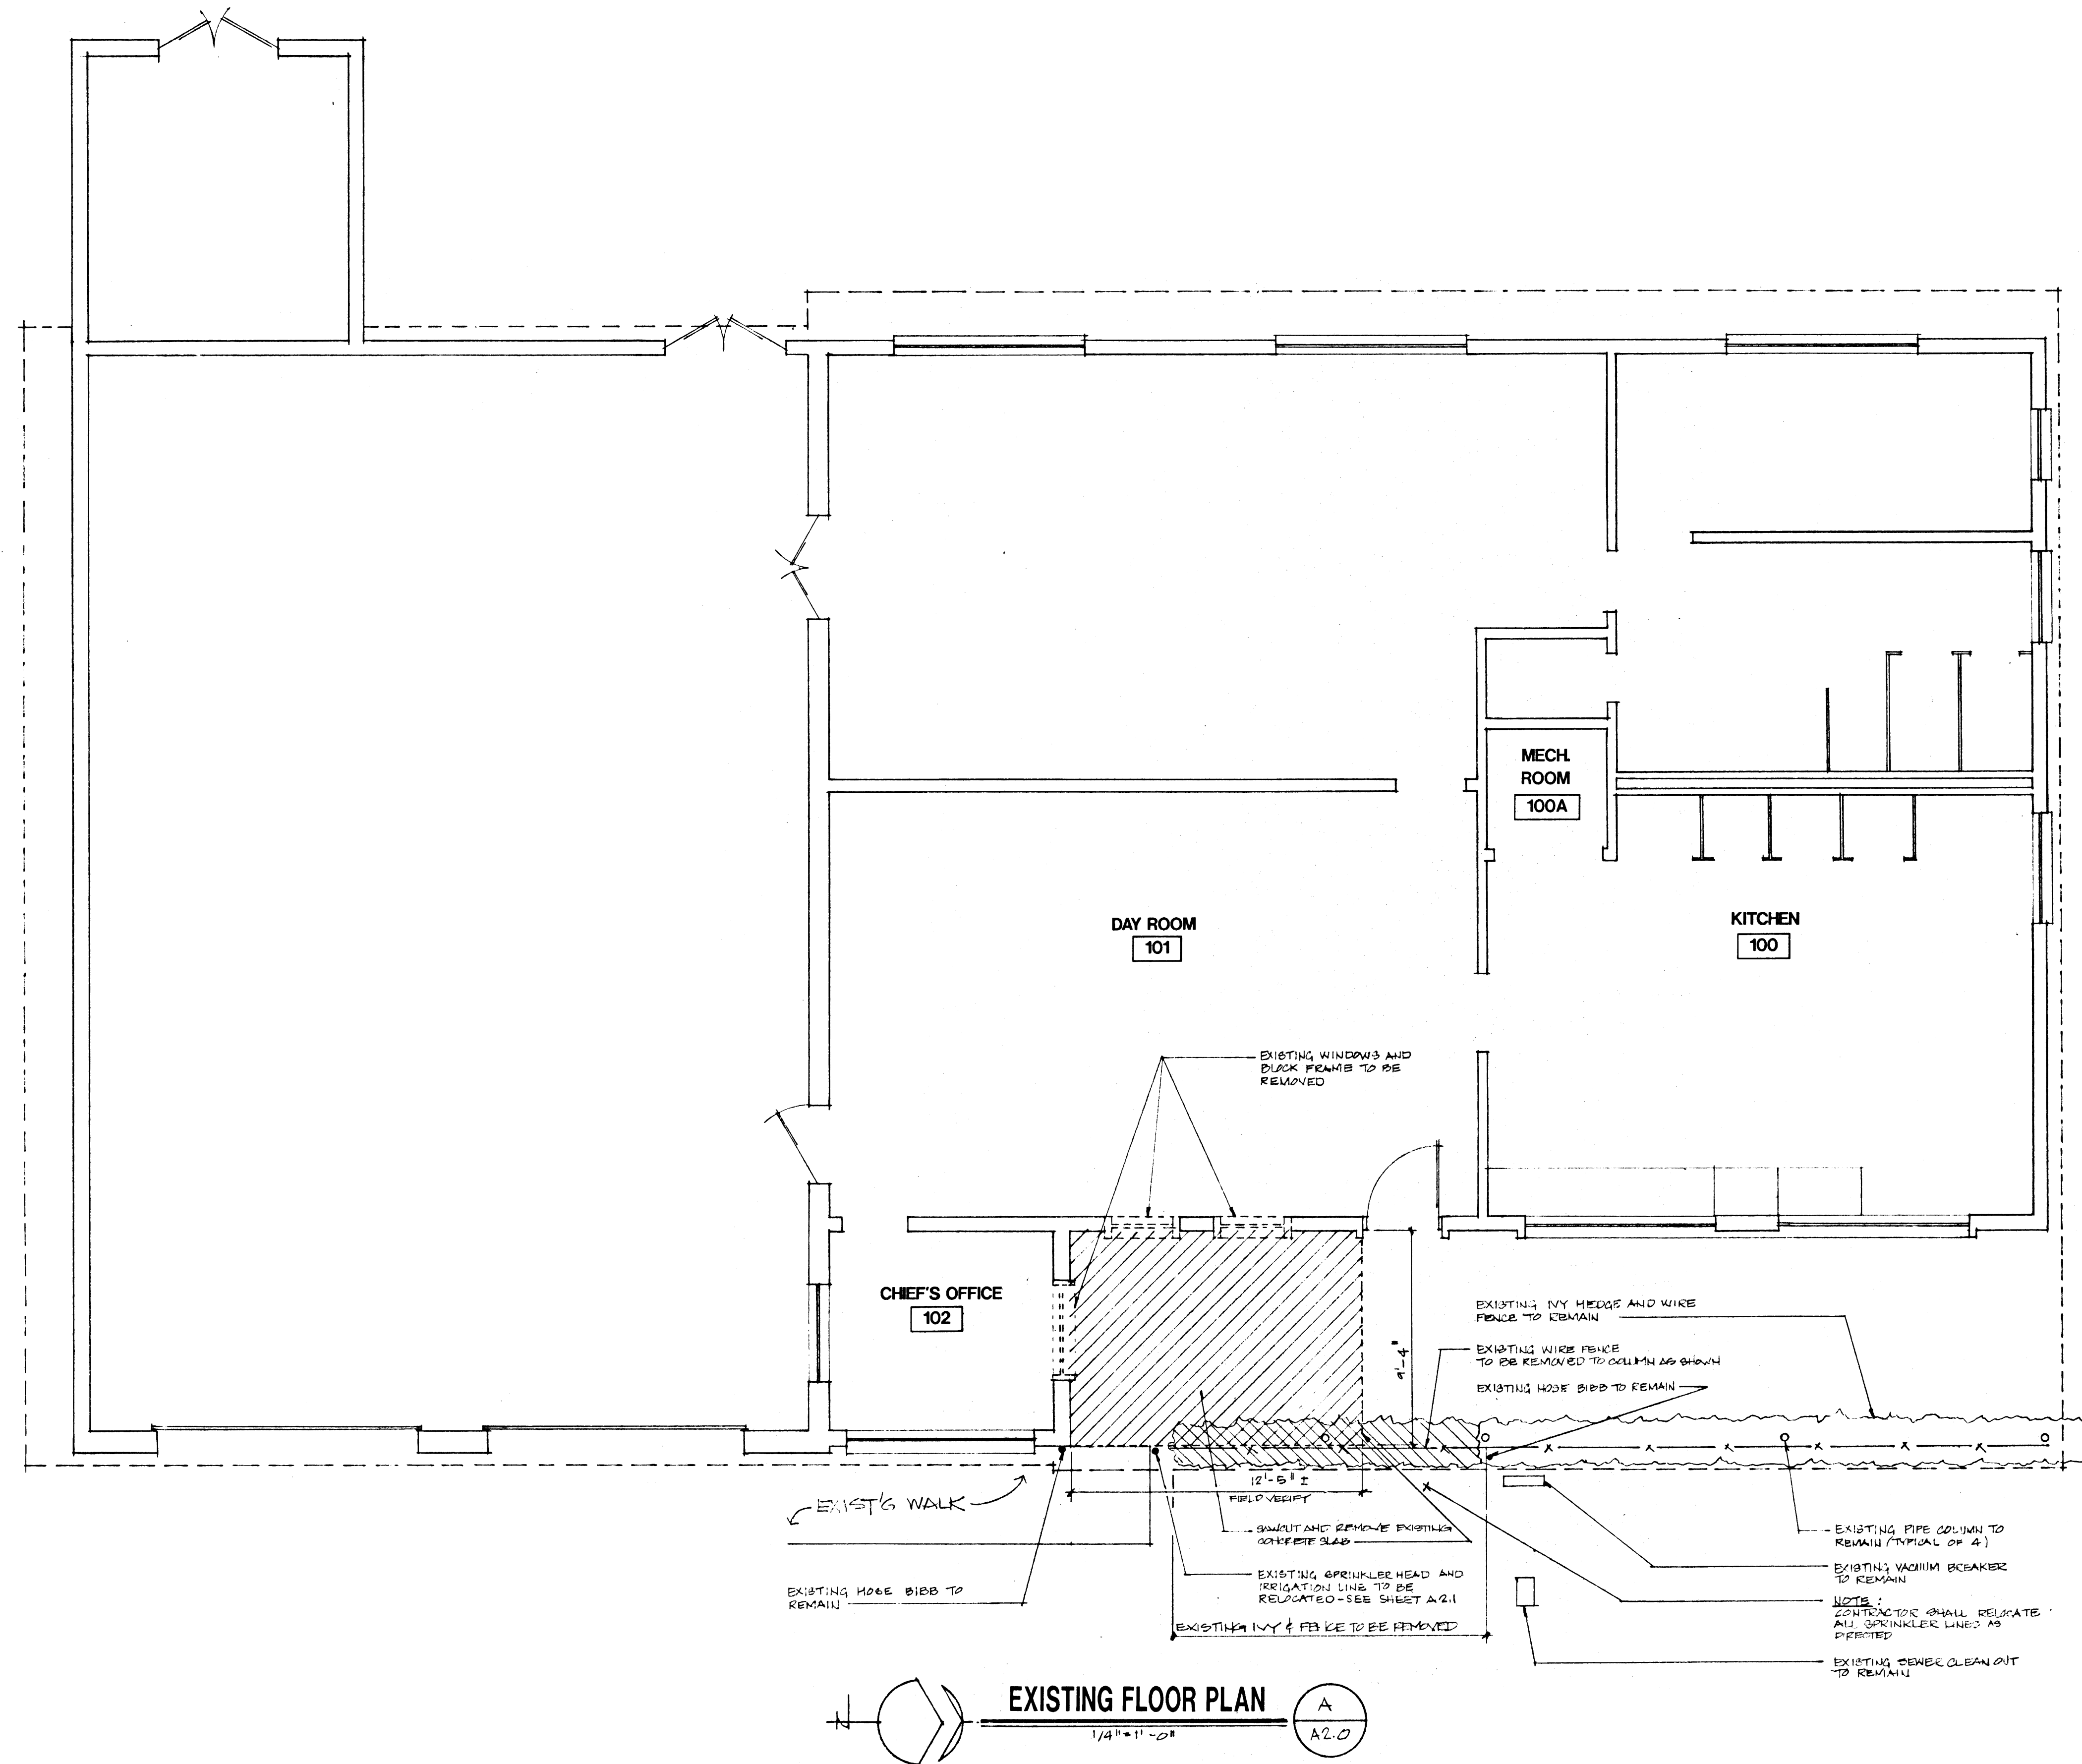


Patrick J. Kark AIA
Wayne P. Schreier AIA
Thomas M. Silva AIA

HSA ARCHITECTS, INC.
Architecture Planning Interiors
1531 West Oakley Boulevard, Las Vegas, Nevada 89102
(702) 383-0077 FAX (702) 383-0057

FIRE STATION #5 - FLOOR PLAN
FEMALE FIRE FIGHTERS
BATHROOM FACILITY ADDITIONS

Drawn By	SSK
Check	TMS
Sheet	A2.0
Of	12

AS-BUILT DRAWINGS
4-143

630-83