




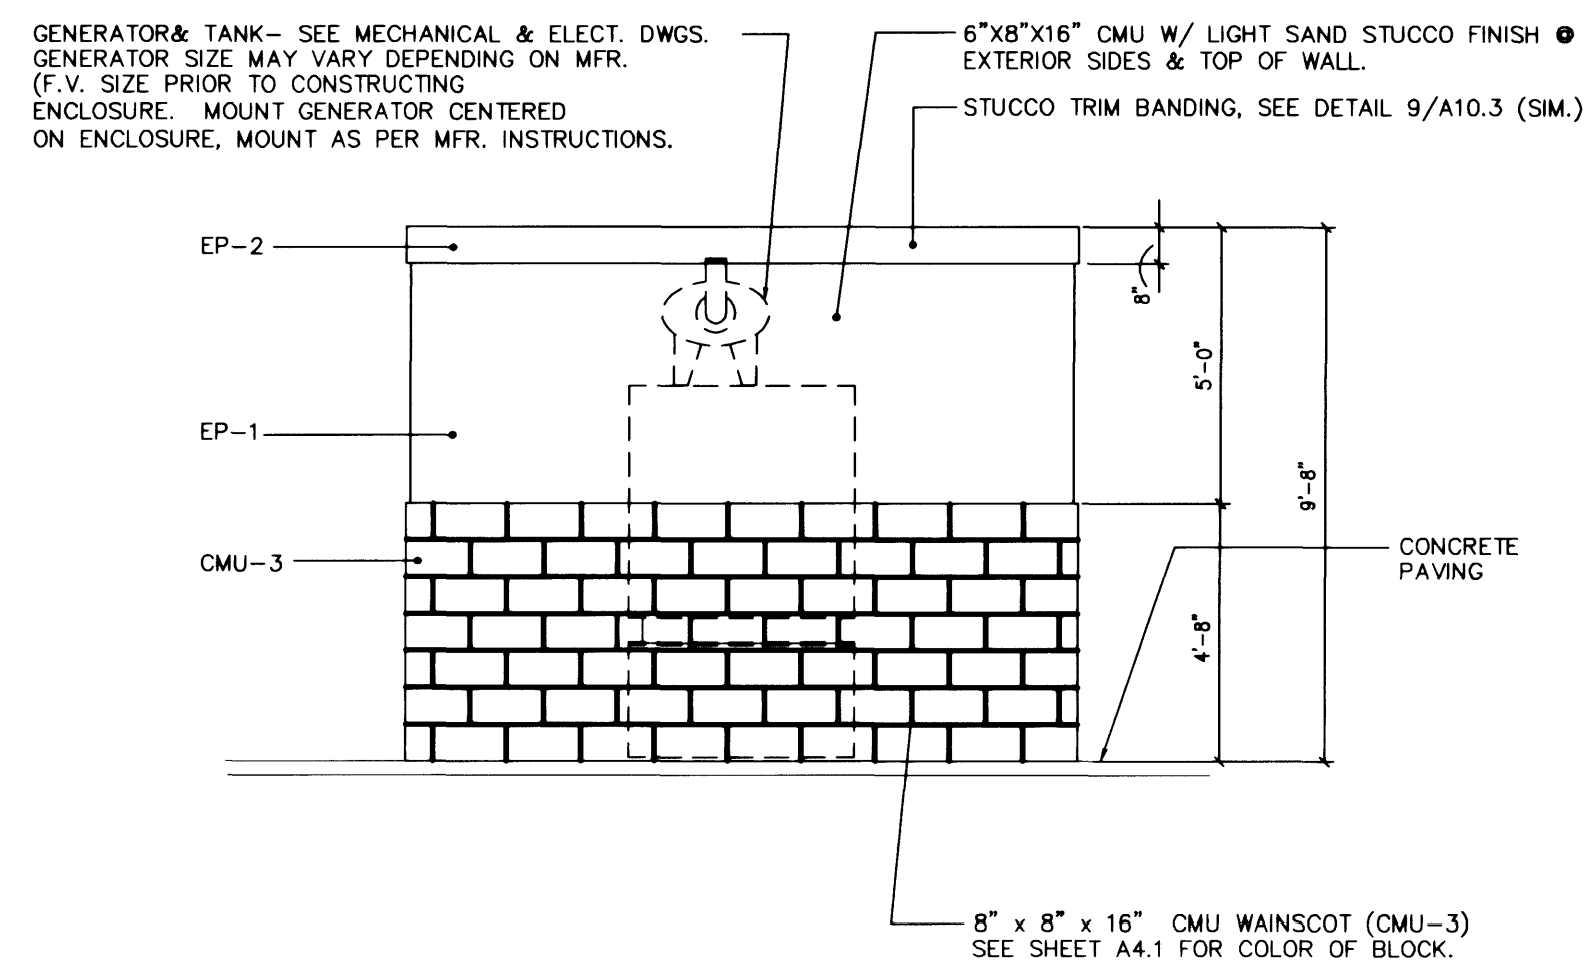


9B Generator Enclosure – East Elevation

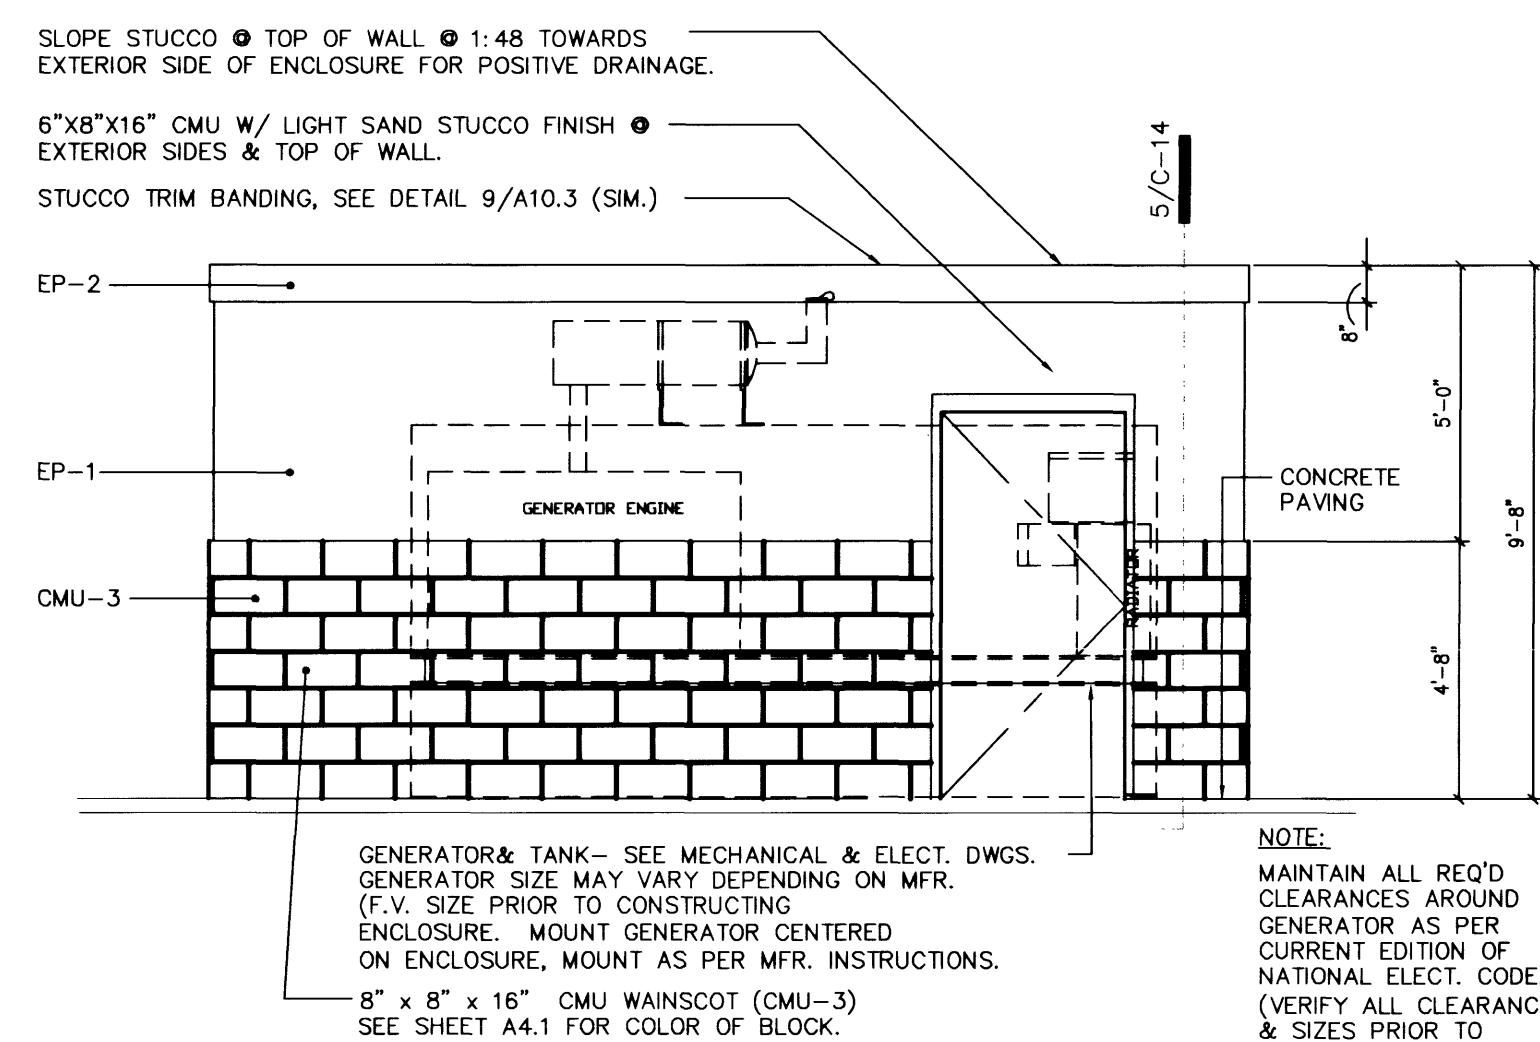


9A Generator Enclosure – South Elevation
Scale: N.T.S. XXXX-XX AS2-11

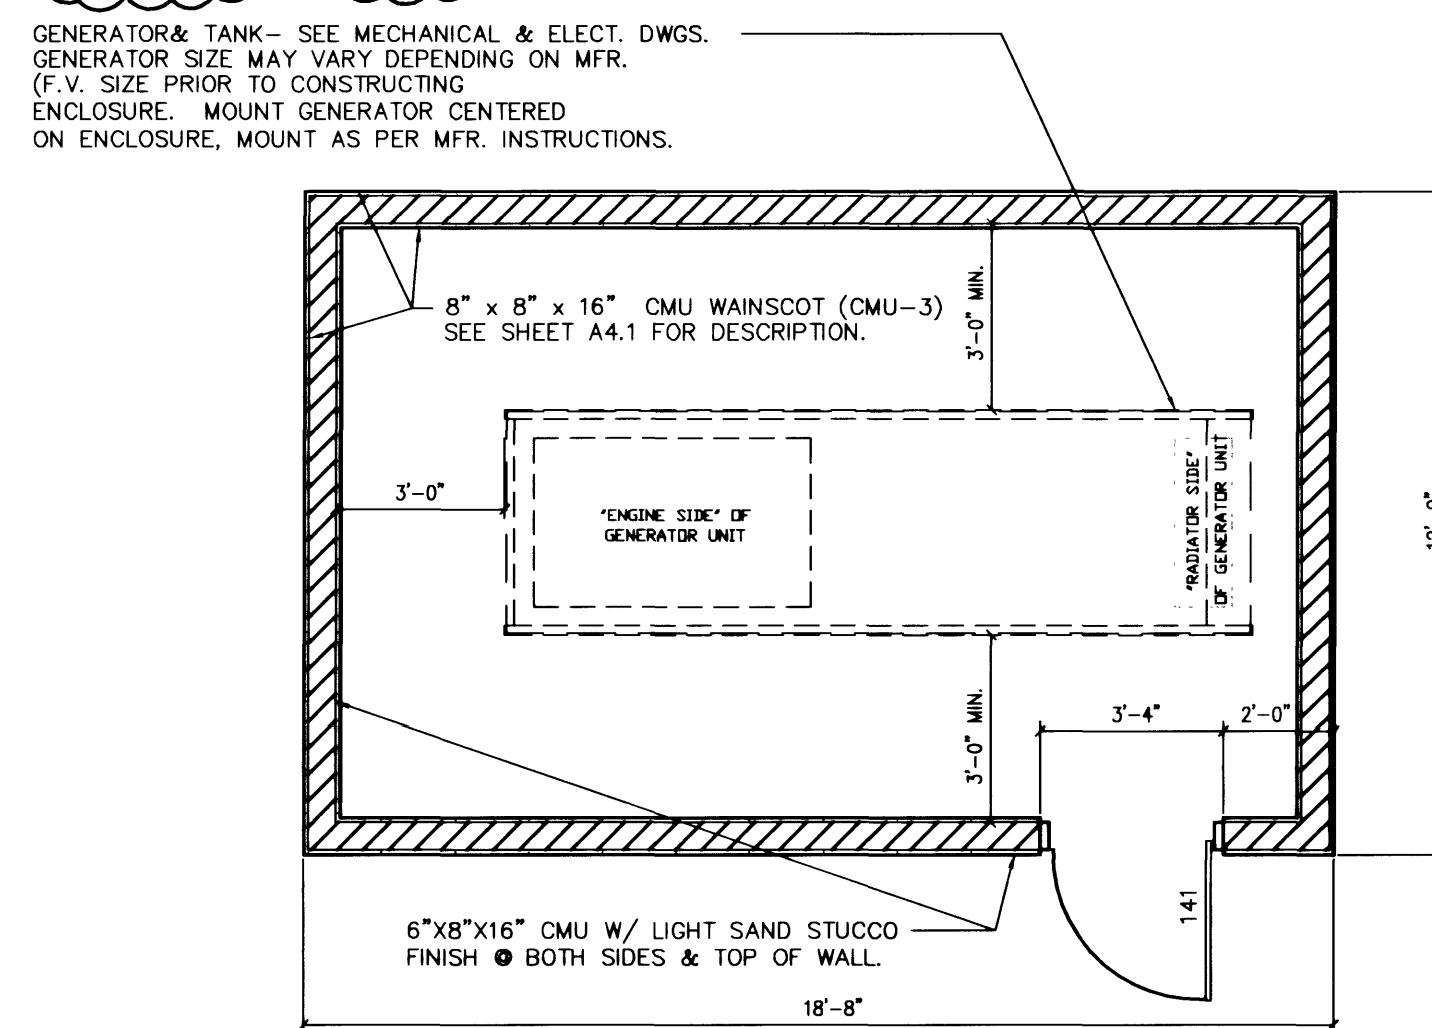

9 Generator Enclosure – Plan View

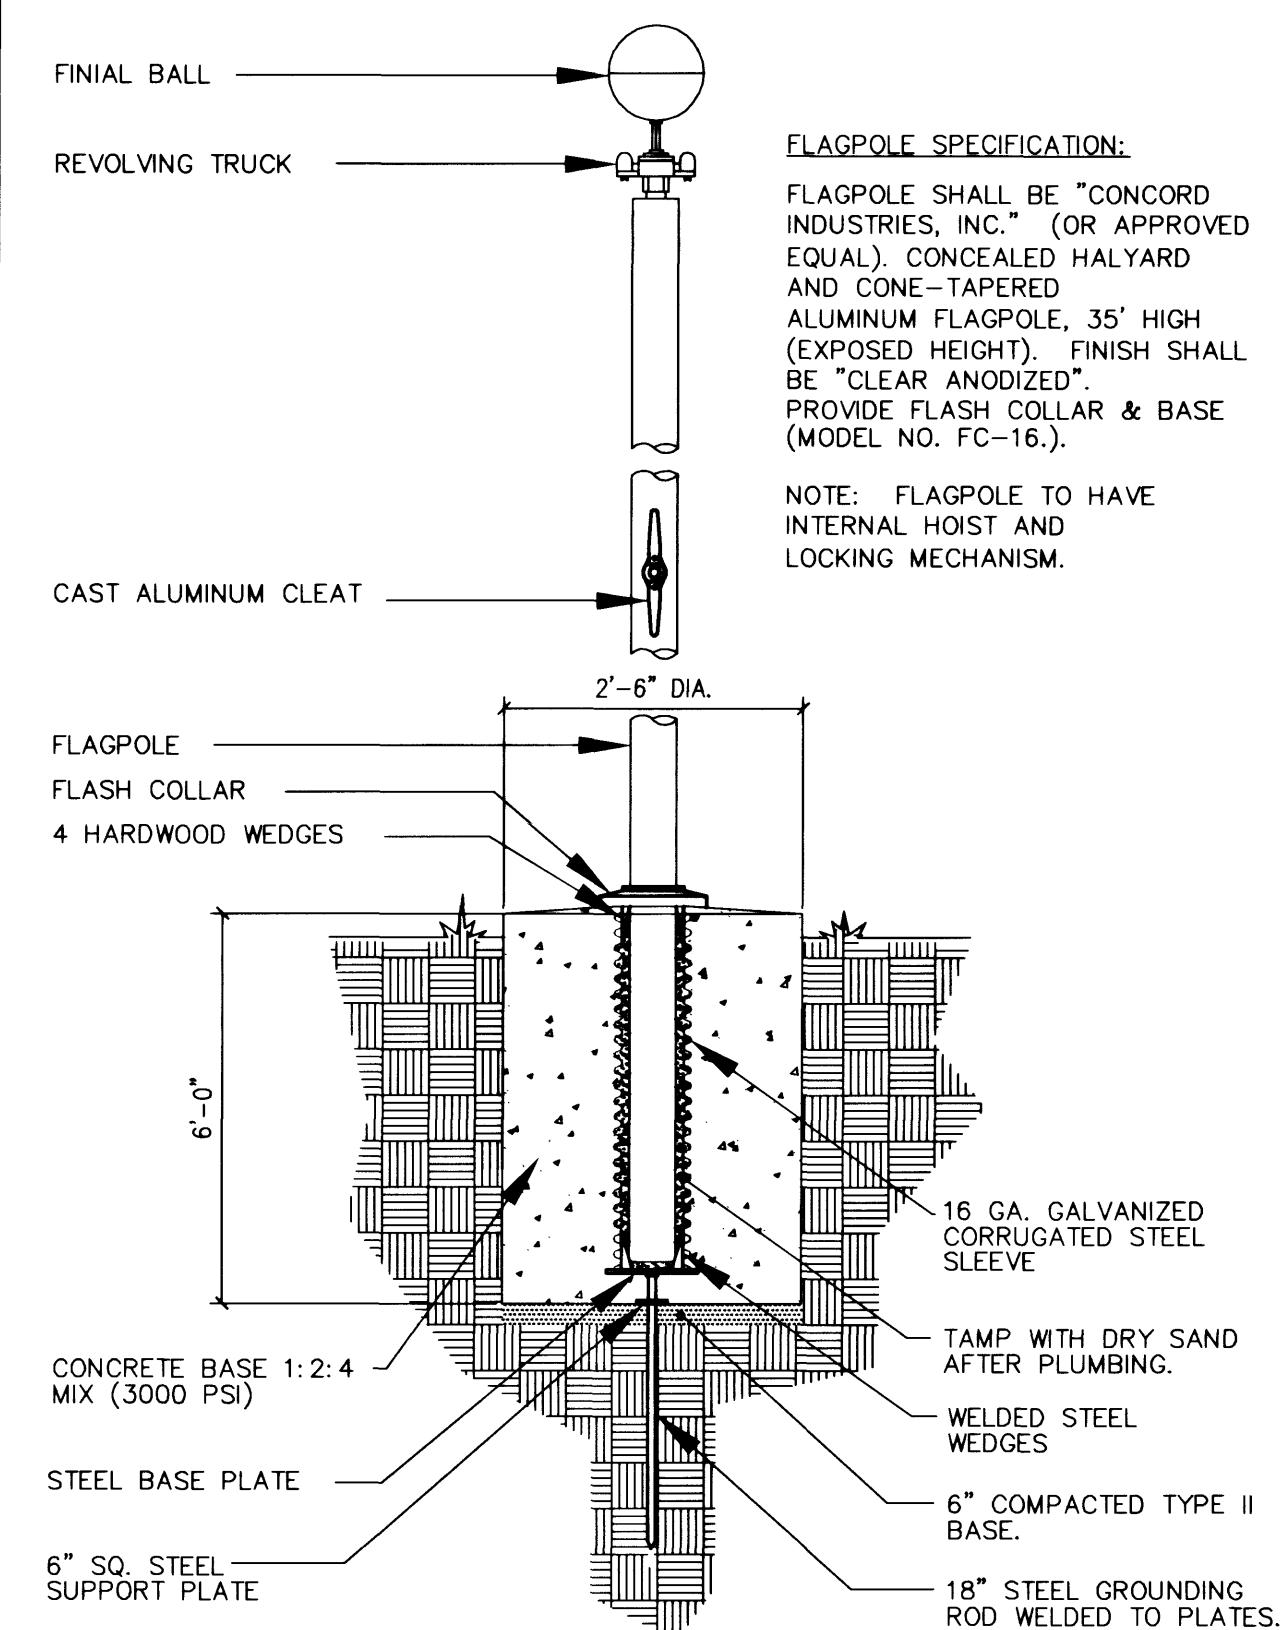


8 Flagpole Base Detail

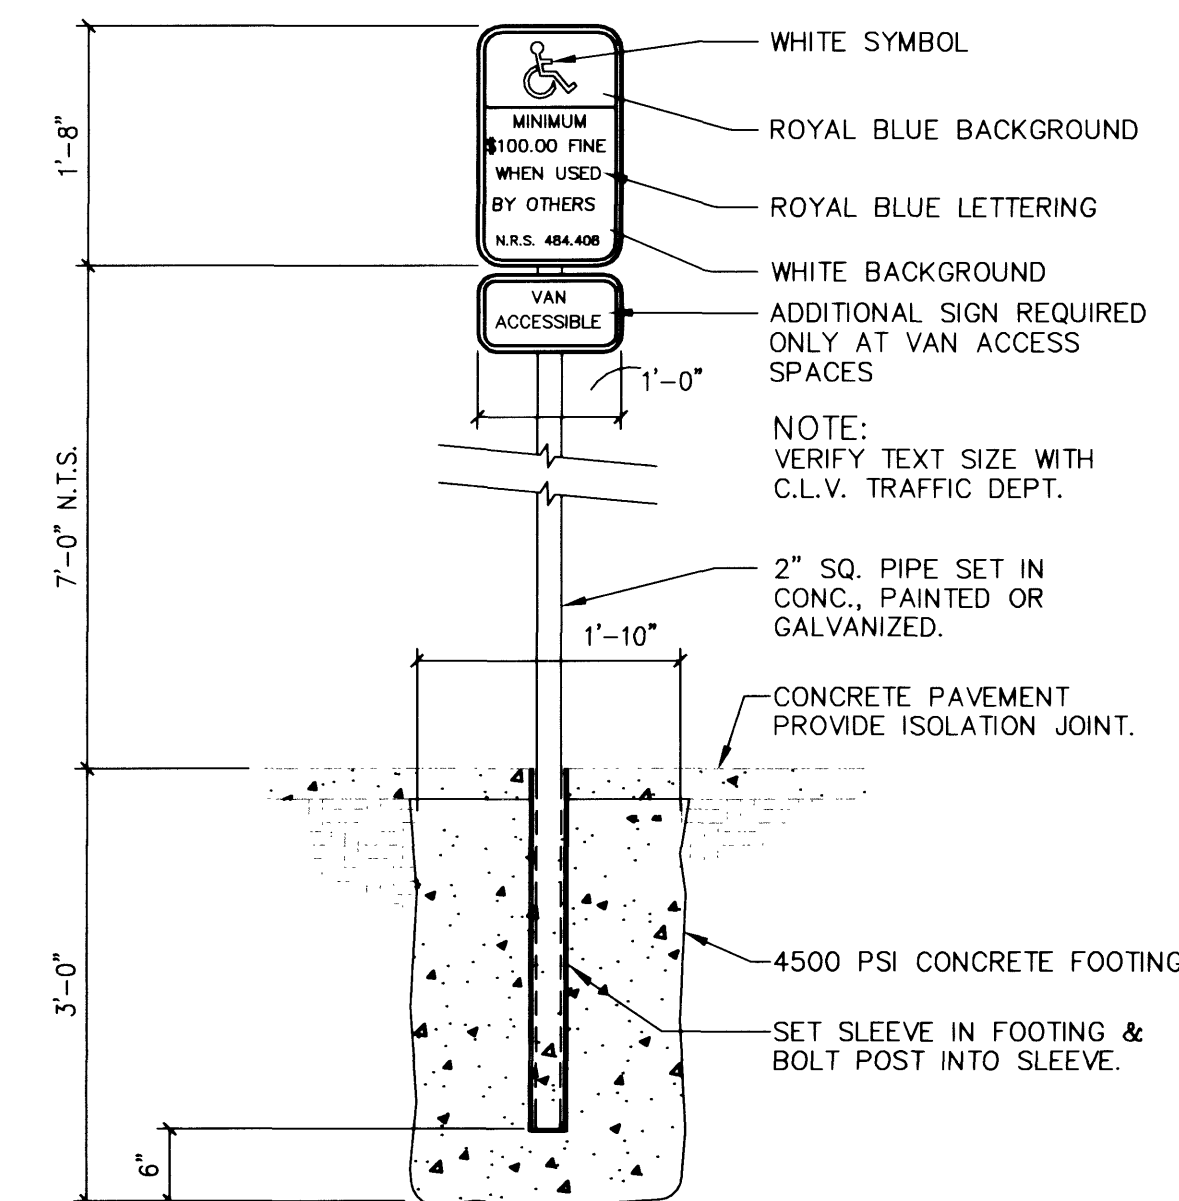

7 Handicap Accessibility Sign
Scale: 3/4" = 1'-0" 10426-01 AS2-09


[illegible]

PROJ NO:	99201F
DESIGN:	RAC/LG
DATE:	11/15/00
SCALE:	AS SHOWN
FILE:	FS10_15

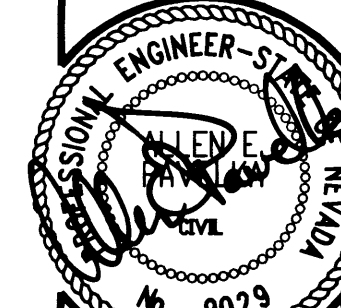

STAMP DATE: 01-10-01

AZTEC • ACEP ENGINEERING
3320 N Buffalo Dr. # 106, Las Vegas, NV 89129
Tel (702) 396-3426 Fax (702) 396-3758
Email: aztec@azteceng.com

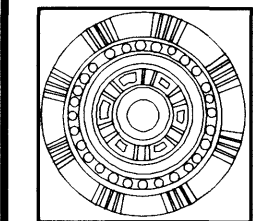


CITY OF LAS VEGAS


FIRE STATION NO. 10

CONSTRUCTION DETAILS I

 SHEET
C-15
15 OF 24 SHEETS
CLV DRAWING NO.
630-95



 
(8) Generator Enclosure - East Elevation



(9a) Generator Enclosure - South Elevation



 (9) Generator Enclosure - Plan View



(6) Flagpole Base Detail



(7) Handicap Accessibility Sign



CITY OF LAS VEGAS
DESIGN DIVISION
DESIGNATION: 10
CONSTRUCTION DETAILS II

CITY OF LAS VEGAS
DESIGN DIVISION
DESIGNATION: 10
CONSTRUCTION DETAILS II

C-15
CITY OF LAS VEGAS
DESIGN DIVISION
DESIGNATION: 10
CONSTRUCTION DETAILS II