


Kennedy/Jenks/Chilton
Consulting Engineers
3233 West Charleston Boulevard, Suite 110
Las Vegas, NV 89102

City of Las Vegas, Nevada
Department of
Design and Development
Thomas B. Graham, AICP, RLA, Director

REVISIONS	DATE


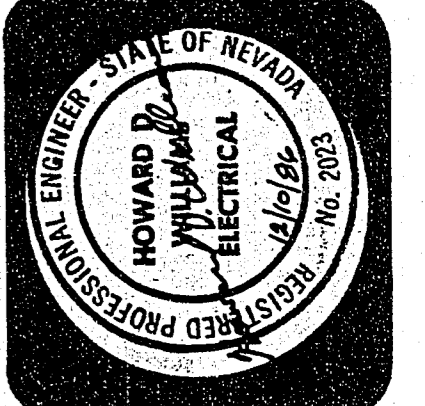


FREEDOM PARK PHASE VIII ELECTRICAL SITE PLAN

PROJECT NO.
WU 9034
DRAWING NO.
650.22-11
SHEET OF 15
E-1

Mojave Road

Washington Ave.

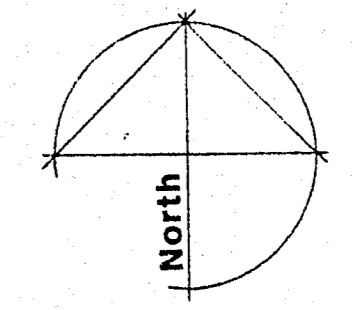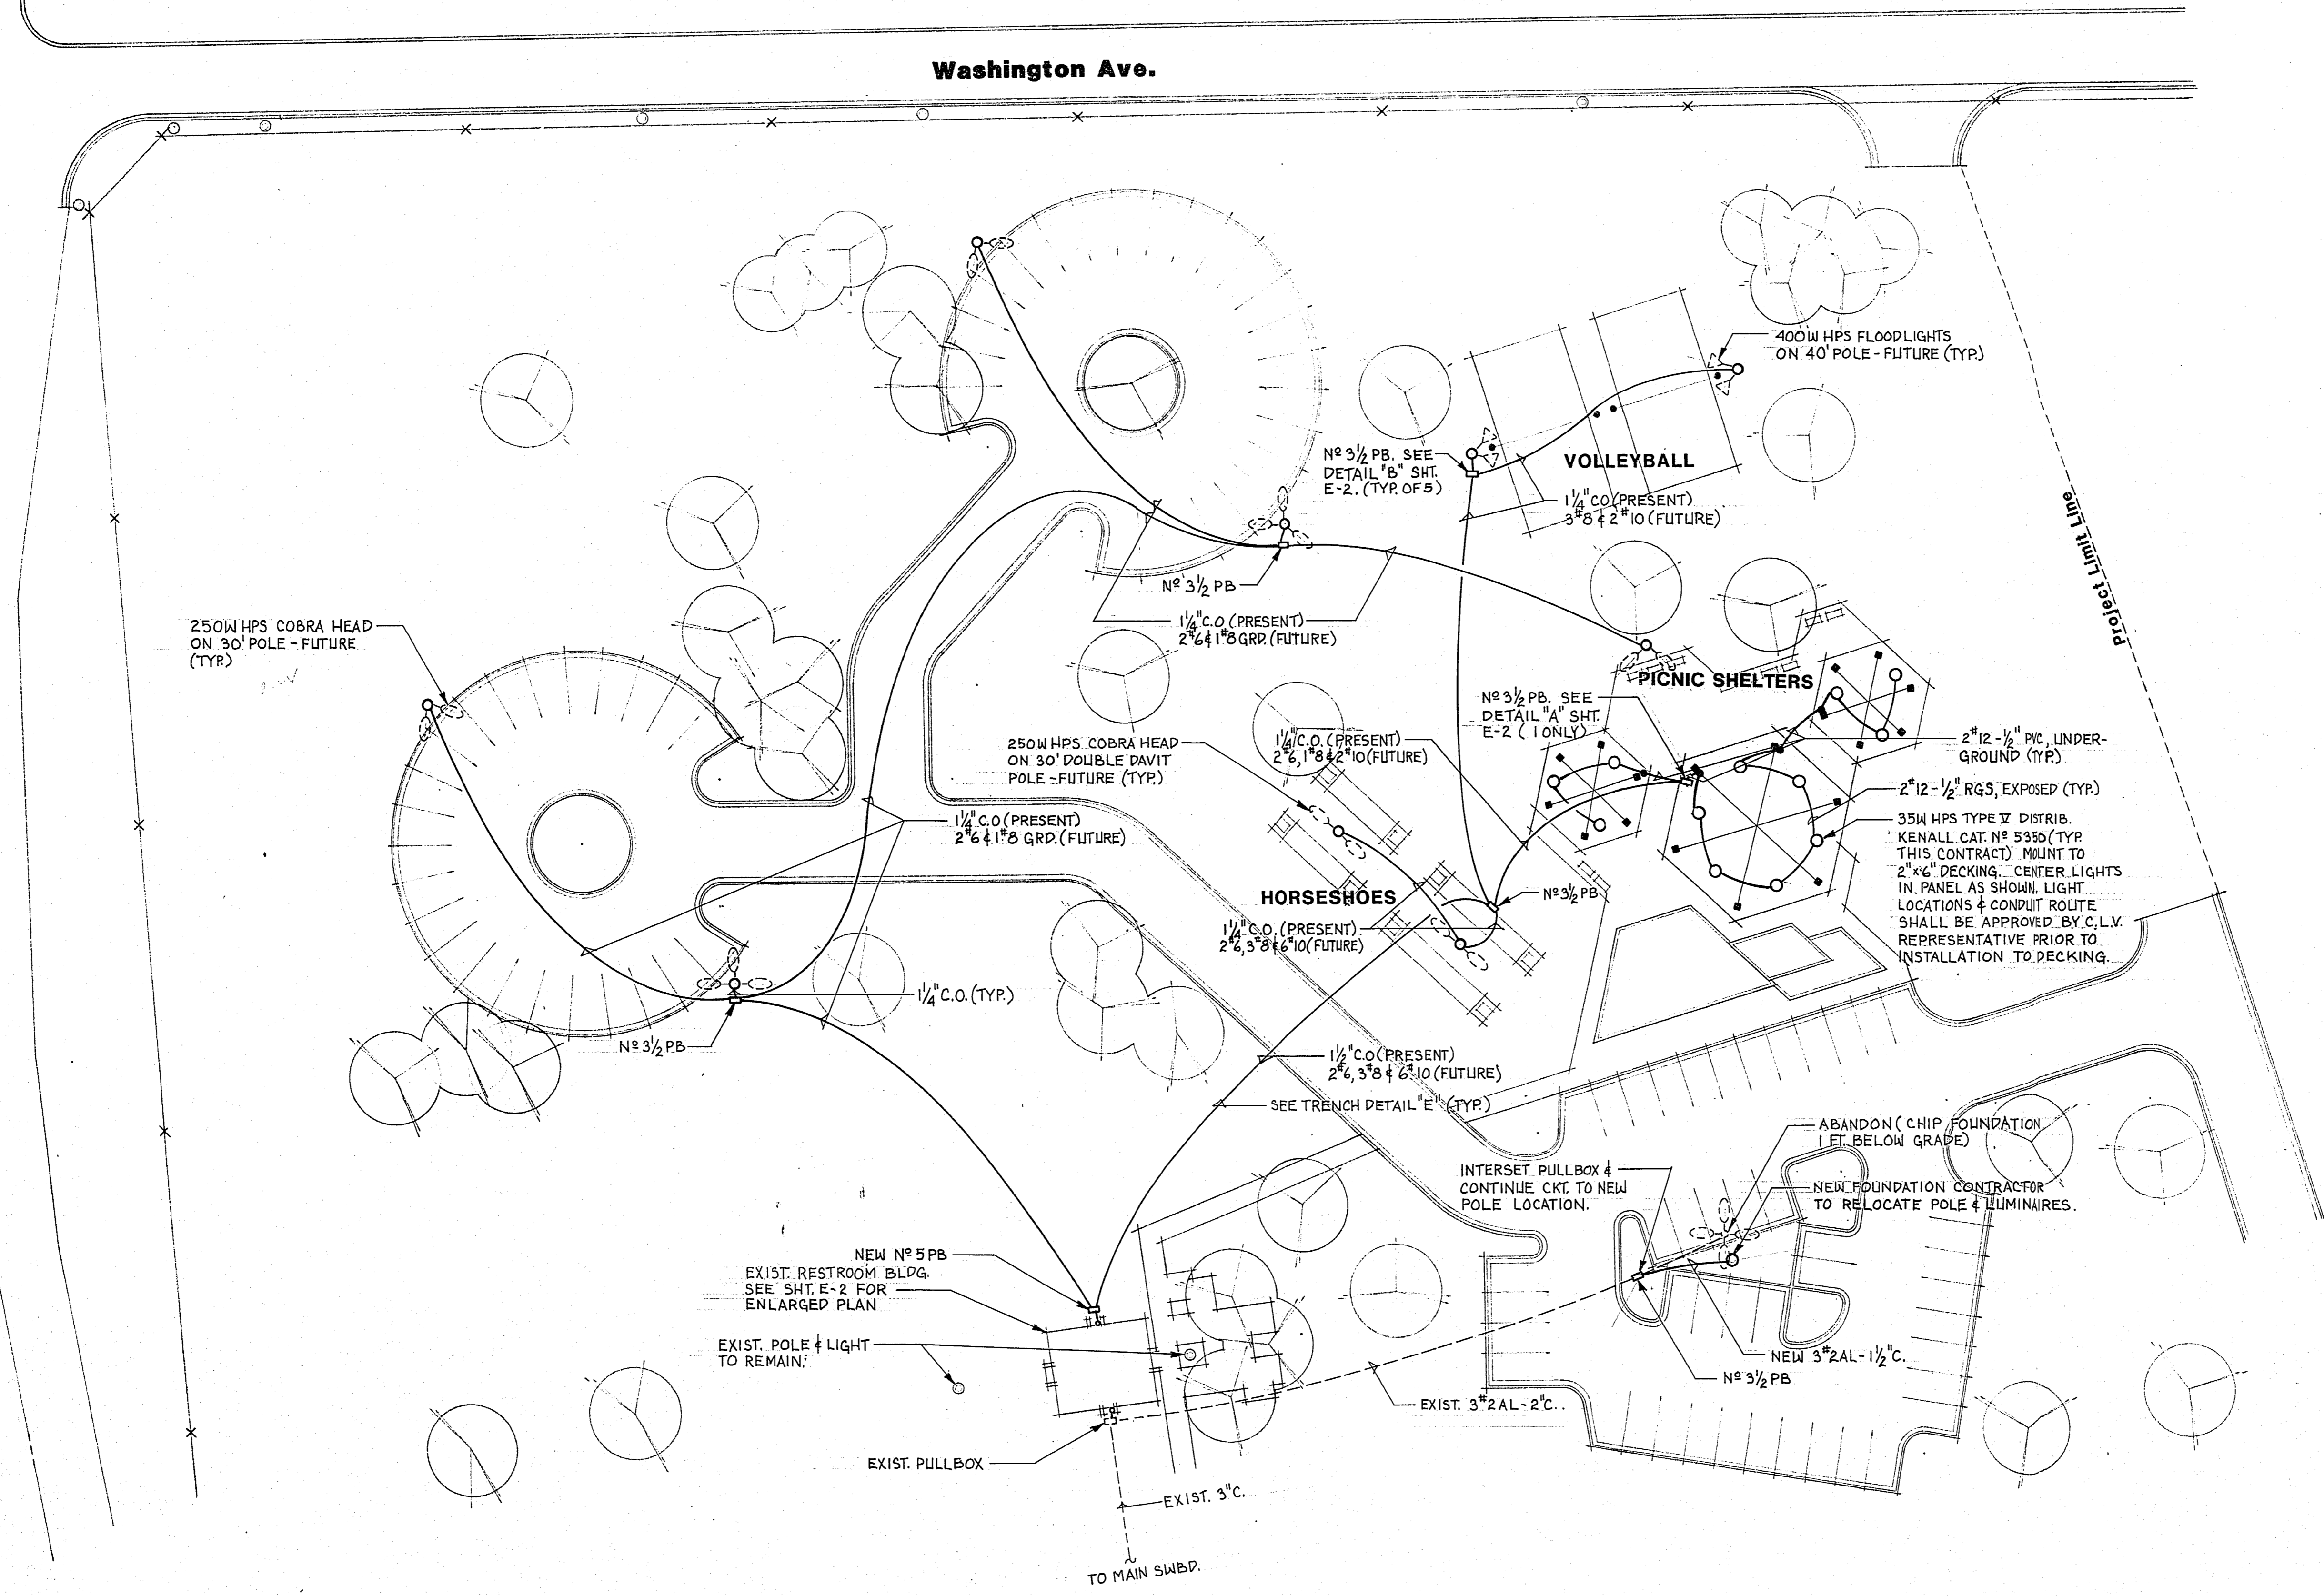

SITE PLAN
SCALE: 1"=30'