

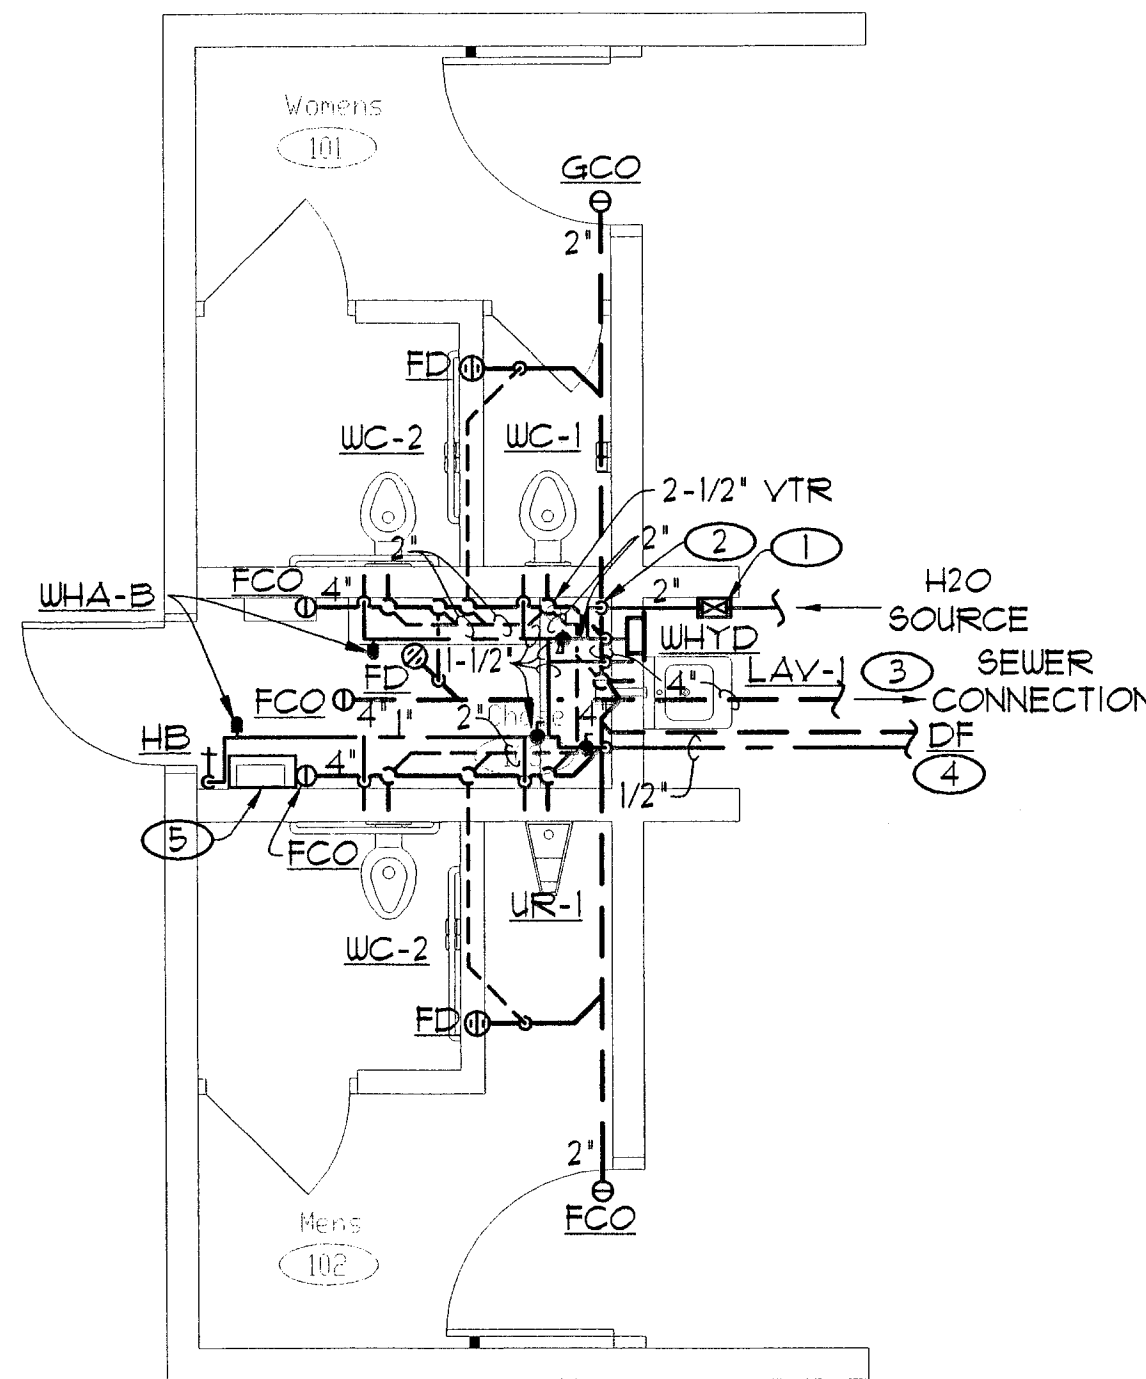
PLUMBING FIXTURE SCHEDULE							
MARK	FIXTURE	MANUFACTURER/ MODEL	ROUGH-IN SIZES				REMARKS
			CW	HW	SAN	VENT	
<u>WC-1</u>	WATER CLOSET	ACORN DURA-WARE 2100-W-1-CN-HS	1'	---	4'	2'	WALL HUNG BLOWOUT JET TOILET WITH SLOAN MODEL 952-16 FLUSH VALVE, HY-100-A ACTUATOR AND HINGED SEAT, HEAVY GAUGE TYPE 304 STAINLESS STEEL CONSTRUCTION. PROVIDE WITH ACORN #5395 ANCHORING ASSEMBLY. 16 G.P.F.
<u>WC-1</u>	WATER CLOSET (HANDICAPPED)	ACORN DURA-WARE 2100-ADA-W-1-CN-HS	1'	---	4'	2'	WALL HUNG BLOWOUT JET TOILET W/RIM @ 18" AFF WITH SLOAN MODEL 952-16 FLUSH VALVE, HY-100-A ACTUATOR AND HINGED SEAT, HEAVY GAUGE TYPE 304 STAINLESS STEEL CONSTRUCTION. 16 G.P.F.
<u>UR-1</u>	URINAL (HANDICAPPED)	ACORN FENAL-WARE 1105-W-1	1'	---	2'	1-1/2'	WALL HUNG STRADDLE TYPE WITH LIP AT 18" AFF WITH SLOAN MODEL 990-1-T FLUSH VALVE AND HY-100-A ACTUATOR, HEAVY GAUGE TYPE 304 STAINLESS STEEL CONSTRUCTION. 10 G.P.F.
<u>LAV-1</u>	LAVATORY (HANDICAPPED)	ACORN DURA-WARE 1953-ADA-1-DM5-3-GE	1/2"	---	2'	1-1/2'	WALL HUNG FRONT ACCESS LAVATORY WITH AIR CONTROL SINGLE TEMPERATURE PUSH BUTTON VALVE, HEAVY GAUGE TYPE 304 STAINLESS STEEL CONSTRUCTION. Ø.75 G.P.M. P-TRAP TO BE IN PLUMBING CHASE, LAV TO BE HUNG WITH BOLTS GOING THRU FULL DEPTH OF WALL.
<u>DF</u>	DRINKING FOUNTAIN	MDF 440DB	1/2"	---	2'	---	DUAL BOUL DRINKING FOUNTAIN WITH DIRECT BURY PEDESTAL. COLOR TO BE SELECTED BY ARCHITECT. INCLUDE VALVE BOX, VALVE AND PLUGGED TEE FOR DRAIN DOWN.
<u>FD</u>	FLOOR DRAIN	J.R. SMITH 2005-A	---	---	2'	1-1/2'	CAST IRON BODY WITH FLASHING COLLAR NICKEL BRONZE ADJUSTABLE STRAINER HEAD AND TRAP PRIMER CONNECTION. (TRAP PRIMER - PRECISION PLUMBING PRODUCTS 'PRIME RITE')
<u>HB</u>	HOSE BIBB	WOODFORD 24P	1/2"	---	---	---	NON-FREEZING WITH INTEGRAL VACUUM BREAKER
<u>WHYD</u>	WALL HYDRANT	J.R. SMITH 5509QT	3/4"	---	---	---	NON-FREEZING WITH INTEGRAL VACUUM BREAKER
<u>WHA</u>	WATER HAMMER ARRESTOR	J.R. SMITH HYDROTROL	---	---	---	---	SEE PLAN FOR PDI CATAGORY

PLUMBING LEGEND		
ABBR	SYMBOL	DESCRIPTION
S		SANITARY BELOW GRADE / FLOOR
V		VENT
CW		COLD WATER
VTR		VENT THRU ROOF
WCO		WALL CLEANOUT
GCO/FCO		GRADE / FLOOR CLEAN OUT
FD		FLOOR DRAIN
HB		HOSE BIBB
WHYD		WALL HYDRANT
GV		GATE VALVE
SOV		SHUT OFF VALVE
		RISER DOWN
		RISER UP
		DROP
		RISER UP
		BRANCH - TOP CONNECTION
		BRANCH - SIDE CONNECTION
		CAP ON END OF PIPE
DIA		DIAMETER
TYP		TYPICAL
MTD		MOUNTED
GPM		GALLONS PER MINUTE
W/		WITH
W/O		WITHOUT
REF		REFERENCE TO INFO. FOUND ON OTHER DRAWINGS
NIC		NOT IN CONTRACT

- ① SOV INSIDE CONCRETE VALVE BOX.
- ② 2' CW UP INSIDE PLUMBING CHASE TO BELOW ROOF.
- ③ REF. CIVIL PLANS FOR CONTINUATION.
- ④ REF. CIVIL PLANS FOR LOCATION OF DE.
- ⑤ PROVIDE ELECTRIC UNIT HEATER IN PLUMBING CHASE EQUAL TO MARKEL MDL. E6650, 500W @ 120/1/60 WITH BUILT IN THERMOSTAT.

1. REFER TO PLUMBING FIXTURE SCHEDULE FOR ANY UNMARKED ROUGH-IN SIZES.
2. SEAL ALL ROOF PENETRATIONS WATER TIGHT.
3. ALL PIPING NOT RUN UNDERGROUND TO BE EXPOSED INSIDE PLUMBING CHASE.
4. COORDINATE LOCATION OF SANITARY LINES WITH BUILDING FOOTINGS. REF. STRUCTURAL DRAWINGS.

RR-PI LEGEND, SCHEDULE AND PLUMBING PLAN

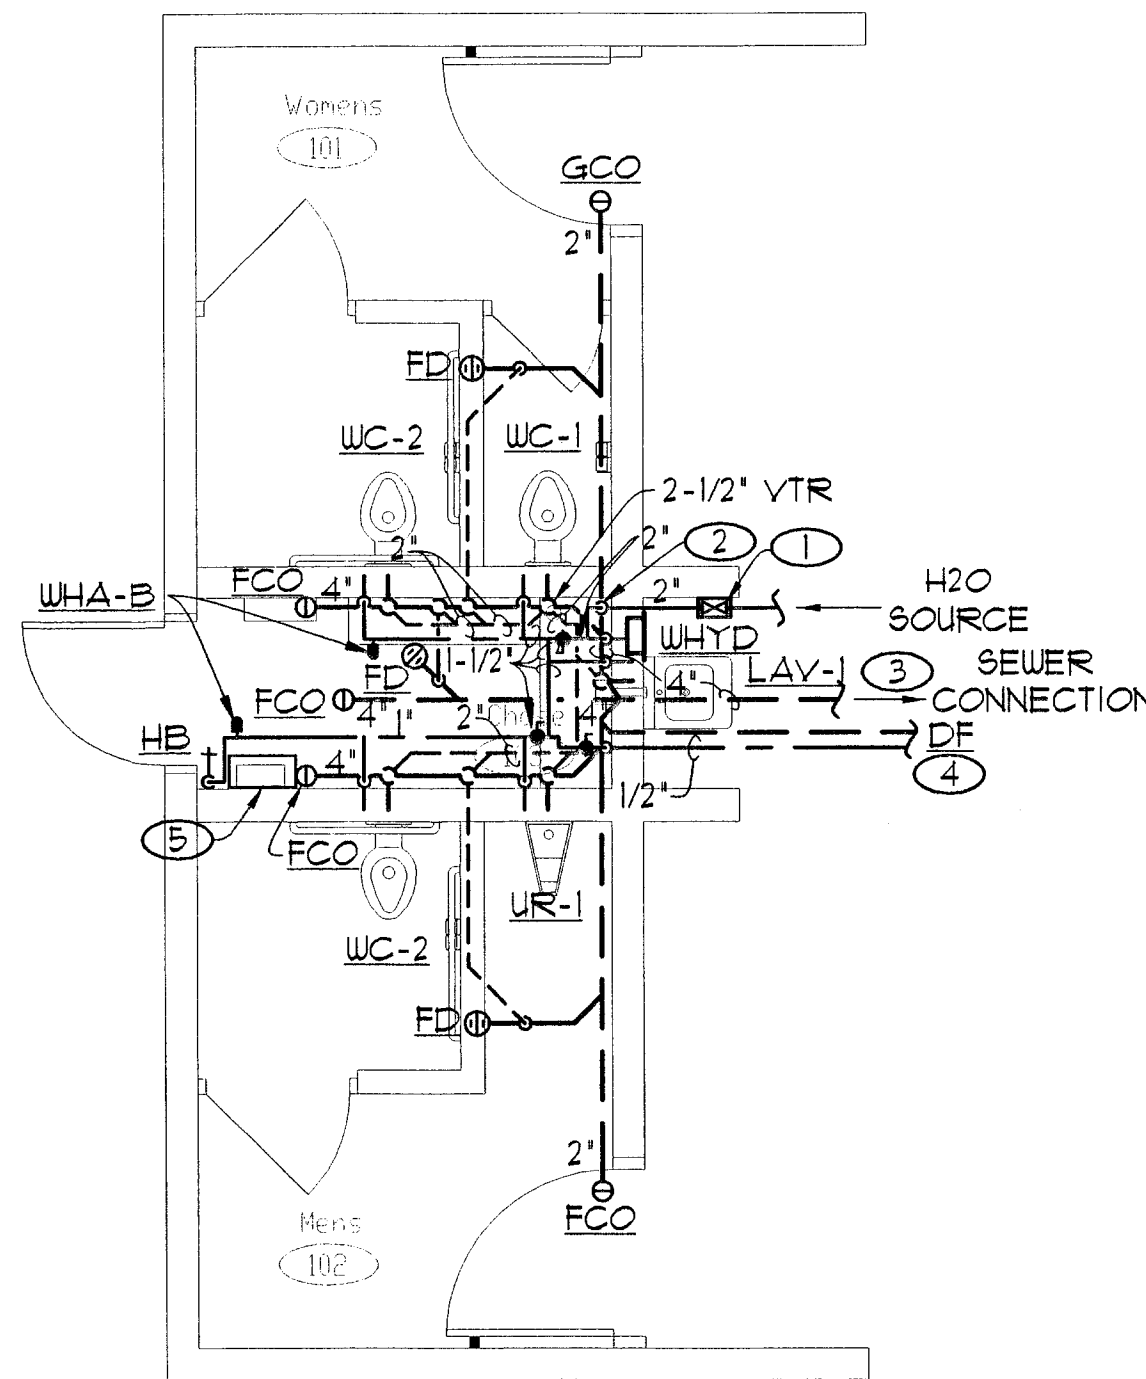

$$1/4^i = 1^i - \emptyset^i$$


PLUMBING LEGEND		
ABBR	SYMBOL	DESCRIPTION
S		SANITARY BELOW GRADE / FLOOR
V		VENT
CW		COLD WATER
VTR		VENT THRU ROOF
WCO		WALL CLEANOUT
GCO/FCO		GRADE / FLOOR CLEAN OUT
FD		FLOOR DRAIN
HB		HOSE BIBB
WHYD		WALL HYDRANT
GV		GATE VALVE
SOV		SHUT OFF VALVE
		RISER DOWN
		RISER UP
		DROP
		RISER UP
		BRANCH - TOP CONNECTION
		BRANCH - SIDE CONNECTION
		CAP ON END OF PIPE
DIA		DIAMETER
TYP		TYPICAL
MTD		MOUNTED
GPM		GALLONS PER MINUTE
W/		WITH
W/O		WITHOUT
REF		REFERENCE TO INFO. FOUND ON OTHER DRAWINGS
NIC		NOT IN CONTRACT

- ① SOV INSIDE CONCRETE VALVE BOX.
- ② 2' CW UP INSIDE PLUMBING CHASE TO BELOW ROOF.
- ③ REF. CIVIL PLANS FOR CONTINUATION.
- ④ REF. CIVIL PLANS FOR LOCATION OF DE.
- ⑤ PROVIDE ELECTRIC UNIT HEATER IN PLUMBING CHASE EQUAL TO MARKEL MDL. E6650, 500W @ 120/1/60 WITH BUILT IN THERMOSTAT.

1. REFER TO PLUMBING FIXTURE SCHEDULE FOR ANY UNMARKED ROUGH-IN SIZES.
2. SEAL ALL ROOF PENETRATIONS WATER TIGHT.
3. ALL PIPING NOT RUN UNDERGROUND TO BE EXPOSED INSIDE PLUMBING CHASE.
4. COORDINATE LOCATION OF SANITARY LINES WITH BUILDING FOOTINGS. REF. STRUCTURAL DRAWINGS.

RR-PI LEGEND, SCHEDULE AND PLUMBING PLAN

 

$$1/4^i = 1^i - \emptyset^i$$


AS-BUILT for *Gilmore Chft. Shadows Trail Head*
Street No. PP-1

AS-BUILT DRAWING

Sheet No. _____

CGRB Enterprises, Inc. has reviewed said drawing and does certify it has verified changes made during the project construction, and field construction criteria related thereto, or will do so, and has checked and coordinated the information within the drawing with the requirements of the Work provided in the Contract Documents.


Signed for the Contractor

11/26/07
Date

All Subcontractors to CGRB Enterprises, Inc. certify that they have reviewed and verified changes made during the project construction, and field construction criteria related thereto and have checked and coordinated the information within the drawing with the requirements of the Work provided in the Contract Documents.

Native Resources/Soil Tech.	Date Completed
Pod Foot Roofing	Date Completed
Pickardson Construction	Date Completed
Sage Construction	Date Completed
IASHD, Inc.	Date Completed

Gilmore Cliff Shadows Park & Trailhead Two Fixture Restroom		LEGEND, SCHEDULE AND PLUMBING PLANS				CONSULTANT ERG Inc. 6170 W. Village Road Las Vegas, Nevada 89103 Telephone 702/248.0338 Facsimile 702/248.0344 202-4497.00		REVISIONS	
---	--	---	--	---	--	---	--	------------------	--

**RECORD DRAWINGS
NOT FOR CONSTRUCTION**

1 TO ANY OTHERS. DOCUMENTS FOR ANOTHER PROJECT BY ANYONE OTHER THAN THE ORIGINAL ARCHITECT IS A VIOLATION OF THIS ACT.

2 THIS RECORD DRAWING HAS BEEN PREPARED IN PART, BASED ON INFORMATION FURNISHED BY THE GENERAL CONTRACTOR. THE ARCHITECT ASSUMES NO LIABILITY FOR THE ACCURACY OF THIS RECORD DRAWING FOR CONSTRUCTION. THE ARCHITECT ASSUMES NO LIABILITY FOR THE ACCURACY OF THIS RECORD DRAWING FOR CONSTRUCTION. THE ARCHITECT ASSUMES NO LIABILITY FOR THE ACCURACY OF THIS RECORD DRAWING FOR CONSTRUCTION.

3 INFORMATION THAT MAY BE INCLUDED WOULD BE SIGNIFICANT CHANGES TO THE PLANNING OF THE PROJECT. THE ARCHITECT ASSUMES NO LIABILITY FOR THE ACCURACY OF THIS RECORD DRAWING FOR CONSTRUCTION. THE ARCHITECT ASSUMES NO LIABILITY FOR THE ACCURACY OF THIS RECORD DRAWING FOR CONSTRUCTION.

**OWNER: CITY OF LAS VEGAS
DEPARTMENT OF PUBLIC WORKS
ARCHITECTURAL SERVICES**

**400 EAST STEWART AVENUE
LAS VEGAS, NEVADA 89101
PHONE: (702) 226-6535
FAX: (702) 362-5128
TELEX: (702) 362-5128**

DESIGN: SJF

DRAWN: 0404931 PI

DATE: 12/18/07

SCALE: AS NOTED

BID NO: 041534138

CLV DWG NO: 65083

SHEET NO: RR-P1

#2004497.00

last modified by sfeller on Sep 21, 2006 at 3:31pm

108626

PLANNING DIVISION
PLUMBING MECHANICAL
Building & Safety Dept.
City of Las Vegas, Nevada

Received 16 April 2001

Does Not Involve Alterations, Electrical
Shoring, or Off-Site
Impoundment, Single No Change
with minor work items
not a permit, not a permit, no permit