

GENERAL NOTE:

1. ALL PULLBOXES ARE NO. 3-1/2 UNO.

KEYED PLAN NOTES:

- ① LOCATION OF RESTROOM PANEL-TI. COORDINATE WITH RESTROOM DRAWINGS.
- ② (2) 4" C.O. PER NPGO REQUIREMENTS. COORDINATE WITH NPGO DRAWINGS. NPGO CONTACT IS DEAN DAMER.
- ③ 1" C.O. WITH FULLSTRING TO SPRINT PULLBOX. COORDINATE WITH SPRINT DRAWINGS.
- ④ (2) 4" C.O. W/ FULLROPE; 2" C.O. W/ FULLROPE.
- ⑤ SEE SINGLE LINE DIAGRAM ON SHEET E4.1 FOR CONDUIT & CONDUCTOR SIZES.
- ⑥ 3/4" C W (2)#10 & (1)#10 GRD (L1-3).
- ⑦ PULLBOX FOR FUTURE IRRIGATION PUMP.
- ⑧ PULLBOX FOR FUTURE IRRIGATION CONTROLLERS.
- ⑨ PULLBOX FOR SPRINT TELEPHONE CONNECTION TO FUTURE IRRIGATION CONTROLLER.
- ⑩ PULLBOX FOR FUTURE EXPANSION. ROUTE FUTURE CONDUITS TO THIS LOCATION.
- ⑪ ADD ALTERNATE #2: PULLBOX FOR IRRIGATION CONTROLLERS.
- ⑫ ADD ALTERNATE #2: PULLBOX FOR SPRINT TELEPHONE CONNECTION TO IRRIGATION CONTROLLER.


**RECORD DRAWINGS
NOT FOR CONSTRUCTION**

1. TO ALTER THESE DOCUMENTS FOR ANOTHER PROJECT BY ANYONE OTHER THAN THE ORIGINAL ARCHITECT IS A VIOLATION OF NRS 623.

2. THIS RECORD DRAWING HAS BEEN PREPARED IN PART, BASED UPON INFORMATION FURNISHED BY THE GENERAL CONTRACTOR, WHILE THIS INFORMATION IS BELIEVED TO BE RELIABLE, THE DESIGN PROFESSIONAL CANNOT ASSURE ITS ACCURACY, AND THUS IS NOT RESPONSIBLE FOR THE ACCURACY OF THIS RECORD DRAWING OR FOR ANY ERRORS OR OMISSIONS WHICH MAY HAVE BEEN INCORPORATED INTO IT AS A RESULT. THE DESIGN PROFESSIONAL CANNOT AND DOES NOT WARRANT THEIR ACCURACY.

3. INFORMATION THAT MAY BE INCLUDED WOULD BE SIGNIFICANT CHANGES TO PLANTING OR IRRIGATION LAYOUT PLANS AND ASSOCIATED DRAWINGS, MINOR DIMENSION OR CONSTRUCTION DETAIL CHANGES MAY NOT BE INCLUDED.

ENGINEER OF RECORD HAS PERFORMED ALL REQUIRED VOLTAGE DROP CALCULATIONS WITHIN THE SCOPE OF THIS PROJECT.

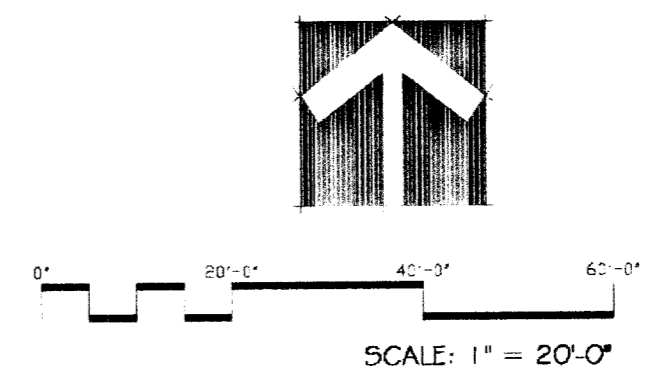

Avoid cutting underground utility lines. It's costly.

Call before you Dig.

1-800-227-2800
NATIONAL SERVICE ALERT (NSA)

108613 MATCHLINE SEE E2.2 FOR CONTINUATION

REVISIONS

10-22-07 CONTRACTOR CHANGES

CONSULTANT

Engineering Solutions
From Concept to Design

Professional Design Associates, Inc.
108 Market Street
Henderson, NV 89015
(702) 567-1022
email: pda@pdaacorp.com

City of Las Vegas
Gilmore Cliff Shadows Trail Head
ELECTRICAL SITE PLAN

OWNER: CITY OF LAS VEGAS
DEPARTMENT OF PUBLIC WORKS
ARCHITECTURAL SERVICES

400 EAST STEWART AVENUE
LAS VEGAS, NEVADA 89101
PHONE: (702) 229-8538
FAX: (702) 384-4846
TDD: (702) 386-9108

DRAWN: AP
FILE: L04-033.DWG
DATE: 12/18/07
SCALE: 1" = 20'-0"
SHEET NO: 06.1534.11
CLV DWG NO: 65083
SIT NO:

E2.1