


SERVICE FOR THIS WATER LINE SHALL BE MAINTAINED CONTINUOUSLY THROUGHOUT THE PERIOD OF THE CONSTRUCTION. THE PIPING SHALL BE EXCAVATED, SUPPORTED, AND BACKFILLED PER THE UTILITY PROVIDER'S REQUIREMENTS.

NOTE: CONTACT CLV FOR COORDINATION OF CONSTRUCTION WITH FUTURE IMPROVEMENTS TO THOM BLVD.

SERVICE FOR THIS WATER LINE SHALL BE MAINTAINED CONTINUOUSLY THROUGHOUT THE PERIOD OF THE CONSTRUCTION. THE PIPING SHALL BE EXCAVATED, SUPPORTED, AND BACKFILLED PER THE UTILITY PROVIDER'S REQUIREMENTS.


SCALE: 1"=40' HORIZ.
1"=4' VERT.

GOWAN ROAD

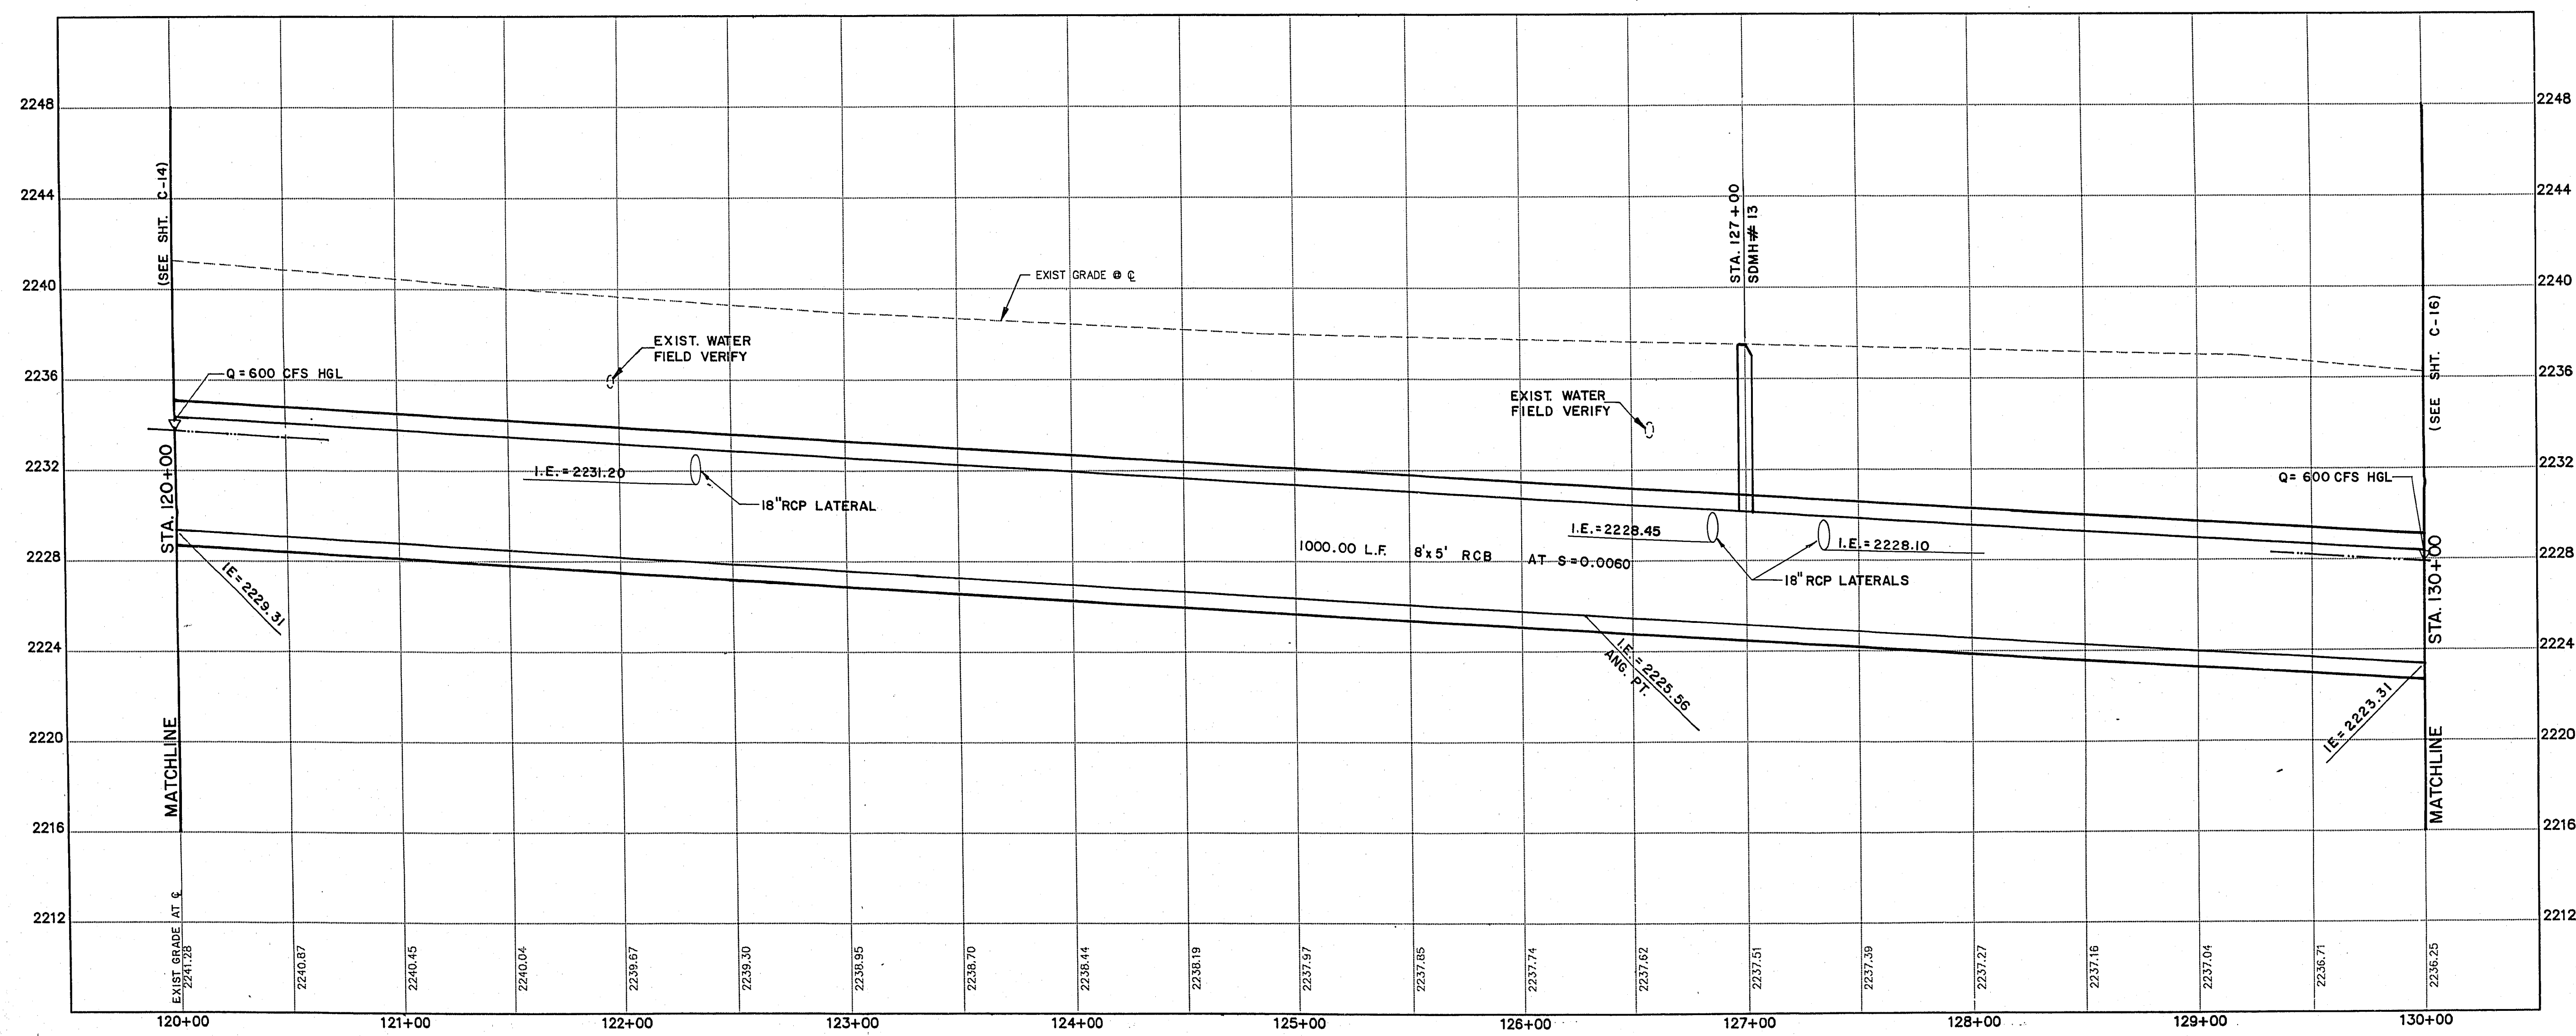

NO.	DATE	REVISION

POGGEMEYER DESIGN GROUP
SURVEYORS
PLANNERS
ENGINEERS
LAS VEGAS, NEVADA 89104 (702) 735-5108
1140 ALMOND TREE LANE, SUITE 306

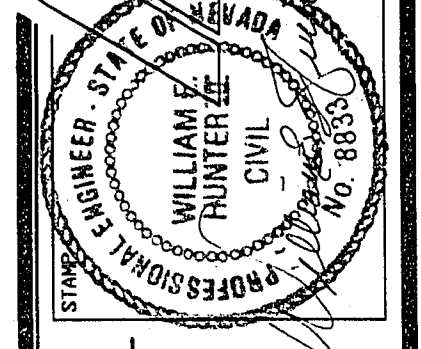

PLAN AND PROFILE
GOWAN
OUTFALL
STA 120+00 - STA 130+00

JOB NUMBER	90081
DESIGNED BY	WH
DRAWN BY	PA/AC
CHECKED BY	TP
DATE	3-25-91

SHEET NUMBER
C-15
15 of 20