
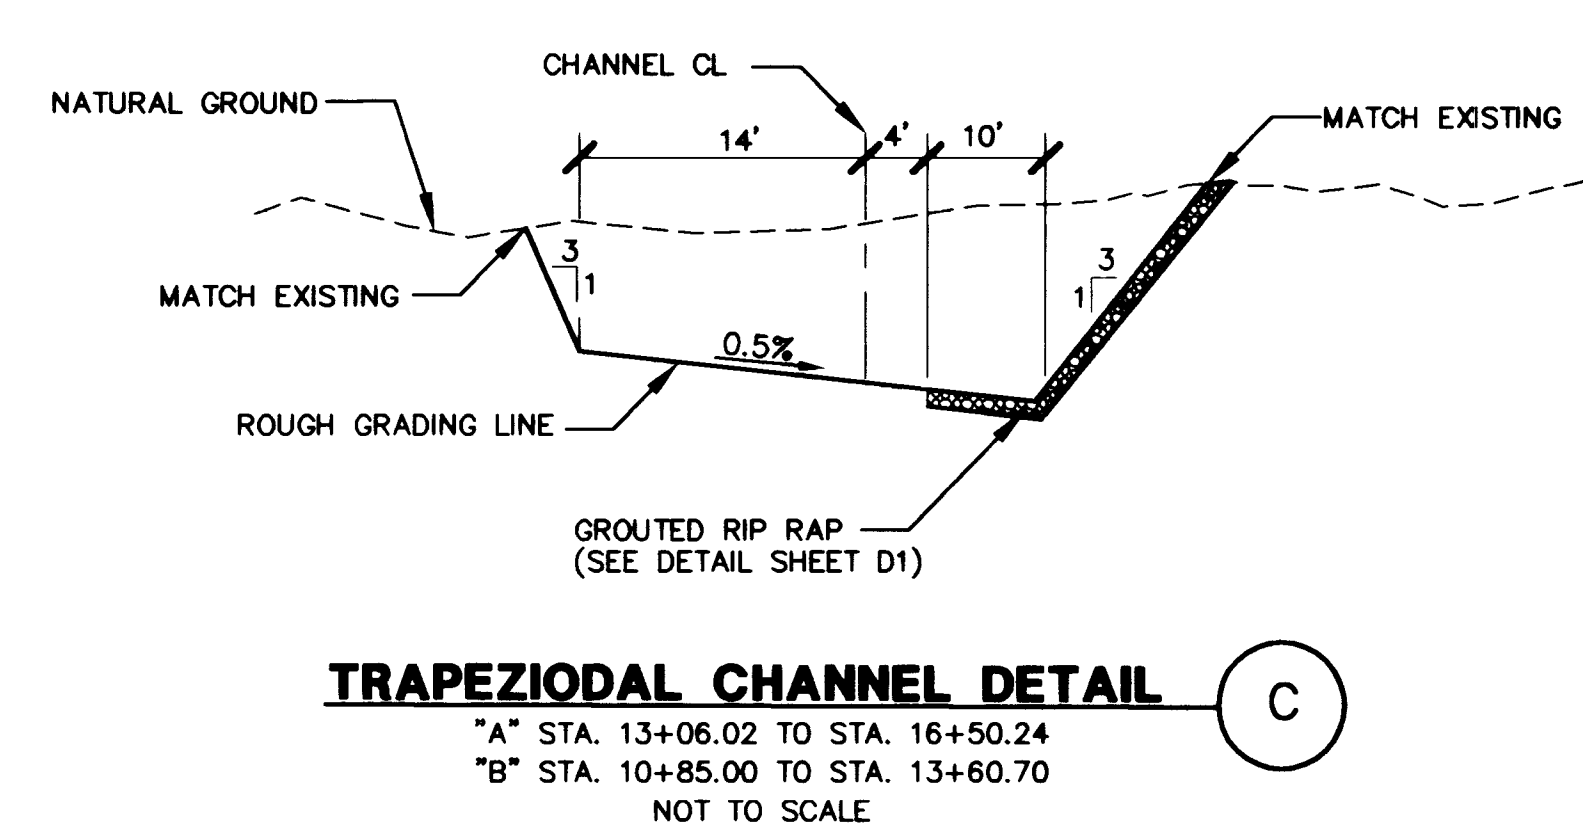
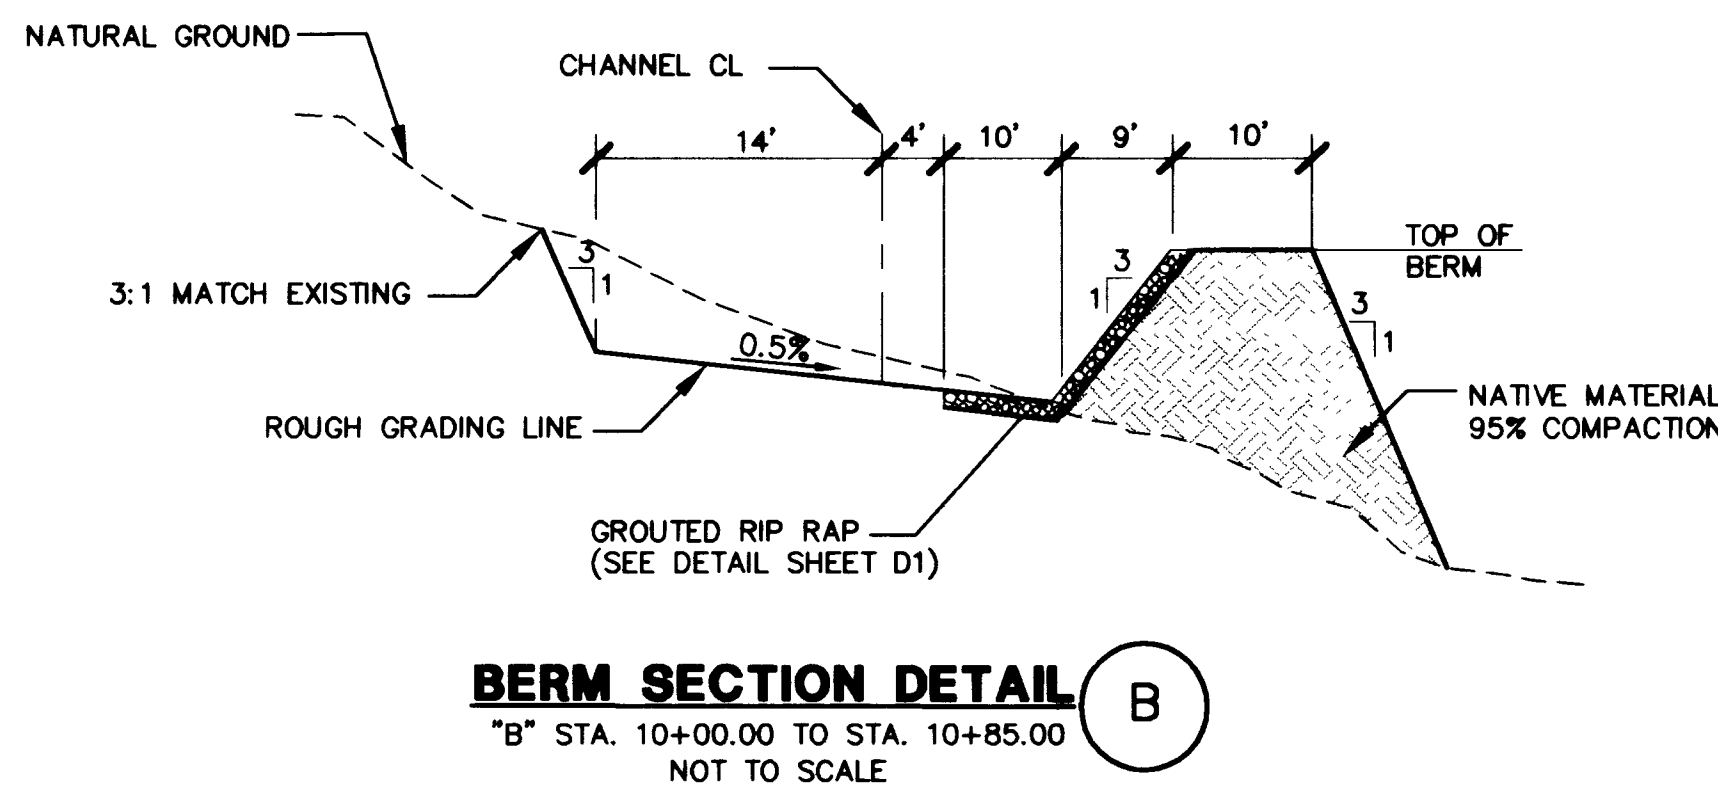
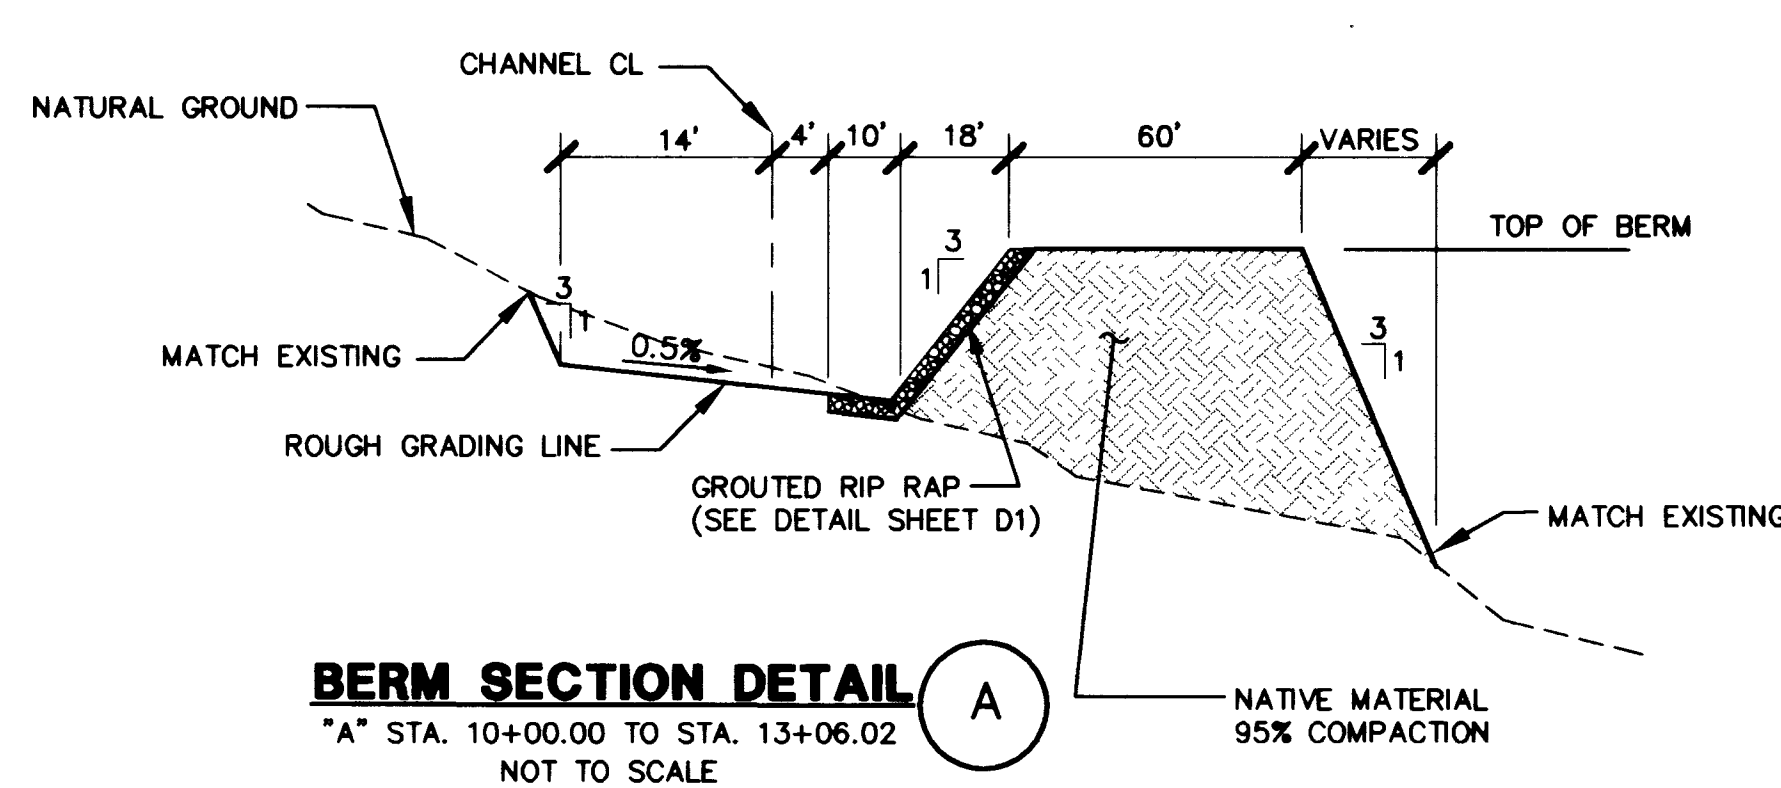
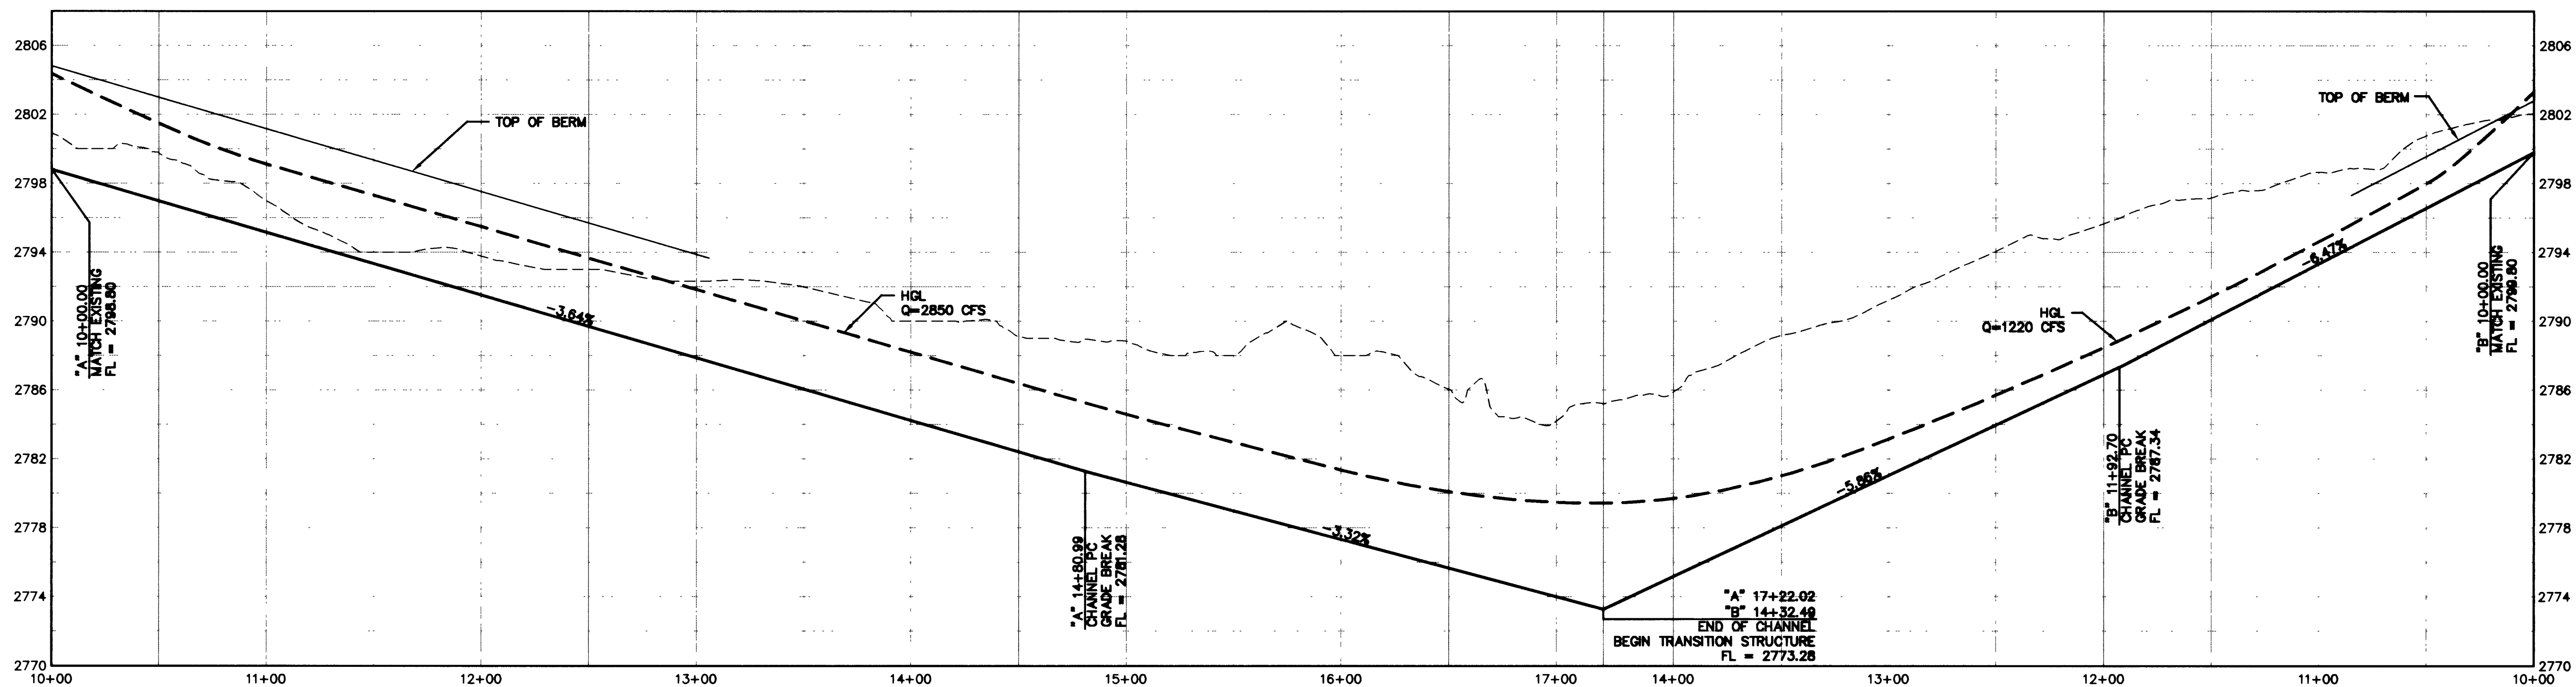


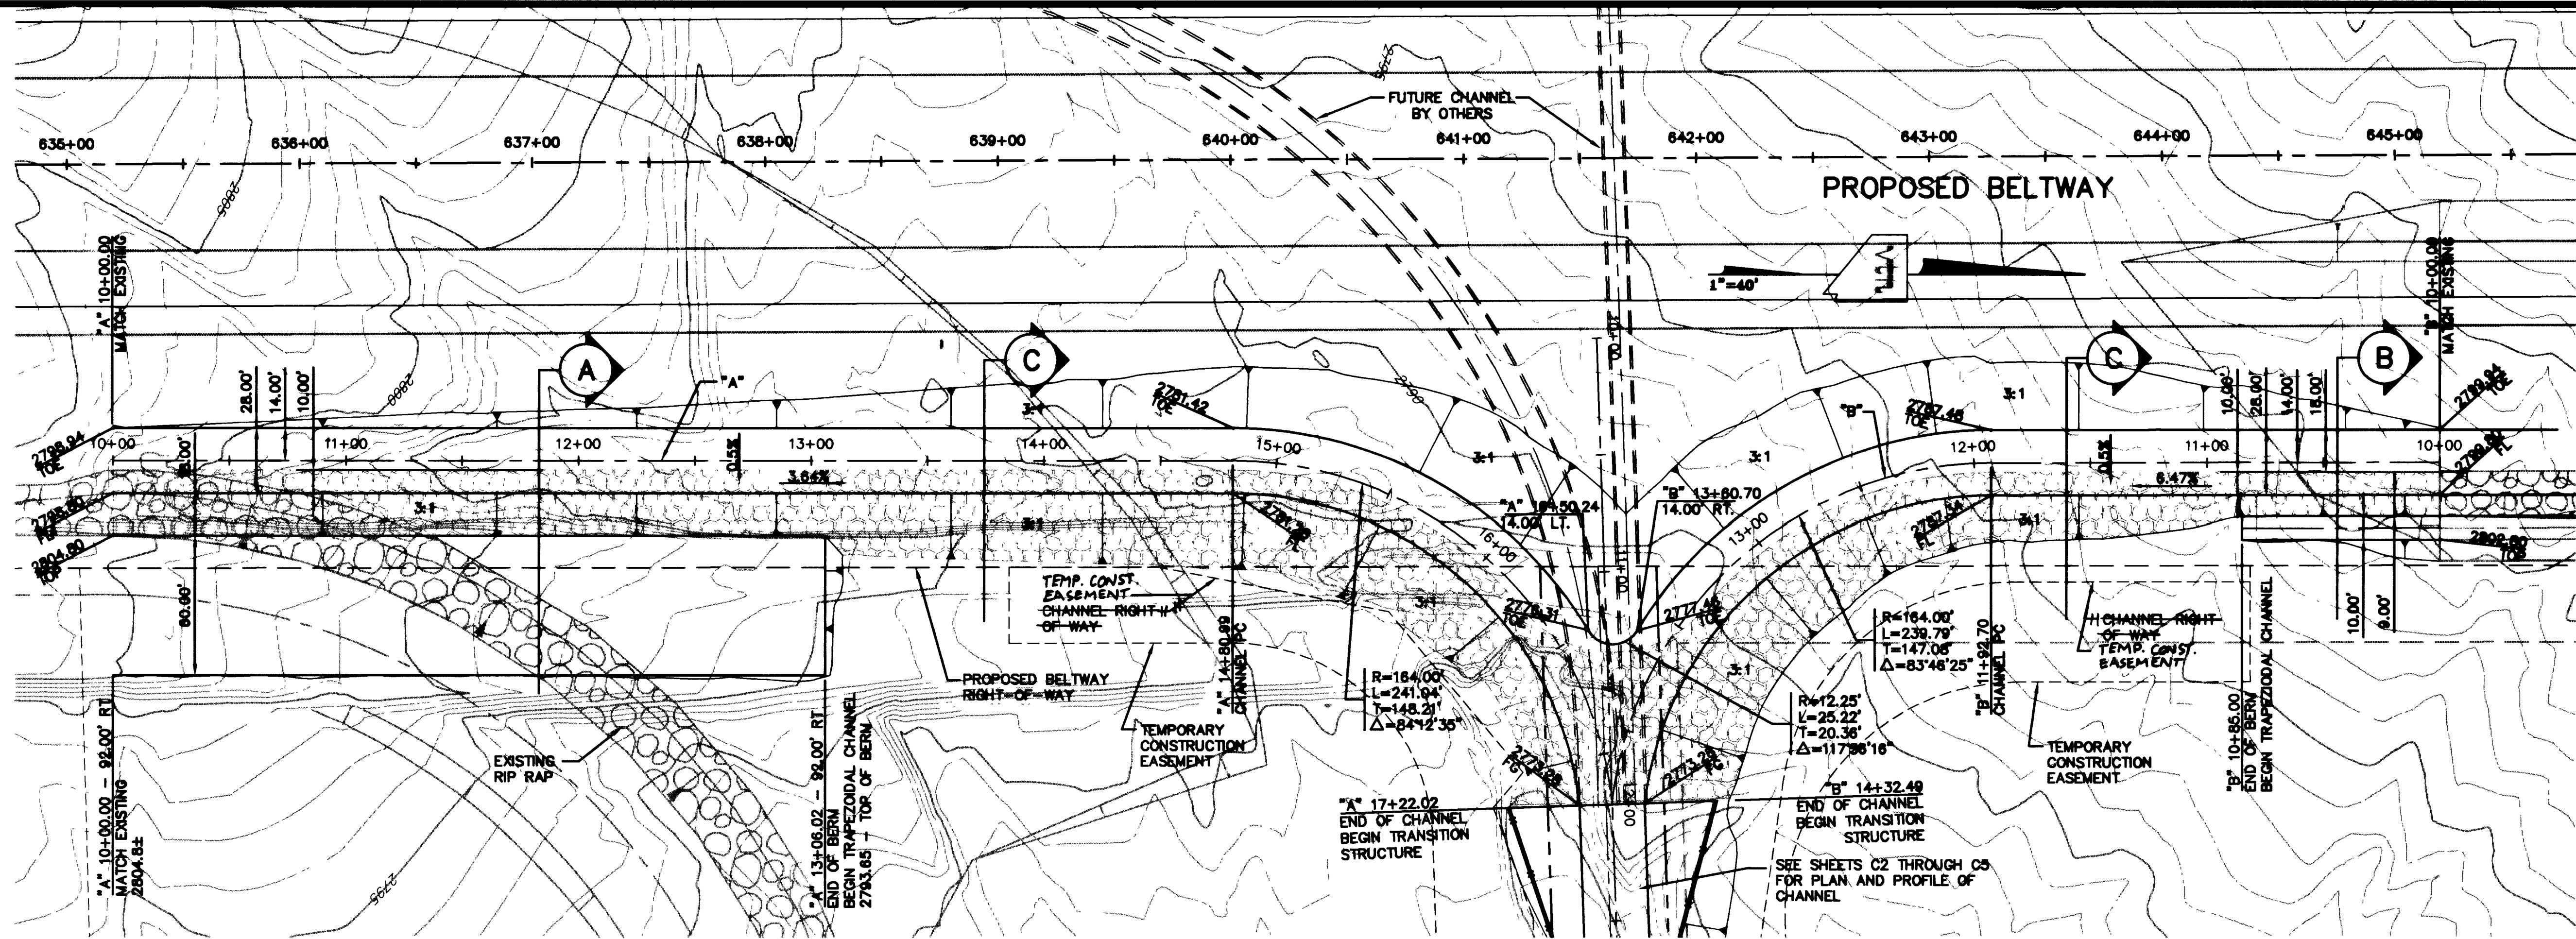

Avoid cutting underground utility lines. It's costly.
 2 working days
Call before you Dig
 1-800-227-2600
 Underground Service Alert (U.S.A.)

PERMA-BILT HOMES 7150 POLLOCK DRIVE SUITE 104 LAS VEGAS, NEVADA 89119 (702) 886-9100		2727 SOUTH RAINBOW BOULEVARD LAS VEGAS, NEVADA 89102-5148 PH. (702) 873-7550 FAX (702) 362-2597 CONSULTING ENGINEERS • PLANNERS • LAND SURVEYORS vtm nevada	
SHEET FLOOD CONTROL CHANNEL INTERIM GRADING PLAN		TITLE GILMORE CHANNEL FLOOD CONTROL IMPROVEMENTS	
DRAWN BY: DUB/BKP	DESIGNED BY: 12/10/99	CHECKED BY: 12/10/99	PROJECT NO: 5093
SCALE: 1"=40' HORIZ. 1"=40' VERT.		SHEET 61 OF 22 SHEETS DRAWING NO. 731-74	