



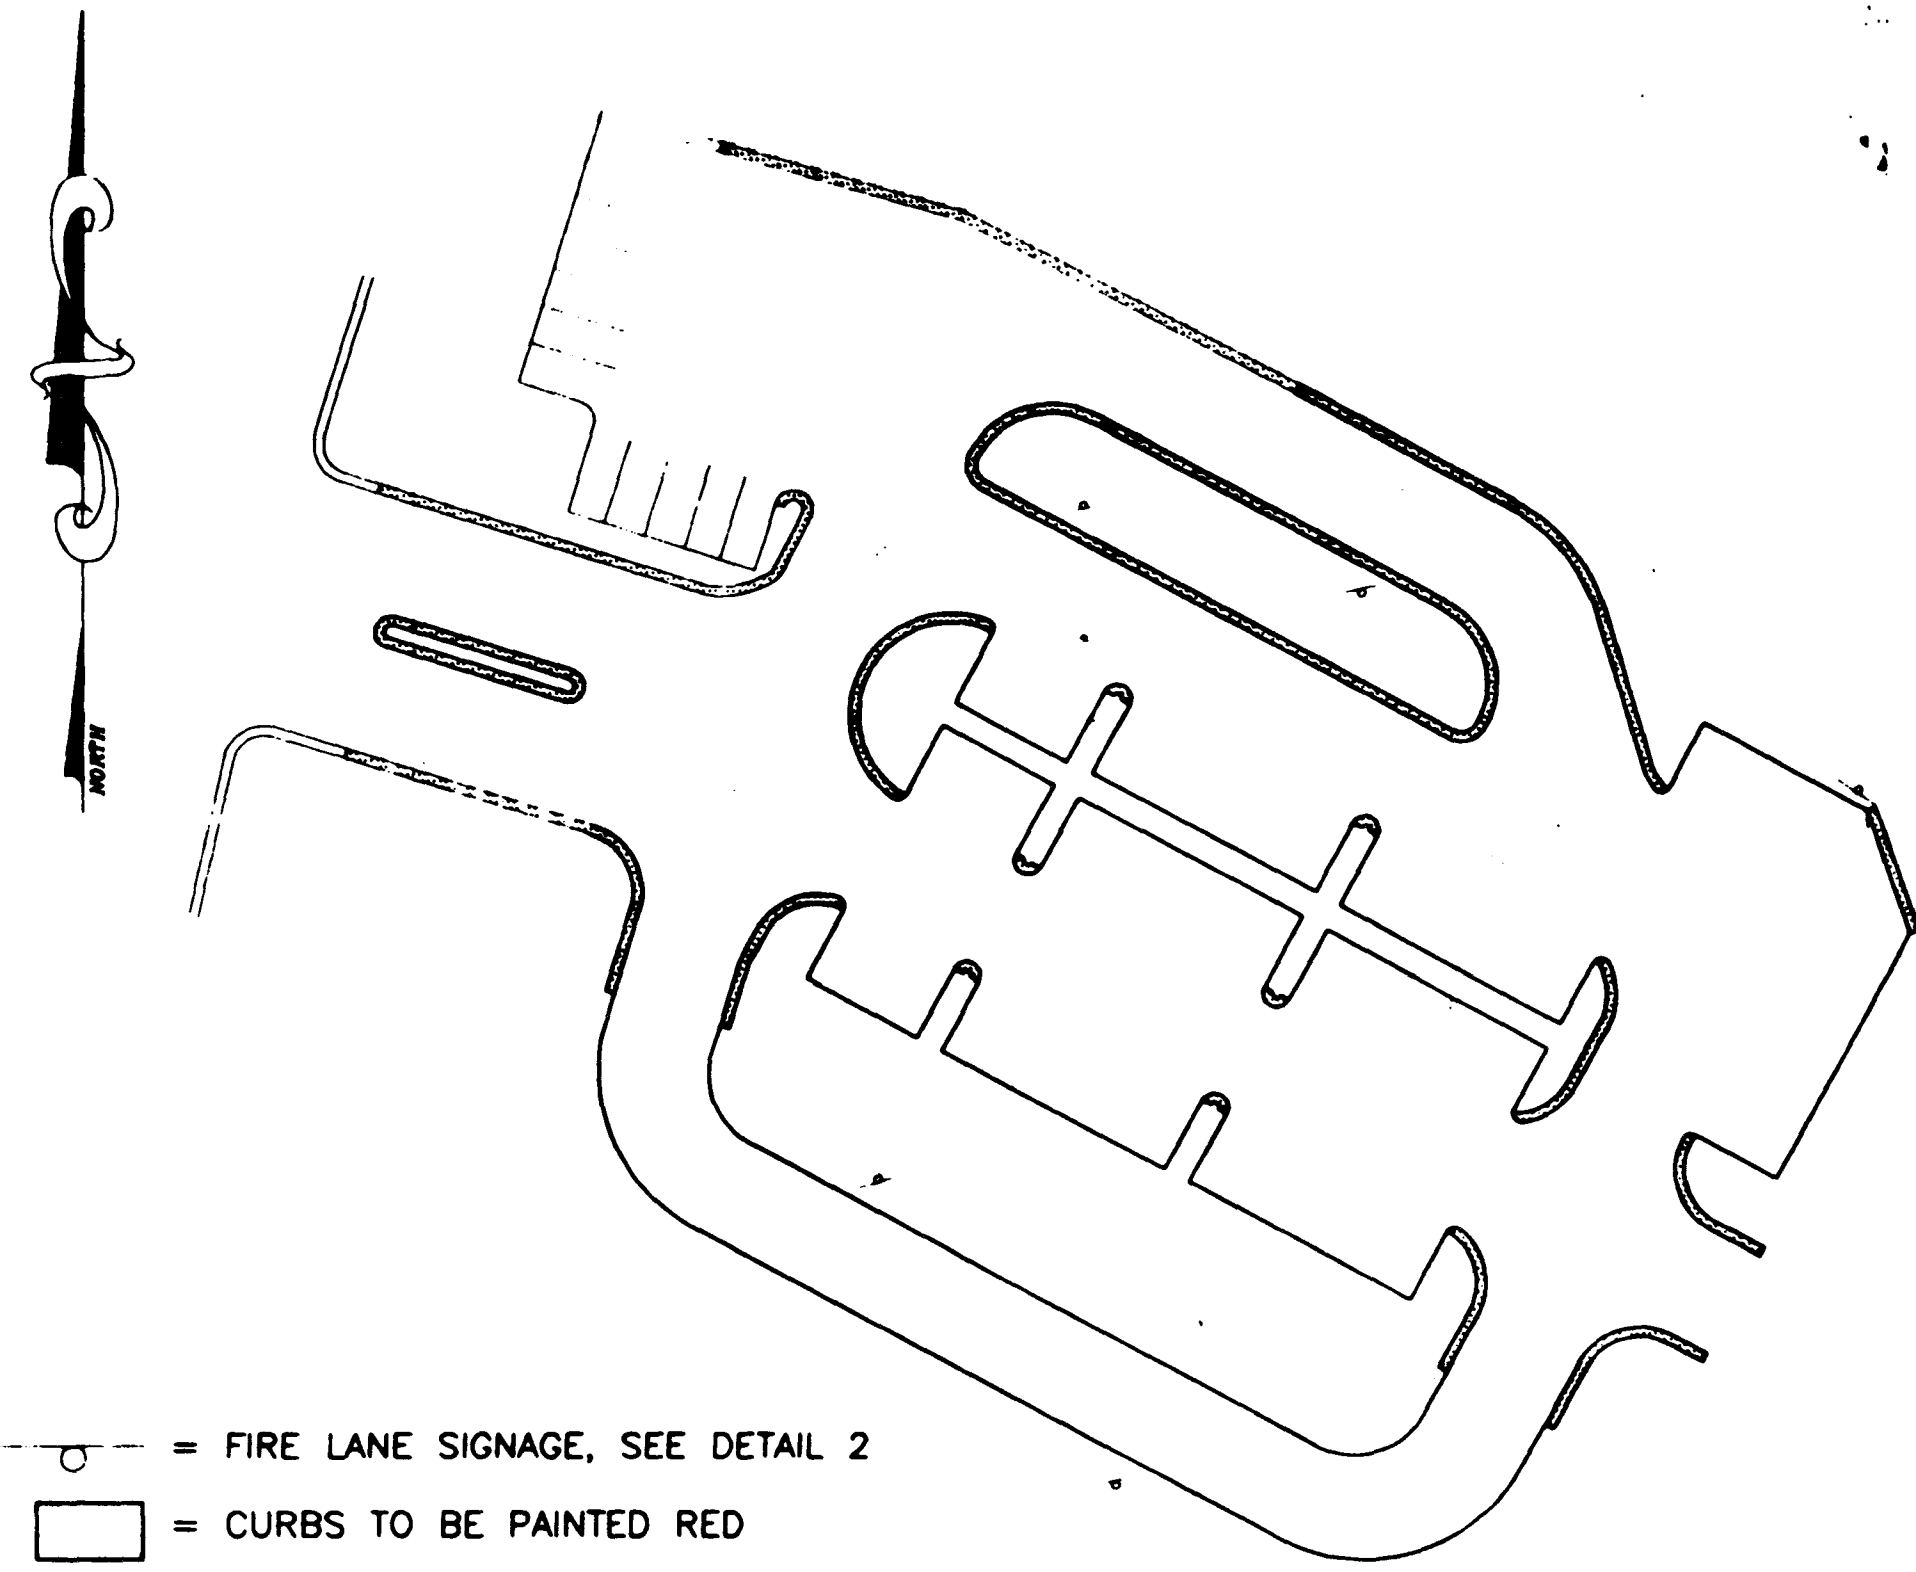


"NO PARKING" ZONES
NTS

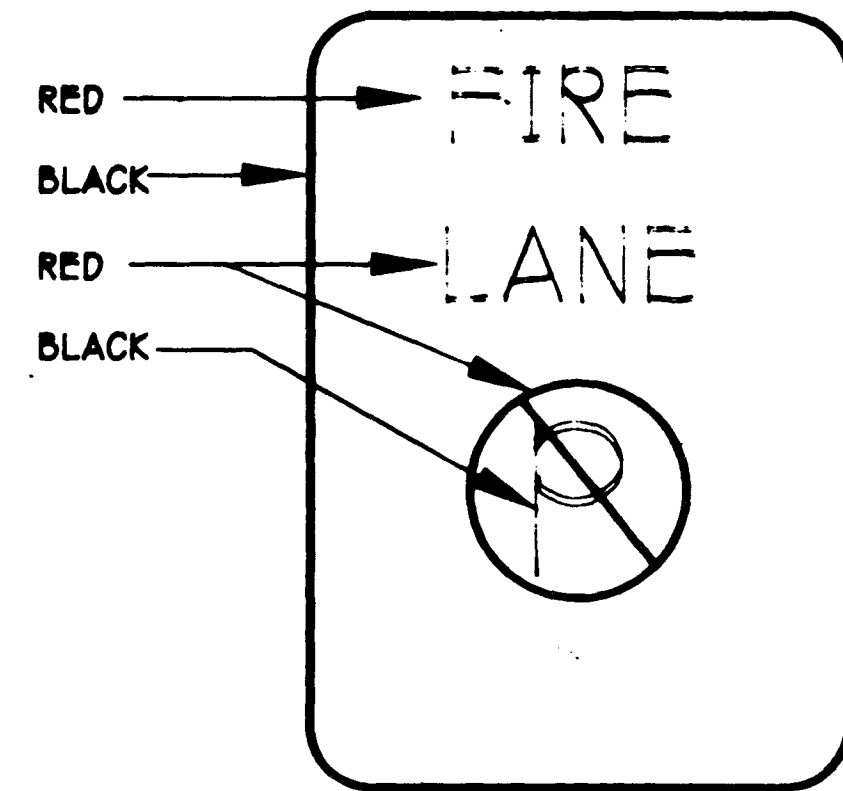

MINIMUM SPECIFICATIONS OF "NO PARKING FIRE LANE SIGNS"
 SIZE: 1' wide X 1 1/2' long or 2' wide X 2 1/2' long as required
 COLOR: Red and black on white luminous background (see above example)
 SYMBOL: International No Parking Symbol
 HEIGHT: To be installed not less than seven (7) feet nor more than ten (10) feet from ground level.


FIRE LANE SIGNAGE

2
C6
NTS
DETAIL

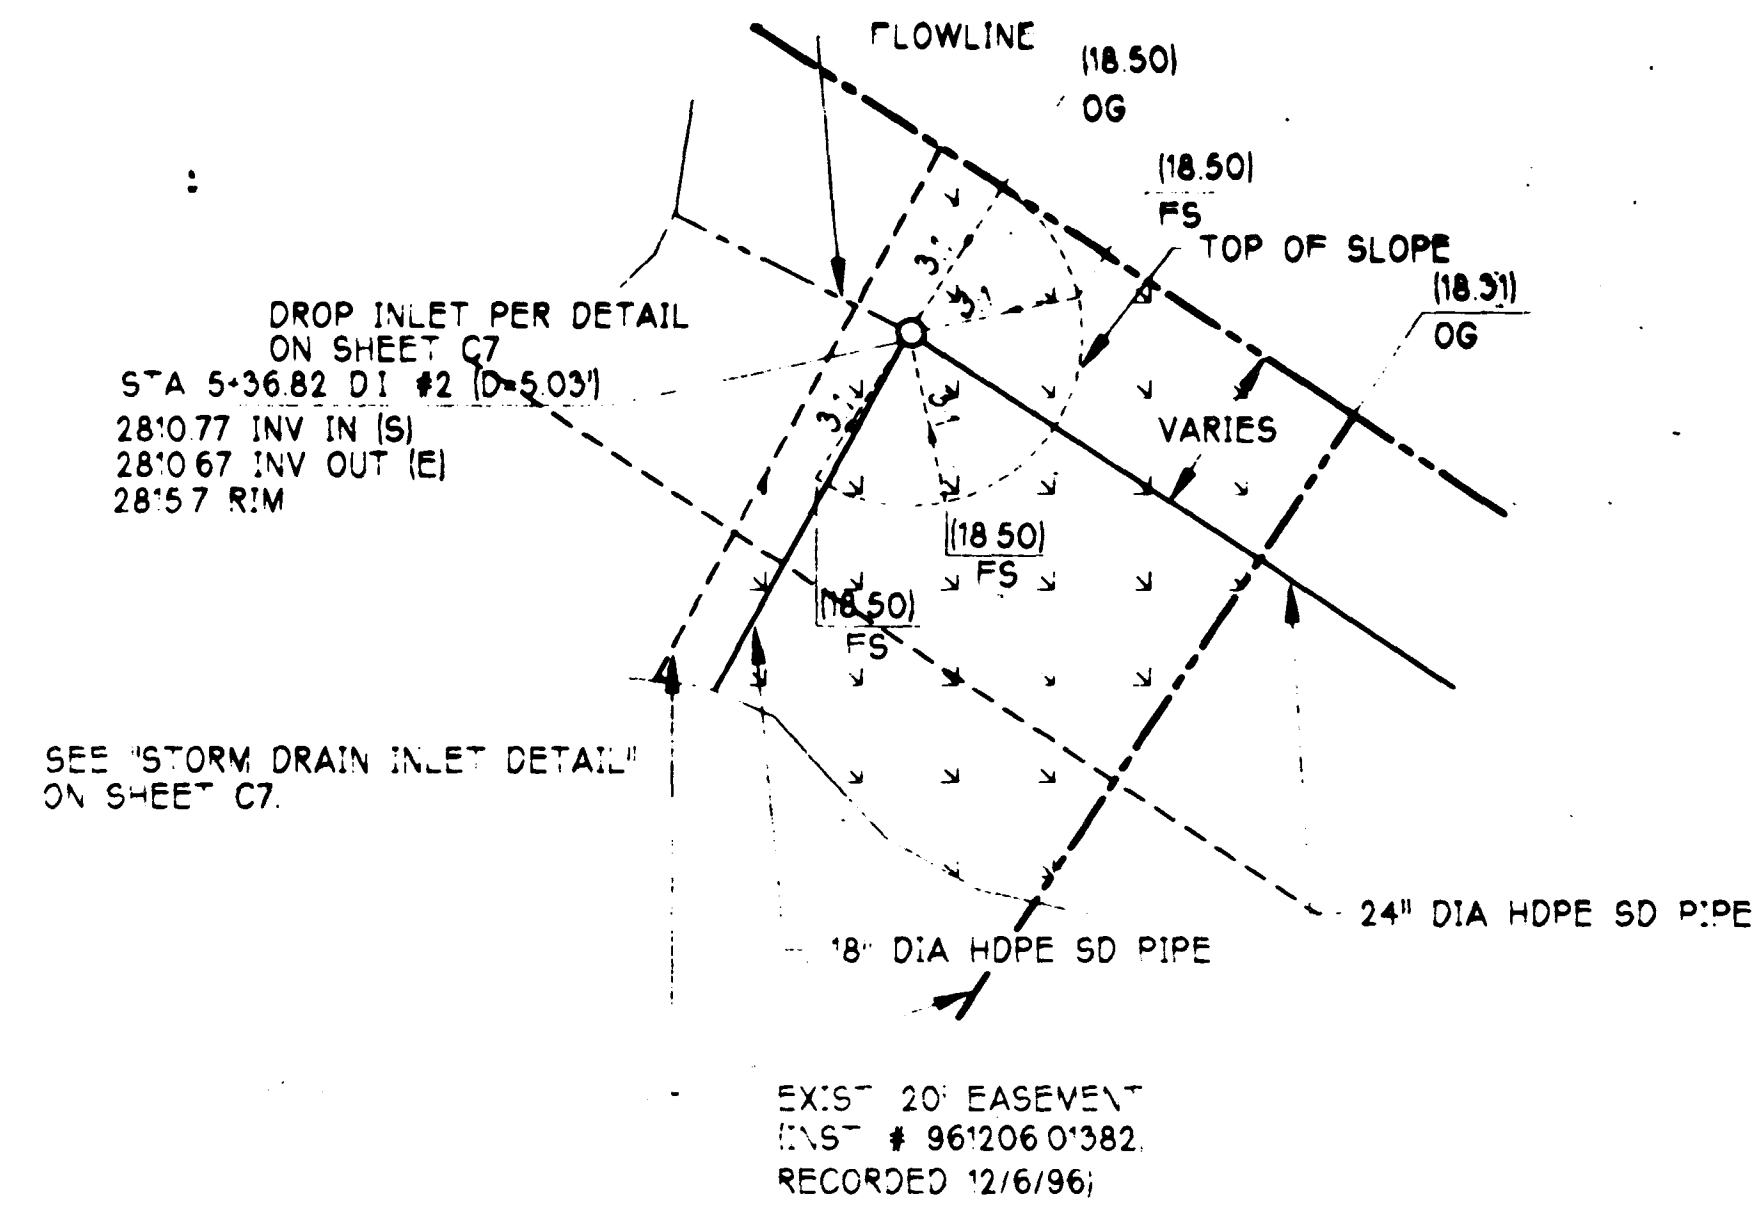

1
C6
NTS
DETAIL

MATERIALS TAKEOFF		QUANTITY
1	CONSTRUCT ROLL TYPE CURB & GUTTER PER CLARK COUNTY DWG NO 2-7	30 LF
2	CONSTRUCT 6" TYPE "A" CURB PER SUMMERLIN STD S-50	1700 LF
3	REMOVE EXIST TAPERING SIDEWALK & REPLACE WITH 5 FT SIDEWALK PER STD S-72	67 LF
4	CONSTRUCT 5 FT SIDEWALK PER SUMMERLIN STD S-72	11,510 SF
5	CONSTRUCT WHEELCHAIR RAMP PER ARCHITECTURAL PLAN	1 EA
6	"NO PARKING" SIGN, SEE DETAIL 2 ON SHEET C6	5 EA
7	CONSTRUCT WROUGHT IRON WALL PER SUMMERLIN STD, "THE TRAILS-WALL-VIEW WALL" AND REMOVE EXISTING AC PAVEMENT	180 LF
8	SAWCUT AND REMOVE EXISTING AC PAVEMENT	2,350 SF
9	CONSTRUCT 48" DIA RISER PER WARREN WALKER PRE-SCHOOL, DWG NO 107-V2530	---
10	INSTALL 6" GRATED PVC SCHEDULE 40 PIPE WITH FITTINGS	88 LF
11	INSTALL 24" DIA HDPE SD PIPE	420 LF
12	INSTALL 12" HDPE SD PIPE	17 LF
13	INSTALL 18" HDPE SD PIPE	440 LF
14	INSTALL JENSEN 24"X24" HDI DROP INLET	1 EA
15	CONST TYPE "A" DRAINAGE DROP INLET PER SUMMERLIN STD D-12 (L=4.00 FT, D=4.20 FT)	1 EA
16	CONST 5' FT WIDE BY 10' FT LONG BY 1' FT THICK RIP-RAP (D50-6")	3 EA
17	REMOVE EXIST 30 LF OF 8" DIA PIPE TO MATCH EXIST GRADE	---
18	INSTALL 65 LF HDPE 8" DIA PIPE TO MATCH EXIST GRADE	45 LF
19	INSTALL DROP INLET PER DESIGN ON SHEET C7	2 EA
20	INSTALL 3" DIA PVC SEWER LATERAL (ASTM D-3034, SDR 35) WITH FITTINGS	149 LF
21	INSTALL 4" DIA PVC SEWER LATERAL (ASTM D-3034, SDR 35) WITH FITTINGS	256 LF
22	INSTALL 6" DIA PVC SEWER LATERAL (ASTM D-3034, SDR 35) WITH FITTINGS	22 LF
23	INSTALL 4" DIA CLEANOUT	8 EA
30	INSTALL 4"X90 BEND AND REMOVE EXCESS WATERLINE FROM CONNECTION POINT END OF EXISTING 4" WATERLINE	6 LF
31	INSTALL 3/4" DIA SCHEDULE 40 PVC WATERLINE WITH FITTINGS	111 LF
32	INSTALL 2" DIA COPPER WATER LINE WITH FITTINGS	264 LF
33	INSTALL 3" DIA SCHEDULE 40 PVC WATERLINE WITH FITTINGS	152 LF
34	INSTALL 4" DIA SCHEDULE 40 PVC WATERLINE WITH FITTINGS	165 LF
35	INSTALL 2" METER WITH REDUCED PRESURE PRINCIPLE ASSEMBLY PER UDS PLATE 11A	1 EA
36	INSTALL 4" DIA AWWA C-900 PVC WATERLINE	770 LF
37	INSTALL 6"X6"X6" TEE	2 EA
38	INSTALL 6"X4" REDUCER	1 EA
39	REMOVE EXIST 4" END CAP, INSTALL 4"X2" REDUCER	1 EA
40	INSTALL 6" SIAMESE FIRE DEPARTMENT CONNECTION	1 EA
41	INSTALL 8"X6" REDUCER	1 EA
42	INSTALL 6" FIRE HYDRANT ASSY PER SUMMERLIN STD D-33	1 EA
43	INSTALL 8"X45 BEND	1 EA
44	INSTALL 8" DIA AWWA C-900 PVC WATERLINE	430 LF
45	INSTALL 6" POST INDICATOR VALVE WITH "TAMPER"	1 EA
46	INSTALL 8"X2" SERVICE SADDLE	1 EA
47	PAINT HANDICAP SYMBOL (INTERNATIONAL BLUE)	L/S
48	INSTALL 4" PARKING STRIPE (WHITE)	L/S
49	POUR 4" THICK CONCRETE MOTORCYCLE PARKING 6"X6"X6"-#10X#10 WWW	180 SF
50	CONSTRUCT LIGHTING FIXTURE AND APPURTENANCES PER ELECTRICAL PLANS	2 EA
51	INSTALL CROSSWALK STRIPPING	75 LF
52	INSTALL 6" DIA PIPE @ 1% PER DETAIL 1, THIS SHEET	125 LF
53	RAISE RIM TO PROPOSED EL. 2826.30 AS SHOWN ON SHEET C2	3 LF

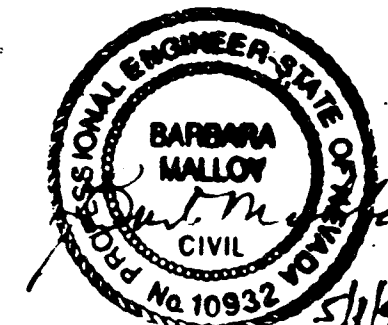

This design is the property of Saxton Incorporated, Nevada. Licensed contractor #0027741. Any unauthorized use is strictly prohibited per the NEVADA REVISED STATUTE.

SAXTON INCORPORATED

5440 WEST SAHARA AVENUE, 3RD FLOOR
LAS VEGAS, NEVADA 89102
(702) 221-1111

HILLPONTE COUNTRY DAY SCHOOL

SUMMERLIN-CITY OF LAS VEGAS

HERE WE GROW, INC.

LAS VEGAS, NEVADA

PROJECT:

HILLPONTE COUNTRY DAY SCHOOL

OWNER:

HERE WE GROW, INC.

SHEET TITLE:

MISCELLANEOUS NOTES & DETAILS

SHEET NO.:

C6 OF 8

JOB NO.:

9626

DRAWN BY:

BI

CHKD BY:

MS

DATE:

11/18/96

DESCRIPTION:

5/1/97 5/1/97

PERMIT/BID:

5/1/97 5/1/97

SHEET NO.:

C6 OF 8

