



- LIGHT FIXTURES**
- ☒ No. 3737 KENALL INDESTRUCTIBLE
 - ☒ No. 3808 " " "
 - ☒ No. 3940 " " "
 - ☒ No. 7240MS " " "
 - ☒ No. NB2 MARCO " "

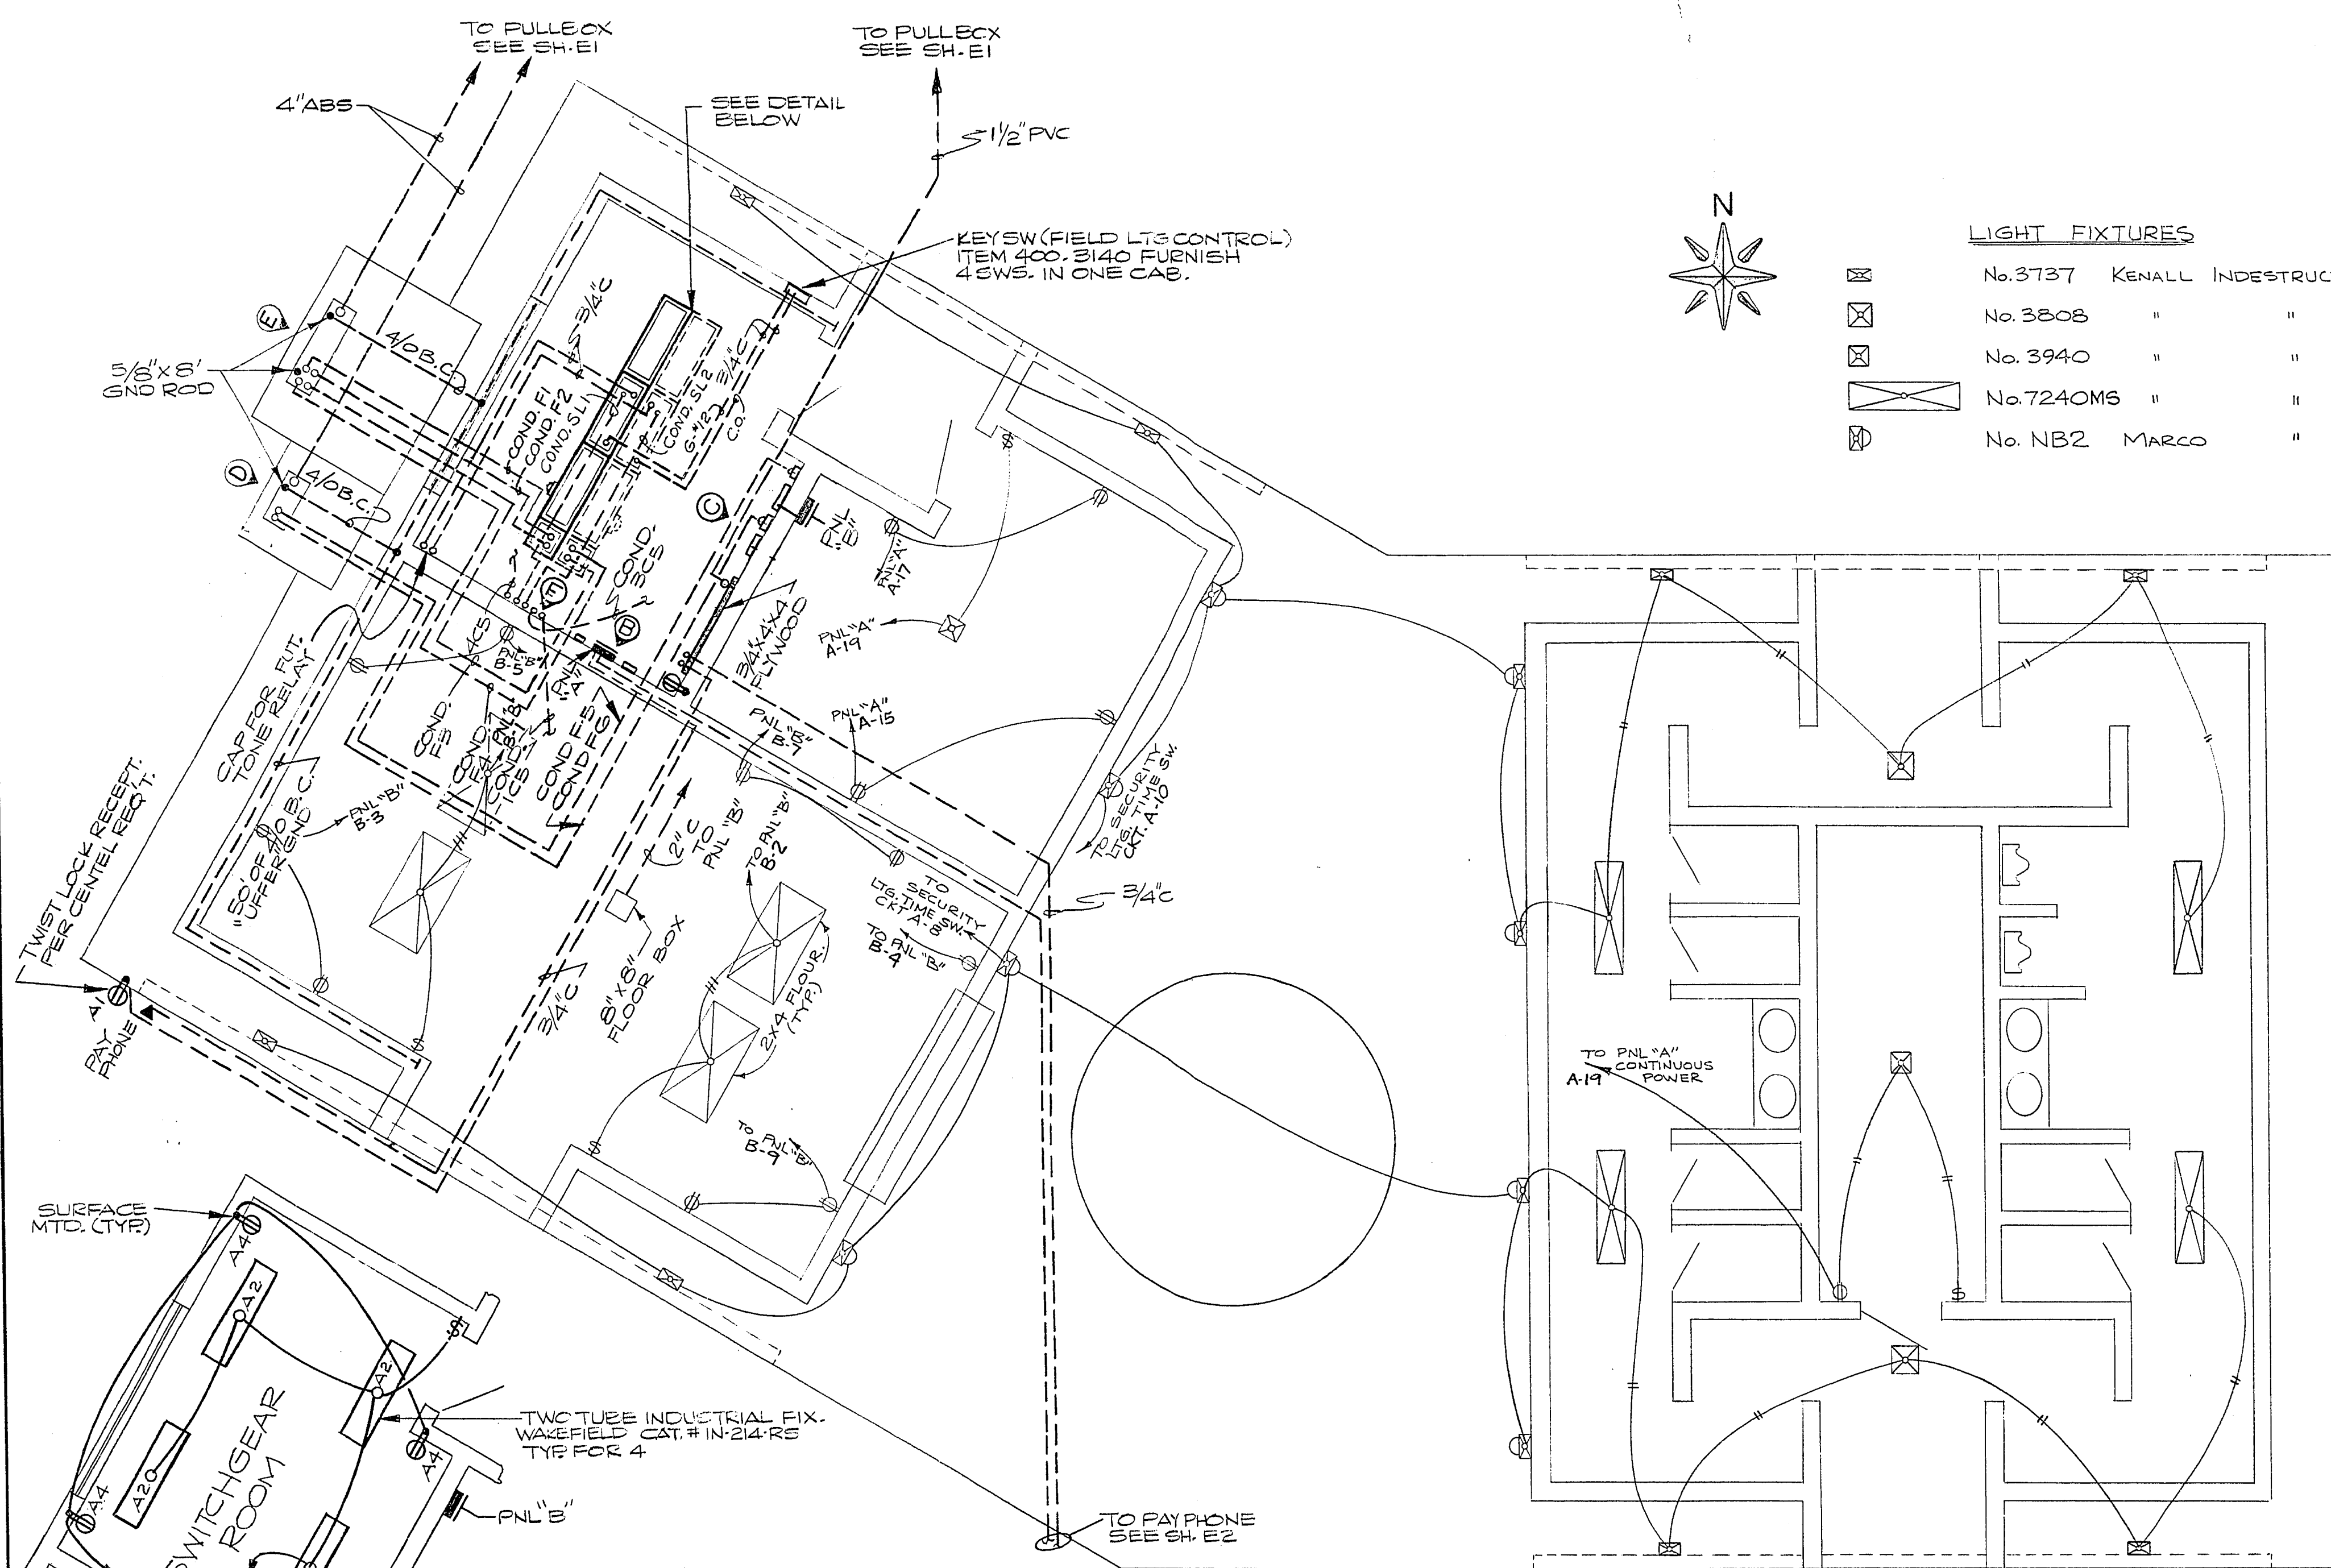


PARTIAL LIGHTING PLAN
SCALE 1/4"=1'-0"


SWITCHGEAR AND RESTROOM BLDG PLAN
SCALE 1/4"=1'-0"

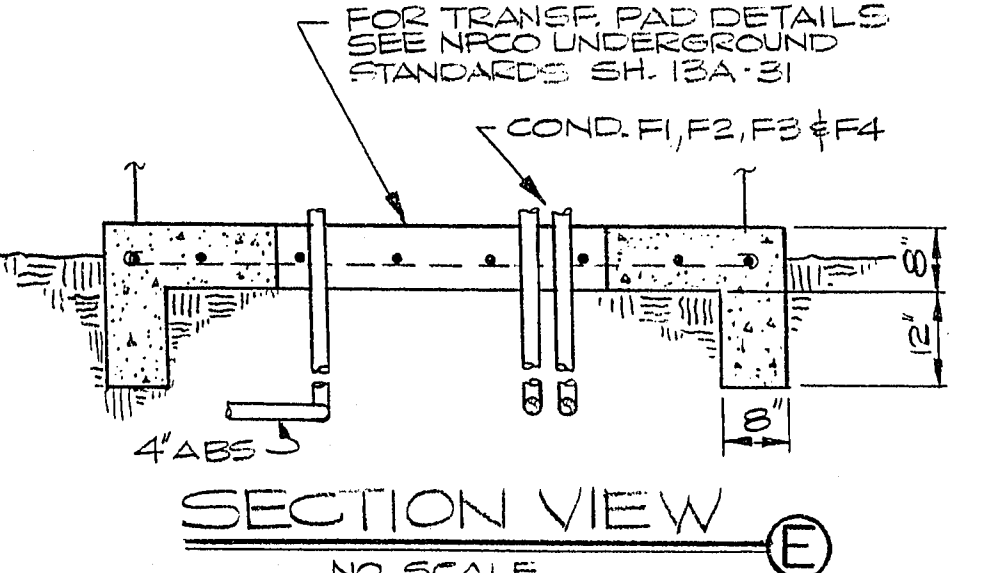


SECTION VIEW E
NO SCALE

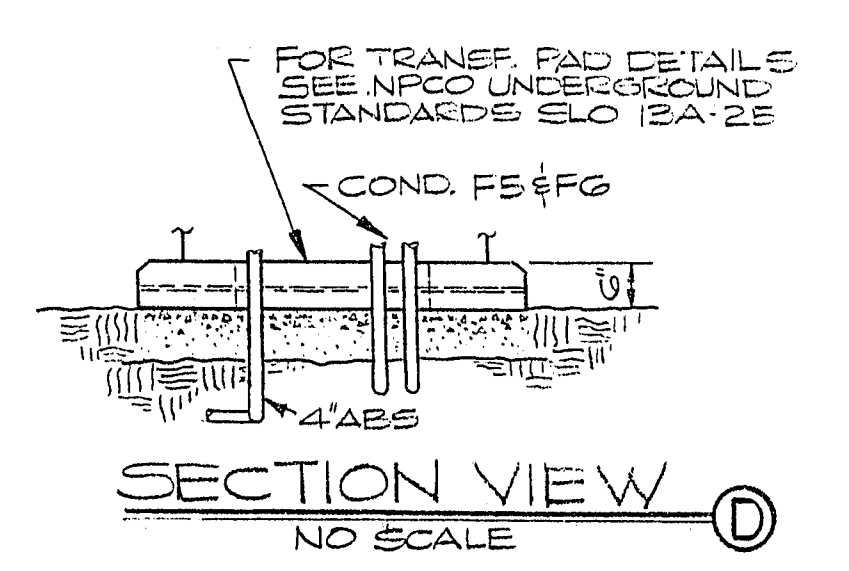


SECTION VIEW D
NO SCALE

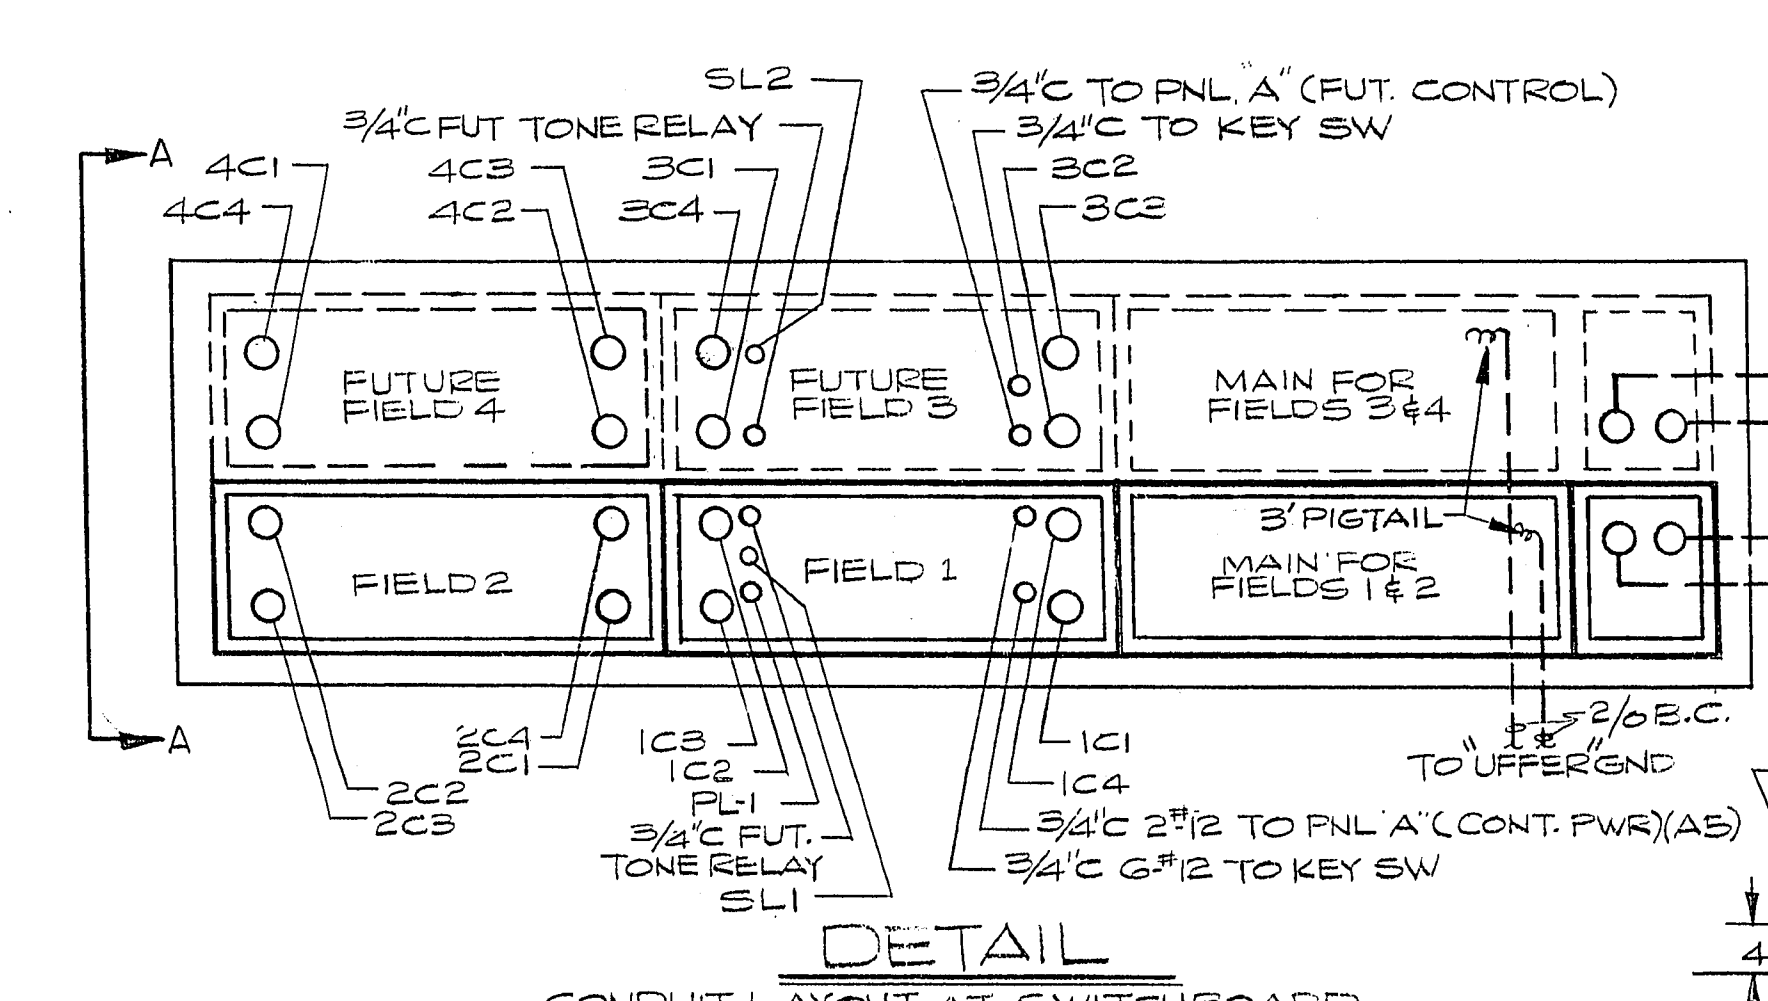


DETAIL
CONDUIT LAYOUT AT SWITCHBOARD
NO SCALE
NOTE: ALL CONDUIT TO BE INSTALLED IN THIS PHASE

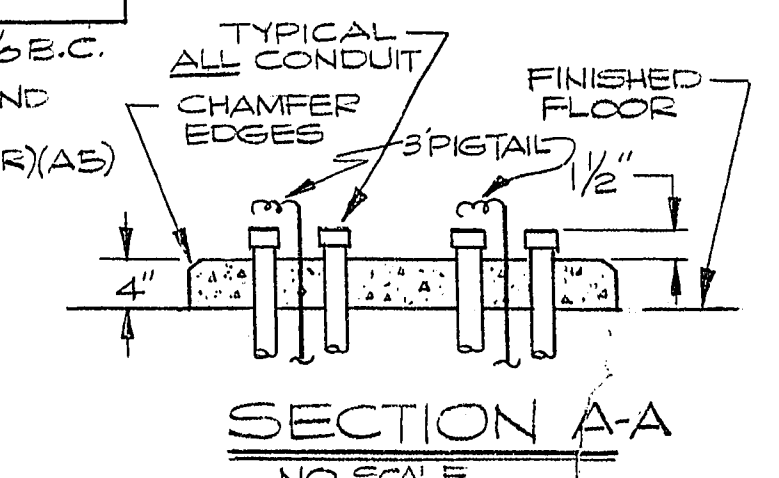


SECTION A-A
NO SCALE

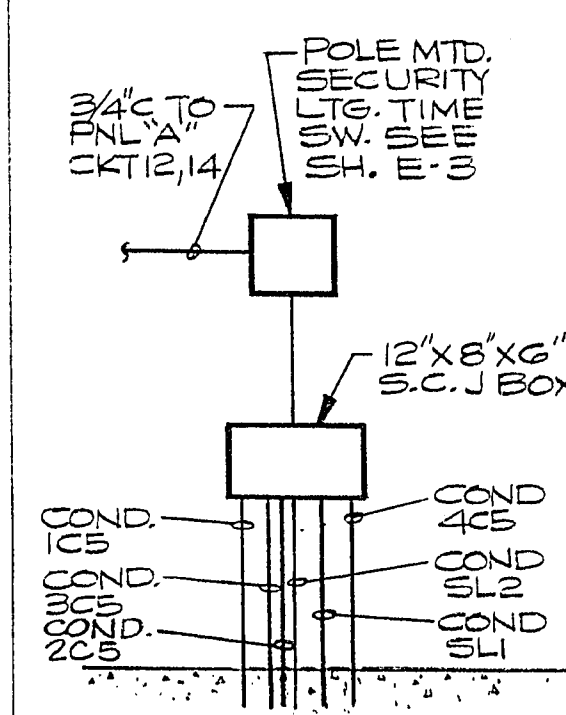

ELEVATION F
NO SCALE

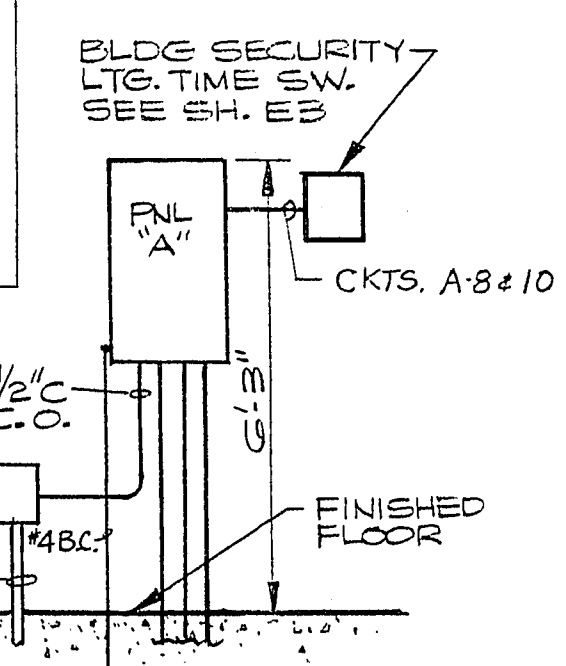

ELEVATION B
NO SCALE

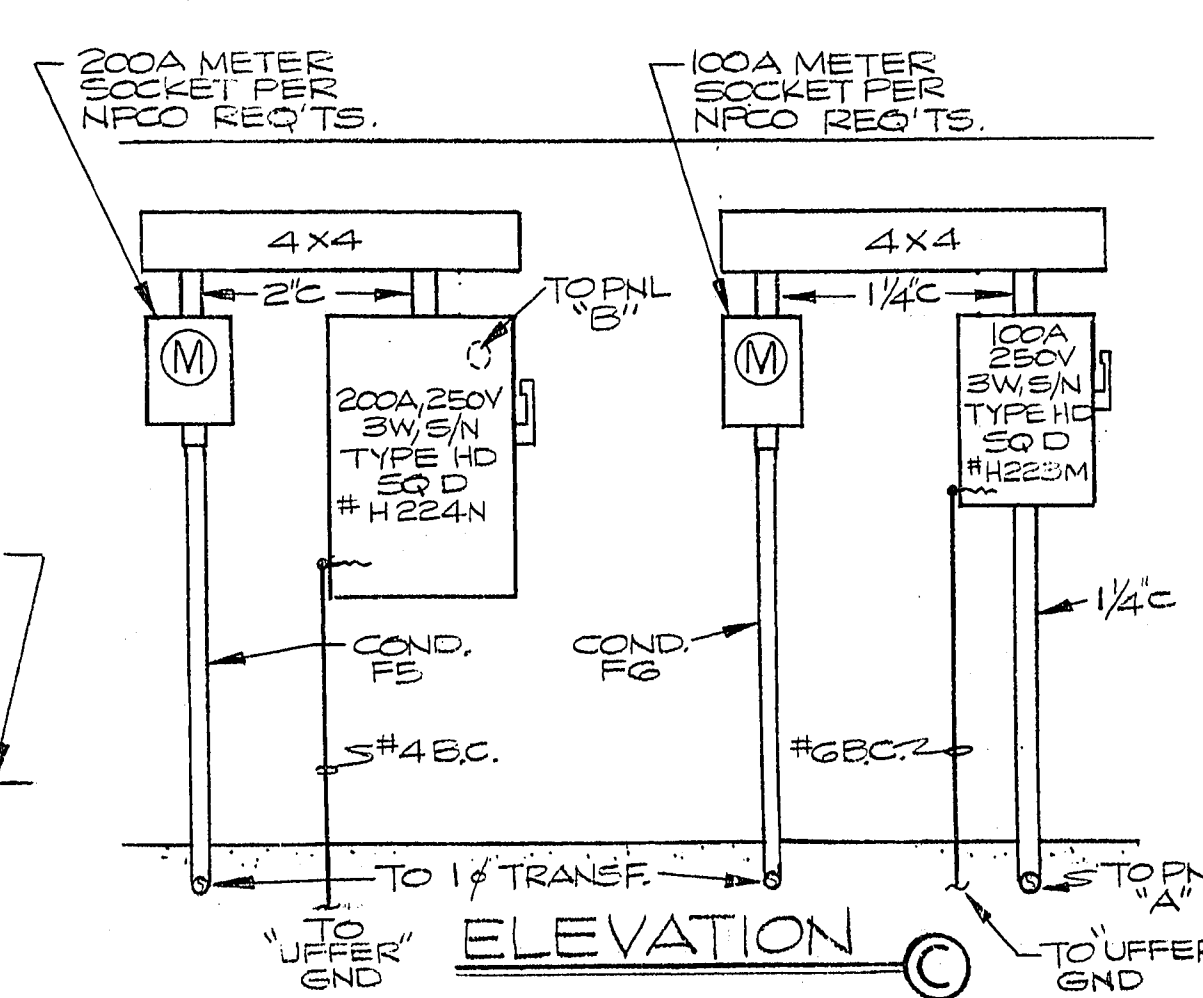

ELEVATION C
NO SCALE

SURFACE MTD. 120/240V
SQ. D. NQOB 30CKT

"A" 1Ø 3W 225A M.L.O.

ITEM	QTY	UNIT	PRICE	TOTAL
PAY TELEPHONES	400	2		
TELE. BOARD	400	1		
CONTROL FLD 1 & 2	1000	1		
CONTROL FLD 3 & 4	1000	1		
POLE A1	400	1		
POLE B2	400	1		
FUT. POLE	400	1		
STORAGE	360	2		
STORAGE	360	2		
SPACE	380	1		
SPACE				
SPACE				
SPACE				
SPACE				
SPACE				
SPACE				

4 400 SW GR ROOM
540 SW GR ROOM
400 POLE D1
1200 EXT. ELDS. LITE.
1200 EXT. ELDS. LITE.
3 750 SECURITY LITE.
750 SECURITY LITE. } 2P SEE ELEV. F

SURFACE MTD. 120/240V
SQ. D. NQOB 42CKT

"B" 1Ø 3W 225A M.L.O.

ITEM	QTY	UNIT	PRICE	TOTAL
CONCESSION	400	2		
CONCESSION	360	2		
CONCESSION	360	2		
CONCESSION	360	2		
CONCESSION	360	2		

2 400 CONCESSION
180 CONCESSION
CONCESSION
CONCESSION
900 CONCESSION } 2P

CONTRACT
DRAWING

REGISTERED PROFESSIONAL ENGINEER
HOWARD D. WILLIAMS
ELECTRICAL
12/5/77

FURNISH PANEL "B" WITH CKT. BKRS. AS SHOWN, BALANCE TO BE ADDED BY USER AT FUTURE DATE.

OWNER, LOBBY, CORN, INCORPORATED
CITY OF LAS VEGAS NEVADA
FREEDOM PARK IMPROVEMENTS-PHASE III
AND PHASE IV
SWITCHGEAR & RESTROOM BUILDING

REVISION NO.	DESCRIPTION	BY	DATE	APPROVED

SCALE (H)-1/4"=1'-0" SCALE (M)- N/A
WONP 3259 IFBK.N
DESIGNED BY: H. WILLIAMS
DRAWN BY: F. SALVEZ
APPROVED BY: DIRECTOR OF PUBLIC SERVICES
DATE:

E-6
650.22-8