

CITY OF LAS VEGAS GENERAL NOTES

- 1. ALL CONSTRUCTION AND MATERIALS SHALL BE IN ACCORDANCE WITH THE "UNIFORM STANDARD SPECIFICATIONS FOR PUBLIC WORKS CONSTRUCTION OFF-SITE IMPROVEMENTS, CLARK COUNTY AREA NEVADA", LATEST ISSUE...

CITY OF LAS VEGAS GRADING NOTES

- 1. IN THE EVENT THAT ANY UNFORESEEN CONDITIONS NOT COVERED BY THESE NOTES ARE ENCOUNTERED DURING GRADING OPERATIONS, THE OWNER/ENGINEER SHALL BE IMMEDIATELY NOTIFIED FOR DIRECTION.

CITY OF LAS VEGAS FIRE & RESCUE GENERAL NOTES

- 1. ALL WORK SHALL BE DONE IN STRICT ACCORDANCE WITH THE LAS VEGAS FIRE AND RESCUE ADOPTED FIRE CODE ORDINANCE # 8124 FOR HYDRANT INSTALLATION SPECIFICATIONS...


CITY OF LAS VEGAS SEWER NOTES

- 1. ALL CONSTRUCTION AND MATERIALS SHALL BE IN ACCORDANCE WITH THE LATEST EDITION OF THE DESIGN AND CONSTRUCTION STANDARDS FOR WASTEWATER COLLECTION SYSTEMS AND THE UNIFORM STANDARD SPECIFICATIONS FOR PUBLIC WORKS CONSTRUCTION OFF-SITE IMPROVEMENTS...

CITY OF LAS VEGAS STREET LIGHT NOTES

- 1. ALL STREET LIGHTING INSTALLATIONS SHALL BE IN ACCORDANCE WITH THE STREET LIGHTING PLANS, THE "UNIFORM STANDARD SPECIFICATIONS FOR PUBLIC WORKS CONSTRUCTION OFF-SITE IMPROVEMENTS, CLARK COUNTY AREA, NEVADA", LATEST REVISION...

LEGEND

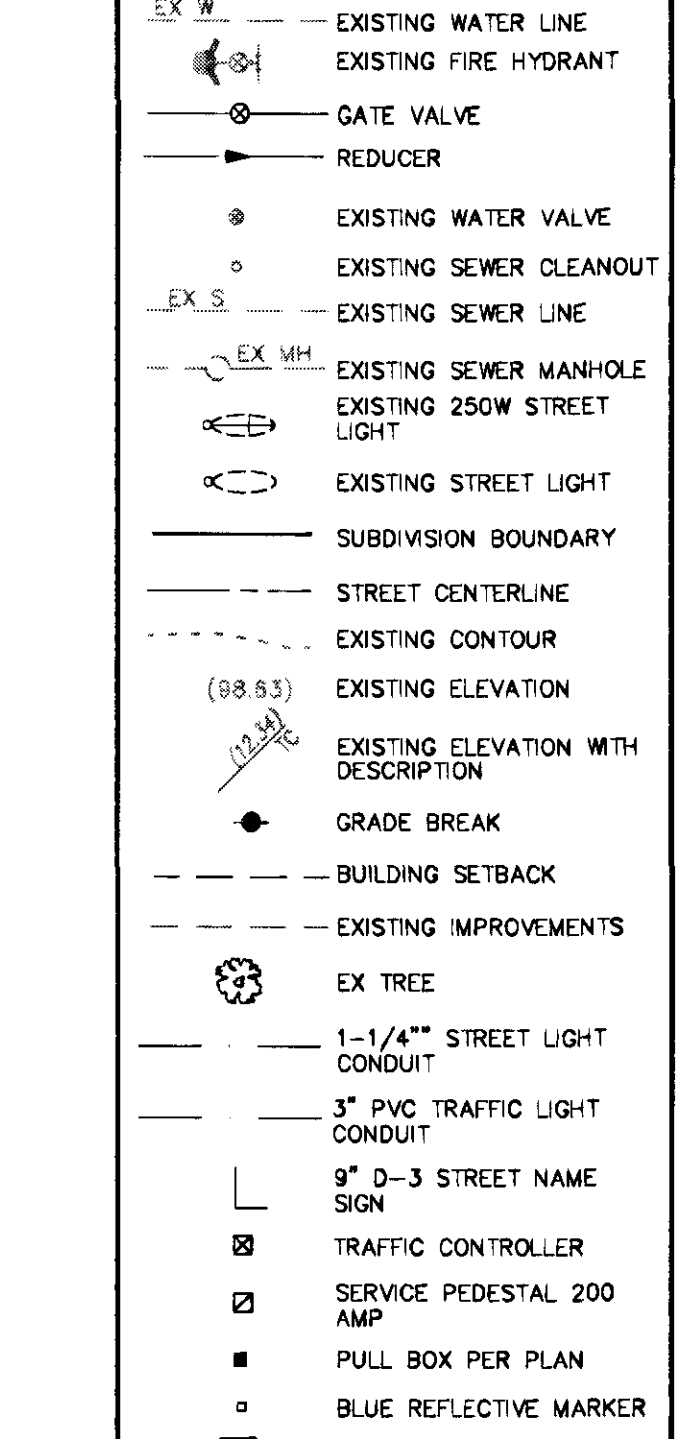

CITY OF LAS VEGAS TRAFFIC NOTES

- 1. ALL CONSTRUCTION SIGNING, BARRICADING, AND TRAFFIC DEVIATION SHALL CONFORM TO THE "MANUAL ON UNIFORM TRAFFIC CONTROL DEVICES", LATEST EDITION.

ABBREVIATIONS

Table listing abbreviations for curb, return, curve, gutter, centerline, intersection, clean out, domestic, east, curb return, edge of pavement, end vertical curve, existing, fire department connection, finish grade, fire hydrant, flow line, finished surface, grade break, gate valve, high density polyethylene, high point, fire hydrant, invert, low point, meter vault reinforced, north, on curve, point of curvature, point of intersection, point of tangency, polyvinyl chloride, point of vertical intersection, pressure zone, reinforced concrete pipe, south, street light, sanitary sewer, sidewalk, top of curb, thrust block, telephone, top of footing, top of grate, top of manhole, top of pipe, top of retaining wall, vertical curve, valley gutter, west or water.

BASIS OF BEARING

SOUTH 62°05'22" EAST BEING THE CENTERLINE OF BOULDER AVENUE BETWEEN FIRST STREET AND CASINO CENTER AS SHOWN BY MAP THEREOF ON FILE AT PAGE 79 IN FILE 67 OF SURVEYS IN THE CLARK COUNTY RECORDER'S OFFICE.

BENCHMARK

CITY OF LAS VEGAS BENCHMARK NO. 11V01 345W06 RIVET AND PLATE IN TOP OF CURB @ SOUTHEAST CORNER OF MAIN AND HOOPER.

ESTIMATE OF QUANTITIES

Table with columns for Street Improvements, Sewer, and Water, categorized by Private, Public, and Total. Includes sub-totals for NA, Private, and Public.

NOTICE TO CONTRACTORS

QUANTITIES SHOWN ARE FOR PERMITTING PURPOSES ONLY. THE CONTRACTOR SHALL BE RESPONSIBLE FOR PERFORMING HIS OWN QUANTITY TAKE OFF, AND BID ACCORDINGLY.

L.V.V.W.D. STANDARD NOTES

- 1. NO WORK SHALL BEGIN UNTIL THE WATER PLANS HAVE BEEN APPROVED FOR CONSTRUCTION BY THE LVVWD. FOLLOWING WATER PLAN APPROVAL, NOTICE SHALL BE GIVEN TO THE LVVWD COMMUNICATIONS SUPPORT CENTER (258-7171) TWO (2) WORKING DAYS PRIOR TO THE START OF CONSTRUCTION...

ENGINEER'S NOTE

- 1. EXISTING UTILITY LOCATIONS SHOWN HEREIN ARE APPROXIMATE ONLY. IT SHALL BE THE CONTRACTOR'S RESPONSIBILITY TO DETERMINE THE EXACT VERTICAL AND HORIZONTAL LOCATION OF ALL EXISTING UNDERGROUND UTILITIES PRIOR TO COMMENCING CONSTRUCTION...

APPROX. SEWER CONTRIBUTION:

Table showing Average Flow and Peak Flow for Parking Required and Parking Provided.

PARKING SUMMARY

Table showing Total Parking Required and Provided, with a total of 102 - 173.

DEVIATIONS TO STANDARDS

- 1. NONE

DEVIATIONS TO STANDARDS

- 1. NONE

Call before you Overhead and Call before you Dig. logos and contact information for Call Before You Dig.

NOTICE

- 1. THESE PLANS SHALL NOT, IN PART OR IN WHOLE, BE USED FOR CONSTRUCTION UNLESS APPROVED AND SIGNED BY THE GOVERNING AGENCY.

Revision table with columns for No., Date, and Description.

ARTICLE LLC logo and contact information for Las Vegas, NV.

GENERAL NOTES AND QUANTITIES, 1ST AND BOULDER LOUNGE SIDEWALK IMPROVEMENTS, PROJECT information.

DESIGNER: DRAWN BY: information.

Professional Engineer Seal for Alvin Hahn, State of Nevada, License No. 1614439.

JOB NO. 11-0020, CLV DWG. NO. C2, SHEET NO. 2 OF 3.

PLOT DATE 11/7/11

APPROVAL: Signature line for Las Vegas Valley Water District, dated 8/30/13.