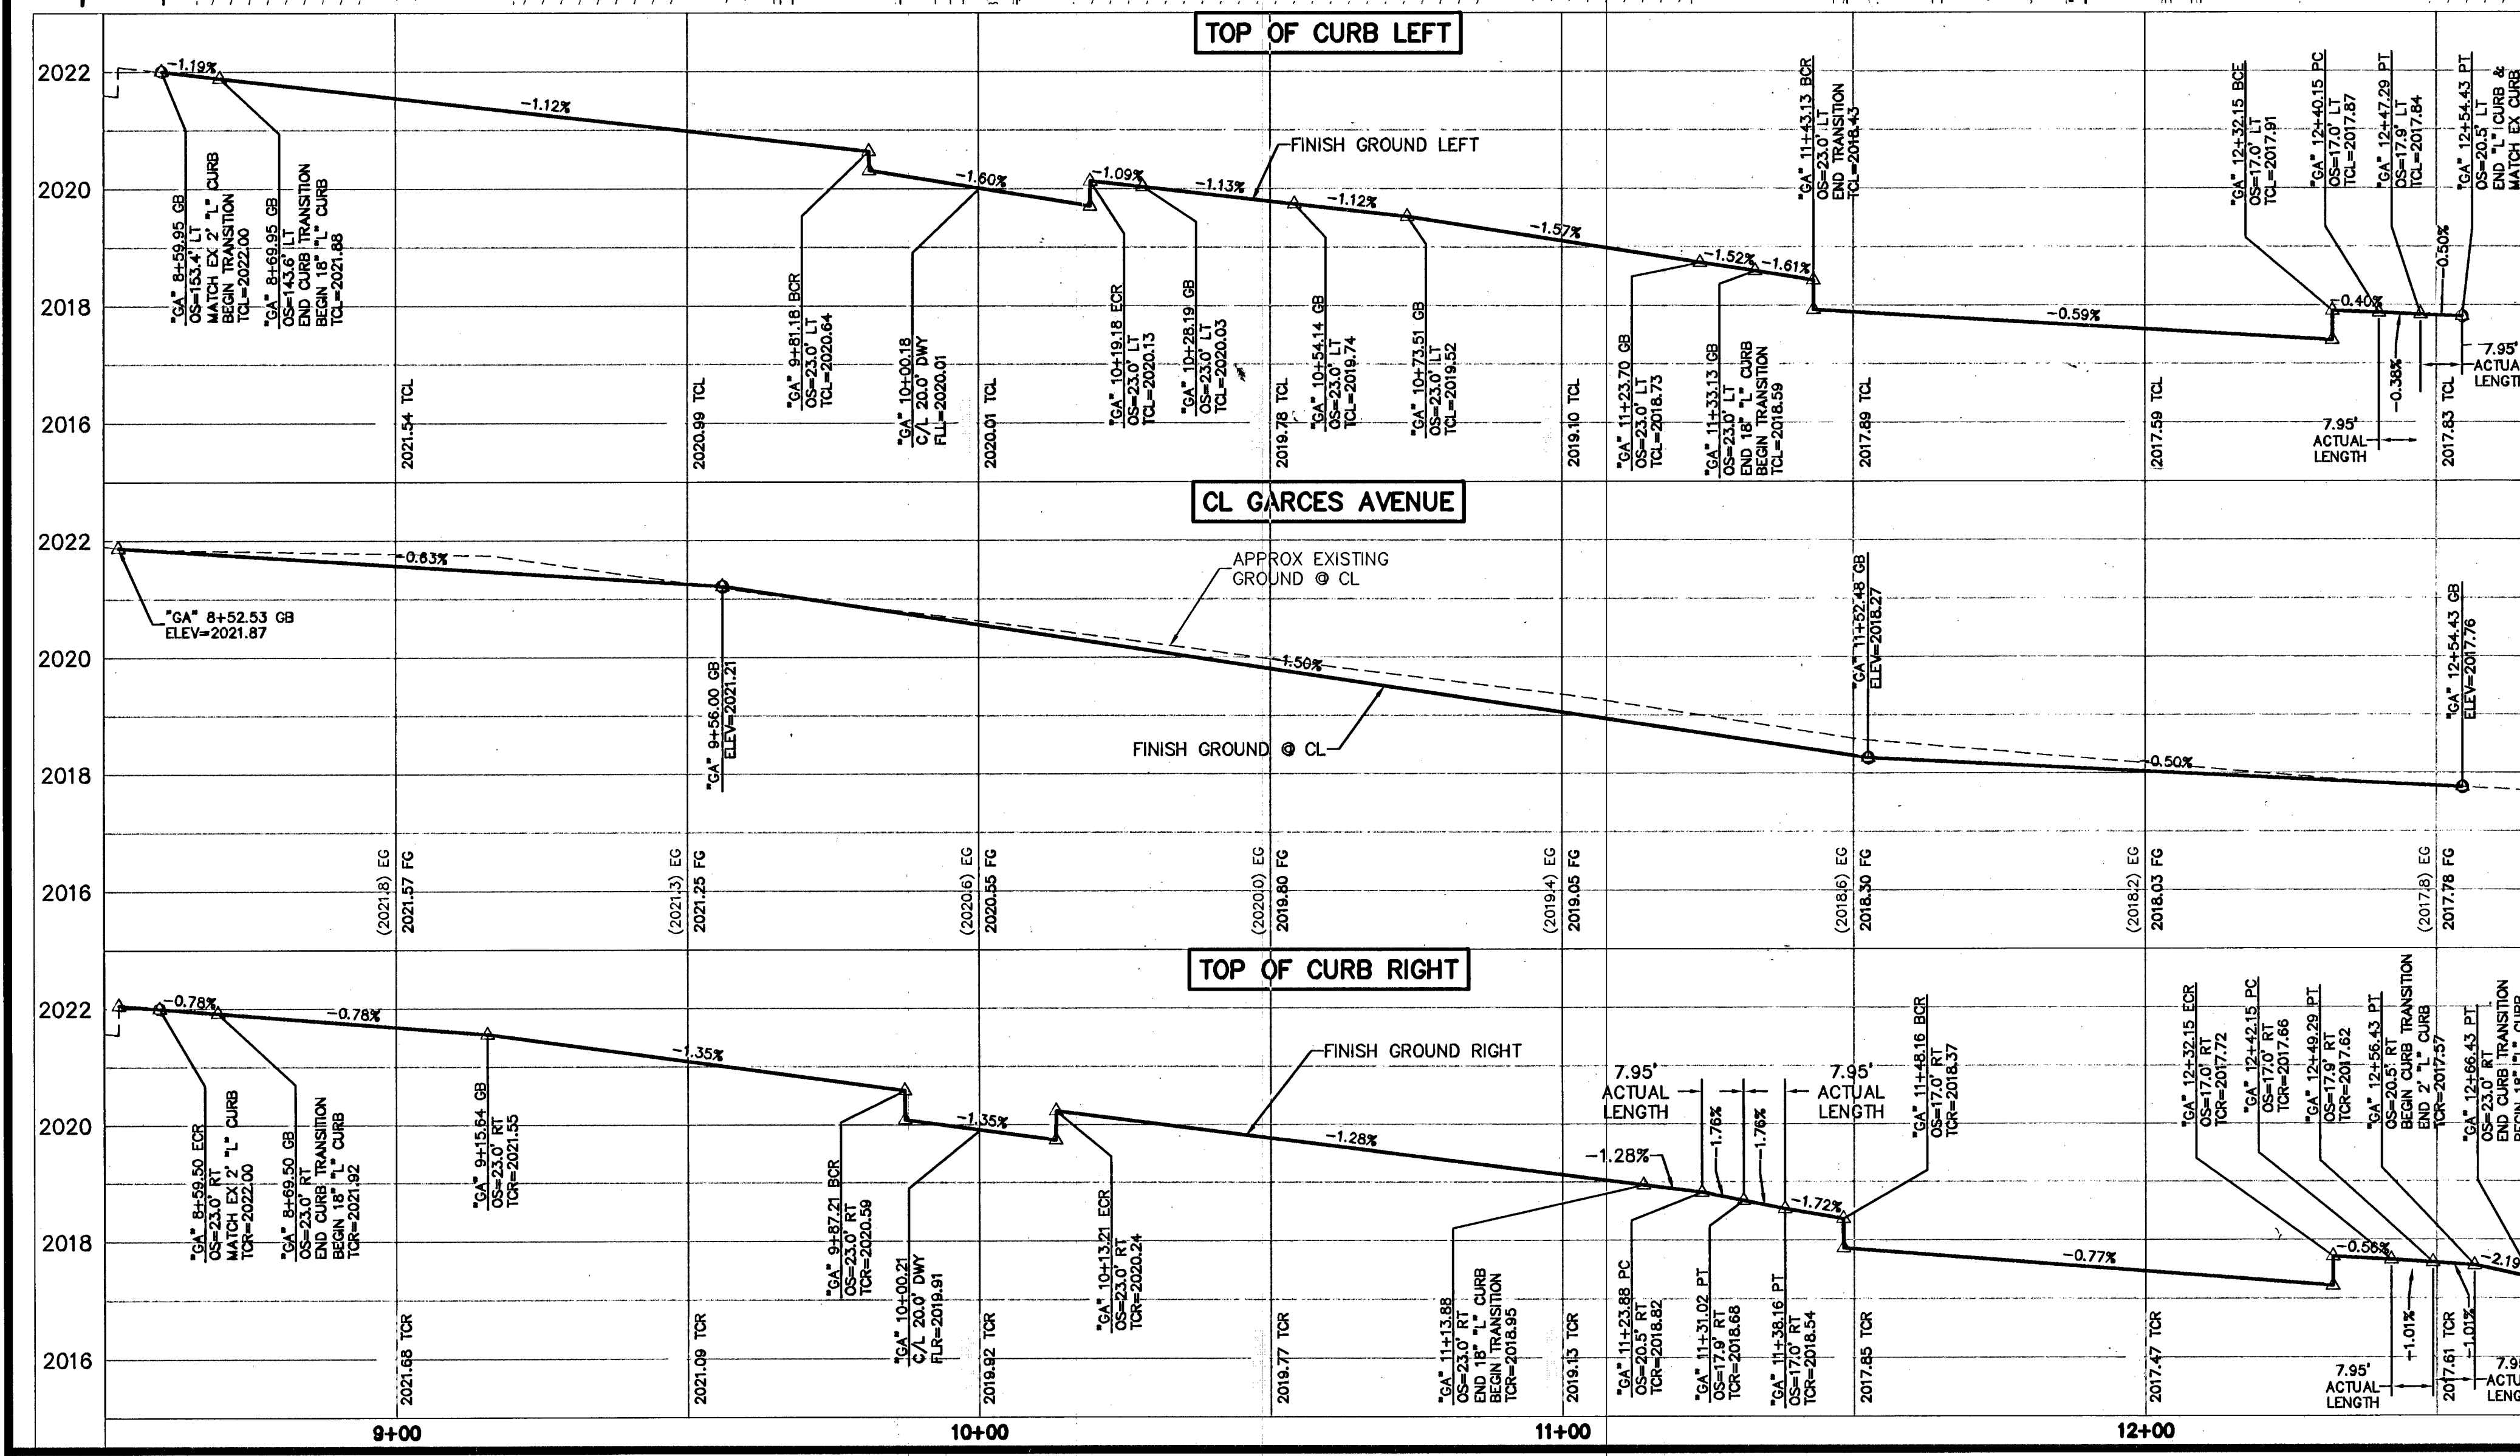
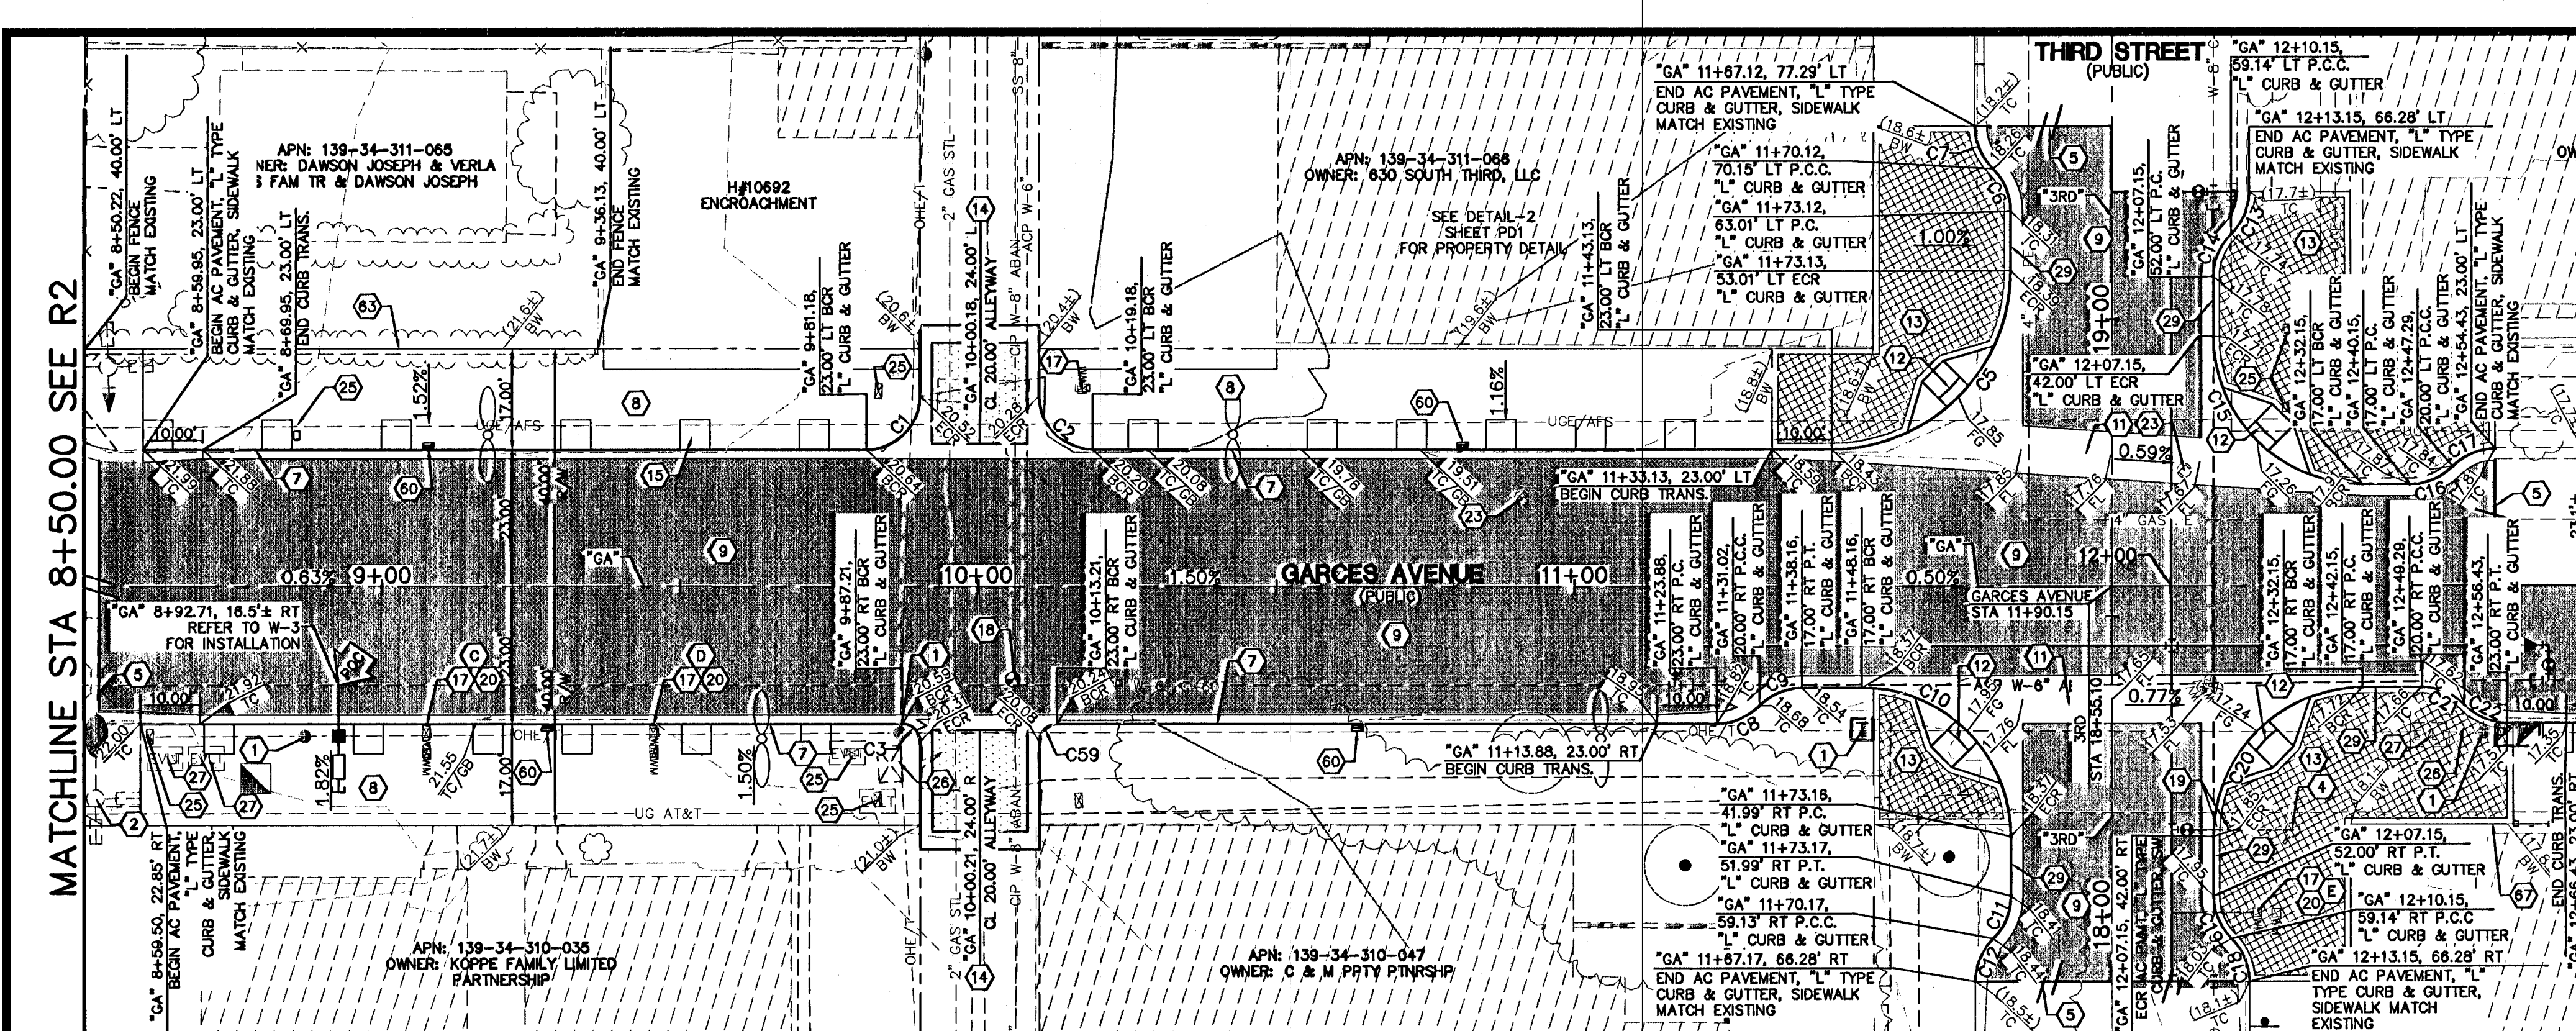


CURVE TABLE				
CURVE #	LENGTH	RADIUS	DELTA	TANGENT
C1	14.14'	9.00'	90°00'00"	9.00'
C2	14.14'	9.00'	90°00'00"	9.00'
C3	4.71'	3.00'	90°00'00"	3.00'
C4	4.71'	3.00'	90°00'00"	3.00'
C5	47.14'	30.00'	90°01'24"	30.01'
C6	7.95'	10.00'	45°34'23"	4.20'
C7	7.95'	10.00'	45°34'23"	4.20'
C8	7.95'	10.00'	45°34'23"	4.20'
C9	7.95'	10.00'	45°34'23"	4.20'
C10	39.28'	25.00'	89°58'45"	24.99'
C11	7.95'	10.00'	45°34'23"	4.20'
C12	7.95'	10.00'	45°34'23"	4.20'
C13	7.95'	10.00'	45°34'23"	4.20'
C14	7.95'	10.00'	45°34'23"	4.20'
C15	39.27'	25.00'	89°59'57"	25.00'
C16	7.95'	10.00'	45°34'23"	4.20'
C17	7.95'	10.00'	45°34'23"	4.20'
C18	7.95'	10.00'	45°34'23"	4.20'
C19	7.95'	10.00'	45°34'23"	4.20'
C20	39.27'	25.00'	89°59'54"	25.00'
C21	7.95'	10.00'	45°34'23"	4.20'
C22	7.95'	10.00'	45°34'23"	4.20'

- ROADWAY & PAVING NOTES**
- EXISTING POWERPOLE UTILITY, PROTECT IN PLACE.
 - EXISTING STREETLIGHT UTILITY, PROTECT IN PLACE.
 - EXISTING FIRE HYDRANT, PROTECT IN PLACE.
 - SAWCUT AND MATCH EXISTING AC.
 - INSTALL 18" "L" TYPE CURB AND GUTTER. SEE SHEET DT1 FOR CURB DETAIL.
 - INSTALL SIDEWALK PER PER CCUSD NO. 234 SEE HARDSCAPE PLANS FOR FINISH DETAILS.
 - INSTALL 5" AC PAVEMENT OVER 14" TYPE II AGGREGATE BASE OR MATCH EXISTING PAVEMENT SECTION, WHICHEVER IS GREATER. SEE TYPICAL SECTIONS FOR DETAILS.
 - INSTALL 8" CROSS GUTTER PER CCUSD NO. 228.
 - INSTALL CASE II SIDEWALK RAMP PER CITY OF LAS VEGAS STANDARD DRAWING NO. 204-DC. (A=8", B=8" UNLESS OTHERWISE SPECIFIED).
 - INSTALL PAVERS. SEE DETAIL 1 SHEET DT1.
 - INSTALL ALLEYWAY PER DOWNTOWN CENTENNIAL STANDARDS.
 - INSTALL SPLANTER. SEE HARDSCAPE PLANS FOR DETAILS.
 - ADJUST WATER METER TO GRADE PER UDACS PLT. NO. 4.
 - ADJUST WATER VALVE TO GRADE PER UDACS PLT. NO. 38 OR 39. (VALVES MUST BE ACCESSIBLE AT ALL TIMES).
 - RELOCATE WATER VALVE PER UDACS PLT. NO. 39. (VALVES MUST BE ACCESSIBLE AT ALL TIMES). REFER TO WATERLINE RELOCATION PLAN.
 - ADJUST BACKFLOW PREVENTER TO GRADE PER UDACS PLT. NO. 4 OR 8.
 - ADJUST NV ENERGY ELECTRICAL MANHOLE TO GRADE.
 - ADJUST NV ENERGY EX. ELECTRICAL PULL BOX TO GRADE.
 - ADJUST EX. CATV BOX TO GRADE.
 - EX. NV ENERGY ELECTRICAL CABINET TO BE ADJUSTED TO GRADE.
 - INSTALL "L" TYPE CURB & GUTTER PER STD DWG 216.
 - INSTALL MULTI-BAY PARKING METER ANCHOR BASE, PROVIDED BY THE CITY OF LAS VEGAS. TO BE INSTALLED IN AMENITY ZONE. EXACT LOCATION TO BE DETERMINED BY THE OWNER OR A OWNERS REPRESENTATIVE.
 - RE-INSTALL SALVAGED WOOD FENCE.
 - RE-INSTALL SALVAGED CHAIN LINK FENCE.

CLV Fire Department
Date 9/16/13

HARDSCAPE & STREET LIGHT NOTES:

- SEE HARDSCAPE PLANS FOR PLANTER BOX LOCATIONS
- REFER TO STREET LIGHTING PLANS FOR NEW STREET LIGHT LOCATIONS

LEGEND

- NEW PAVEMENT AREA
- NEW DRIVEWAY/ALLEYWAY SEE SHEET H51 FOR DETAILS.
- ACCENT PAVERS SEE SHEET H51 FOR DETAILS.

WATERLINE RELOCATION NOTE

REFER TO SHEETS W1 THROUGH W3 FOR WATERLINE RELOCATION IMPROVEMENTS.

SERVICE METER ACCOUNT & SIZE INFORMATION

ACCT# 149416, MTR# 606498, 5/8" MTR W/1" DCVA
ACCT# 149417, MTR# 277230, 5/8" MTR W/1" DCVA
ACCT# 149402, MTR# 540070, 3/4" MTR W/1" DCVA

APPROVED FOR CONSTRUCTION
LAS VEGAS VALLEY WATER DISTRICT ENGINEERING SERVICES MANAGER
DATE 5/15/13 PROJECT NO. 116883

FAST
Call before you Dig
1-702-432-5300
FREEMAN AND ARTERIAL SYSTEM OF TRANSPORTATION

811
Call before you Dig
1-702-227-2929

PUBLIC WORKS DEPARTMENT
2727 SOUTH RAINBOW BOULEVARD
LAS VEGAS, NV 89166
PH (702) 864-6046
FAX (702) 864-7550
WEB SITE WWW.VNVP.COM

ROADWAY PLAN AND PROFILE
STA 8+50 TO STA 12+50
GARCES AVENUE

DOWNTOWN PEDESTRIAN & BICYCLE IMPROVEMENTS
GARCES AVENUE
MAIN STREET TO 6TH STREET

DRAWN BY: 11/20/2012
DESIGNED BY: 11/20/2012
CHECKED BY: 11/20/2012
PROJECT NO: SCALE HORIZ 1"=20' VERT. 1"=2'

SHEET R3 OF 62 SHEETS
107V6664-GARCES