
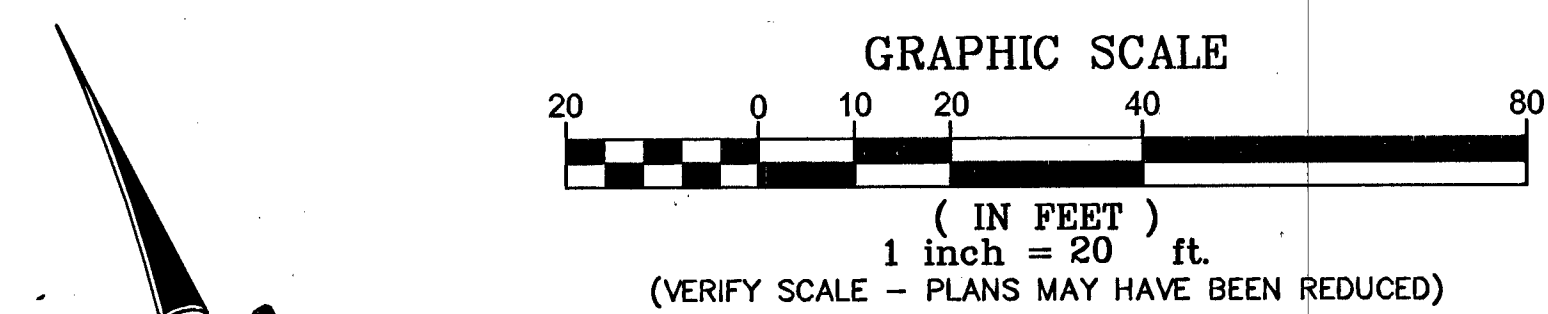


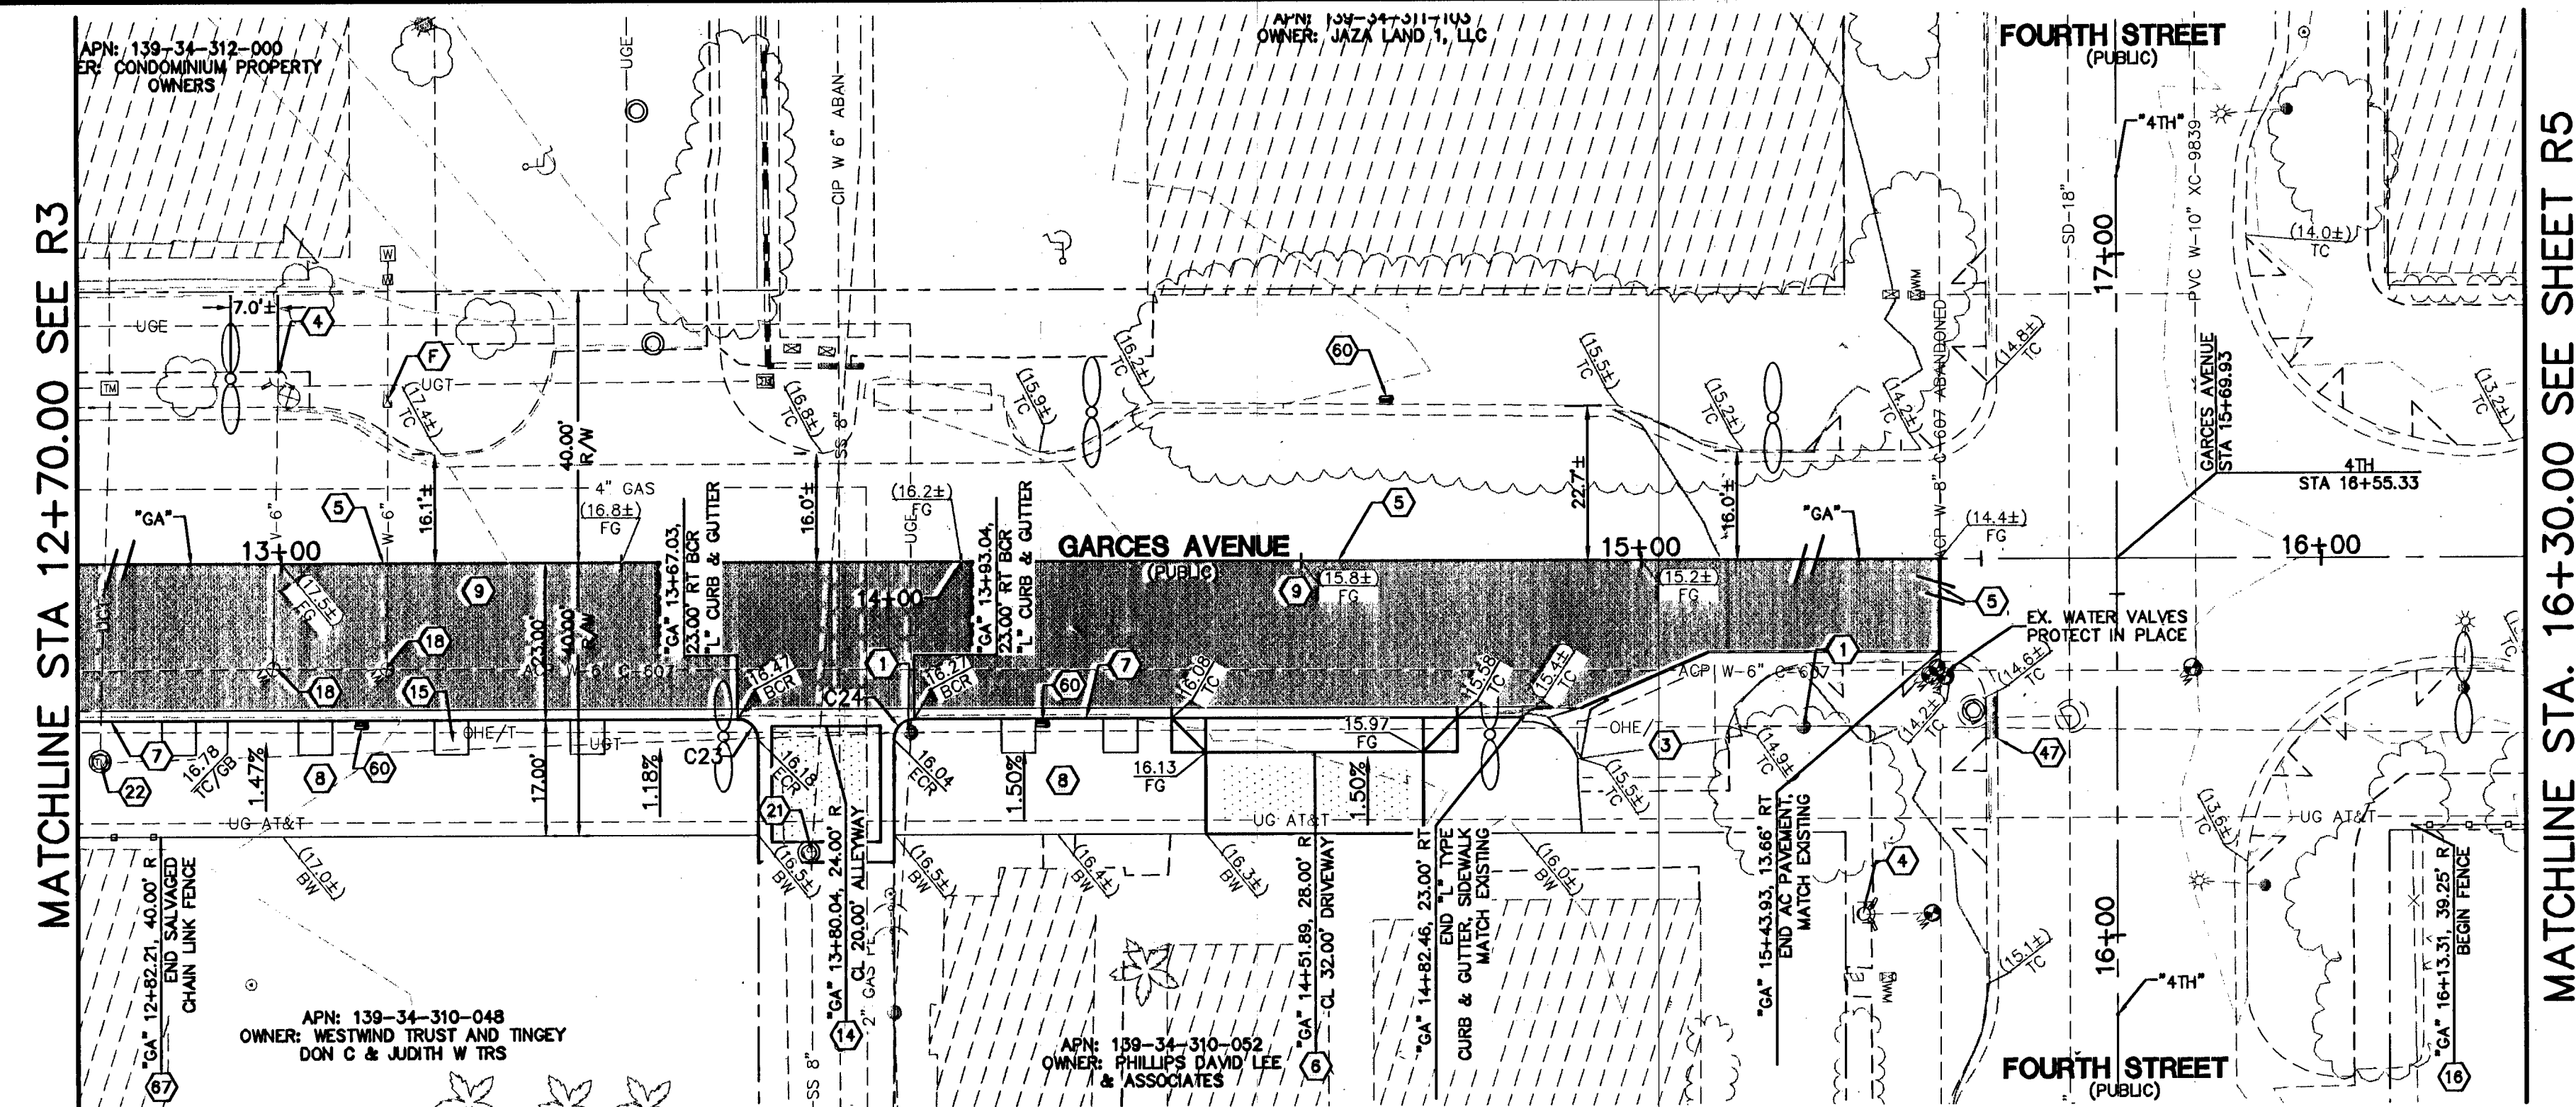


CURVE TABLE				
CURVE #	LENGTH	RADIUS	DELTA	TANGENT
C23	4.71'	3.00'	90°00'00"	3.00'
C24	4.71'	3.00'	90°00'00"	3.00'

- LEGEND**
- NEW PAVEMENT AREA
 - NEW DRIVEWAY/ALLEYWAY SEE SHEET H51 FOR DETAILS.
 - ACCENT PAVERS SEE SHEET H51 FOR DETAILS.

ROADWAY & PAVING NOTES

- EXISTING POWERPOLE UTILITY, PROTECT IN PLACE.
- EXISTING DRIVEWAY, PROTECT IN PLACE.
- EXISTING FIRE HYDRANT, PROTECT IN PLACE.
- SAWCUT AND MATCH EXISTING AC.
- INSTALL DRIVEWAY PER DOWNTOWN CENTENNIAL STANDARDS.
- INSTALL 18" "L" TYPE CURB AND GUTTER. SEE SHEET D11 FOR CURB DETAIL.
- INSTALL SIDEWALK PER PER CCSD NO. 234 SEE HARDSCAPE PLANS FOR FINISH DETAILS.
- INSTALL 5" AC PAVEMENT OVER 4" TYPE II AGGREGATE BASE OR MATCH EXISTING PAVEMENT SECTION, WHICHEVER IS GREATER. SEE TYPICAL SECTIONS FOR DETAILS.
- INSTALL ALLEYWAY PER DOWNTOWN CENTENNIAL STANDARDS.
- INSTALL PLANTER. SEE HARDSCAPE PLANS FOR DETAILS.
- INSTALL WROUGHT IRON FENCE PER DOWNTOWN CENTENNIAL STANDARD.
- ADJUST WATER VALVE TO GRADE PER UDACS PLT. NO. 38 OR 39. (VALVES MUST BE ACCESSIBLE AT ALL TIMES).
- ADJUST SSMH MANHOLE GRADE PER DCSCS SD-5.
- ADJUST NV ENERGY TELEPHONE MANHOLE TO GRADE.
- EX. DROP INLET. PROTECT IN PLACE.
- INSTALL MULTI-BAY PARKING METER ANCHOR BASE, PROVIDED BY THE CITY OF LAS VEGAS. TO BE INSTALLED IN AMENITY ZONE, EXACT LOCATION TO BE DETERMINED BY THE OWNER OR A OWNERS REPRESENTATIVE.
- INSTALL SALVAGED CHAIN LINK FENCE.

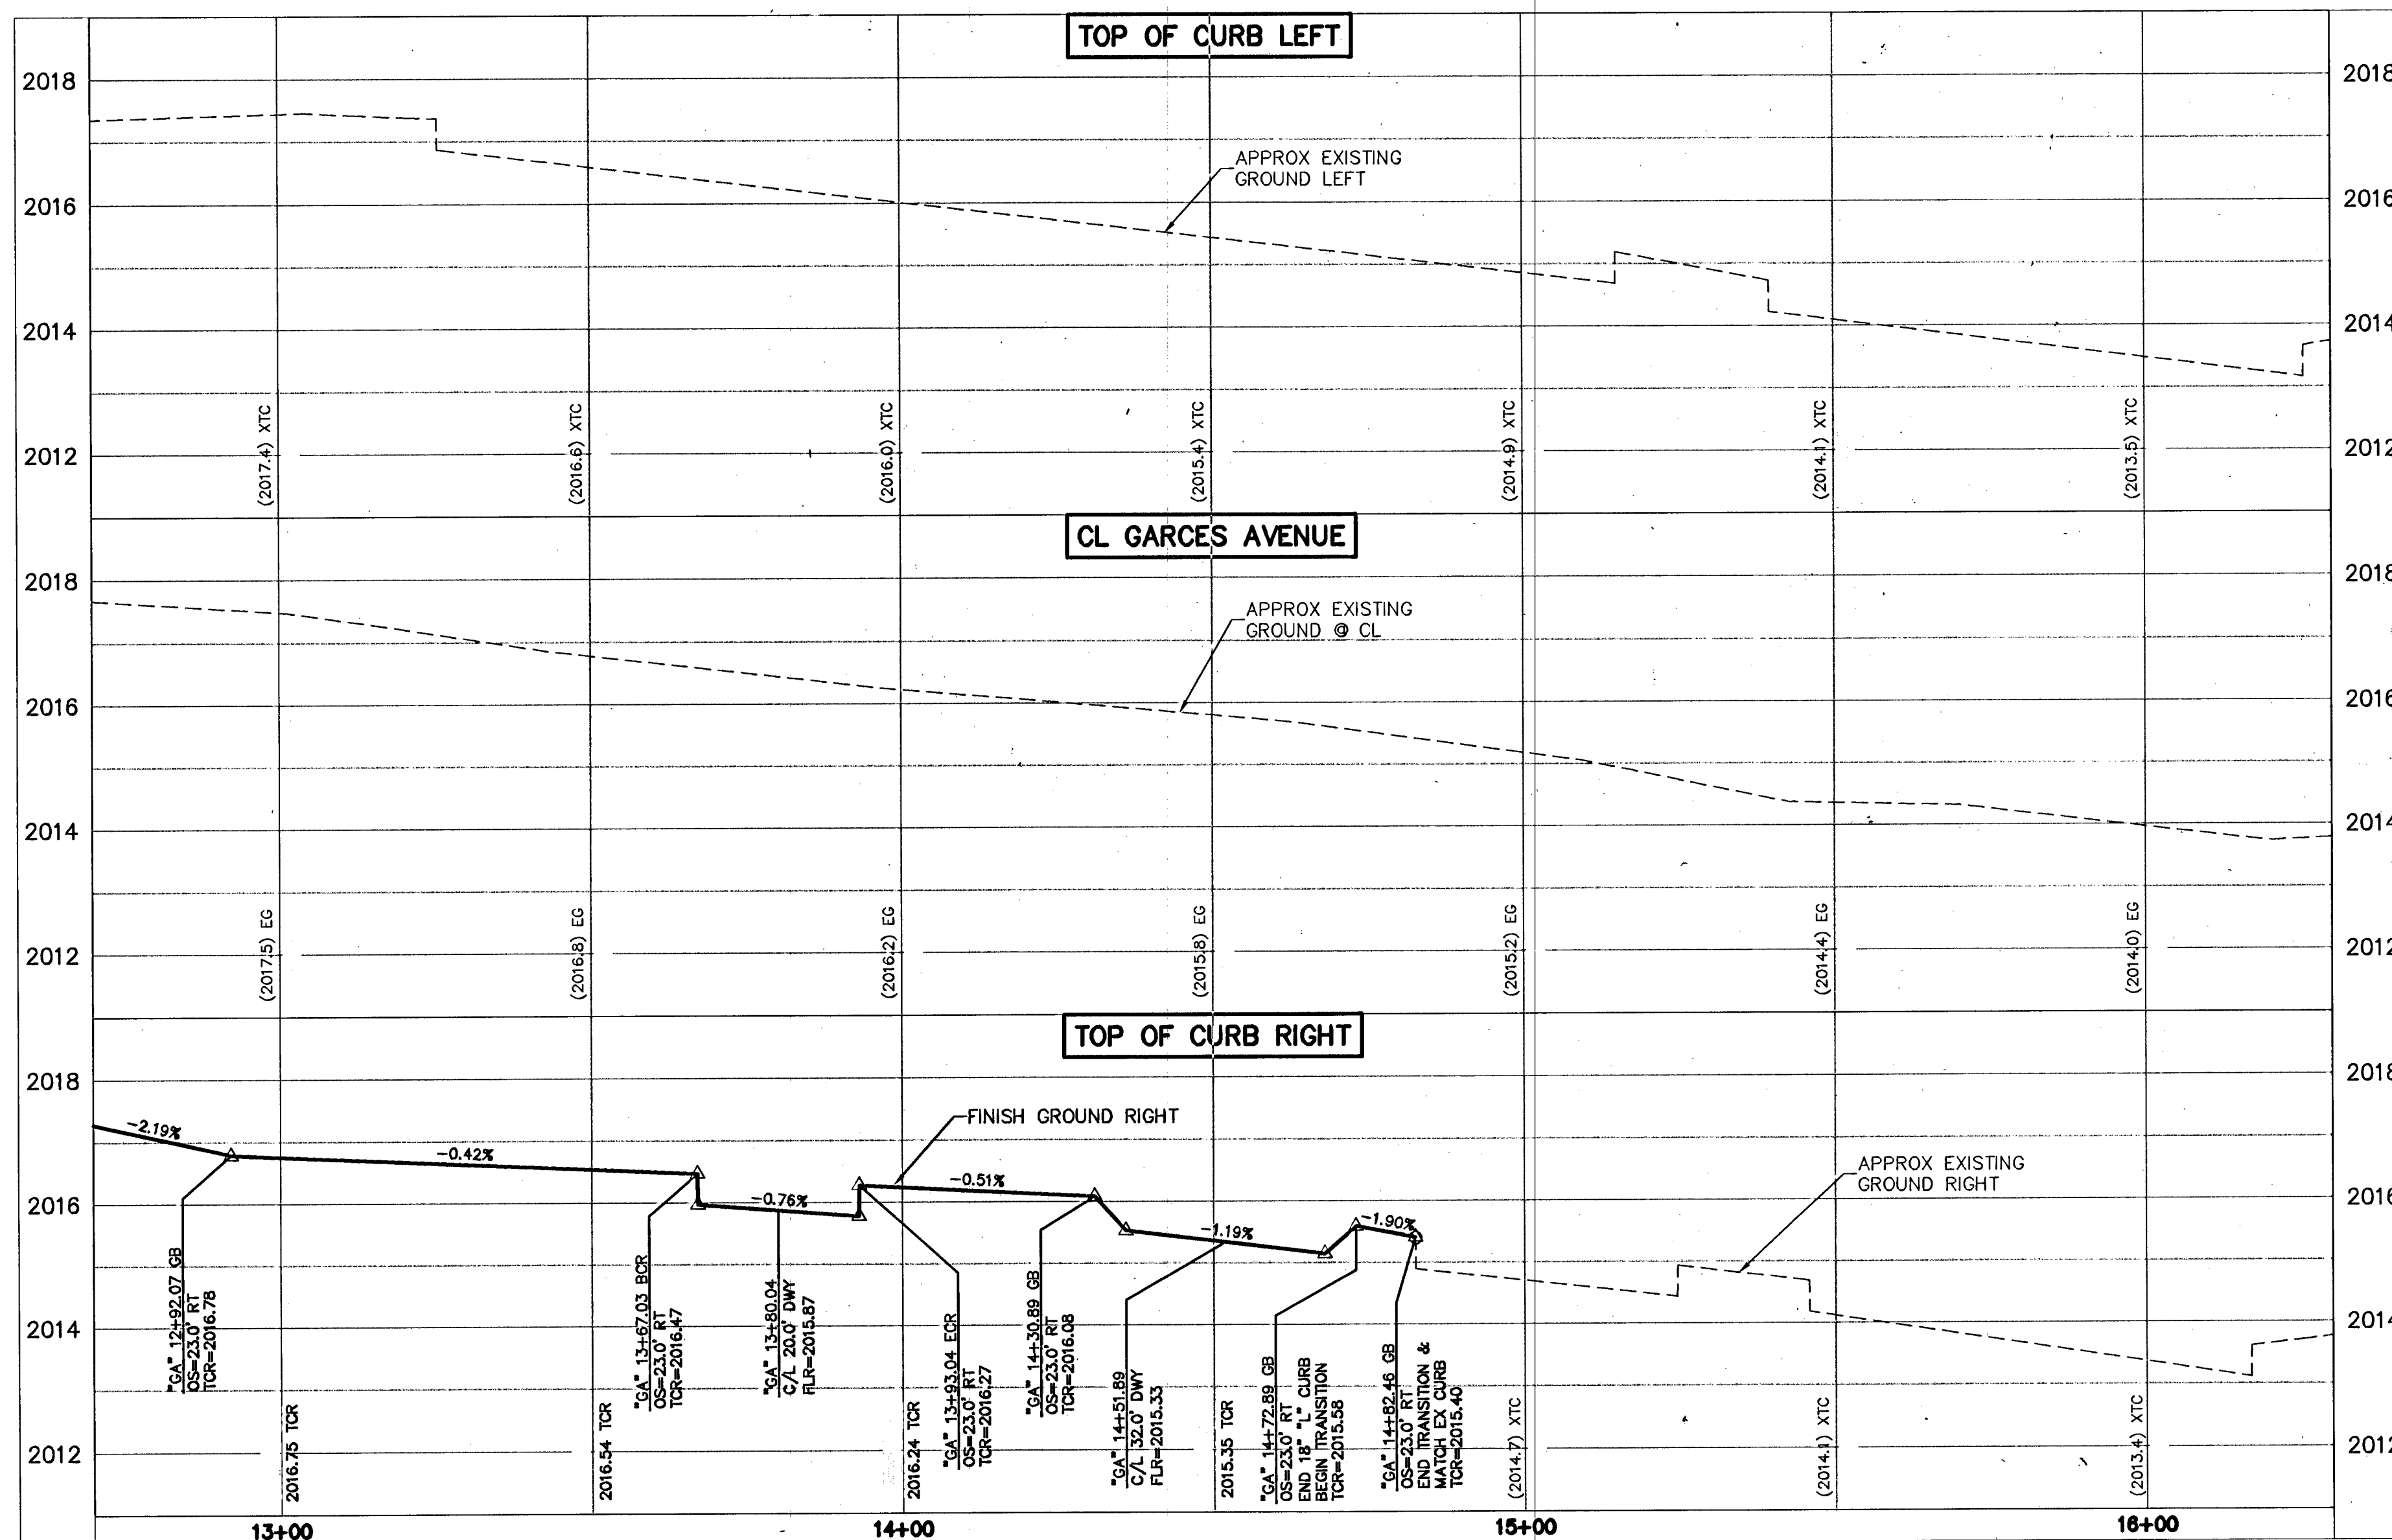

R. Milk
CLV Fire Department

9/16/13
Date

- HARDSCAPE & STREET LIGHT NOTES:**
- SEE HARDSCAPE PLANS FOR PLANTER BOX LOCATIONS
 - REFER TO STREET LIGHTING PLANS FOR NEW STREET LIGHT LOCATIONS

LVVWD NOTE:
RELOCATED SERVICES WITH LESS THAN 1" LATERALS MUST HAVE A MINIMUM OF 1" LATERALS.
WATER METERS * BOX SHALL NOT BE IN DRIVEWAY AND DRIVEWAY PAN.

WATERLINE RELOCATION NOTE:
REFER TO SHEETS W1 THROUGH W3 FOR WATERLINE RELOCATION IMPROVEMENTS.

SERVICE METER ACCOUNT & SIZE INFORMATION
(E) ACCT# 790321, MTR# 626783, 3" TB W/3" RPPA

APPROVED FOR CONSTRUCTION
Las Vegas Valley Water District Engineering Services Manager
DATE *5/15/13* PROJECT NO. *116883*

FAST
Call before you UnderGround
1-702-432-5300
FREEWAY AND ARTERIAL SYSTEM OF TRANSPORTATION

Call before you Dig
Call 811
1-702-227-2929
H#38974

DRAWN BY: *11/20/2012*
DESIGNED BY: *11/20/2012*
CHECKED BY: *11/20/2012*
PROJECT NO: *11-201*
SCALE: HORIZ 1"=20'
VERT 1"=2'

ROBERT HOSEA
CIVIL
4-16-13
SHEET **R4**
15 OF 52 SHEETS
107V6664-GARCES

ROADWAY PLAN AND PROFILE
STA 12+50 TO 16+50
GARCES AVENUE

DOWNTOWN PEDESTRIAN & BICYCLE IMPROVEMENTS
GARCES AVENUE
MAIN STREET TO 6TH STREET

PUBLIC WORKS DEPARTMENT
333 N. RANCHO DRIVE
LAS VEGAS, NV 89106
702-229-6272

777 SOUTH RANCHO BOULEVARD
LAS VEGAS, NEVADA 89106-5148
PH: (702) 872-7550
FAX: (702) 362-2557
WEB SITE: WWW.PWV.COM