



SUMMERLIN

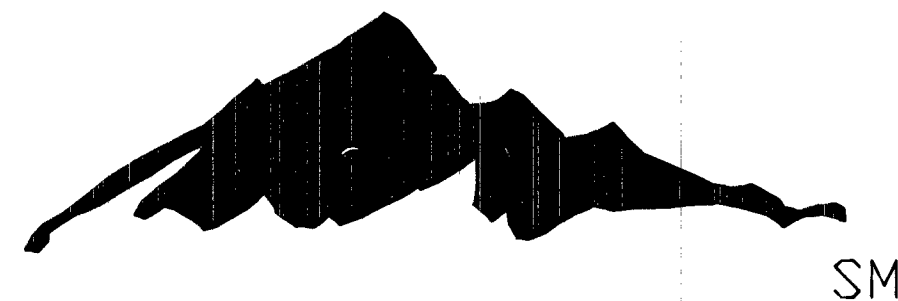

VILLAGE 23B FAR HILLS AVENUE IMPROVEMENTS - PHASE II FOX HILL DRIVE TO SKY VISTA DRIVE 2014

SID NO. 808 PROJECT 33
SID NO. 810 PROJECTS 5A, 5B, AND 5C


APN# 137-22-000-015

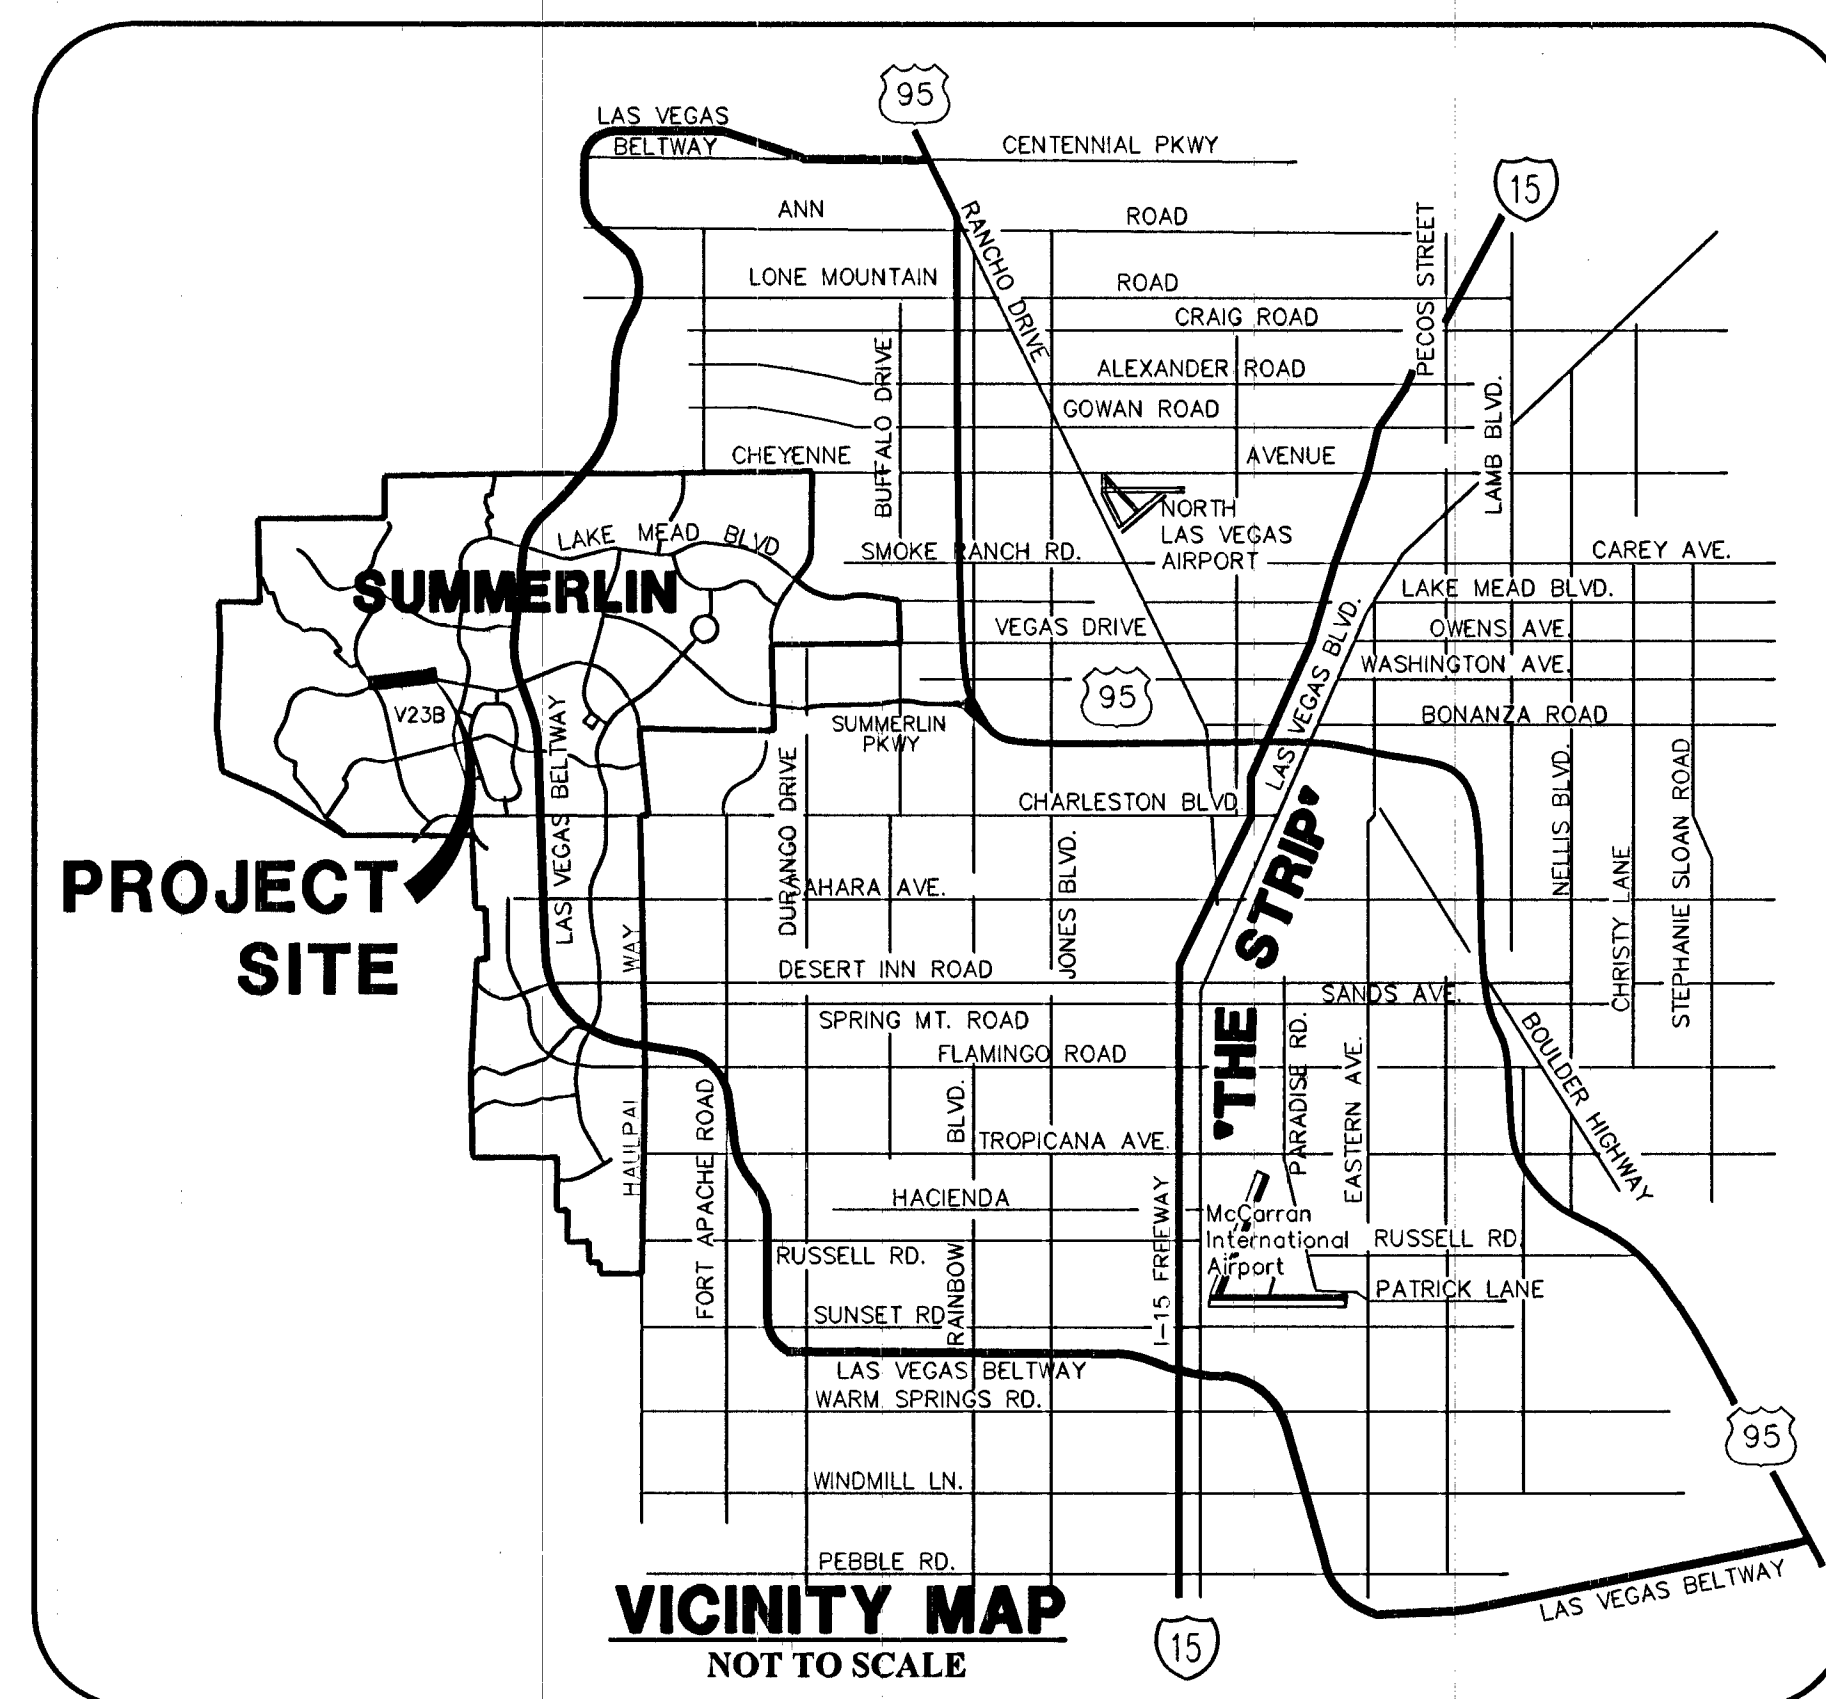

OWNER/DEVELOPER


THE HOWARD HUGHES COMPANY, LLC
10801 W. CHARLESTON BLVD., 3RD FLOOR
LAS VEGAS, NEVADA 89146
OFFICE PHONE NO. (702) 791-4300
OFFICE FAX NO. (702) 791-4450

ENGINEER

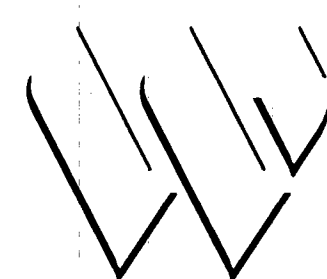

G.C. WALLACE COMPANIES
ENGINEERS | PLANNERS | SURVEYORS
1555 S. RAINBOW BLVD. LAS VEGAS, NV 89146
T: 702.804.2000 • F: 702.804.2299 • GCWALLACE.COM

INDEX OF DRAWINGS		
No.	DWG	DESCRIPTION
1	1	COVER SHEET
2	2	PROJECT DATA SHEET
3	3	GENERAL NOTE SHEET
4	4	MASTER UTILITY PLAN - WATER
5	5	MASTER UTILITY PLAN - STORM DRAIN
6	6	MASTER UTILITY PLAN - SEWER
7	7	FAR HILLS AVENUE - GRADING PLAN AND PROFILE STA: 219+50 TO 228+00
8	8	FAR HILLS AVENUE - GRADING PLAN AND PROFILE STA: 228+00 TO 234+00
9	9	FAR HILLS AVENUE - GRADING PLAN AND PROFILE STA: 234+00 TO 242+50
10	10	FAR HILLS AVENUE - UTILITY PLAN AND PROFILE STA: 219+50 TO 228+00
11	11	FAR HILLS AVENUE - UTILITY PLAN AND PROFILE STA: 228+00 TO 234+00
12	12	FAR HILLS AVENUE - UTILITY PLAN AND PROFILE STA: 234+00 TO 242+50
13	13	LATERAL PROFILES 1
14	14	LATERAL PROFILES 2
15	15	ROADWAY SECTION DETAILS
16	16	UTILITY DETAILS
17	17	TRAFFIC CONTROL - SIGNAGE AND STRIPING PLAN
18	18	TRAFFIC CONTROL - NOTES & DETAILS
19	19	STREET LIGHTING - CONDUIT AND ELECTRICAL PLAN
20	20	STREET LIGHTING - NOTES & DETAILS

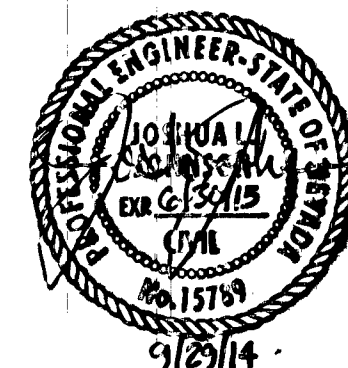

DRAINAGE CERTIFICATION

I CERTIFY THAT THE GRADING PLANS ARE IN CONFORMANCE WITH THE APPROVED DRAINAGE STUDY ON FILE AT THE CITY OF LAS VEGAS FOR THIS PROJECT.

Joshua L. Johnson 5/5/14
JOSHUA L. JOHNSON P.E. 15789 DATE

David Bowers 7/2/14
DAVID BOWERS, PE, PTOE, PE# 16736
CITY ENGINEER
CITY OF LAS VEGAS, NEVADA

APPROVAL OF THESE PLANS IS LIMITED TO THOSE IMPROVEMENTS CONSTRUCTED IN THE DEDICATED RIGHTS-OF-WAY AND/OR DEDICATED EASEMENTS. THIS APPROVAL DOES NOT AUTHORIZE THE CONSTRUCTION OF ANY IMPROVEMENTS THAT DEVIATE FROM ADOPTED STANDARDS AND/OR SPECIFICATIONS, EXCEPT THOSE SPECIFICALLY LISTED UNDER "DEVIATIONS FROM STANDARDS". THE ENGINEER SHALL RESOLVE ANY DEVIATION OTHER THAN THOSE LISTED IN "DEVIATIONS FROM STANDARDS" IN FAVOR OF THE UNIFORM STANDARD DRAWINGS AND SPECIFICATIONS CLARK COUNTY AREA NEVADA.

CLV PLANNING DEPARTMENT
THIS PLAN MEETS THE APPLICABLE STANDARDS OF THE CITY OF LAS VEGAS PLANNING DEPARTMENT
NA
CHRIS KNIGHT, DIRECTOR BUILDING AND SAFETY DATE

APPROVED FOR CONSTRUCTION
David M. Wade
LAS VEGAS VALLEY WATER DISTRICT ENGINEERING SERVICES MANAGER
PROJECT NO. 122213 DATE: 6/24/14
DRAWINGS: 1-4, 10-13, 14 & 16

THE HOWARD HUGHES COMPANY, LLC
Kevin Orrock 6/27/14
KEVIN ORROCK
TITLE: VICE PRESIDENT DATE

LAS VEGAS VALLEY WATER DISTRICT NOTE:

THIS PROJECT PLAN APPROVAL CONTINGENT ON SUMMERLIN VILLAGE 23B 24" 3550 ZONE WATERLINE (LVWD #12123) PLAN APPROVAL

UTILITY/AGENCY APPROVALS

Roshanda Barker 4/7/14
COX COMMUNICATIONS LAS VEGAS, INC. DATE

Larry Washburn 4-7-14
CENTRAL TELEPHONE CO., DBA CENTURYLINK DATE

THE AFFIXED CENTURYLINK APPROVAL DOES NOT ASSUME OR GUARANTEE LIABILITY FOR KNOWN OR UNKNOWN CONFLICTS WITH EXISTING OR PROPOSED IMPROVEMENTS. RESOLUTION OF ANY CONFLICT WILL BE ACCOMPLISHED PURSUANT TO LOCAL ORDINANCES, NEVADA REVISED STATUTES AND/OR PUBLIC UTILITY COMMISSION RULES AND REGULATIONS.


Barbara Garrison 4-7-14
NV ENERGY DATE

NEVADA POWER COMPANY ACKNOWLEDGES THAT WE HAVE RECEIVED YOUR PLANS AND WILL PROVIDE SERVICE TO ALL ELECTRICAL NEEDS ASSOCIATED WITH THIS PROJECT. NEVADA POWER COMPANY RESERVES THE RIGHT TO ADDRESS ANY EXISTING OR FUTURE CONFLICTS ONCE THE FINAL DESIGN IS COMPLETED. THE NEW SERVICE AND THE RESOLUTION OF ANY CONFLICTS WILL BE ACCOMPLISHED PURSUANT TO THE NEVADA PUBLIC UTILITY COMMISSION'S RULES AND REGULATIONS.

John Hammy 5-15-14
NV ENERGY - TRANSMISSION ENGINEERING DATE

Nicole Hunt 5/12/14
SOUTHWEST GAS CORP. DATE

H NO. 53053 CLV DRAWING NO. 107V 6128-2

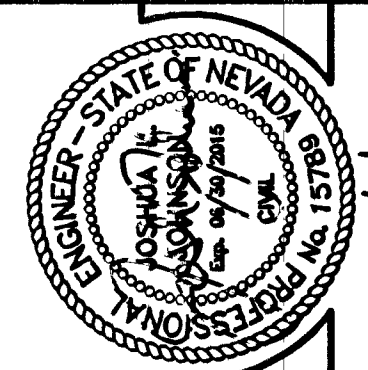

G.C. WALLACE COMPANIES
ENGINEERS | PLANNERS | SURVEYORS
1555 S. RAINBOW BLVD. LAS VEGAS, NV 89146
T: 702.804.2000 • F: 702.804.2299 • GCWALLACE.COM

THE HOWARD HUGHES COMPANY, LLC
VILLAGE 23B FAR HILLS AVENUE IMPROVEMENTS - PHASE II
COVER SHEET

DRAWING
1
1 OF 20 SHTS

JOB NO. 62023B-208