
 



NOTE: EXISTING SEWER
LATERALS TO BE
RECONNECTED TO
NEW SEWER

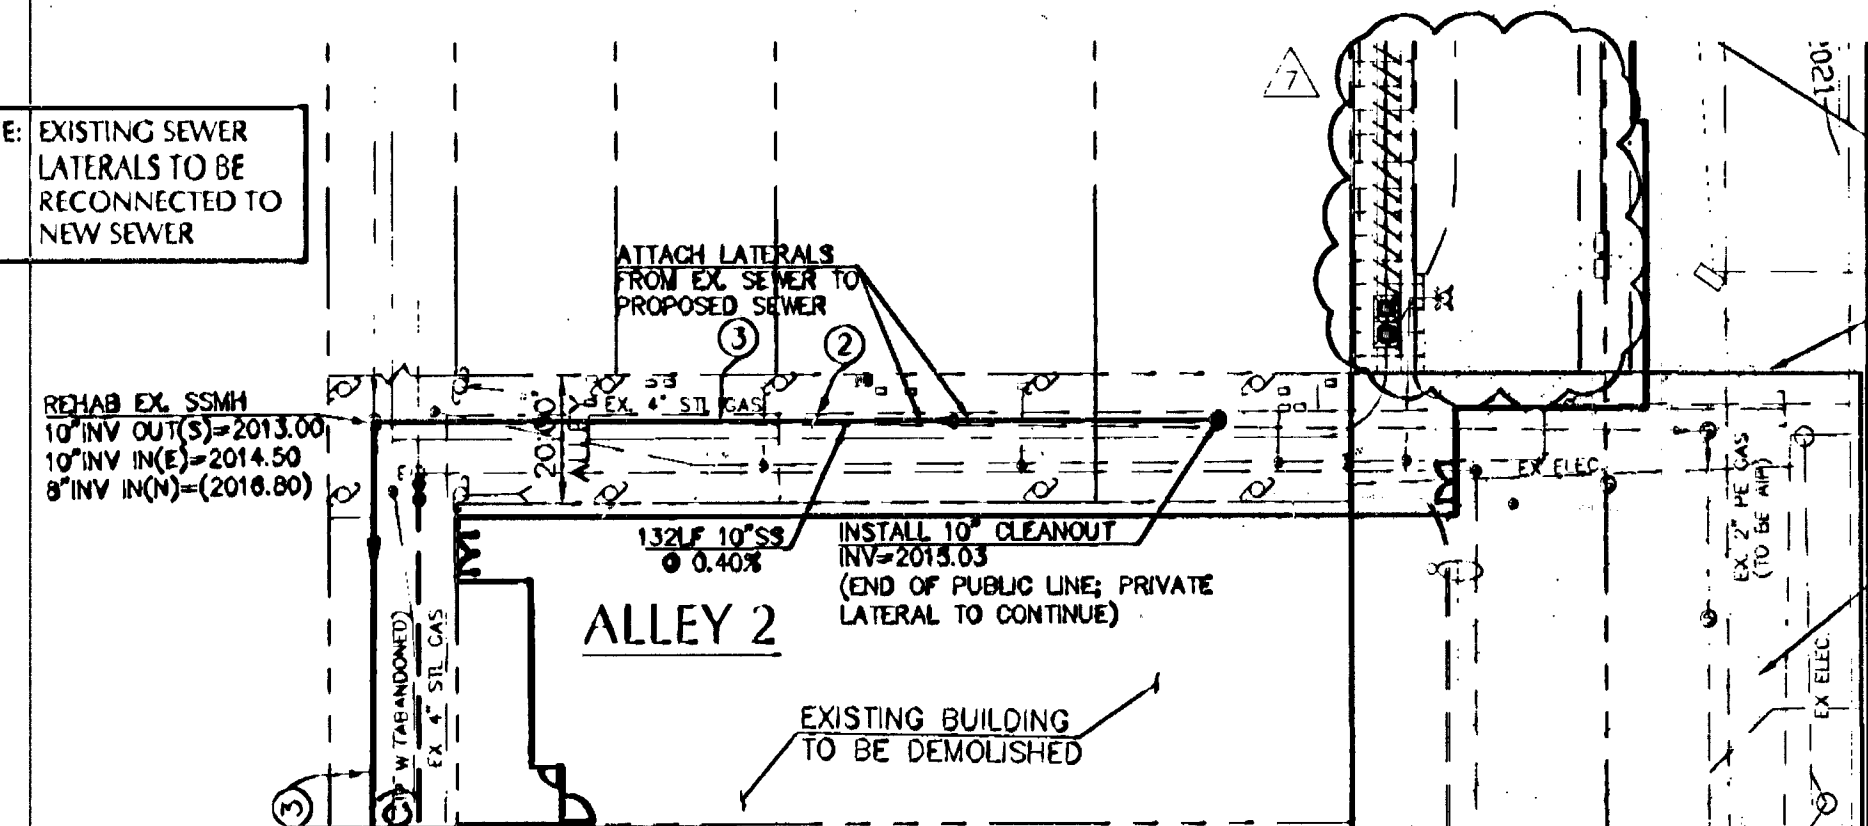


GRAPHIC SCALE



(IN FEET)
1 INCH = 30 FT

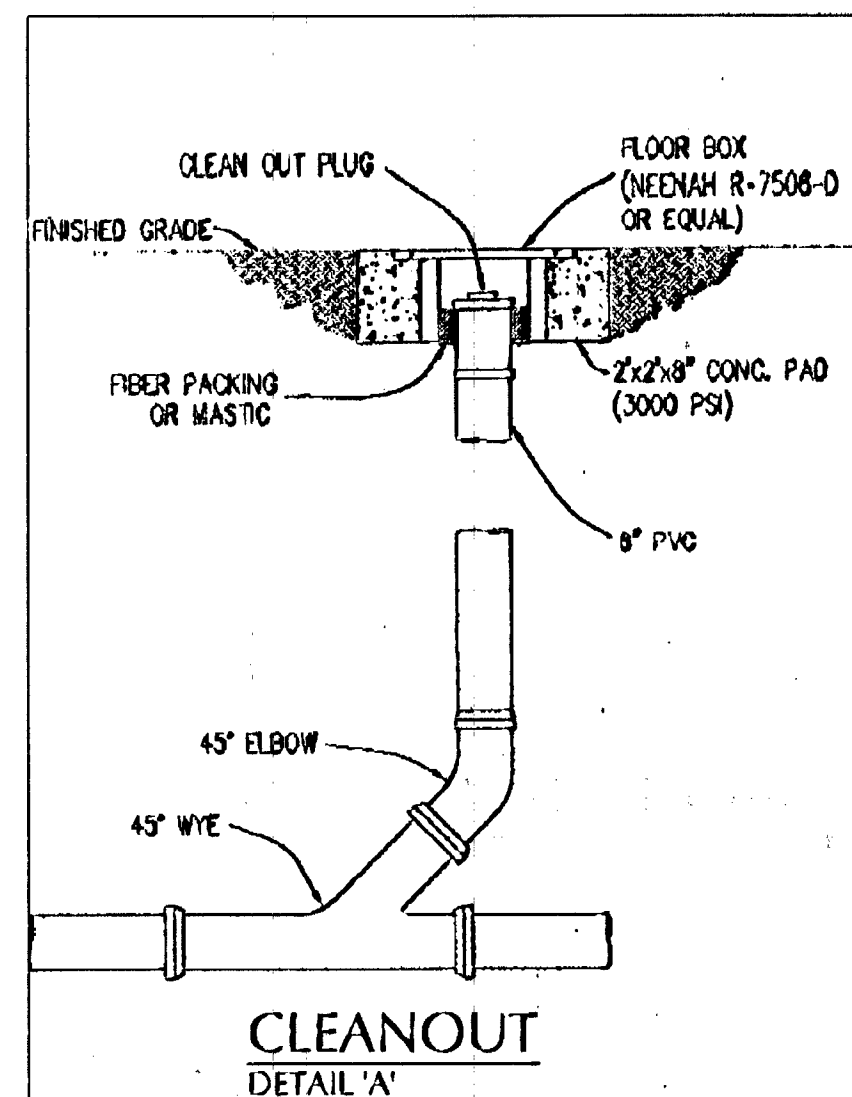


CLEANOUT
DETAIL 'A'

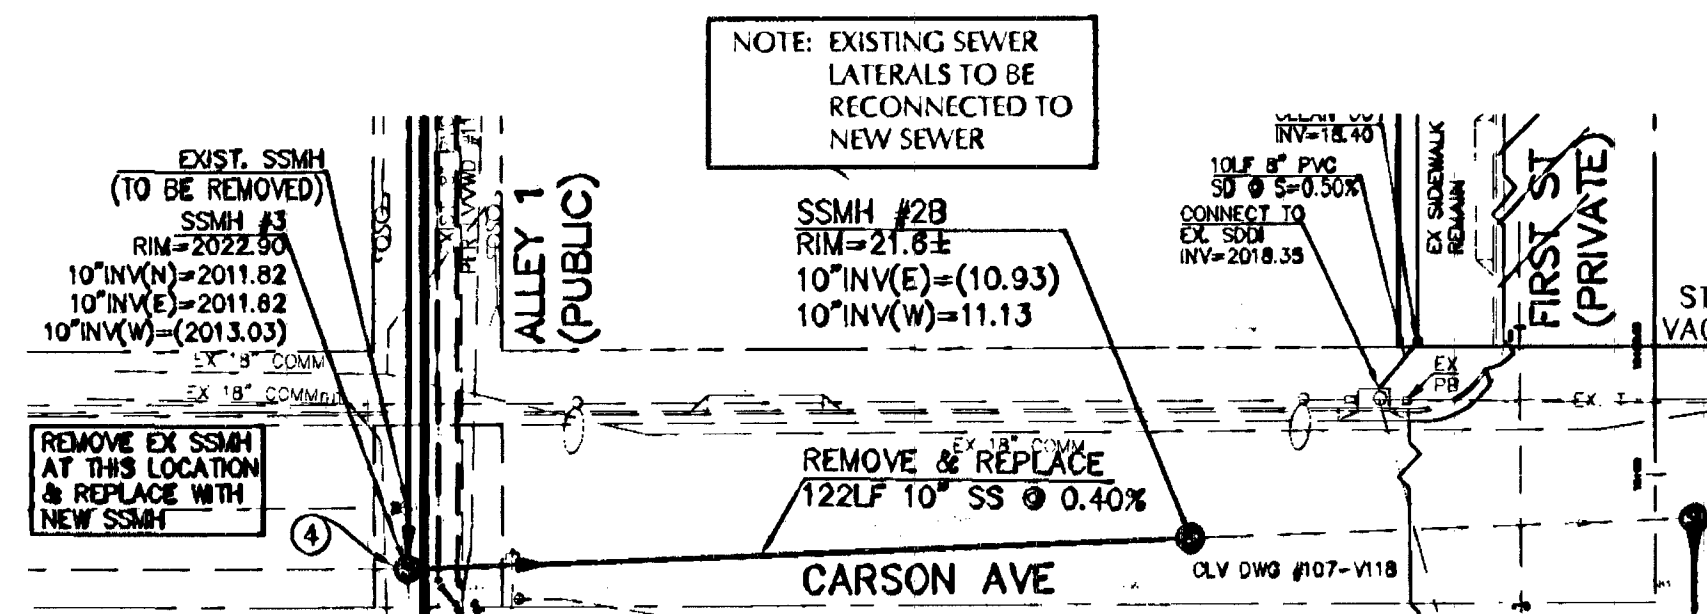


CARSON AVE (PUBLIC)

 
GRAPHIC SCALE



(IN FEET)
1 INCH = 30 FT

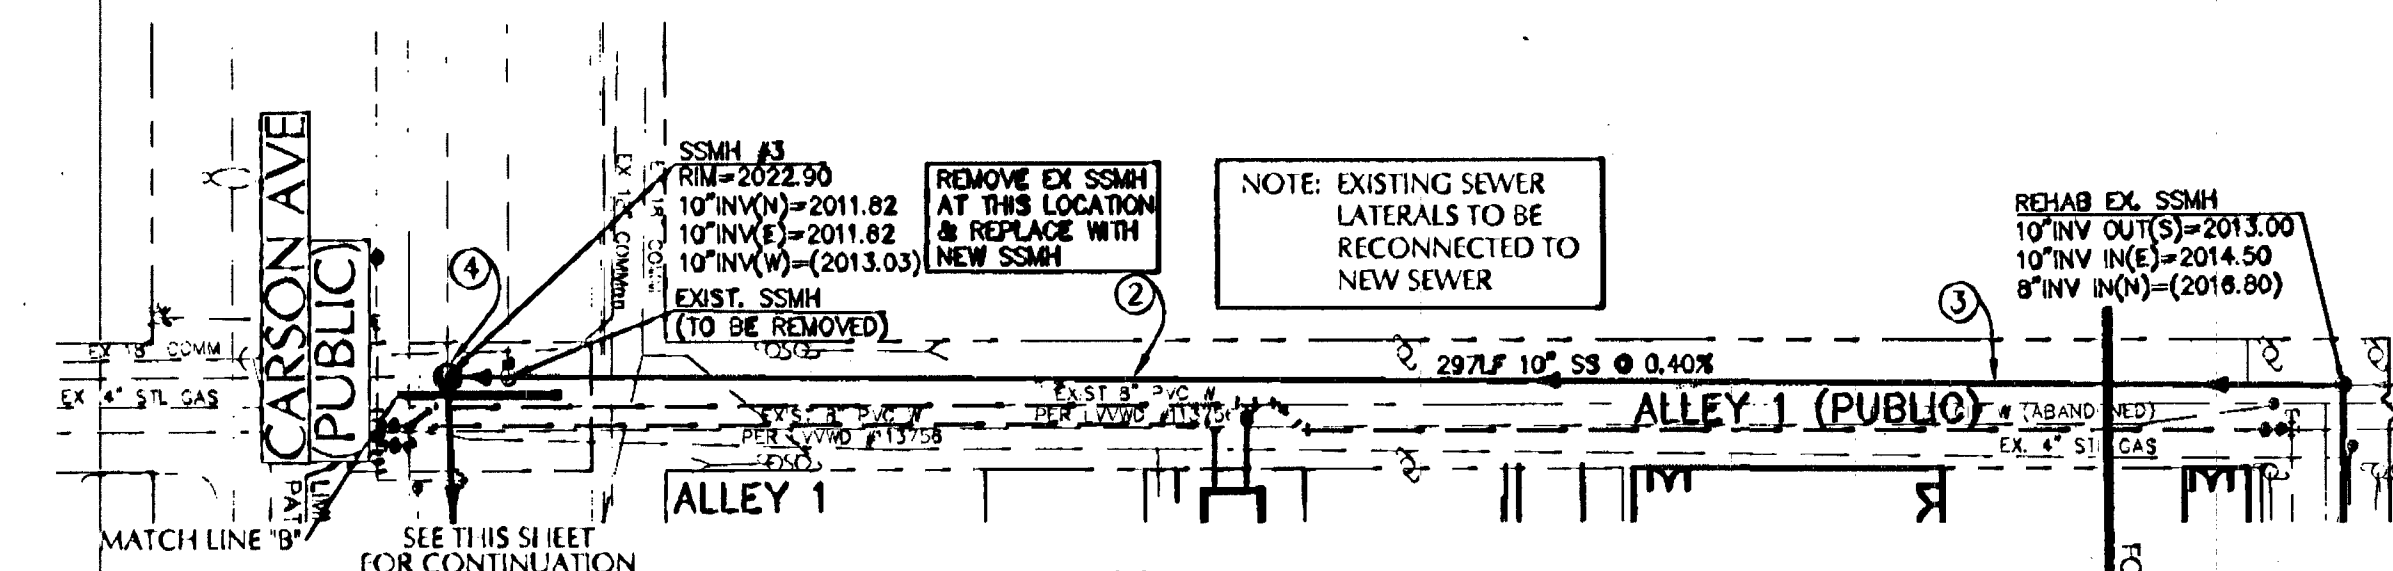

GRAPHIC SCALE

 

(IN FEET)
1 INCH = 30 FT

2030

2025

2020

2015

2010

0+00

1+00

2+00

3+00

4+00

5+00

6+00

EXISTING GROUND
CENTERLINE
OF SANITARY

NOTE: CONTRACTOR TO VERIFY DEPTH OF
WATER & GAS AT THESE CROSSINGS

10" CLEANOUT
SEE DETAIL 'A'
THIS SHEET

SEWER ENCASEMENT
10" EACH SIDE OF
CROSSING PER
SD-22 DCSWCS

132LF 10" PUBLIC
PVC SS @ 0.40%
STA=5+29.00
INV OUT=2015.03
(END OF PUBLIC LINE;
PRIVATE LATERAL TO
CONTINUE)

PLUG EX. 8"
DURING SSMH
REHAB

EX. 8" PUBLIC SEWER
TO BE ABANDONED IN PLACE

EX. 8" PUBLIC SEWER
TO BE ABANDONED IN PLACE
INV=2010.8

REFERENCE
SHEET C-7
CLV# 107-V-1181

SSMH #3
RIM=2022.90
CONT'D ABOVE
RIGHT

EX SSMH
RIM=(2022.79)
(TO BE REMOVED)

STA: 1+10.00
EX. 8" INV IN(W)=2017.65
EX. 8" INV OUT(NE)=2017.45

EX. 8" PUBLIC SEWER
TO BE REMOVED

297LF 10" PUBLIC
PVC SS @ 0.40%

BEGIN SLURRY (CLSM):
4" MIN. AROUND PIPE

STA: 2+35.00
END SLURRY (CLSM):
4" MIN. AROUND PIPE

ALLEY

SCALE: HORIZONTAL 1"=30'
VERTICAL 1"=3'

2030

2025

2020

2015

2010

2020

2015

2010

REFERENCE
SHEET C-7
CLV# 107-V-1181

SSMH #3
RIM=2022.90
CONT'D BELOW
LEFT

EXISTING GROUND
CENTERLINE
OF SANITARY

SSMH #28
RIM=21.8E
10" INV(E)=(10.93)
10" INV(W)=11.13

122LF 10" PUBLIC PVC
SS @ 0.40%

STA=1+00.00
10" INV IN(N)=2011.82
10" INV OUT(E)=(2010.93)
10" INV IN(W)=(2013.03)

STA=2+22.00
10" INV OUT(E)=(2010.93)
10" INV IN(W)=2011.13

CARSON STREET

SCALE: HORIZONTAL 1"=30'
VERTICAL 1"=3'


LEGEND

EXISTING	PROPOSED	DESCRIPTION	EXISTING	PROPOSED	DESCRIPTION
---	---	WATER LINE	---	---	WATER LINE
---	---	SANITARY SEWER LINE	---	---	SANITARY SEWER LINE
---	---	GAS LINE	---	---	GAS LINE
---	---	STORM DRAIN	---	---	STORM DRAIN
---	---	POWER LINE/POLE	---	---	POWER LINE/POLE
---	---	TELEPHONE LINE	---	---	TELEPHONE LINE
---	---	FIRE DEPARTMENT CONNECTION	---	---	FIRE DEPARTMENT CONNECTION
---	---	WATER VALVE	---	---	WATER VALVE
---	---	GAS VALVE	---	---	GAS VALVE
---	---	METERS/PULL BOXES	---	---	METERS/PULL BOXES
---	---	REDUCER	---	---	REDUCER
---	---	MANHOLE	---	---	MANHOLE
---	---	CLEANOUT	---	---	CLEANOUT
---	---	SEWER MANHOLE	---	---	SEWER MANHOLE
---	---	UTILITY POLE	---	---	UTILITY POLE
---	---	DRAIN INLET	---	---	DRAIN INLET
---	---	AREA LIGHT	---	---	AREA LIGHT
---	---	STREET LIGHTS	---	---	STREET LIGHTS
---	---	MISCELLANEOUS	---	---	MISCELLANEOUS
---	---	100 W.H.P.S.	---	---	100 W.H.P.S.
---	---	150 W.H.P.S.	---	---	150 W.H.P.S.
---	---	200 W.H.P.S.	---	---	200 W.H.P.S.
---	---	250 W.H.P.S.	---	---	250 W.H.P.S.

CONSTRUCTION NOTES:

1. INSTALL 48" SSMH (FLAT TOP)
2. REMOVE EXISTING 8" SEWER
3. CONSTRUCT NEW 10" PVC SEWER
4. CONNECT 10" SEWER TO EXIST SSMH

VICINITY MAP

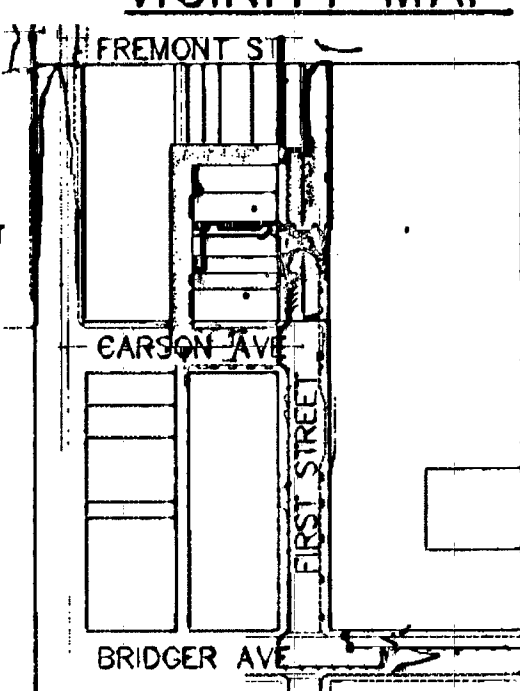

AS BUILTS

NO.	DESCRIPTION OF REVISIONS	DATE	INITIALS
1	ADJUST FIRST ST SANITARY SEWER	12/11/06	RRS
2	REVERSE WATER	12/14/06	RRS
3	REVISE ALLEY SANITARY SEWER	2/22/07	RRS
4	REVISE ALLEY SANITARY SEWER	05/30/2007	RRS
5	REVISED SD & FH INFORMATION	8/5/12	RRS

GNLV CORPORATION
P.O. BOX 610
LAS VEGAS NEVADA
89125

MARTIN & MARTIN
CIVIL ENGINEERS
SUITE 120
LAS VEGAS, NV 89146
PHONE (702) 248-8000
FAX (702) 248-8070

SANITARY SEWER PLAN AND PROFILE

GOLDEN NUGGET
TOWER ADDITION

DATE: 10/12/06
JOB NUMBER: 2107.02
DESIGN BY: J. PATCHETT, E.I.
DRAWN BY: B. FUNK
CHECKED BY: R. STREGL, P.E.

SEAL
KENNETH J. WELDON
EXP. 06-30-12
CIVIL
NO. 020244
8/21/11

SHEET
C5.07
SHEET 13 OF 14
DRAWING NUMBER
107V4611-2

128836

CALL BEFORE YOU DIG
CALL 1-702-435-7511
CALL 1-702-227-9511

Call before you dig
CALL 1-800-227-2600
UNDERGROUND SERVICE (USA)

MARTIN & MARTIN ASSUMES NO RESPONSIBILITY FOR EXISTING UTILITY LOCATIONS AND ELEVATIONS. THE UTILITIES SHOWN ON THIS DRAWING HAVE BEEN PLOTTED FROM THE BEST AVAILABLE INFORMATION. IT IS, HOWEVER, THE CONTRACTOR'S RESPONSIBILITY TO FIELD VERIFY THE LOCATION AND ELEVATION OF ALL UTILITIES PRIOR TO THE COMMENCEMENT OF ANY CONSTRUCTION. CONTRACTOR TO FIELD VERIFY ALL EXISTING SITE CONDITIONS PRIOR TO CONSTRUCTION. IF A CONFLICT EXISTS BETWEEN WHAT IS SHOWN ON THESE DRAWINGS AND WHAT EXISTS IN THE FIELD, THE CONTRACTOR IS TO NOTIFY THE ARCHITECT OR ENGINEER IMMEDIATELY.

MYLAR RELOT