


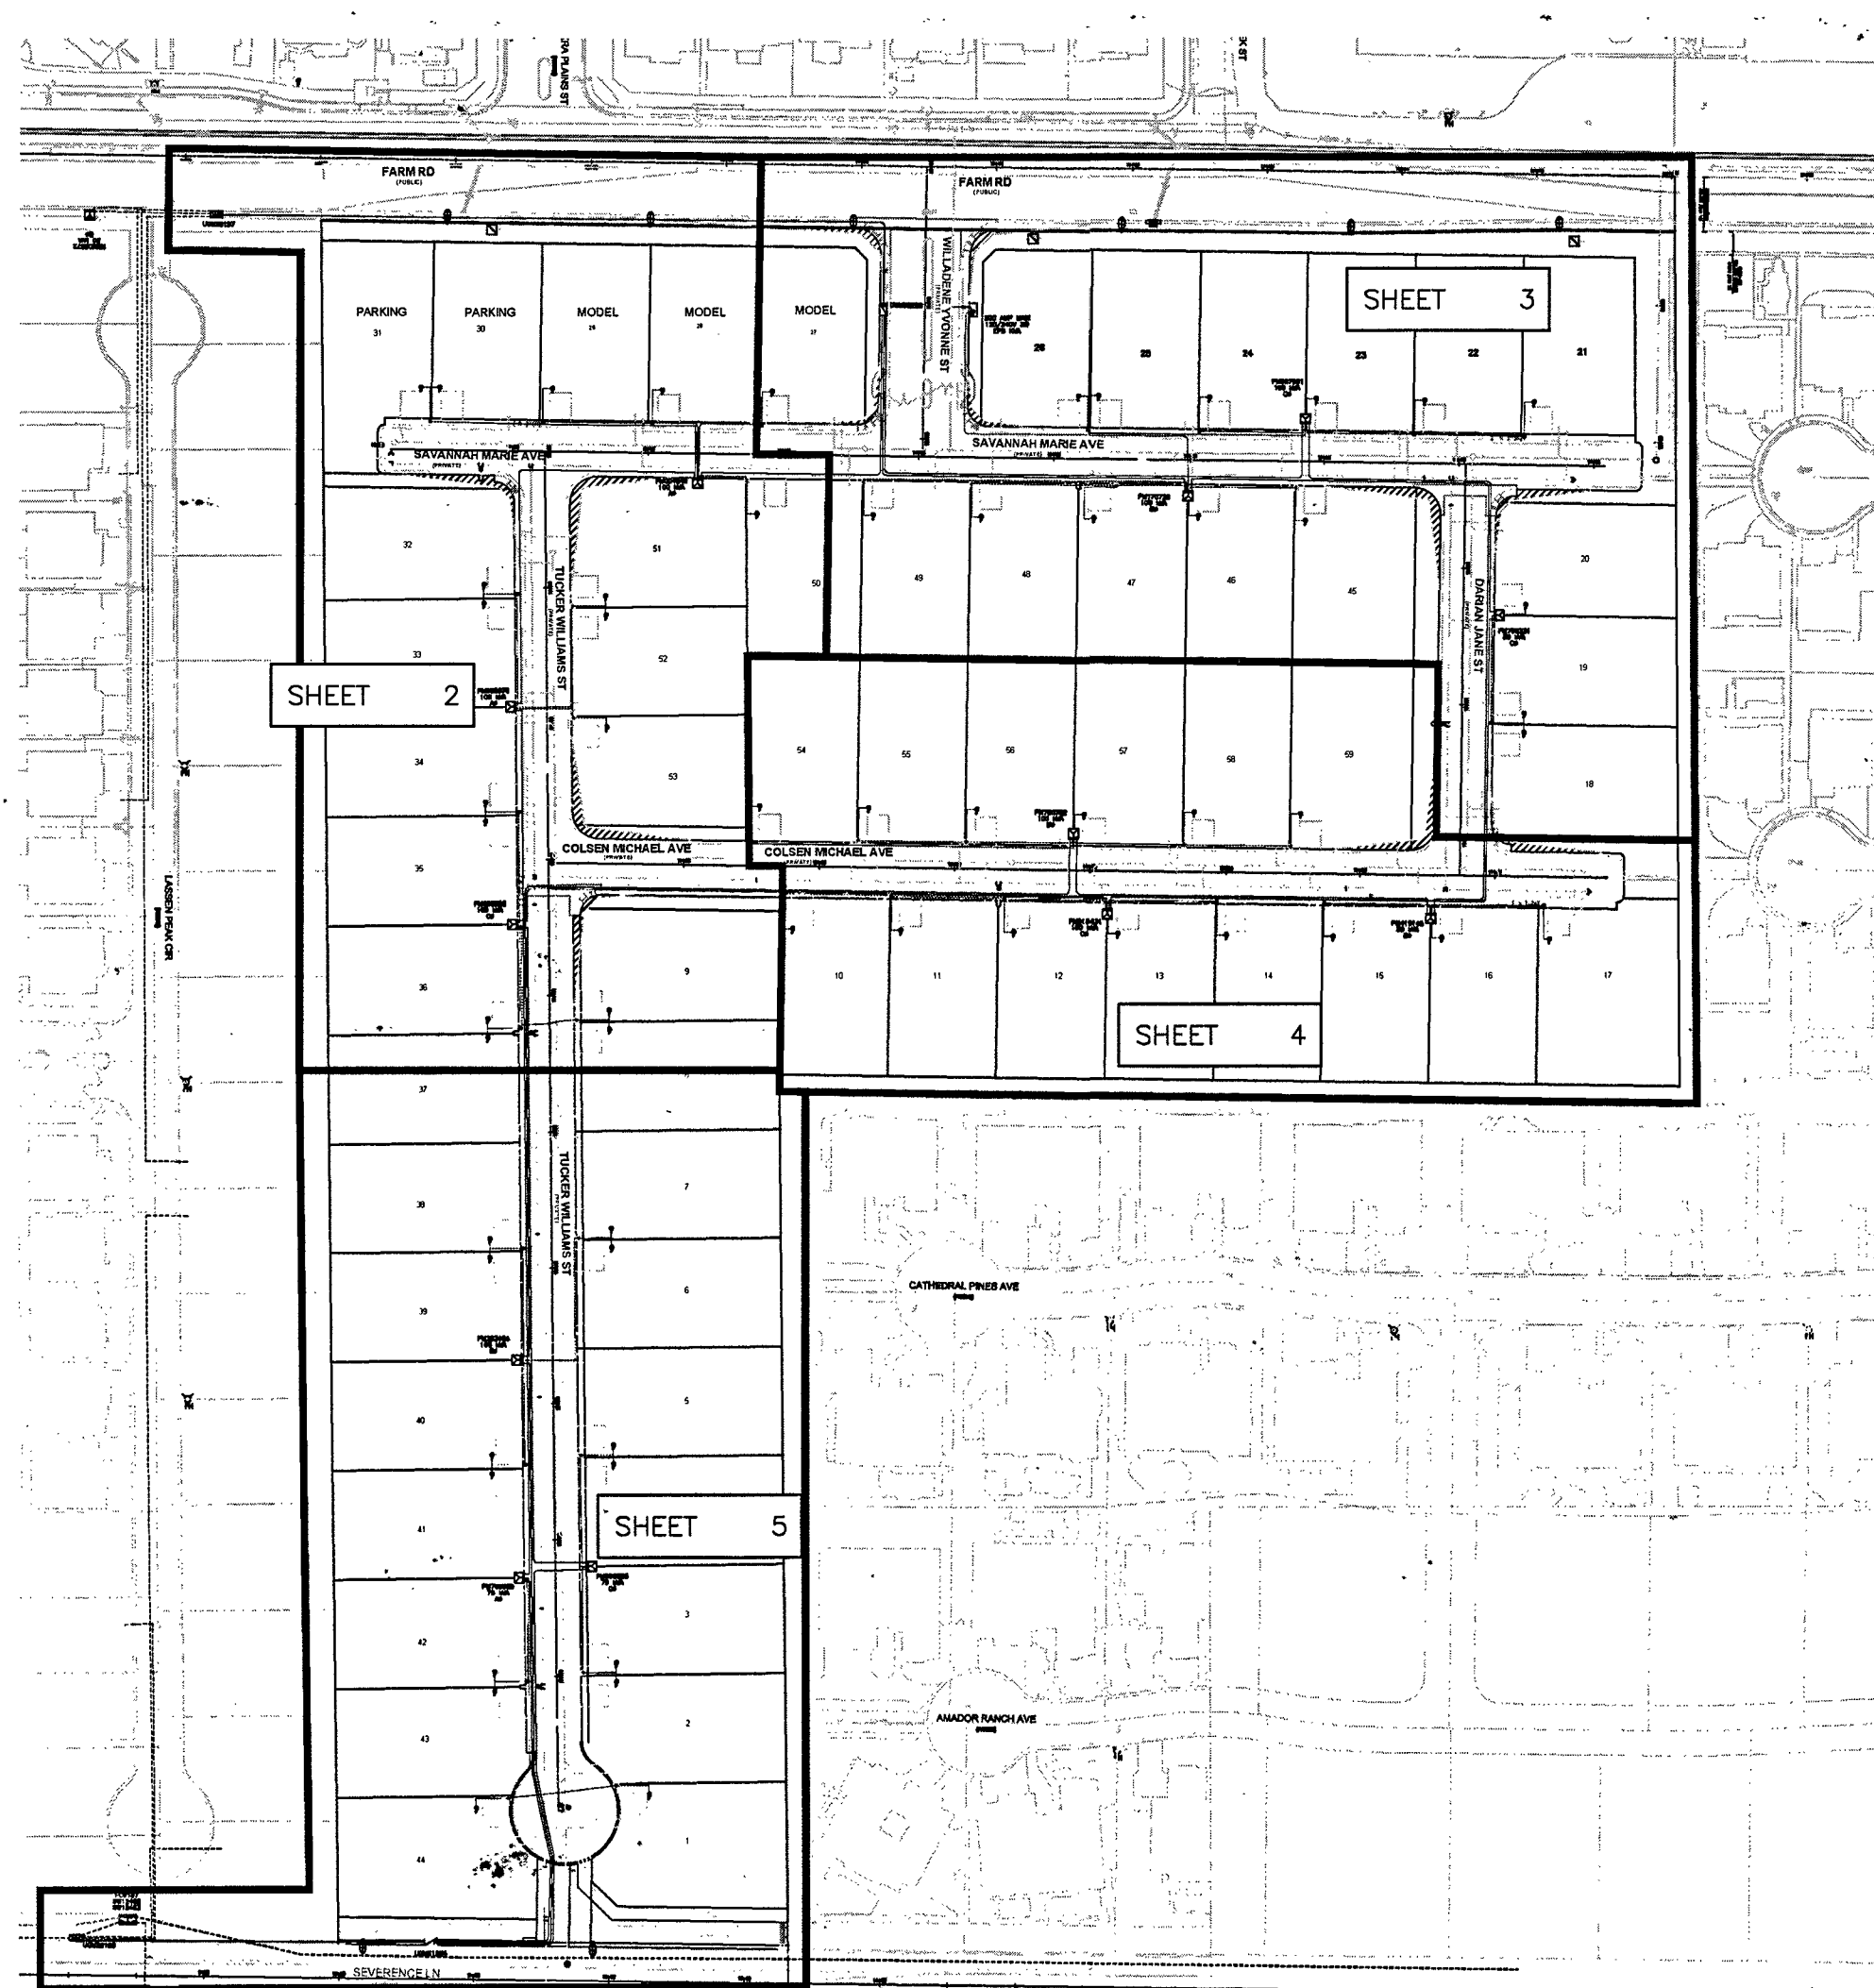

## OVERALL PROJECT

-NOT TO SCALE-

## CONDUIT SEALING REQUIREMENT:

CONDUIT SEALING PER NESC AND OR NEP LATEST VERSION.  
ALL ELECTRIC CONDUITS ENTERING BUILDING THROUGH  
PENETRATING CONCRETE SLAB SHALL BE SEALED AT JOINTS  
WITH EXPANDING PLUGS AFTER CONDUIT IS HANDLED.  
NVE WILL INSTALL A PERMANENT SEAL  
AFTER CONDUITS ARE INSTALLED.

## METER LOCATION & ACCESS REQUIREMENTS

(NVE ENERGY STANDARDS RPI-2 & RPI-G)

MIN. 3'X3' CLEAR, LEVEL SPACE (SAFE WORK SPACE) REQUIRED  
DIRECTLY IN FRONT OF METER. THIS SPACE SHALL NOT BE PART OF  
A DRIVEWAY OR SUBJECT TO VEHICULAR TRAFFIC.

SERVICE POINT TO BE NO GREATER THAN 100' FROM BACK OF CURB  
OR PUBLIC EASEMENT (NO GREATER THAN 25' FROM SIDE STREET OR  
ALLEY).

A SERVICE PEDESTAL MUST BE 5' MIN. FROM BACK OF CURB, 6' MIN  
FROM DRIVEWAY OR OTHER TRAFFIC AREA.

BOTH SERVICE POINT AND SAFE WORK SPACE TO BE DIRECTLY  
VISIBLE FROM BACK OF CURB OR PUBLIC EASEMENT, AND MUST BE  
EASILY ACCESSIBLE TO NV ENERGY AT ALL TIMES WITHOUT REQUIRING  
PASSAGE THROUGH RESTRICTED AREAS OR REQUIRING CUSTOMER  
CONTACT, FENCES, GATES, WALLS, OR OTHER OBSTRUCTIONS IN FRONT  
OF THE SERVICE POINT ARE PROHIBITED.

VISIBILITY, ACCESSIBILITY, AND SAFE WORK SPACE MUST BE  
MAINTAINED FOR THE ENTIRE LIFE OF THE SERVICE.

## NOTICE:

THIS EXHIBIT IS THE EXCLUSIVE AND CONFIDENTIAL PROPERTY OF  
NV ENERGY AND MAY NOT BE USED, REPRODUCED OR  
DISTRIBUTED WITHOUT THE EXPRESSED, WRITTEN APPROVAL OF NV  
ENERGY.


THE IMAGES HEREON ARE NOT ORTHOPHOTOGRAPHIC. ANY  
LOCATIONS DEPICTED HEREON ARE APPROXIMATE ONLY. THIS  
EXHIBIT WAS CREATED FOR GENERAL PRESENTATION AND  
DISCUSSION PURPOSES ONLY AND IS NOT PURPORTED TO  
REPRESENT ANY MEASURE OF ACCURACY. THIS EXHIBIT IS NOT TO  
BE UTILIZED IN ANY MANNER NOT CONSISTENT WITH THE INTENT  
OF ITS CREATION AS STATED ABOVE.

## FIRE HYDRANT CLEARANCE:

6' RADIUS FROM CENTER OF HYDRANT TO ALL ABOVE  
GROUND PADS AND/OR EQUIPMENT AND ALL  
MANHOLES AND SWITCHBOXES.

6' RADIUS FROM CENTER OF HYDRANT TO ALL  
UNDERGROUND HANDHOLES, PULLBOXES AND  
SPURBOXES. ALL PER NVEnergy STD. RS-5

## FARM RD (PUBLIC)

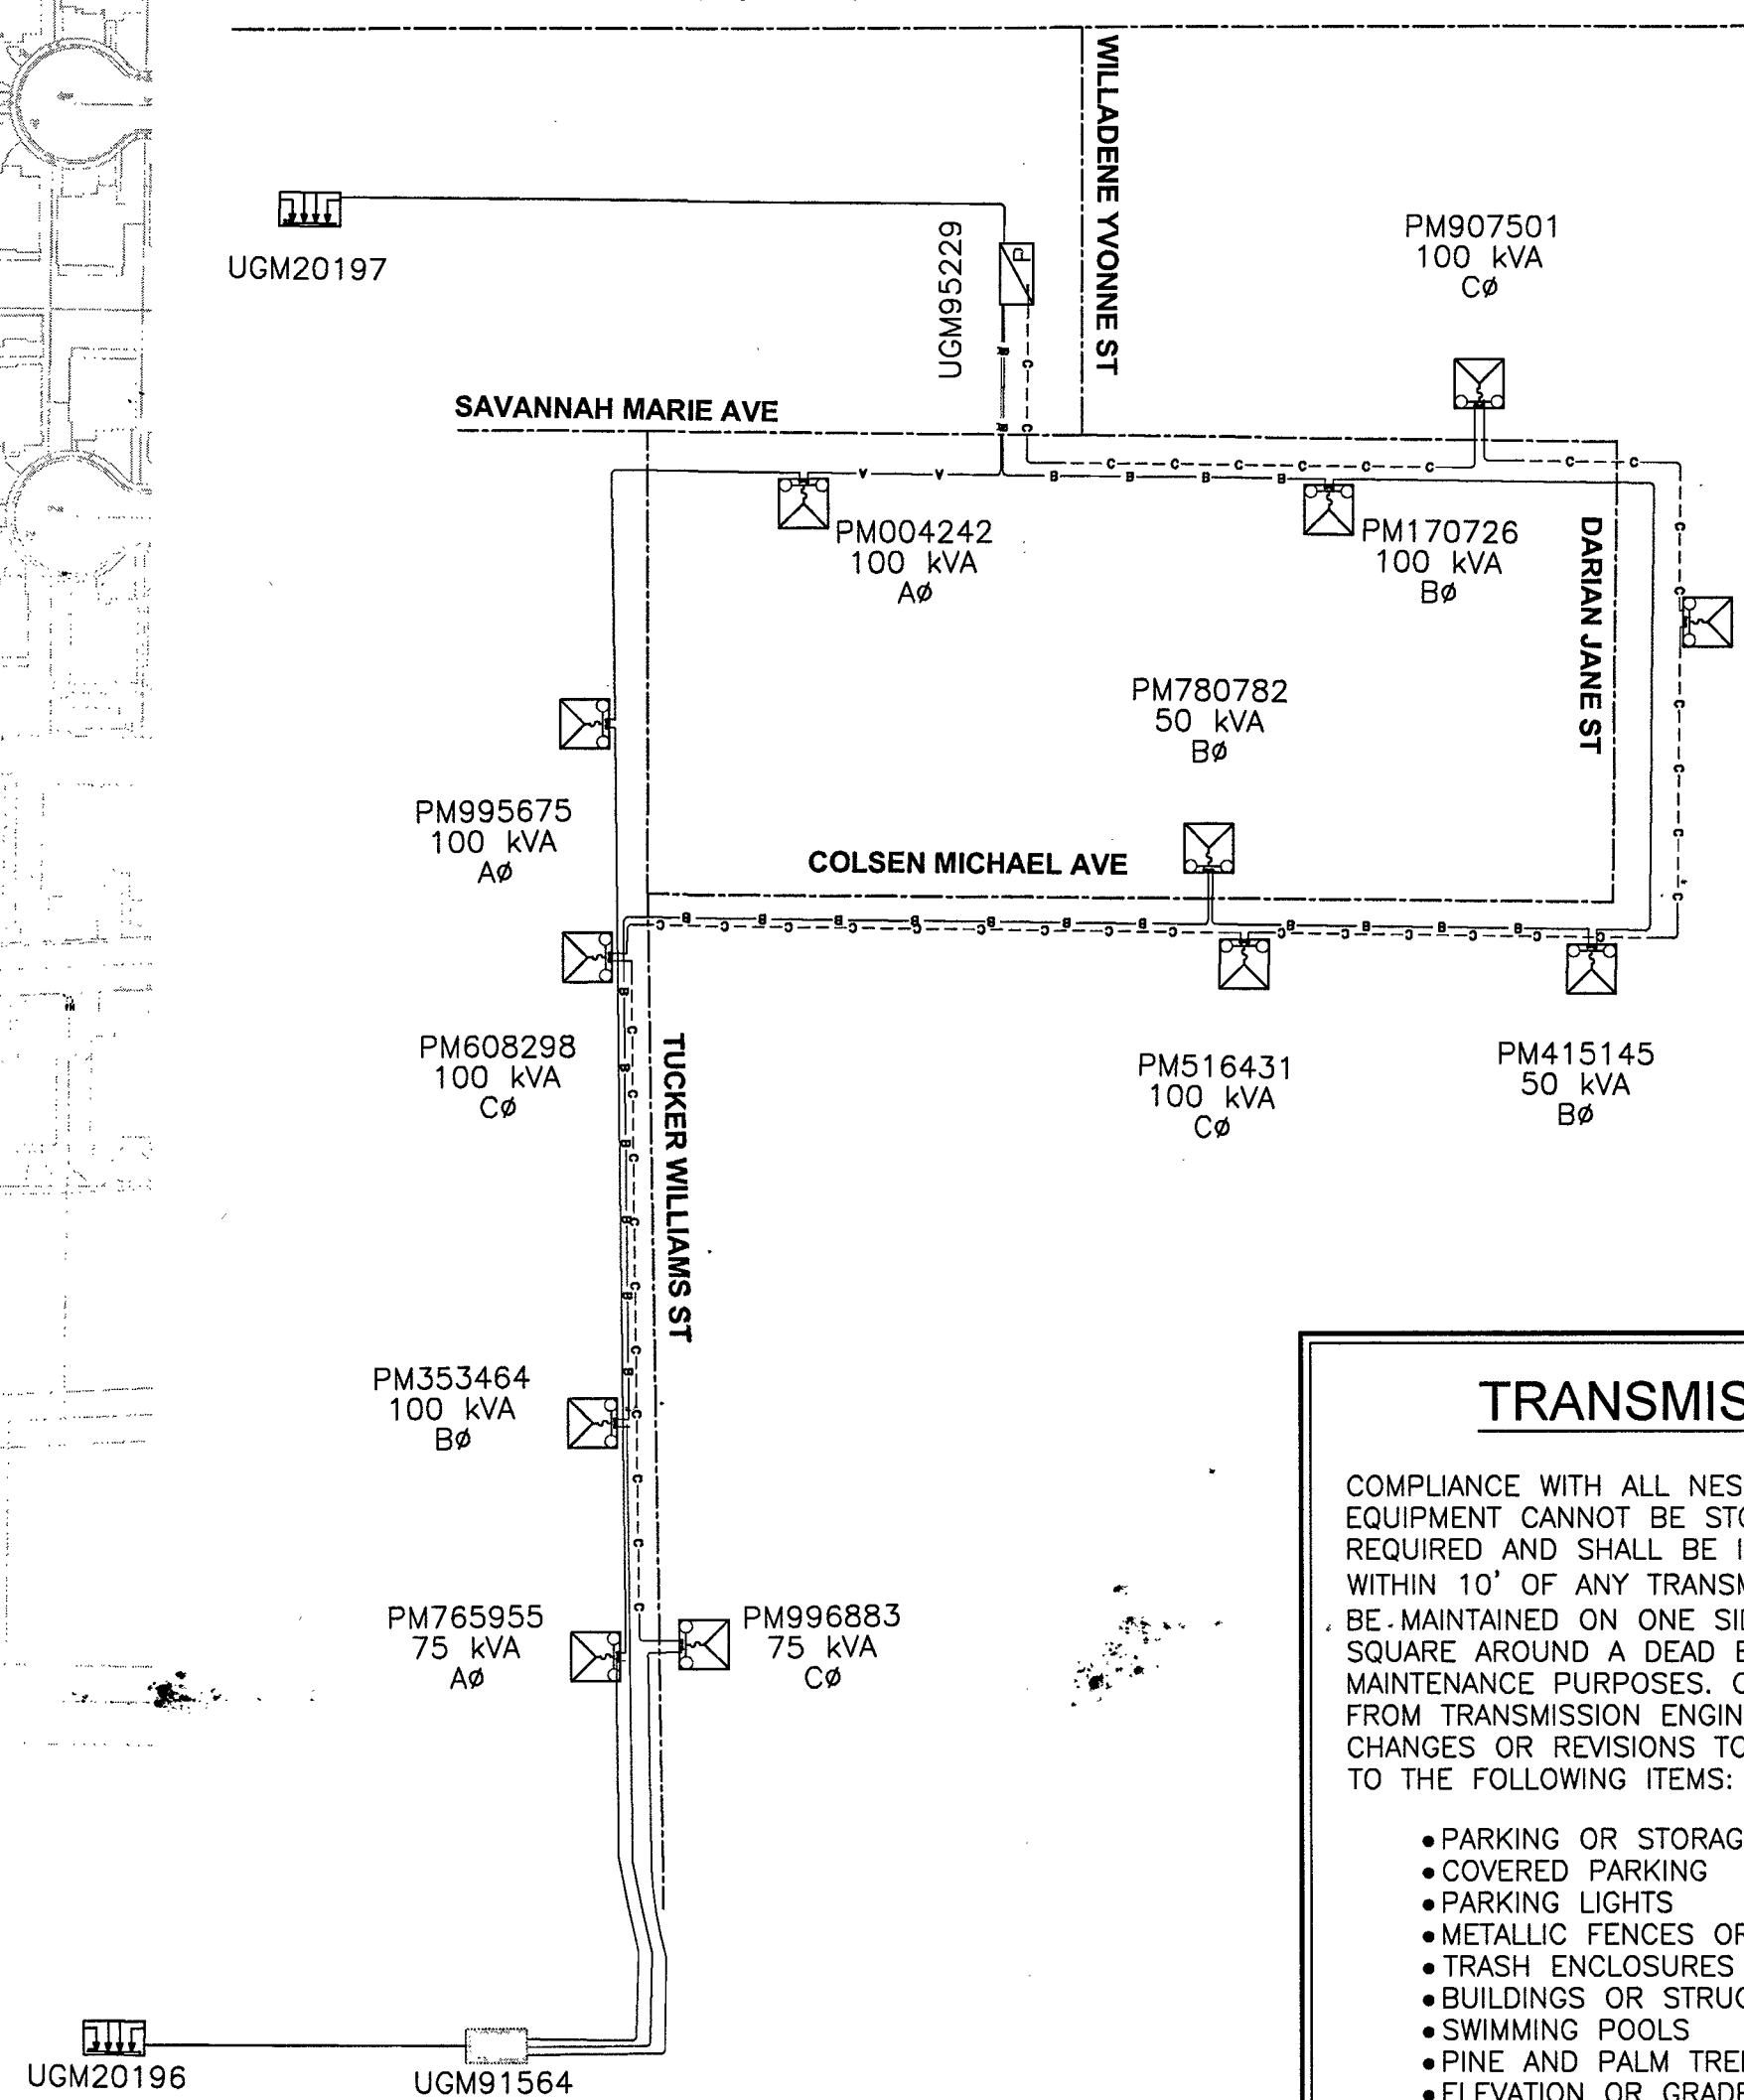

## SINGLE LINE DIAGRAM

-NVE USE ONLY-

## TRANSMISSION REQUIREMENTS

COMPLIANCE WITH ALL NESC AND OSHA REQUIREMENTS. MATERIALS AND  
EQUIPMENT CANNOT BE STOCKPILED UNDER LINES. POLE BOLLARDS ARE  
REQUIRED AND SHALL BE INSTALLED BY THE OWNER IF PARKING IS  
WITHIN 10' OF ANY TRANSMISSION STRUCTURE. A 40'X40' SQUARE MUST  
BE MAINTAINED ON ONE SIDE OF A TANGENT STRUCTURE AND A 20'X20'  
SQUARE AROUND A DEAD END STRUCTURE TO ALLOW ACCESS FOR  
MAINTENANCE PURPOSES. CUSTOMER MUST OBTAIN PRIOR APPROVAL  
FROM TRANSMISSION ENGINEERING FOR FUTURE PROJECTS AND ANY  
CHANGES OR REVISIONS TO THIS PROJECT INCLUDING BUT NOT LIMITED  
TO THE FOLLOWING ITEMS:

- PARKING OR STORAGE OF VEHICLES EXCEEDING 8' IN HEIGHT
- COVERED PARKING
- PARKING LIGHTS
- METALLIC FENCES OR BLOCK WALLS
- TRASH ENCLOSURES
- BUILDINGS OR STRUCTURES AND FREE STANDING SIGNS
- SWIMMING POOLS
- PINE AND PALM TREES
- ELEVATION OR GRADE CHANGES

CONTRACTOR SHALL MAINTAIN RADIUS OF 10' PLUS 1:1 SLOPE OF  
UNDISTURBED SOIL AROUND POLES OR CONTRACTOR WILL NEED TO  
PROVIDE FOR TRENCH SHORING AND/OR BRACING. CONTRACTOR MAY  
OBTAIN WAIVER FROM NVE CONSTRUCTION SUPERVISOR.

## CONSTRUCTION / INSPECTION REQUIREMENTS

WORK MUST CONFORM TO NVE ELECTRIC SERVICE STANDARDS, AVAILABLE AT:  
[www.nvenergy.com/business/newconstruction/newconstruction5/servicestandards.cfm](http://www.nvenergy.com/business/newconstruction/newconstruction5/servicestandards.cfm)

NVE INSPECTOR MUST BE PRESENT TO INSPECT TRENCHING (SCHEDULE AT LEAST 72  
HOURS IN ADVANCE) AT EACH OF THE FOLLOWING STAGES:

1. BOTTOM SAND AND CONDUIT INSTALLED
2. TOP SAND INSTALLED
3. BACKFILL INSTALLED

CONDUIT MUST BE MANDRILLED PRIOR TO RELEASE (COORDINATE WITH INSPECTOR).

NVE STAND BY CREW IS REQUIRED WHEN WORKING AT AN ENERGIZED VAULT OR  
TRANSFORMER. CALL STAND BY NUMBER (SEE TITLE BLOCK) TO SCHEDULE.

NVE ELECTRICAL INSTALLATION WILL NOT BE SCHEDULED UNTIL AFTER THE NVE  
INSPECTOR HAS COMPLETED THE OFFICIAL RELEASE.

METER(S) WILL NOT BE SET UNTIL ALL OF THE FOLLOWING ARE COMPLETE:

- INSTRUMENT-RATED ONLY METERING EQUIPMENT HAS BEEN SUBMITTED TO NVE  
METERING ENGINEER AND APPROVED. (submit to [southern@nvenergy.com](mailto:southern@nvenergy.com))
- APPLICATION FOR METER SET HAS BEEN SUBMITTED TO NVE'S NEW DEVELOPMENT  
CENTER. FORM AVAILABLE AT:  
[www.nvenergy.com/brochures\\_arch/new\\_construction/meter\\_set.pdf](http://www.nvenergy.com/brochures_arch/new_construction/meter_set.pdf)
- THE LOCAL BUILDING AUTHORITY HAS INSPECTED, AND APPROVED THE METERING  
EQUIPMENT.
- METERING EQUIPMENT IS ACCESSIBLE AND CLEARLY IDENTIFIED WITH PERMANENT  
MARKINGS. ADDRESSES, SUITE NUMBERS, AND STREET SIGNS ARE POSTED IN  
PERMANENT LOCATIONS (SEE RPI-G).

TRACK PROJECT STATUS ONLINE WITH NVE'S DEVELOPER DASHBOARD:  
[www.nvenergy.com/business/newconstruction/newconstruction5/developerdashboard.cfm](http://www.nvenergy.com/business/newconstruction/newconstruction5/developerdashboard.cfm)

## CUSTOMER NOTE:

UNLESS OTHERWISE NOTED, ALL CONDUIT, BENDS  
AND SUBSTRUCTURES ARE THE RESPONSIBILITY  
OF THE CUSTOMER'S CONTRACTOR OR ASSIGNED  
DCA CONTRACTOR (RESIDENTIAL ONLY)

## UNLESS OTHERWISE NOTED:

ALL SERVICE CONDUCTOR: 4/0 AL. TRI.  
ALL TRANSFORMERS: 7200V-120/240V-16 PM  
LARGEST A/C UNIT SIZE: 5 TONS  
NUMBER OF UNITS: 59  
MAIN SIZE: 320 AMPS  
ESTIMATED KVA PER UNIT: 15.7 KVA  
SQ. FT. OF LARGEST UNIT: 3410 SQ. FT.

## DEVELOPER'S OFFSITE ENCROACHMENT PERMIT TO BE UTILIZED FOR THE INSTALLATION OF NVEnergy FACILITIES

NOTE: ALL THE ABOVE GROUND UTILITY APPURTENANCES  
SHALL CONFORM TO THE REQUIREMENTS OF CLV UNIFIED  
DEVELOPMENT CODE TITLE 19.06 AND 19.08


## APPROVED FOR CONSTRUCTION

THIS APPROVAL IS FOR WORK IN CLV R/W & EASEMENT  
ONLY. OBTAINING PERMISSIONS OR EASEMENTS FOR WORK  
SHOWN ON PRIVATE PROPERTY IS THE RESPONSIBILITY  
OF THE UTILITY.

APPROVAL BY: [Signature] DATE: 6/27/19



NVE STANDARDS

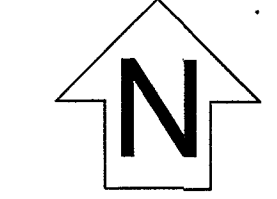

T,R,S: 19-60-18

APN: 12518301002  
12518301003  
12518301004  
12518301014

## GENERAL NOTES:

ANY NOTES LOCATED IN DRAWING AREA TAKE  
PRECEDENCE OVER STANDARD NOTES.

REFER TO A CURRENT NVEnergy ELECTRIC SERVICE REQUIREMENTS  
HANDBOOK FOR FURTHER CLARIFICATION OF NVEnergy STANDARDS.

THE APPLICANT SHALL INFORM THE INSPECTOR AT LEAST 48  
HOURS BEFORE COMMENCING ANY ITEM OF CONSTRUCTION OR  
INSTALLATION OF MATERIAL TO ENABLE PROPER INSPECTION OF  
MATERIALS AND WORKMANSHIP. MAIN TRENCH WIRE PULLS TO BE  
SCHEDULED 72 HOURS IN ADVANCE OF INSTALLATION. APPLICANT'S  
PROJECT WILL NOT BE SCHEDULED UNTIL FINAL APPROVAL FROM  
NVEnergy UNDERGROUND & ELECTRICAL INSPECTORS.

ALL WORK SHALL BE ACCOMPLISHED IN STRICT ACCORDANCE WITH  
THE SPECIFICATIONS SET FORTH IN THE ELECTRIC SERVICE  
REQUIREMENTS HANDBOOK, AS CURRENTLY ADOPTED BY NVEnergy.  
THE CONTRACTOR SHALL SECURE COPIES OF THE AFOREMENTIONED  
CONSTRUCTION SPECIFICATIONS ON HIS OR HER OWN BEHALF.

SYMBOLS ARE NOT TO SCALE AND DO NOT NECESSARILY  
REPRESENT ACTUAL LOCATIONS OF FACILITIES.

THIS DRAWING ILLUSTRATES DATA COLLECTED FROM VARIOUS  
SOURCES AND MAY NOT REPRESENT A SURVEY OF THE PREMISES.

APPLICANT SHALL FIELD DETERMINE POSITION AND DEPTH OF  
EXISTING UTILITY EQUIPMENT PRIOR TO COMMENCING  
CONSTRUCTION.

USE CAUTION PRIOR TO EXCAVATION. CHECK TO ENSURE  
ADDITIONAL DEPTH IS NOT REQUIRED TO ACCOMMODATE GAS  
AND/OR WATER FACILITIES AND DRAINAGE CHANNELS.

CALL NVEnergy UNDERGROUND INSPECTORS 48 HOURS PRIOR TO  
START OF CONSTRUCTION FOR TRENCH INSPECTION BEFORE  
COVERING TRENCH.

ALL NVEnergy CABLE TO BE INSTALLED BEHIND CURB, UNLESS  
OTHERWISE STATED.

APPLICANT IS RESPONSIBLE FOR STAKING OF PROPERTY CORNERS  
& ELEVATIONS.

ALL HANDHOLES AND PULLBOXES SHALL BE INSTALLED TO  
FINISHED GRADE OR 6" ABOVE IF GRADE IS NOT ESTABLISHED.

ANY SUBSTRUCTURE VAULT INSTALLED IN GRAVEL, GRASS, OR BARE  
GROUND WILL REQUIRE A CONCRETED 8" WIDE AND 6" DEEP  
COLLAR AROUND BOX IN ACCORDANCE TO RS-G6.

2" PLASTIC CONDUIT BENDS (90°, 45°) WITH 36" MIN. RADIUS.  
(USE FIBERGLASS IF CONDUIT LENGTH IS OVER 500')

3" & 4" PLASTIC CONDUIT BENDS (90°, 45°) WITH 36" MIN.  
RADIUS.  
(USE RGS IF CONDUIT LENGTH IS OVER 100')

6" PLASTIC CONDUIT BENDS (90°, 45°) WITH 48" MIN. RADIUS.  
(USE RGS IF CONDUIT LENGTH IS OVER 100')

WHEN INSTALLING CONDUIT IN FIELD, USE APPROPRIATE BENDS TO  
COMPLETE THE INSTALLATION.

DEFLECTION OF CONDUIT BENDS AND CONDUIT NOT TO EXCEED  
NVEnergy STANDARDS.

EXISTING STUB-OUT/CONDUIT INSTALLED BY PREVIOUS CONTRACTOR  
/ DEVELOPER. NVEnergy DOES NOT GUARANTEE LOCATION, LENGTH,  
OR ACCESSIBILITY OF EXISTING STUB-OUT/CONDUIT. IF UTILIZING  
ANY PORTION OF EXISTING CONDUIT, IT MUST BE MANDRELED  
PRIOR TO FINAL RELEASE.

PREVIOUSLY MANDRELED CONDUIT WHICH HAS BEEN IN THE  
GROUND FOR OVER 6 MONTHS MUST BE RE-MANDRILLED PRIOR  
TO FINAL RELEASE.

WHEN NVEnergy FACILITIES ARE TO BE REMOVED, NVEnergy WILL  
REMOVE ALL WIRES AND EQUIPMENT. NVEnergy IS NOT  
RESPONSIBLE FOR THE REMOVAL OF CONDUIT RUNS OR  
SUBSTRUCTURES FROM THE PROPERTY.

NO COVERED PARKING IN FRONT OF EQUIPMENT.

ALL CONSTRUCTION AND MATERIALS SHALL BE IN ACCORDANCE  
WITH THE "UNIFORM STANDARD SPECIFICATIONS FOR PUBLIC WORKS  
CONSTRUCTION OFF-SITE IMPROVEMENTS, CLARK COUNTY AREA  
NEVADA", LATEST ISSUE; THE "UNIFORM STANDARD DRAWINGS FOR  
PUBLIC WORKS CONSTRUCTION, CLARK COUNTY AREA NEVADA",  
LATEST ISSUE; AND OTHER APPLICABLE APPROVED STANDARDS  
ISSUED BY THE CONTROLLING AGENCY; ALL LOCAL CITY CODES  
AND ORDINANCES APPLICABLE.

## CIVIL LINETYPE LEGEND


|                   |     |
|-------------------|-----|
| CENTERLINE        | --- |
| PROPERTY LINE/R/W | --- |
| CURB              | --- |
| EDGE OF PAVEMENT  | --- |
| EDGE OF SIDEWALK  | --- |
| SEWER LINE        | --- |
| WATER LINE        | --- |
| COHW WATER LINE   | --- |
| LWWD WATER LINE   | --- |
| SNWA WATER LINE   | --- |
| SNWA GAS LINE     | --- |
| TEL               | --- |
| CATV              | --- |
| FIBER             | --- |
| SD                | --- |
| FIRE HYDRANT      | --- |
| SIGNAL LIGHT      | --- |
| SERVICE INDICATOR | --- |
| STREET LIGHT      | --- |

## CITY OF LAS VEGAS PERMIT REQUIRED\*

CONTACT CLV LAND DEVELOPMENT (229-6371)  
CLV CONSTRUCTION SERVICES MUST BE NOTIFIED  
24 HOURS PRIOR TO COMMENCING CONSTRUCTION  
(229-6337)  
1073704-UTL  
HANSEN 48-0239-001

DATE: 6/27/19

\*NVE INSPECTOR MUST BE NOTIFIED BY FAX 48  
HOURS PRIOR TO COMMENCING CONSTRUCTION &  
WILL PERMIT CITY PERMIT FOR WORK DONE IN  
STREETS OR SIDEWALK.  
FAX PERMIT TO:  
LAS VEGAS NORTH (RYAN CENTER): 402-4354  
LAS VEGAS SOUTH (BELTWAY CENTER): 402-6864

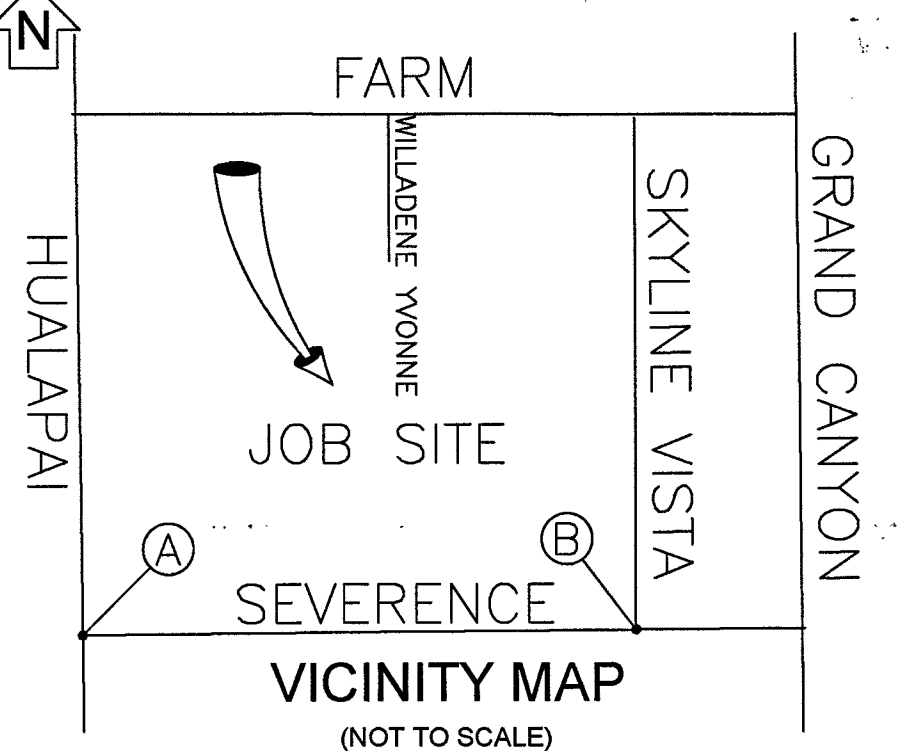

## VICINITY MAP (NOT TO SCALE)

EVERY EFFORT HAS BEEN MADE TO IDENTIFY ALL NVE  
FACILITIES. THE CUSTOMER SHALL CONFIRM THE EXISTENCE  
AND LOCATION OF THESE FACILITIES.

AVOID HITTING OVERHEAD  
POWER LINES. IT'S COSTLY.

CALL BEFORE  
YOU DO  
OVERHEAD

CALL 1-702-402-2929

Call before you Dig  
Avoid cutting underground  
utility lines. It's costly.

**CALL**  
**811**

OR  
1-800-227-2600  
AND CLARK COUNTY TRAFFIC OPERATIONS  
1-702-455-6000

## REVISIONS

| NO. | DESCRIPTION | DATE | REV BY |
|-----|-------------|------|--------|
| 1   |             |      |        |
| 2   |             |      |        |
| 3   |             |      |        |
| 4   |             |      |        |
| 5   |             |      |        |
| 6   |             |      |        |
| 7   |             |      |        |
| 8   |             |      |        |
| 9   |             |      |        |
| 10  |             |      |        |
| 11  |             |      |        |
| 12  |             |      |        |
| 99  |             |      |        |
| 100 |             |      |        |

## STANDARD DCA

## PROJECT PURPOSE:

PROVIDE 1PH SVC TO A SINGLE-FAMILY DETACHED  
RESIDENTIAL SUBDIVISION 59 HOMES, 320A 120/240V  
PANELS, 1 GATE SVC 200A PEDESTAL

PROVIDE 1PH SVC TO A SINGLE-FAMILY DETACHED  
RESIDENTIAL SUBDIVISION 59 HOMES, 320A 120/240V  
PANELS, 1 GATE SVC 200A PEDESTAL

PROVIDE 1PH SVC TO A SINGLE-FAMILY DETACHED  
RESIDENTIAL SUBDIVISION 59 HOMES, 320A 120/240V  
PANELS, 1 GATE SVC 200A PEDESTAL

PROVIDE 1PH SVC TO A SINGLE-FAMILY DETACHED  
RESIDENTIAL SUBDIVISION 59 HOMES, 320A 120/240V  
PANELS, 1 GATE SVC 200A PEDESTAL

## EXHIBIT 'A'

## NVEnergy INFORMATION:

COORDINATOR: SANTIAGO, CHERI

PHONE: (702)622-4365 D.F. LOWELL, KEN

DESIGNER: BENNETT-ORILLO, CINDY

DCA: 285-8182, 219-5761

INSPECTOR: 702-402-3008 OR UG@NVEENERGY.COM

STAND BY: (702) 402-4450, 4150, 4114, 4117, 4118

DISTRICT: LAS VEGAS NORTH DISTRICT

## JPA INFORMATION:

JPA ADMIN PHONE: N/A JPA#: N/A

## CUSTOMER INFORMATION:

APPLICANT: RICHMOND AMERICAN HOMES OF NEVADA, INC.

ENGINEER: SLATER HANIFAN GROUP

CONTACT: RICHARDSON VON-OT, DAVE \*\* 702-379-7577

APPROVAL DATE: 02/19/2019

## GOVERNMENT INFORMATION:

AGENCY: CLV

APPROVAL DATE: ----

FOR EACH SERVICE POINT (POINT OF DELIVERY), ENERGY FOR  
EACH TENANT SPACE WILL BE MEASURED THROUGH ONE  
WATTHOUR METER. ENERGY FOR ALL, NON-TENANT SPACE WILL  
BE MEASURED THROUGH ONE WATTHOUR METER. CONTACT NVE  
METER OPERATIONS FOR MULTIPLE RATE CLASS INSTALLATIONS.

## NVEnergy.



## FARM HUALAPAI - SUBDIVISION

## GRAND TETON / HUALAPAI


PROJ #3003264462 SCALE: 1"=30'

SHEET # 1 OF 5 DATE: 1/10/2019



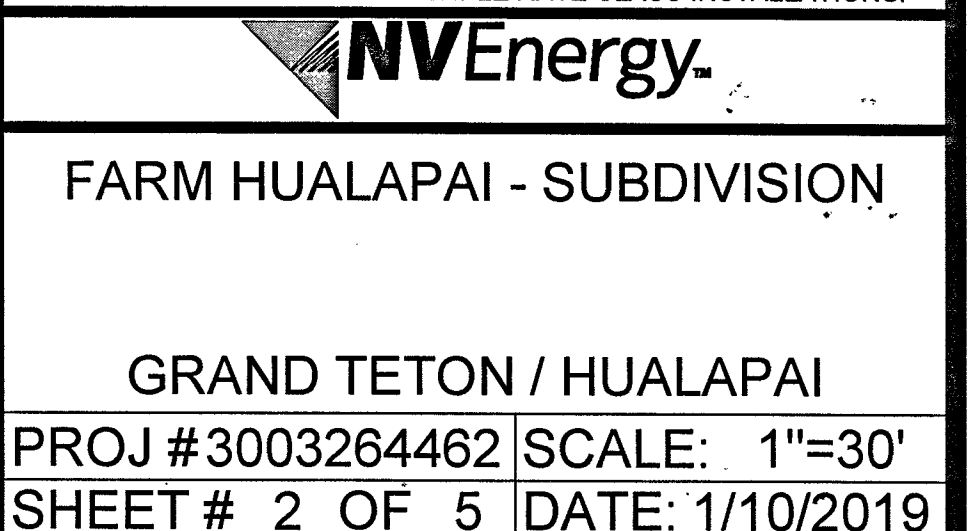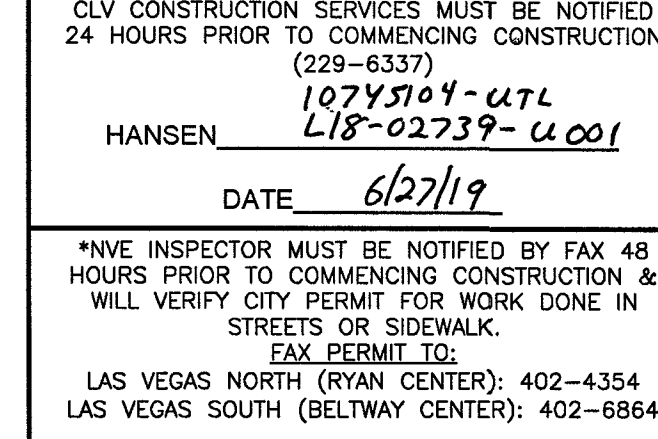



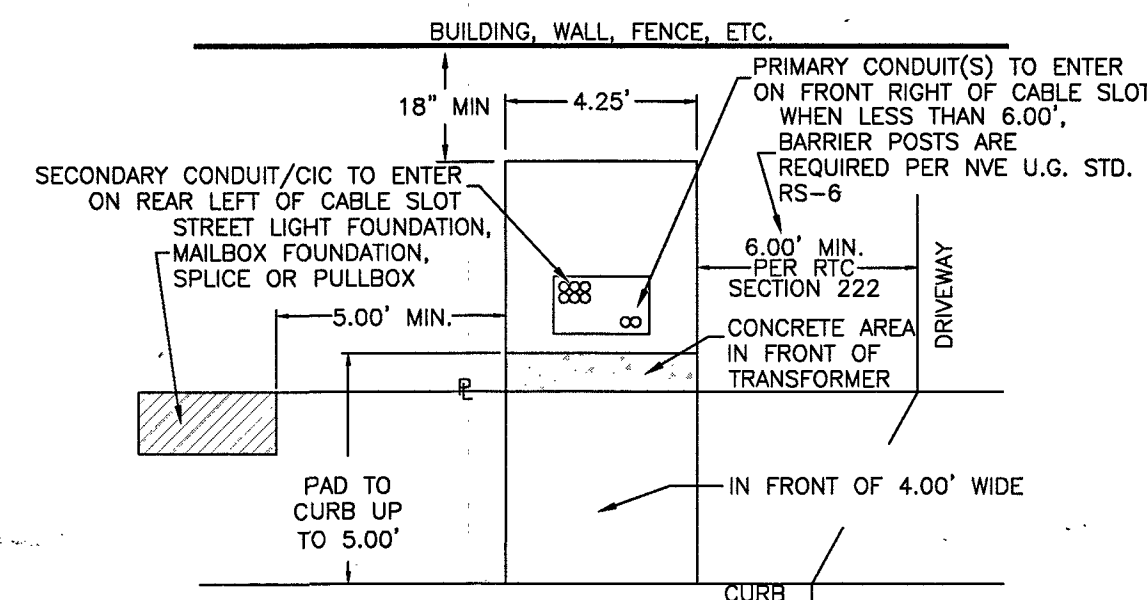

UNLESS OTHERWISE NOTED:

ALL SERVICE CONDUCTOR: 4/0 AL TRI.

ALL TRANSFORMERS: 7200V-120/240V-1Ø PM

LARGEST A/C UNIT SIZE: 5 TONS

NUMBER OF UNITS: 59

MAIN SIZE: 320 AMPS

ESTIMATED KVA PER UNIT: 15.7 KVA

SQ. FT. OF LARGEST UNIT: 3410 FT<sup>2</sup>


NOTE: ALL THE ABOVE GROUND UTILITY APPURTENANCES SHALL CONFORM TO THE REQUIREMENTS OF CLV UNIFIED DEVELOPMENT CODE TITLE 19.06 AND 19.08

**APPROVED FOR CONSTRUCTION**

THIS APPROVAL IS FOR WORK IN CLV R/W & EASEMENT ONLY. OBTAINING PERMISSIONS OR EASEMENTS FOR WORK SHOWN ON PRIVATE PROPERTY IS THE RESPONSIBILITY OF THE UTILITY.

*Li* 6/27/19

APPROVAL BY: DATE

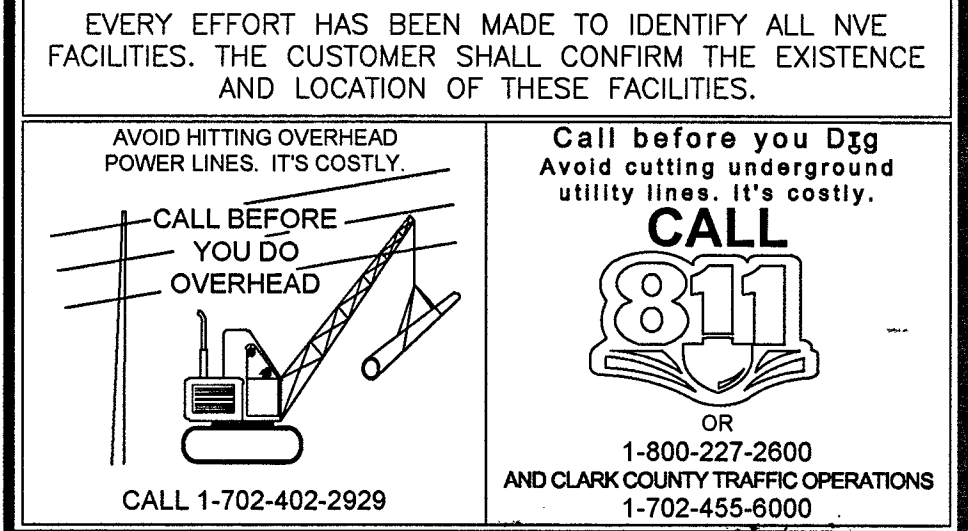[illegible]

**PROJECT PURPOSE:**  
 PROVIDE 1PH SVC TO A SINGLE-FAMILY DETACHED  
 RESIDENTIAL SUBDIVISION 59 HOMES, 320A 120/240V  
 PANELS, 1 GATE SVC 200A PEDESTAL

**NVEnergy INFORMATION:**

COORDINATOR: SANTIAGO, CHERI

PHONE: (702)822-4365 D.F. LOWELL, KEN

DESIGNER: BENNETT-ORILLO, CINDY

OCA: 285-8182, 219-5761

INSPECTOR: 702-402-3008 OR UGI@NVENERGY.COM

STAND BY: (702) 402-4450, 4150, 4114, 4117, 4118

DISTRICT: LAS VEGAS NORTH DISTRICT

**JPA INFORMATION:**

JPA ADMIN PHONE: N/A JPA#: N/A

**CUSTOMER INFORMATION:**

APPLICANT: RICHMOND AMERICAN HOMES OF NEVADA, INC.

ENGINEER: SLATER HANIFAN GROUP

CONTACT: RICHARDSON VON-OY, DAVE \*\* 702-379-7577

APPROVAL DATE: 02/19/2019

**GOVERNMENT INFORMATION:**

AGENCY: CLV

APPROVAL DATE: ----

FOR EACH SERVICE POINT (POINT OF DELIVERY), ENERGY FOR EACH TENANT SPACE WILL BE MEASURED THROUGH ONE WATTHOUR METER. ENERGY FOR ALL NON-TENANT SPACE WILL BE MEASURED THROUGH ONE WATTHOUR METER. CONTACT NVE METER OPERATIONS FOR MULTIPLE RATE CLASS INSTALLATIONS.



# NV Energy

## FARM HUALAPAI - SUBDIVISION

### GRAND TETON / HUALAPAI

|                  |                 |
|------------------|-----------------|
| PROJ #3003264462 | SCALE: 1"=30'   |
| SHEET # 3 OF 5   | DATE: 1/10/2019 |

0 REVISION(S)












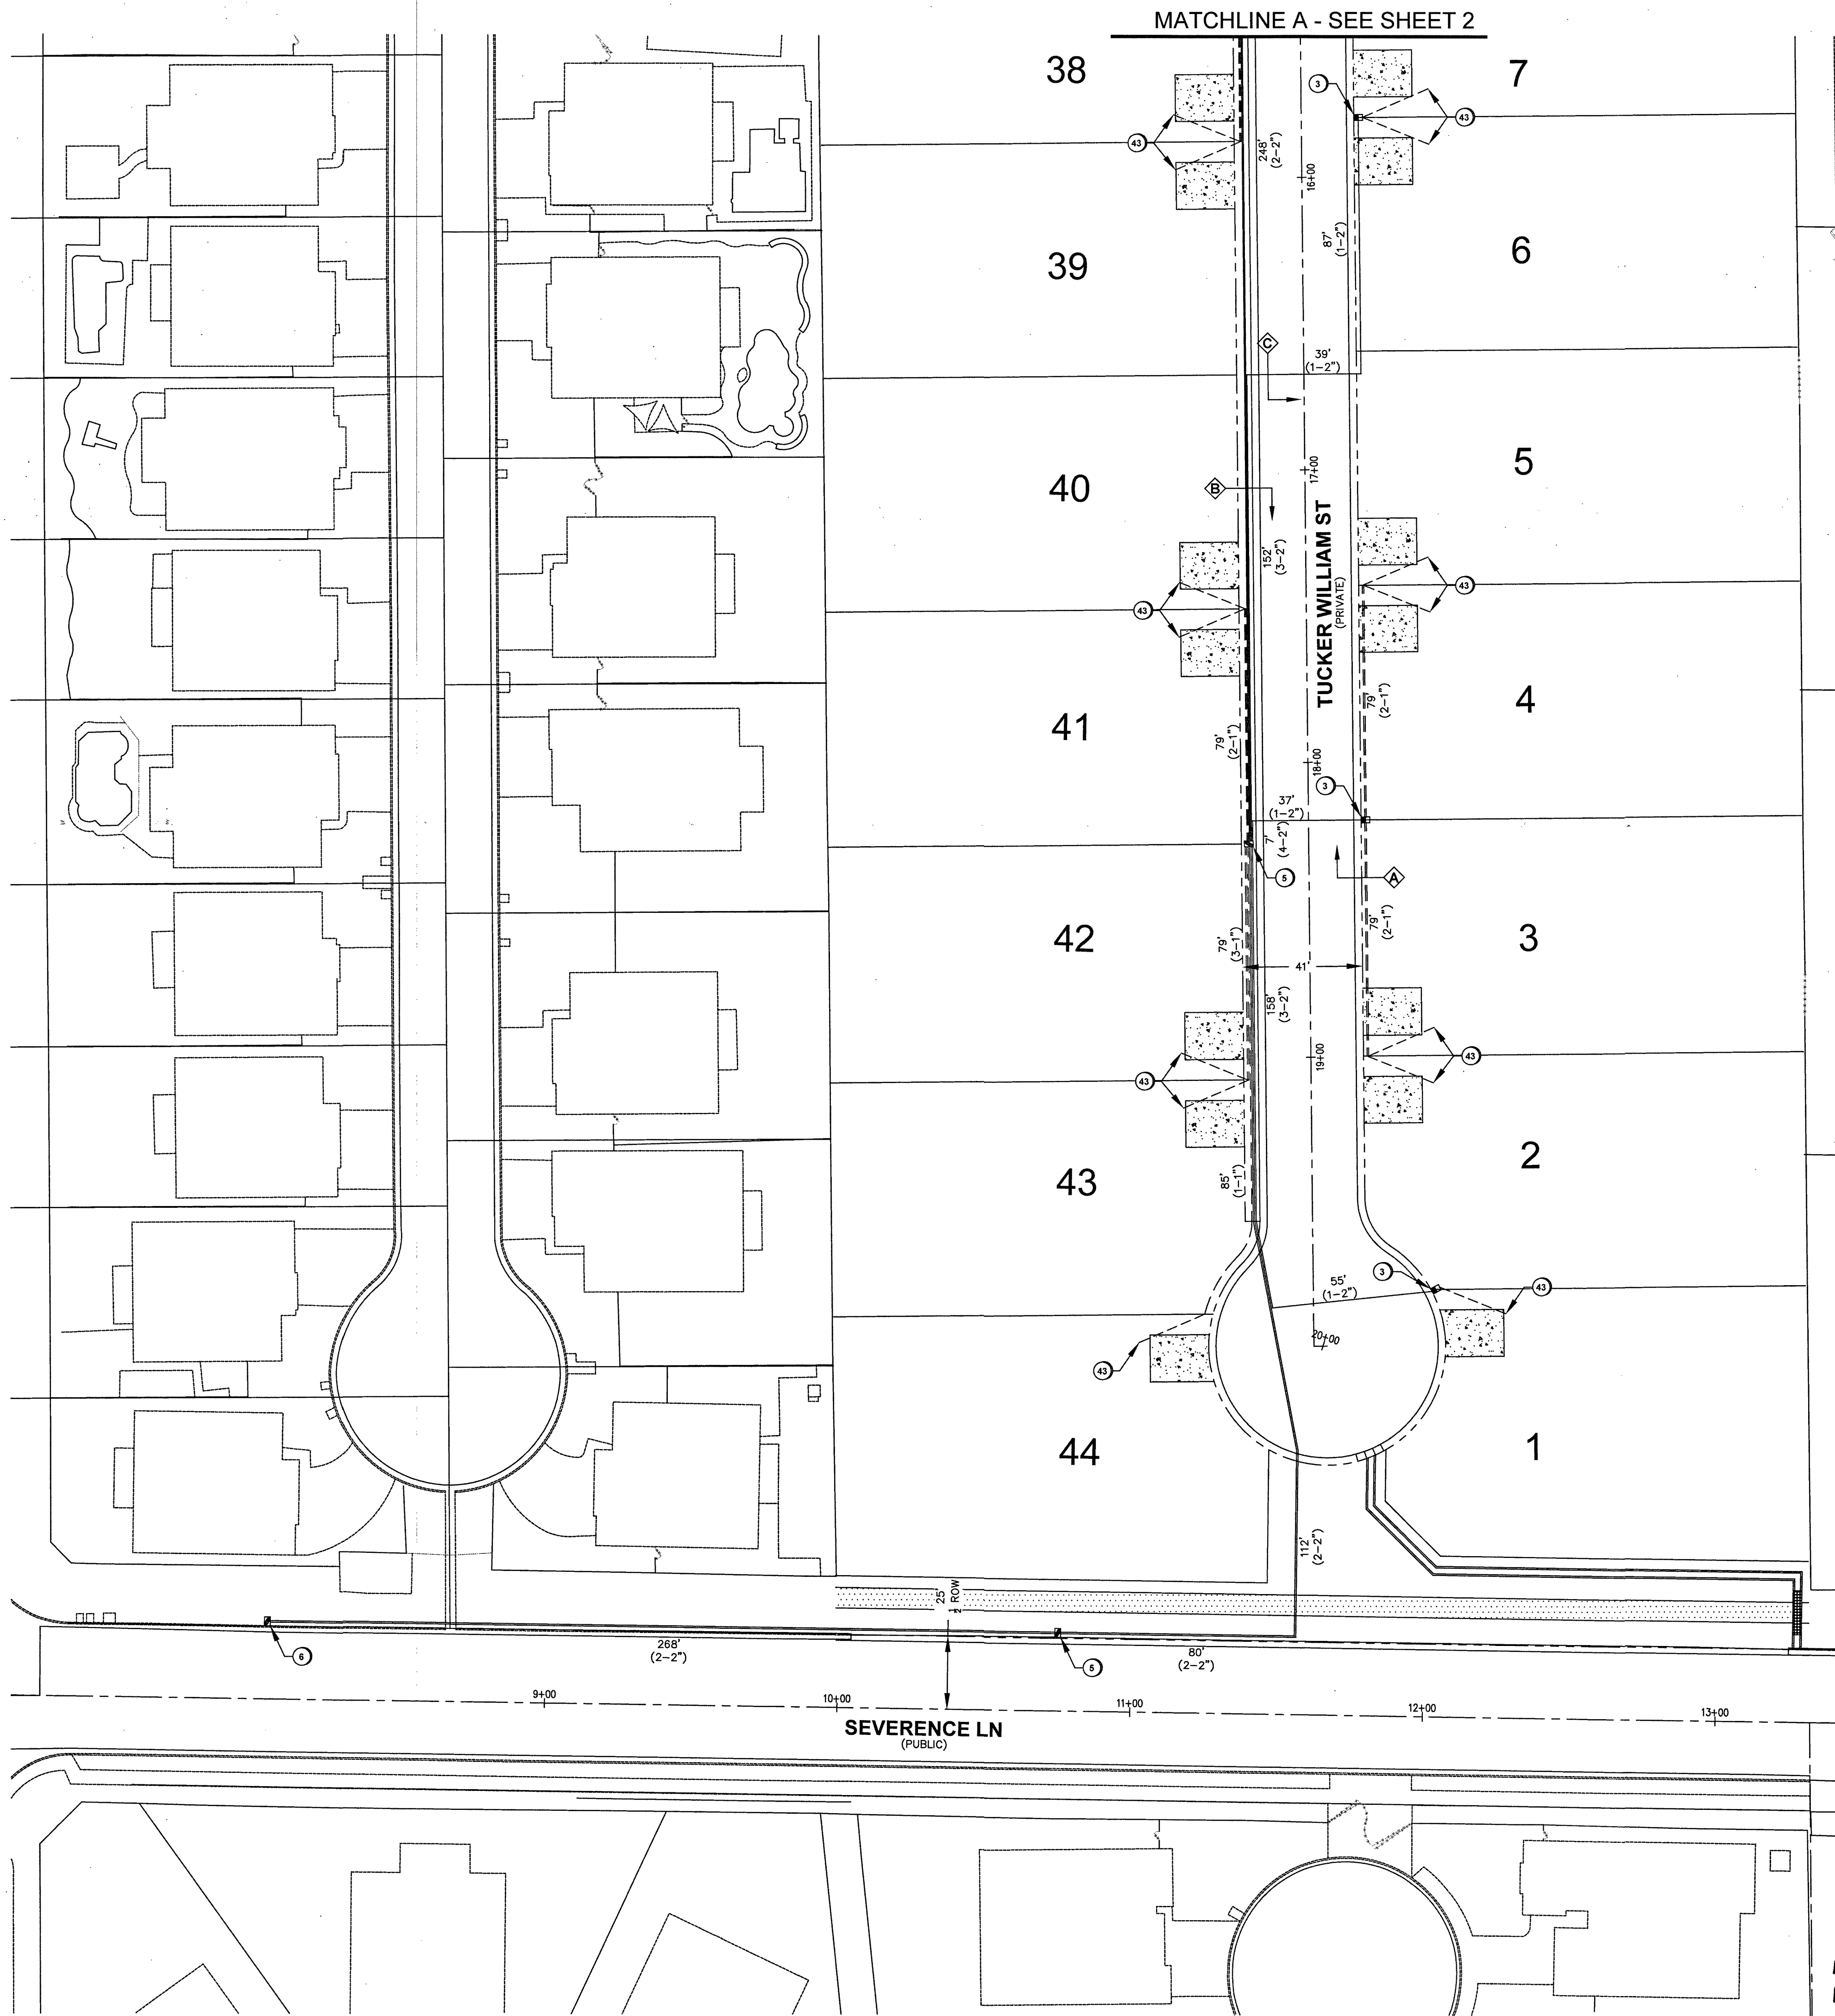

| LEGEND |                                                       |
|--------|-------------------------------------------------------|
| 1      | INSTALL B-36 PULL BOX (24"x36"x24")                   |
| 2      | EXISTING B-36 PULL BOX (24"x36"x24")                  |
| 3      | INSTALL B-50 PULL BOX (13"x24"x24")                   |
| 4      | EXISTING B-50 PULL BOX (13"x24"x24")                  |
| 5      | INSTALL B-100 PULL BOX (24"x36"x24")                  |
| 6      | EXISTING B-100 PULL BOX (24"x36"x24")                 |
| 7      | INSTALL T-200 CATV VAULT (30"x48"x36")                |
| 8      | EXISTING T-200 CATV VAULT (30"x48"x36")               |
| 9      | INSTALL T-400 CATV VAULT (36"x60"x36")                |
| 10     | EXISTING T-400 CATV VAULT (36"x60"x36")               |
| 11     | INSTALL T-600 CATV VAULT (48"x72"x36")                |
| 12     | EXISTING T-600 CATV VAULT (48"x72"x36")               |
| 13     | INSTALL NEW CATV PEDESTAL/CABINET                     |
| 14     | EXISTING NEW CATV PEDESTAL/CABINET                    |
| 15     | R&R S/W SLAB(S)                                       |
| 16     | POTHOLE                                               |
| 17     | SIDEWALK/DIRT TRENCH INSTALL WITH FIBER/COAX PULL     |
| 18     | ASPHALT MITIGATION/STREET TRENCH WITH FIBER/COAX PULL |
| 19     | PROPOSED BORE WITH FIBER/COAX PULL                    |
| 20     | EXISTING CATV CONDUIT(S)                              |
| 21     | PROPOSED OVERHEAD FIBER OPTIC CABLE OR COAX INSTALL   |
| 22     | EXISTING OVERHEAD FIBER OPTIC CABLE OR COAX           |
| 23     | U.G. FIBER/COAX PULL THROUGH EXISTING CONDUIT         |
| 24     | RIGHT OF WAY LINE                                     |
| 25     | LOT/PROPERTY LINE                                     |
| 26     | EDGE OF PAVEMENT/SIDEWALK/CONCRETE                    |
| 27     | P EXISTING NVE PULL BOX                               |
| 28     | T EXISTING TELCO PULL BOX                             |
| 29     | TM EXISTING TELCO MANHOLE                             |
| 30     | T EXISTING TELCO POLE                                 |
| 31     | NVE EXISTING NVE POLE                                 |
| 32     | NVE EXISTING NVE TRANSMISSION POLE                    |
| 33     | EXISTING JOINT POLE                                   |
| 34     | EXISTING JOINT POLE WITH TRANSFORMER                  |
| 35     | POLE ANCHOR                                           |
| 36     | EXISTING NVE TRANSFORMER TRANSFORMER PAD              |
| 37     | TS SNWA TEST STATION                                  |
| 38     | COX POWER SUPPLY (49"x24"x52")                        |
| 39     | RC INSTALL RHINO CABINET                              |
| 40     | RISER POLE/QUADRANT DETAIL RISER OWNERSHIP NOTED      |
| 41     | RAILROAD                                              |
| 42     | EXISTING MANHOLE (SS),(SD)...ECT                      |
| 43     | 1in CONDUIT LATERAL                                   |
| 44     | STORMWATER ASSETS                                     |
| 45     |                                                       |

**DISCLAIMER NOTE**

UTILITY LOCATIONS SHOWN HEREON ARE APPROXIMATE ONLY. IT SHALL BE THE CONTRACTOR'S RESPONSIBILITY TO DETERMINE THE EXACT HORIZONTAL AND VERTICAL LOCATION OF ALL EXISTING UNDERGROUND AND OVERHEAD UTILITIES PRIOR TO COMMENCING CONSTRUCTION. NO REPRESENTATION IS MADE THAT ALL EXISTING UTILITIES ARE SHOWN HEREON. THE ENGINEER ASSUMES NO RESPONSIBILITY FOR UTILITIES NOT SHOWN OR UTILITIES NOT SHOWN IN THEIR PROPER LOCATIONS.

**CALL BEFORE YOU DIG**  
OR 1-800-227-2600  
UNDERGROUND SERVICE (USA)

**CALL BEFORE YOU OVERHEAD**  
1-702-227-2629  
NEVADA POWER ENVIRONMENT AND SAFETY SERVICE DEPARTMENT

**AVOID CUTTING UNDERGROUND UTILITY LINES. IT'S COSTLY.**

**AVOID OVERHEAD POWER LINE CONTACT**

**CALL BEFORE YOU OVERHEAD**

**AVOID HITTING UNDERGROUND UTILITY LINES. IT'S COSTLY.**

**CALL BEFORE YOU OVERHEAD**

**CLARK COUNTY TRAFFIC OPERATIONS AND 1-702-455-7511 LAS VEGAS AREA COMPUTERIZED SYSTEM**

|                      |    |
|----------------------|----|
| TOTAL BORE           | 0' |
| TOTAL DIRT TRENCH    | 0' |
| TOTAL ASPHALT TRENCH | 0' |
| TOTAL TRENCH         | 0' |
| TOTAL S/W PANELS     | 0  |
| TOTAL LINEAR FOOTAGE | 0' |

**T19S R60E SEC18**

VICINITY MAP

**REVISIONS**

| REV | DESCRIPTION | DATE | BY |
|-----|-------------|------|----|
| 0   |             |      |    |

**API/ROVED FOR CONSTRUCTION**

THIS APPROVAL IS FOR WORK IN CLV R/W OR CLV EASEMENT ONLY. OBTAINING PERMISSION OR EASEMENT FOR WORK SHOWN IN PRIVATE PROPERTY IS THE RESPONSIBILITY OF THE UTILITY.

*Signature* 6/27/19  
DATE

PERMIT # RB-2223  
DRAWN BY: WTB  
DATE: 4/12/2019  
SCALE: 1:30  
NODE: RB-2223  
PROJECT # 40505190000RB22230  
TECH # 702-333-8728  
APPROVED BY: MICHAEL HERVIS

**COX**  
1700 VEGAS DRIVE  
LAS VEGAS, NEVADA 89106  
PHONE: (702) 545-1606  
FAX: (702) 545-2606

**CITY OF LAS VEGAS**  
333 N. KANACHU DRIVE  
LAS VEGAS, NEVADA 89106  
(702) 229-6885

**FARM HUALAPAI SUBDIVISION**

**DBA: COX COMMUNICATIONS**

**SHEET NO: 1**

Sheet 1 of 3

L18-02739-0001  
107Y5104-UTL



MATCHLINE C - SEE SHEET 3



MATCHLINE A - SEE SHEET 1

118-02739-0001  
107Y5104-UTL

**LEGEND**

- 1. INSTALL B-36 PULL BOX (24"x36"x24")
- 2. EXISTING B-36 PULL BOX (24"x36"x24")
- 3. INSTALL B-50 PULL BOX (13"x24"x24")
- 4. EXISTING B-50 PULL BOX (13"x24"x24")
- 5. INSTALL B-100 PULL BOX (24"x36"x24")
- 6. EXISTING B-100 PULL BOX (24"x36"x24")
- 7. INSTALL T-200 CATV VAULT (30"x48"x36")
- 8. EXISTING T-200 CATV VAULT (30"x48"x36")
- 9. INSTALL T-400 CATV VAULT (36"x60"x36")
- 10. EXISTING T-400 CATV VAULT (36"x60"x36")
- 11. INSTALL T-600 CATV VAULT (48"x72"x36")
- 12. EXISTING T-600 CATV VAULT (48"x72"x36")
- 13. INSTALL NEW CATV PEDESTAL/CABINET
- 14. EXISTING NEW CATV PEDESTAL/CABINET
- 15. R&R S/W SLAB(S)
- 16. POTHOLE
- 17. SIDEWALK/DIRT TRENCH INSTALL WITH FIBER/COAX PULL
- 18. ASPHALT MITIGATION/STREET TRENCH WITH FIBER/COAX PULL
- 19. PROPOSED BORE WITH FIBER/COAX PULL
- 20. EXISTING CATV CONDUIT(S)
- 21. PROPOSED OVERHEAD FIBER OPTIC CABLE OR COAX INSTALL
- 22. EXISTING OVERHEAD FIBER OPTIC CABLE OR COAX
- 23. U.G. FIBER/COAX PULL THROUGH EXISTING CONDUIT
- 24. RIGHT OF WAY LINE
- 25. LOT/PROPERTY LINE
- 26. EDGE OF PAVEMENT/SIDEWALK/CONCRETE
- 27. EXISTING NVE PULL BOX
- 28. EXISTING TELCO PULL BOX
- 29. EXISTING TELCO MANHOLE
- 30. EXISTING TELCO POLE
- 31. EXISTING NVE POLE
- 32. EXISTING NVE TRANSMISSION POLE
- 33. EXISTING JOINT POLE
- 34. EXISTING JOINT POLE WITH TRANSFORMER
- 35. POLE ANCHOR
- 36. EXISTING NVE TRANSFORMER TRANSFORMER PAD
- 37. SNWA TEST STATION
- 38. COX POWER SUPPLY (49"x24"x52")
- 39. INSTALL RHINO CABINET
- 40. RISER POLE/QUADRANT DETAIL RISER OWNERSHIP NOTED
- 41. RAILROAD
- 42. EXISTING MANHOLE (SS),(SD)...ECT
- 43. 1in CONDUIT LATERAL
- 44. STORMWATER ASSETS
- 45.

**DISCLAIMER NOTE**

UTILITY LOCATIONS SHOWN HEREON ARE APPROXIMATE ONLY. IT SHALL BE THE CONTRACTOR'S RESPONSIBILITY TO DETERMINE THE EXACT HORIZONTAL AND VERTICAL LOCATION OF ALL EXISTING UNDERGROUND AND OVERHEAD UTILITIES PRIOR TO COMMENCING CONSTRUCTION. NO REPRESENTATION IS MADE THAT ALL EXISTING UTILITIES ARE SHOWN HEREON. THE ENGINEER ASSUMES NO RESPONSIBILITY FOR UTILITIES NOT SHOWN OR UTILITIES NOT SHOWN IN THEIR PROPER LOCATIONS.

**CALL BEFORE YOU DIG**  
811  
BEFORE YOU DIG  
OR 1-800-227-2600  
UNDERGROUND SERVICE (USA)

**CALL BEFORE YOU OVERHEAD**  
1-702-227-2929  
NEVADA POWER ENVIRONMENT AND SAFETY SERVICE DEPARTMENT

**CITY OF LAS VEGAS**  
333 N. KANACHU DRIVE  
LAS VEGAS, NEVADA 89106  
(702) 229-6885

**COX**  
1700 VEGAS DRIVE  
LAS VEGAS, NEVADA 89106  
PHONE: (702) 545-1806  
FAX: (702) 545-2806

**REVISIONS**

| REV | DESCRIPTION | DATE | BY |
|-----|-------------|------|----|
| 0   |             |      |    |

**APPROVED FOR CONSTRUCTION**

THIS APPROVAL IS FOR WORK IN CLV R/W OR CLV EASEMENT ONLY. OBTAINING PERMISSION OR EASEMENT FOR WORK SHOWN IN PRIVATE PROPERTY IS THE RESPONSIBILITY OF THE UTILITY.

APPROVAL: *[Signature]* DATE: 6/27/19

**PERMIT #**  
RB-2223

**DATE:**  
4/12/2019

**SCALE:**  
1:30

**PROJECT #**  
405051900000RB22230

**TECH #**  
702-333-8728

**APPROVED BY:**  
MICHAEL HERVIS

**PROJECT LOCATION:**  
FARM HUALAPAI SUBDIVISION

**SUB-CONTRACTOR:**  
DBA: COX COMMUNICATIONS

**ENTITY NOTES:**

**SHEET NO:**  
2

Sheet 2 of 3

**T19S R60E SEC18**

**CITY/ENTITY:**  
CITY OF LAS VEGAS

**PROJECT LOCATION:**  
FARM HUALAPAI SUBDIVISION





**SUB-CONTRACTOR:**  
DBA: COX COMMUNICATIONS

**ENTITY NOTES:**


**SHEET NO:**  
2



MATCHLINE B - SEE SHEET 2

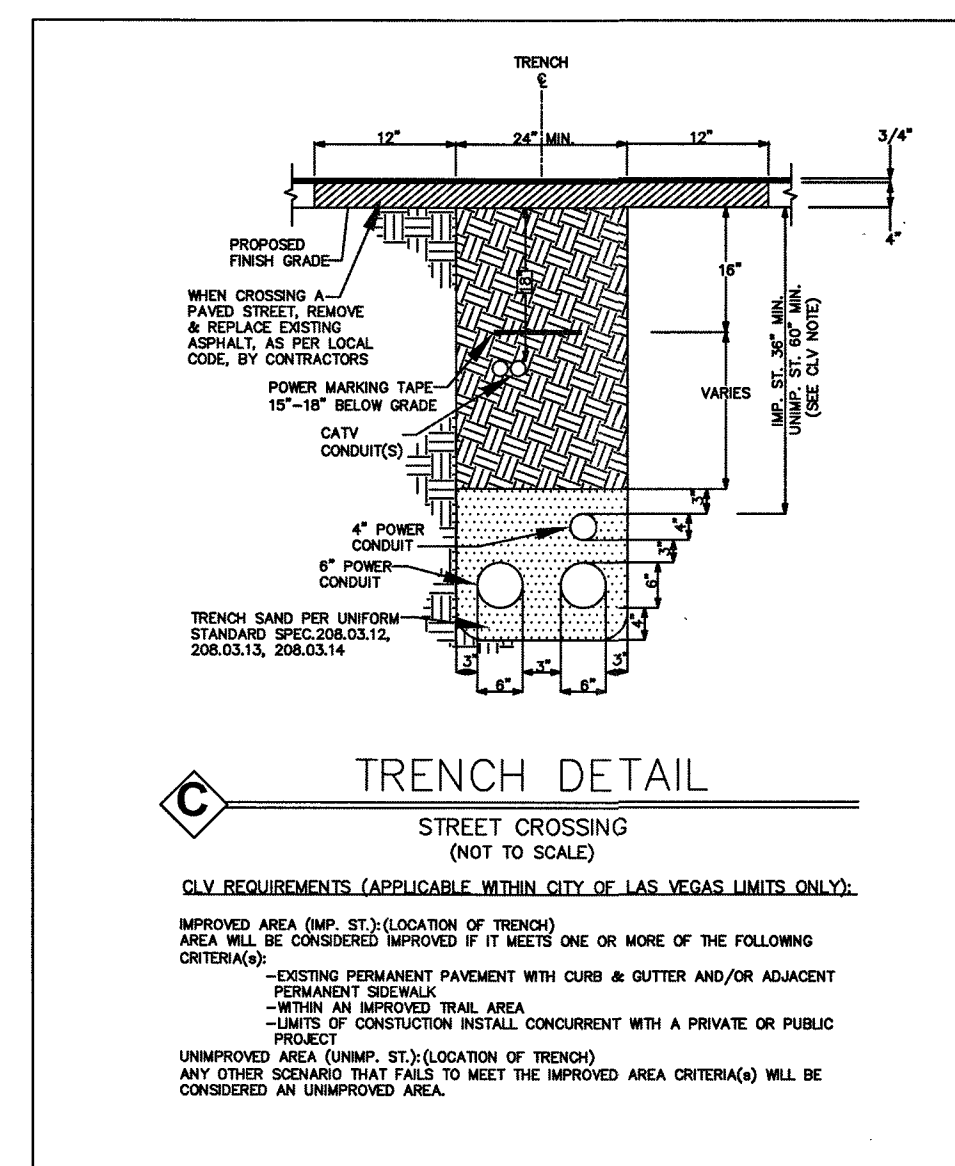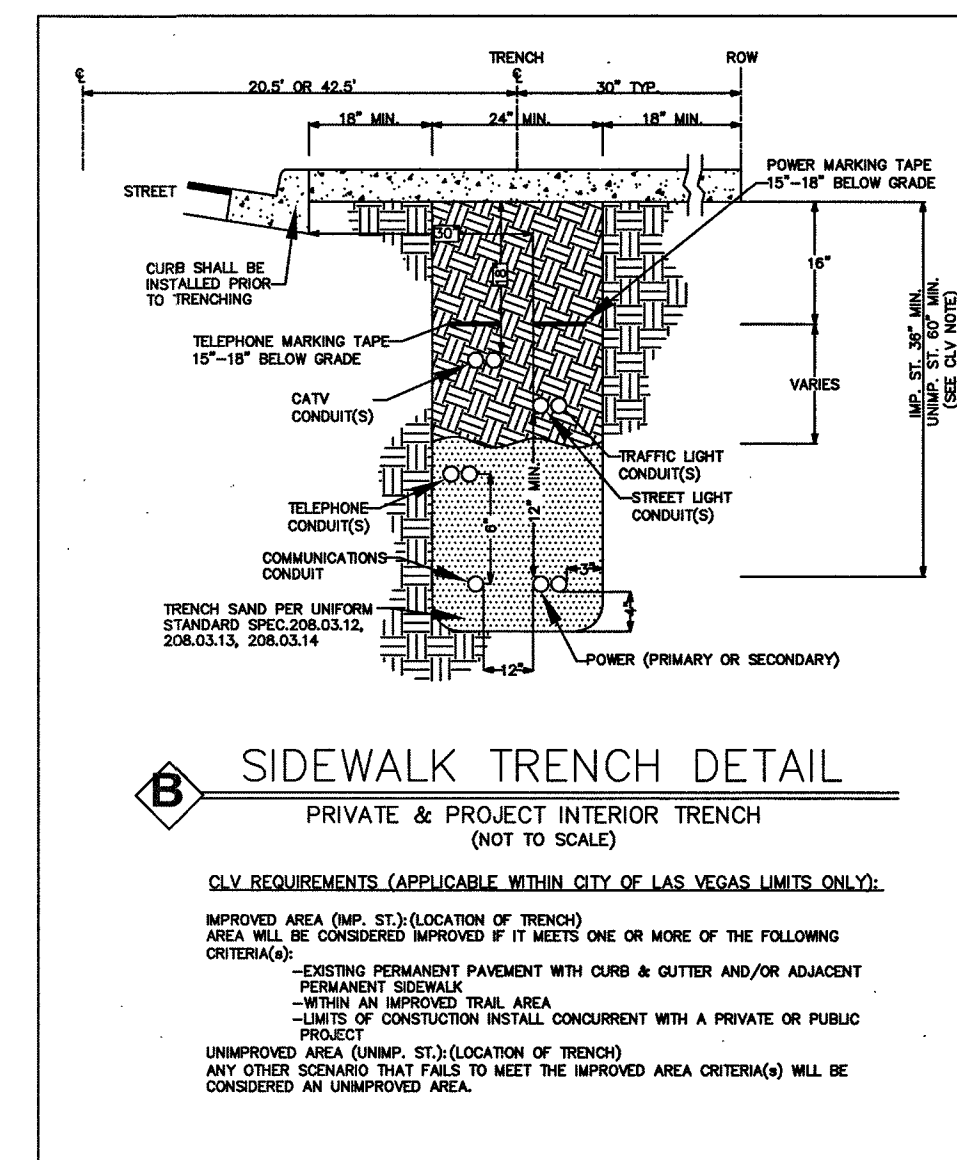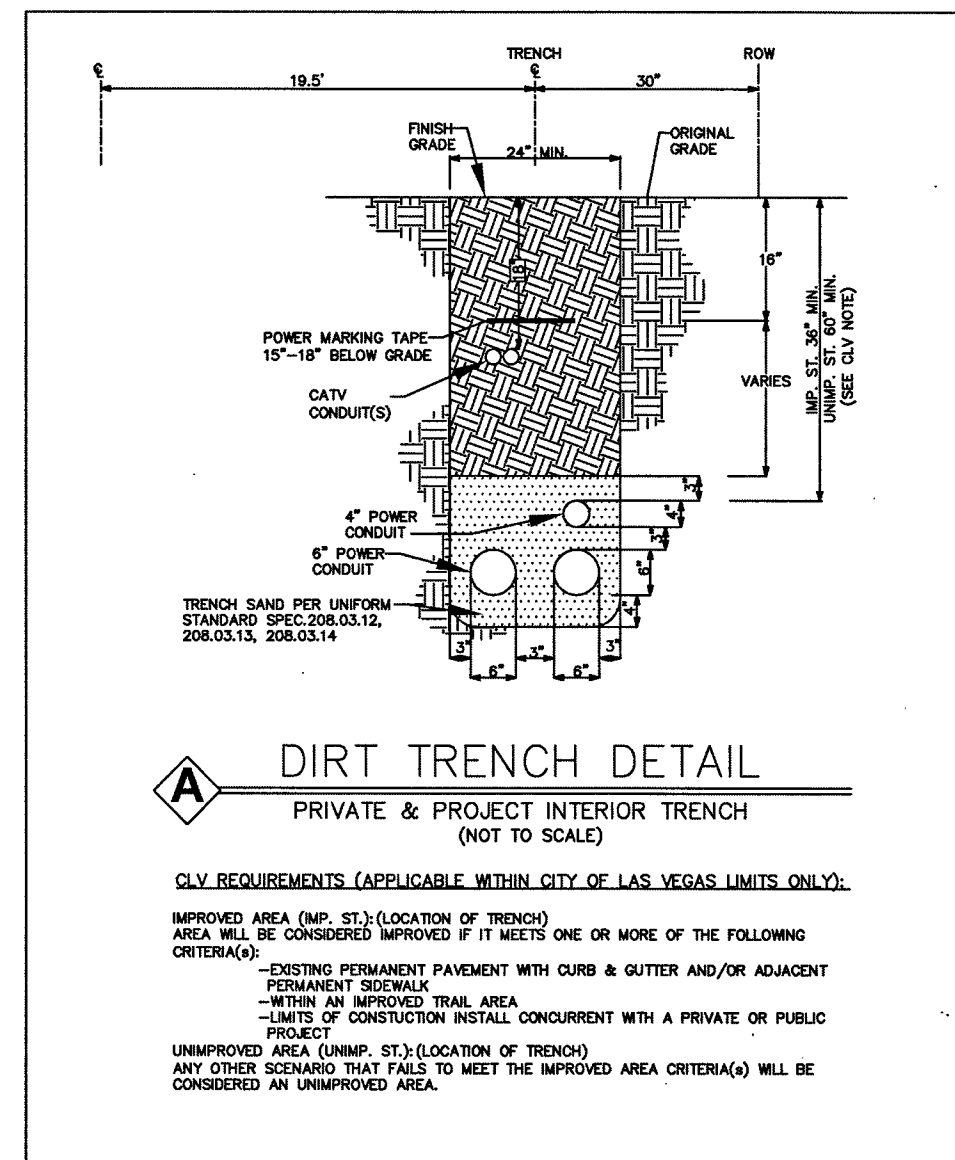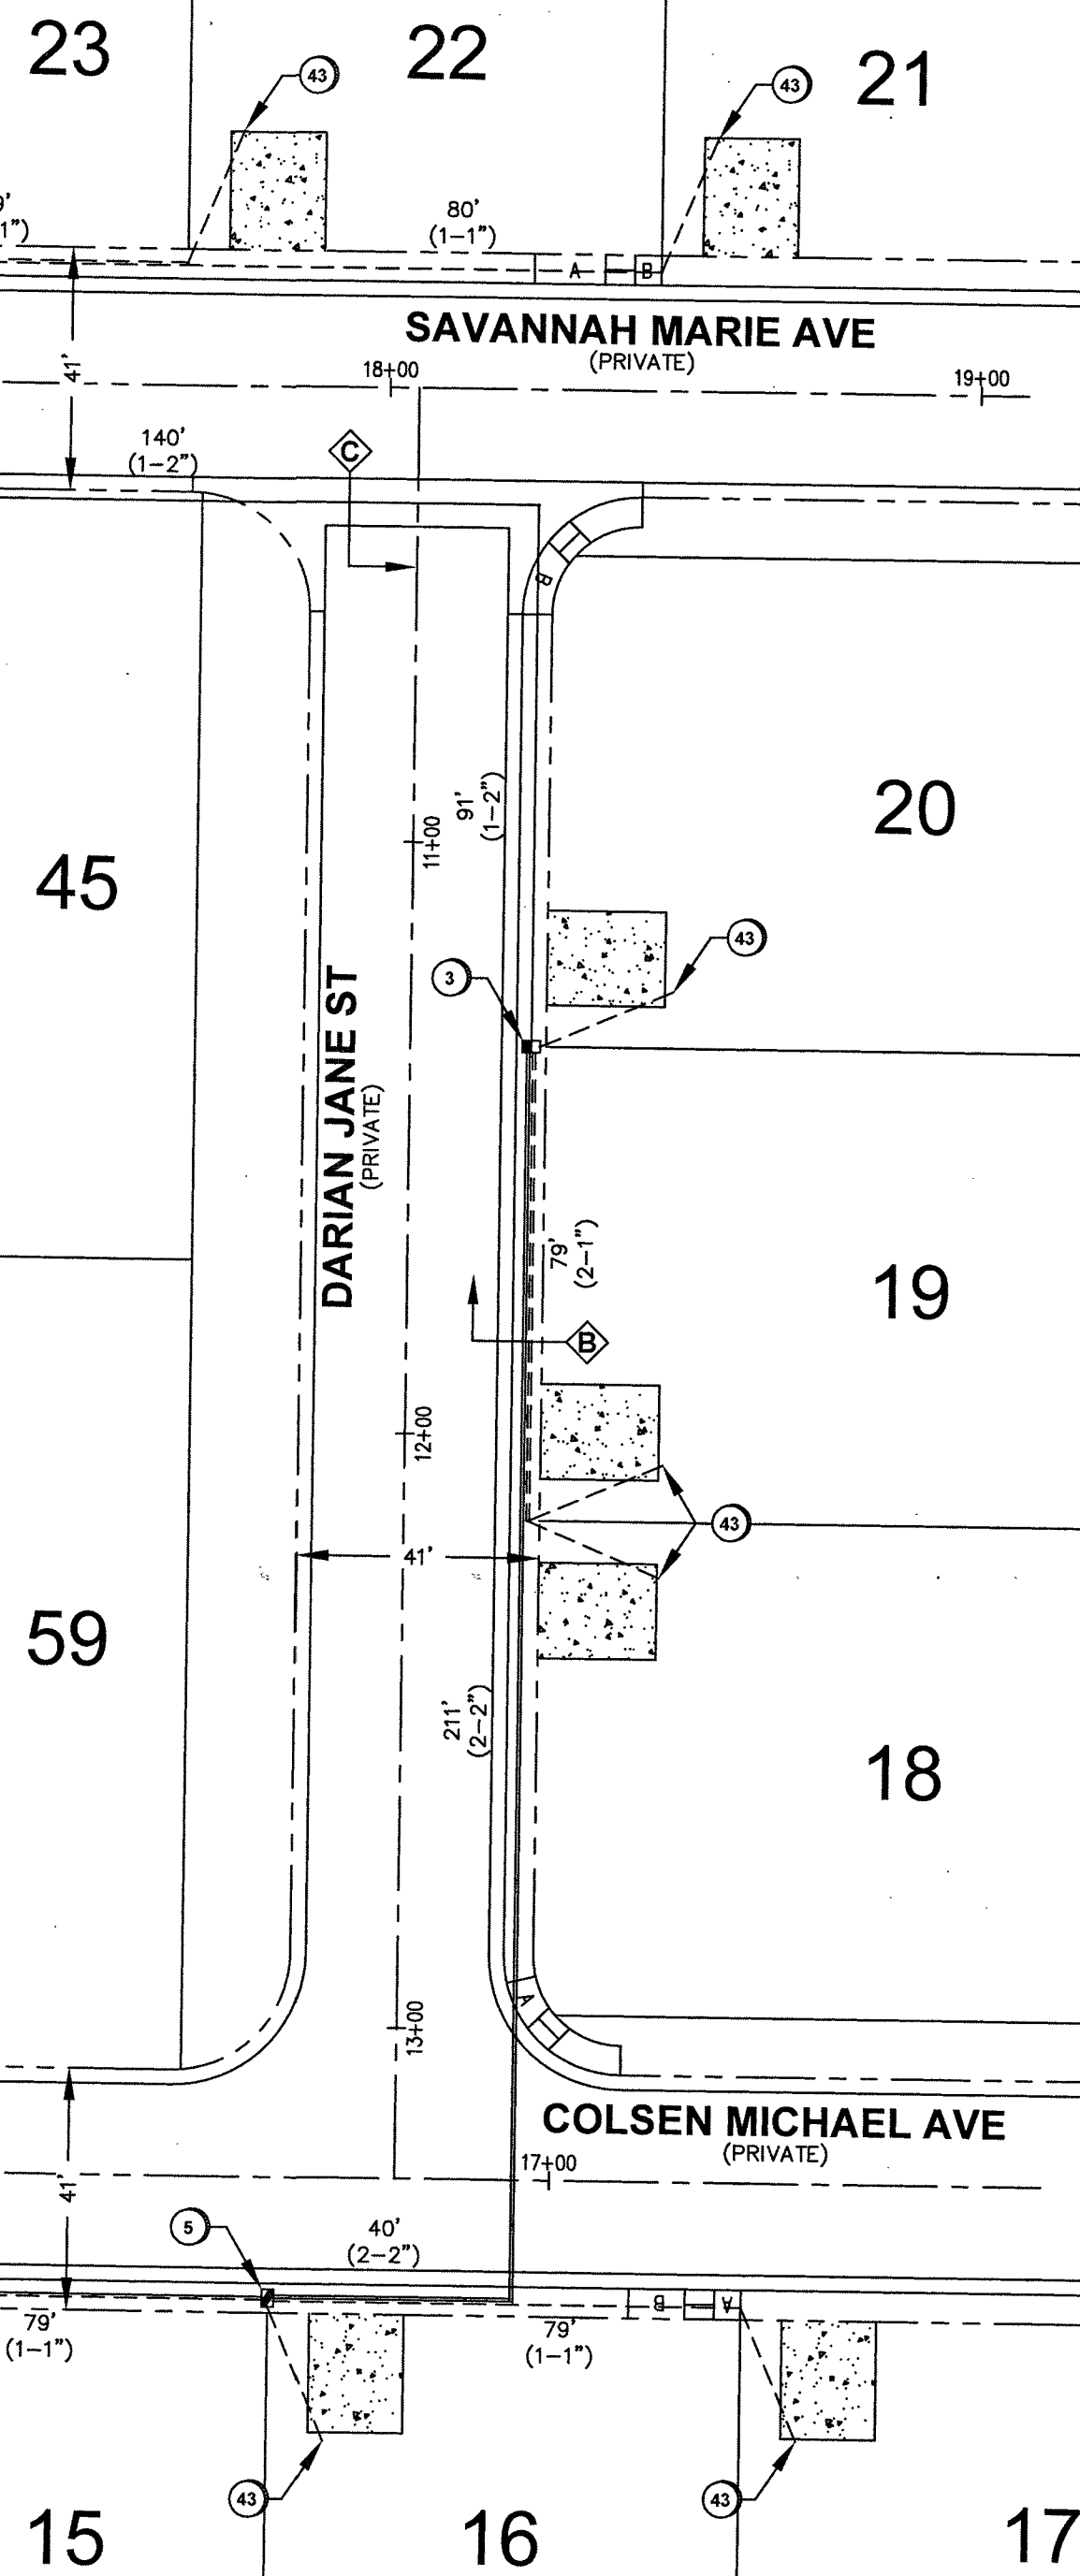

| LEGEND |                                                       |
|--------|-------------------------------------------------------|
| 1      | INSTALL B-36 PULL BOX (24"x36"x24")                   |
| 2      | EXISTING B-36 PULL BOX (24"x36"x24")                  |
| 3      | INSTALL B-50 PULL BOX (13"x24"x24")                   |
| 4      | EXISTING B-50 PULL BOX (13"x24"x24")                  |
| 5      | INSTALL B-100 PULL BOX (24"x36"x24")                  |
| 6      | EXISTING B-100 PULL BOX (24"x36"x24")                 |
| 7      | INSTALL T-200 CATV VAULT (30"x48"x36")                |
| 8      | EXISTING T-200 CATV VAULT (30"x48"x36")               |
| 9      | INSTALL T-400 CATV VAULT (36"x60"x36")                |
| 10     | EXISTING T-400 CATV VAULT (36"x60"x36")               |
| 11     | INSTALL T-600 CATV VAULT (48"x72"x36")                |
| 12     | EXISTING T-600 CATV VAULT (48"x72"x36")               |
| 13     | INSTALL NEW CATV PEDESTAL/CABINET                     |
| 14     | EXISTING NEW CATV PEDESTAL/CABINET                    |
| 15     | R&R S/W SLAB(S)                                       |
| 16     | POTHOLE                                               |
| 17     | SIDEWALK/DIRT TRENCH INSTALL WITH FIBER/COAX PULL     |
| 18     | ASPHALT MITIGATION/STREET TRENCH WITH FIBER/COAX PULL |
| 19     | PROPOSED BORE WITH FIBER/COAX PULL                    |
| 20     | EXISTING CATV CONDUIT(S)                              |
| 21     | PROPOSED OVERHEAD FIBER OPTIC CABLE OR COAX INSTALL   |
| 22     | EXISTING OVERHEAD FIBER OPTIC CABLE OR COAX           |
| 23     | U.G. FIBER/COAX PULL THROUGH EXISTING CONDUIT         |
| 24     | RIGHT OF WAY LINE                                     |
| 25     | LOT/PROPERTY LINE                                     |
| 26     | EDGE OF PAVEMENT/SIDEWALK/CONCRETE                    |
| 27     | EXISTING NVE PULL BOX                                 |
| 28     | EXISTING TELCO PULL BOX                               |
| 29     | EXISTING TELCO MANHOLE                                |
| 30     | EXISTING TELCO POLE                                   |
| 31     | EXISTING NVE POLE                                     |
| 32     | EXISTING NVE TRANSMISSION POLE                        |
| 33     | EXISTING JOINT POLE                                   |
| 34     | EXISTING JOINT POLE WITH TRANSFORMER                  |
| 35     | POLE ANCHOR                                           |
| 36     | EXISTING NVE TRANSFORMER TRANSFORMER PAD              |
| 37     | SNWA TEST STATION                                     |
| 38     | COX POWER SUPPLY (49"x24"x52")                        |
| 39     | INSTALL RHINO CABINET                                 |
| 40     | RISER POLE/QUADRANT DETAIL RISER OWNERSHIP NOTED      |
| 41     | RAILROAD                                              |
| 42     | EXISTING MANHOLE (SS),(SD), ECT                       |
| 43     | 1in CONDUIT LATERAL                                   |
| 44     | STORMWATER ASSETS                                     |
| 45     |                                                       |

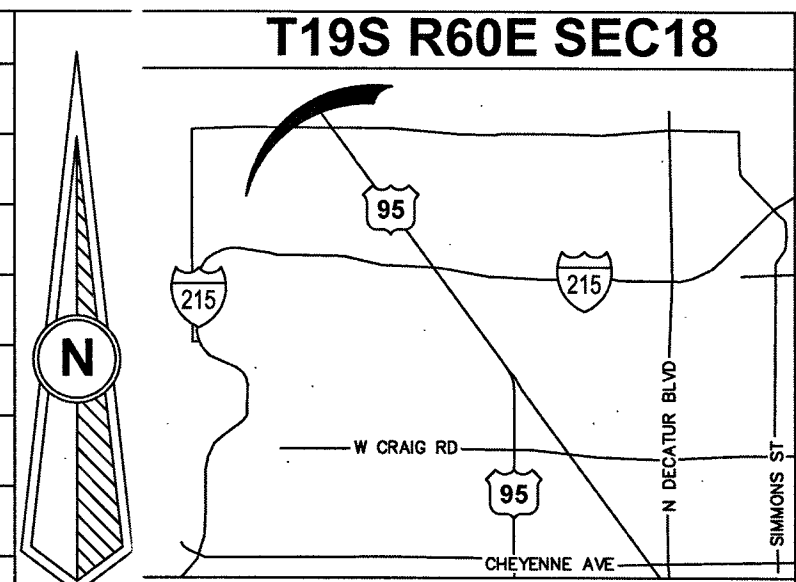

| REVISIONS |             |         |
|-----------|-------------|---------|
| REV       | DESCRIPTION | DATE BY |
| 1         |             |         |
| 2         |             |         |
| 3         |             |         |
| 4         |             |         |
| 5         |             |         |
| 6         |             |         |
| 7         |             |         |
| 8         |             |         |
| 9         |             |         |
| 10        |             |         |
| 11        |             |         |
| 12        |             |         |
| 13        |             |         |
| 14        |             |         |
| 15        |             |         |
| 16        |             |         |
| 17        |             |         |
| 18        |             |         |
| 19        |             |         |
| 20        |             |         |
| 21        |             |         |
| 22        |             |         |
| 23        |             |         |
| 24        |             |         |
| 25        |             |         |
| 26        |             |         |
| 27        |             |         |
| 28        |             |         |
| 29        |             |         |
| 30        |             |         |
| 31        |             |         |
| 32        |             |         |
| 33        |             |         |
| 34        |             |         |
| 35        |             |         |
| 36        |             |         |
| 37        |             |         |
| 38        |             |         |
| 39        |             |         |
| 40        |             |         |
| 41        |             |         |
| 42        |             |         |
| 43        |             |         |
| 44        |             |         |
| 45        |             |         |

ALL CONSTRUCTION AND MATERIALS SHALL BE IN ACCORDANCE WITH THE "UNIFORM STANDARD SPECIFICATIONS FOR PUBLIC WORKS CONSTRUCTION OFF-SITE IMPROVEMENTS, CLARK COUNTY AREA NEVADA" LATEST ISSUE; THE "UNIFORM STANDARD DRAWINGS FOR PUBLIC WORKS CONSTRUCTION, CLARK COUNTY AREA NEVADA" LATEST ISSUE; AND OTHER APPLICABLE APPROVED STANDARDS ISSUED BY THE CONTRACTING AGENCY; ALL LOCAL CITY CODES AND ORDINANCES APPLICABLE.

**APPROVED FOR CONSTRUCTION**  
THIS APPROVAL IS FOR WORK IN CLV R/W OR CLV EASEMENT ONLY. OBTAINING PERMISSION OR EASEMENT FOR WORK SHOWN IN PRIVATE PROPERTY IS THE RESPONSIBILITY OF THE UTILITY.

APPROVAL: *[Signature]* DATE: 6/27/19

|             |                    |
|-------------|--------------------|
| PERMIT #    | RB-2223            |
| DATE        | 4/12/2019          |
| SCALE       | 1:30               |
| NODE        | RB-2223            |
| PROJECT #   | 40505190000RB22230 |
| TECH #      | 702-333-8728       |
| APPROVED BY | MICHAEL HERVIS     |

**COX**  
1700 VEGAS DRIVE  
LAS VEGAS, NEVADA 89106  
PHONE: (702) 545-1606  
FAX: (702) 545-2606

**CITY OF LAS VEGAS**  
333 N. KANGU DRIVE  
LAS VEGAS, NEVADA 89106  
(702) 229-6885

**FARM HUALAPAI SUBDIVISION**  
SUB-CONTRACTOR:  
DBA: COX COMMUNICATIONS

**DISCLAIMER NOTE**  
UTILITY LOCATIONS SHOWN HEREON ARE APPROXIMATE ONLY. IT SHALL BE THE CONTRACTOR'S RESPONSIBILITY TO DETERMINE THE EXACT HORIZONTAL AND VERTICAL LOCATION OF ALL EXISTING UNDERGROUND AND OVERHEAD UTILITIES PRIOR TO COMMENCING CONSTRUCTION. NO REPRESENTATION IS MADE THAT ALL EXISTING UTILITIES ARE SHOWN HEREON. THE ENGINEER ASSUMES NO RESPONSIBILITY FOR UTILITIES NOT SHOWN OR PROPER LOCATIONS.

**CALL BEFORE YOU DIG**  
OR 1-800-227-2600  
UNDERGROUND SERVICE (USA)

**CALL BEFORE YOU OVERHEAD**  
1-702-227-2929  
NEVADA POWER ENVIRONMENT AND SAFETY SERVICE DEPARTMENT

|                      |    |
|----------------------|----|
| TOTAL BORE           | 0' |
| TOTAL DIRT TRENCH    | 0' |
| TOTAL ASPHALT TRENCH | 0' |
| TOTAL S/W PANELS     | 0' |
| TOTAL LINEAR FOOTAGE | 0' |

MATCHLINE C - SEE SHEET 2 107YS104-UTL