
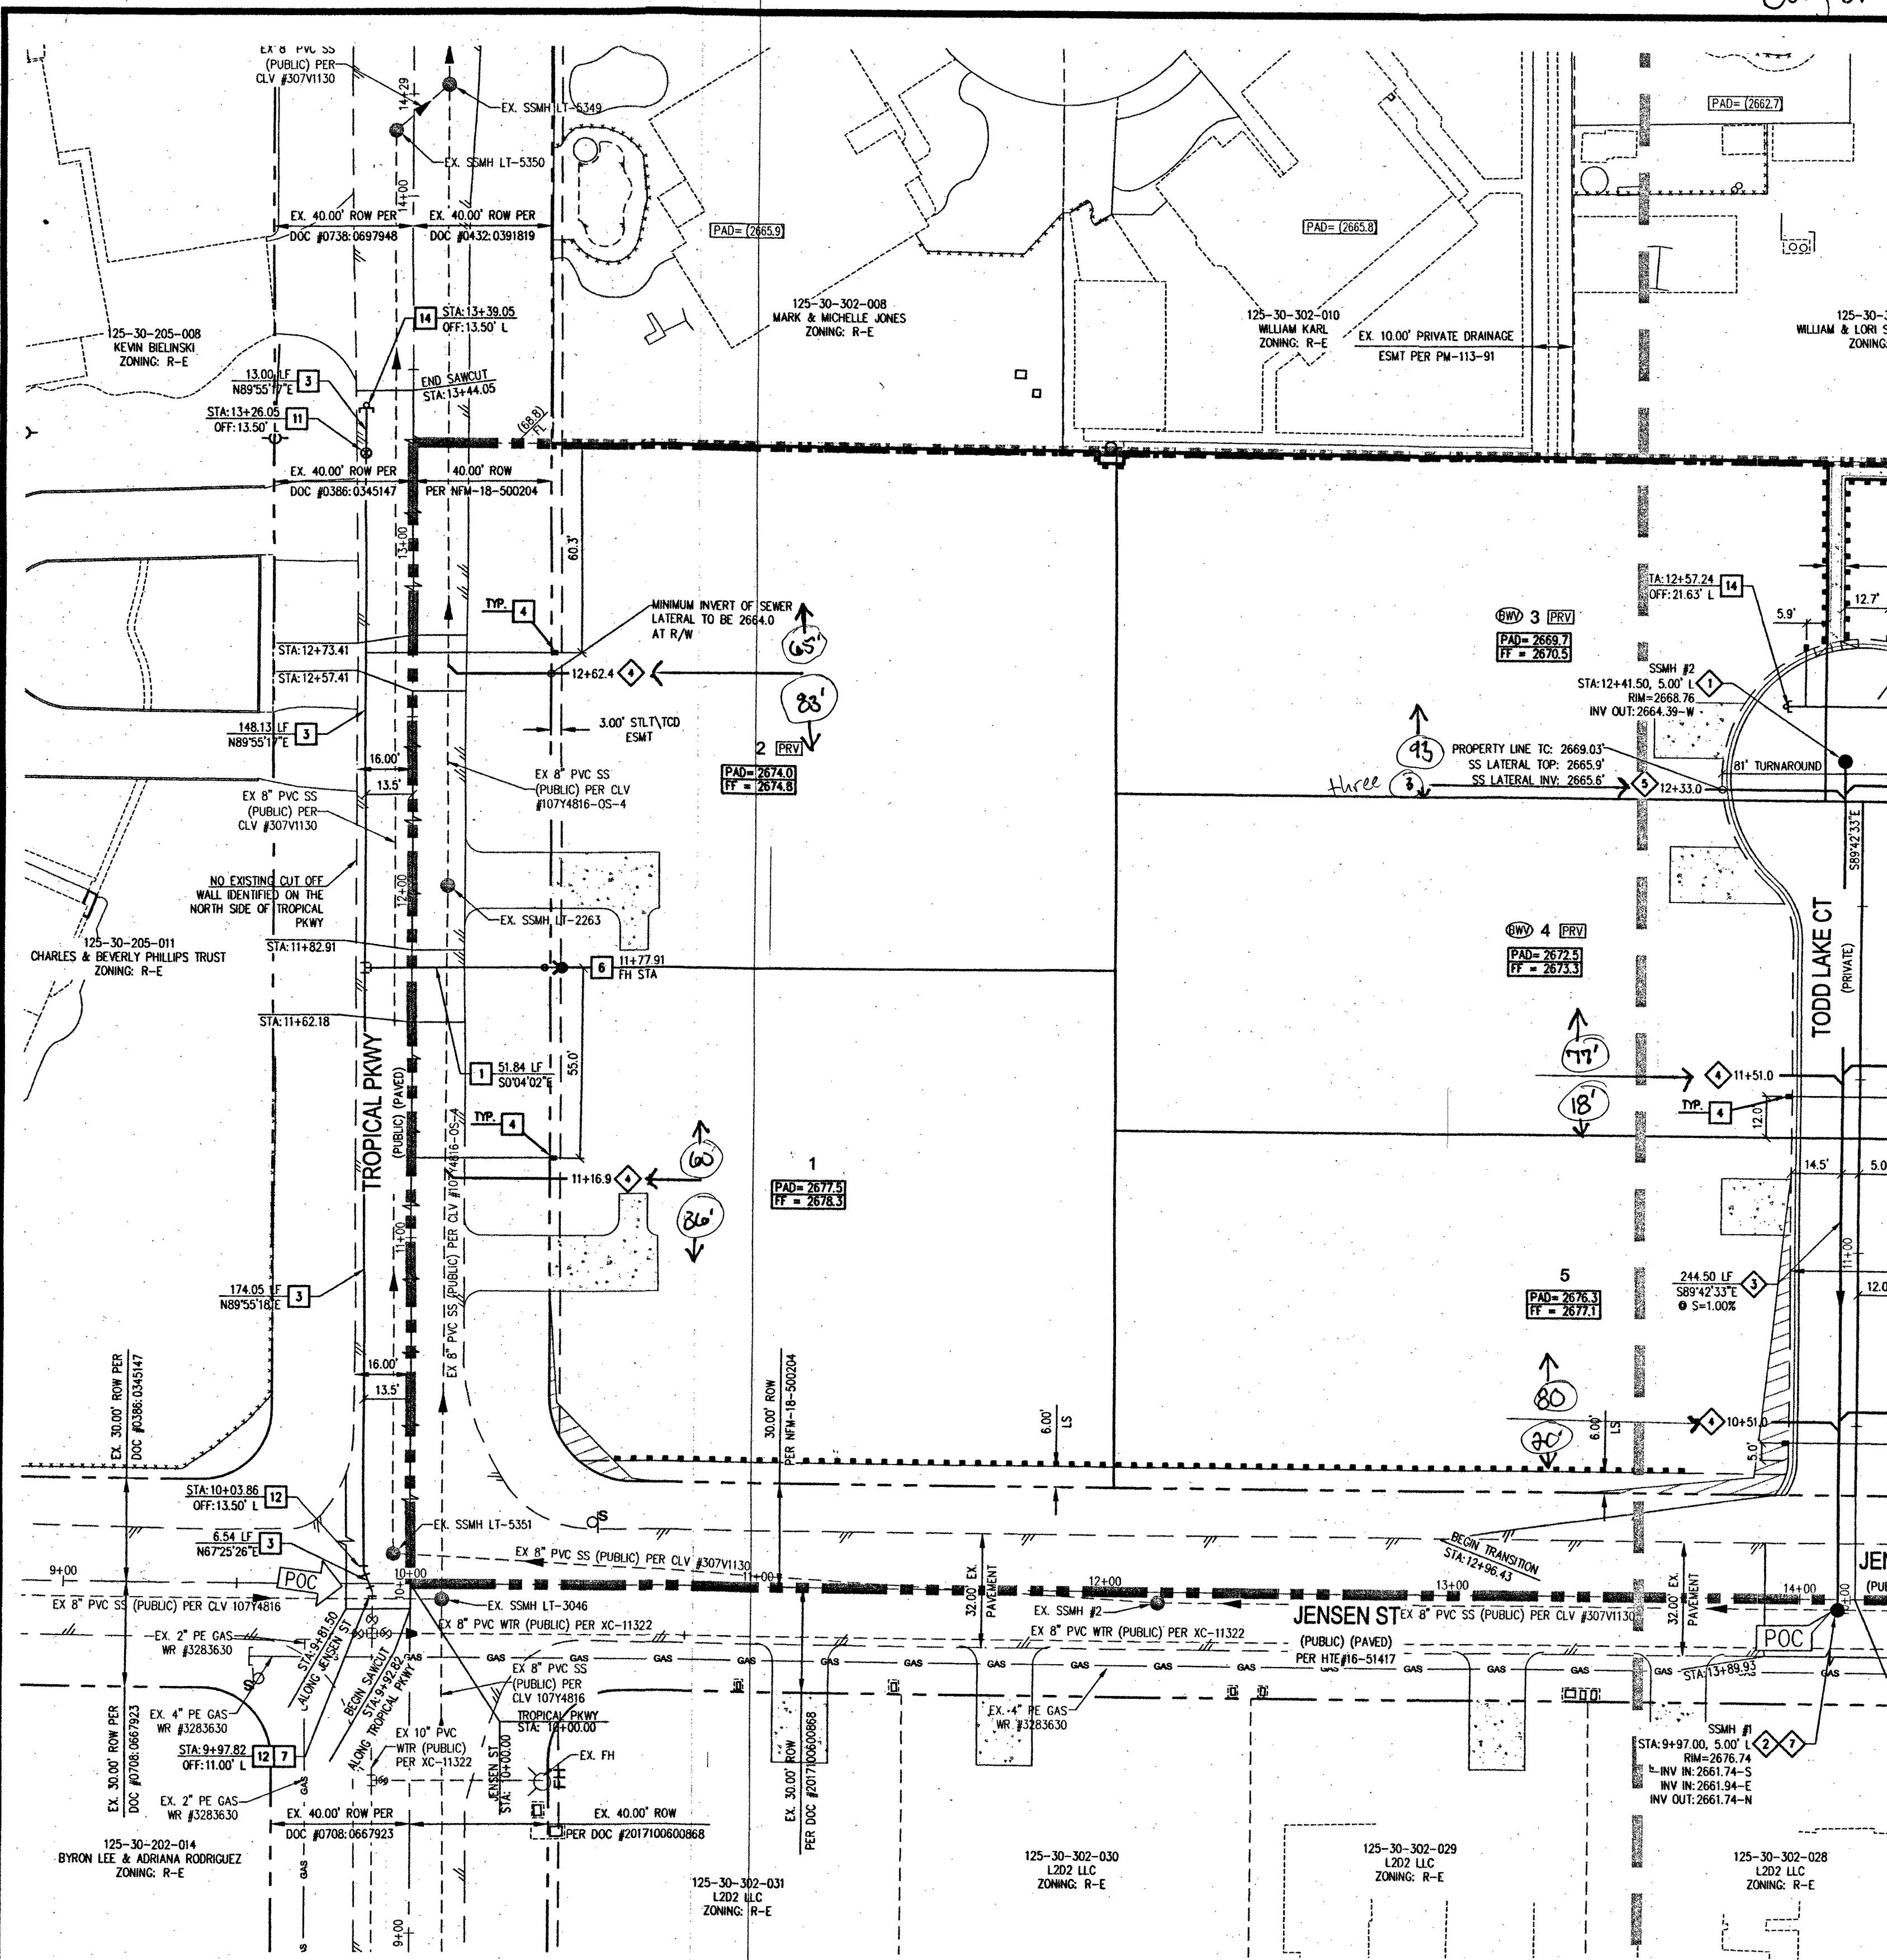


FIRE FLOW CALCULATIONS	
FIRE FLOW 2,250 GPM AT 20 P.S.I. RESIDUAL	
USE/OCCUPANCY	SINGLE FAMILY
TYPE OF CONSTRUCTION (BC)	TYPE V-B
AUTOMATIC FIRE SPRINKLERS	NO
SQUARE FOOTAGE (LIVABLE)	<5000
SQUARE FOOTAGE (TOTAL)	<7000
LARGEST AREA BETWEEN 4 HOUR WALLS	N/A
BUILDING HEIGHT	<3
NO OF STORES INCLUDING BASEMENT	2
HIGH PILED COMBUSTIBLE STORAGE	NO
NO OF HYDRANTS INSTALLED	2

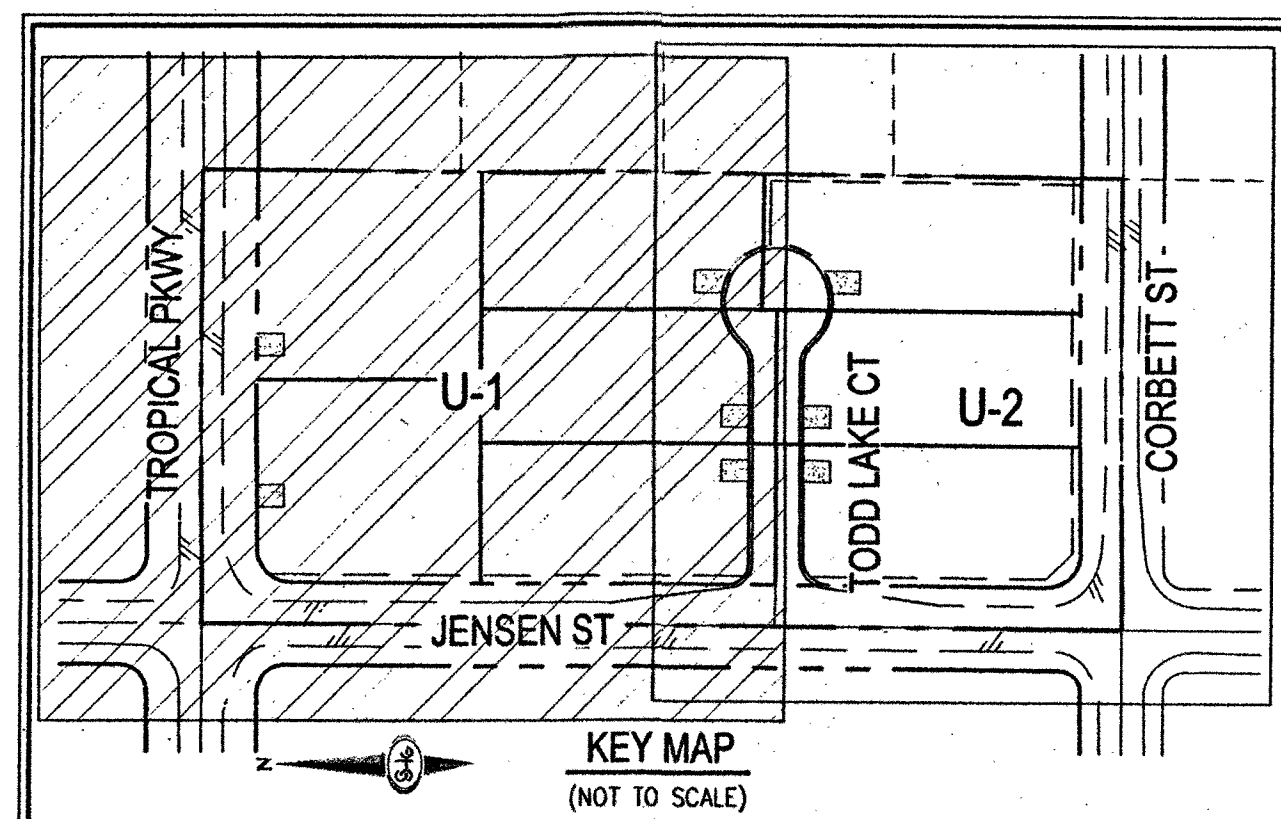

SEWER CONSTRUCTION NOTES

- INSTALL 48" DIAMETER SANITARY SEWER MANHOLE PER DCSWCS SD-1A, SD-1B, AND SD-9 WITH SINGLE 24" LD
- INSTALL 48" DIAMETER SANITARY SEWER MANHOLE WITH CAST-IN-PLACE BASE PER DCSWCS SD-4, SD-7, AND SD-9 WITH SINGLE 24" LD
- INSTALL 8" CSD SANITARY SEWER PIPE (PUBLIC) PER DCSWCS SD-17
- INSTALL 4" PVC SANITARY SEWER LATERAL PER DCSWCS SD-17, SD-22 AND SD-25
- INSTALL 4" PVC SANITARY SEWER LATERAL WITH A SLOPE OF 1.5% PER DCSWCS SD-17, SD-22, AND SD-25
- INSTALL 4" 6-900 PVC SANITARY SEWER LATERAL WITH A SLOPE OF 1.5% PER DCSWCS SD-17, SD-22, AND SD-25
- FIELD VERIFY LOCATION AND CONNECT TO EXISTING SEWER

ESTIMATED AVERAGE DAILY SEWER CONTRIBUTIONS

SEE SHEET MU-1

LATERAL MARKING REQUIREMENTS


LATERALS SHALL BE MARKED ACCORDING TO THE 2009 DESIGN AND CONSTRUCTION STANDARDS FOR WASTEWATER COLLECTIONS SYSTEMS. STANDARD DRAWING 5, A 3/4" MARKER BALL IS TO BE INSTALLED OVER THE CONNECTION POINT AT THE MAIN OR MANHOLE. A SECOND MARKER IS TO BE INSTALLED AT THE POINT WHERE THE LATERAL CROSSES THE PROPERTY LINE. A VISUAL MARK IS ALSO REQUIRED. A 3-INCH HIGH "S" STAMPED OR CHISELED INTO THE CONCRETE AT THE POINT DIRECTLY OVER WHERE THE LATERAL PASSES UNDER THE CURB.

WATER NOTES

- INSTALL 6" PVC WATER PIPE (2860 WP2)
- INSTALL 8" PVC WATER PIPE (2860 WP2)
- INSTALL 10" PVC WATER PIPE (2860 WP2)
- INSTALL 1" COPPER SERVICE W/ 3/4" METER PER UDACS PLATE NO. 1
- INSTALL FIRE HYDRANT ASSEMBLY W/ 6" GATE VALVE PER UDACS PLATES NO. 30, 39 & 40 (SEE DETAIL "A" ON THIS SHEET)
- INSTALL FIRE HYDRANT ASSEMBLY W/ 6" GATE VALVE PER UDACS PLATES NO. 30, 39 & 40 (SEE DETAIL "B" ON THIS SHEET)
- FIELD VERIFY INVERT, AND CONNECT TO EXISTING WATERLINE
- INSTALL 8" X 8" TAPPING SLEEVE WITH 8" TAPPING VALVE PER UDACS PLATE NO. 30, 34, 39 AND SECTION 2.24.01A
- INSTALL 6" GATE VALVE WITH VALVE BOX PER UDACS PLATE NO. 30 & 39
- INSTALL 90 DEGREE BEND PER UDACS PLATE NO. 31
- INSTALL 10" GATE VALVE WITH VALVE BOX PER UDACS PLATE NO. 30 & 39
- INSTALL 22.5 DEGREE BEND PER UDACS PLATE NO. 31
- INSTALL 8" X 6" REDUCER PER UDACS PLATE NO. 30
- INSTALL CAP AND 2" BLOW-OFF VALVE PER UDACS PLATE NO. 36

UTILITY LEGEND	
	MATCHLINE
	BOUNDARY LINE
	STREET CENTERLINE
	RIGHT-OF-WAY
	EASEMENT LINE
	PROPERTY LINE
	PROPOSED CURB AND GUTTER WITH PRIVATE ROADWAY EASEMENT AT BACK OF CURB
	EXISTING CURB AND GUTTER
	WATER PIPE FITTING
	WATER GATE VALVE
	FIRE HYDRANT
	REFLECTIVE RAISED PAVEMENT MARKERS
	SANITARY SEWER MANHOLE
	SANITARY SEWER FLOW DIRECTION
	WATER POINT OF CONNECTION
	SEWER POINT OF CONNECTION
	INSTALL PRESSURE REDUCING VALVE

SEE SHEET C-3 FOR QUANTITIES AND ABBREVIATIONS

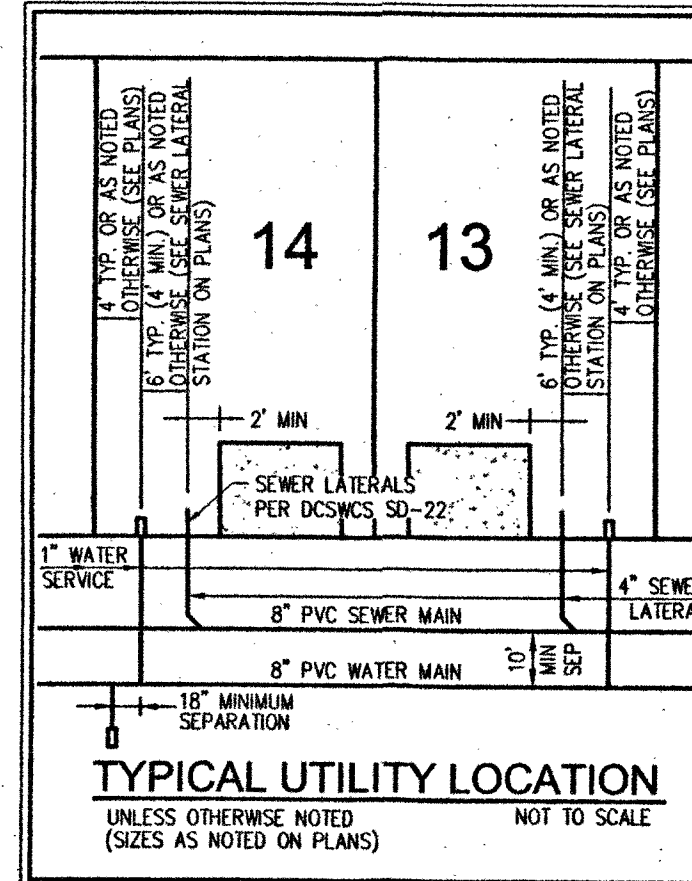

CLARK COUNTY FIRE DEPT. APPROVAL

BY: *[Signature]* DATE: 3/8/19

APPROVAL OF THESE PLANS SHALL NOT BE CONSIDERED TO BE A PERMIT FOR OR AN APPROVAL OF ANY VIOLATION OF ANY OF THE PROVISIONS OF THE STATE OR COUNTY LAWS. FIRE FLOW 2,250 GPM AT 20 P.S.I. RESIDUAL.

APPROVED FOR CONSTRUCTION

[Signature]

LAS VEGAS VALLEY WATER DISTRICT ENGINEERING SERVICES

PROJECT NO. 135041 FIRST APPROVED DATE: 3-15-19

LVWVD APPROVED FIRE FLOW 2,250 GPM AT 20 PSI RESIDUAL

MAXIMUM AVAILABLE FIRE SPRINKLER FLOW: N/A GPM

GENERAL NOTES

- THE CONTRACTOR IS TO VERIFY THE ACTUAL FIELD CONDITIONS OF ALL LOTS AND INSTALL SEWER CHECK VALVES WHERE REQUIRED PER THE LATEST EDITION OF THE UNIFORM PLUMBING CODE.
- FITTINGS SHALL NOT FAIL UNDER CURBS, GUTTERS OR SIDEWALK.

DISCLAIMER NOTE

EXISTING UTILITY LOCATIONS SHOWN HEREON ARE APPROXIMATE ONLY. IT SHALL BE THE CONTRACTOR'S RESPONSIBILITY TO DETERMINE THE EXCEPT VERTICAL AND HORIZONTAL LOCATION OF ALL EXISTING UNDERGROUND UTILITIES PRIOR TO COMMENCING CONSTRUCTION. NO REPRESENTATION IS MADE THAT ALL EXISTING UTILITIES ARE SHOWN HEREON. THE ENGINEER ASSUMES NO RESPONSIBILITY FOR UTILITIES NOT SHOWN IN THEIR PROPER LOCATION.

SOUTHWEST GAS APPROVAL

[Signature] DATE: 2-7-2019

SOUTHWEST GAS CORPORATION

BASIS OF BEARING

NORTH 00°39'20" EAST, BEING THE BEARING ON THE EAST LINE OF THE SOUTHWEST QUARTER (SW1/4) OF SECTION 30, TOWNSHIP 19 SOUTH, RANGE 50 EAST, N.M.S., CLARK COUNTY, NEVADA, AS SHOWN BY MAP THEREOF IN FILE 122, PAGE 74 OF PARCEL MAPS IN THE CLARK COUNTY RECORDER'S OFFICE, NEVADA.

PRV NOTE

THIS PROPERTY MAY HAVE STATIC WATER PRESSURE IN EXCESS OF 80 PSI. THE UNIFORM PLUMBING CODE REQUIRES THAT INDIVIDUAL ON-SITE (PRIVATE) PRESSURE-REDUCING VALVES (PRV) BE INSTALLED WHENEVER THE PRESSURE EXCEEDS 80 PSI. PRVs ARE THE DEVELOPER'S RESPONSIBILITY, AND WILL NOT BE INSPECTED OR INCLUDED IN THE ACCEPTANCE OF LVWVD FACILITIES.

BENCHMARK

BENCHMARK NUMBER: 1C90 3056

RIVET AND SQUARE ALUMINUM PLATE IN A 4' X 4' CONCRETE ELECTRIC PAD AT 9620 EL CAMPO GRANDE AVENUE, 30' NORTH AND 170' WEST OF GRAND CANYON DRIVE AND EL CAMPO GRANDE AVENUE.

ELEVATION = 2655.329 FEET, 809.346 METERS

N.A.S.D. 88 DATUM


PER THE CLARK COUNTY VERTICAL CONTROL V2003

FOR ALL DRY UTILITY CROSSINGS

- MAINTAIN MINIMUM 12" VERTICAL SEPARATION AT ALL POINTS OF CROSSING
- MAINTAIN MINIMUM 3' PARALLEL SEPARATION
- ANY EXCAVATION AT BACK OF CURB MUST REMAIN OPEN FOR INSPECTION OF COPPER SERVICE LATERALS. ANY COPPER SERVICE LATERAL KINKED, BENT OR OTHERWISE DAMAGED MUST BE REPLACED FROM THE MAIN TO THE ANGLE METER STOP.

LVWVD EASEMENT NOTE

ALL LVWVD EASEMENTS FOR METER, RPPA, AND FIRE HYDRANT LOCATIONS WILL BE CLEAR OF OBSTRUCTIONS (2% TO MAX 3% SLOPE) AND THE METER, RPPA, AND FIRE HYDRANT WILL BE INSTALLED WITHIN A LEVEL SURFACE PER UDACS PLATES 4, 8, & 40.

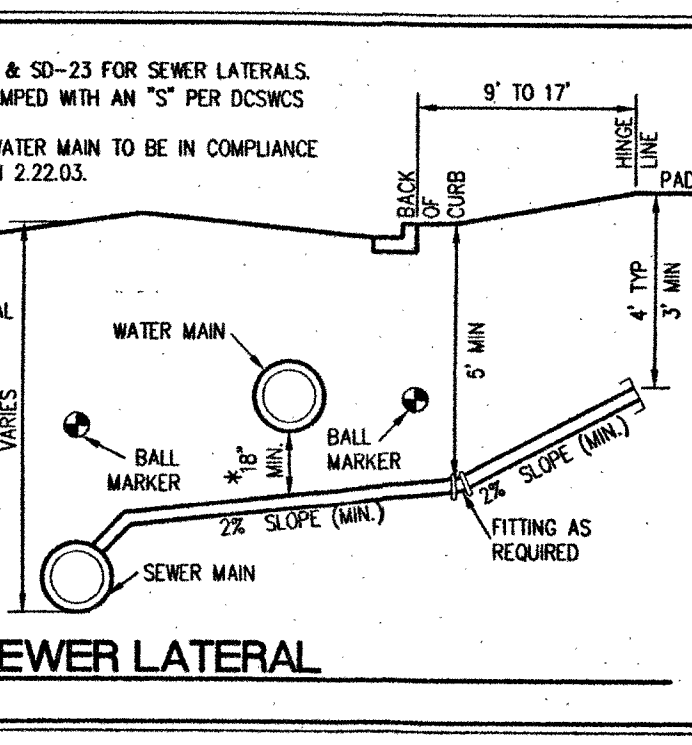

NOTES

- SEE DCSWCS SD-22 & SD-23 FOR SEWER LATERALS.
- CURB SHALL BE STAMPED WITH AN "S" PER DCSWCS SD-25
- SEPARATION FROM WATER MAIN TO BE IN COMPLIANCE WITH UDACS SECTION 2.22.03.

* 6" 18" SEPARATION CANNOT BE MAINTAINED. THE ENTIRE SEWER LATERAL TO BE CONSTRUCTED WITH C900 WATER QUALITY MATERIALS AND A MINIMUM SEPARATION OF 6" BETWEEN THE SEWER LATERAL AND WATER MAIN MUST BE MAINTAINED. (SEE WATER NOTES FOR CLSM NOTE)

FAST

Call before you Dig

UnderGround

1-702-432-5300

FREEWAY & ARTERIAL SYSTEM OF TRANSPORTATION (F.A.S.T.)

SLATER HANIFAN GROUP

a Westwood team

5740 S. ARVILLE STREET #216, LAS VEGAS, NV 89118

PHONE (702) 284-5300 FAX (702) 284-5399

CLARK COUNTY, NEVADA

DATE: 02/07/19

DRAWN: EMH

DESIGNER: EMH

CHECKED: KMB

PROJECT NO. PIN1801

U-1

SHEET 10 OF 21

PW18-17991

GREYHAWK

UTILITY PLAN I

FAST

Call before you Dig

UnderGround

1-702-432-5300

FREEWAY & ARTERIAL SYSTEM OF TRANSPORTATION (F.A.S.T.)

Call before you Dig

AVOID CUTTING UNDERGROUND UTILITY LINES. IT'S COSTLY.

Call

811

OR

1-800-227-2600

ENGINEER

KEVIN M. BROSS


Exp. 12/31/2026

CIVIL


Exp. 12/31/2026

118-02835

307V1158

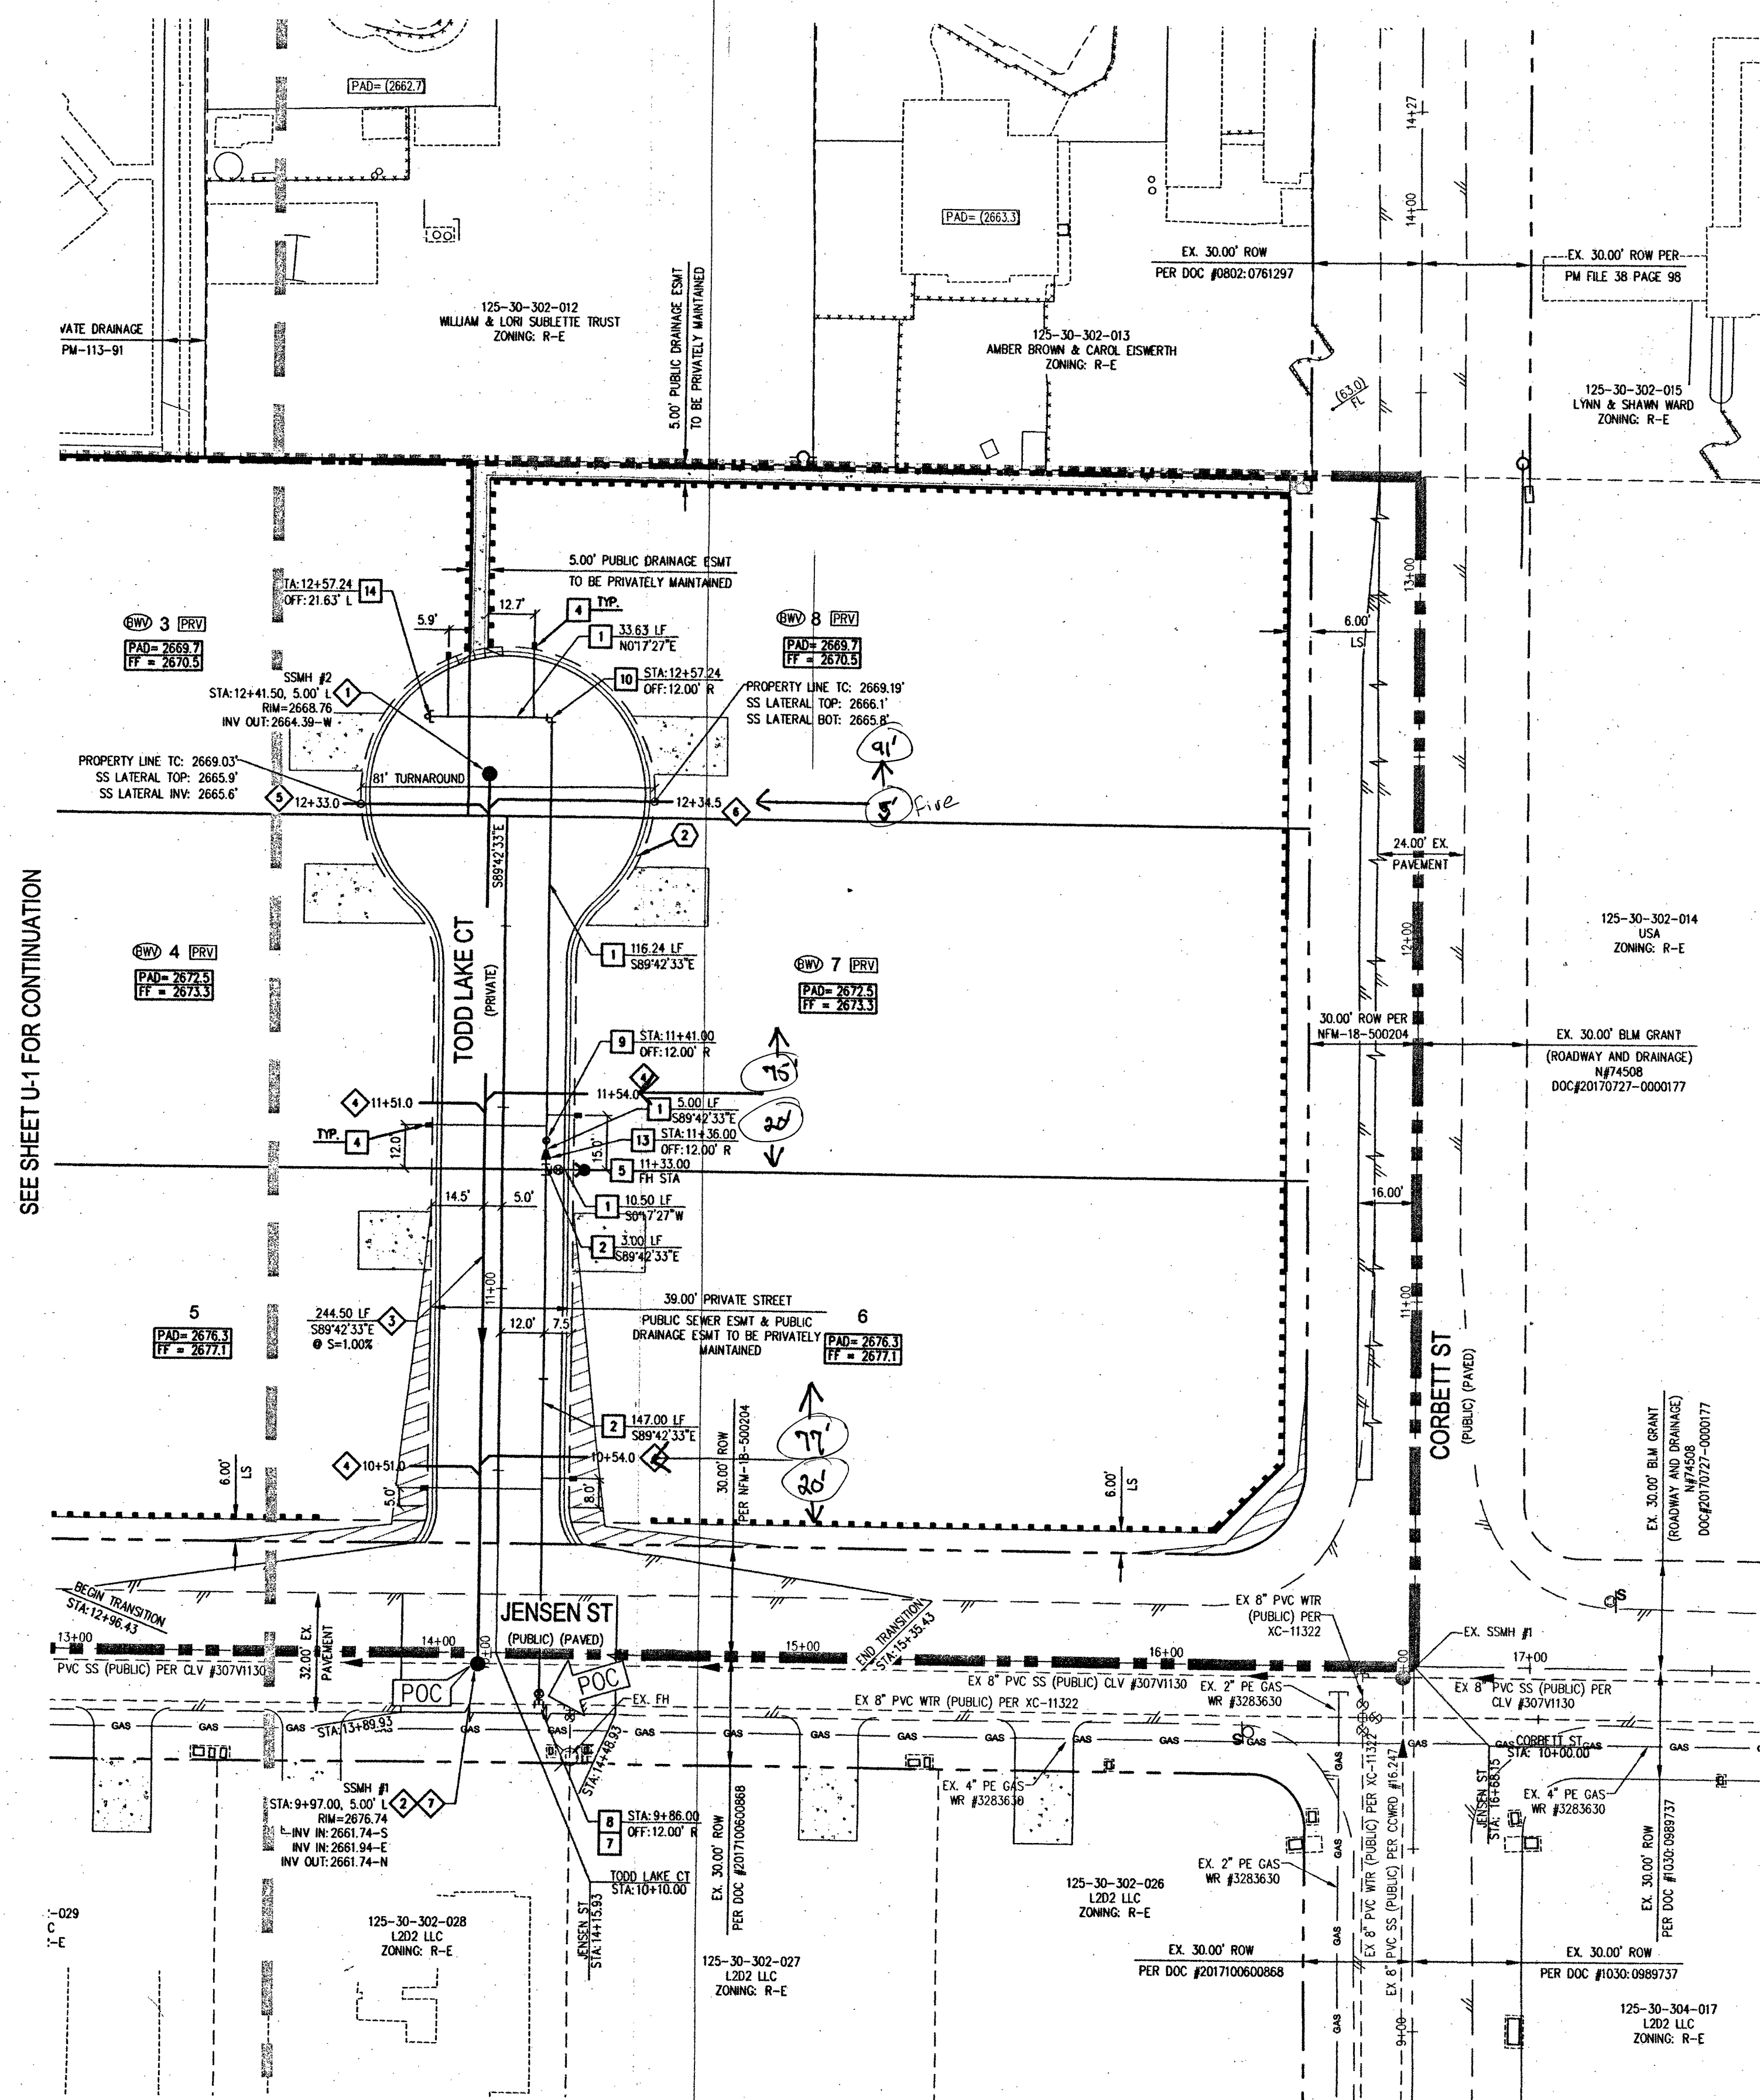

SEE SHEET U-1 FOR CONTINUATION

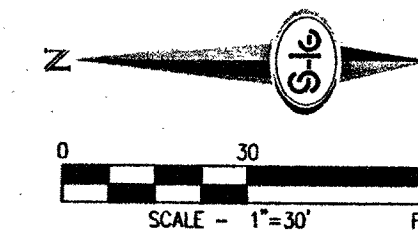

FIRE FLOW CALCULATIONS	
FIRE FLOW 2,250 GPM AT 20 P.S.I. RESIDUAL	
USE/OCCUPANCY	SINGLE FAMILY
TYPE OF CONSTRUCTION (BOC)	TYPE V-B
AUTOMATIC FIRE SPRINKLERS	NO
SQUARE FOOTAGE (LIVABLE)	<5000
SQUARE FOOTAGE (TOTAL)	<7000
LARGEST AREA BETWEEN 4 HOUR WALLS	N/A
BUILDING HEIGHT	<35
NO OF STORES INCLUDING BASEMENT	NO
HIGH PILED COMBUSTIBLE STORAGE	NO
NO OF HYDRANTS INSTALLED	2

CONSTRUCTION NOTES

- INSTALL 30" MODIFIED ROLL TYPE CURB PER CCAUSD NO. 2171 IN PRIVATE STREET

SEWER CONSTRUCTION NOTES


- INSTALL 48" DIAMETER SANITARY SEWER MANHOLE PER DCSWCS SD-1A, SD-1B, AND SD-9 WITH SINGLE 24" LID
- INSTALL 48" DIAMETER SANITARY SEWER MANHOLE WITH CAST-IN-PLACE BASE PER DCSWCS SD-4, SD-7, AND SD-9 WITH SINGLE 24" LID
- INSTALL 6" CSO SANITARY SEWER PIPE (PUBLIC) PER DCSWCS SD-17
- INSTALL 4" PVC SANITARY SEWER LATERAL PER DCSWCS SD-17, SD-22 AND SD-25
- INSTALL 4" PVC SANITARY SEWER LATERAL WITH A SLOPE OF 1.5% PER DCSWCS SD-17, SD-22, AND SD-25
- INSTALL 4" C-900 PVC SANITARY SEWER LATERAL WITH A SLOPE OF 1.5% PER DCSWCS SD-17, SD-22, AND SD-25
- FIELD VERIFY LOCATION AND CONNECT TO EXISTING SEWER

ESTIMATED AVERAGE DAILY SEWER CONTRIBUTIONS

SEE SHEET MU-1

LATERAL MARKING REQUIREMENTS

LATERALS SHALL BE MARKED ACCORDING TO THE 2009 DESIGN AND CONSTRUCTION STANDARDS FOR WASTEWATER COLLECTIONS SYSTEMS. STANDARD DRAWING 5, A 3/4" MARKER BALL IS TO BE INSTALLED OVER THE CONNECTION POINT AT THE MAIN OR MANHOLE. A SECOND MARKER IS TO BE INSTALLED AT THE POINT WHERE THE LATERAL CROSSES THE PROPERTY LINE. A VISUAL MARK IS ALSO REQUIRED. A 3-INCH HIGH "S" STAMPED OR CHISELED INTO THE CONCRETE AT THE POINT DIRECTLY OVER WHERE THE LATERAL PASSES UNDER THE CURB.

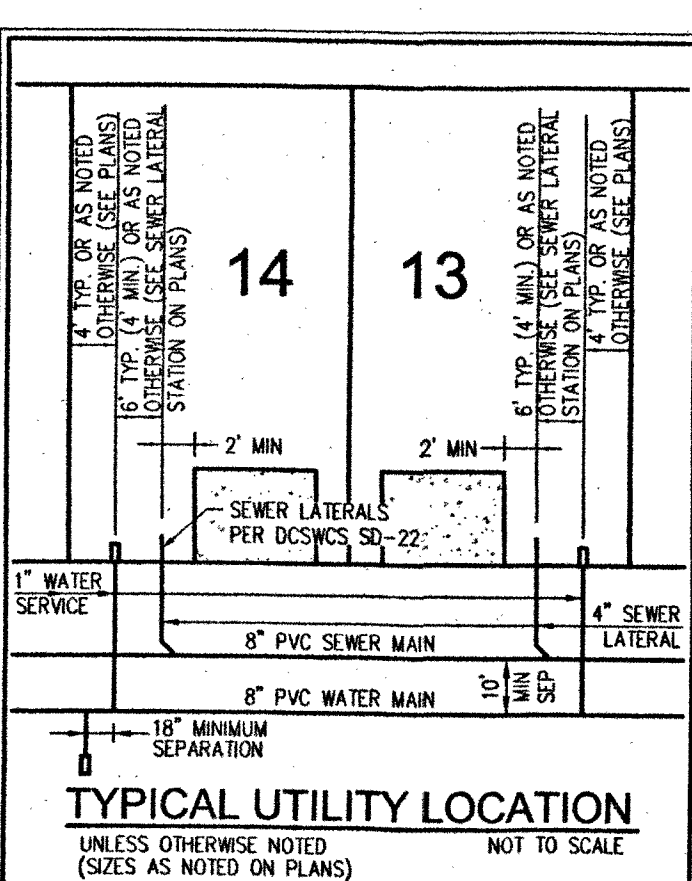

TYPICAL UTILITY LOCATION

UNLESS OTHERWISE NOTED (SIZES AS NOTED ON PLANS)

A. FIRE HYDRANT LOCATION

NOT TO SCALE PER UDACS PLATE NO. 40

B. FIRE HYDRANT LOCATION

NOT TO SCALE PER UDACS PLATE NO. 40

NOTES

- SEE DCSWCS SD-22 & SD-23 FOR SEWER LATERALS.
- CURB SHALL BE STAMPED WITH AN "S" PER DCSWCS SD-25.
- SEPARATION FROM WATER MAIN TO BE IN COMPLIANCE WITH UDACS SECTION 2.22.03.

TYPICAL SEWER LATERAL

NOT TO SCALE

WATER NOTES

- INSTALL 6" PVC WATER PIPE (2860 MP2)
- INSTALL 8" PVC WATER PIPE (2860 MP2)
- INSTALL 10" PVC WATER PIPE (2860 MP2)
- INSTALL 1" COPPER SERVICE W/ 3/4" METER PER UDACS PLATE NO. 1
- INSTALL FIRE HYDRANT ASSEMBLY W/ 6" GATE VALVE PER UDACS PLATES NO. 30, 39 & 40 (SEE DETAIL "A" ON THIS SHEET)
- INSTALL FIRE HYDRANT ASSEMBLY W/ 6" GATE VALVE PER UDACS PLATES NO. 30, 39 & 40 (SEE DETAIL "A" ON THIS SHEET)
- FIELD VERIFY INVERT, AND CONNECT TO EXISTING WATERLINE
- INSTALL 8" x 8" TAPPING SLEEVE WITH 8" TAPPING VALVE PER UDACS PLATE NO. 30, 34, 39 AND SECTION 2.24.01A
- INSTALL 6" GATE VALVE WITH VALVE BOX PER UDACS PLATE NO. 30 & 39
- INSTALL 90 DEGREE BEND PER UDACS PLATE NO. 31
- INSTALL 10" GATE VALVE WITH VALVE BOX PER UDACS PLATE NO. 30 & 39
- INSTALL 22.5 DEGREE BEND PER UDACS PLATE NO. 31
- INSTALL 8" x 6" REDUCER PER UDACS PLATE NO. 30
- INSTALL CAP AND 2" BLOW-OFF VALVE PER UDACS PLATE NO. 36

GENERAL NOTES

- THE CONTRACTOR IS TO VERIFY THE ACTUAL FIELD CONDITIONS OF ALL LOTS AND INSTALL SEWER CHECK VALVES WHERE REQUIRED PER THE LATEST EDITION OF THE UNIFORM PLUMBING CODE.
- FITTINGS SHALL NOT FALL UNDER CURBS, OUTLETS OR SIDEWALK.

DISCLAIMER NOTE

EXISTING UTILITY LOCATIONS SHOWN HEREON ARE APPROXIMATE ONLY. IT SHALL BE THE CONTRACTOR'S RESPONSIBILITY TO DETERMINE THE EXCEPT VERTICAL AND HORIZONTAL LOCATION OF ALL EXISTING UNDERGROUND UTILITIES PRIOR TO COMMENCING CONSTRUCTION. NO REPRESENTATION IS MADE THAT ALL EXISTING UTILITIES ARE SHOWN HEREON. THE ENGINEER ASSUMES NO RESPONSIBILITY FOR UTILITIES NOT SHOWN IN THEIR PROPER LOCATION.

SOUTHWEST GAS APPROVAL

Penelope Kennedy 2-7-2019
SOUTHWEST GAS CORPORATION DATE

CLARK COUNTY FIRE DEPT. APPROVAL

APPROVAL OF THESE PLANS NOT BE CONSIDERED TO BE A PERMIT FOR OR AN APPROVAL OF ANY VIOLATION OF ANY OF THE PROVISIONS OF THE STATE OR COUNTY LAWS. FIRE FLOW 2,250 GPM AT 20 P.S.I. RESIDUAL.

APPROVED FOR CONSTRUCTION

AS VEGAS VALLEY WATER DISTRICT ENGINEERING SERVICES
PROJECT NO. 135041 FIRST APPROVED DATE: 3-7-19
LVWVD APPROVED FIRE FLOW 2,250 GPM AT 20 PSI RESIDUAL
MAXIMUM AVAILABLE FIRE SPRINKLER FLOW N/A GPM

BASIS OF BEARING

NORTH 00°39'20" EAST, BEING THE BEARING ON THE EAST LINE OF THE SOUTHWEST QUARTER (SW1/4) OF SECTION 30, TOWNSHIP 19 SOUTH, RANGE 50 EAST, N.M.L., CLARK COUNTY, NEVADA, AS SHOWN BY MAP THEREOF IN FILE 122, PAGE 7A OF PARCEL MAPS IN THE CLARK COUNTY RECORDER'S OFFICE, NEVADA.

BENCHMARK

BENCHMARK NUMBER: 1030 3056
RIVET AND SQUARE ALUMINUM PLATE IN A 4' X 4' CONCRETE ELECTRIC PAD AT 9620 EL CAMPO GRANDE AVENUE, 30' NORTH AND 170' WEST OF GRAND CANYON DRIVE AND EL CAMPO GRANDE AVENUE.
ELEVATION = 2655.329 FEET, 809.346 METERS
N.A.V.D. 88 DATUM
PER THE CLARK COUNTY VERTICAL CONTROL V.2003

FOR ALL DRY UTILITY CROSSINGS

- MAINTAIN MINIMUM 12" VERTICAL SEPARATION AT ALL POINTS OF CROSSING
- MAINTAIN MINIMUM 3' PARALLEL SEPARATION
- ANY EXCAVATION AT BACK OF CURB MUST REMAIN OPEN FOR INSPECTION OF COPPER SERVICE LATERALS. ANY COPPER SERVICE LATERAL KINKED, BENT OR OTHERWISE DAMAGED MUST BE REPLACED FROM THE MAIN TO THE ANGLE METER STOP.

LVWVD EASEMENT NOTE


ALL LVWVD EASEMENTS FOR METER, RPPA, AND FIRE HYDRANT LOCATIONS WILL BE CLEAR OF OBSTRUCTIONS (2% TO MAX 38 SLOPE) AND THE METER, RPPA, AND FIRE HYDRANT WILL BE INSTALLED WITHIN A LEVEL SURFACE PER UDACS PLATES 4, 8, & 40.

FAST

Call before you Dig
UnderGround
1-702-432-5300
FREEWAY & ARTERIAL SYSTEM OF TRANSPORTATION (F.A.S.T.)

AVOID HITTING OVERHEAD POWER LINES. IT'S COSTLY.
CALL BEFORE YOU DIG OVERHEAD
1-702-227-2929

Call before you Dig
AVOID CUTTING UNDERGROUND UTILITY LINES. IT'S COSTLY.
Call
811
OR
1-800-227-2600

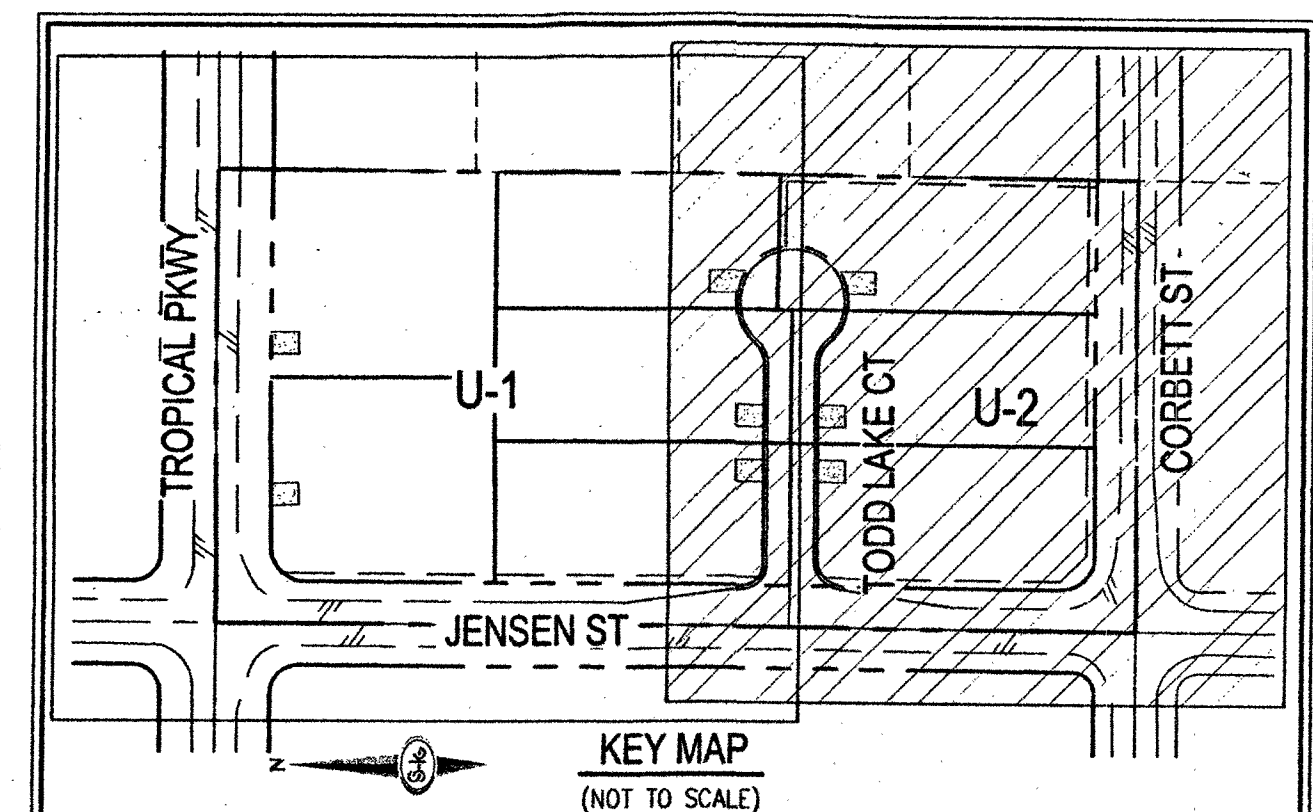

KEY MAP

(NOT TO SCALE)

UTILITY LEGEND

- MATCHLINE
- BOUNDARY LINE
- STREET CENTERLINE
- RIGHT-OF-WAY
- EASEMENT LINE
- PROPERTY LINE
- PROPOSED CURB AND GUTTER WITH PRIVATE ROADWAY EASEMENT AT BACK OF CURB
- EXISTING CURB AND GUTTER
- WATER PIPE FITTING
- WATER GATE VALVE
- FIRE HYDRANT
- REFLECTIVE RAISED PAVEMENT MARKERS
- SANITARY SEWER MANHOLE
- SANITARY SEWER FLOW DIRECTION
- WATER POINT OF CONNECTION
- SEWER POINT OF CONNECTION
- INSTALL PRESSURE REDUCING VALVE

SEE SHEET C-3 FOR QUANTITIES AND ABBREVIATIONS

CLARK COUNTY FIRE DEPT. APPROVAL

APPROVAL OF THESE PLANS NOT BE CONSIDERED TO BE A PERMIT FOR OR AN APPROVAL OF ANY VIOLATION OF ANY OF THE PROVISIONS OF THE STATE OR COUNTY LAWS. FIRE FLOW 2,250 GPM AT 20 P.S.I. RESIDUAL.

APPROVED FOR CONSTRUCTION

AS VEGAS VALLEY WATER DISTRICT ENGINEERING SERVICES
PROJECT NO. 135041 FIRST APPROVED DATE: 3-7-19
LVWVD APPROVED FIRE FLOW 2,250 GPM AT 20 PSI RESIDUAL
MAXIMUM AVAILABLE FIRE SPRINKLER FLOW N/A GPM

BASIS OF BEARING

NORTH 00°39'20" EAST, BEING THE BEARING ON THE EAST LINE OF THE SOUTHWEST QUARTER (SW1/4) OF SECTION 30, TOWNSHIP 19 SOUTH, RANGE 50 EAST, N.M.L., CLARK COUNTY, NEVADA, AS SHOWN BY MAP THEREOF IN FILE 122, PAGE 7A OF PARCEL MAPS IN THE CLARK COUNTY RECORDER'S OFFICE, NEVADA.

BENCHMARK

BENCHMARK NUMBER: 1030 3056
RIVET AND SQUARE ALUMINUM PLATE IN A 4' X 4' CONCRETE ELECTRIC PAD AT 9620 EL CAMPO GRANDE AVENUE, 30' NORTH AND 170' WEST OF GRAND CANYON DRIVE AND EL CAMPO GRANDE AVENUE.
ELEVATION = 2655.329 FEET, 809.346 METERS
N.A.V.D. 88 DATUM
PER THE CLARK COUNTY VERTICAL CONTROL V.2003

FOR ALL DRY UTILITY CROSSINGS

- MAINTAIN MINIMUM 12" VERTICAL SEPARATION AT ALL POINTS OF CROSSING
- MAINTAIN MINIMUM 3' PARALLEL SEPARATION
- ANY EXCAVATION AT BACK OF CURB MUST REMAIN OPEN FOR INSPECTION OF COPPER SERVICE LATERALS. ANY COPPER SERVICE LATERAL KINKED, BENT OR OTHERWISE DAMAGED MUST BE REPLACED FROM THE MAIN TO THE ANGLE METER STOP.

LVWVD EASEMENT NOTE

ALL LVWVD EASEMENTS FOR METER, RPPA, AND FIRE HYDRANT LOCATIONS WILL BE CLEAR OF OBSTRUCTIONS (2% TO MAX 38 SLOPE) AND THE METER, RPPA, AND FIRE HYDRANT WILL BE INSTALLED WITHIN A LEVEL SURFACE PER UDACS PLATES 4, 8, & 40.

SLATER HANFAN GROUP
a Westwood team
5740 S. ARVILLE STREET #216, LAS VEGAS, NV 89118
PHONE (702) 284-5300
FAX (702) 284-5399

CLARK COUNTY, NEVADA

DATE: 02/07/19

DRAWN BY: EMH

DESIGNER: EMH

CHECKED: KMB

PROJECT NO. PIN1801

U-2

SHEET 11 OF 21

PW18-17991

L18-02835

307V1158

U-2

SHEET 11 OF 21

PW18-17991

L18-02835

307V1158

U-2

SHEET 11 OF 21

PW18-17991

L18-02835

307V1158

U-2

SHEET 11 OF 21

PW18-17991

L18-02835

307V1158

U-2

SHEET 11 OF 21

PW18-17991

L18-02835

307V1158

U-2

SHEET 11 OF 21

PW18-17991

L18-02835

307V1158

U-2

SHEET 11 OF 21

PW18-17991

L18-02835

307V1158

U-2

SHEET 11 OF 21

PW18-17991

L18-02835

307V1158

U-2

SHEET 11 OF 21

PW18-17991

L18-02835

307V1158

U-2

SHEET 11 OF 21

PW18-17991

L18-02835

307V1158

U-2

SHEET 11 OF 21

PW18-17991

L18-02835

307V1158

U-2

SHEET 11 OF 21

PW18-17991

L18-02835

307V1158

U-2

SHEET 11 OF 21

PW18-17991

L18-02835

307V1158

U-2

SHEET 11 OF 21

PW18-17991

L18-02835

307V1158

U-2

SHEET 11 OF 21

PW18-17991

L18-02835

307V1158