

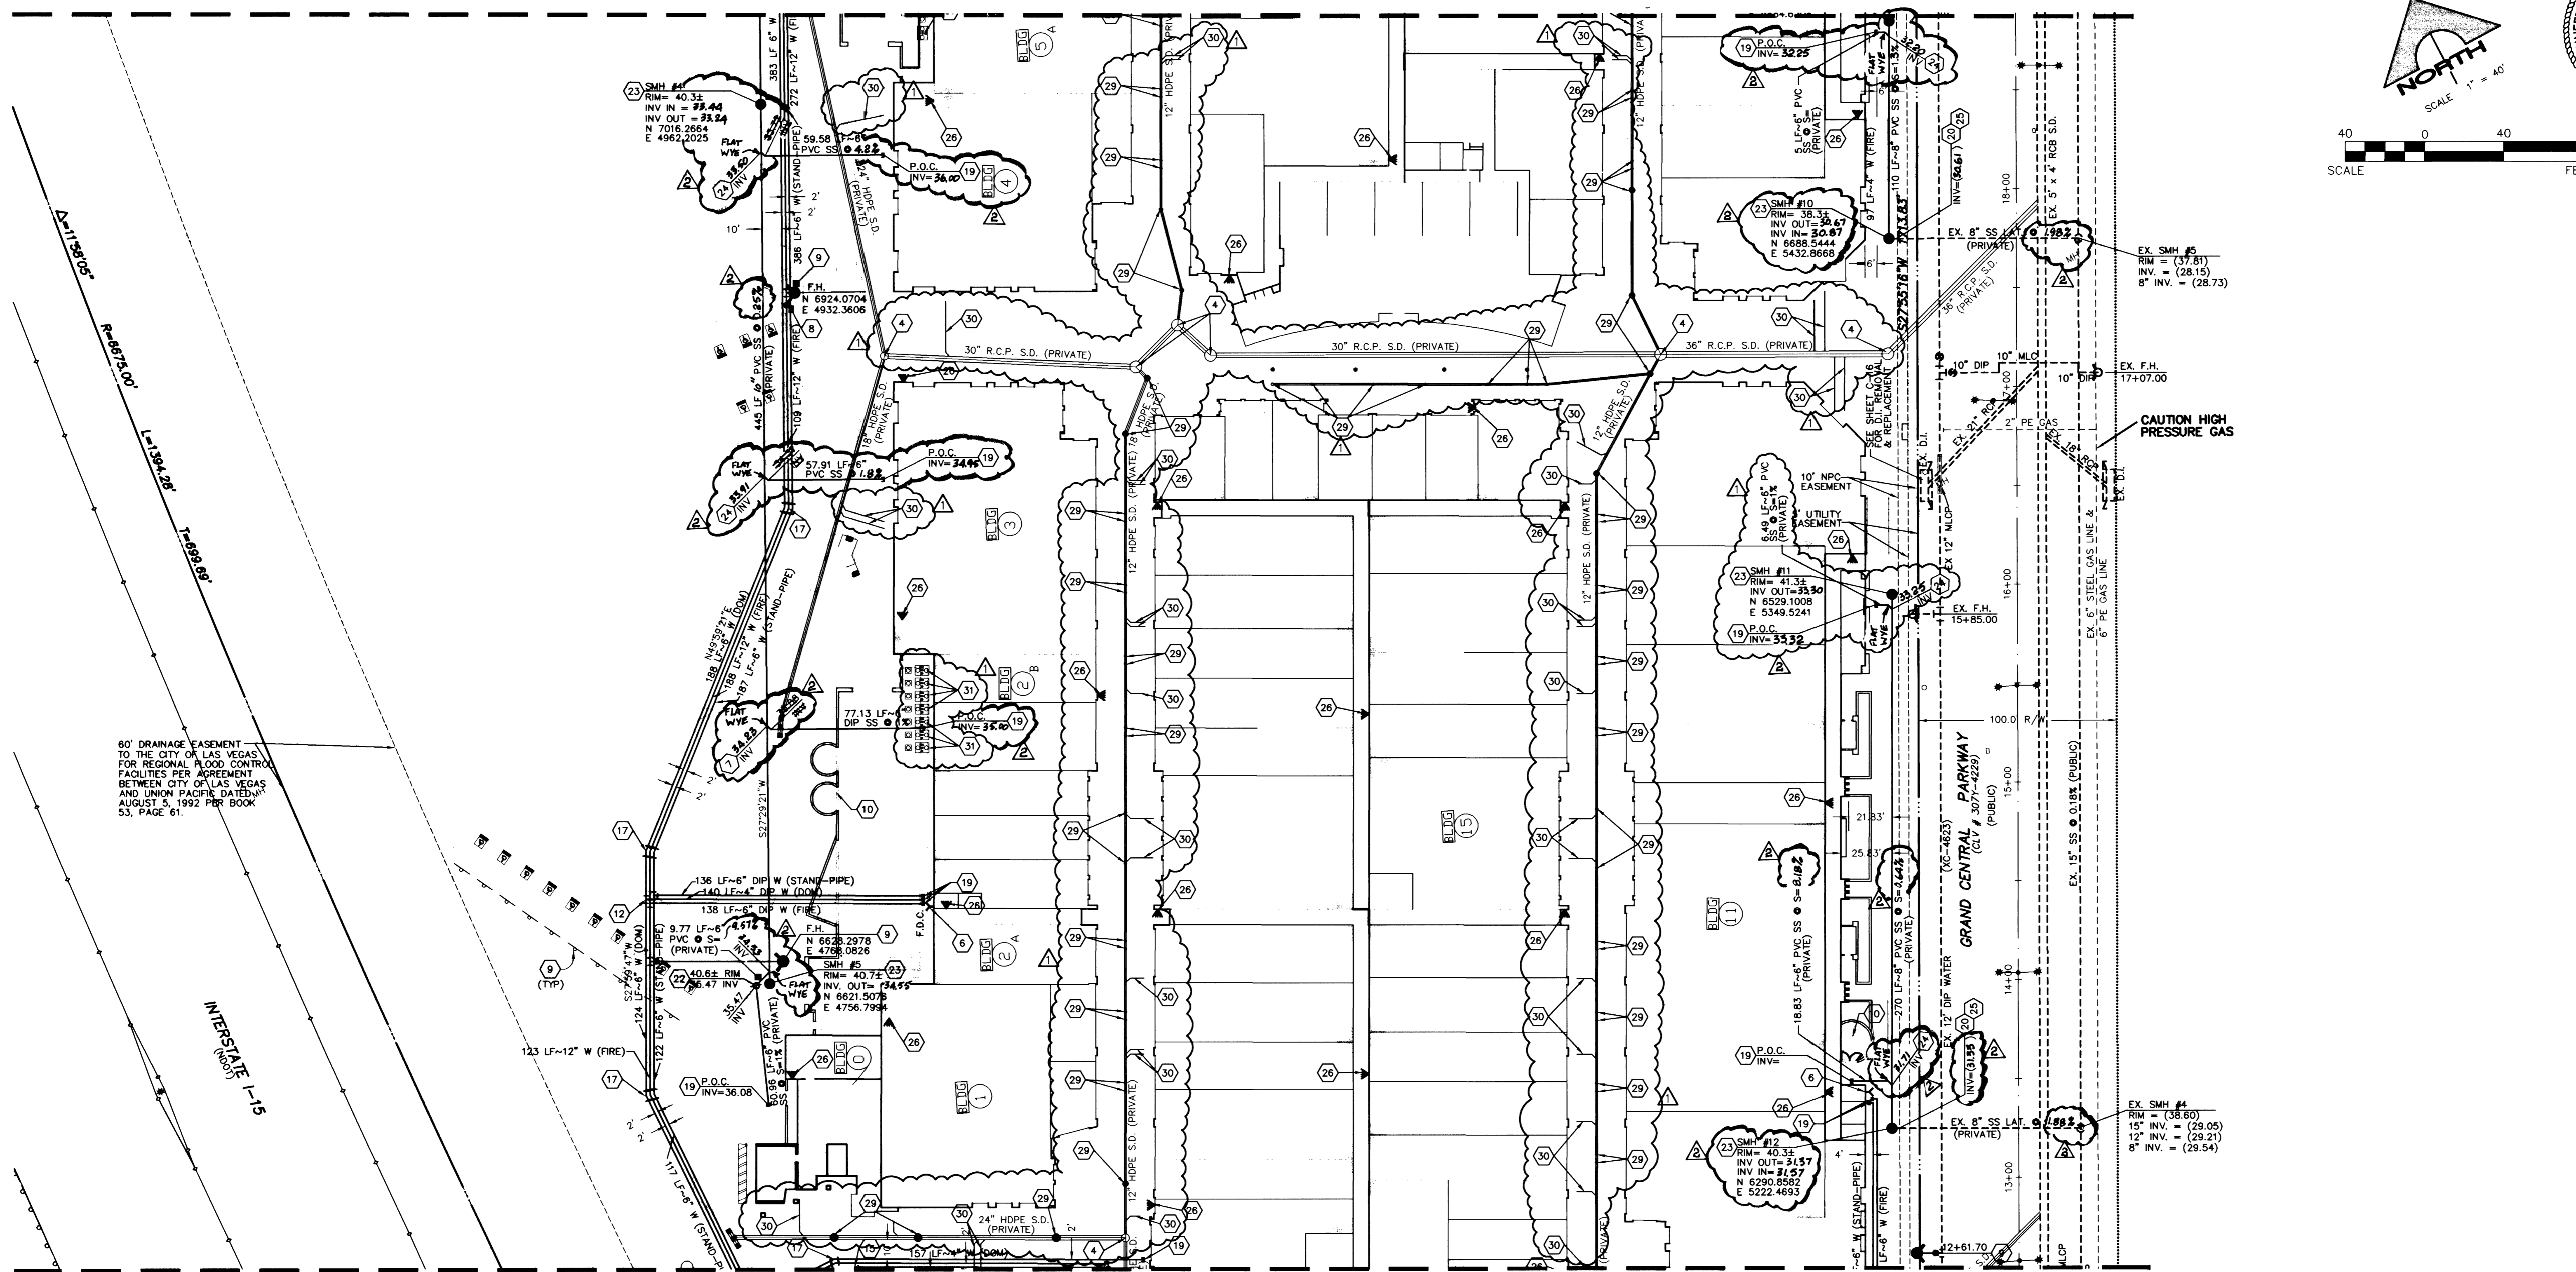


SEE SHEET C-10

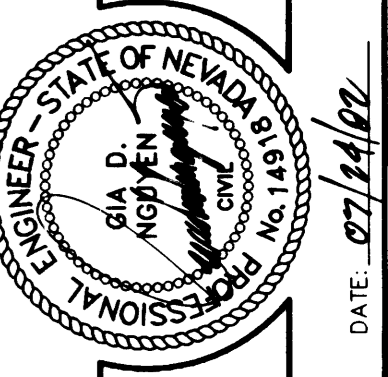

SEE SHEET C-8

60' DRAINAGE EASEMENT TO THE CITY OF LAS VEGAS FOR REGIONAL FLOOD CONTROL FACILITIES PER AGREEMENT BETWEEN CITY OF LAS VEGAS AND UNION PACIFIC DATED AUGUST 5, 1992 PRR BOOK 53, PAGE 61.

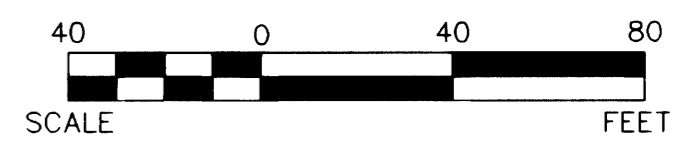

REV.	DATE	DESCRIPTION
1	07/14/02	ISSUE FOR PERMITS
2	07/14/02	ISSUE FOR PERMITS
3	07/14/02	ISSUE FOR PERMITS
4	07/14/02	ISSUE FOR PERMITS
5	07/14/02	ISSUE FOR PERMITS
6	07/14/02	ISSUE FOR PERMITS
7	07/14/02	ISSUE FOR PERMITS
8	07/14/02	ISSUE FOR PERMITS
9	07/14/02	ISSUE FOR PERMITS
10	07/14/02	ISSUE FOR PERMITS
11	07/14/02	ISSUE FOR PERMITS
12	07/14/02	ISSUE FOR PERMITS
13	07/14/02	ISSUE FOR PERMITS
14	07/14/02	ISSUE FOR PERMITS
15	07/14/02	ISSUE FOR PERMITS
16	07/14/02	ISSUE FOR PERMITS
17	07/14/02	ISSUE FOR PERMITS
18	07/14/02	ISSUE FOR PERMITS
19	07/14/02	ISSUE FOR PERMITS
20	07/14/02	ISSUE FOR PERMITS
21	07/14/02	ISSUE FOR PERMITS
22	07/14/02	ISSUE FOR PERMITS
23	07/14/02	ISSUE FOR PERMITS
24	07/14/02	ISSUE FOR PERMITS
25	07/14/02	ISSUE FOR PERMITS
26	07/14/02	ISSUE FOR PERMITS
27	07/14/02	ISSUE FOR PERMITS
28	07/14/02	ISSUE FOR PERMITS
29	07/14/02	ISSUE FOR PERMITS
30	07/14/02	ISSUE FOR PERMITS
31	07/14/02	ISSUE FOR PERMITS

DESIGN: G.C. WALLACE, INC.
 DRAWN: G.C. WALLACE, INC.
 CHECK: G.C. WALLACE, INC.
 ISSUE DATE: 07/14/02
 PLOT DATE: 07/24/02
 PLOT TIME: 13:14:45
 G.C. WALLACE, INC.
 ENGINEERS/PLANNERS/SURVEYORS
 1555 SOUTH PARKWAY BLDG. LAS VEGAS, NEVADA 89146
 TELEPHONE: (702) 804-2000 FAX: (702) 804-2299
 G. 1789-001 (Imprev) 789-009.dwg


43084 44528

APPROVED FOR CONSTRUCTION

Robert Bell
 CITY OF LAS VEGAS FIRE DEPART.
 DATE: 7-24-02

NOTICE

G.C. WALLACE, INC. ASSUME NO RESPONSIBILITY FOR EXISTING UTILITY SHOWN OR NOT SHOWN. THE UTILITIES SHOWN ON THIS DRAWING HAVE BEEN PLOTTED FROM RECORD INFORMATION AND ARE FOR THE CONVENIENCE OF THE CONTRACTOR ONLY. IT IS THE CONTRACTOR'S RESPONSIBILITY TO FIELD VERIFY THE LOCATION AND DEPTH OF ALL RELEVANT UTILITIES PRIOR TO COMMENCEMENT OF CONSTRUCTION. IF A CONFLICT OR DISCREPANCY IS DISCOVERED, THE CONTRACTOR SHALL NOTIFY THE ENGINEER IN WRITING IMMEDIATELY.

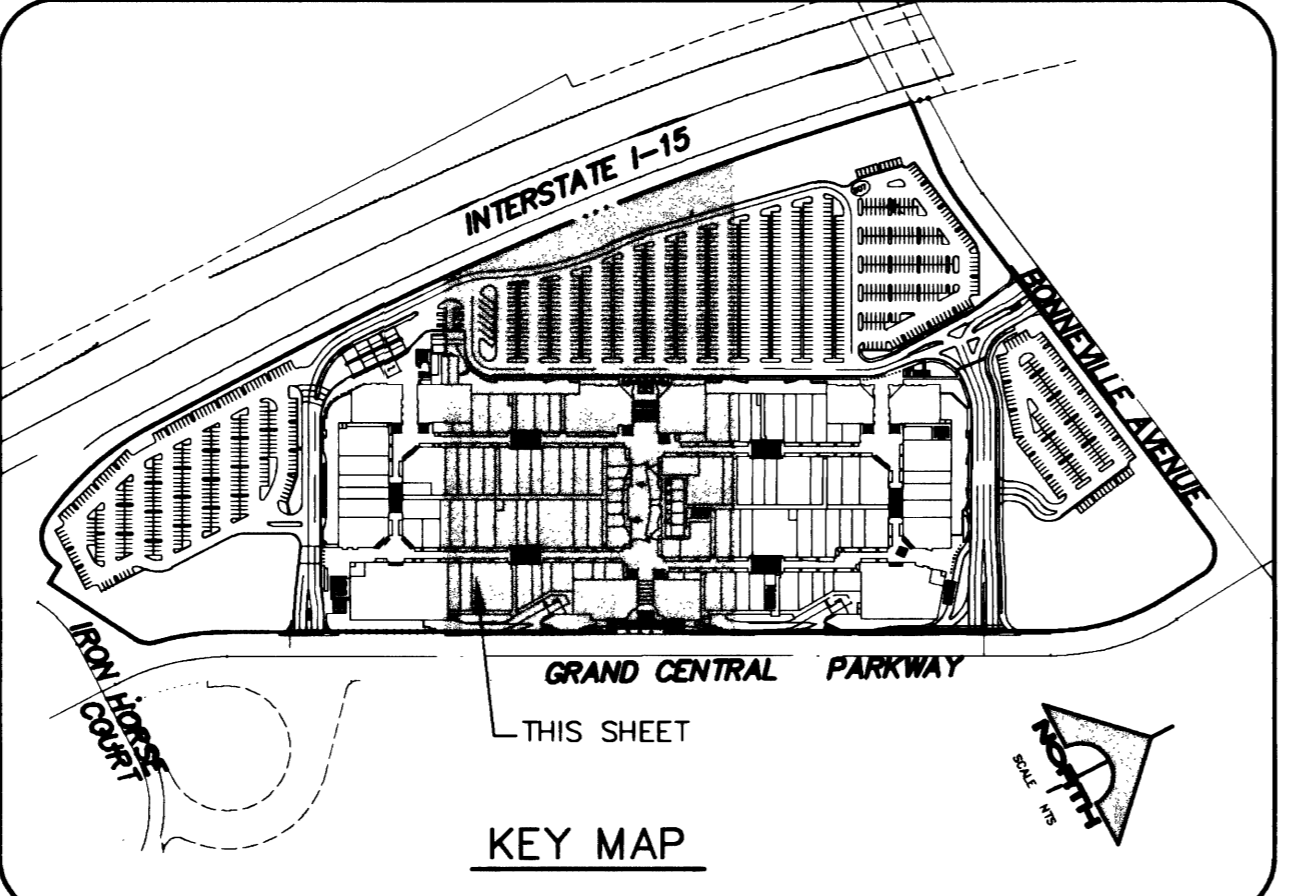

- UTILITY CONSTRUCTION NOTES**
1. INSTALL 12"x10" MECHANICAL JOINT TAPPING TEE W/10" TAPPING VALVE.
 2. INSTALL 10" FEBCO MODEL 876V DOUBLE CHECK DETECTOR ASSEMBLY PER UDACS PLATE NO. 20B.
 3. INSTALL 2-2" WATER METER W/ 2" RPPA PER UDACS PLATES 1D & 11A.
 4. STORM DRAIN MANHOLE
 5. INSTALL 10"x12" REDUCER/INCREASER.
 6. FIRE DEPT. CONNECTION - SEE ARCHITECTURAL/FIRE PROTECTION PLANS FOR EXACT LOCATION.
 7. INSTALL FLAT SEWER WYE PER SANITATION DISTRICT STANDARDS.
 8. INSTALL GATE VALVE. SEE PLAN FOR SIZE.
 9. INSTALL FIRE HYDRANT ASSEMBLY PER UDACS PLATE NO. 7.
 10. TRANSFORMER PAD - SEE ARCHITECTURAL/ELECTRICAL PLANS FOR EXACT LOCATION.
 11. INSTALL 10"x6" REDUCER/INCREASER.
 12. INSTALL TEE. SEE PLAN FOR SIZE.
 13. INSTALL 6" x 4" REDUCER.
 14. INSTALL 12"x6" TAPPING TEE W/6" TAPPING VALVE.
 15. INSTALL 90° BEND. SEE PLAN FOR SIZE.
 16. INSTALL 45° BEND. SEE PLAN FOR SIZE.
 17. INSTALL 22-2" BEND. SEE PLAN FOR SIZE.
 18. INSTALL 11-1/4" BEND. SEE PLAN FOR SIZE.
 19. SEE PLUMBING PLANS FOR CONTINUATION.
 20. REMOVE EX. PLUG AND CONNECT TO EXISTING SEWER.
 21. INSTALL CHECK VALVE.
 22. INSTALL SEWER CLEAN OUT PER SANITATION DISTRICT STANDARDS. INSTALL ALL CLEANOUTS IN PAVED AREAS WITH VALVE BOXES, TRAFFIC BEARING LIDS AND CONCRETE COLLARS.
 23. INSTALL 48" DIA. TYPE I SEWER MANHOLE PER SANITATION DISTRICT STANDARDS.
 24. INSTALL SEWER WYE PER SANITATION DISTRICT STANDARD.
 25. CONTRACTOR TO FIELD VERIFY DEPTH AND LOCATION OF EXISTING UTILITIES PRIOR TO CONSTRUCTION.
 26. STAND PIPE - SEE ARCHITECTURAL/FIRE PROTECTION PLAN FOR EXACT LOCATION AND DETAIL.
 27. INSTALL 6" CROSS.
 28. INSTALL 12" x 6" REDUCER
 29. STORM DRAIN GRATE INLET
 30. ROOF DRAIN LATERAL - SEE PLUMBING PLANS
 31. GREASE TRAP - SEE PLUMBING PLANS FOR DETAILS

NOTE:

ALL ON-SITE FIRE PIPE CANNOT BE LESS THAN CLASS 200, AND THE MINIMUM PIPE WORKING PRESSURE LESS THAN 200 PSI.

APPROVED FOR CONSTRUCTION

Robert Bell
 LAS VEGAS VALLEY WATER DISTRICT
 8-9-02



Avoid cutting underground utility lines. It's costly.

Call before you Dig.

1-800-227-2600
 UNDERGROUND SERVICE (USA)

LAS VEGAS PREMIUM OUTLET
 CHELSEA PROPERTY GROUP
 SHEET
C-9
 107-V-3573
 9 OF 17 SHITS
 REPEAT