



- |                           |   |                          |                                 |                          |  |
|---------------------------|---|--------------------------|---------------------------------|--------------------------|--|
| "C" 112+52<br>"L1" 121+23 | REMOVE CURB, GUTTER AND PLANTMIX PAVING LT.         | "C" 113+18<br>"C" 113+69 | CONSTRUCT LANDSCAPE PLANTER LT. | "C" 114+13<br>"C" 114+97 | RELOCATE WATER SERVICE LT.               |
| "C" 112+86<br>"C" 113+18  | CONSTRUCT PLANTMIX BITUMINOUS DRIVEWAY APPROACH LT. | "C" 114+01<br>"C" 114+58 | CONSTRUCT LANDSCAPE PLANTER LT. | "C" 115+14               | RELOCATE FIRE HYDRANT TO "C" 115+01± LT. |
| "C" 113+69<br>"C" 114+01  | CONSTRUCT PLANTMIX BITUMINOUS DRIVEWAY APPROACH LT. | "C" 114+90<br>"C" 115+25 | CONSTRUCT LANDSCAPE PLANTER LT. |                          |  |
| "C" 114+58<br>"C" 114+90  | CONSTRUCT PLANTMIX BITUMINOUS DRIVEWAY APPROACH LT. |                          |                                 |                          |  |

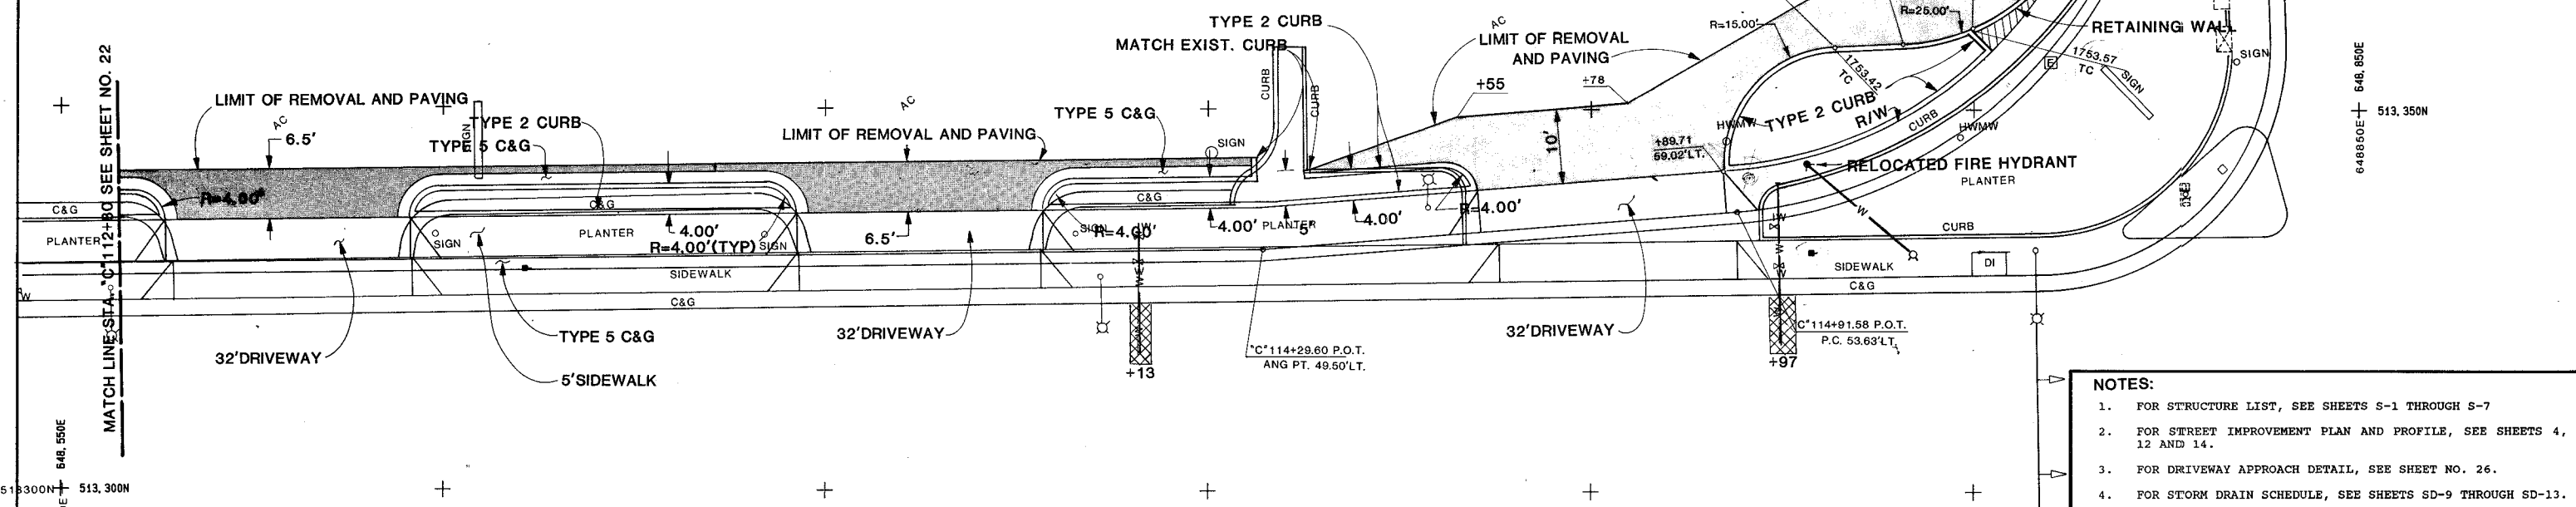

- NOTES:**
- FOR STRUCTURE LIST, SEE SHEETS 5-1 THROUGH 5-7
  - FOR STREET IMPROVEMENT PLAN AND PROFILE, SEE SHEETS 4, 12 AND 14.
  - FOR DRIVEWAY APPROACH DETAIL, SEE SHEET NO. 26.
  - FOR STORM DRAIN SCHEDULE, SEE SHEETS SD-9 THROUGH SD-13.
  - FOR LANDSCAPE PLANTER DETAIL, SEE SHEET NO. 26.
  - FOR WATER SYSTEM STRUCTURE LIST, SEE SHEET NO. W-11.
- HMMW HAZARDOUS WASTE MONITORING WELL  
 PLANTMIX BITUMINOUS PAVING - MISC. AREA  
 P.C.C. PAVING - 4" SIDEWALK  
 PLANTMIX PATCH - SEE DETAIL "C" ON SHEET NO. 2A FOR DETAILS

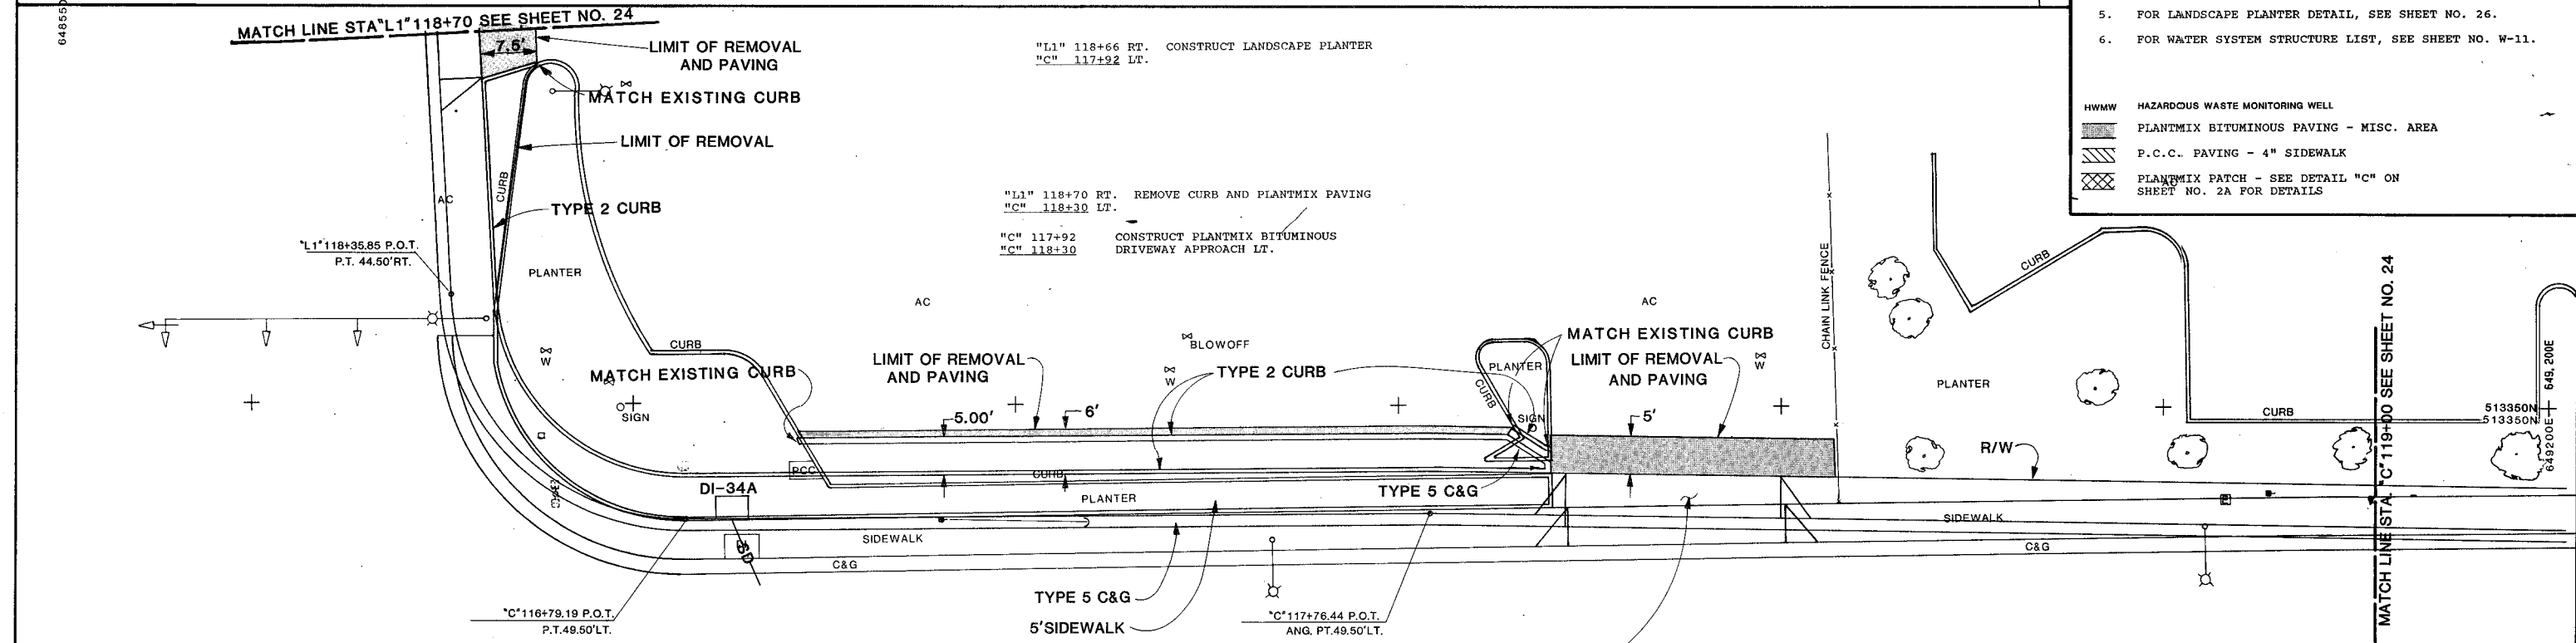

	RENO: SPARKS, NEVADA LAS VEGAS, NEVADA PHOENIX, ARIZONA	STATE OF NEVADA DEPARTMENT OF TRANSPORTATION
	JOB NO. 990-02-2	10713989
	DESIGNED G.S.	OFFSITE DETAILS
	DRAWN C.H.W.	E. CHARLESTON BLVD.
	CHECKED <i>[Signature]</i>	
DATE 3-30-90		

66933

513300N 513,300N  
648900E 648,900E