
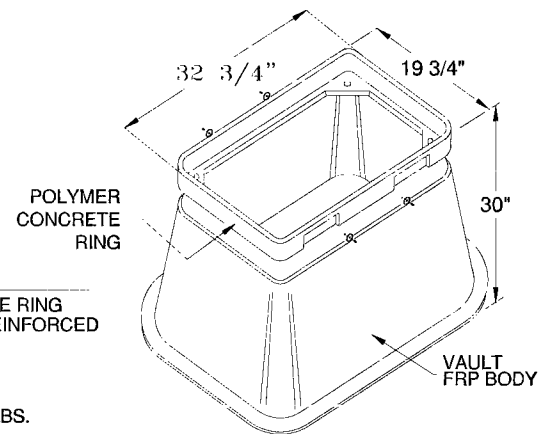


- COVER FEATURES:
- * PW - 10,400 LBS. WHEEL LOAD ON 10" X 10" PLATE.
 - * APPROX. WT. = 72 LBS.
 - * POLYMER CONCRETE
 - * ONE PIECE COVER
 - * FOUR BOLT DOWN
 - * COLOR: CONCRETE GREY
 - * NON - SKID SURFACE

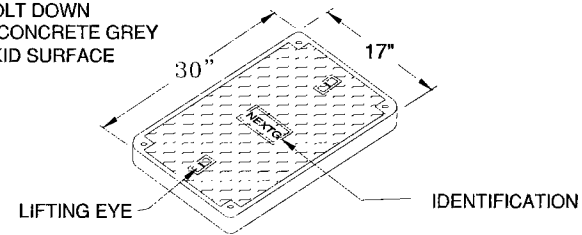


VAULT FEATURES:

- * POLYMER CONCRETE RING AND FIBERGLASS REINFORCED POLYMER BODY
- * COLOR OF RING: CONCRETE GREY
- * APPROX. WT. = 123 LBS.

SCALE: 17" X 30" CONNECTOR VAULT
N.T.S.


A

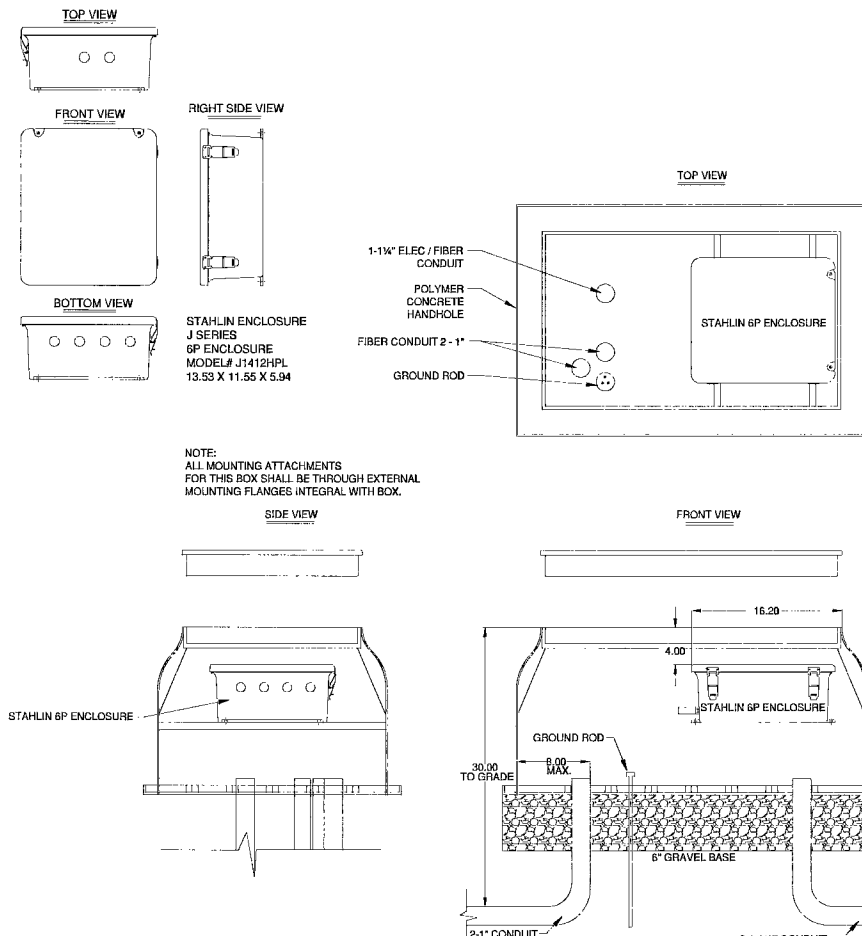

NOTE:
ALL MOUNTING ATTACHMENTS
FOR THIS BOX SHALL BE THROUGH EXTERNAL
MOUNTING FLANGES INTEGRAL WITH BOX.


SCALE: STAHLIN 6P ENCLOSURE
N.T.S.

B

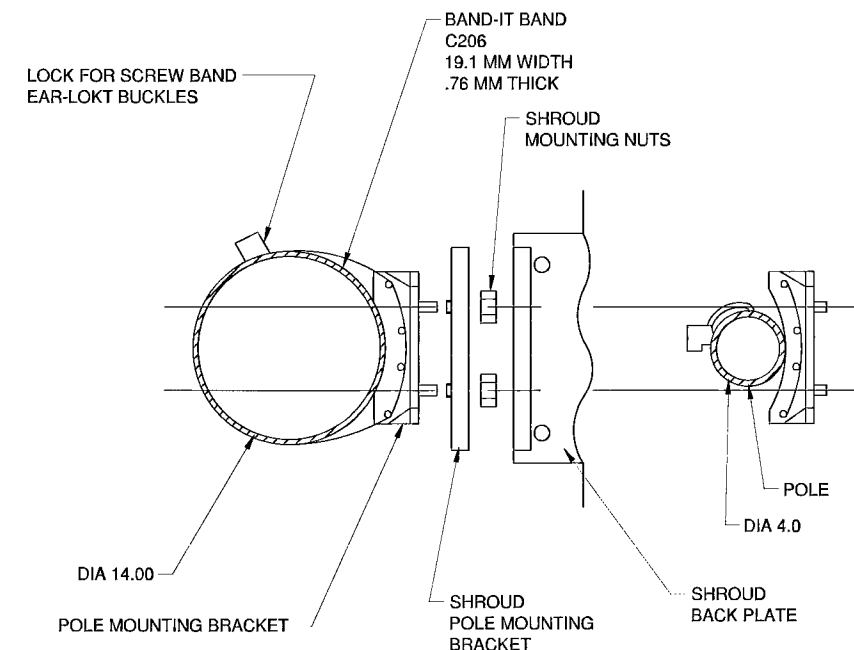

SCALE: POLE MOUNTING
N.T.S.


C

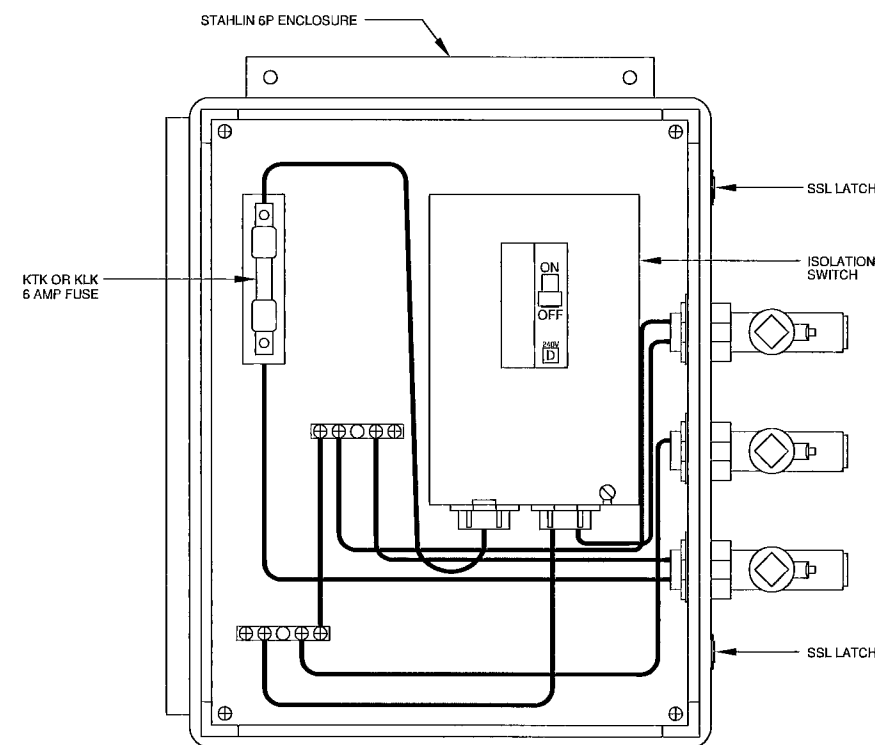

(FOR NEW POLES, STREETLIGHTS & TRAFFIC SIGNALS)

SCALE: POWER SERVICE DISCONNECT FUSE BOX
N.T.S.

D

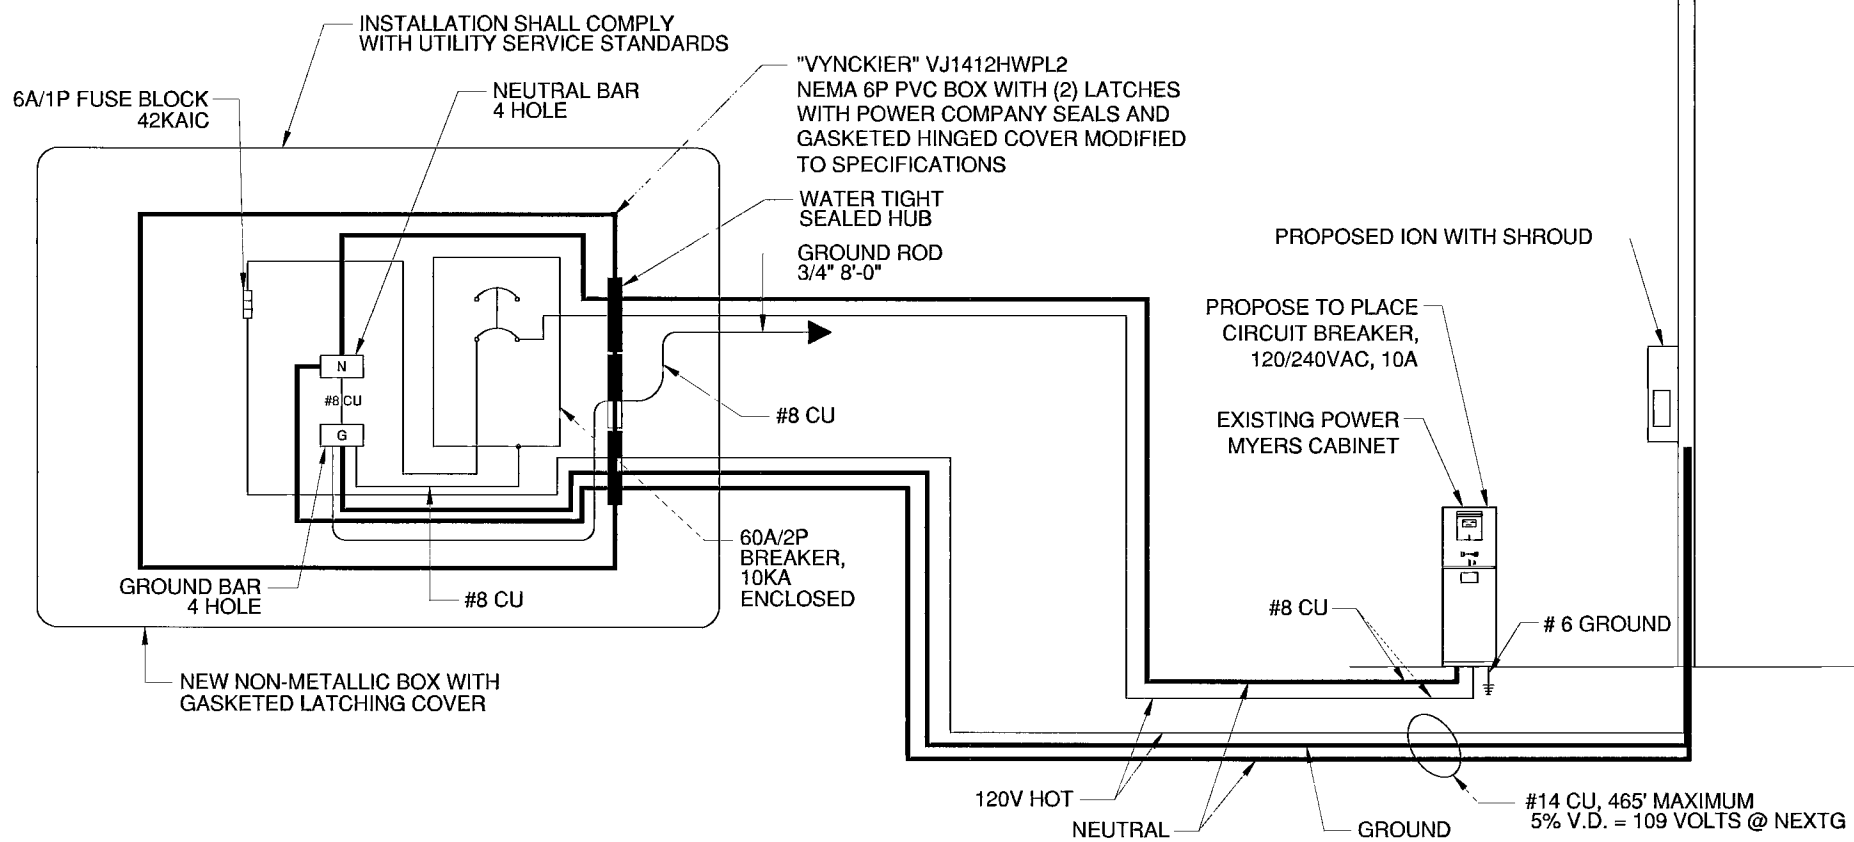

SCALE: POWER SINGLE LINE DIAGRAM
N.T.S.

E

PROJECT INFORMATION:

SPR1009NV-SUMN035
LAS VEGAS, NV 89117

CURRENT ISSUE DATE:

01/19/2010

PERMIT SUBMISSION:

REV. DATE DESCRIPTION BY:

PLANS BY:

REP:

COMMENTS:

H # 36027
PWG # 107V5365-TEL

SHEET TITLE:

TYPICALS 1

SHEET NUMBER: REVISION:

5

5 OF 7