



- COVER FEATURES:
- * PW - 10,400 LBS. WHEEL LOAD ON 10" X 10" PLATE.
 - * APPROX. WT. = 72 LBS.
 - * POLYMER CONCRETE
 - * ONE PIECE COVER
 - * FOUR BOLT DOWN
 - * COLOR: CONCRETE GREY
 - * NON - SKID SURFACE

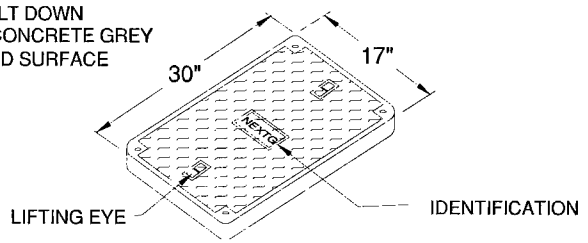


- VAULT FEATURES:
- * POLYMER CONCRETE RING AND FIBERGLASS REINFORCED POLYMER BODY
 - * COLOR OF RING: CONCRETE GREY
 - * APPROX. WT. = 123 LBS.

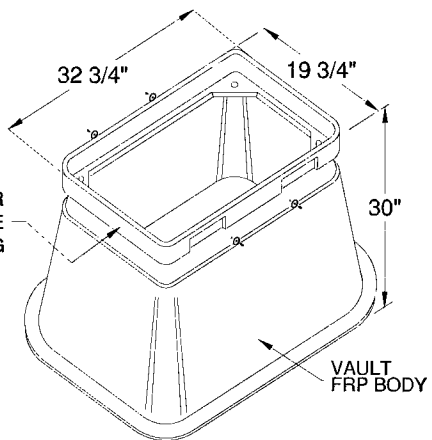


SCALE: N.T.S. 17" X 30" CONNECTOR VAULT

A

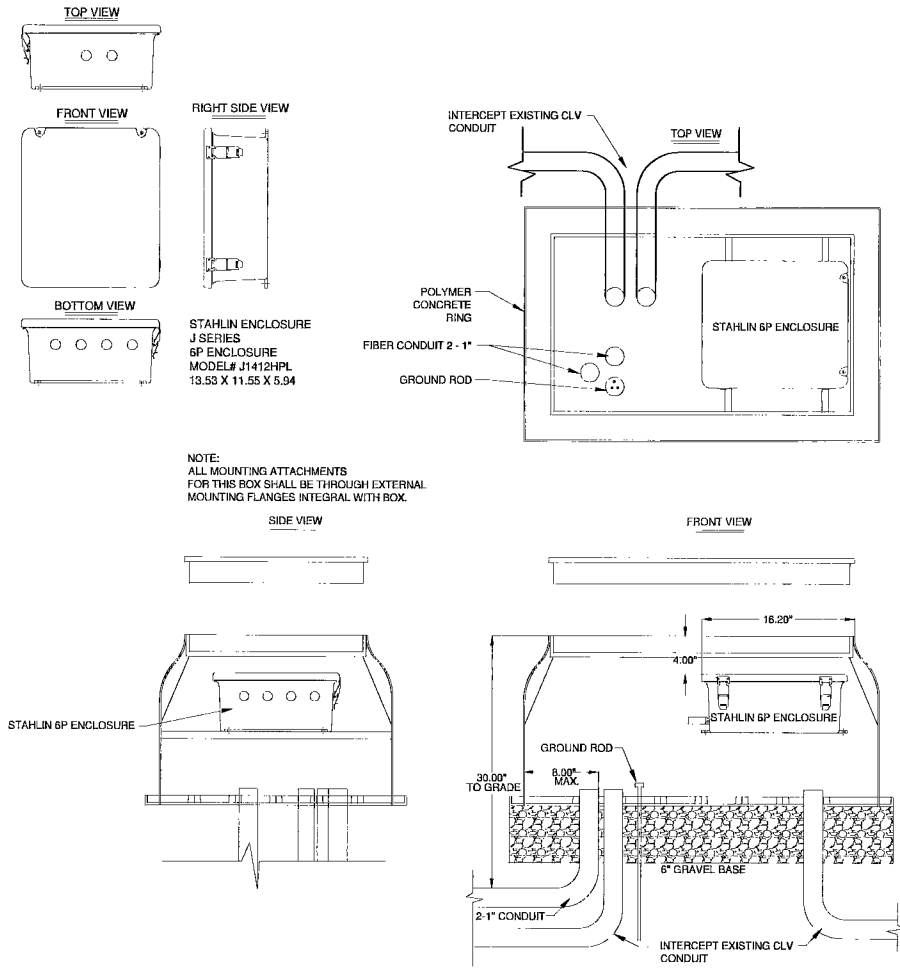


SCALE: N.T.S. STAHLIN 6P ENCLOSURE

B

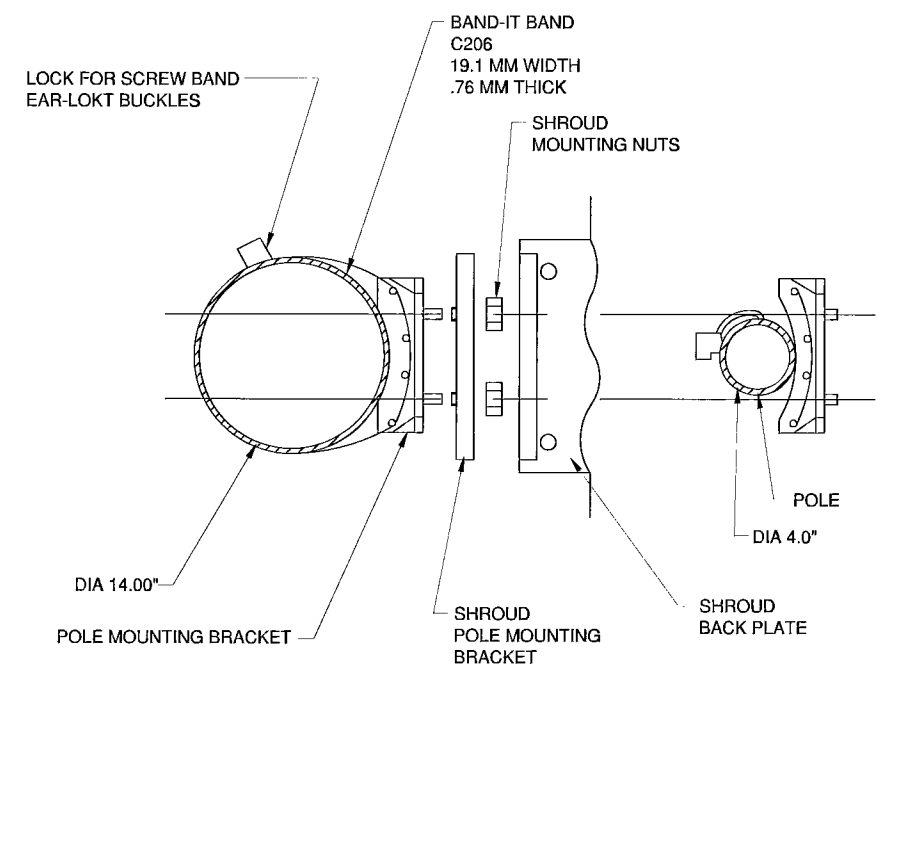


SCALE: N.T.S. POLE MOUNTING PER AMERON STANDARDS

C

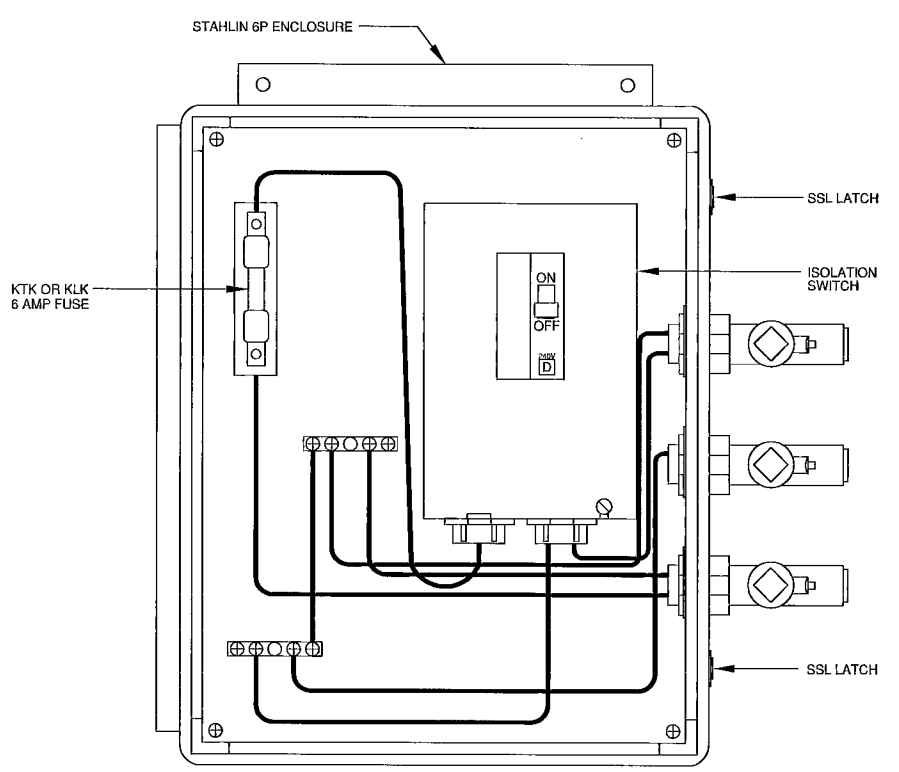

122722 SCALE: N.T.S. POWER SERVICE DISCONNECT FUSE BOX

D

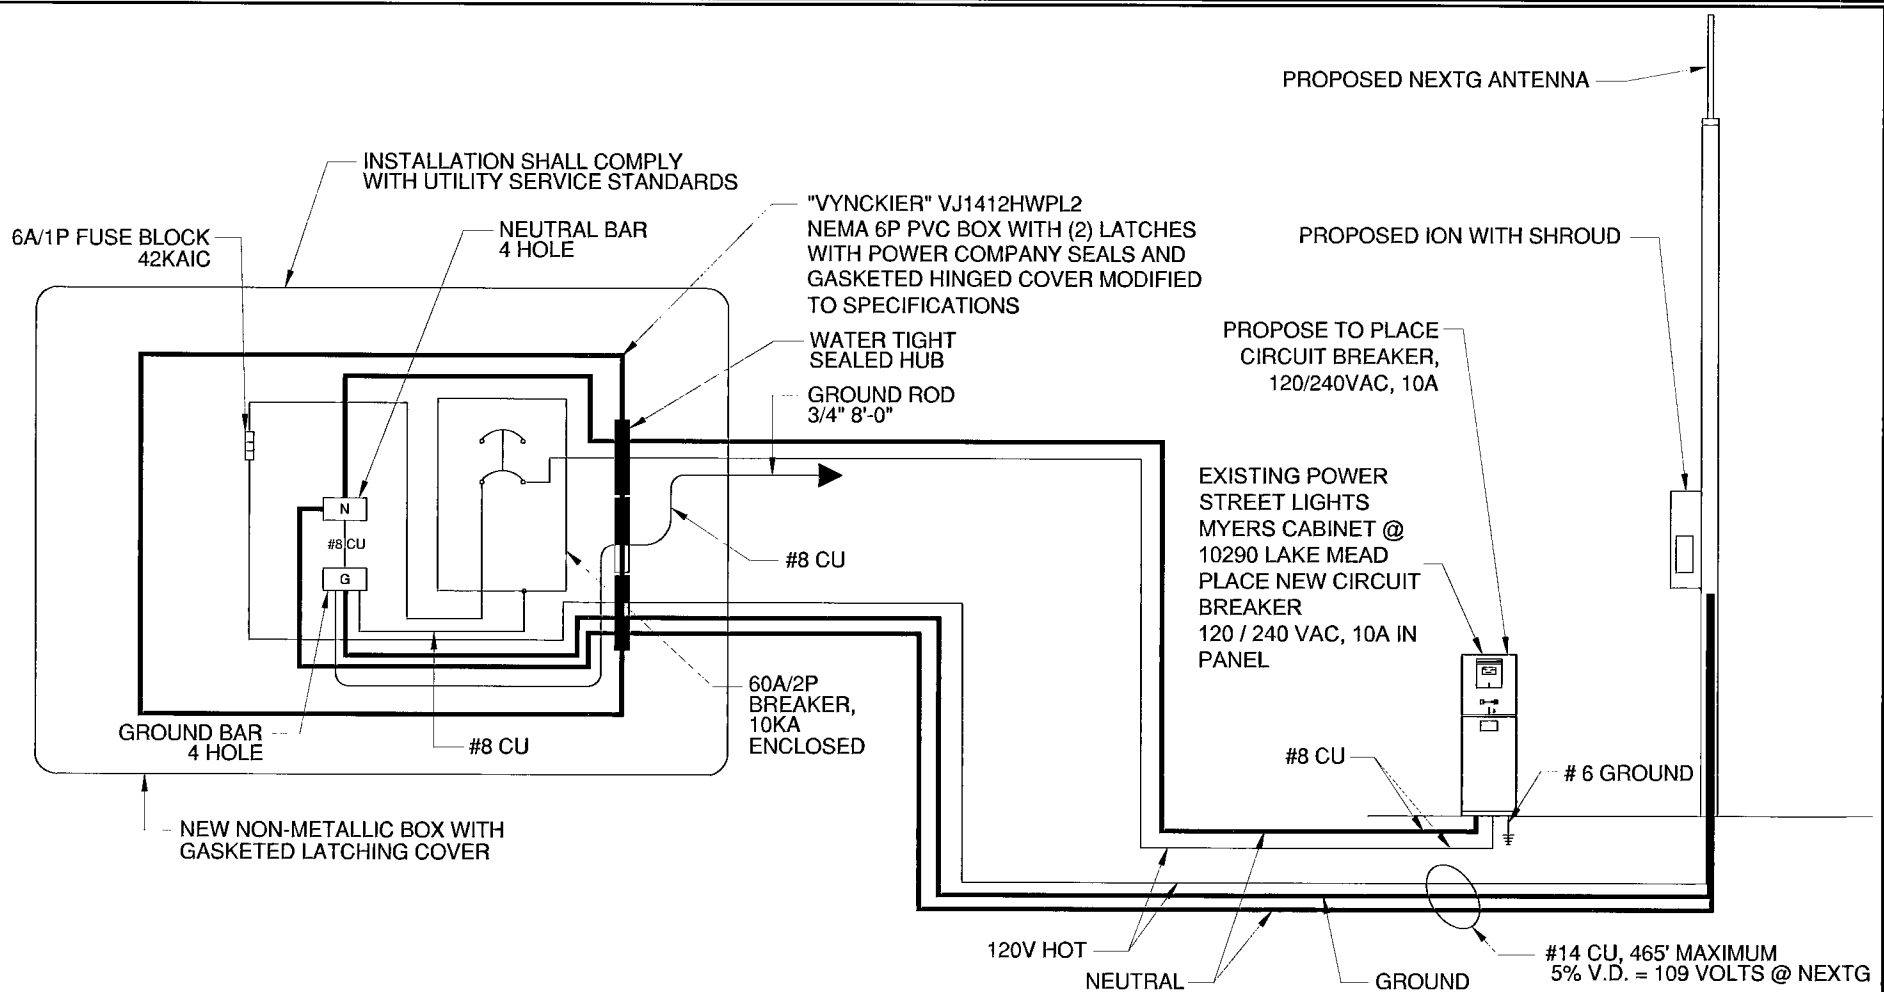

SCALE: N.T.S. POWER SINGLE LINE DIAGRAM

E

PROJECT INFORMATION:

SPR1009NV-SUMN007
LAS VEGAS, NV 89134

CURRENT ISSUE DATE:

03/10/2010

PERMIT SUBMISSION:

REV. DATE DESCRIPTION BY

PLANS BY:

REP:

COMMENTS:

37697
10705427-T&L

SHEET TITLE:

TYPICALS 1

SHEET NUMBER: REVISION: