
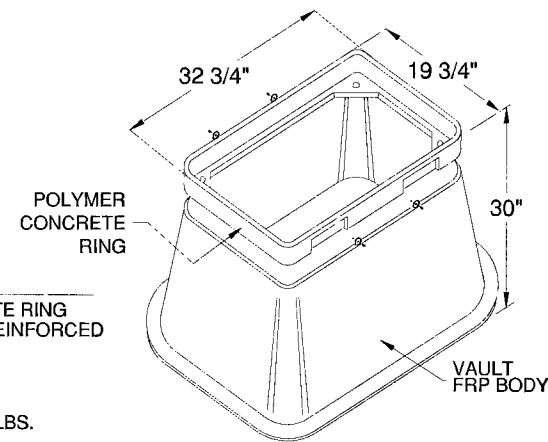



- COVER FEATURES:
- \* PW - 10,400 LBS. WHEEL LOAD ON 10" X 10" PLATE.
  - \* APPROX. WT. = 72 LBS.
  - \* POLYMER CONCRETE
  - \* ONE PIECE COVER
  - \* FOUR BOLT DOWN
  - \* COLOR: CONCRETE GREY
  - \* NON - SKID SURFACE

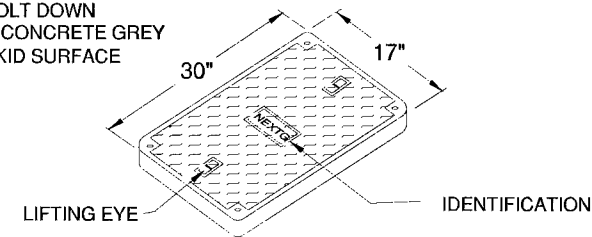

- VAULT FEATURES:
- \* POLYMER CONCRETE RING AND FIBERGLASS REINFORCED POLYMER BODY
  - \* COLOR OF RING: CONCRETE GREY
  - \* APPROX. WT. = 123 LBS.


SCALE: N.T.S. 17" X 30" CONNECTOR VAULT

A

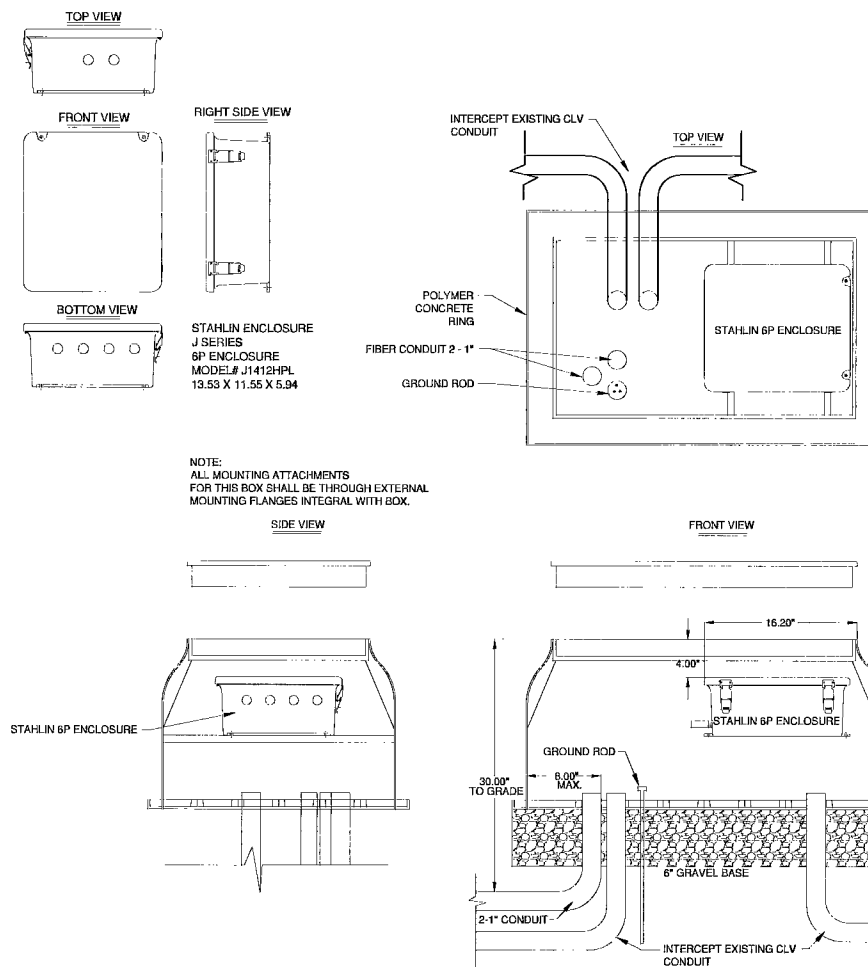


SCALE: N.T.S. STAHLIN 6P ENCLOSURE

B

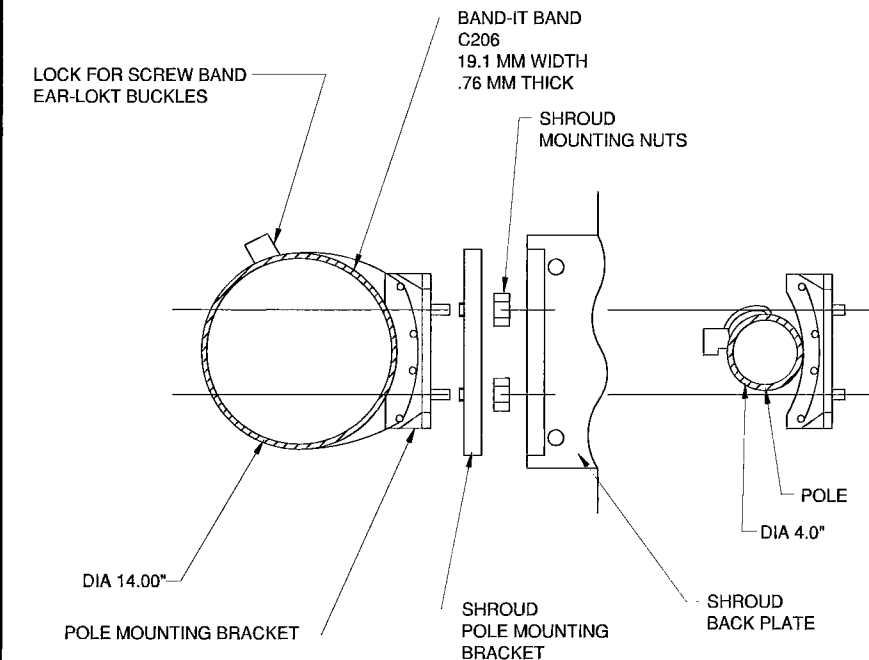

SCALE: N.T.S. POLE MOUNTING PER AMERON STANDARDS


C

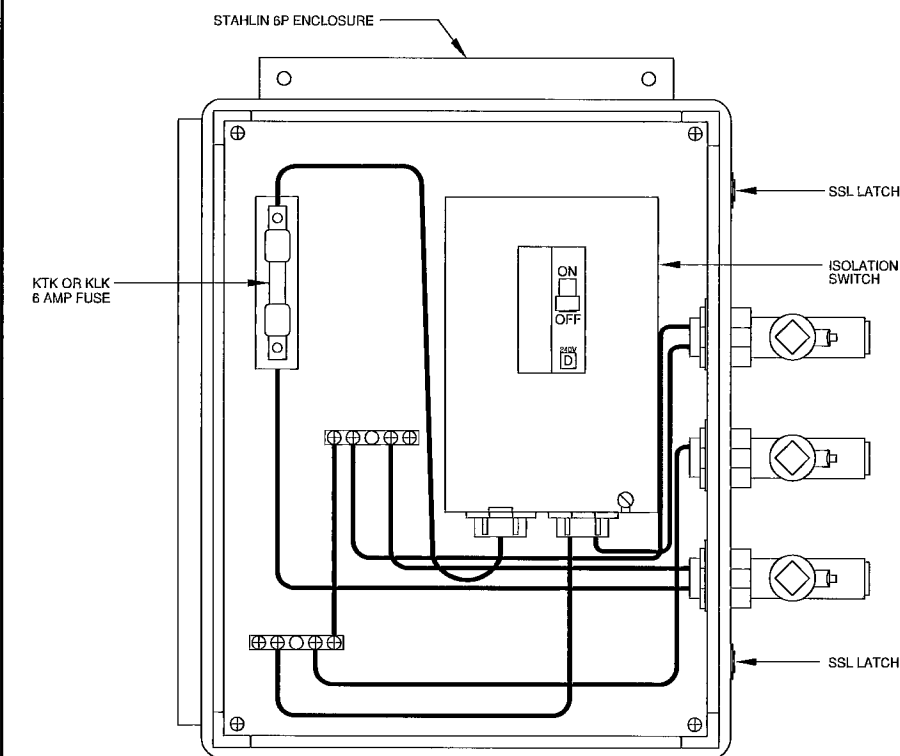

(FOR NEW POLES, STREETLIGHTS & TRAFFIC SIGNALS)

SCALE: N.T.S. POWER SERVICE DISCONNECT FUSE BOX

D

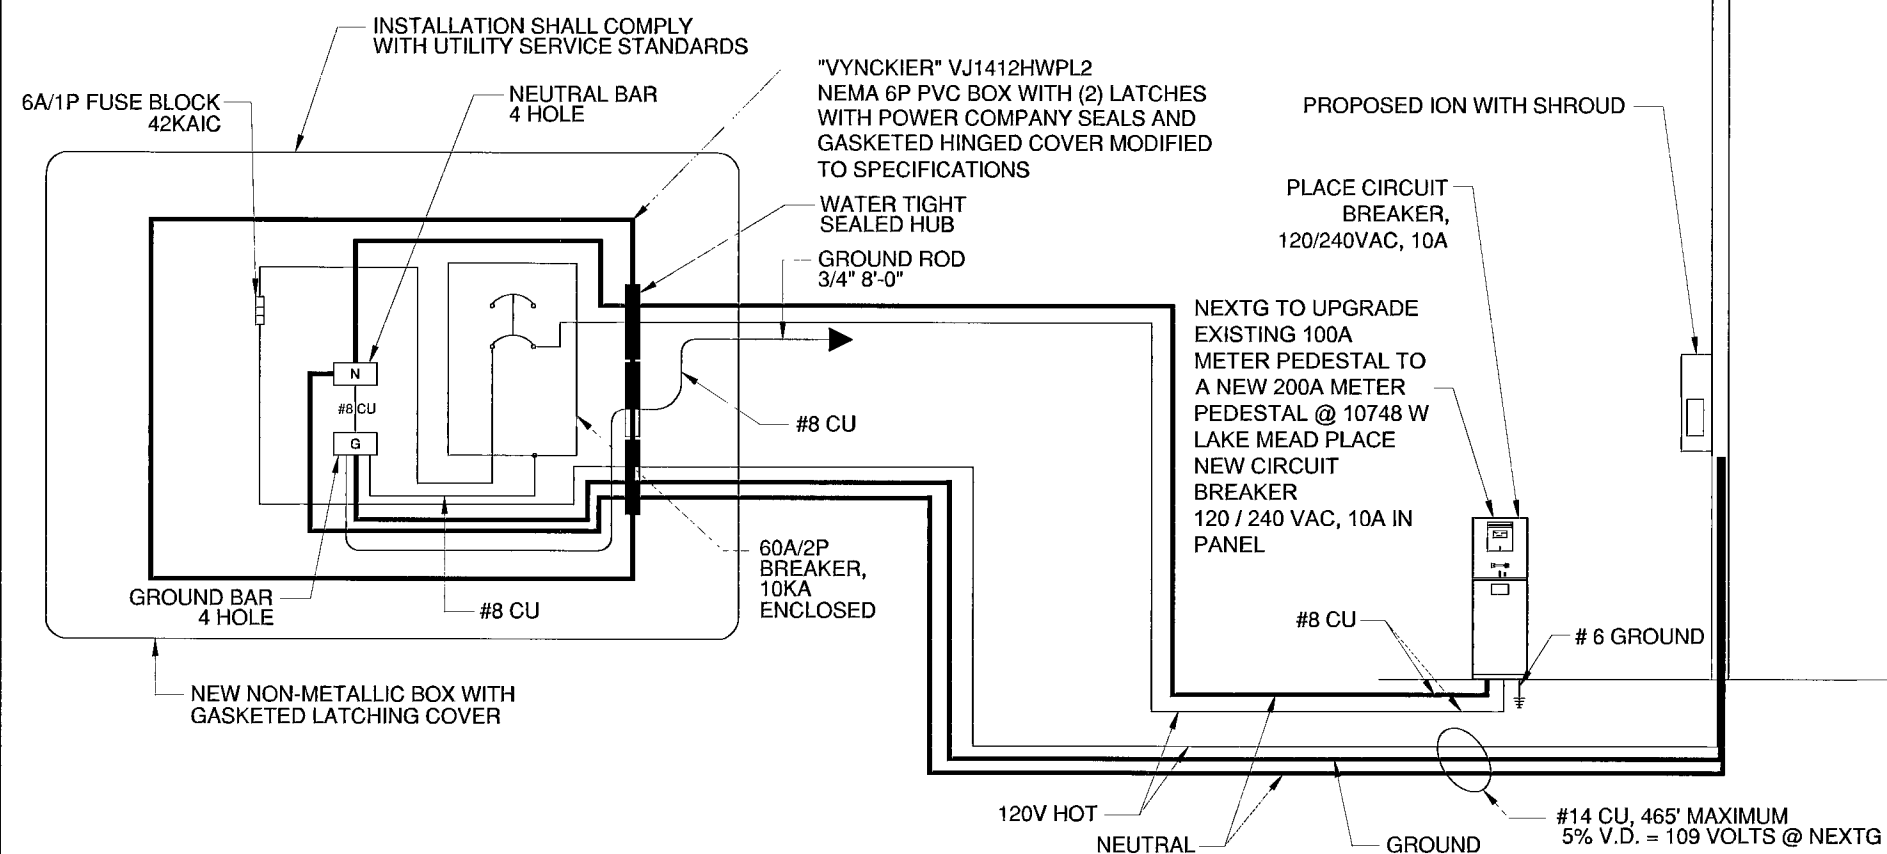

SCALE: N.T.S. POWER SINGLE LINE DIAGRAM

E

PROJECT INFORMATION:

SPR1009NV-SUMN006  
LAS VEGAS, NV 89134

CURRENT ISSUE DATE:

03/10/2010

PERMIT SUBMISSION:

REV. DATE DESCRIPTION BY:

PLANS BY:

REP:

COMMENTS:

37681

107U5432-TEL

SHEET TITLE:

TYPICALS 1

SHEET NUMBER: REVISION:

6

6 OF 8