
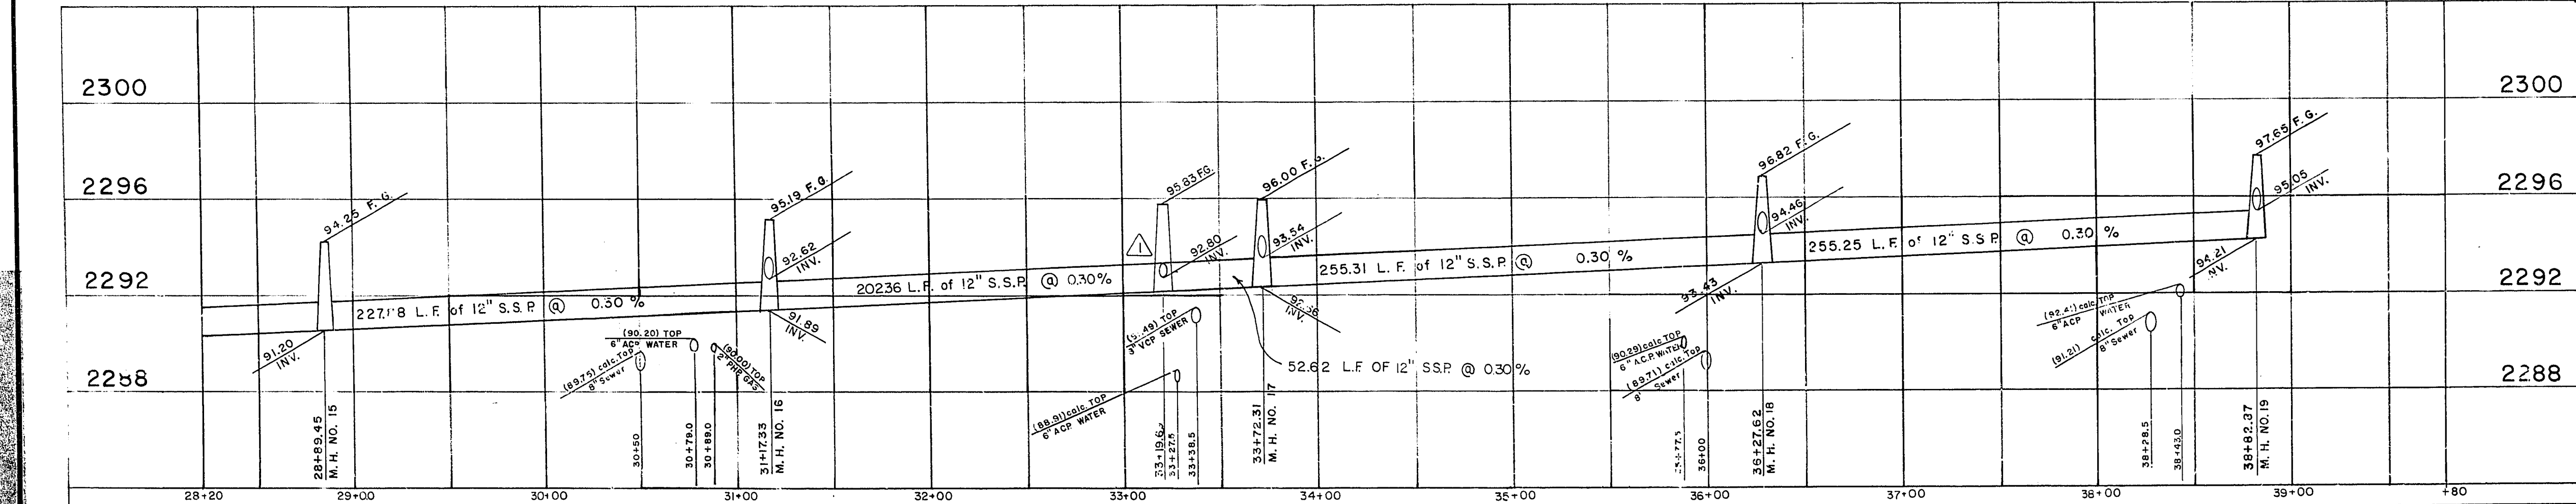


D-LOAD CHART	
LFG	D-LOAD ULT.
▲	1754
▲	1817
▲	1742
▲	1897
▲	1626
▲	3407
▲	2649
▲	2550
▲	4163
▲	2644
▲	2022
▲	4847
▲	1836
▲	5150
▲	1608
▲	5393
▲	1779
▲	4092

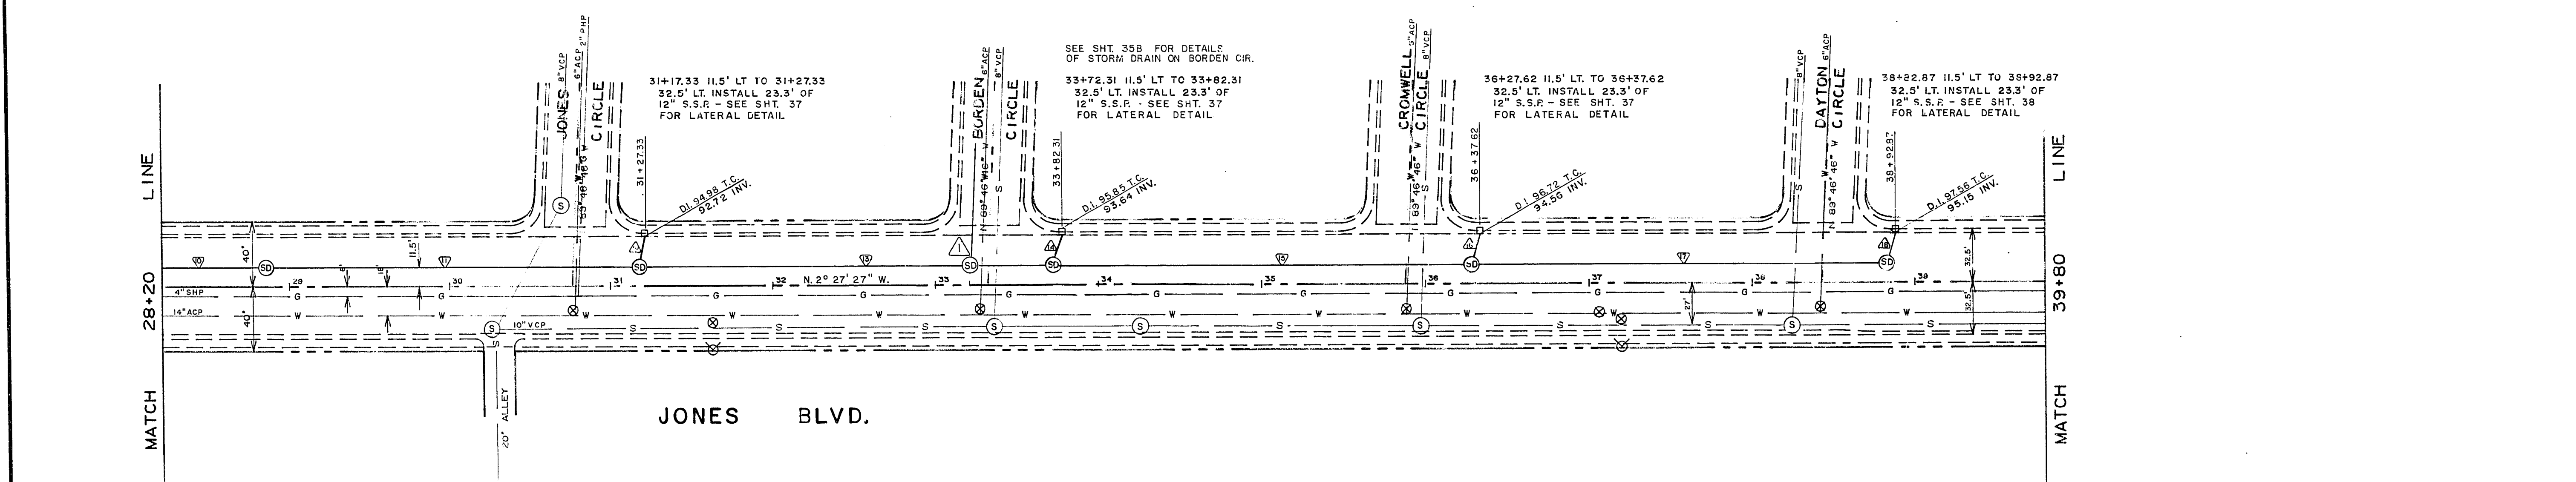

BENCH MARK
 No 06035-D3, S.W. Cor
 JONES & ALTA DRIVE
 ELEV. 2294.17

Department of Public Services Engineering Design Division		Scale (V) 1" = 4' Scale (H) 1" = 50'	W.O. no. 7694 Date 2/15/72
JONES BLVD. CHARLESTON BLVD. To SMOKE RANCH ROAD		Design by C. KREHNOVI Drawn by CALCOMP Approved by the Director of Public Services <i>William J. ...</i>	Date 12/1/78
Storm Drain Plan and Profile		Revisions	
Drawing no. 107-V948A		30/66	

274-14