

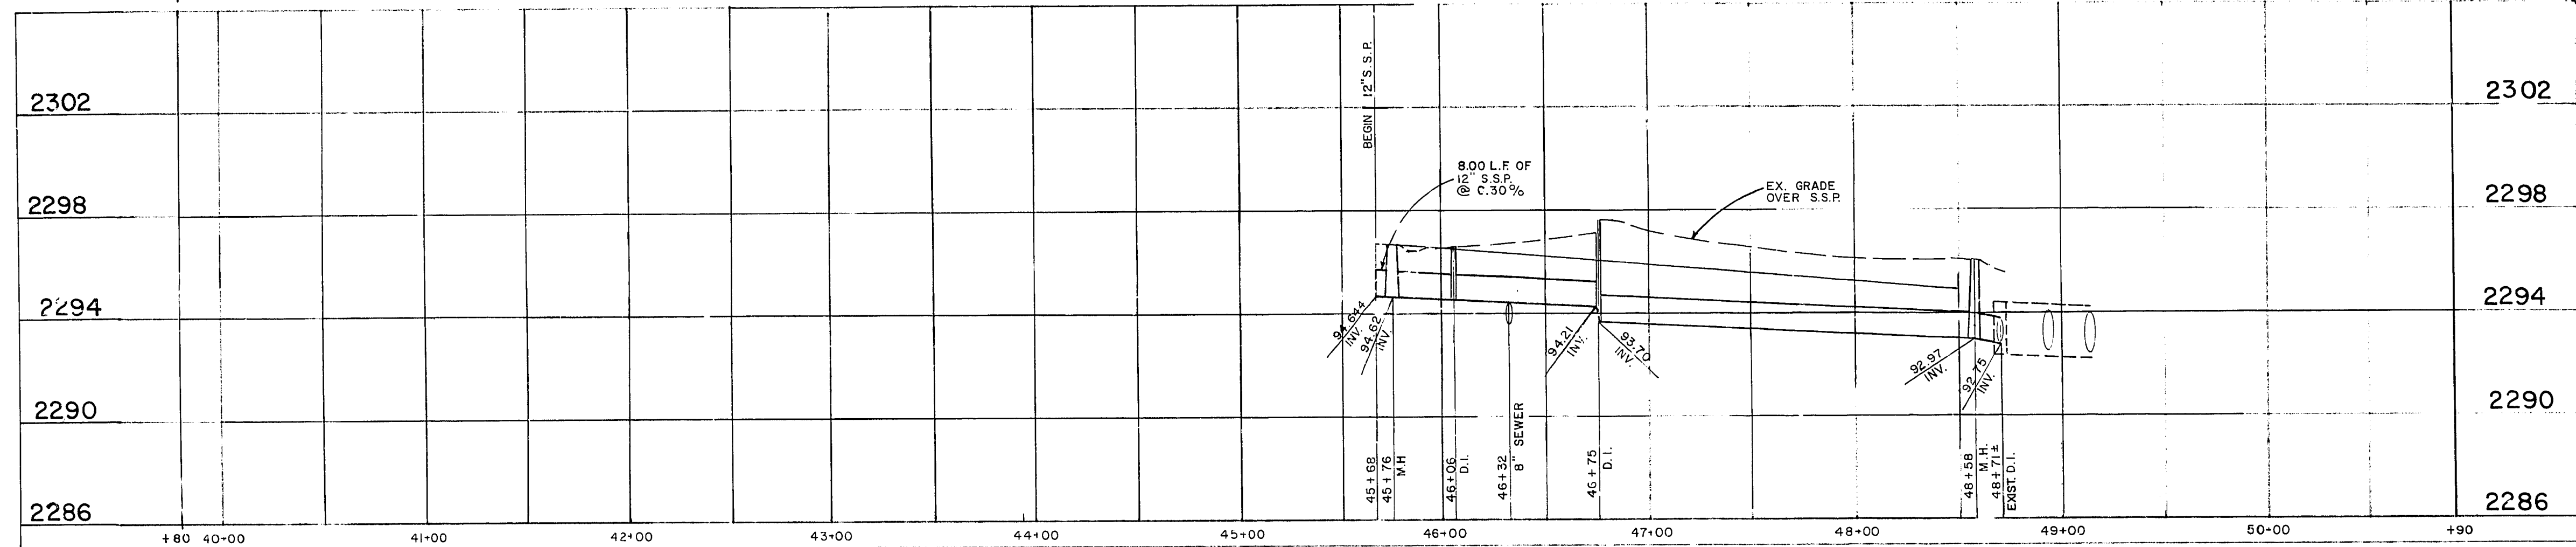


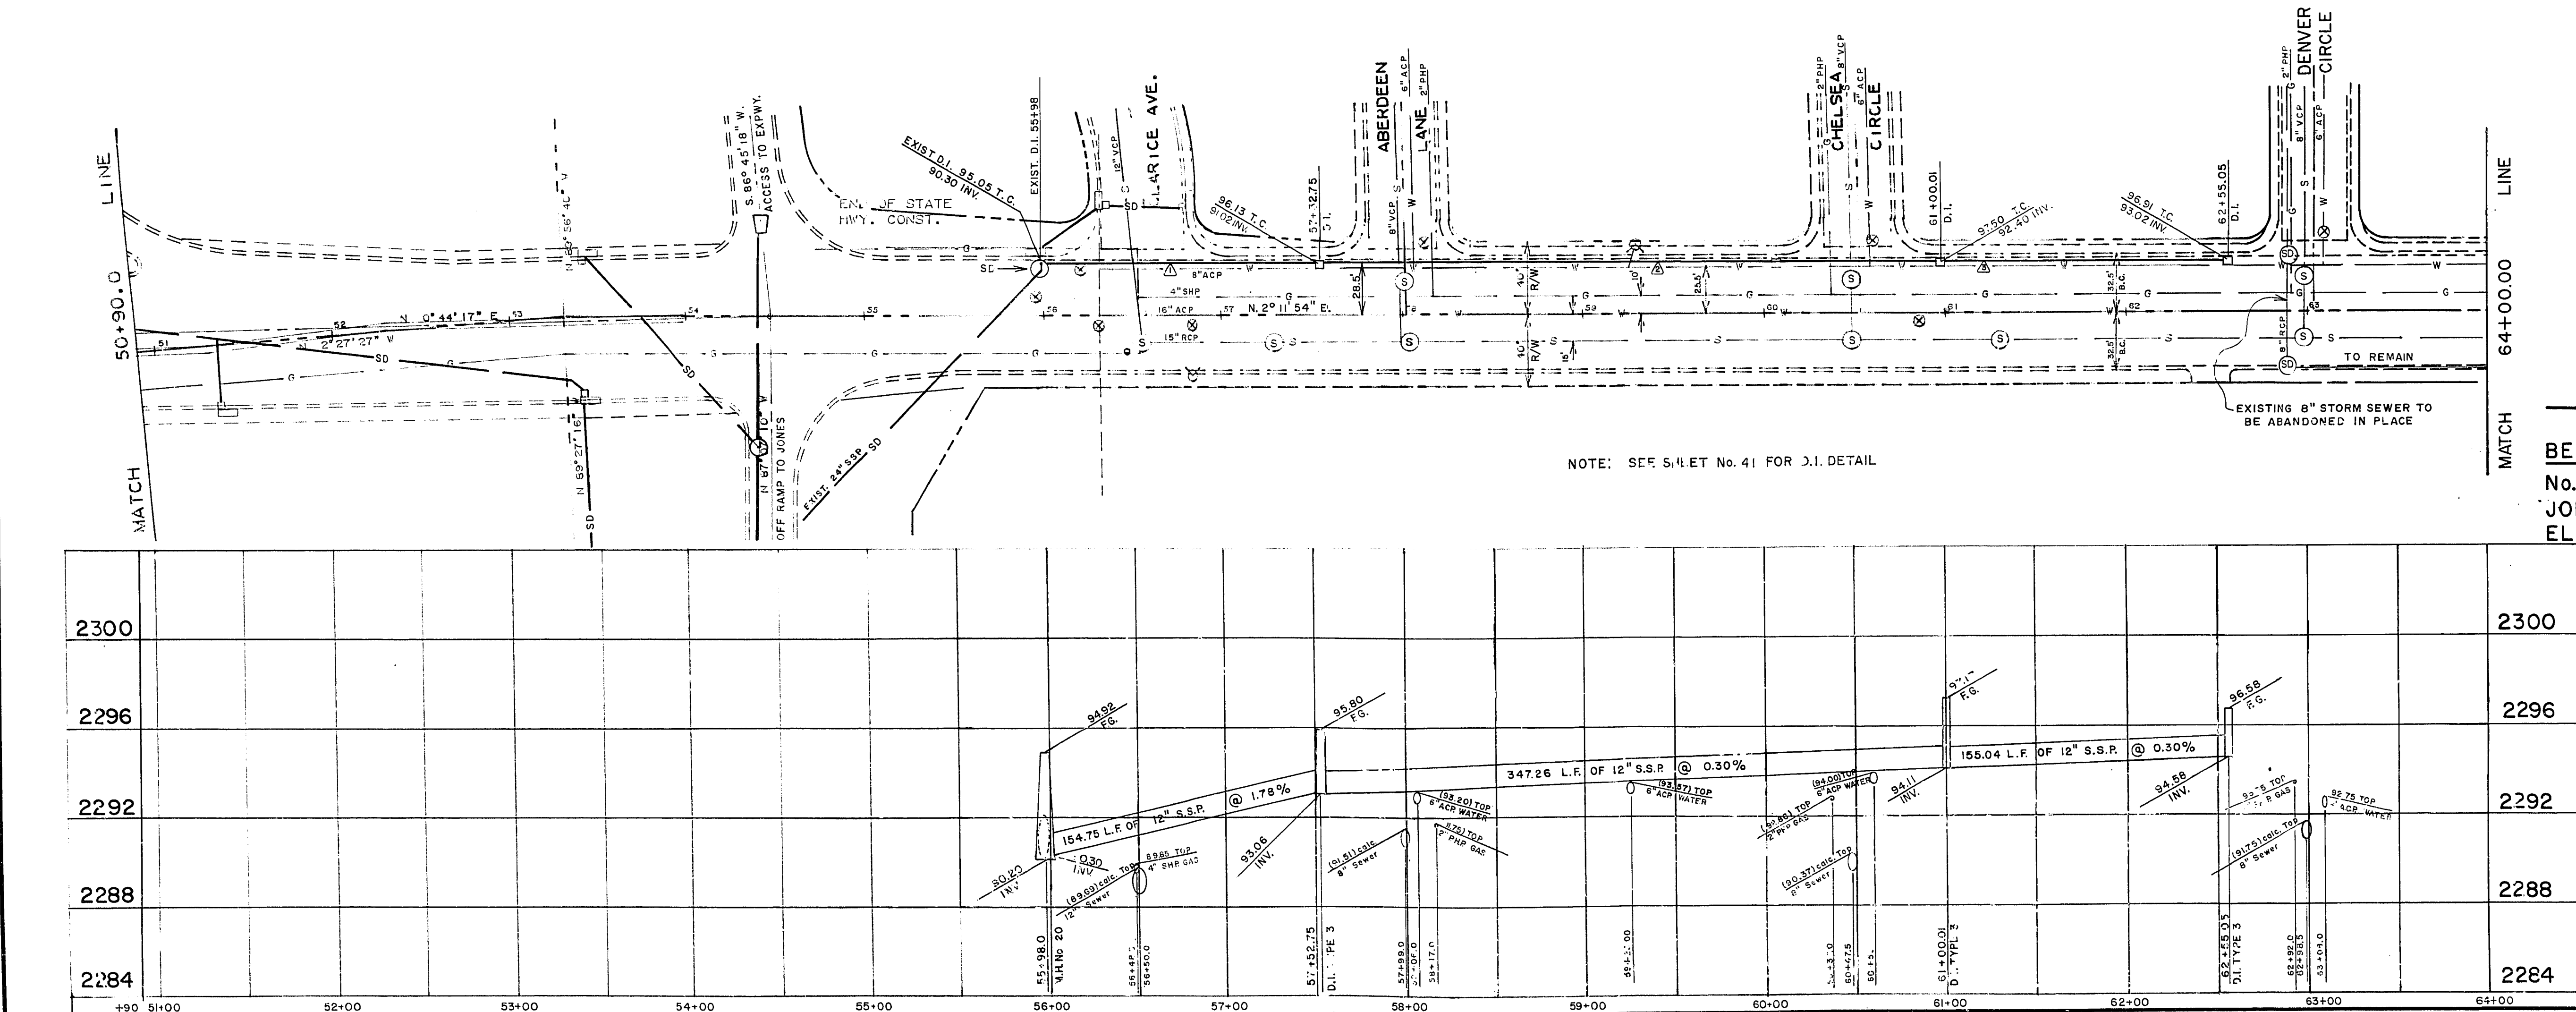

D-LOAD CHART	
LEO	D-LOAD ULT
▲	1674
▲	1674
▲	2384

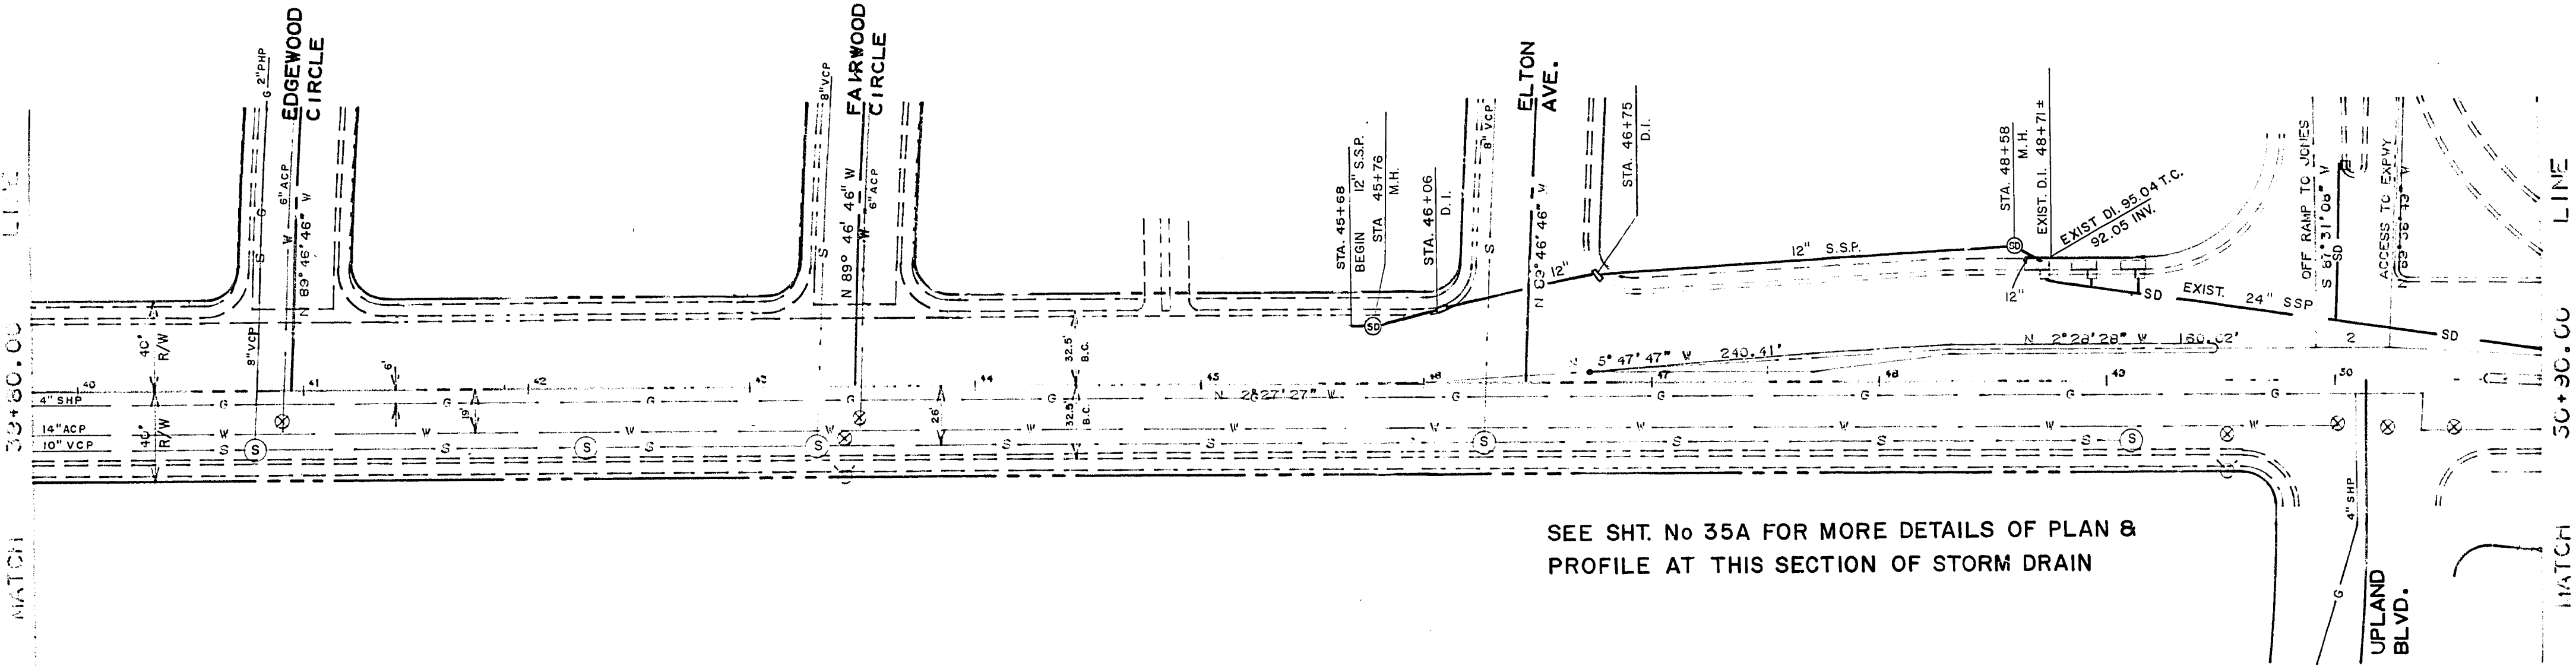

SEE SHT. No 35A FOR MORE DETAILS OF PLAN & PROFILE AT THIS SECTION OF STORM DRAIN

BENCH MARK
No. 06026 D2, S.W. Cor.
JONES & DENVER CIRCLE
ELEV. 2296.90

City of Las Vegas

Department of Public Services

Engineering Design Division

JONES BLVD.
CHARLESTON BLVD.
To
SMOKE RANCH ROAD

STORM DRAIN
PLAN AND PROFILE

Scale (h) 1" = 50'

Scale (v) 1" = 4'

W.O. no. 7694

Fid. bk. no. 75-4X

Design by C. KREHNOVI

Drawn by CALCOMP

Approved by the Director of Public Services

Date 12/1/84

Revisions

Date