
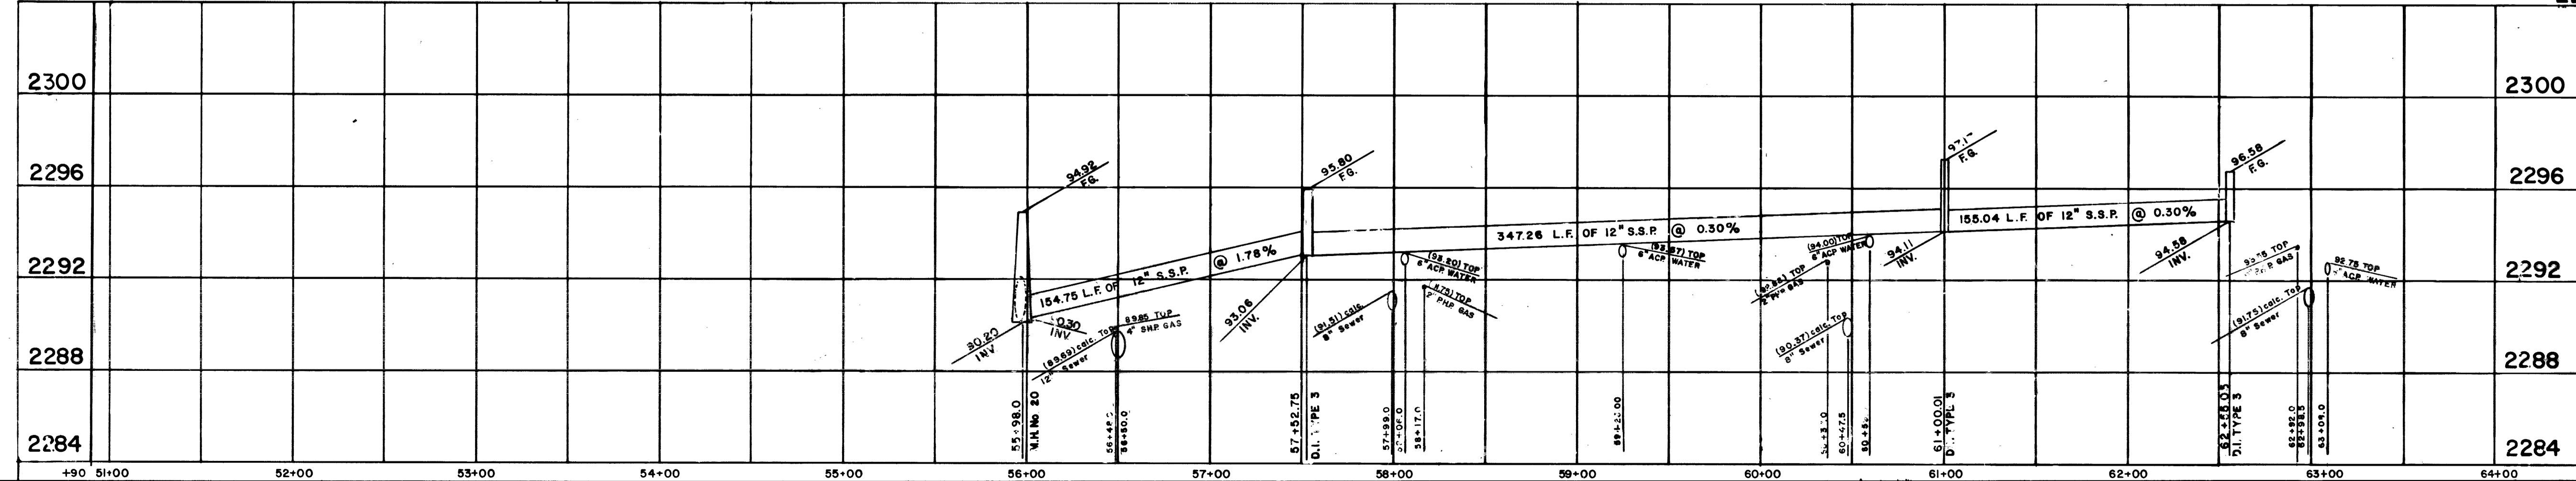
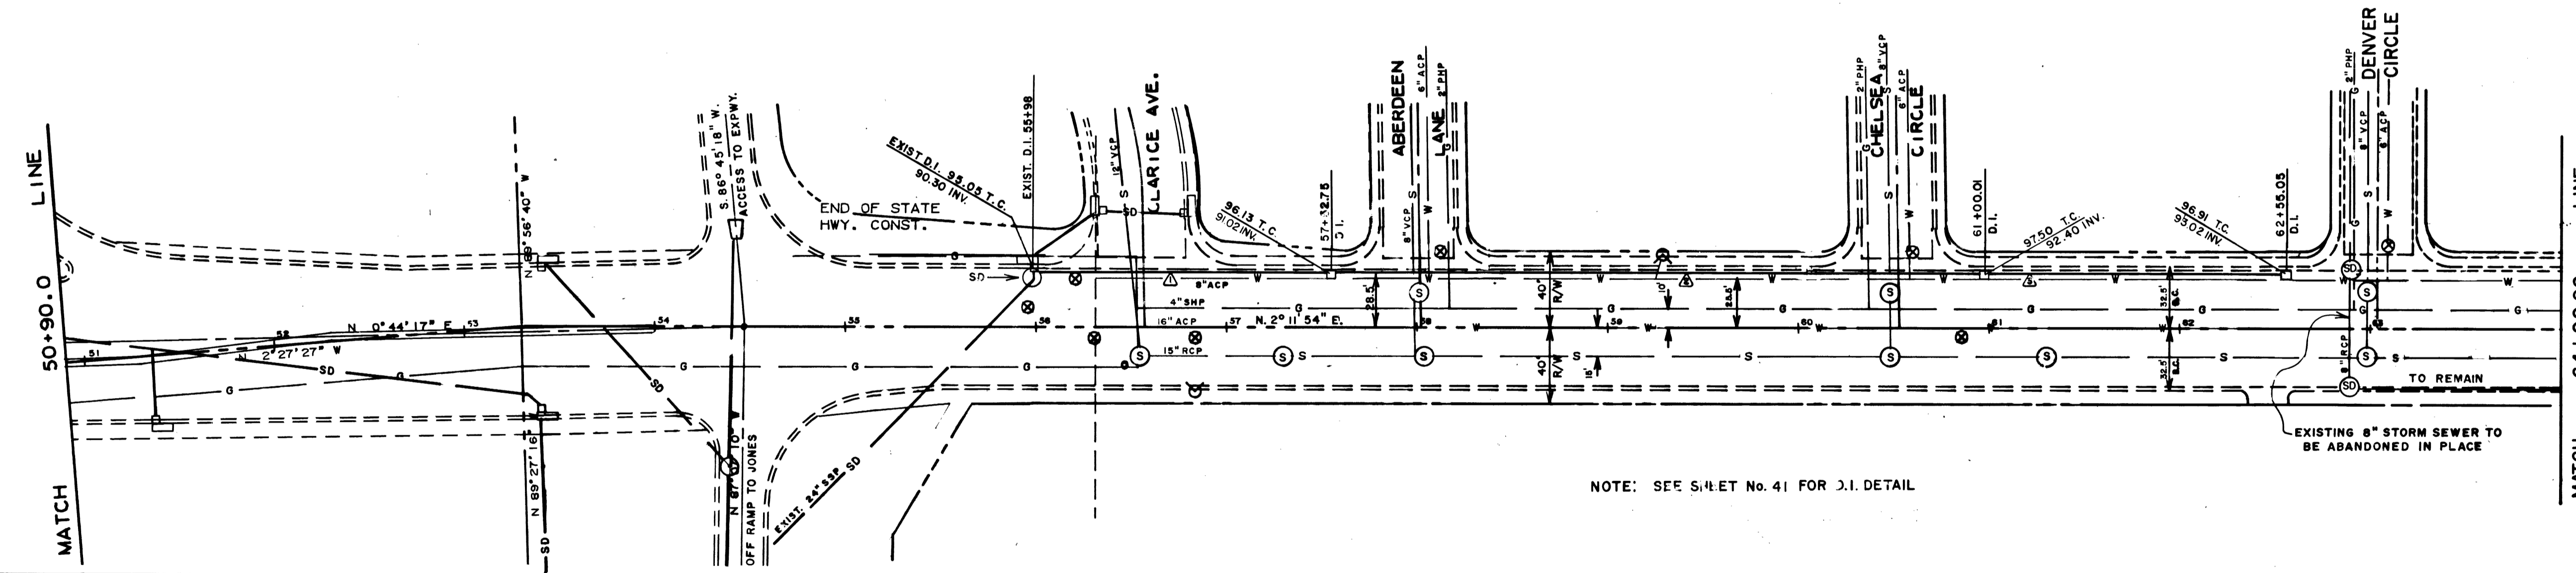


D-LOAD CHART	
LE#	D-LOAD ULT.
▲	1674
▲	1674
▲	2384

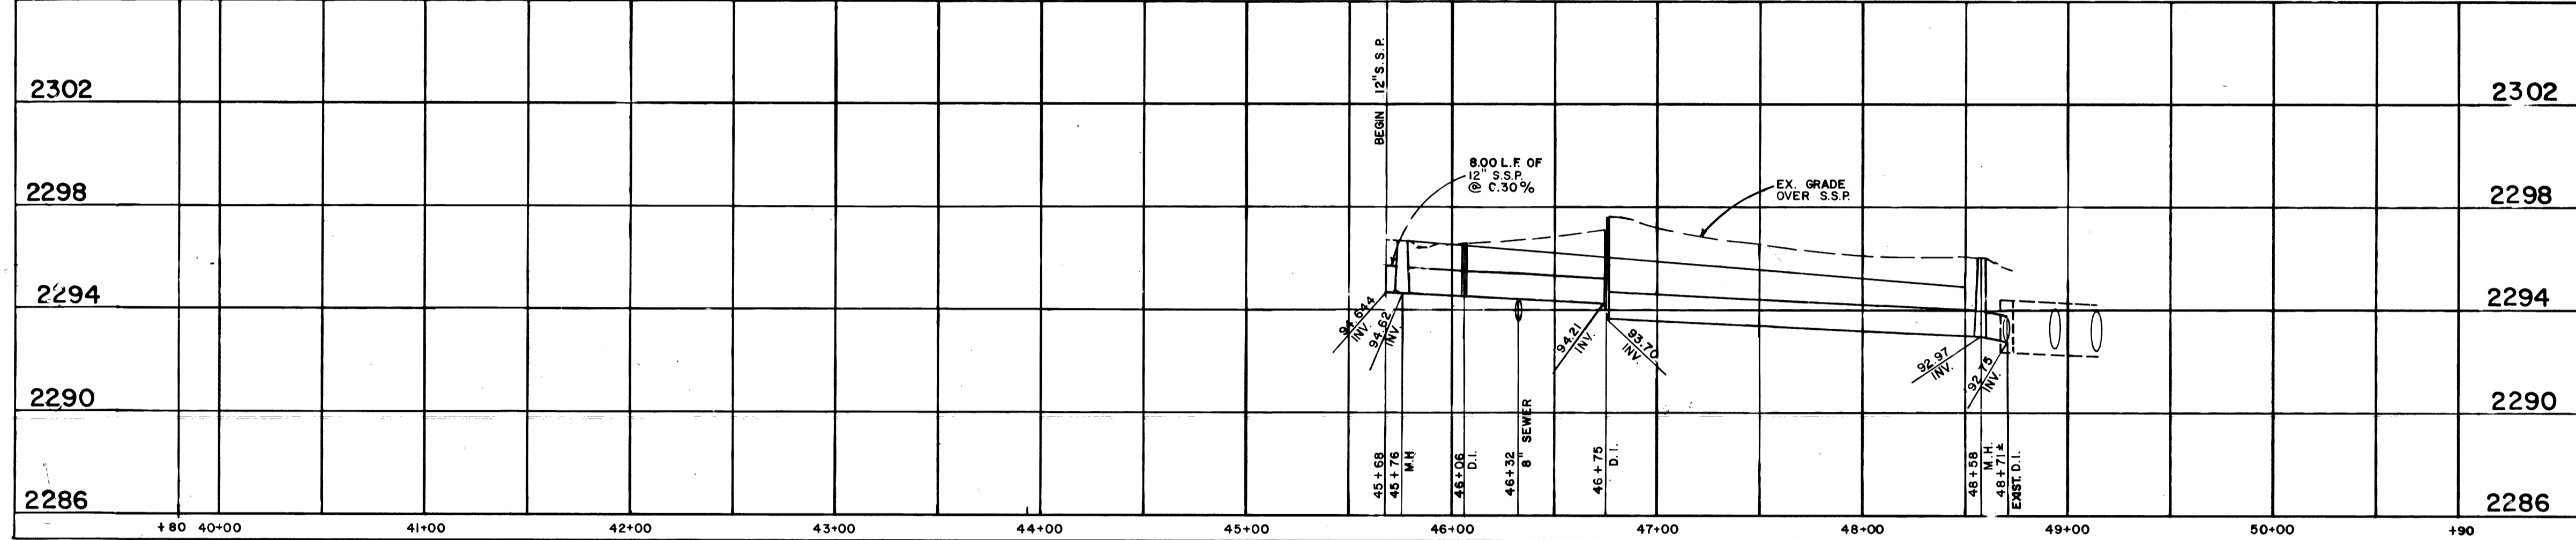

CONTRACT
DRAWING
FEB 2 1975

Department of Public Services Engineering Design Division
 STORM DRAIN
 PLAN AND PROFILE
 JONES BLVD.
 CHARLESTON BLVD.
 To
 SMOKE RANCH ROAD

Scale (h) 1" = 50'
 Scale (v) 1" = 4'
 Fid. bk. no. 75-4X
 Design by C. KREHNOVI
 Drawn by CALCOMP
 Approved by the Director of Public Services
 Date 12/1/78

W.O. no. 7694
 Revisions

23645