

REGIONAL STREET AND HIGHWAY COMMISSION

CITY OF LAS VEGAS CLARK COUNTY, NEVADA

DEPARTMENT OF PUBLIC SERVICES ENGINEERING DESIGN DIVISION

MAYOR

William H. Briare

COMMISSIONERS

Ron Lurie
Paul J. Christensen
Myron E. Leavitt
Roy Woofter



CITY MANAGER

Russell Dorn

ASSISTANT CITY MANAGER

Donald J. Saylor, A.I.P.

DIRECTOR OF PUBLIC SERVICES

William J. Purvis, P.E.


JONES BLVD.

CHARLESTON BLVD. To SMOKE RANCH ROAD

BID NO.
R78.22

CONTRACT NO.
CLVR-1522

LOCATION MAP

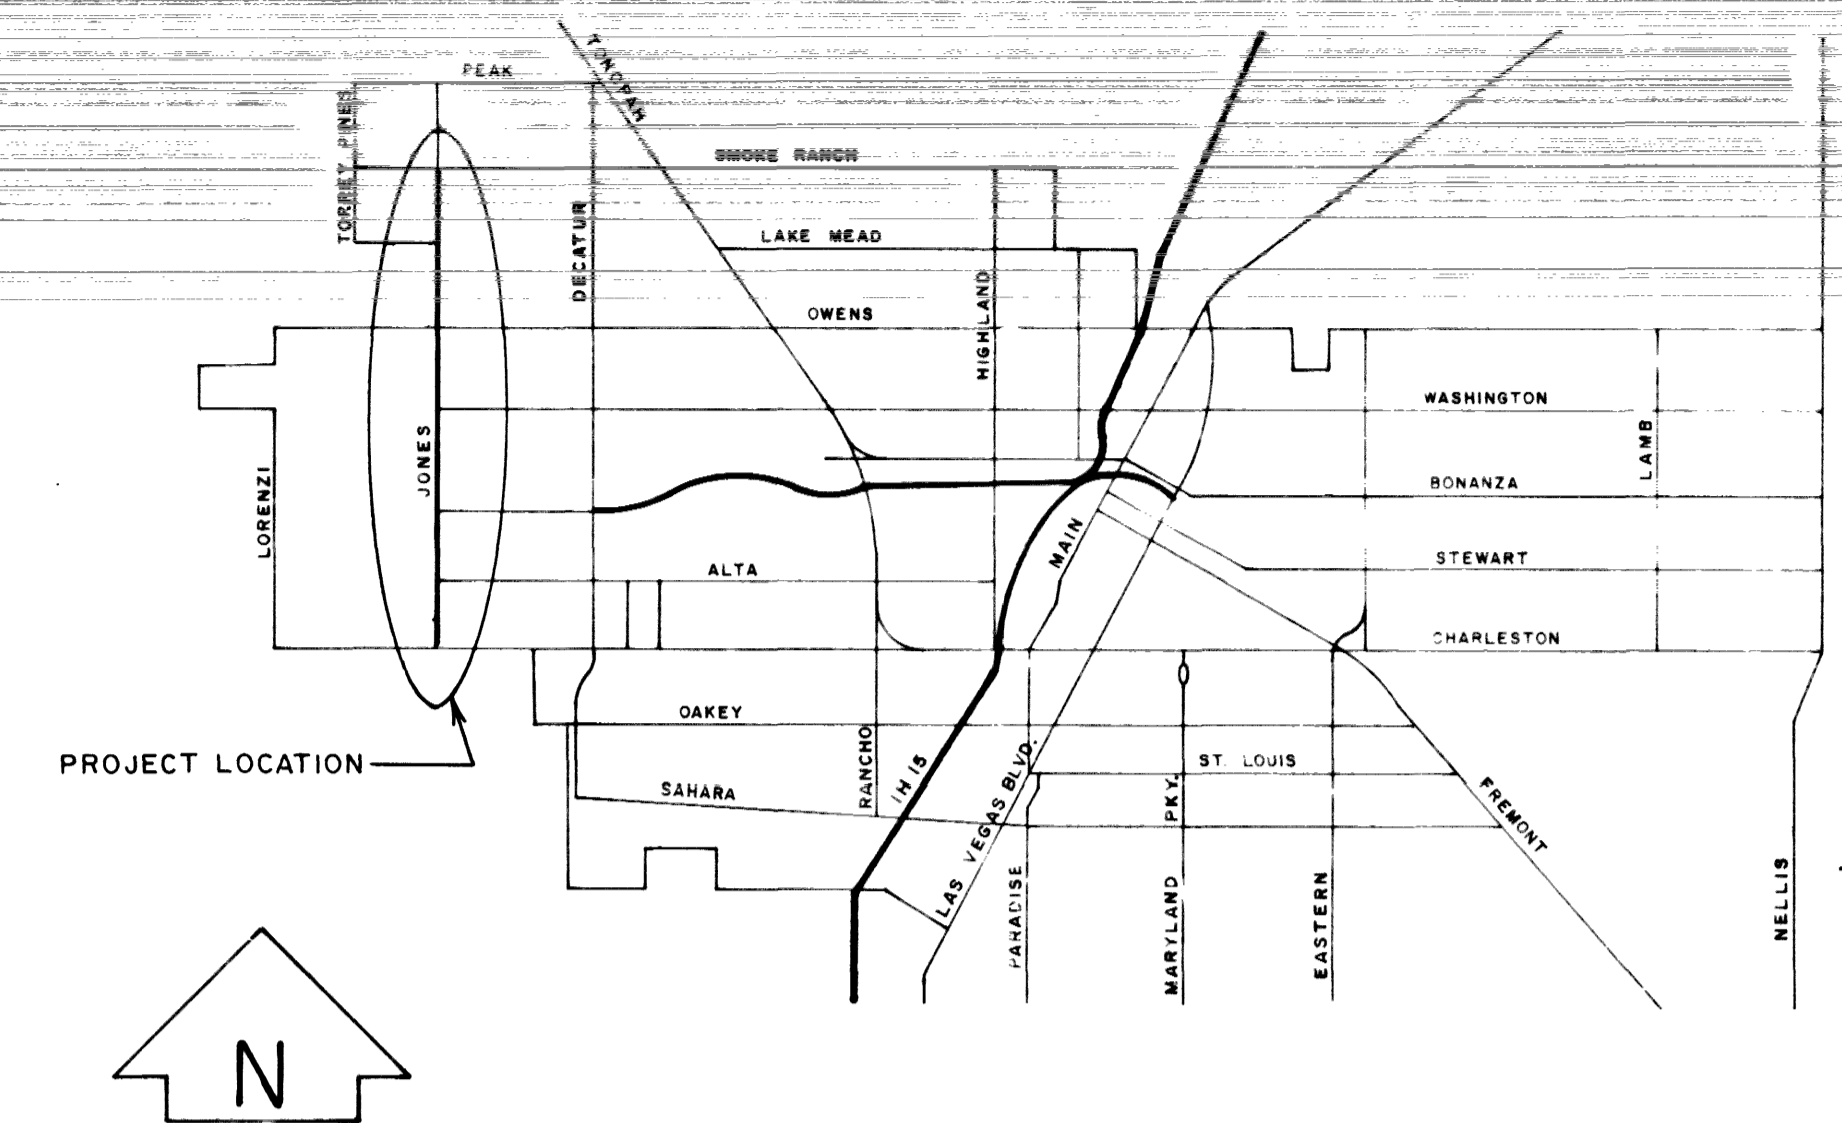

INDEX OF SHEETS

NO.	DESCRIPTION
1	Title Sheet - Vicinity Map - Index and Approvals
2	APPROXIMATE QUANTITIES, GENERAL NOTES, COLLAR & ISLAND DETAILS
3	TYPICAL SECTIONS
4-18	JONES BLVD., CHARLESTON BLVD To SMOKE RANCH RD. PLAN AND PROFILE
19	EVERGREEN AVENUE, ALTA DRIVE, PLANS AND PROFILES
20	WASHINGTON AVENUE, PLAN AND PROFILE
21	VEGAS DRIVE, PLAN AND PROFILE
22	LAKE MEAD BLVD., PLAN AND PROFILE, AND CONSTRUCTION SIGN DETAIL
23	STAMPED CONCRETE ISLAND DETAILS (ADDITIVE ALTERNATE)
24-28	ABOVE GROUND CONSTRUCTION FEATURES & UNDERGROUND UTILITIES
29-35A,B	STORM DRAIN, PLAN AND PROFILE
36-39	STORM DRAIN LATERAL DETAILS
40	DROP INLET DETAILS
41-41A	STORM DRAIN, TRENCHING AND WHEEL CHAIR RAMP DETAILS
42-42A	ISLAND IRRIGATION SERVICE (ADDITIVE ITEM)
43-50	STREET LIGHTING
51-53	TRAFFIC LANE DELINEATION
54	TRAFFIC SIGNAL JONES BLVD. & EVERGREEN AVE. 208-V502
55	TRAFFIC SIGNAL JONES BLVD. & LAKE MEAD BLVD 208-V262
56	TRAFFIC SIGNAL JONES BLVD. & VEGAS DR. 208-V250
57	TRAFFIC SIGNAL JONES BLVD. & WASHINGTON AVE. 208-V259
58	TRAFFIC SIGNAL JONES BLVD. & ALTA DR. 208-V258
59-68	TRAFFIC SIGNAL INTERCONNECT JONES BLVD FR. CHARLESTON TO SMOKE RANCH RD. 208-V257

REVISIONS

NO.	DESCRIPTION	BY	DATE	APPR.	DATE	DRAWING NO.
						107-V948A
						SHEET 1 OF 68

AGENCY	NO SERVICE	REVIEWED BY	DATE	TITLE	APPROVED	DATE
R.S. & H.C. Mng. Engr.		C.P. Brith	1-31-78	Director of Public Services	[Signature]	12-1-78
N.S.H.D. Dist. Engr.		[Signature]	12/1/78	City Engineer	[Signature]	12/6/78
CenTel		[Signature]	9-21-78	Field Operations Engineer	[Signature]	12-6-78
L.V.V. Water Dist.		[Signature]	9-19-78	Supv. of Engineering	[Signature]	11/29/78
Nevada Power Comp.		[Signature]		Supv. of Traffic	[Signature]	4-1-78
SW Gas Corp.		[Signature]	9/14/78	Supv. of Quality Control	[Signature]	12-6-78
				Supv. of Electrical Services	[Signature]	9-13-78
				Supv. of Sanitation	[Signature]	8-7-78
				Supv. of Building & Safety	N.A.	
				Dir. of Comm. Plan. & Dev.		9-1
				Dir. of Cultural Services	[Signature]	9-13-78
				Dir. of Fire Services	[Signature]	12-8-78
				Assistant City Manager	[Signature]	12-8-78