
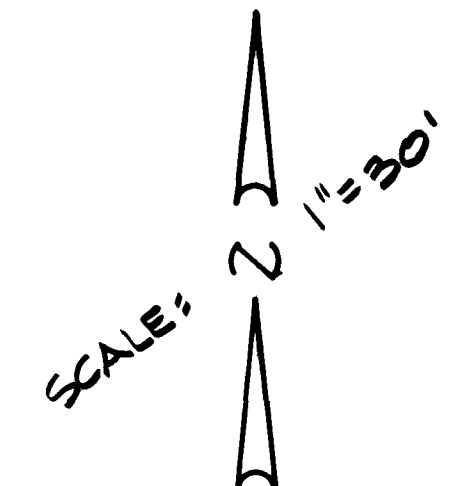


FREMONT ESTATES
UNITS 2A & 2-C
(EXIST. FHA "A" TYPE DRAINAGE)

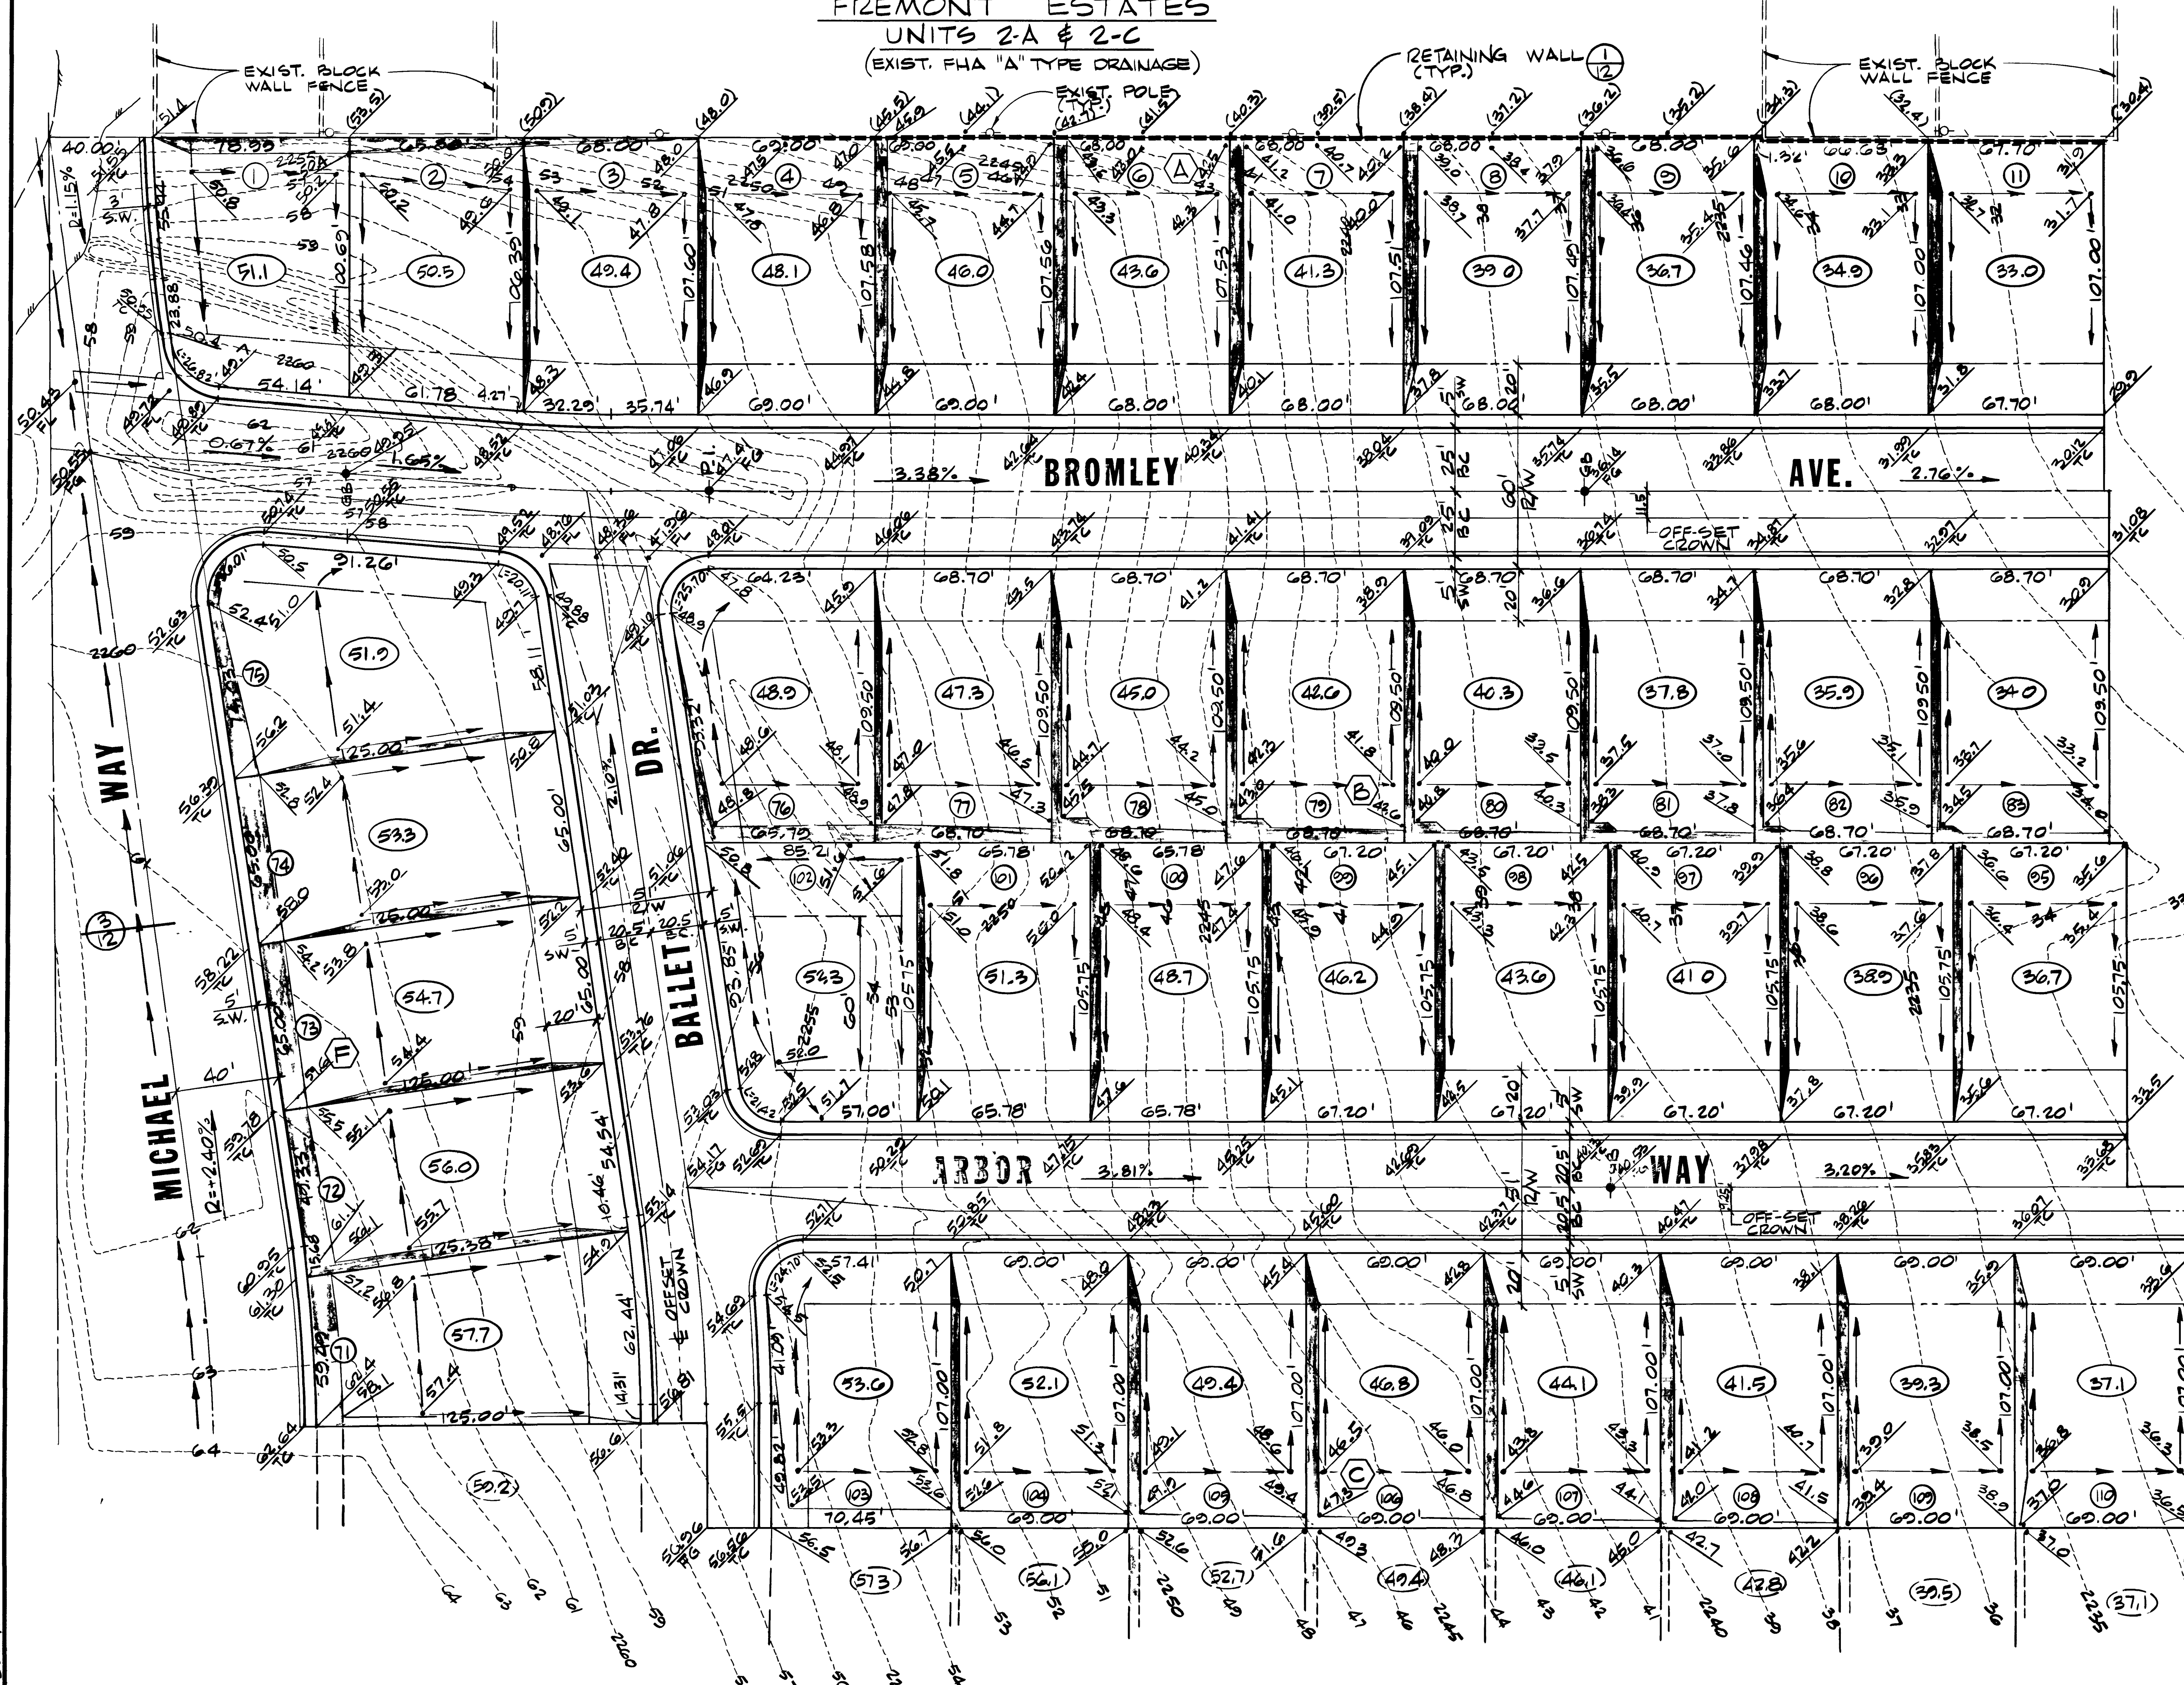


LEWIS HOMES MEADOW VISTA
UNIT N# 2

LEWIS HOMES - MEADOW VISTA UNIT N# 4

APPROVALS:
 [Signature] CITY ENGINEER
 [Signature] FIELD OPERATIONS ENGR.
 [Signature] QUALITY CONTROL ENGINEER

REV.	DATE	DESCRIPTION
1	10/17/11	ISSUE FOR PERMITS
2	10/17/11	ISSUE FOR PERMITS
3	10/17/11	ISSUE FOR PERMITS

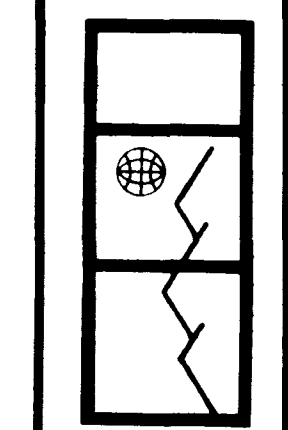

G. C. WALLACE
Consulting Engineers, Inc.
1100 East Sahara Ave., Las Vegas, Nevada 89104 • 732-3300

LEWIS HOMES OF NEVADA
LEWIS HOMES - MEADOW VISTA UNIT NO. 1
GRADING PLAN II


SHEET
13
OF 13 SHEETS

5543.5110

974 DIETRICH POST 21228 .003 FILM

1074-2029-1 24 7 170 1074-2029-1

SCALE 1/8" = 1'-0"

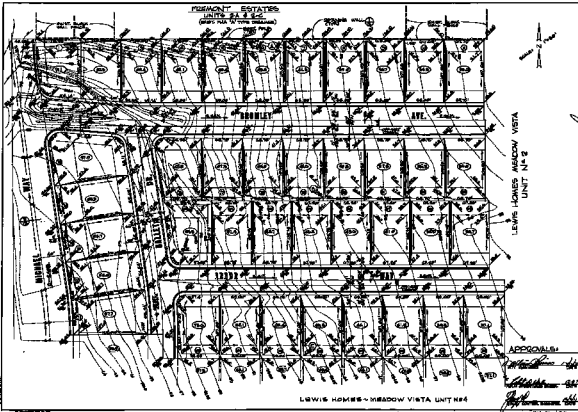

FREMONT ESTATES
 UNITS 2A & 2-C
 (SEAL PLAN IN THIS DRAWING)

LEWIS HOMES MEADOW VISTA
 UNIT N#2

LEWIS HOMES - MEADOW VISTA UNIT N#2

APPROVALS:

[Signature]
[Signature]
[Signature]

13
 1962 MAY 24 7 190
 B.C. WALLACE
 Consulting Engineers, Inc.
 1330 13th St. N.W., Seattle, Wash. 98108
 GRADE PLAN 2