


JOB NO. 5543.7010

WINTERGREEN DRIVE

MATCH LINE - SEE SHEET 3

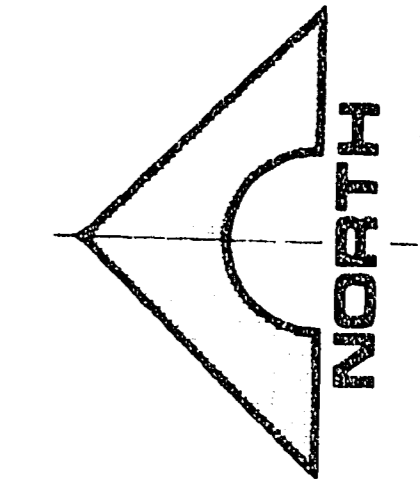

SCALE: 1" = 30'

MATCH LINE - SEE SHEET 1

MOGHA DRIVE

BITTERSWEET CIRCLE



 
WHEATLAND WAY

TENAYA WAY

CARMEN BOULEVARD


TYPICAL REAR & SIDE YARD SCARP

APPROVALS:

 2-15-02
 CLV ENGINEER DATE
 2/10/03
 CLV QUALITY CONTROL ENGINEER DATE
 2/15/03
 CLV CHIEF LAND DEVELOPMENT AND FLOOD CONTROL

REV	DATE	DESCRIPTION
1	2/15/03	FINAL PLAN
2	2/10/03	REVISED PLAN
3	2/15/03	REVISED PLAN

RECOMMENDED	REVISION	DATE	DESCRIPTION
1	1	2/15/03	FINAL PLAN
2	2	2/10/03	REVISED PLAN
3	3	2/15/03	REVISED PLAN

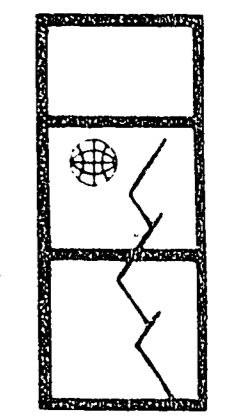


G. C. WALLACE
 Consulting Engineers, Inc.
 1100 East Sahara Ave. - Las Vegas, Nevada 89104 - 792-3330

LEWIS HOMES OF NEVADA
 LEWIS HOMES - RAINBOW PARK
 GRADING PLAN II

SHEET
2
 OF 4 SHEETS

247-74 1074-2030-1

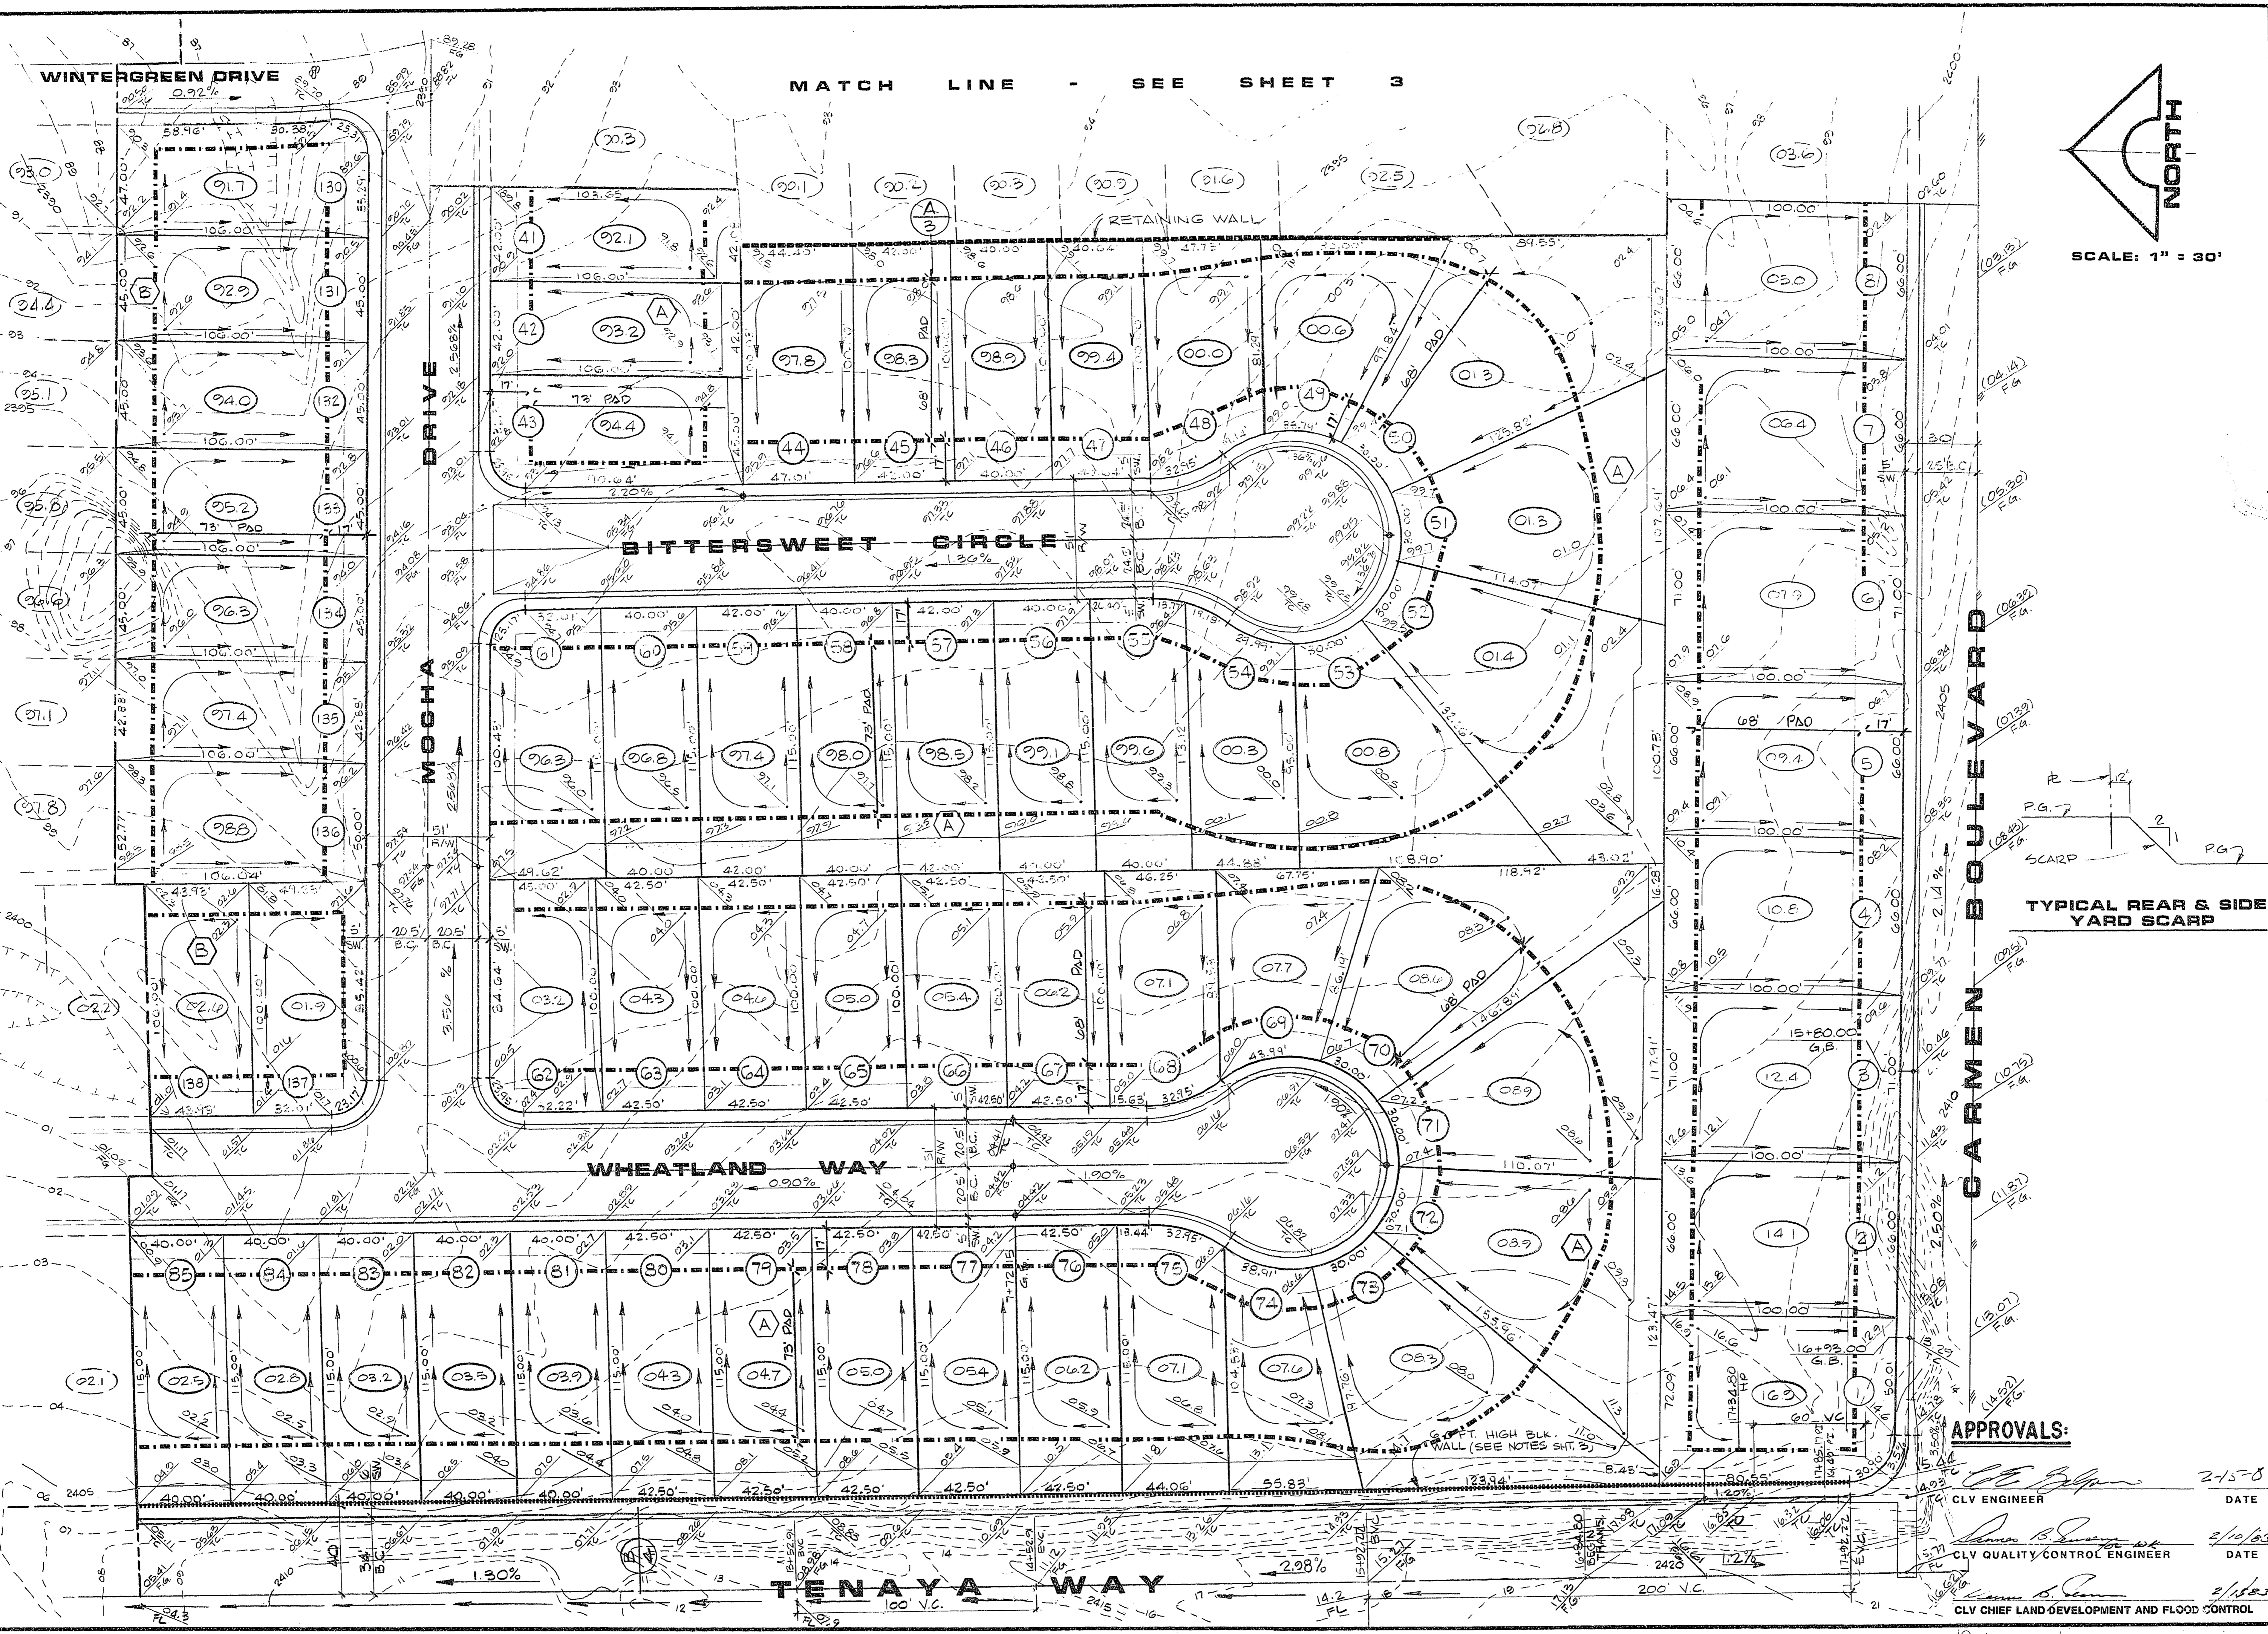

9/78 DIETRICH-POST 5338