



LAKE MEAD BLVD.

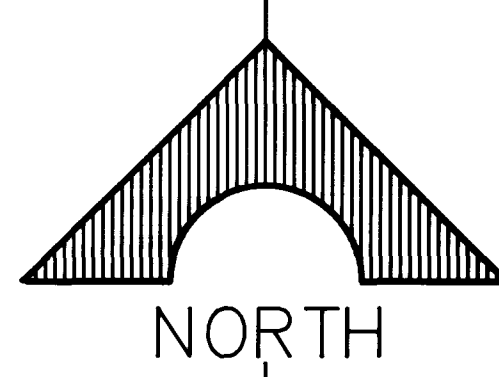

SERVICE PEDESTAL SCHEDULE

- (1) - 200A - 2P Main Breaker
- (1) - 60A - 1P Controller Bkr. (future)
- (1) - 20A - 1P Street Name Sign Lighting Bkr.
- (2) - 60A - 2P Roadway Lighting Bkr.
- (2) - 60A - 2P Roadway Lighting Contactor
- (1) - 15A - 1P Photoeye/Contactor Control
- (1) - 30A - 1P Intersection Luminaires

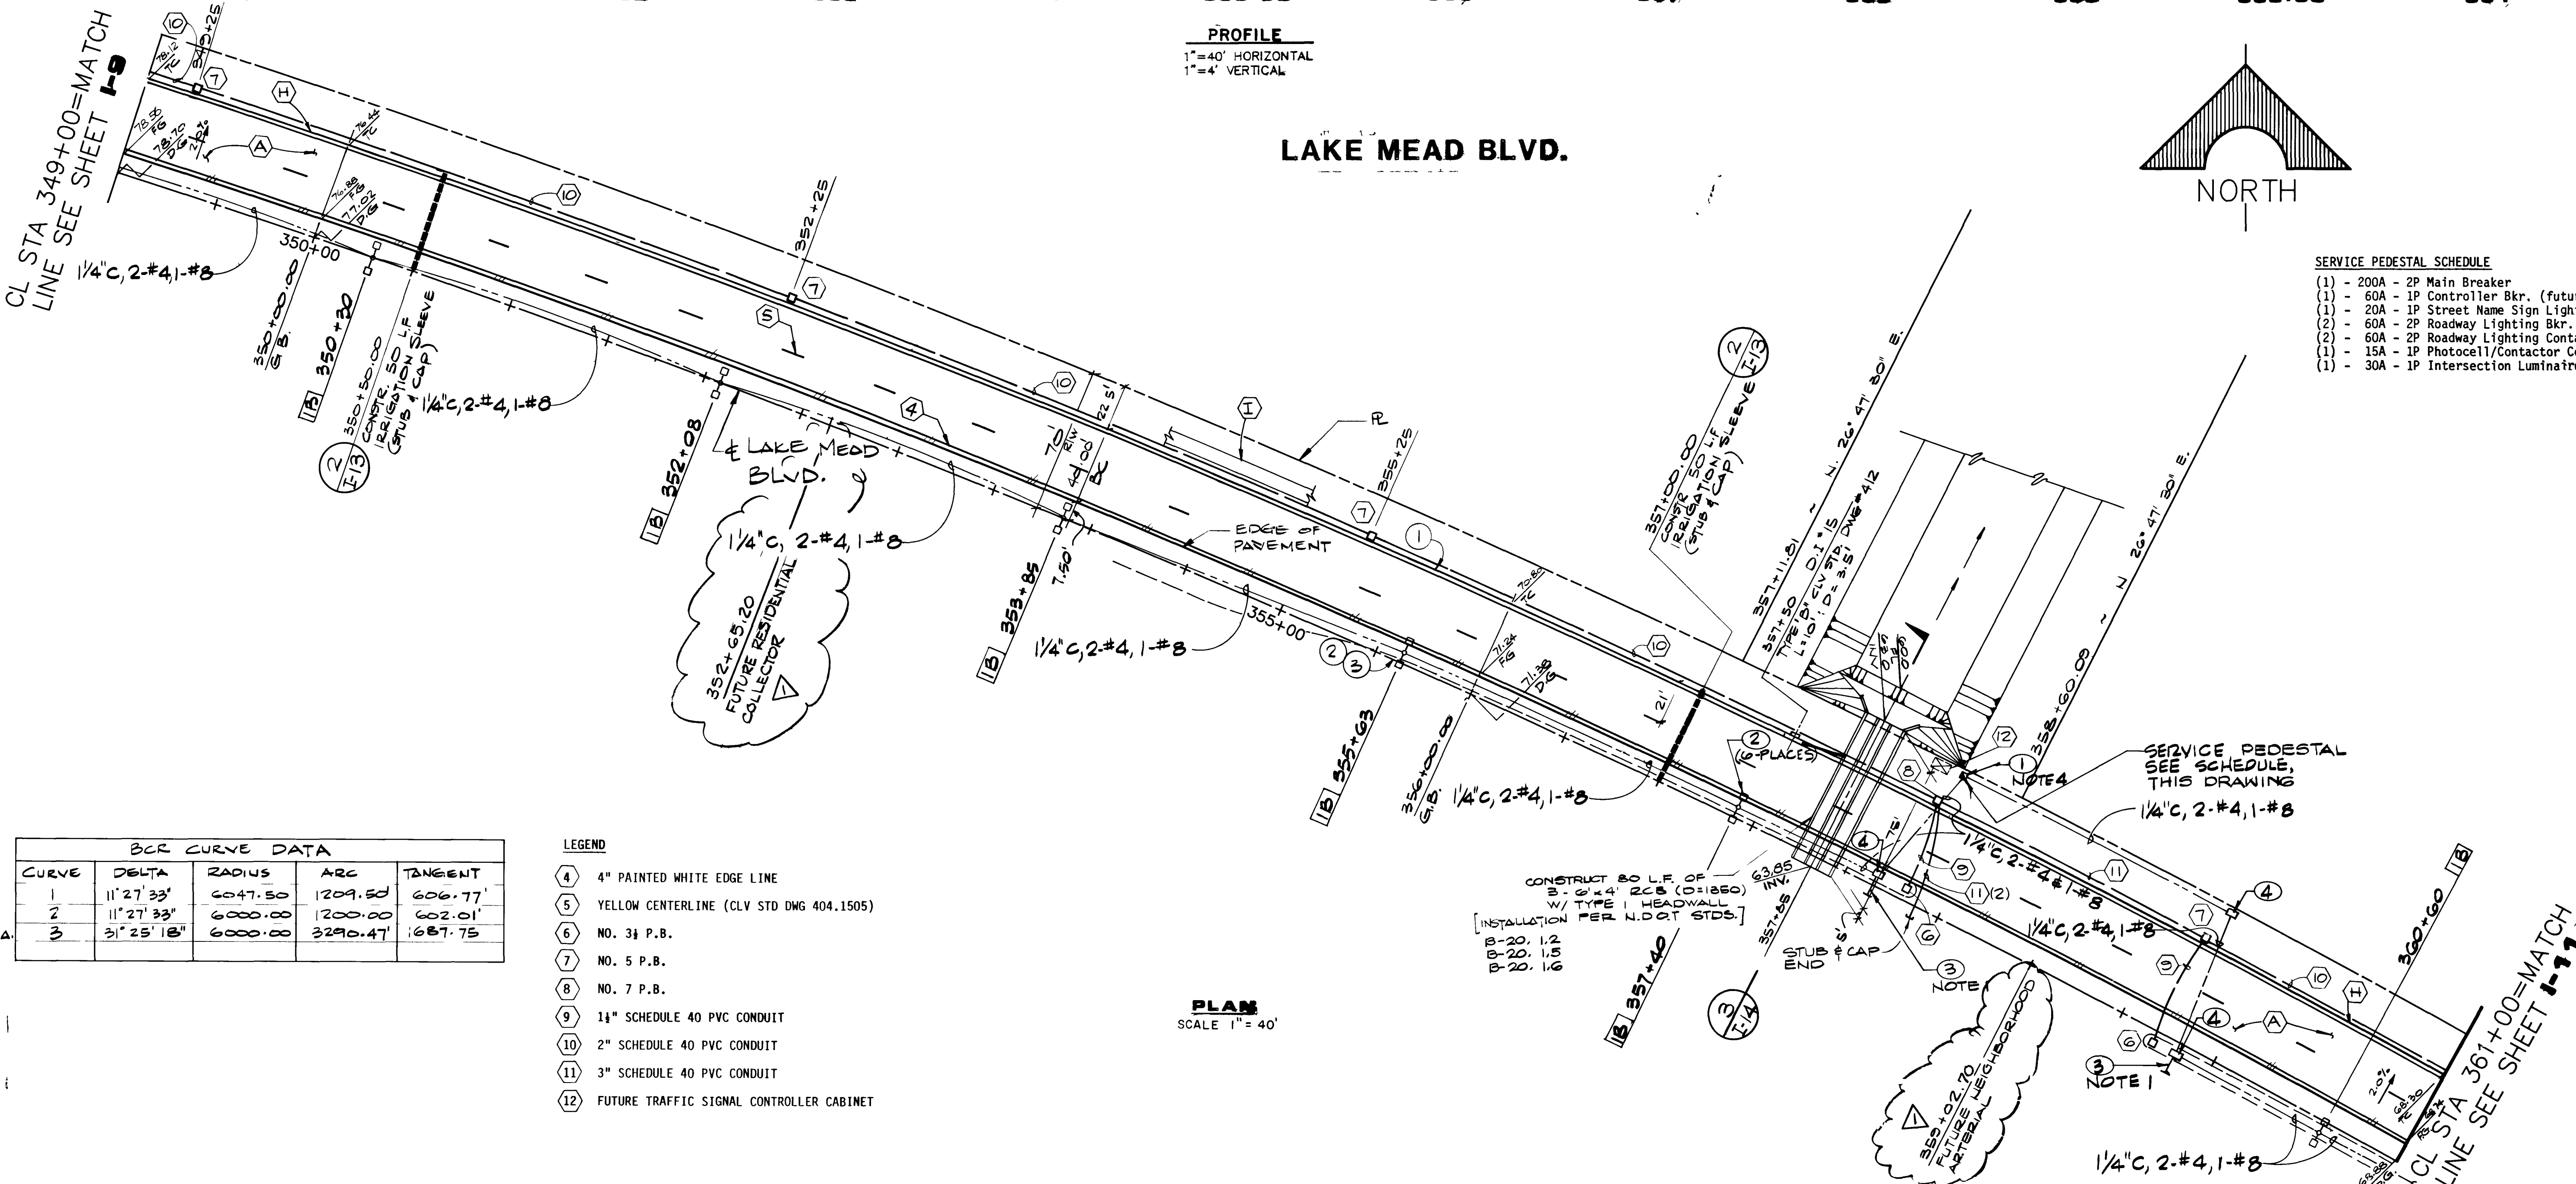

BCR CURVE DATA

CURVE	DELTA	RADIUS	ARC	TANGENT
1	11° 27' 33"	6047.50	1209.50	606.77'
2	11° 27' 33"	6000.00	1200.00	602.01'
3	31° 25' 18"	6000.00	3290.47	1687.75'

- LEGEND**
- (4) 4" PAINTED WHITE EDGE LINE
 - (5) YELLOW CENTERLINE (CLV STD DWG 404.1505)
 - (6) NO. 31 P.B.
 - (7) NO. 5 P.B.
 - (8) NO. 7 P.B.
 - (9) 1 1/2" SCHEDULE 40 PVC CONDUIT
 - (10) 2" SCHEDULE 40 PVC CONDUIT
 - (11) 3" SCHEDULE 40 PVC CONDUIT
 - (12) FUTURE TRAFFIC SIGNAL CONTROLLER CABINET

PLAN
 SCALE 1" = 40'


RECOMMENDED: [Signature]

REV DATE 1/19/08 REVISED INTERSECTING STREETS

DEL WEBB COMMUNITIES, INC.
 SUN CITY SUMMERLIN
LAKE MEAD BLVD.
PLAN AND PROFILE
 STA. 349.00 TO STA. 361.00

G.C. WALLACE, INC.
 Engineering/Architecture
 155 SOUTH RAINBOW BLVD LAS VEGAS, NEVADA 89102

SHEET 12
I-10
 OF 23 SHEETS

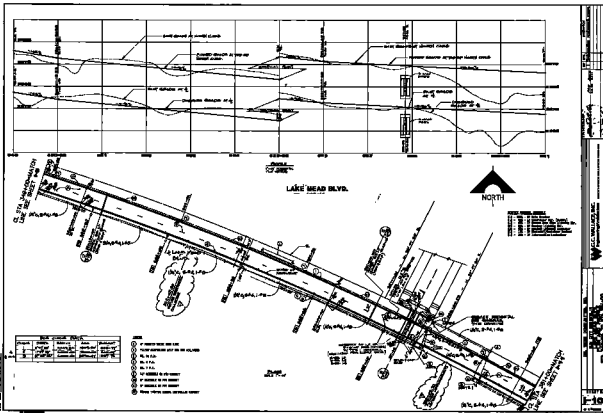

5524

4-2-14

PROJECT NO. 1001-018
 SHEET NO. 1001-018-1
 DATE 4-2-14
 DRAWN BY [Name]
 CHECKED BY [Name]
 APPROVED BY [Name]
 TITLE [Title]
 SCALE [Scale]
 PROJECT LOCATION [Location]
 CLIENT [Client]
 CONTRACT NO. [Contract No.]
 PROJECT NO. [Project No.]
 SHEET NO. [Sheet No.]
 DATE [Date]
 DRAWN BY [Name]
 CHECKED BY [Name]
 APPROVED BY [Name]
 TITLE [Title]
 SCALE [Scale]
 PROJECT LOCATION [Location]
 CLIENT [Client]
 CONTRACT NO. [Contract No.]
 PROJECT NO. [Project No.]
 SHEET NO. [Sheet No.]
 DATE [Date]