


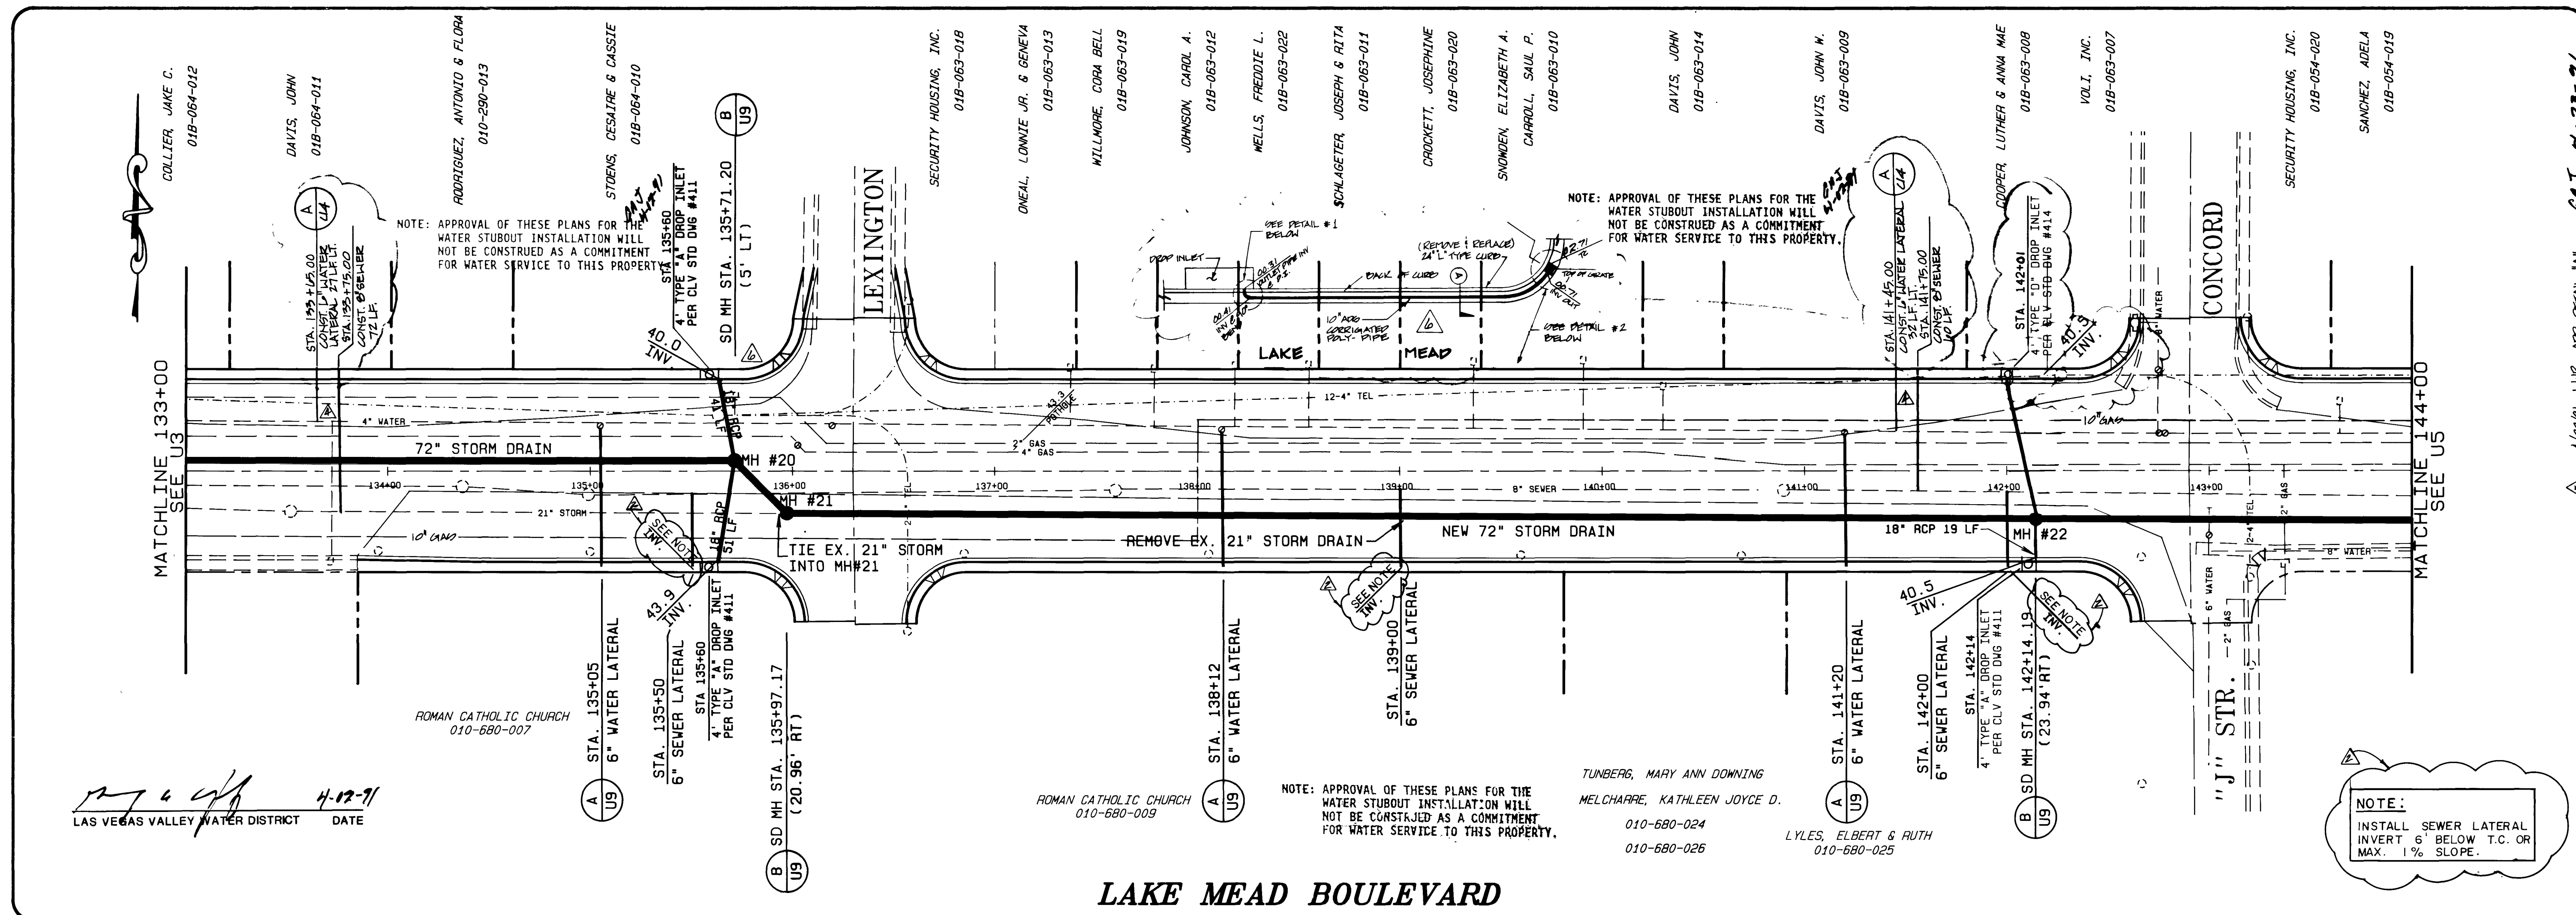


REV	DATE	BY	REVISION
1	4-12-71	JLS	ADT WATER & SEWER
2	4-12-71	JLS	REVISED D.I. FROM 142+14 TO 142+01
3	3-12-71	MTS	ADT WATER & SEWER
4	10-22-70	ACE	ADT WATER & SEWER
5	5-11-70	WLE	ADT WATER & SEWER

CONSULTING ENGINEERS - PLANNERS

2300 PASEO DEL PRADO BUILDING A SUITE 100
LAS VEGAS, NEVADA 89102 PHONE (702) 873-7550

vtm nevada

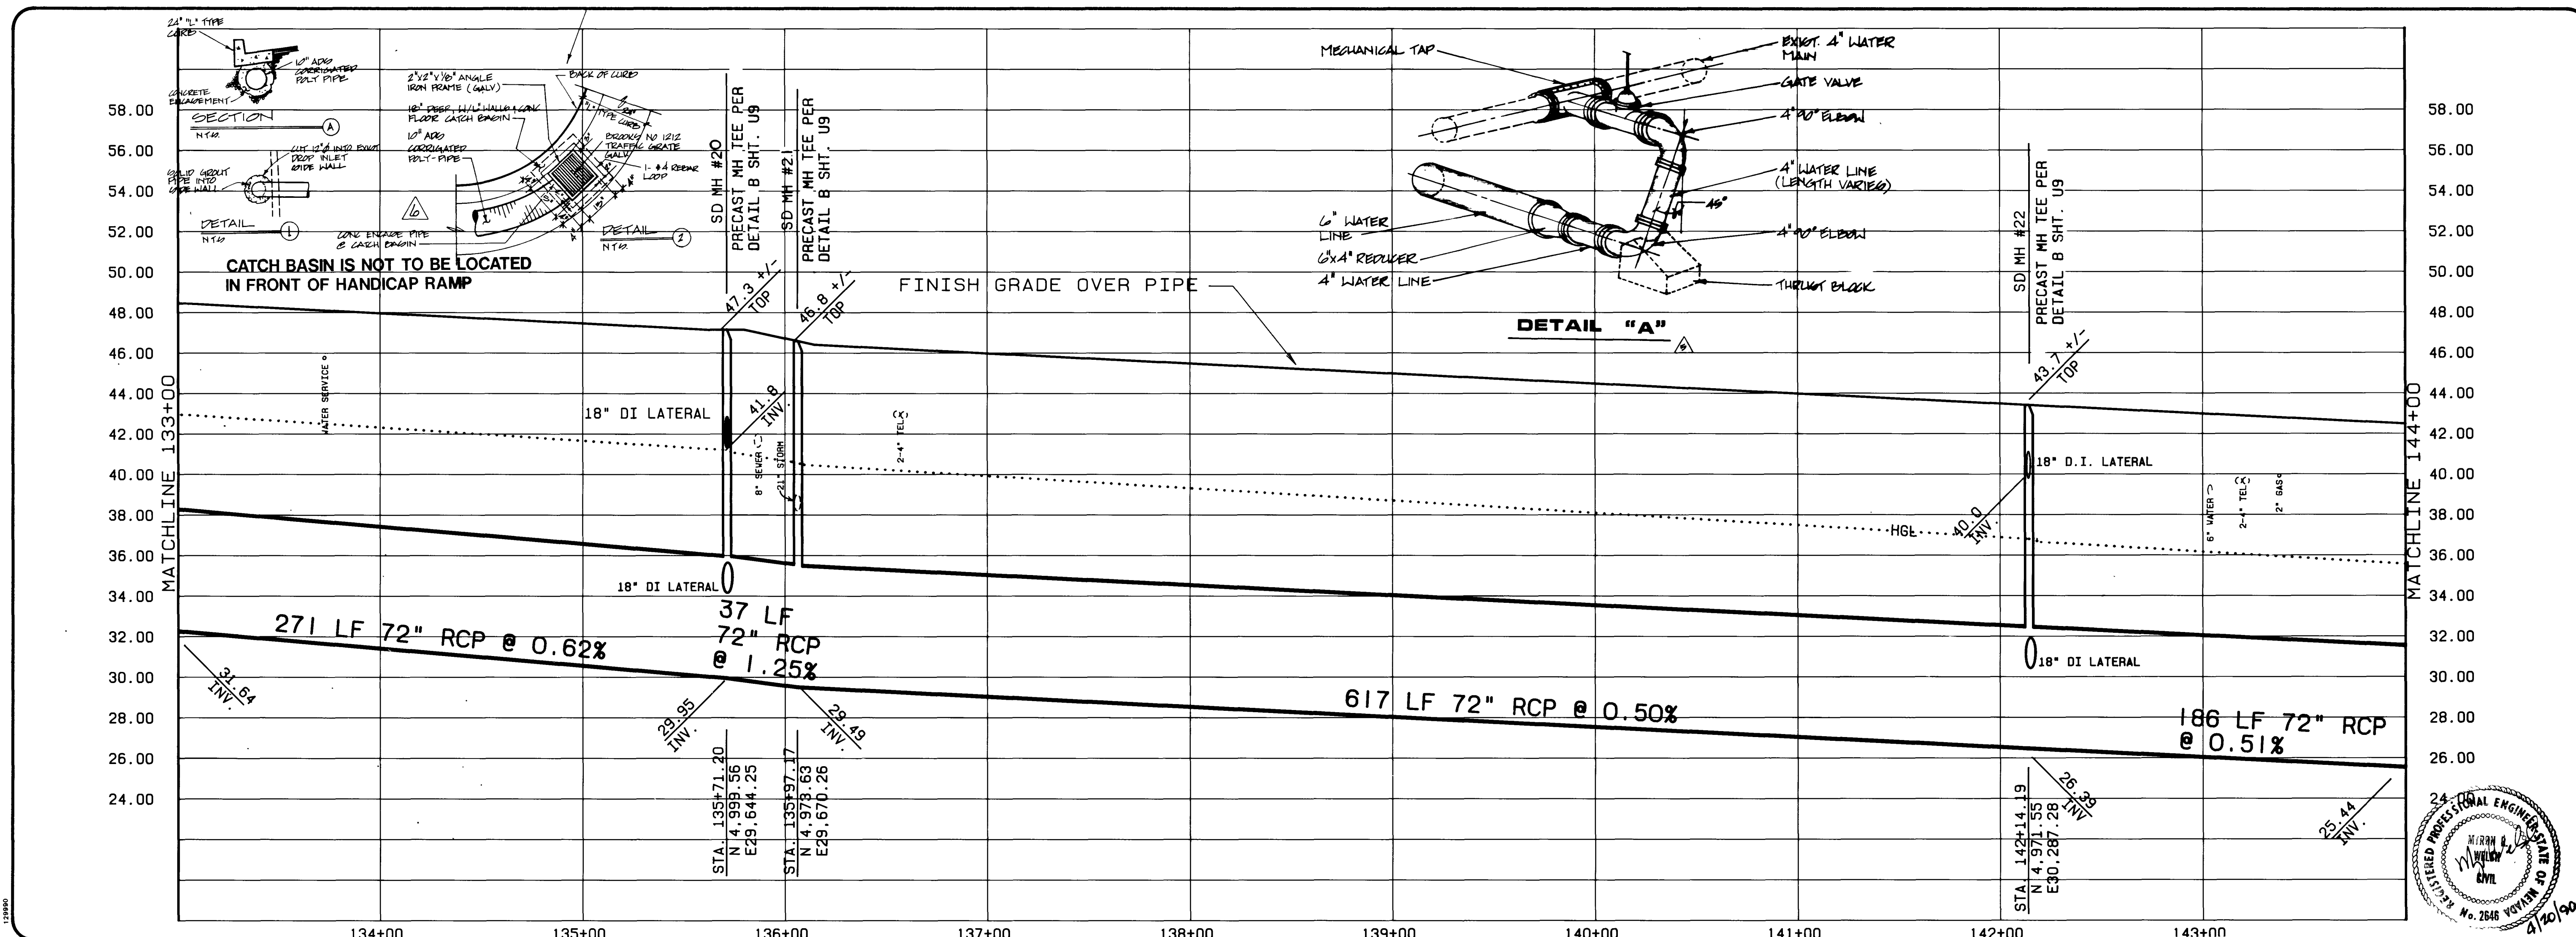

STA. 133+00 TO STA. 144+00
STORM DRAIN PLAN AND PROFILE
PROJ. LAKE MEAD BOULEVARD
TONOPAH TO INTERSTATE 15

WD NO. 3661

BY D.L.A.

DATE 11/17/89



HOR: 1"=40'

SCALE VER: 1"=4'

SHEET U4 OF 29 SHEETS

9-3-145

107-V1607

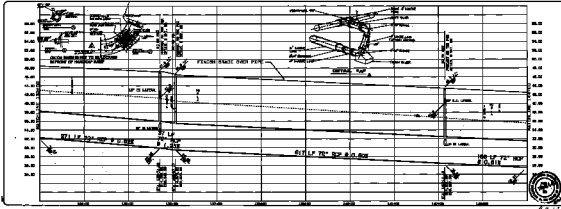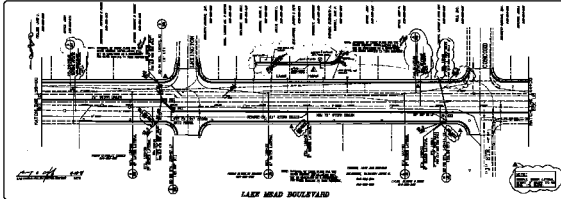

PROJECT NO. 133-00
 DRAWING NO. 133-00-00
 SHEET NO. 1
 DATE 10/1/50
 DESIGNED BY
 CHECKED BY
 APPROVED BY
 LAK MEAD BOULEVARD
 STATION 100+00 TO 100+50
 U.S. DEPARTMENT OF AGRICULTURE
 BUREAU OF RECLAMATION
 LAS VEGAS, NEVADA

STA. 133-00 TO STA. 144-00
 STORM DRAIN PLAN AND PROFILE
 LAK MEAD BOULEVARD
 STATION 100+00 TO 100+50
 U.S. DEPARTMENT OF AGRICULTURE
 BUREAU OF RECLAMATION
 LAS VEGAS, NEVADA



9-2-107

U4

9/1-14001