


DISCLAIMER NOTE:
UTILITY LOCATIONS SHOWN HEREON ARE APPROXIMATE ONLY. IT SHALL BE THE CONTRACTOR'S RESPONSIBILITY TO DETERMINE THE EXACT HORIZONTAL AND VERTICAL LOCATION OF ALL EXISTING UNDERGROUND OR OVERHEAD UTILITIES PRIOR TO COMMENCING CONSTRUCTION. NO REPRESENTATION IS MADE THAT ALL EXISTING UTILITIES ARE SHOWN HEREON. THE ENGINEER ASSUMES NO RESPONSIBILITY FOR UTILITIES NOT SHOWN OR UTILITIES NOT SHOWN IN THEIR PROPER LOCATION.
CONTRACTOR TO NOTIFY ENGINEER OF ANY CHANGES OR DISCREPANCIES.

Avoid cutting underground utility lines. It's costly.
before Call you Dig
1-800-227-2600
UNDERGROUND SERVICE (USA)

Avoid overhead power line contact.
before Call Overhead
1-702-593-6111
NEVADA POWER ENVIRONMENT AND SAFETY SERVICES DEPARTMENT

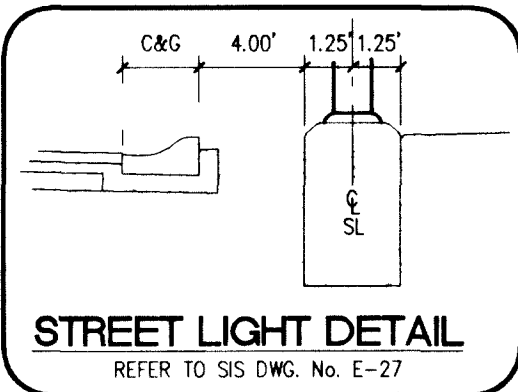

STREETLIGHT CIRCUIT CAPACITY VERIFICATION			
STREETLIGHT CIRCUIT 'SP1-1' (PRIVATE)			
SERVICE POINT CAPACITY	=	60	AMPS
MAXIMUM ALLOWABLE DRAW	=	48	AMPS
EXISTING CIRCUIT LOAD	=	0	AMPS
PROPOSED LUMINAIRE LOAD TO CIRCUIT			
(16) 100 WATT @ 0.6 AMP EACH	=	9.6	AMPS
(0) 150 WATT @ 0.9 AMPS EACH	=	0	AMPS
(0) 250 WATT @ 1.35 AMPS EACH	=	0	AMPS
TOTAL PROPOSED LOAD	=	9.6	AMPS
EXISTING PLUS PROPOSED LOAD	=	9.6	AMPS
REMAINING AVAILABLE LOAD	=	38.4	AMPS
SERVICE POINT LOCATION:	VISTA LINDA AVENUE = STA. 12+75.33, 21.50' LT.		
FIELD CONNECTION VERIFICATION			
ELECTRICAL CONTRACTOR NAME *			
CONTRACTOR LICENSE NUMBER *		(AS OF): DATE _____	
NAME AND TITLE OF PERSON WHO DID FIELD TESTING *			
I FIELD VERIFIED THIS ELECTRICAL SERVICE FOR CAPACITY (ONE MUST BE CIRCLED): YES NO			
SIGNATURE _____		DATE _____	
ENGINEER OF THE OFFSITE PLANS * (IF NEW SERVICE POINT):			
PERSON WHO DID THE CALCULATIONS	ROGER BLASCO	(AS OF): DATE 10/15/2003	

STREETLIGHT CIRCUIT CAPACITY VERIFICATION			
STREETLIGHT CIRCUIT "SP2-1" (PRIVATE)			
SERVICE POINT CAPACITY	=	60	AMPS
MAXIMUM ALLOWABLE DRAW	=	48	AMPS
EXISTING CIRCUIT LOAD	=	0	AMPS
PROPOSED LUMINAIRE LOAD TO CIRCUIT			
(8) 100 WATT @ 0.6 AMP EACH	=	4.8	AMPS
(0) 150 WATT @ 0.9 AMPS EACH	=	0	AMPS
(0) 250 WATT @ 1.35 AMPS EACH	=	0	AMPS
TOTAL PROPOSED LOAD	=	4.8	AMPS
EXISTING PLUS PROPOSED LOAD	=	4.8	AMPS
REMAINING AVAILABLE LOAD	=	43.2	AMPS
SERVICE POINT LOCATION:	LOMA BANITA DRIVE = STA. 14+50.00, 21.50' LT.		
FIELD CONNECTION VERIFICATION			
ELECTRICAL CONTRACTOR NAME *			
CONTRACTOR LICENSE NUMBER *		(AS OF): DATE	
NAME AND TITLE OF PERSON WHO DID FIELD TESTING *			
I FIELD VERIFIED THIS ELECTRICAL SERVICE FOR CAPACITY (ONE MUST BE CIRCLED): YES NO			
SIGNATURE		DATE	
ENGINEER OF THE OFFSITE PLANS * (IF NEW SERVICE POINT):			
PERSON WHO DID THE CALCULATIONS		ROGER BLASCO (AS OF): DATE 10/15/2003	

CONSTRUCTION NOTES

1. INSTALL 100 WATT STREET LIGHT
2. INSTALL No. 3-1/2 PULL BOX
3. INSTALL 125 AMP SERVICE POINT
4. PROVIDE 1-1/4" CONDUIT
(1) #8 CU GRND

SIGNAGE CONSTRUCTION NOTES


1. INSTALL 2-12" D3 STREET NAME SIGNS AND 1-36" R1-1 STOP SIGN (PRIVATE STREET SIGNS TO BE WHITE LETTERS ON BROWN BACK GROUND)
2. INSTALL 2-9" D3 STREET NAME SIGNS AND 1-30" R1-1 STOP SIGN (PRIVATE STREET SIGNS TO BE WHITE LETTERS ON BROWN BACK GROUND)
3. INSTALL 2-9" D3 STREET NAME SIGNS (PRIVATE STREET SIGNS TO BE WHITE LETTERS ON BROWN BACK GROUND)

PRIVATE STREET NOTE:


PRIVATE STREETS ARE P.U.E.'S, CLV PUBLIC SEWER EASEMENTS, AND PUBLIC DRAINAGE EASEMENT TO BE PRIVATELY MAINTAINED.

LEGEND

- 100 WATT STREET LIGHT (SUMMERLIN POLE TYPE 3A/B OR 5A/B)
- 1-1/4" CONDUIT
- No. 3-1/2 PULL BOX
- 125 AMP SERVICE POINT

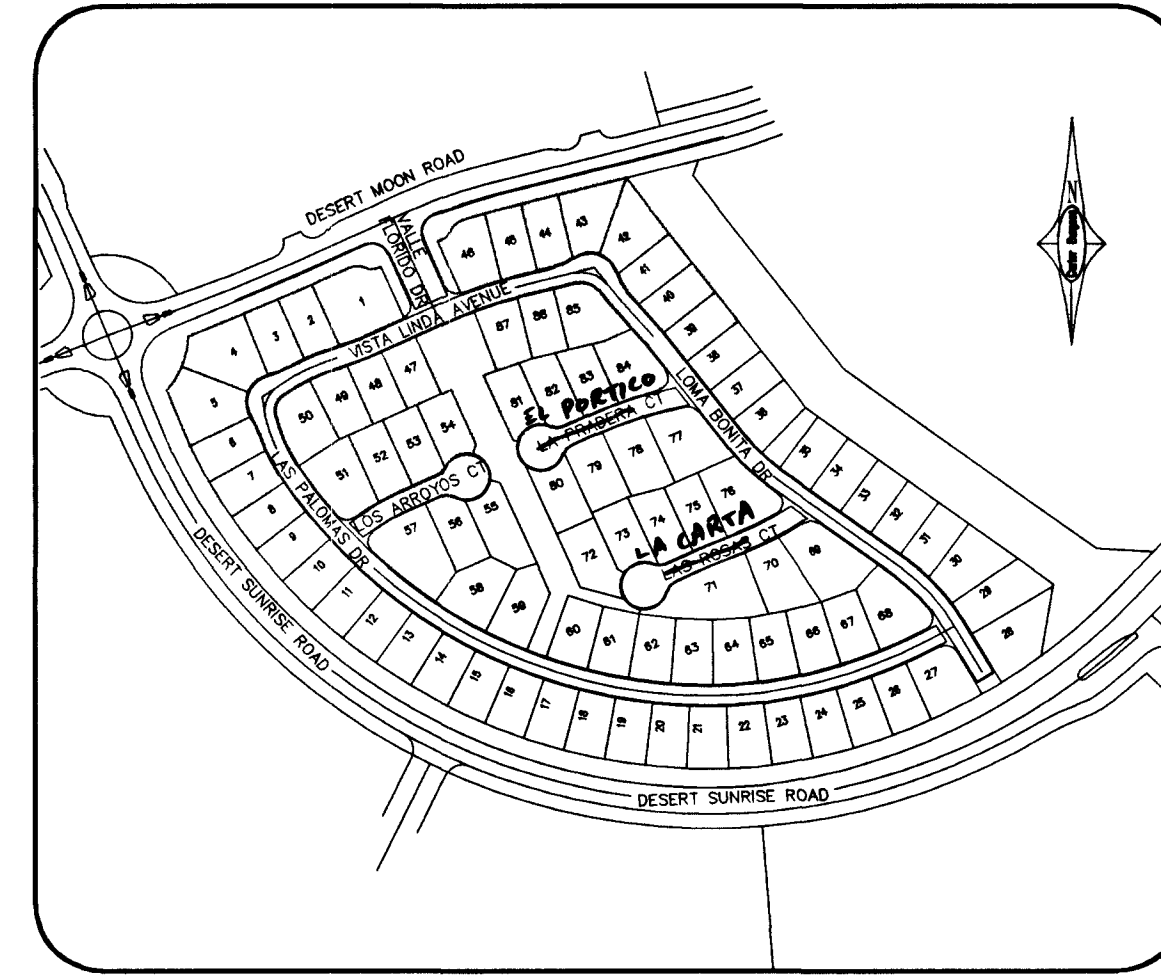

SITE MAP

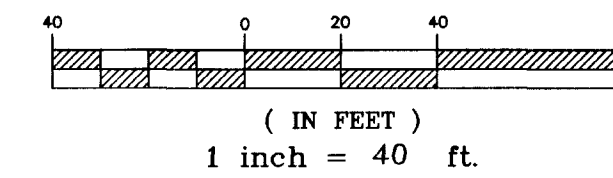

The Howard Hughes Corporation
10000 West Charleston Boulevard, Suite 200
Las Vegas, Nevada 89136-1004


6655 Bermuda Road
Las Vegas, NV 89119
Fax (702) 938-5454

Carter Burgess
Consultants in Planning, Engineering,
Construction Management, and Related Services

STREET SIGNAGE & STRIPING PLAN
SHEET 1 OF 3

LOS LOMAS • THE PASEOS
PARCEL F • VILLAGE 23A

DRAWN BY: TA
DESIGNED BY: EB
CHECKED BY: DW
PROJECT NO: 240812
SCALE: 1"=40'
HORIZ. VERT. N/A

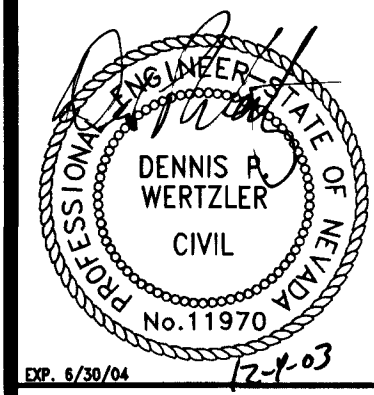

DATE: 8/28/04
SHEET 18
18 OF 20 SHEETS
CLV DRAWING NO. 10714779